


DRAWING NO. : _____

PROJECT	CATEGORY	BLOCK	FLOOR	TYPE	NUMBER
---------	----------	-------	-------	------	--------

A-201

DRAWING PATH : _____

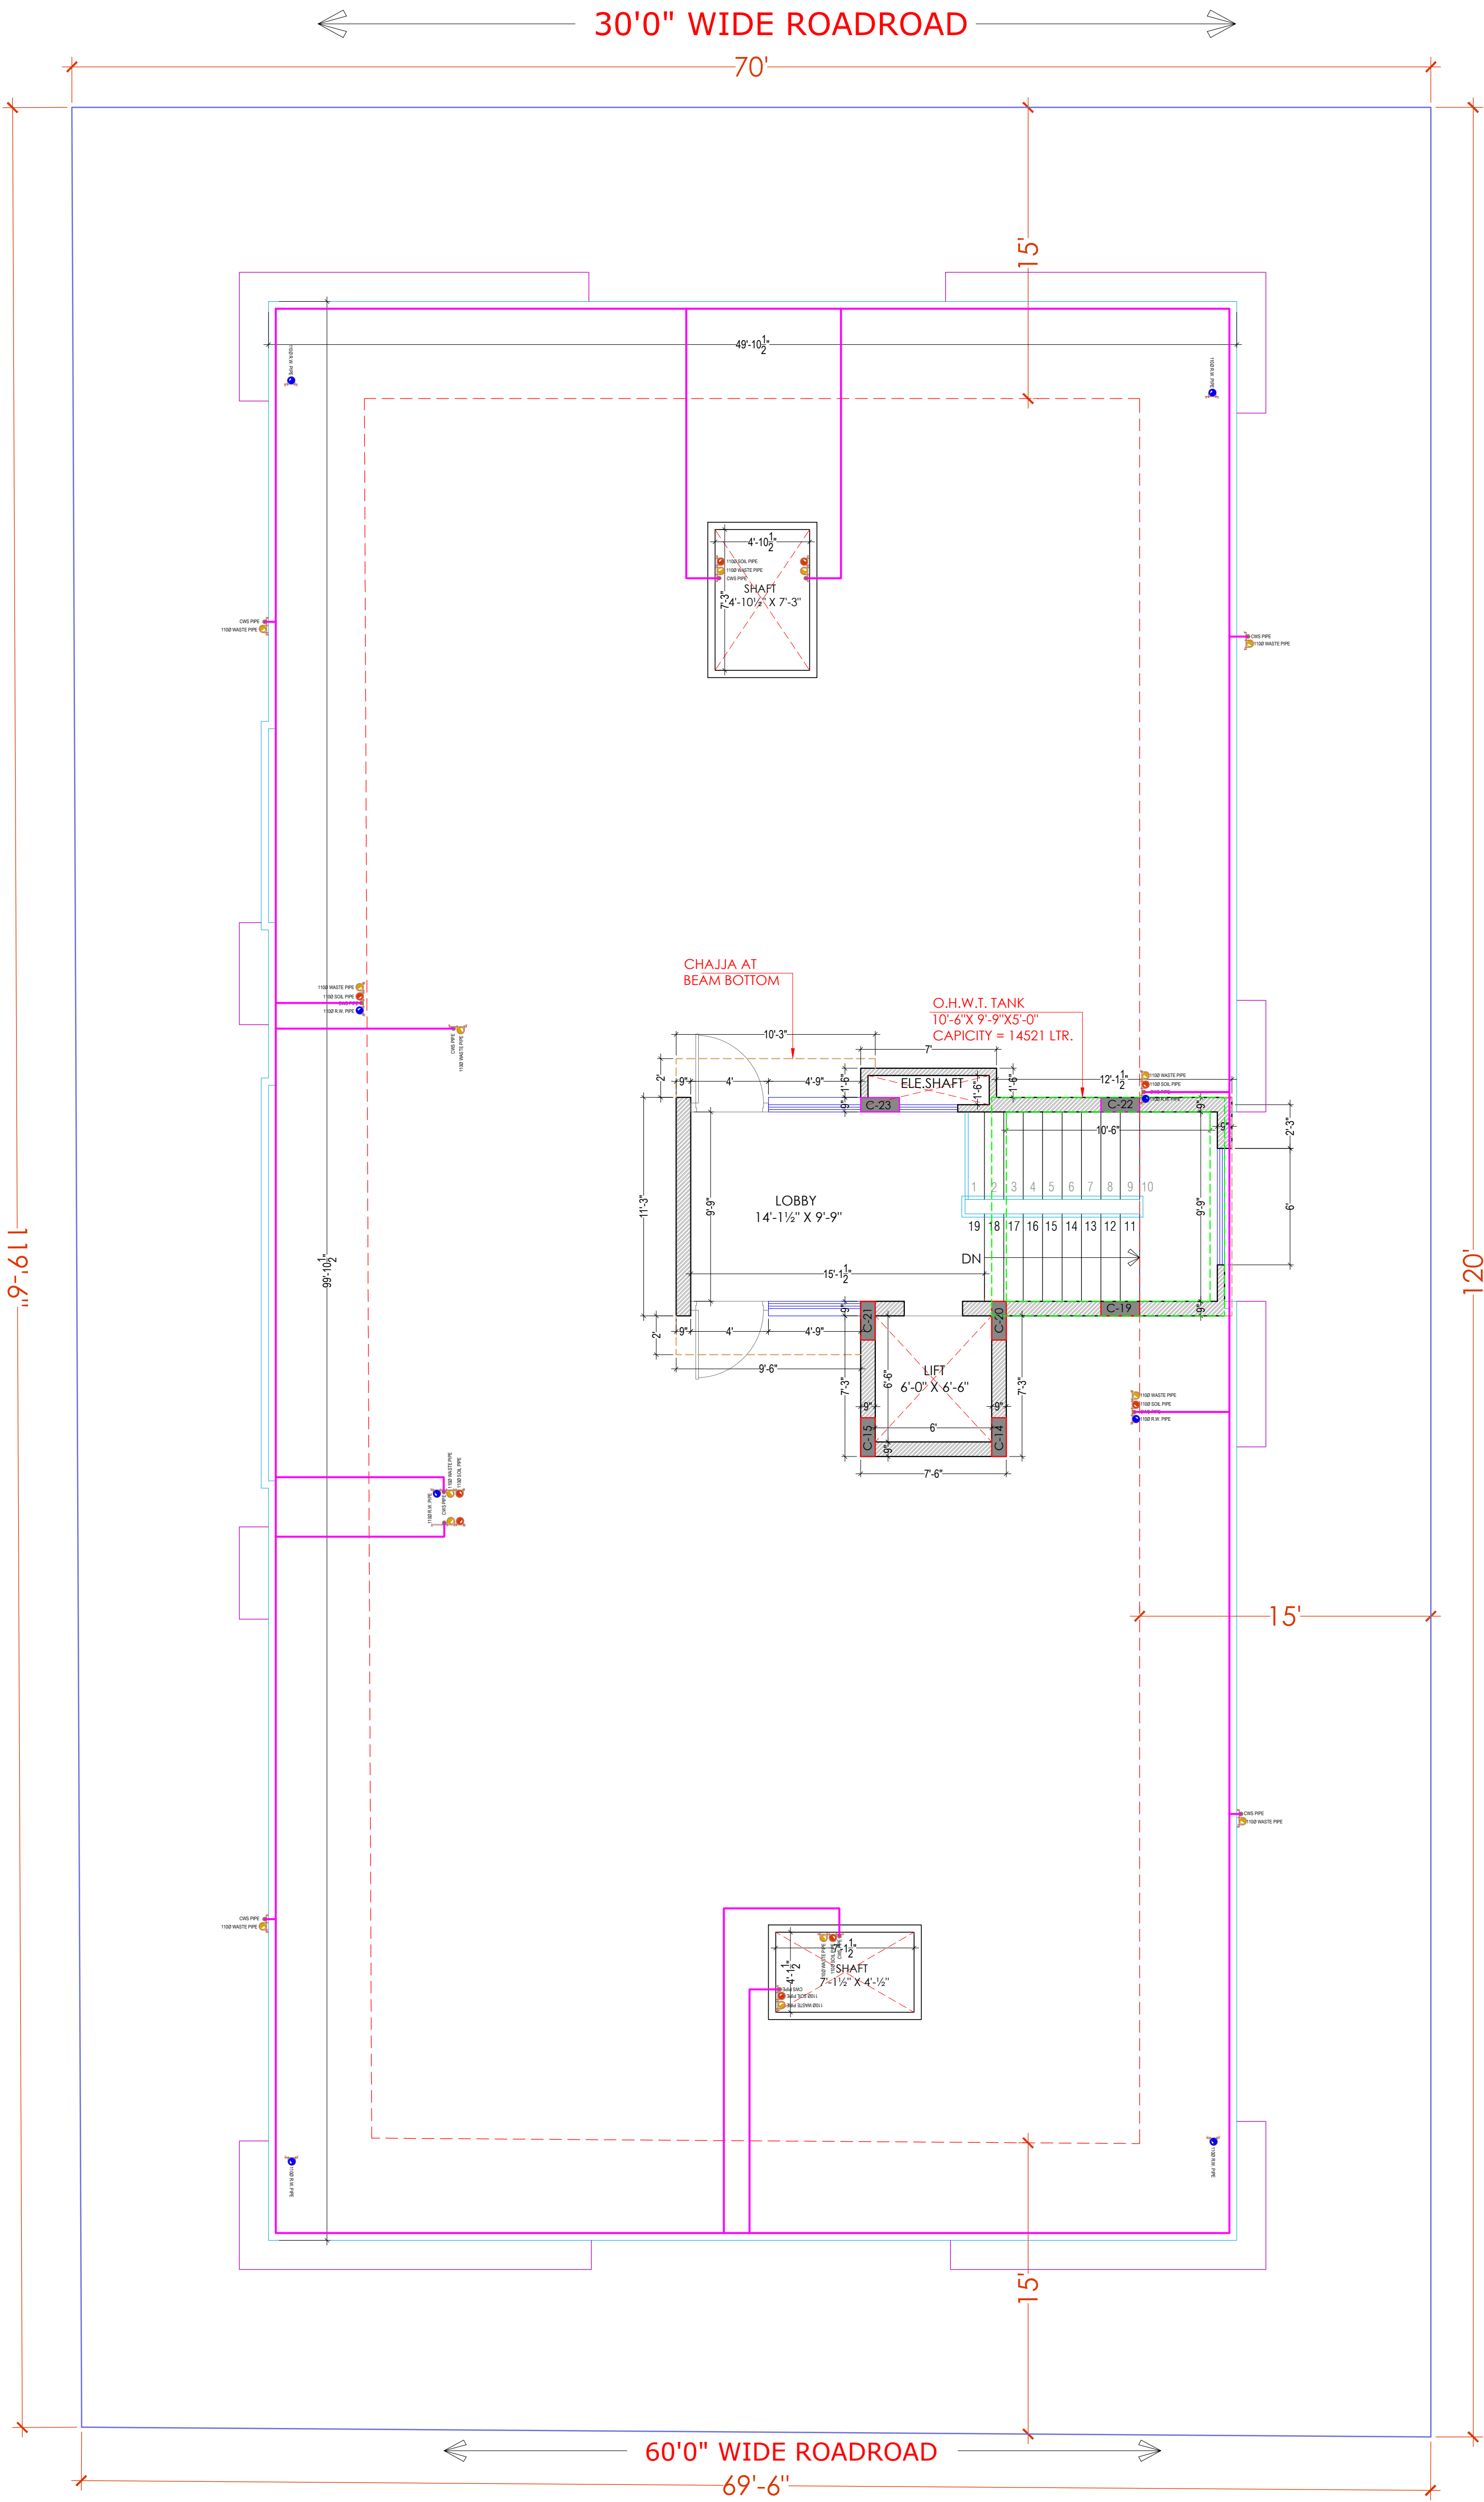

PROJECT NAME :
BALAJI AASHIYANA II

DEVELOPER NAME :
BALAJI BUILDER

ARCHITECTS :
4 INSIDE
ARCHITECTURE N INTERIORS
Plot no. 72, S.P. Marg , C- Scheme
jaipur, rajasthan, India
cont: +91 9950595991 , 91
9982812777
e.mail: 4insideofficial@gmail.com

LEGEND:-		
①	SOIL PIPE	
②	WASTE PIPE	
③	VENT PIPE	
④	COLD WATER SUPPLY (CWS)	
⑤	HOT WATER SUPPLY (HWS)	
	RAIN WATER PIPE	
SW	SEWER LINE- EXTERNAL	
RW	STORM WATER DRAINAGE PIPE	
	SEWERAGE MANHOLE (2' x 2')	M.H.
	STORM WATER MANHOLE (2' x 2')	M.H.
GT	GULLY TRAP	
BV	BALL VALVE	
FT	FLOOR TRAP	
FD	FLOOR FLOOR DRAIN	
	RAIN WATER COLLECTION CHAMBER 450X450MM	
	KHURRA	

- GENERAL NOTES :
- All dimension on this drawing are in MKS System Only written dimensions are to be followed drawing should not be scaled.
 - All measurements must be checked and verified by the contractors prior to execution of work at the site.
 - This drawing is to be read in conjunction with all relevant structural, services & facility planning drawings.
 - Architectural drawings are to be followed for the location of all structural members & masonry walls, for sizes & reinforcement details of structural members, relevant structural drawings are to be referred.
 - Any discrepancies between architectural, structural and services drawings must be brought to the notice of the architects immediately & prior to execution at site.
 - Co-ordinate with services such as hvac, plumbing & electrical, etc. is the responsibility of the contractors.
 - All masonry walls should be aligned with the columns as indicated on the plan, irrespective of the position as calculated with the dimensions.
 - For details, refer relevant large scale detail drgs. as indicated.

PROJECT:
PLOT NO. 49,50,62 & 63
SCHEME NO.17 LAXMAN REKHA
JAIPUR.

NAME OF DRAWING:
**TERRACE FLOOR FLOOR RING MAIN LAYOUT,
WATER SUPPLY SYSTEMATIC DIAGRAM ,UG WATER
TANK TO OHT FILLING ROUTE PLAN**

DRAWING WORKING DRAWING	NORTH:
PROJECT NO. :	DATE : 21, Nov. - 2024
SCALE : NTS	REV NO. : R-0

DRAWING NO. :	DRAWING PATH :
PROJECT CATEGORY BLOCK FLOOR TYPE NUMBER	A-201

TERRACE FLOOR FLOOR RING MAIN LAYOUT, WATER SUPPLY SYSTEMATIC DIAGRAM ,
UG WATER TANK TO OHT FILLING ROUTE PLAN