


TITLE: —

TITLE: –
SUBMISSION DRAWING
STILT FLOOR ELECTRICAL PLAN

NORTH :


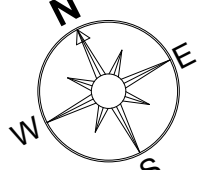


PROPOSED RESIDENTIAL
APARTMENT AT AURALLIS ,
A-22. SHANTI PATH ,TILAK
NAGAR JAIPUR ,UPASNA
INFRA LLP

m | a | a r c h i t e c t s pvt. ltd.

Jaipur - Bangalore - Hyderabad
Plot No. -1, Greenwoods, Lal Kothi Scheme,
Sahkar Marg Jaipur-302001
Tel : 91 141 4299999
email - studio@maarchitects.in,
web - www.maarchitects.in

ARCHITECTS

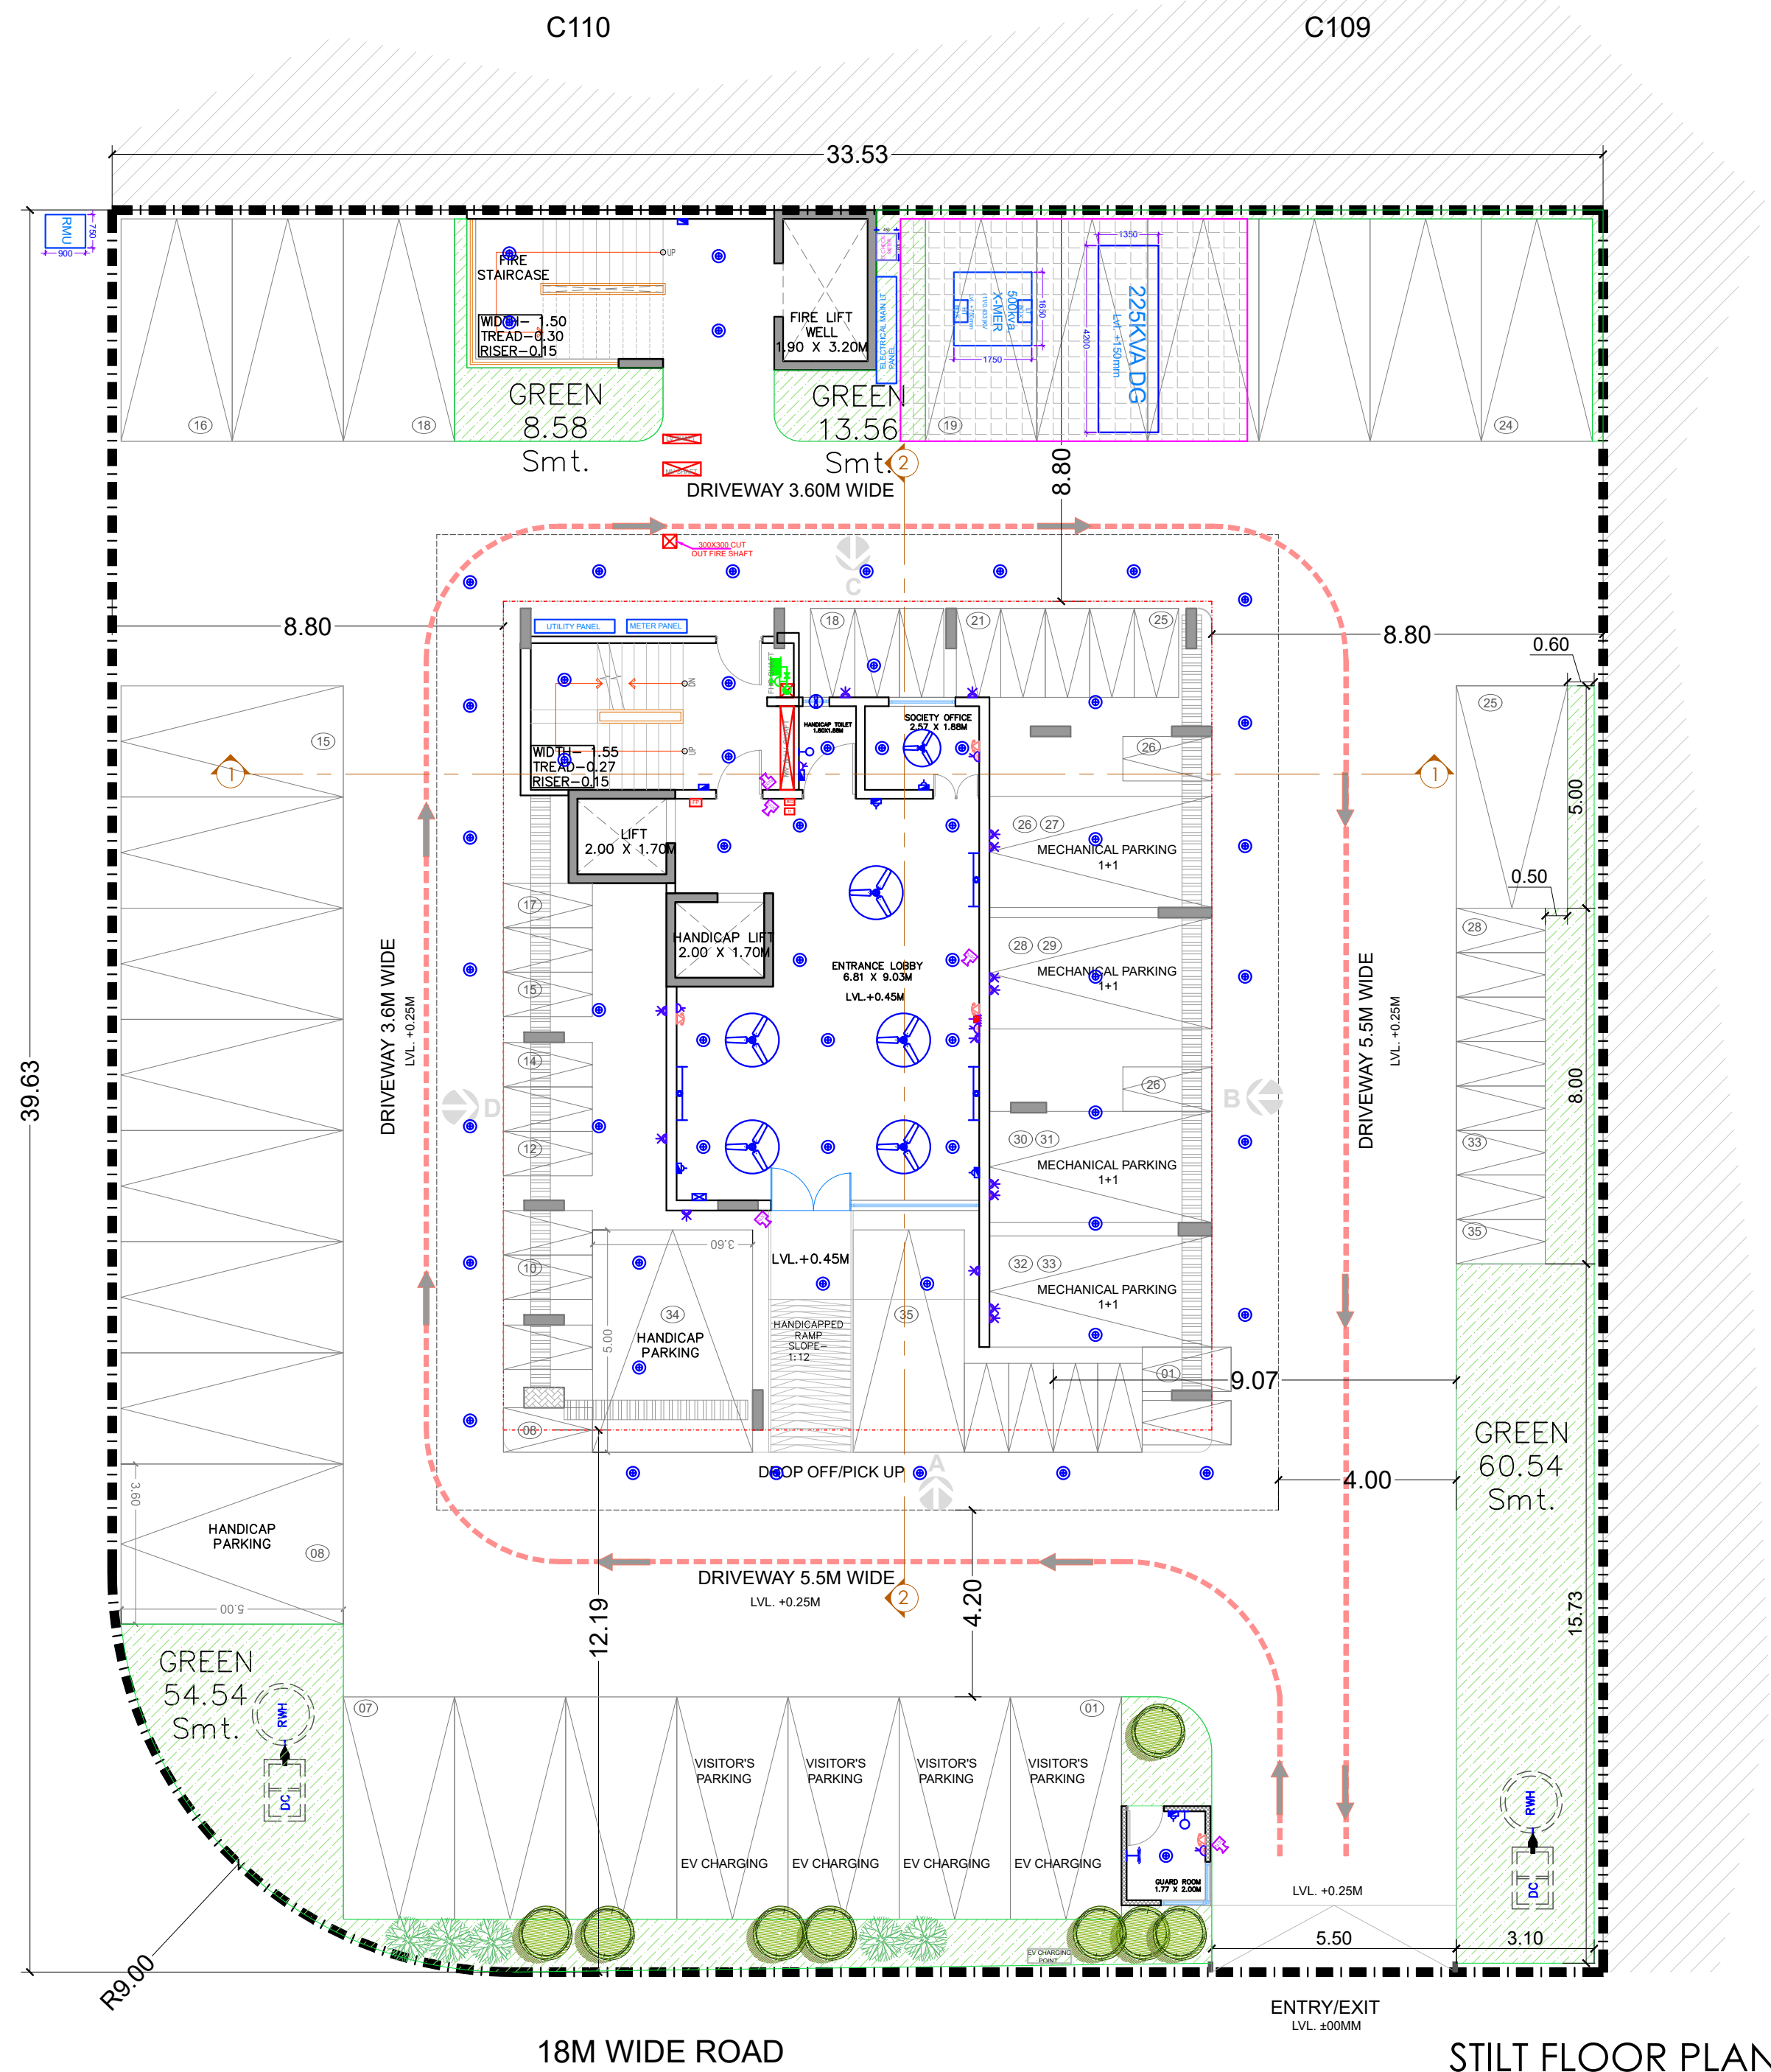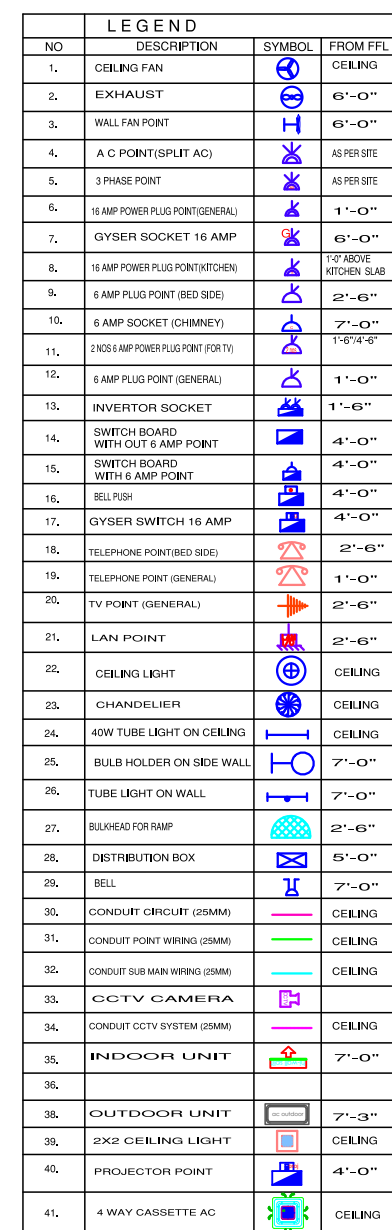

NOTE
1. GA DRAWING OF THE PANEL SHOULD BE GOT APPROVED FROM THE CONSULTANT BEFORE EXECUTION.
2. FOR MCCB ALL BREAKING VALUE ARE Ics VALUES.


PROJECT TITLE

PROPOSED RESIDENTIAL
APARTMENT AT AURALLIS ,
A-22. SHANTI PATH ,TILAK
NAGAR JAIPUR ,UPASNA
INFRA LLP

DRAWING TITLE
**ELECTRICAL SINGLE
LINE DIAGRAM (MAIN PANEL)**

DATE	05-03-2025	DEALT	RAHMAN
SCALE	N.T.S.	CHKD.	PG

DRAWING NO.			REV
			00

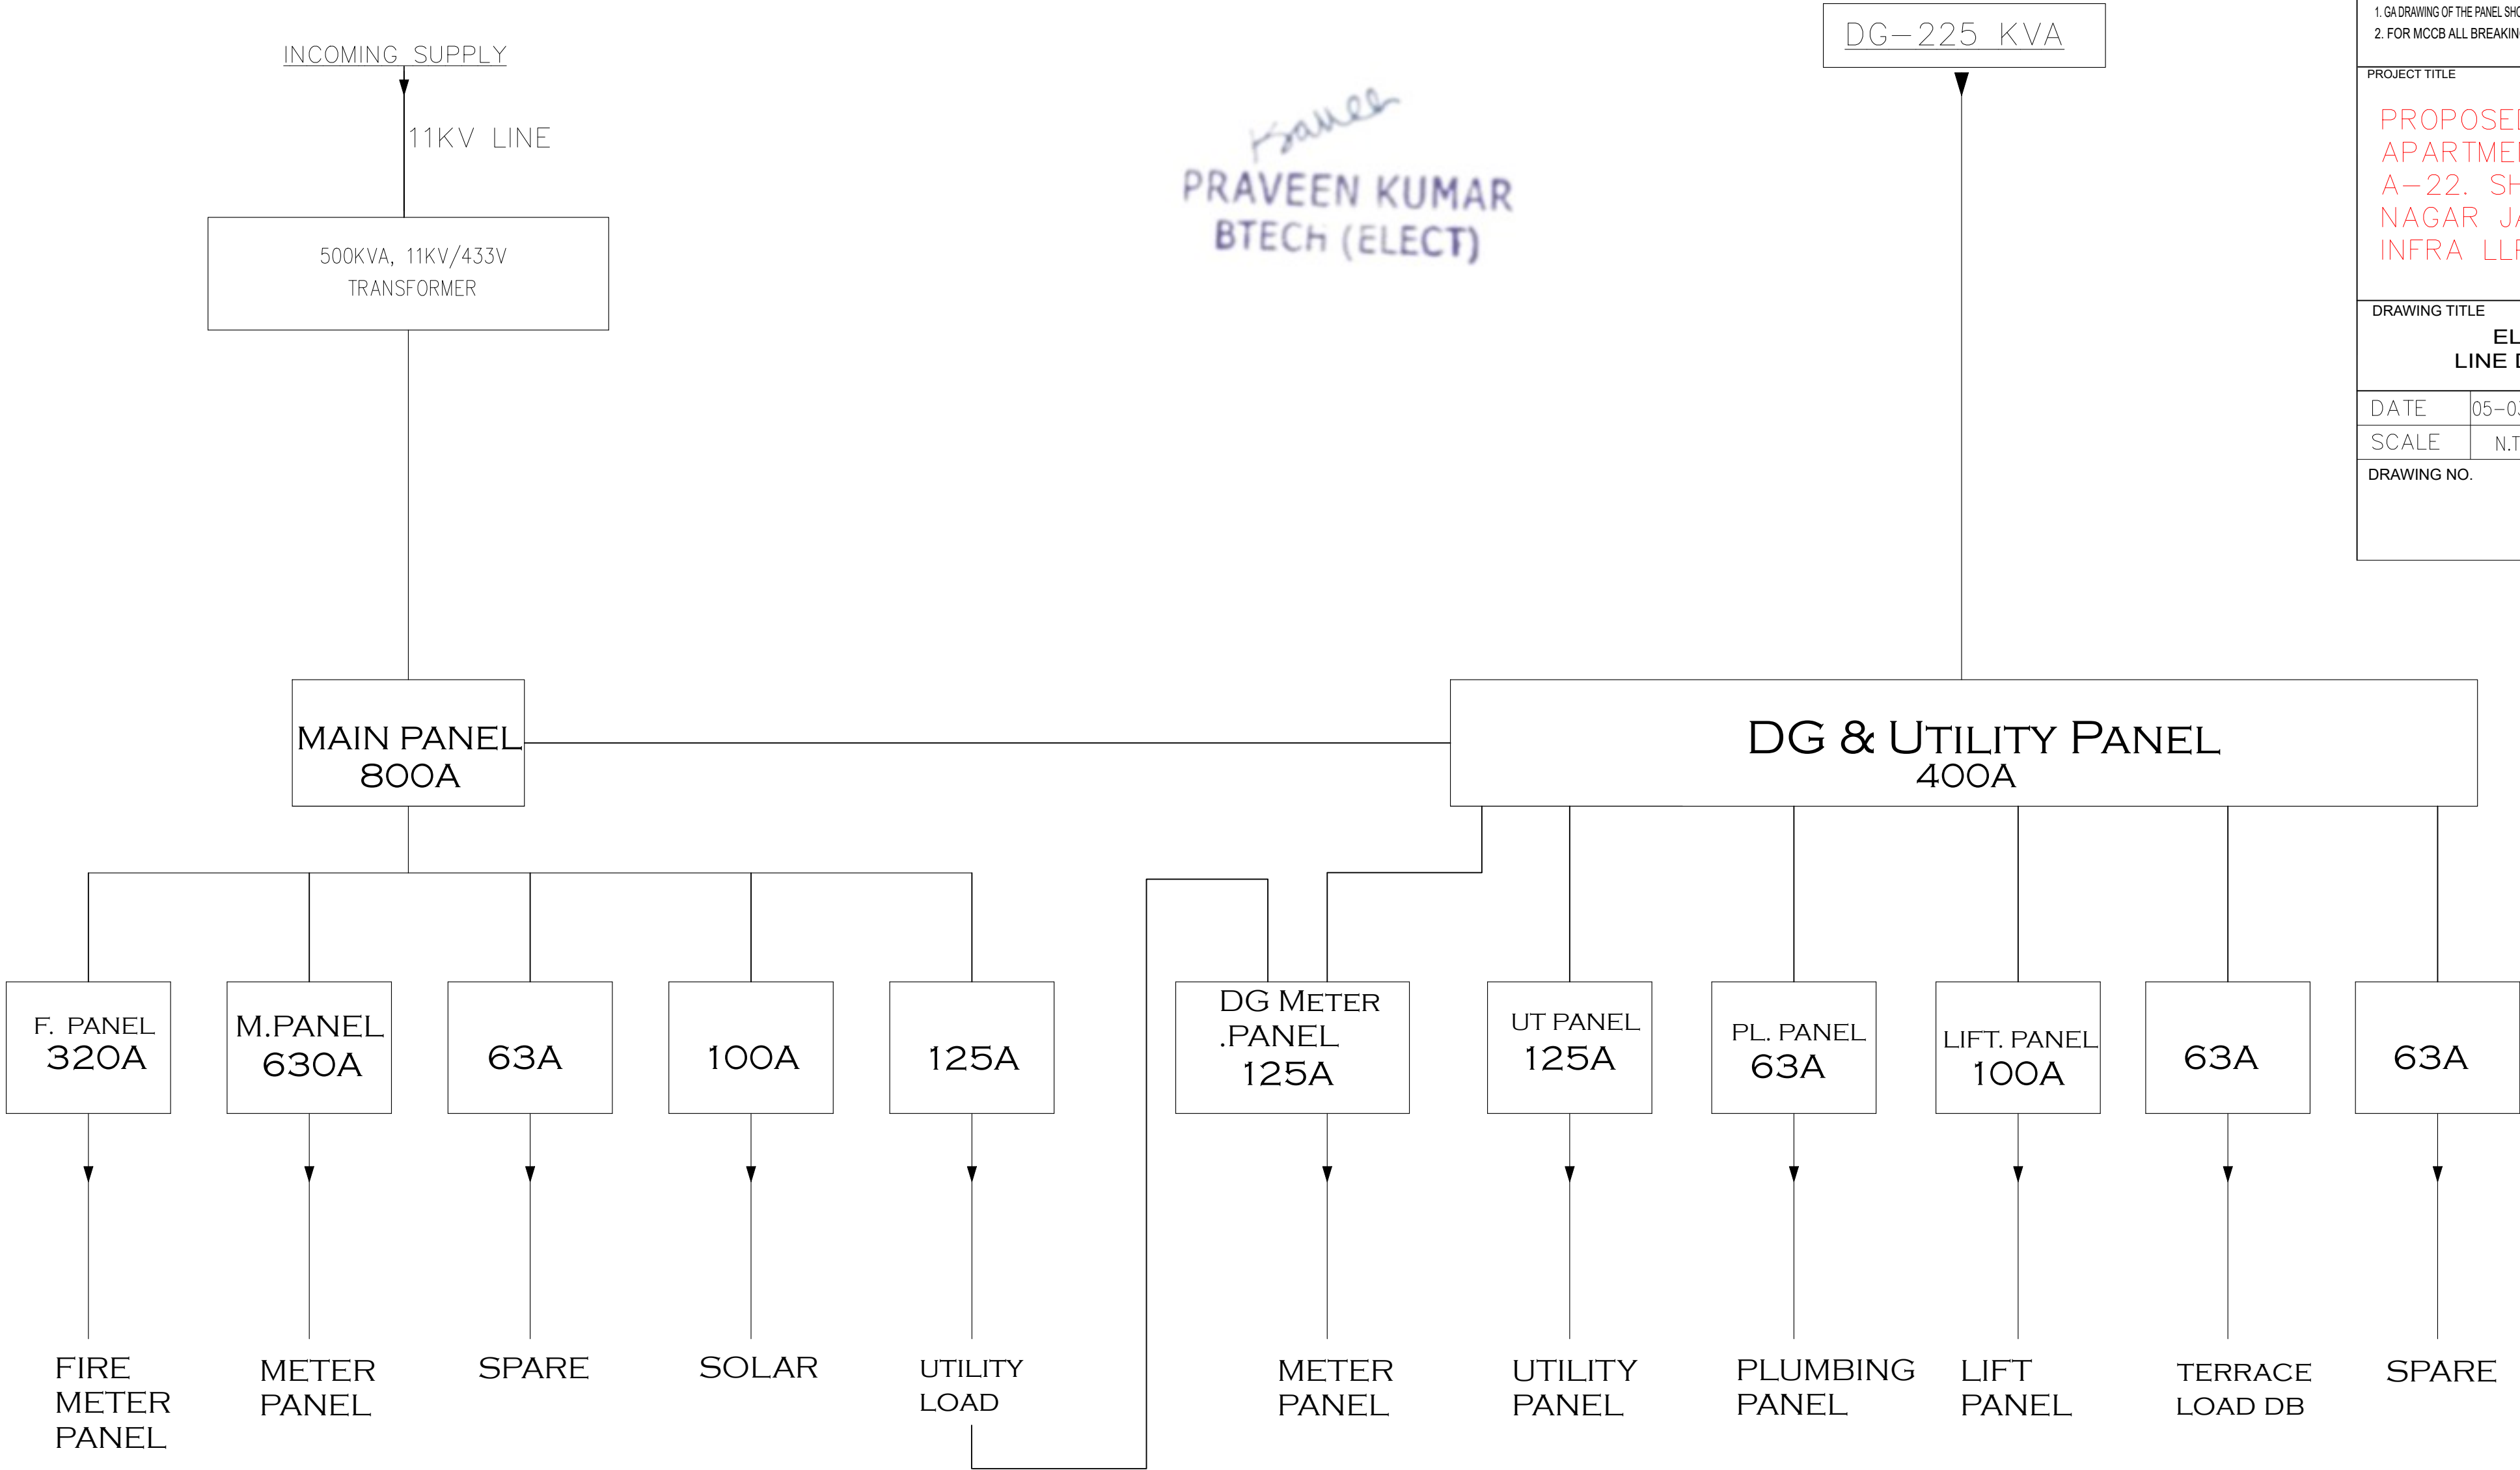

Praveen
PRAVEEN KUMAR
BTECH (ELECT)