


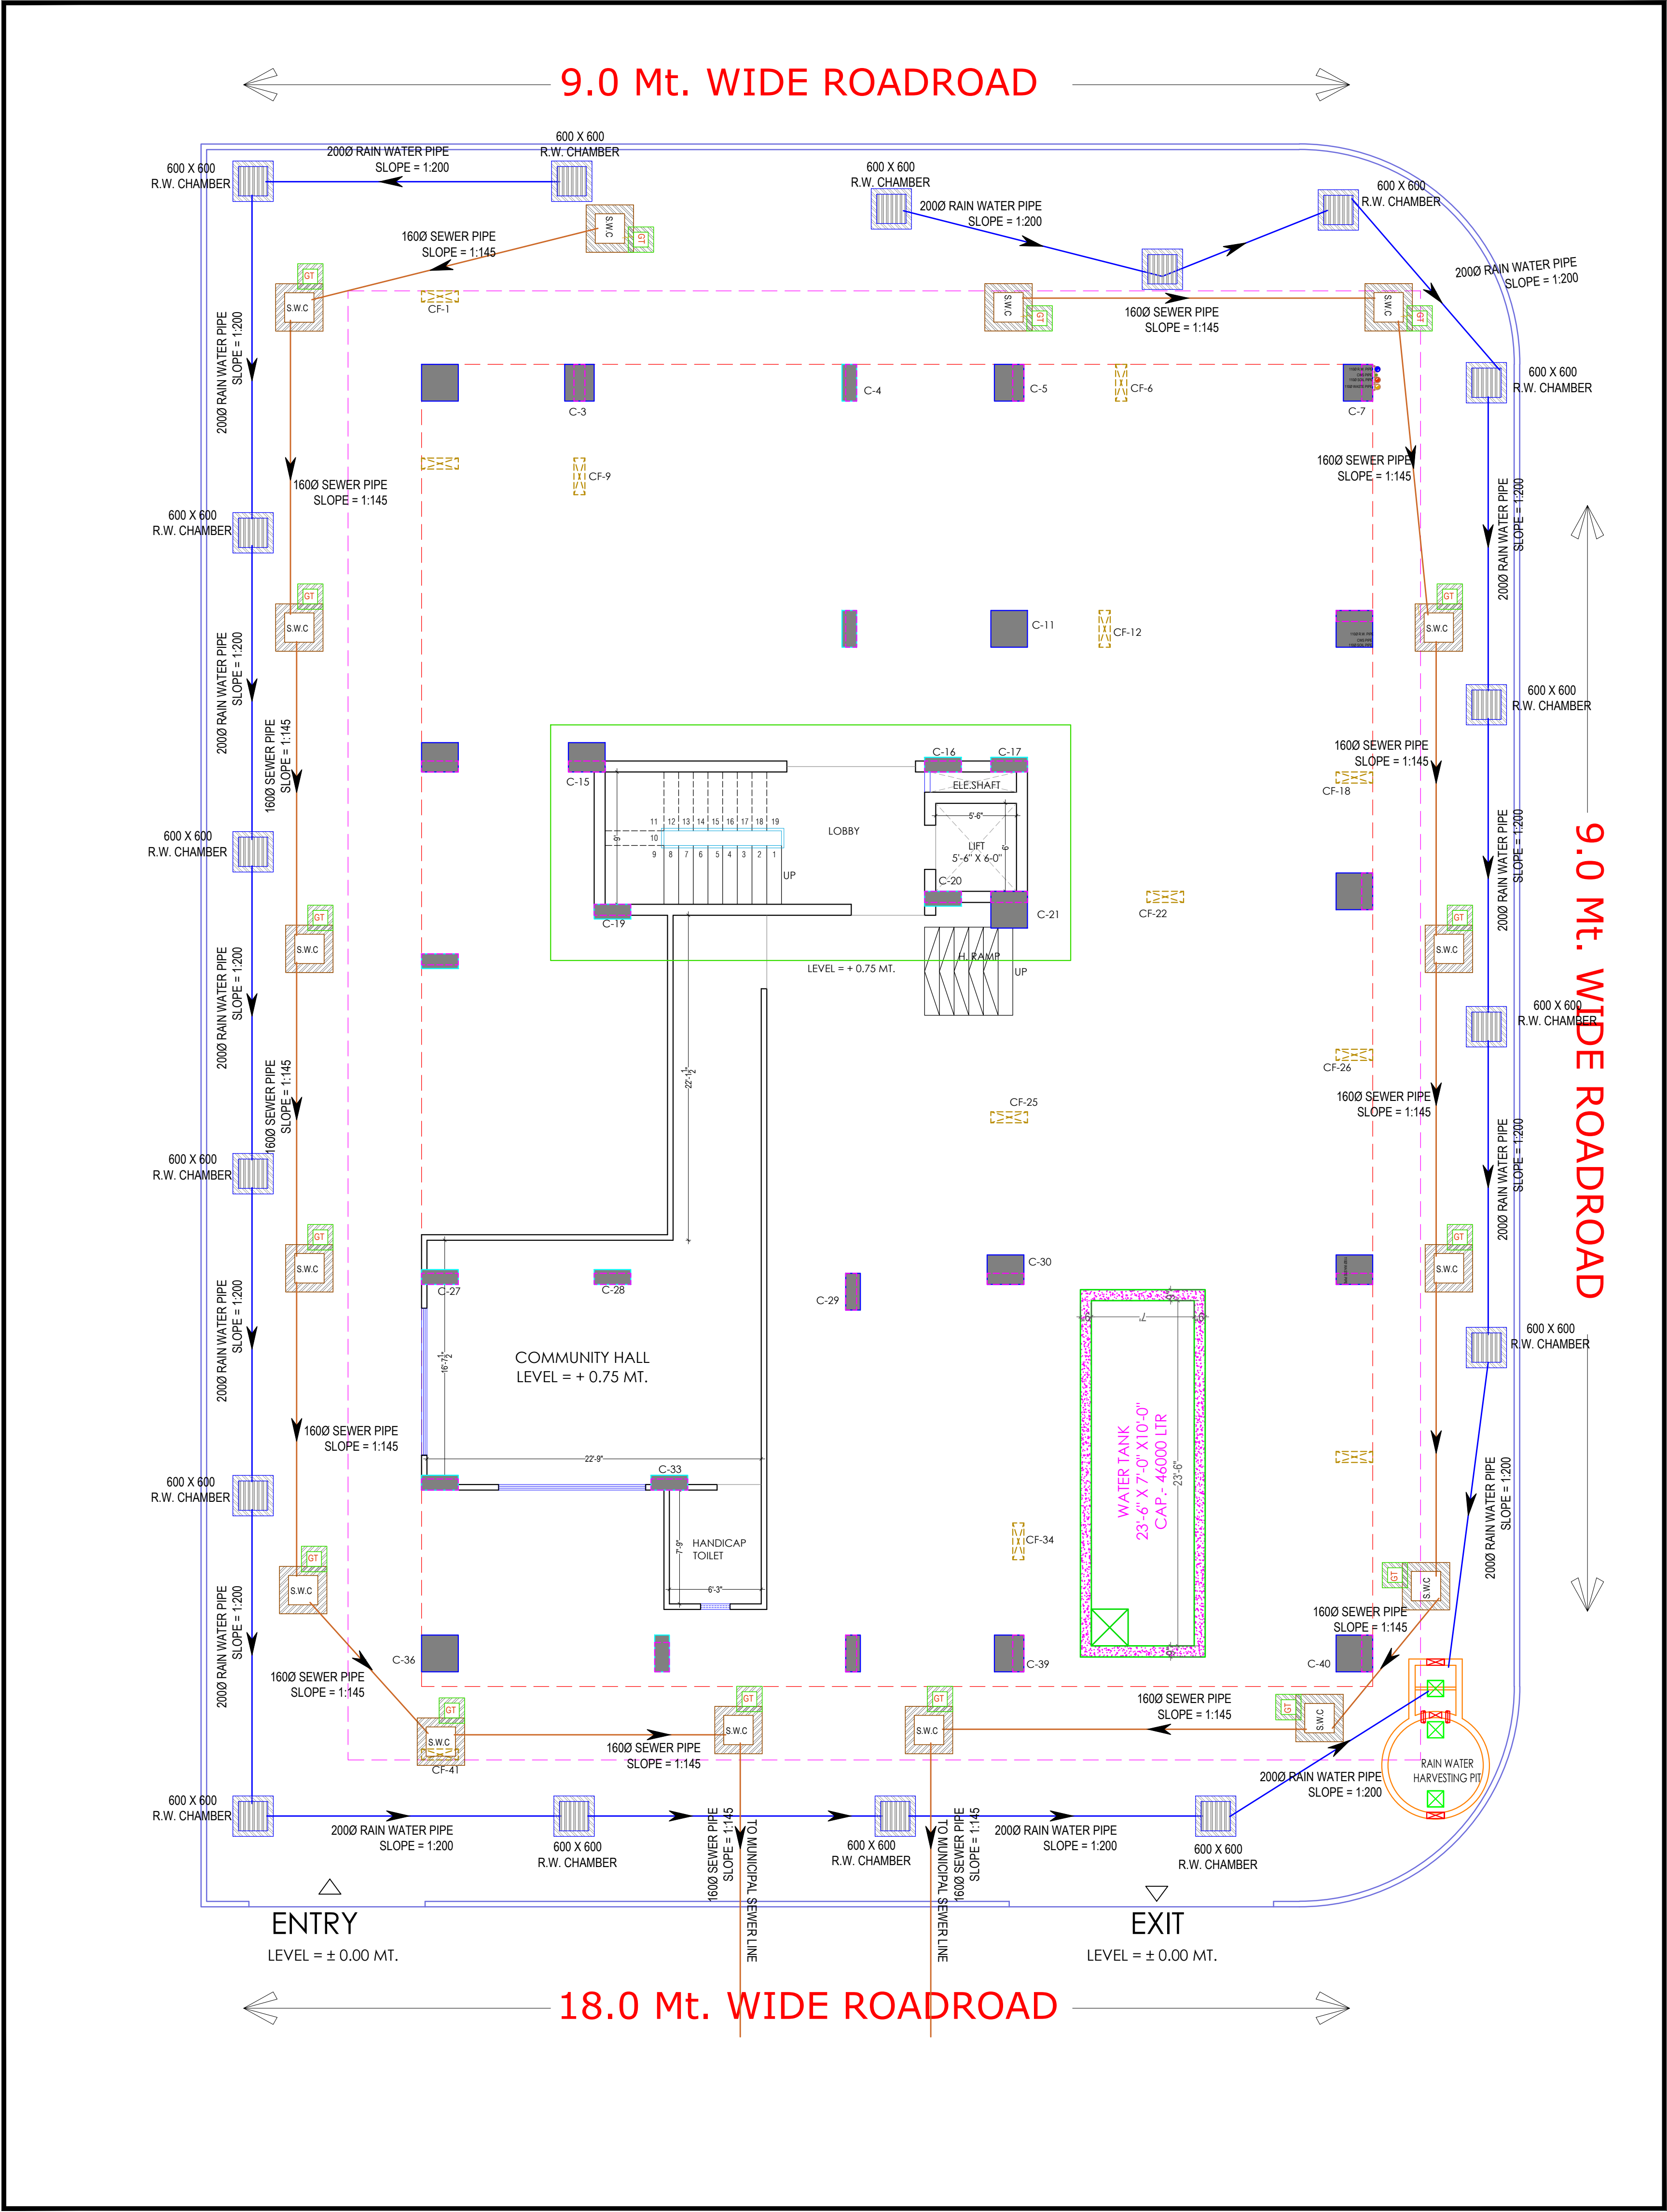

PROJECT NAME :

BALAJI AASHIYANA I

DEVELOPER NAME :

BALAJI BUILDER

LEGEND:-

①	SOIL PIPE	
②	WASTE PIPE	
③	VENT PIPE	
④	COLD WATER SUPPLY (CWS)	
⑤	HOT WATER SUPPLY (HWS)	
	RAIN WATER PIPE	
SW	SEWER LINE- EXTERNAL	
RW	STORM WATER DRAINAGE PIPE	
	SEWERAGE MANHOLE (2' x 2')	M.H.
	STORM WATER MANHOLE (2' x 2')	M.H.
GT	GULLY TRAP	
BV	BALL VALVE	
FT	FLOOR TRAP	
FD	FLOOR FLOOR DRAIN	
	RAIN WATER COLLECTION CHAMBER 450X450MM	
	KHURRA	

GENERAL NOTES:

- All dimensions on this drawing are in MMS System Only written dimensions are to be followed.
- All measurements must be checked and verified by the contractors prior to execution.
- This drawing is to be read in conjunction with all relevant structural, services & facility drawings.
- Architectural drawings are to be followed for the location of all structural members & necessary walls, for sizes & reinforcement details of structural members, relevant connections with services such as basic, plumbing & electrical, etc. in the responsibility of the contractor.
- Any discrepancies between architectural, structural and services drawings must be brought to the notice of the architect immediately & prior to execution of site.
- Coordination with services such as basic, plumbing & electrical, etc. is the responsibility of the contractor.
- All necessary work should be aligned with the columns as indicated on the plan, irrespective of the position as indicated with the dimensioning.
- For details, refer relevant large scale detail drawings, as indicated.

PROJECT:

PROPOSED RESIDENTIAL FLATS ON PLOT NO.- 51, 52, 60 & 61, LAXMAN REKHA, SCHEME NO- 17, JHOTWARA, JAIPUR, RAJASTHAN.

NAME OF DRAWING:

STILT FLOOR WATER SUPPLY DRAWING, STILT FLOOR EXTERNAL RAIN WATER HARVESTING AND PIPE ROUTE PLAN, STILT FLOOR EXTERNAL SEWERAGE WATER PIPE ROUT PLAN, PIT LOCATION

DRAWING	NORTH:
WORKING DRAWING	
PROJECT NO. :	DATE:
	28, Dec. - 2024
SCALE :	REV NO. :
NTS	R-0
DRAWING NO. :	
PROJECT	CATEGORY
A-201	

Er. SANJEEV SHARMA
B.E (Electrical)

For BALAJI BUILDERS
Proprietor

STILT FLOOR WATER SUPPLY DRAWING, STILT FLOOR EXTERNAL RAIN WATER HARVESTING AND PIPE ROUTE PLAN, STILT FLOOR EXTERNAL SEWERAGE WATER PIPE ROUT PLAN, PIT LOCATION

PROJECT NAME :
BALAJI AASHIYANA I


DEVELOPER NAME :
BALAJI BUILDER

LEGEND:-

①	SOIL PIPE	
②	WASTE PIPE	
③	VENT PIPE	
④	COLD WATER SUPPLY (CWS)	
⑤	HOT WATER SUPPLY (HWS)	
	RAIN WATER PIPE	
SW	SEWER LINE- EXTERNAL	
RW	STORM WATER DRAINAGE PIPE	
	SEWERAGE MANHOLE (2' x 2')	M. H.
	STORM WATER MANHOLE (2' x 2')	M. H.
GT	GULLY TRAP	
BV	BALL VALVE	
FT	FLOOR TRAP	
FD	FLOOR FLOOR DRAIN	
	RAIN WATER COLLECTION CHAMBER 450X450MM	
	KHURRA	


PROJECT:
PROPOSED RESIDENTIAL FLATS ON
PLOT NO.- 51, 52, 60 & 61, LAXMAN
REKHA, SCHEME NO- 17,JHOTWARA,
JAIPUR. RAJASTHAN.

NAME OF DRAWING:
TERRACE FLOOR FLOOR RING MAIN LAYOUT,
WATER SUPPLY SYSTEMATIC DIAGRAM UG WATER
TANK TO OHT FILLING ROUTE PLAN

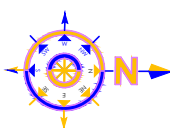DRAWING WORKING DRAWING	NORTH: 
PROJECT NO. :	DATE : 06, Mar.- 2025
SCALE : NTS	REV NO. : R-0

DRAWING NO. :									
PROJECT	CATEGORY	BLOCK	FLOOR	TYPE	NUMBER				

A-202

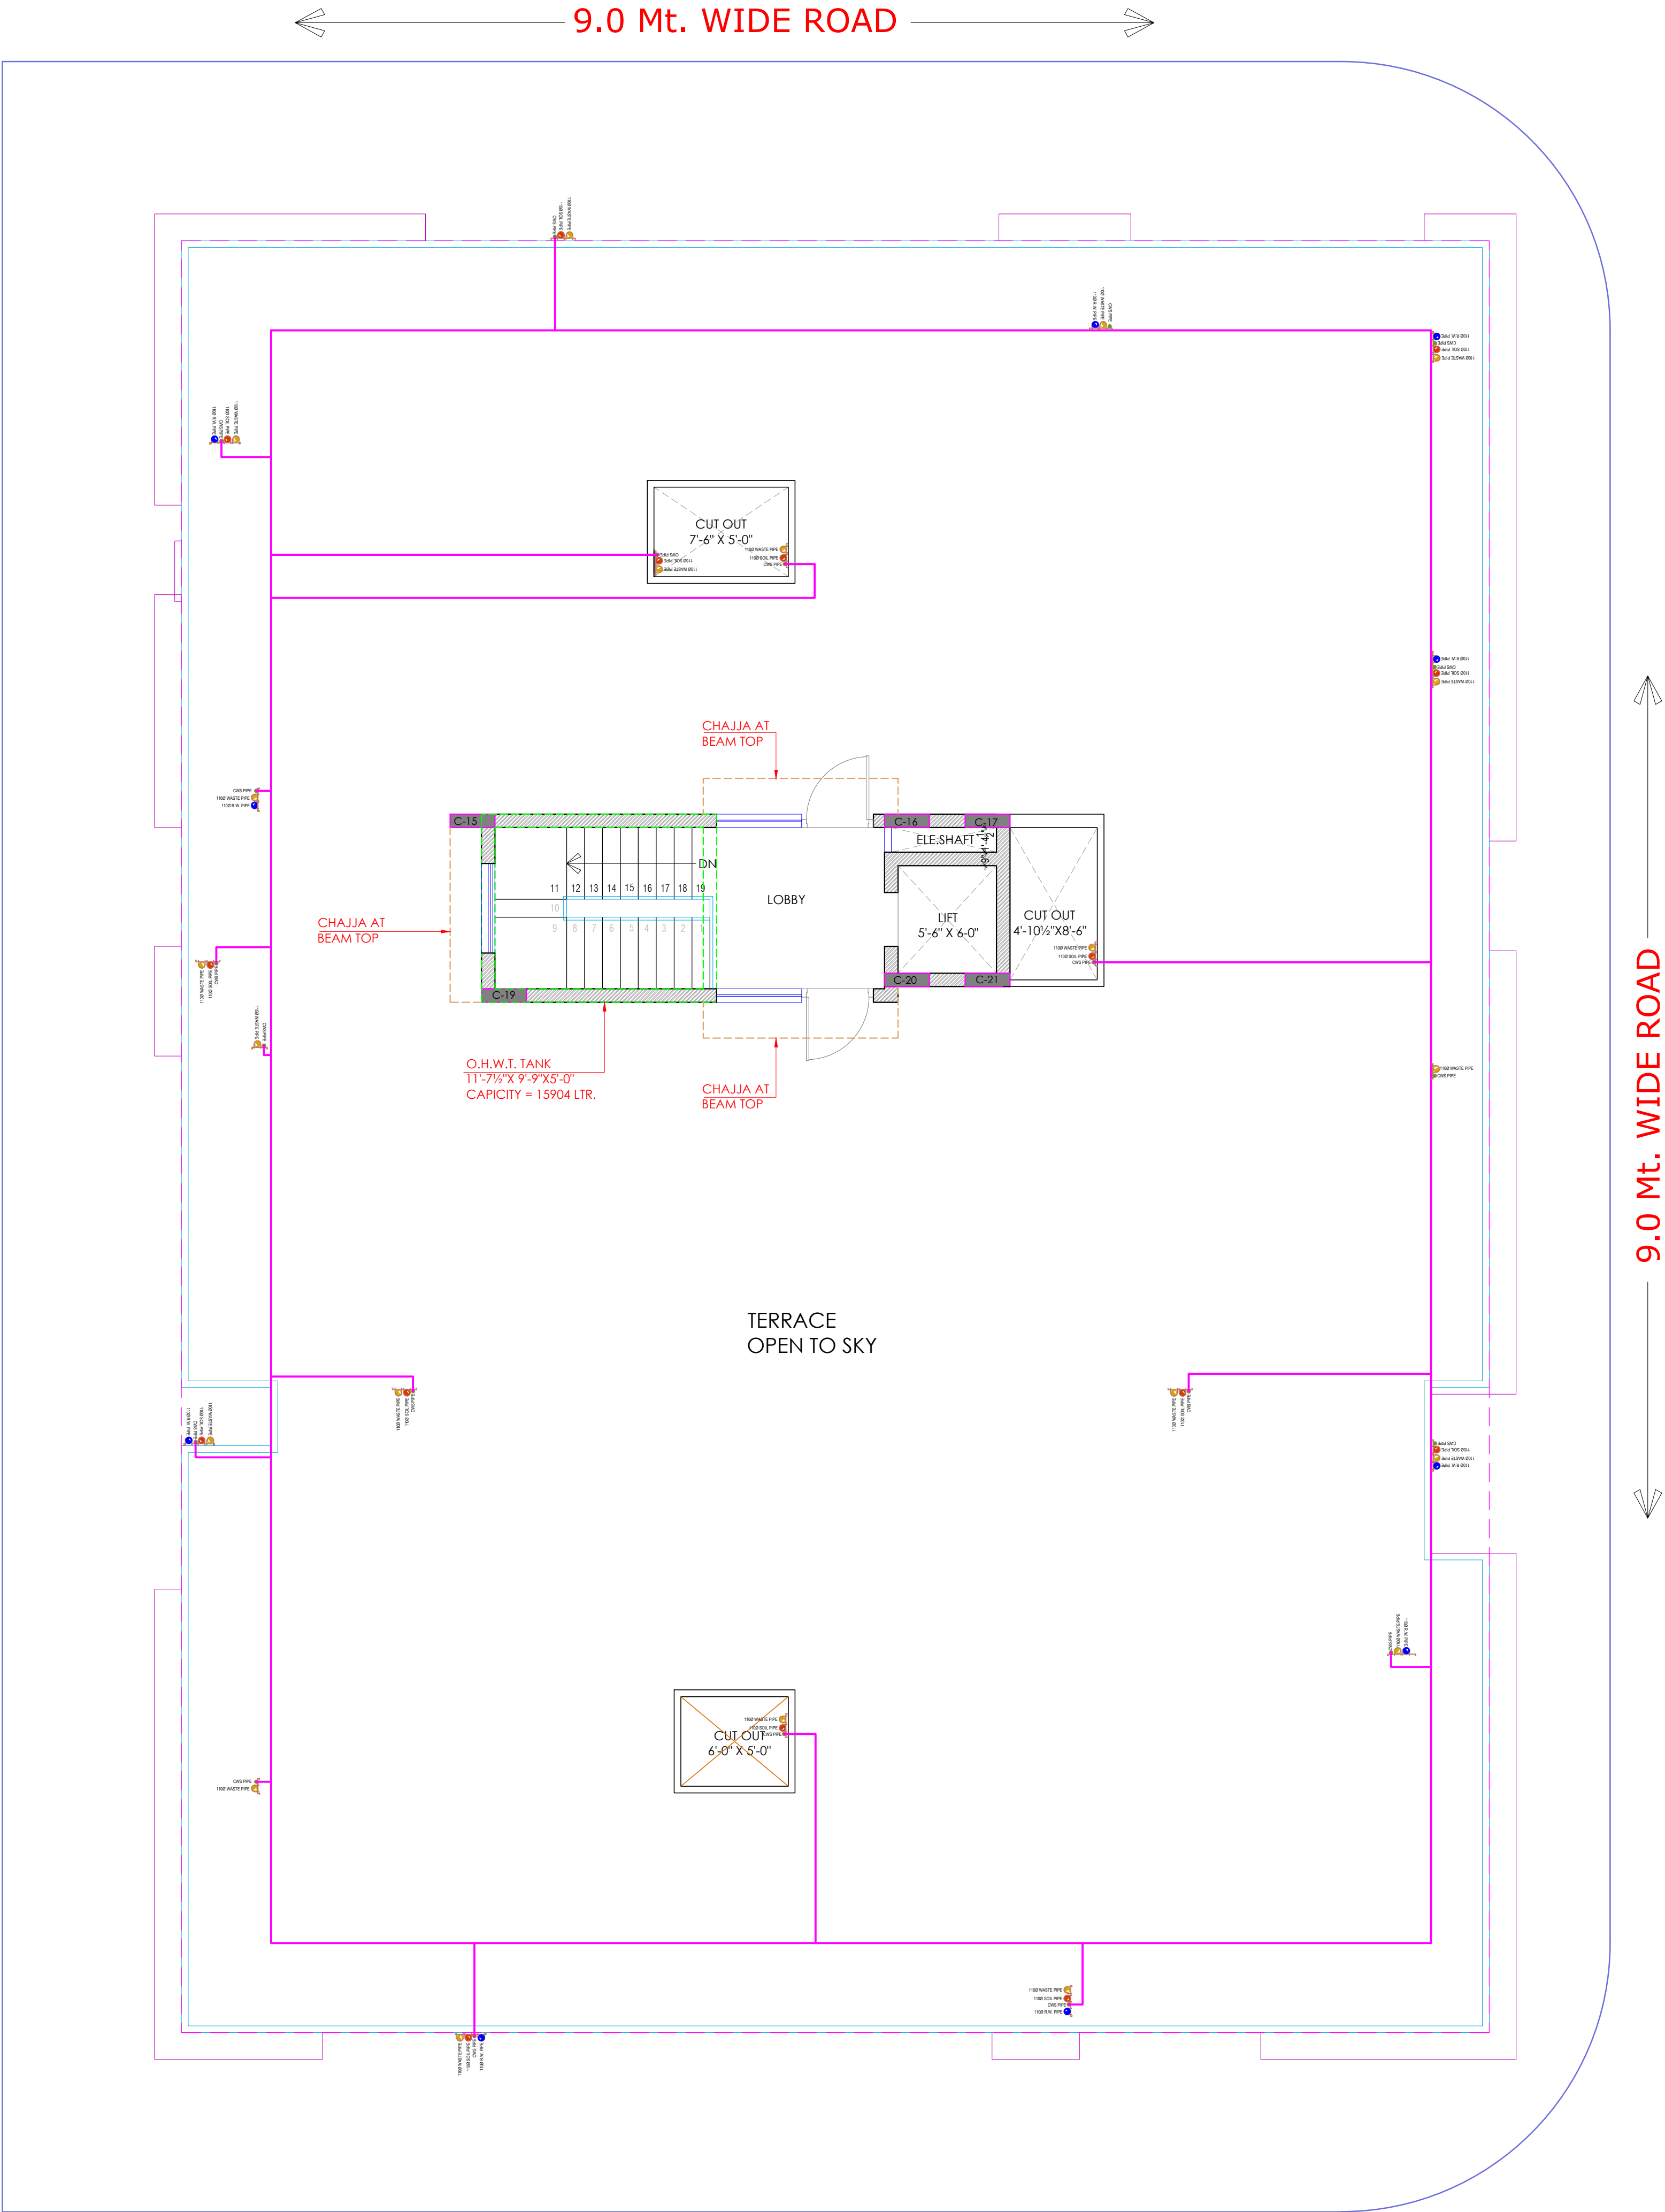

Er. SANJEEV SHARMA
B.E (Electrical)

For BALAJI BUILDERS
Proprietor

TERRACE FLOOR FLOOR RING MAIN LAYOUT, WATER SUPPLY SYSTEMATIC DIAGRAM
UG WATER TANK TO OHT FILLING ROUTE PLAN