


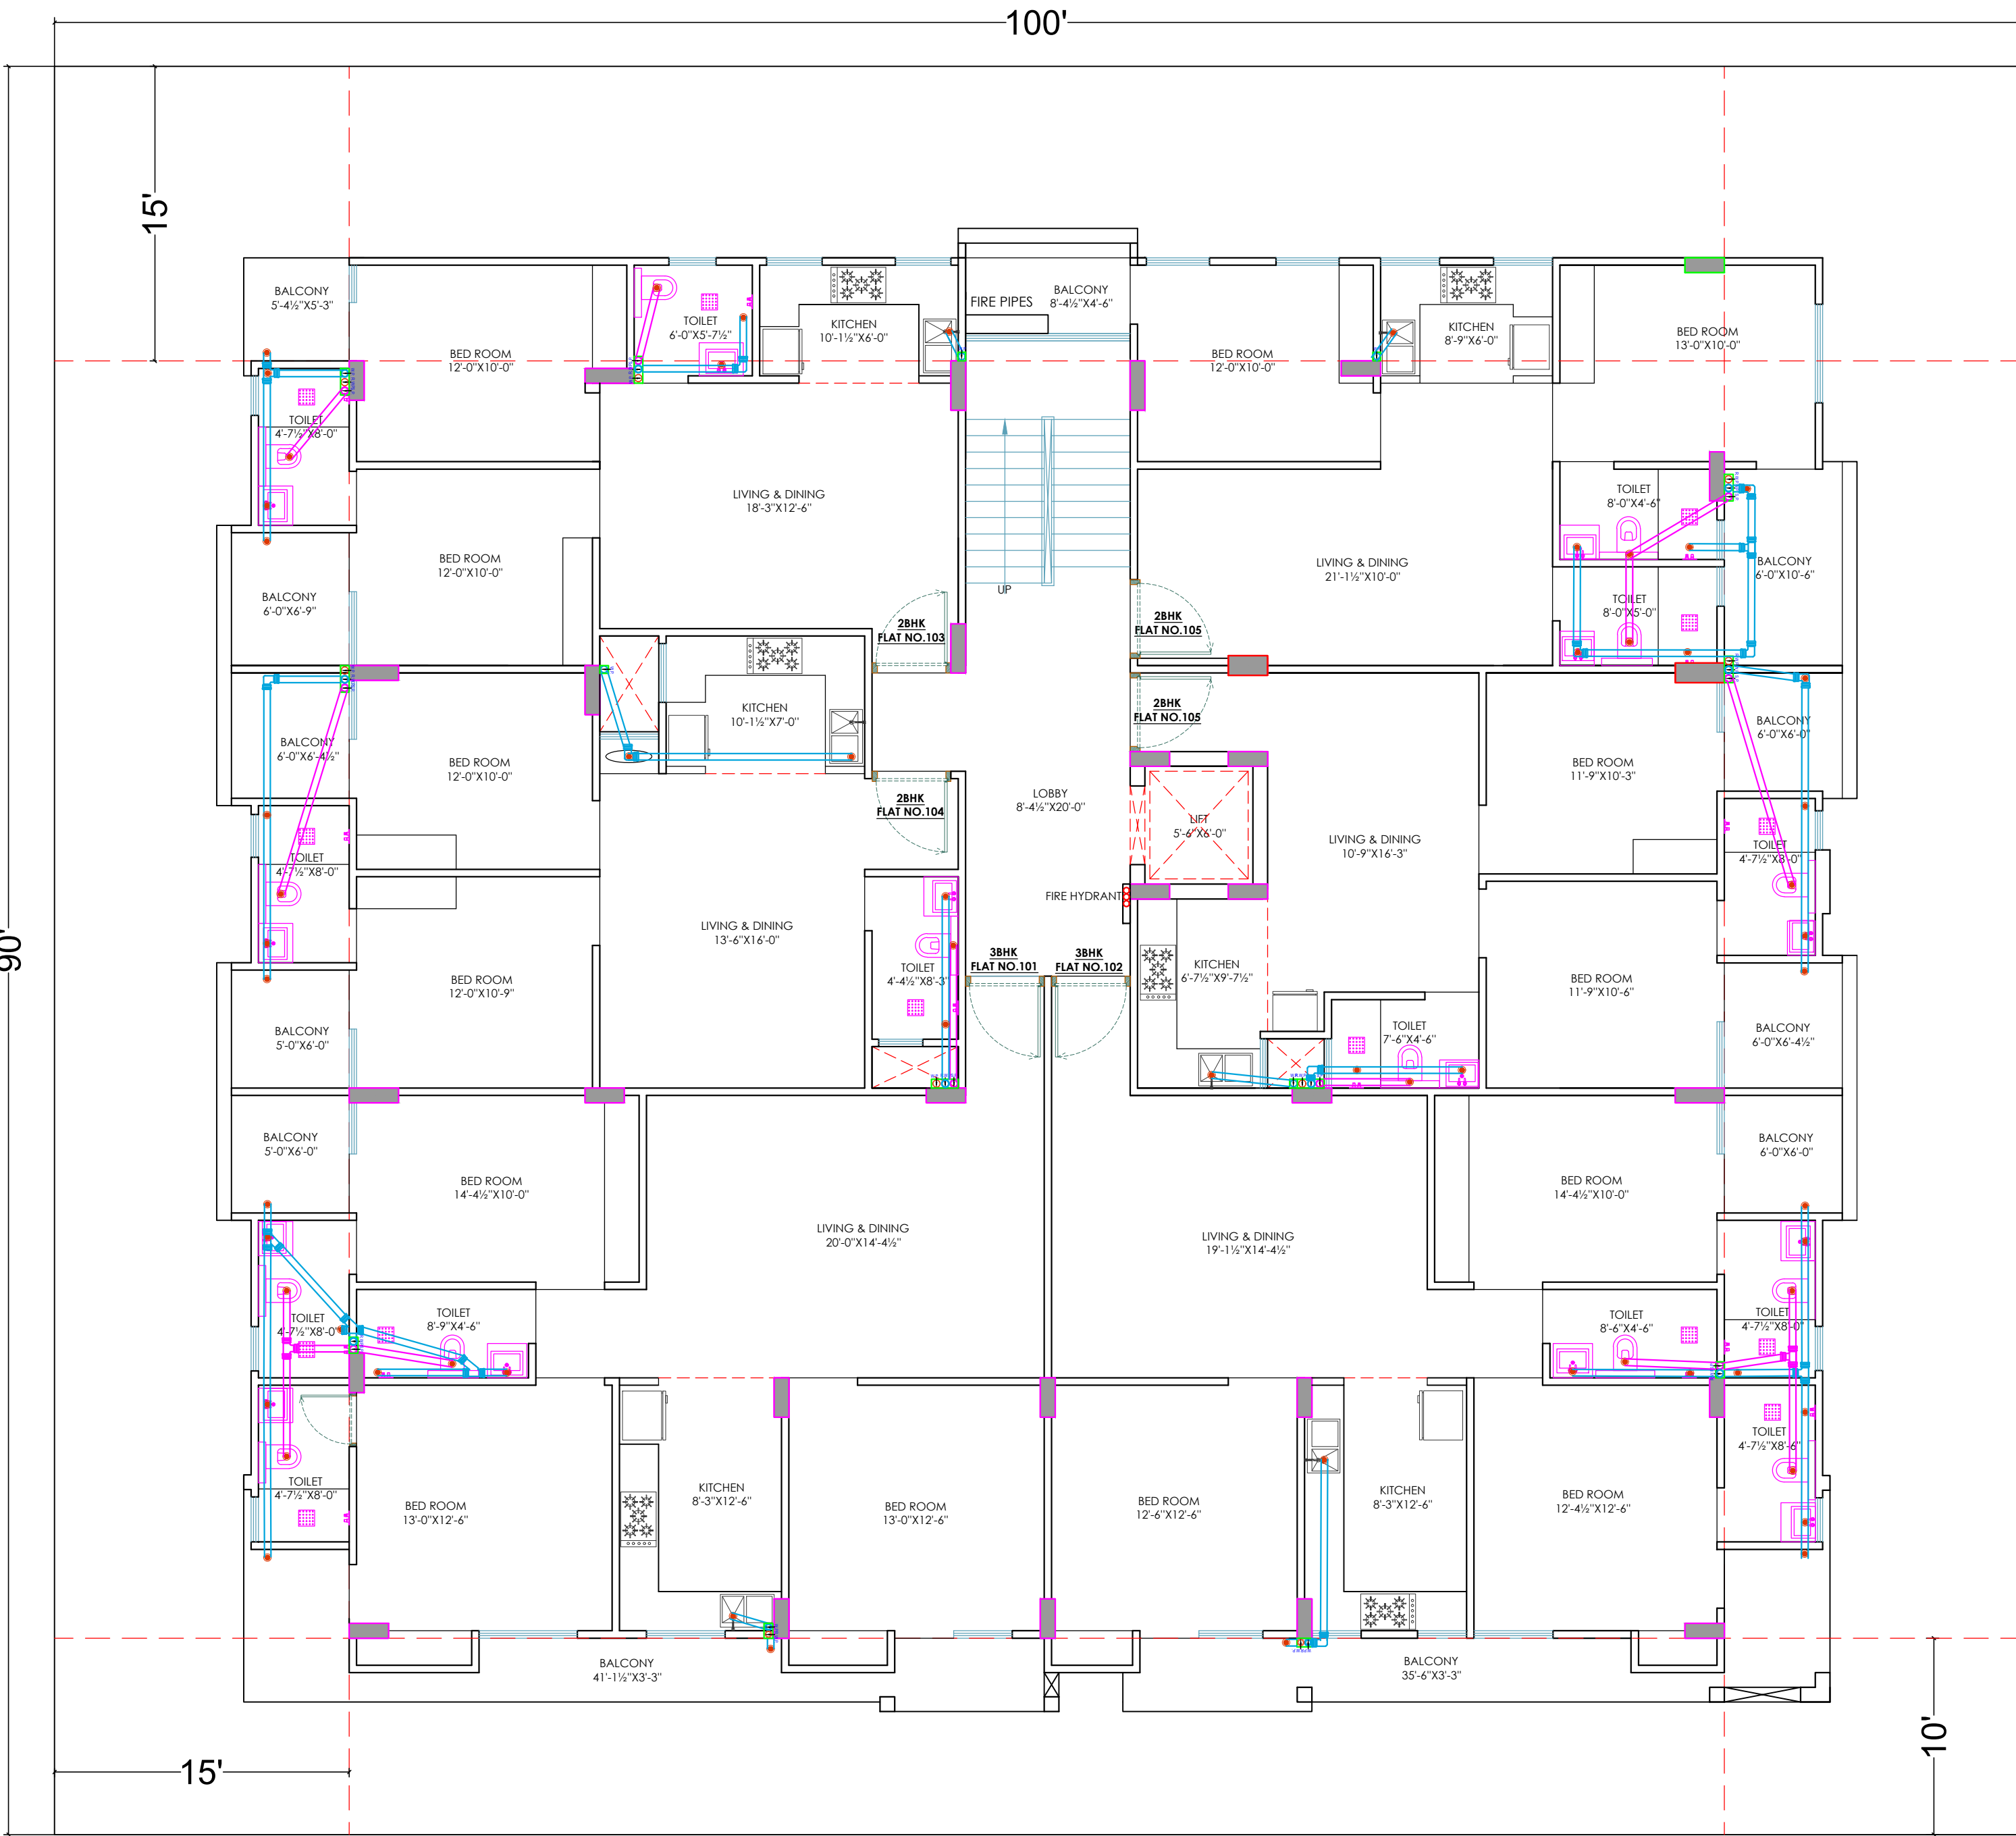

PROJECT TITTLE :-
PROPOSED RESIDENTIAL
BUILDING AT PLOT-20&21,HARE KRISHNA VILL-IIND IN KHAS
PER ARA NO.309 T0312,311/374,316 TO 320 VILL.DHOLAI,
SANGANER,JAIPUR

DRAWING TITTLE :-
TYPICAL FLOOR PLAN
FIRE HYDRANT DRAWING

- GENERAL NOTES
1. All dimensions are in feet and inches.
 2. Do not scale this drawing follow written dimensions only.
 3. This drawing should be read in conjunction with other architectural and structural drawings.
 4. Any discrepancy in the drawing should be immediately brought to the notice of architect.


CHKD BY :-
AR. VIJAY SHARMA

DRAWN BY :-
MANOJ KUMAWAT

DATE :-
12-05-2023

SCALE :-
NTS

REV.:-

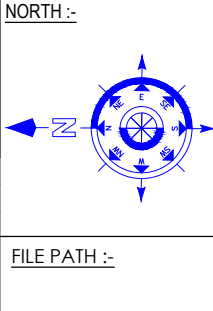

VISTAAR ARCHITECTS & PLANNERS

Architects :: Interior Designers
B-2/12, Chitrkoot scheme,
main Gandhi Path,Opp mall of jaipur,Jaipur-21
Email-Vistaararchitects.web@gmail.com
PH.- 0141-4116461,09001010366

Er. LOKESH WADHWAN
B.Tech.(Civil), M.Tech (Structure)
VASTRAE-AM-232

NOTE :-
This drawing is the sole copyright of Architects VISTAAR and should be used for the purpose expressly issued