




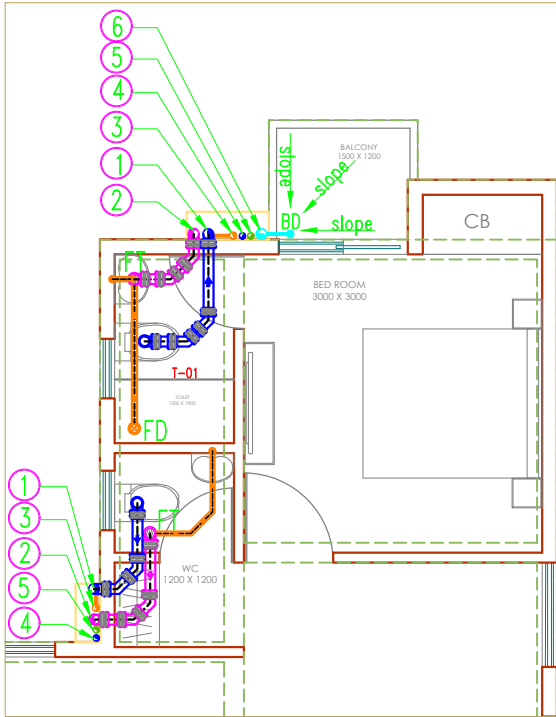


TYPICAL FLOOR TOILET DETAIL-01
DRAINAGE LAYOUT

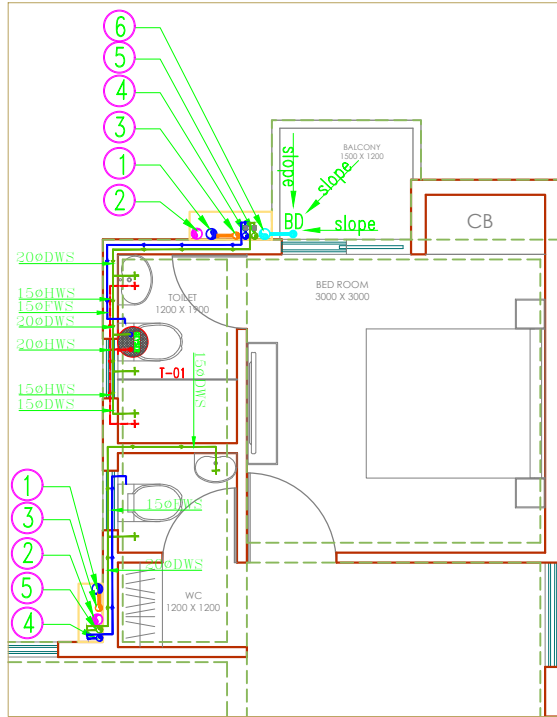


TYPICAL FLOOR TOILET DETAIL-01
WATER SUPPLY LAYOUT

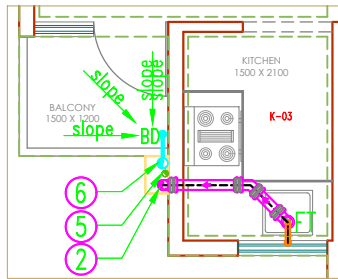


TYPICAL FLOOR KITCHEN DETAIL-03
DRAINAGE LAYOUT

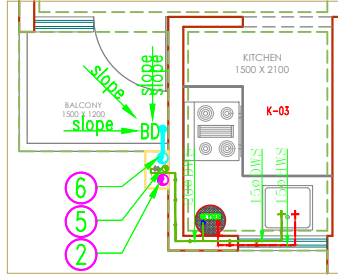


TYPICAL FLOOR KITCHEN DETAIL-03
WATER SUPPLY LAYOUT

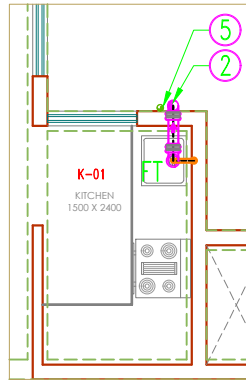


TYPICAL FLOOR KITCHEN DETAIL-01
DRAINAGE LAYOUT

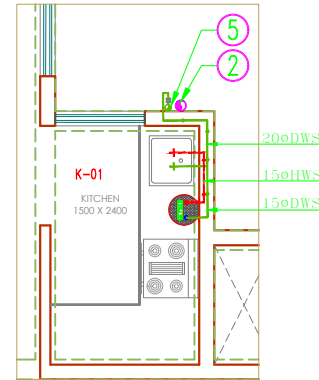


TYPICAL FLOOR KITCHEN DETAIL-01
WATER SUPPLY LAYOUT

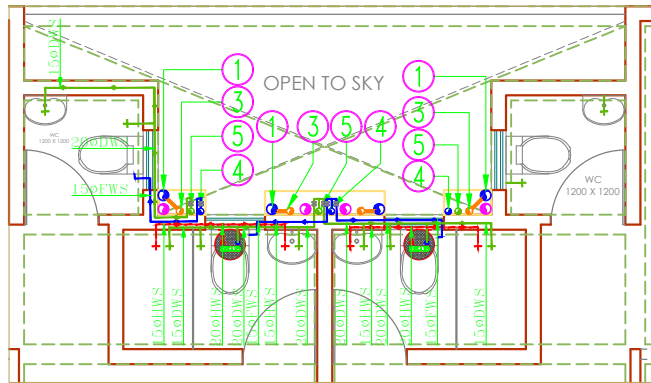


TYPICAL FLOOR TOILET DETAIL-02
WATER SUPPLY LAYOUT

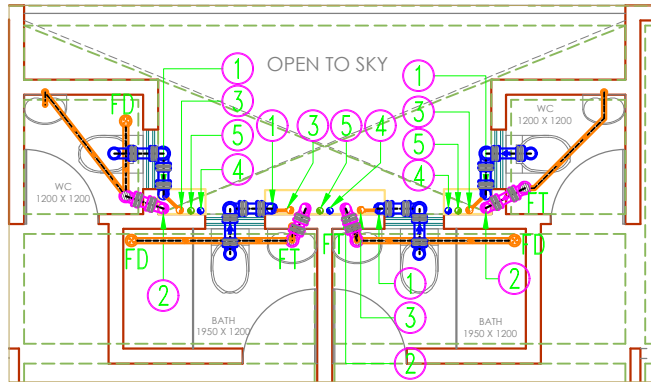


TYPICAL FLOOR TOILET DETAIL-02
DRAINAGE LAYOUT

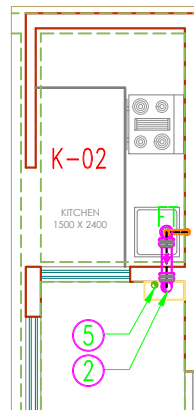

TYPICAL FLOOR KITCHEN DETAIL-02
DRAINAGE LAYOUT

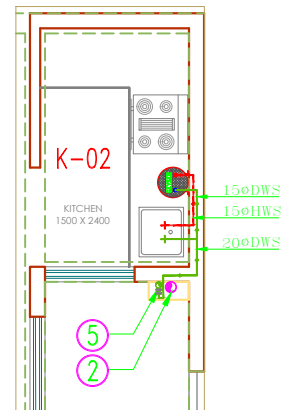

TYPICAL FLOOR KITCHEN DETAIL-02
WATER SUPPLY LAYOUT

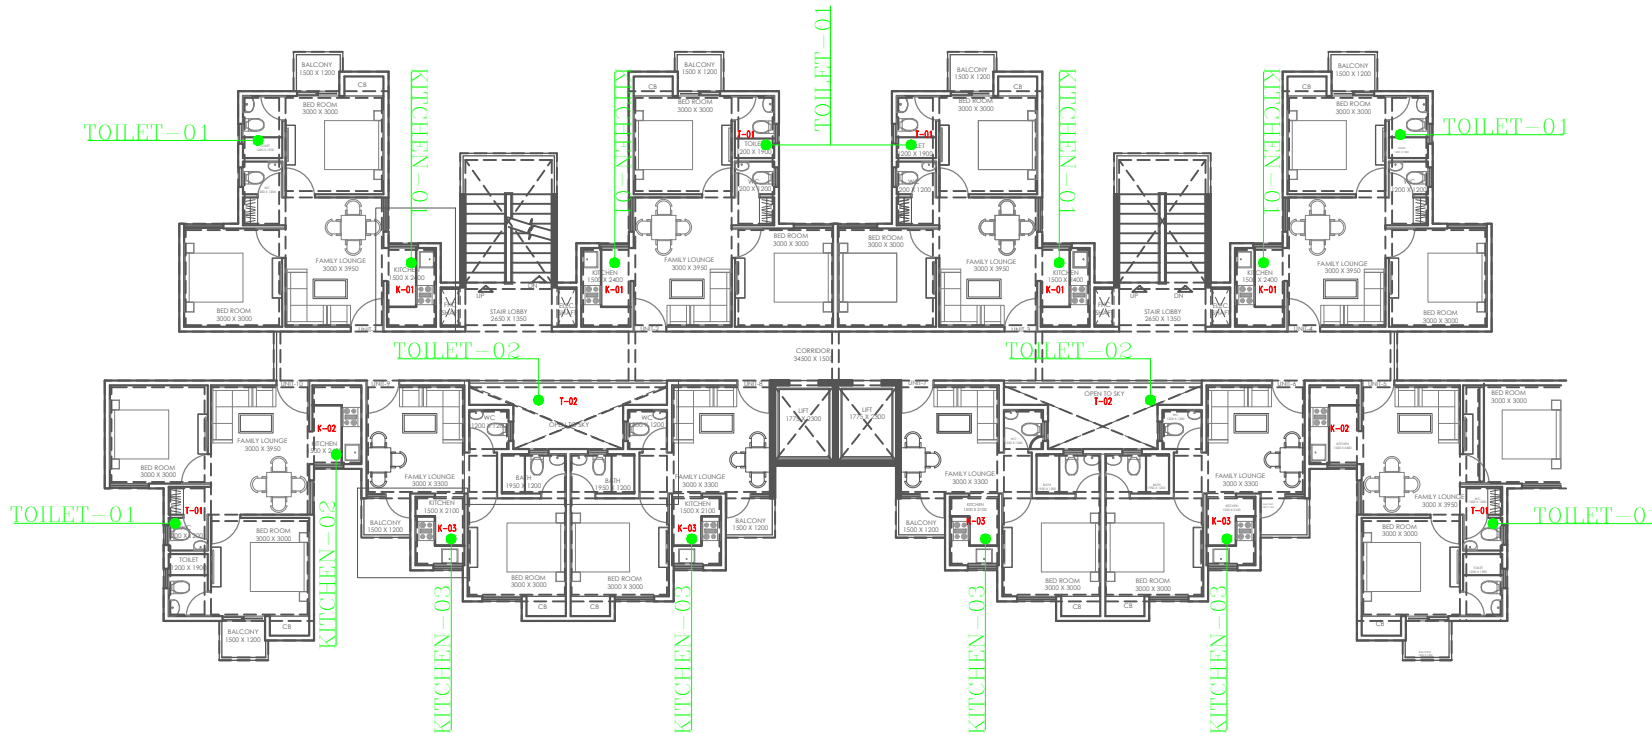

SCHEDULE OF PIPES

PIPE NO.	DESCRIPTION
1	110 OD uPVC SOIL PIPE
2	110 OD uPVC WASTE PIPE
3	90 OD ANTI-SYPHONES PIPE
4	FLUSHING WATER SUPPLY D/N TAKE
5	DOMESTIC WATER SUPPLY D/N TAKE
6	110 OD uPVC RAIN WATER PIPE FOR TERRACE
7	WATER SUPPLY RISER PIPE * (DOMESTIC)
8	WATER SUPPLY RISER PIPE * (FLUSHING)
FT	FLOOR TRAP (110 x 110) MM
FD	FLOOR DRAIN (110 x 63) MM
BD	BALCONY DRAIN (110 x 63) MM

PLUMBING NOTES:-

I	WASH BASIN TO FLOOR TRAP (FT) 40 OD uPVC PIPE.
II	KITCHEN SINK TO FLOOR TRAP (FT) 40 OD uPVC PIPE
III	FLOOR DRAIN (FD) TO FLOOR TRAP (FT) 63 OD UPVC WASTE PIPE.
IV	110 OD uPVC PIPE USED FOR SOIL & WASTE.
V	110 OD uPVC PIPE USED FOR TERRACE RAIN WATER
VI	90 OD uPVC PIPE USED FOR BALCONY.

PROJECT :

PROPOSE LAYOUT FOR COSMOS GREENS
AT VILL. SAIDPUR (BHIWADI DISTT. ALWAR)
ON KHASRA NO.-518-527, 534-538, 543-551

SHEET TITLE :

TYPICAL FLOOR TOILET DETAILS
DRAINAGE & WATER SUPPLY LAYOUT


ARCHITECTS :

Sapil Shilpkar Architects Pvt. Ltd.
Sustainable Green Architecture
architects, engineers, valuers, project managers
OFF. - 909, 9th Fl., ILD Trade Centre, Sec.-47, Sohna Road, Gurgaon.
Ph. No. - 0124-4361909
OFF. - Hotel Regency Complex Bhiwadi (Rajasthan)
Ph. No. - 01493-221766
OFF. - 307, 308, Central Plaza, CC2, EPIP, Neemrana (Rajasthan)
e-mail - info@sapilind.in, infoggn@sapilind.in, informn@sapilind.in

PLUMBING & FIRE CONSULTANT:-

BEHERA & ASSOCIATES
F-623a, BEHIND, CNG FILLING STATION,
LADO SARAI, NEW DELHI 110030
PH:- 011-40583898, 09811911853
E mail:- behera.associates@gmail.com

SCALE A2-1:50	DRG. NO.	REV. NO.
DATE 06-08-2018	PL-BA-CO-AR-101	
P/C BY :		
CHK BY M. SINGH		
DLT BY DK GOLA		
FILE:		

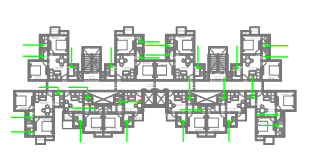

PROJECT :
PROPOSE LAYOUT FOR COSMOS GREENS
AT VILL. SAIDPUR (BHIWADI DISTT. ALWAR)
ON KHASRA NO.-518-527, 534-538, 543-551

SHEET TITLE :
CLUSTER & UNIT
LAYOUT
WATER SUPPLY DAIGRAM

ARCHITECTS :
Shilpkar Architects Pvt.
Sustainable Green Architecture
architects, interior designers, project managers
OFF. : - 909, 9th Fl., LD Trade Centre, Sec.-47, Sohna Road, Gurgaon.
Ph. No. : - 0124-4361909
OFF. : - Hotel Regency Complex Bhiwadi (Rajasthan)
Ph. No. : - 01493-221766
OFF. : - 307, 308, Central Plaza, CC2, EPP, Neemrana (Rajasthan)
e-mail : - info@shilpkar.in, info@shilpkar.in, info@shilpkar.in



PLUMBING & FIRE CONSULTANT:-
BEHERA & ASSOCIATES
F-623a, BEHIND, CNG FILLING STATION,
LADO SARAI, NEW DELHI 110030
PH:- 011-40583898, 09811911853
E mail:- behera.associates@gmail.com

SCALE : 1:125(A2)
DATE : 06-08-2018
P/C BY :
CHK BY : M. SINGH
DLT BY : DK GOLA
FILE:

DRG. NO.
PL-BA-CO-AR-101
REV. NO.

LEGEND:-	
—	DOMESTIC WATER SUPPLY D/N TAKE
—	FLUSHING WATER SUPPLY D/N TAKE
DWS	DOMESTIC WATER SUPPLY
FWS	FLUSHING WATER SUPPLY
X	 BALL VALVE

SITE PLAN

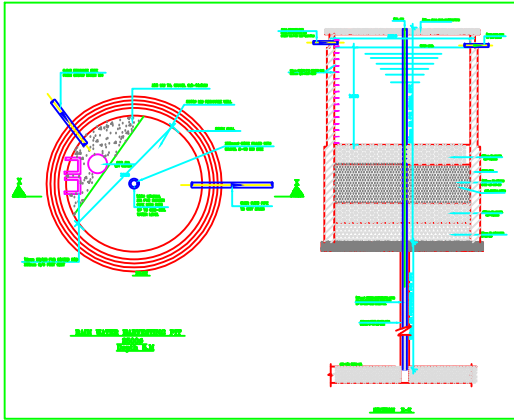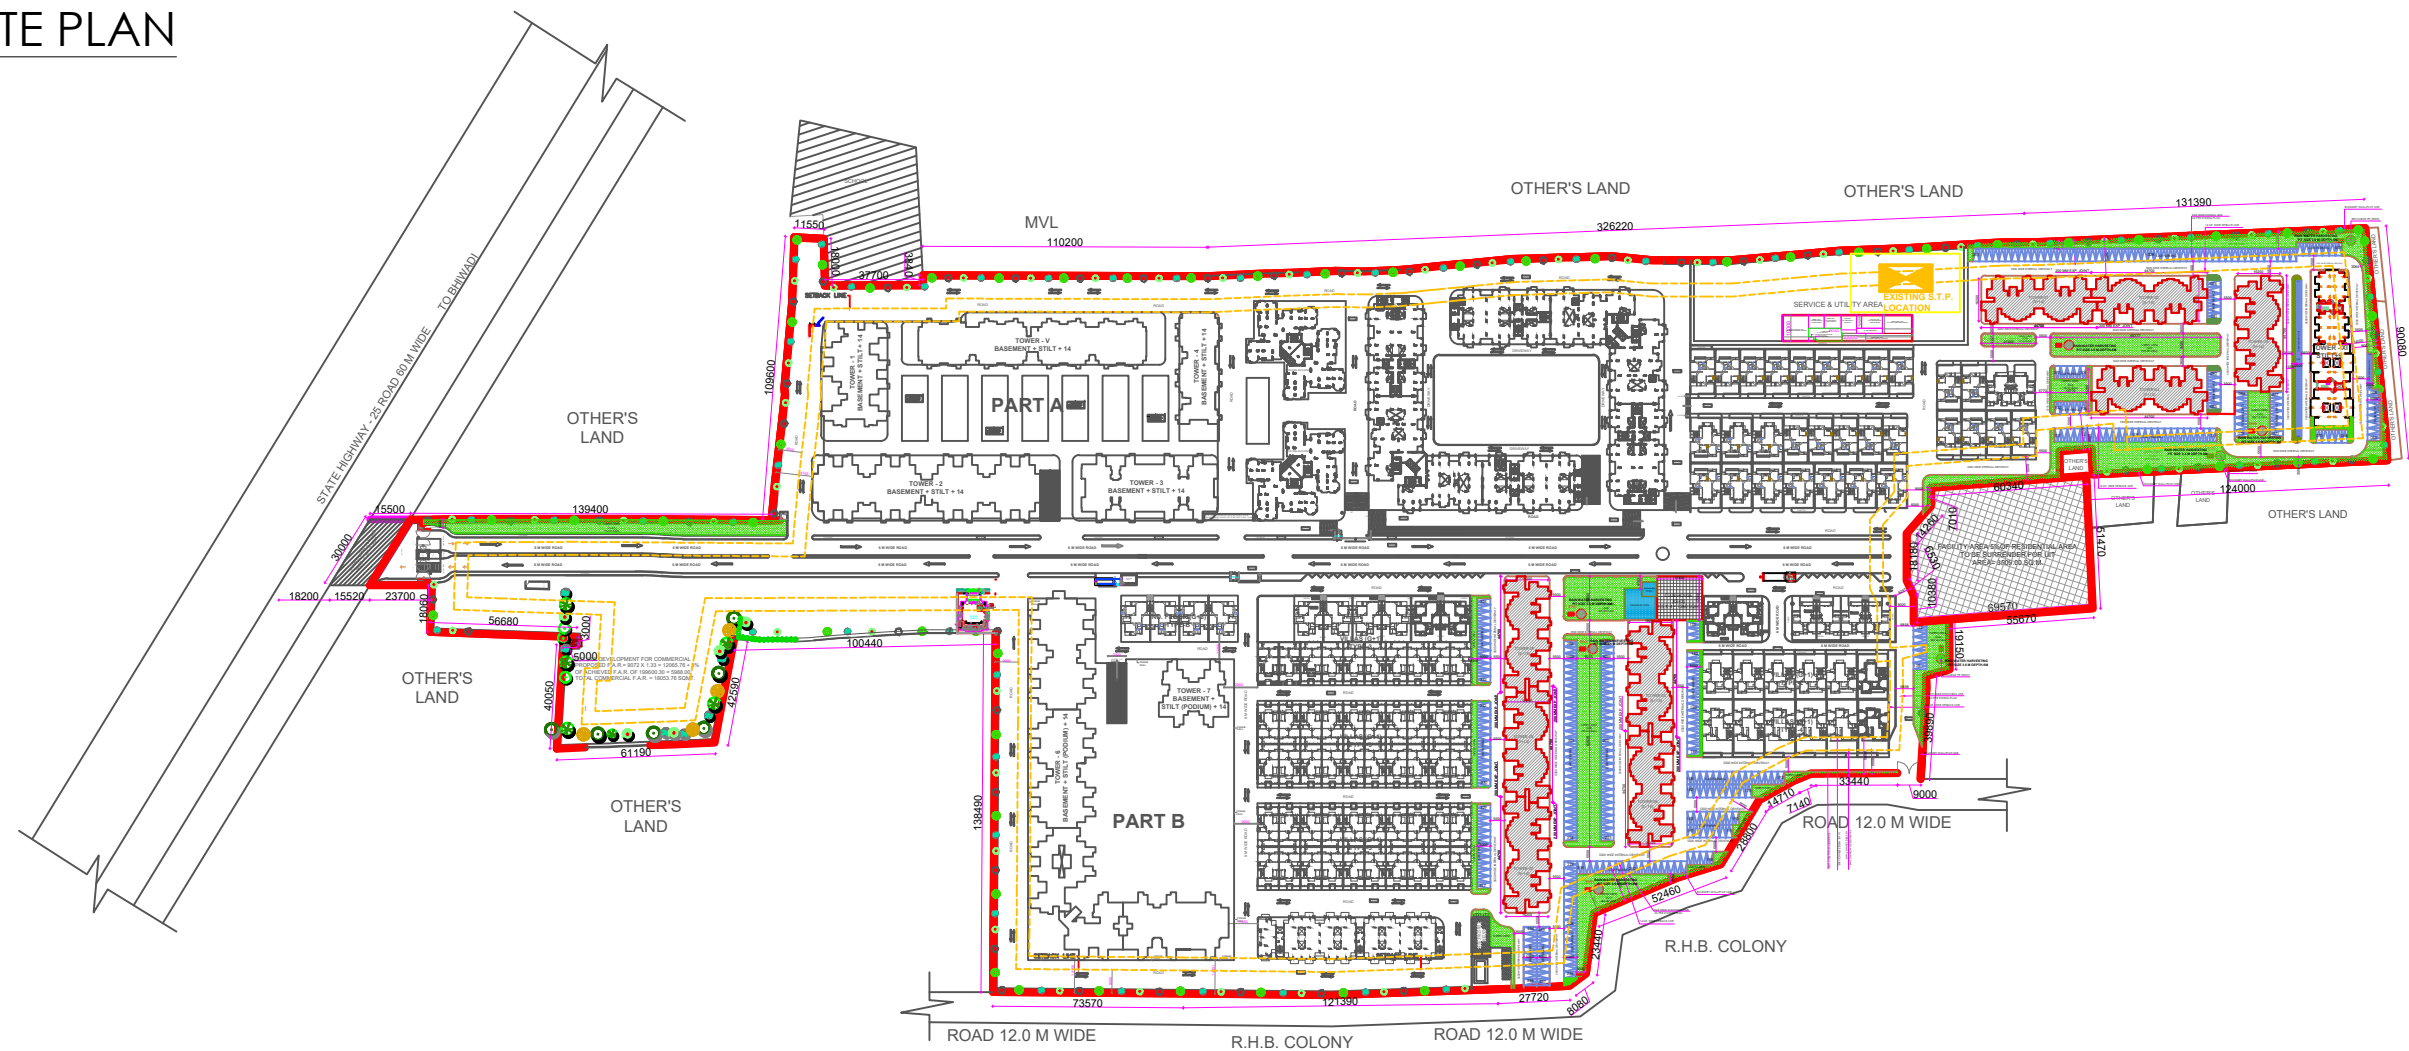





ARCHITECTS :
Sa Shilpkaar Architects Pvt. Ltd.
Sustainable Green Architecture
architects, engineers, valuers, project managers
OFF. - 909, 9th Fl., ILD Trade Centre, Sec.-47, Sohna Road, Gurgaon,
Ph. No. - 0124-4361909, 2217088
OFF. - Hotel Regency Complex Bhiwadi (Rajasthan)
Ph. No. - 01493-221766, 222652
OFF. - 307, 308, Central Plaza, CC2, EPIP, Neemrana (Rajasthan)
e-mail - info@saplind.in, infogn@saplind.in, informn@saplind.in

Signature of Owner	Signature of Architect
--------------------	------------------------

ADDRESS :
PROPOSED RESIDENTIAL GROUP HOUSING FOR
COSMOS GREENS OF M/S COSMOS INFRA
ENGINEERING (INDIA) LTD. & M/S INNOVATIVE
COLONISERS PVT. LTD. AT KHASRA NO.-518-527,
534-538, 543-551 VILL. SAIDPUR (BHIWADI),
DISTT.-ALWAR(RAJASTHAN)

SHEET TITLE :
SITE PLAN & PARKING PLAN

TYPE : SITE PLAN	DATE : 30-05-2018	NORTH :
SHEET NO : -----	SCALE : N.T.S.	

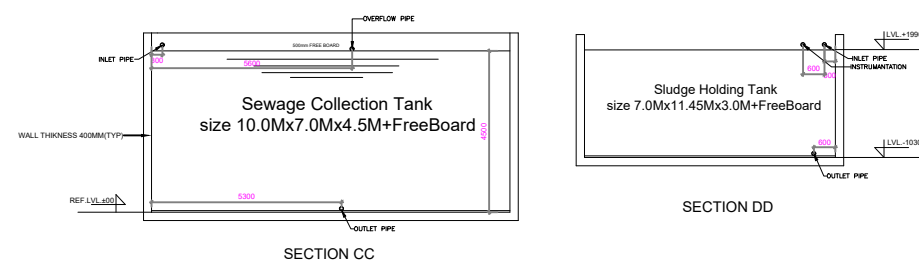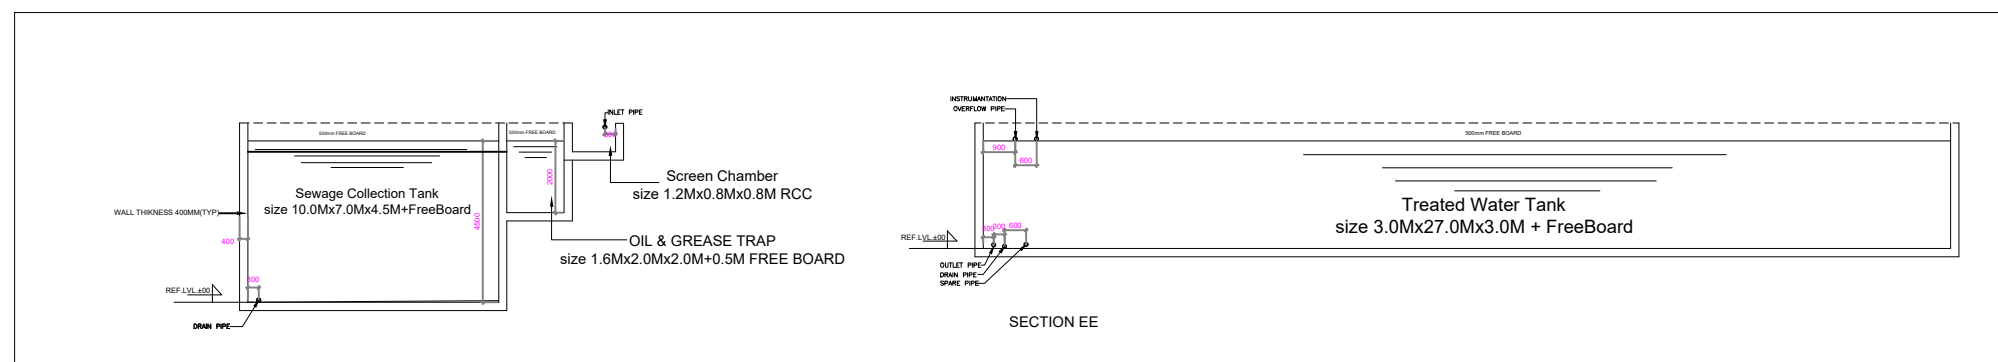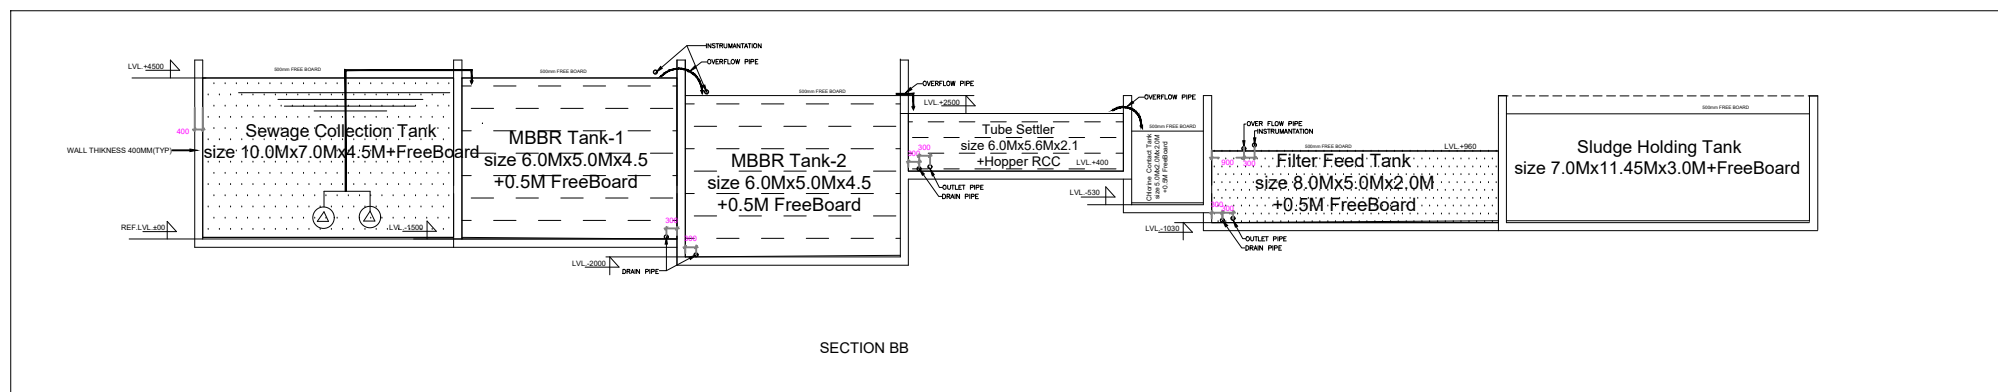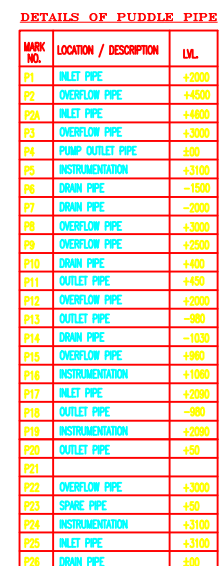

R.NO.	DATE	DESCRIPTION	REVISION	REV-01
S.NO.	DATE	ISSUE TO	ISSUED	FO
PROJECT NAME: PROPOSED PLAN OF COSMOS GREENS AT VILL. SAIDPUR (BHIWADI DIST. ALWAR) ON KHASRA NO. 518-527, 534-538 543-551				
TITLE OF DRAWING: PLUMBING DRAWING S.T.P DETAIL CAP-1200 KLD				
CLIENT'S NAME: COSMOS INFRA ENGINEERING INDIA LTD. & INNOVATIVE COLONISERS PVT. LTD.				
STRUCTURE CONSULTANT : OPTIMIZATION CONSULTANTS				
MEP CONSULTANT :				
SPC Engineering Pvt. Ltd. 62, Samrat Enclave, Near Britannia Chowk, Road No.43, Delhi-110034 Tel.-011-45380016, 47064964, 43063979. E-Mail: info@spcdelhi.com				
ARCHITECT CONSULTANT :				
Ar. SANJAY JETHI LINEAR CONCEPTS CORPORATE ARCHITECTURE, INTERIORS & PROJECT MANAGEMENT				
407, GD-ITL NORTH-EX TOWER, A-09 NETAJI SUBHASH PLACE, PITAM PURA NEW DELHI-110034, INDIA TEL.- 9811205100, 011-27354056, 011-42470300 EMAIL: linear_concepts@yahoo.com WEBSITE : www.linearconcepts.in				
JOB. NO. - 106		DWG. NO.		
SCALE	DATE	BH-SPC303-PL-STP-3001		
N.T.S	30-06-16	Revision Suffix		
GOPAL SANI DRAWN	GOPAL SANI DEALT	AYUSH CHECKED BY	AYUSH APPROVED BY	ISSUED BY