


PROPOSED LAY-OUT PLAN OF RESIDENTIAL COLONY
HAPPY AEROCITY-I


KHASRA NO 730/224 =19499.25 SQ MTR.
AT VILLAGE :- FARASIYA, TEH.- KISHANGARH , DIST. AJMER

ELECTRICAL LAYOUT PLAN

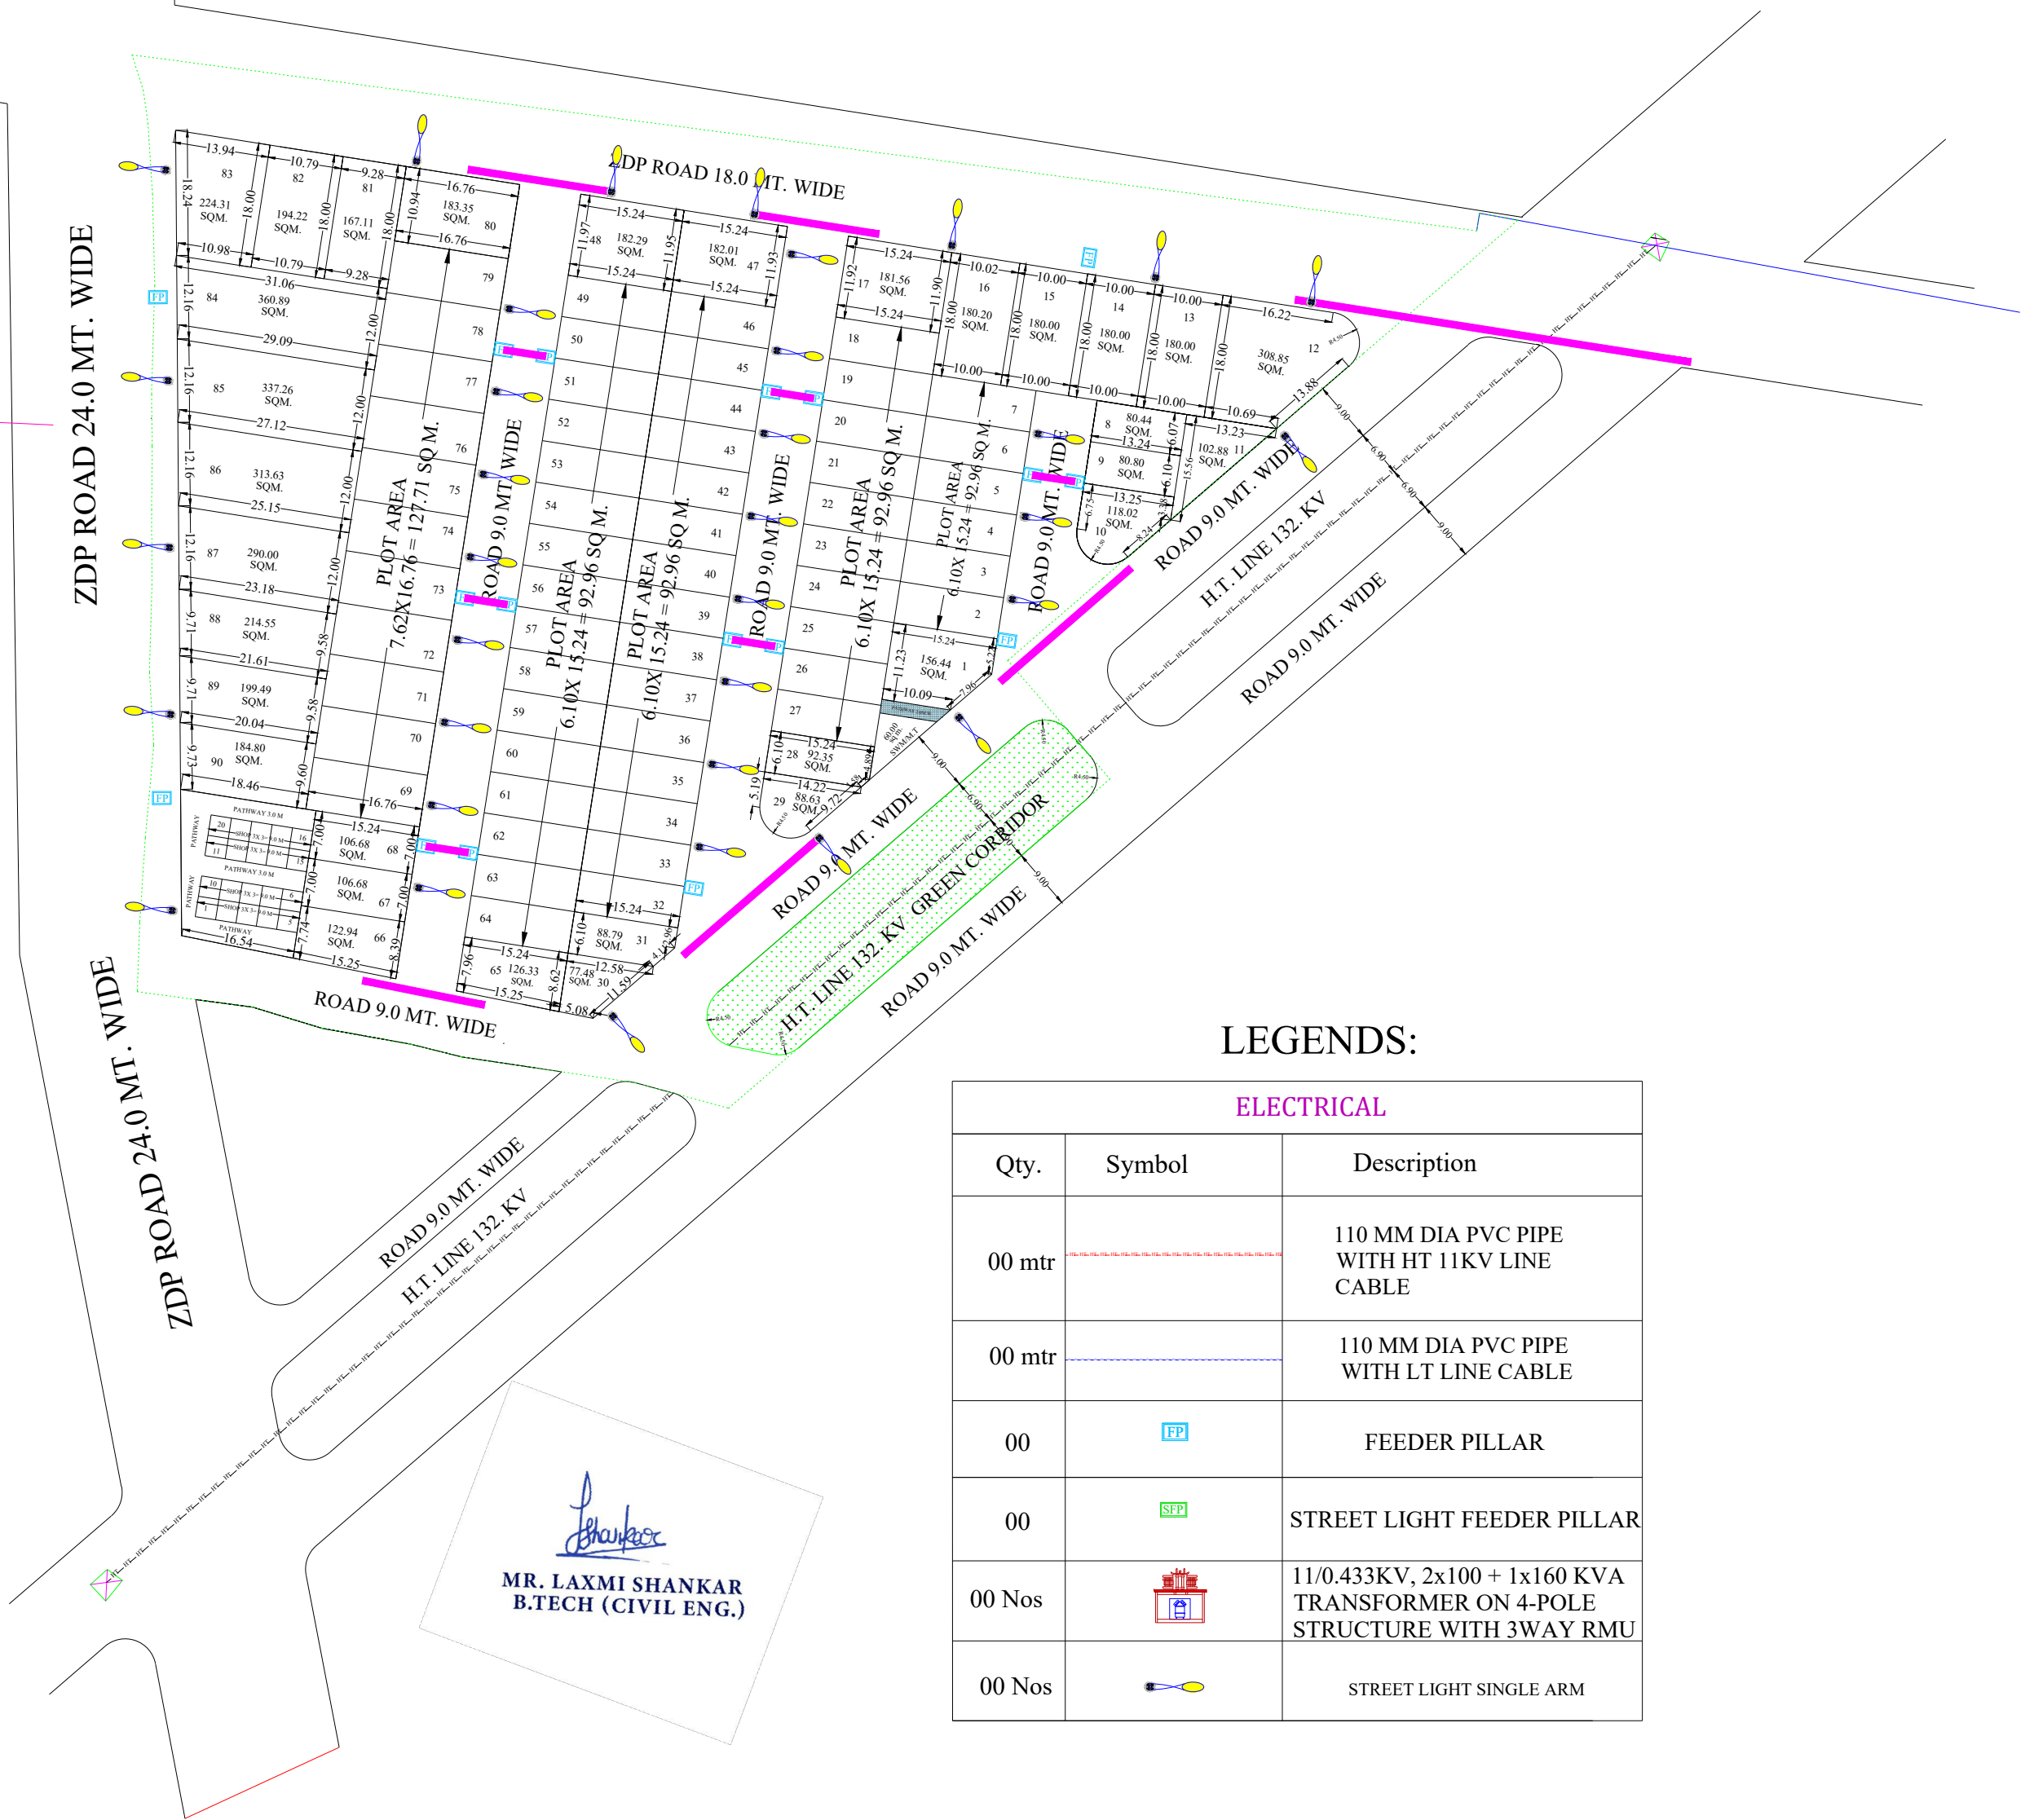

LEGENDS:

ELECTRICAL		
Qty.	Symbol	Description
00 mtr		110 MM DIA PVC PIPE WITH HT 11KV LINE CABLE
00 mtr		110 MM DIA PVC PIPE WITH LT LINE CABLE
00		FEEDER PILLAR
00		STREET LIGHT FEEDER PILLAR
00 Nos		11/0.433KV, 2x100 + 1x160 KVA TRANSFORMER ON 4-POLE STRUCTURE WITH 3WAY RMU
00 Nos		STREET LIGHT SINGLE ARM

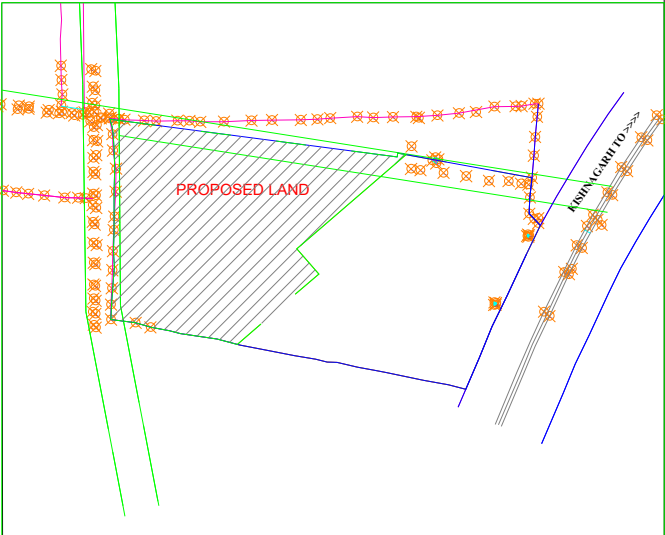

KHASRA PLAN

AREA ANALYSIS :-

S.No.	LAND USED	AREA IN (SQ.MTR.)	(%)
1.	RESIDENTIAL	11366.91	58.29 %
2.	INFORMAL	389.99	02.00 %
TOTAL = 1+2		11756.06	60.28 %
3	PARK/ H.T. LINE	902.51	04.63 %
4	ZDP 24M. ROAD	553.80	02.84 %
5	ZDP 18M. ROAD	2428.97	12.46 %
6	SWM/M.T	60.00	00.3 %
7	ROAD	3797.91	19.49 %
TOTAL = 3 TO 7		7743.19	39.71 %

SCHEME AREA	19499.25	100.00 %
	1.94 HECT.	

Proposed Lay-Out Plan of Residential Colony

HAPPY AEROCITY-I

KHASRA NO 730/224 =19499.25 SQ MTR.
AT VILLAGE :- FARASIYA, TEH.- KISHANGARH , DIST. AJMER

योजना का नाम :- हैप्पी एरोसिटी - I

NORTH :- 	SCALE :- 1"=50'	APPLICANT :-
--------------	--------------------	--------------