


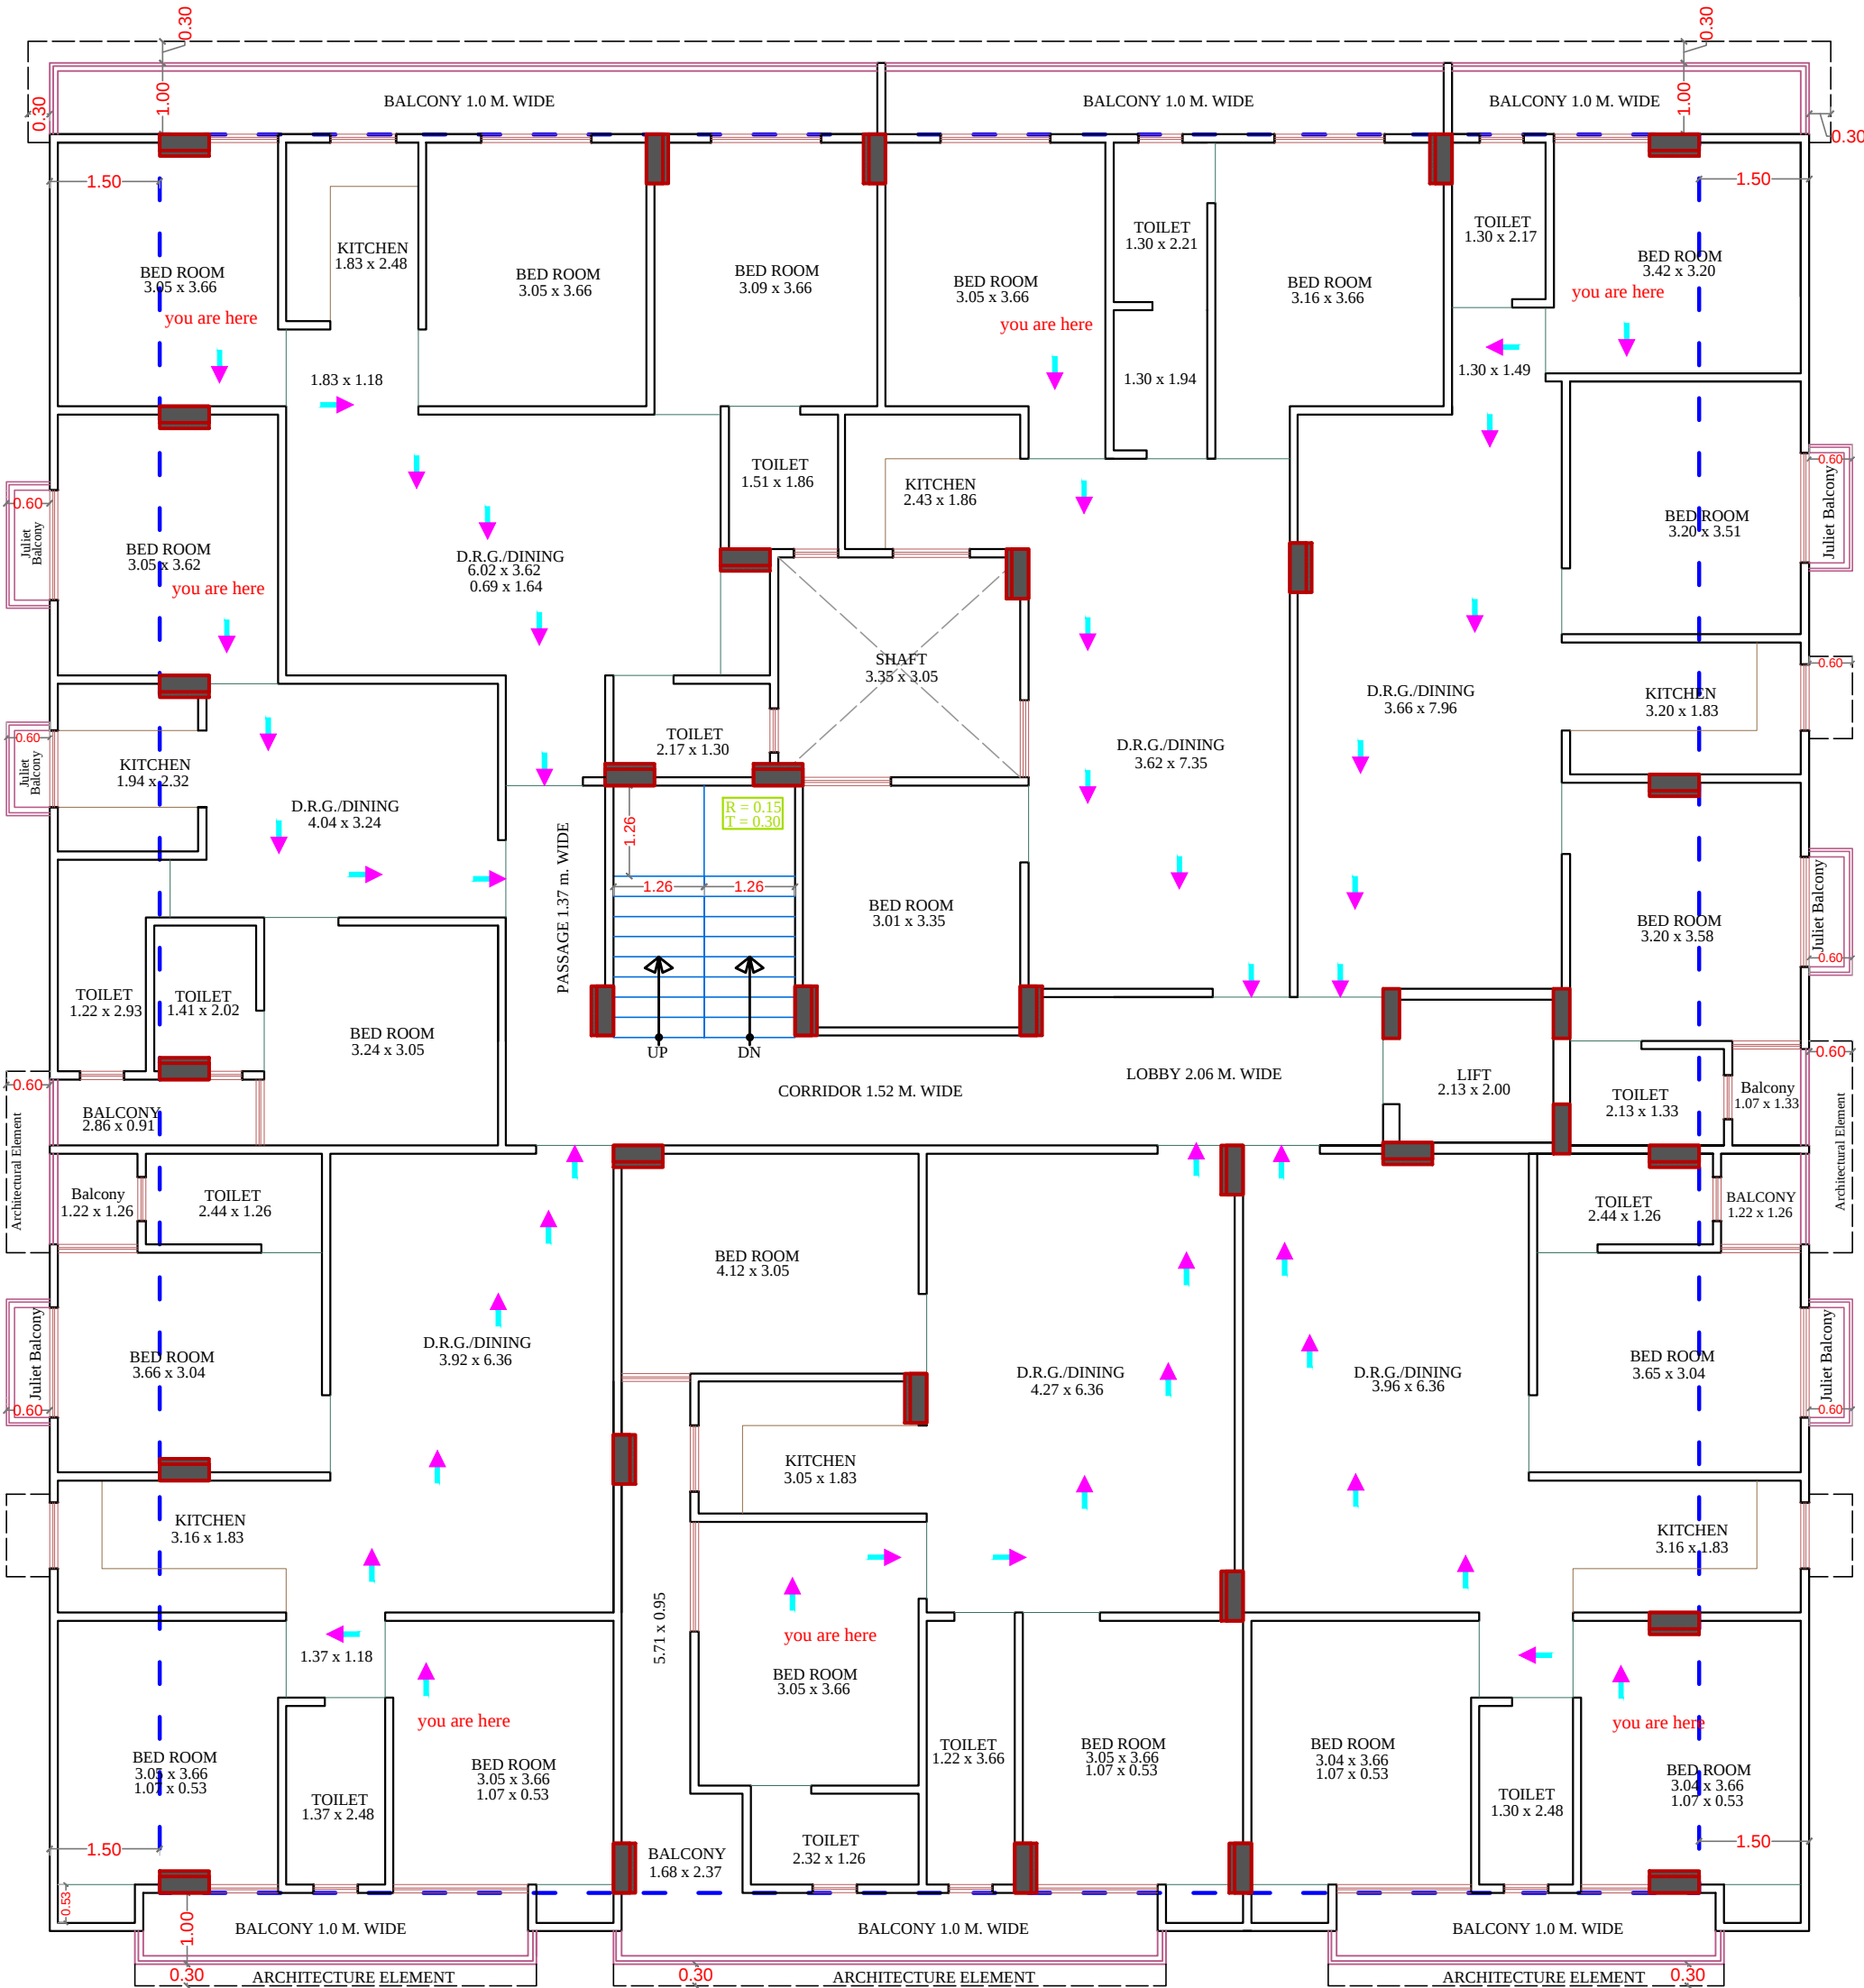


GROUND, 1st TO 5th FLOOR PLAN

For B D BUILDERS
[Signature]
Proprietor

[Signature]
RAMESH KUMAWAT
M.E.P. CONSULTANT
B.E. CIVIL

PROJECT TITLE :- PROPOSED BUILDING AT PLOT NO. A102, A-103, A-104, A-105, A-122, A-123, A-124 & A-125, NARAYAN VATIKA, AT VILLAGE-DHAWAS, HEERAPURA AJMER ROAD, JAIPUR	BUILDING NAME ANANTAM UTSAV NARAYAN VATIKA		DRAWING TITLE :- TYPICAL FLOOR FIRE FIGHTING	<u>SPACE CONSULTANT</u> PLOT-A-173, JAGDAMBA NAGAR, HEERAPURA POWER HOWER, JAIPUR (RAJ) 302024		DRN. BY			NORTH
	DEVELOPER NAME BD BUILDERS			APPD. BY		DATE	REVISION		
				SCALE	N.T.S				

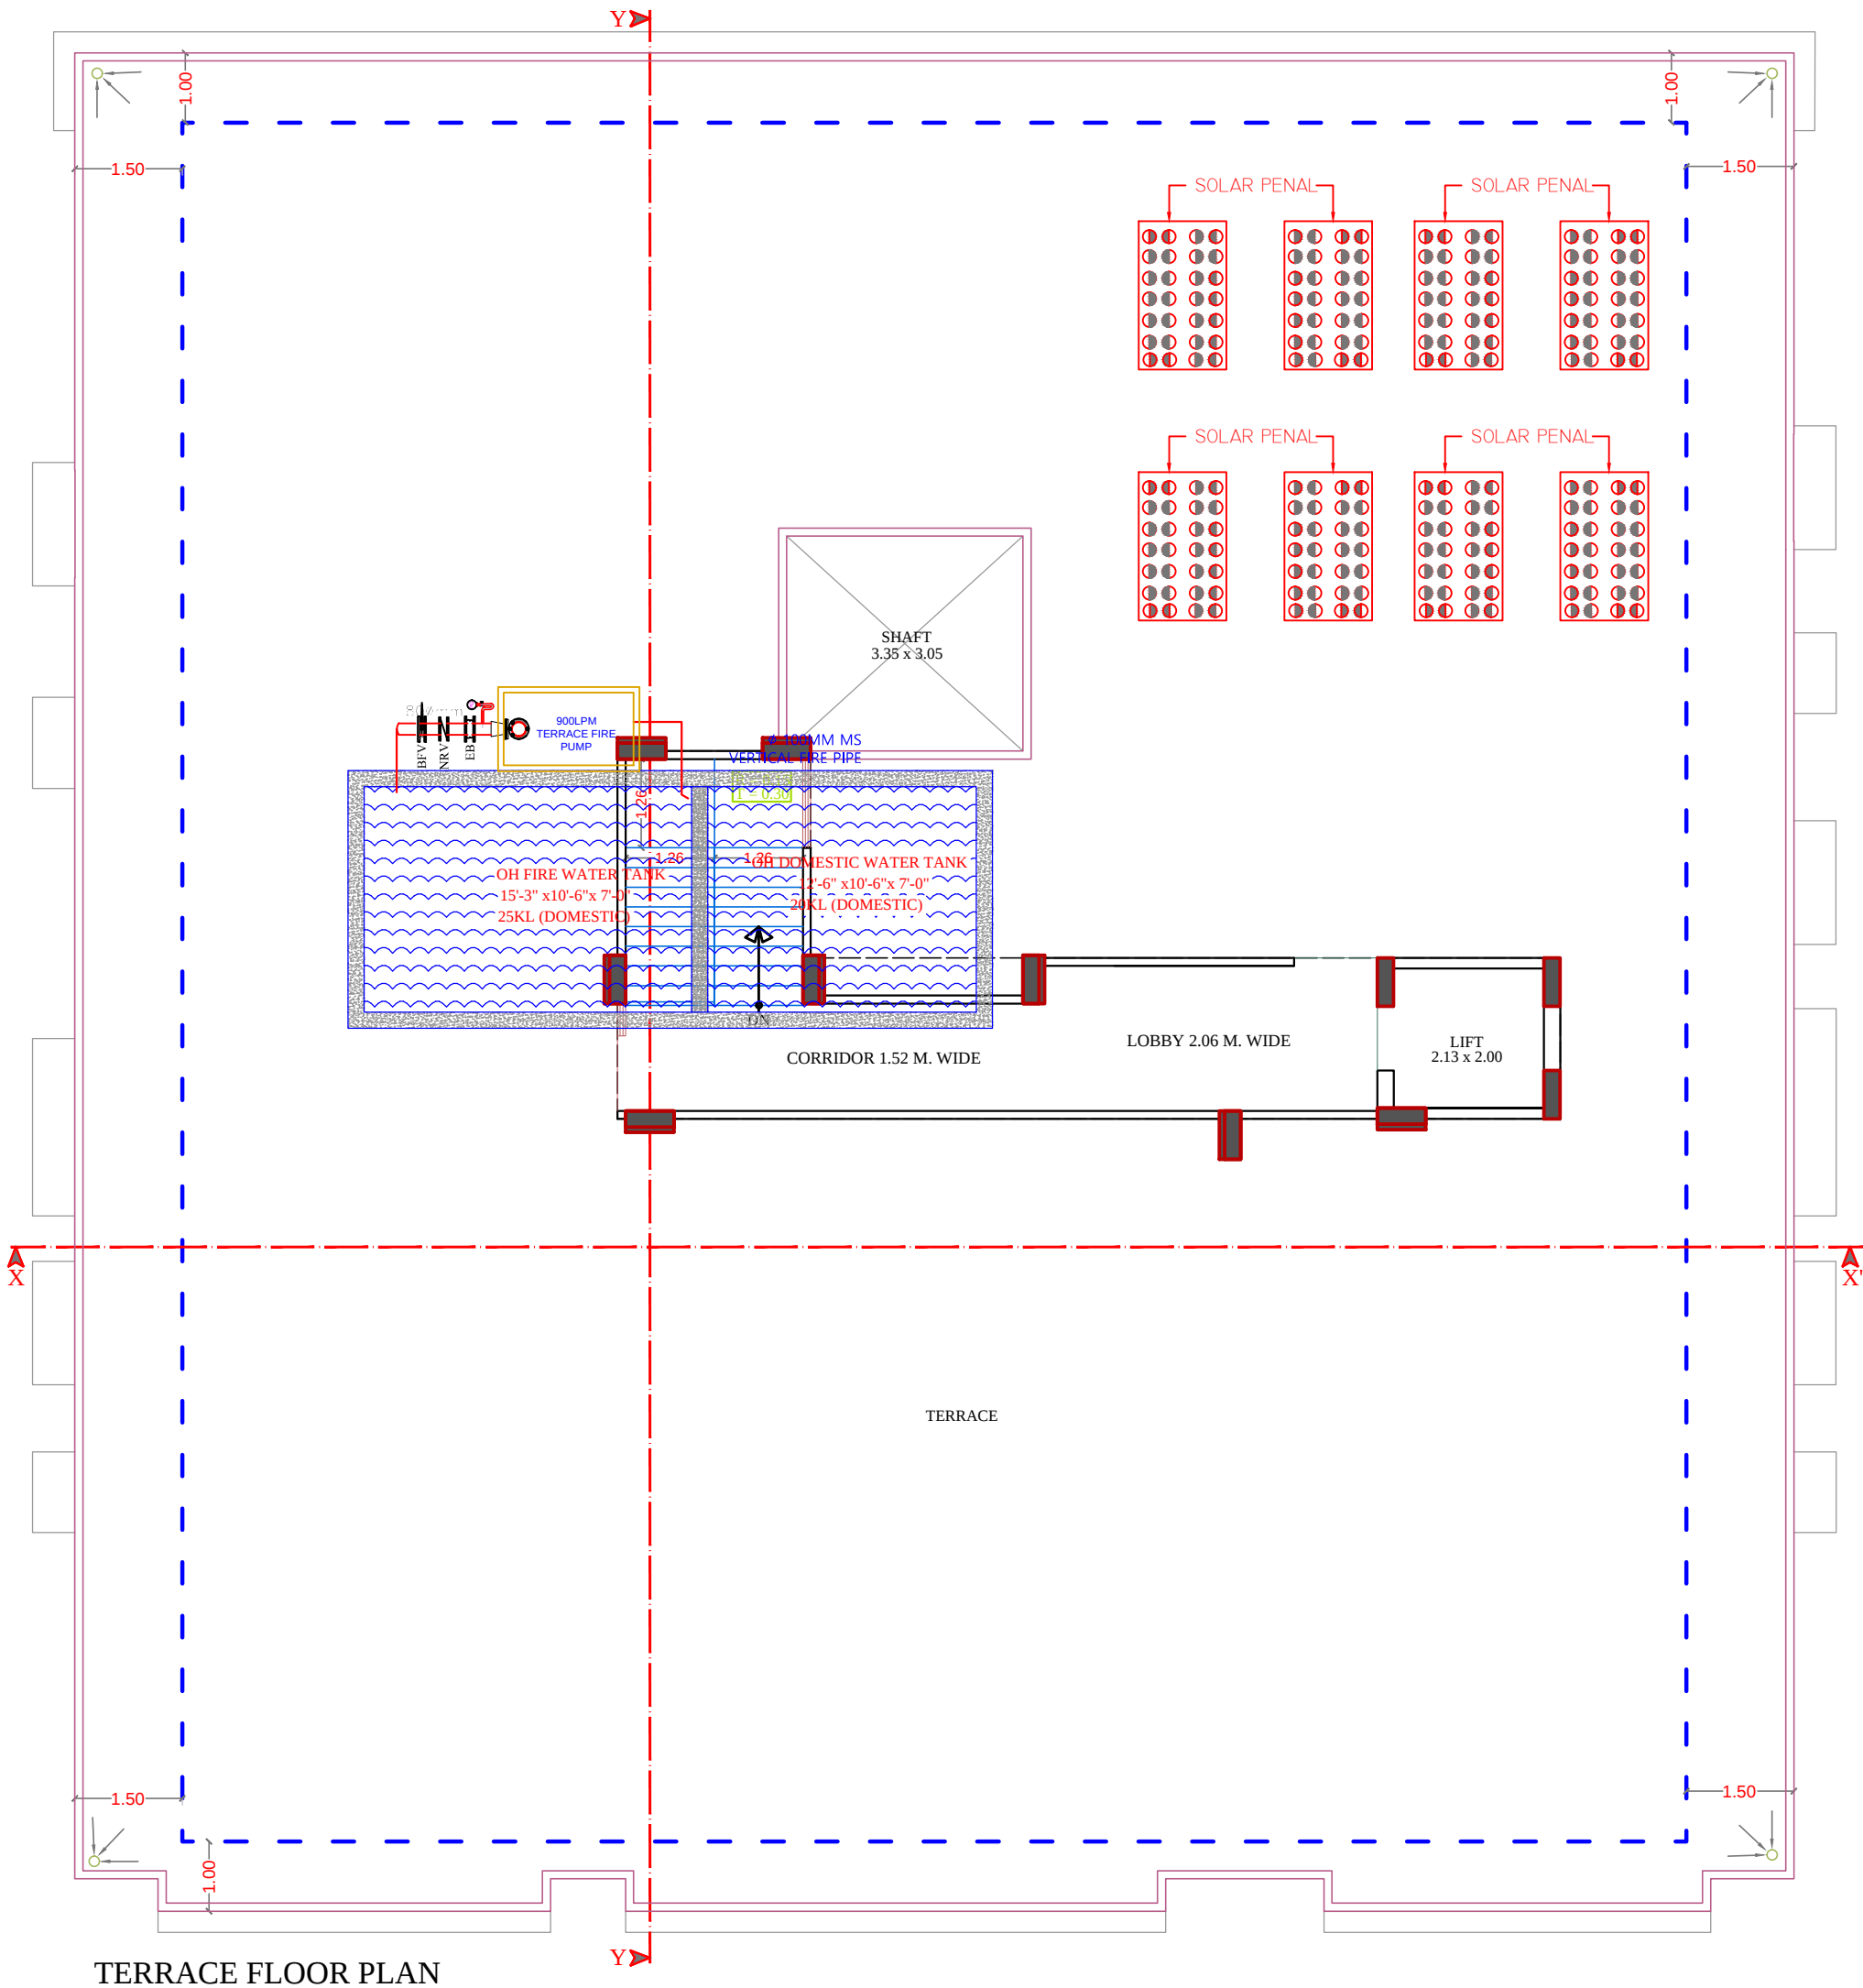

TERRACE FLOOR PLAN

LEGEND

	Symbole	DESCRIPTION
1.		HOSEREEL
2.		FIRE PIPE
3.		FIRE PIPE
4.		FIRE EXTINGUISHER
5.		EXTERNAL YARD HYDRANT

RAMESH KUMAWAT
M.E.P. CONSULTANT
B.E. CIVIL

For B D BUILDERS
Proprietor

PROJECT TITLE :-

PROPOSED BUILDING AT PLOT NO.
A102, A-103, A-104, A-105, A-122,
A-123, A-124 & A-125, NARAYAN
VATIKA, AT VILLAGE-DHAWAS,
HEERAPURA AJMER ROAD, JAIPUR

BUILDING NAME

ANANTAM UTSAV NARAYAN VATIKA

DEVELOPER NAME

BD BUILDERS

DRAWING TITLE :-

TARRACE FLOOR
FIRE FIGHTING

SPACE CONSULTANT

PLOT-A-173, JAGDAMBA NAGAR, HEERAPURA
POWER HOWER, JAIPUR (RAJ) 302024

DRN. BY

APPD. BY

SCALE

DATE

REVISION

NORTH