


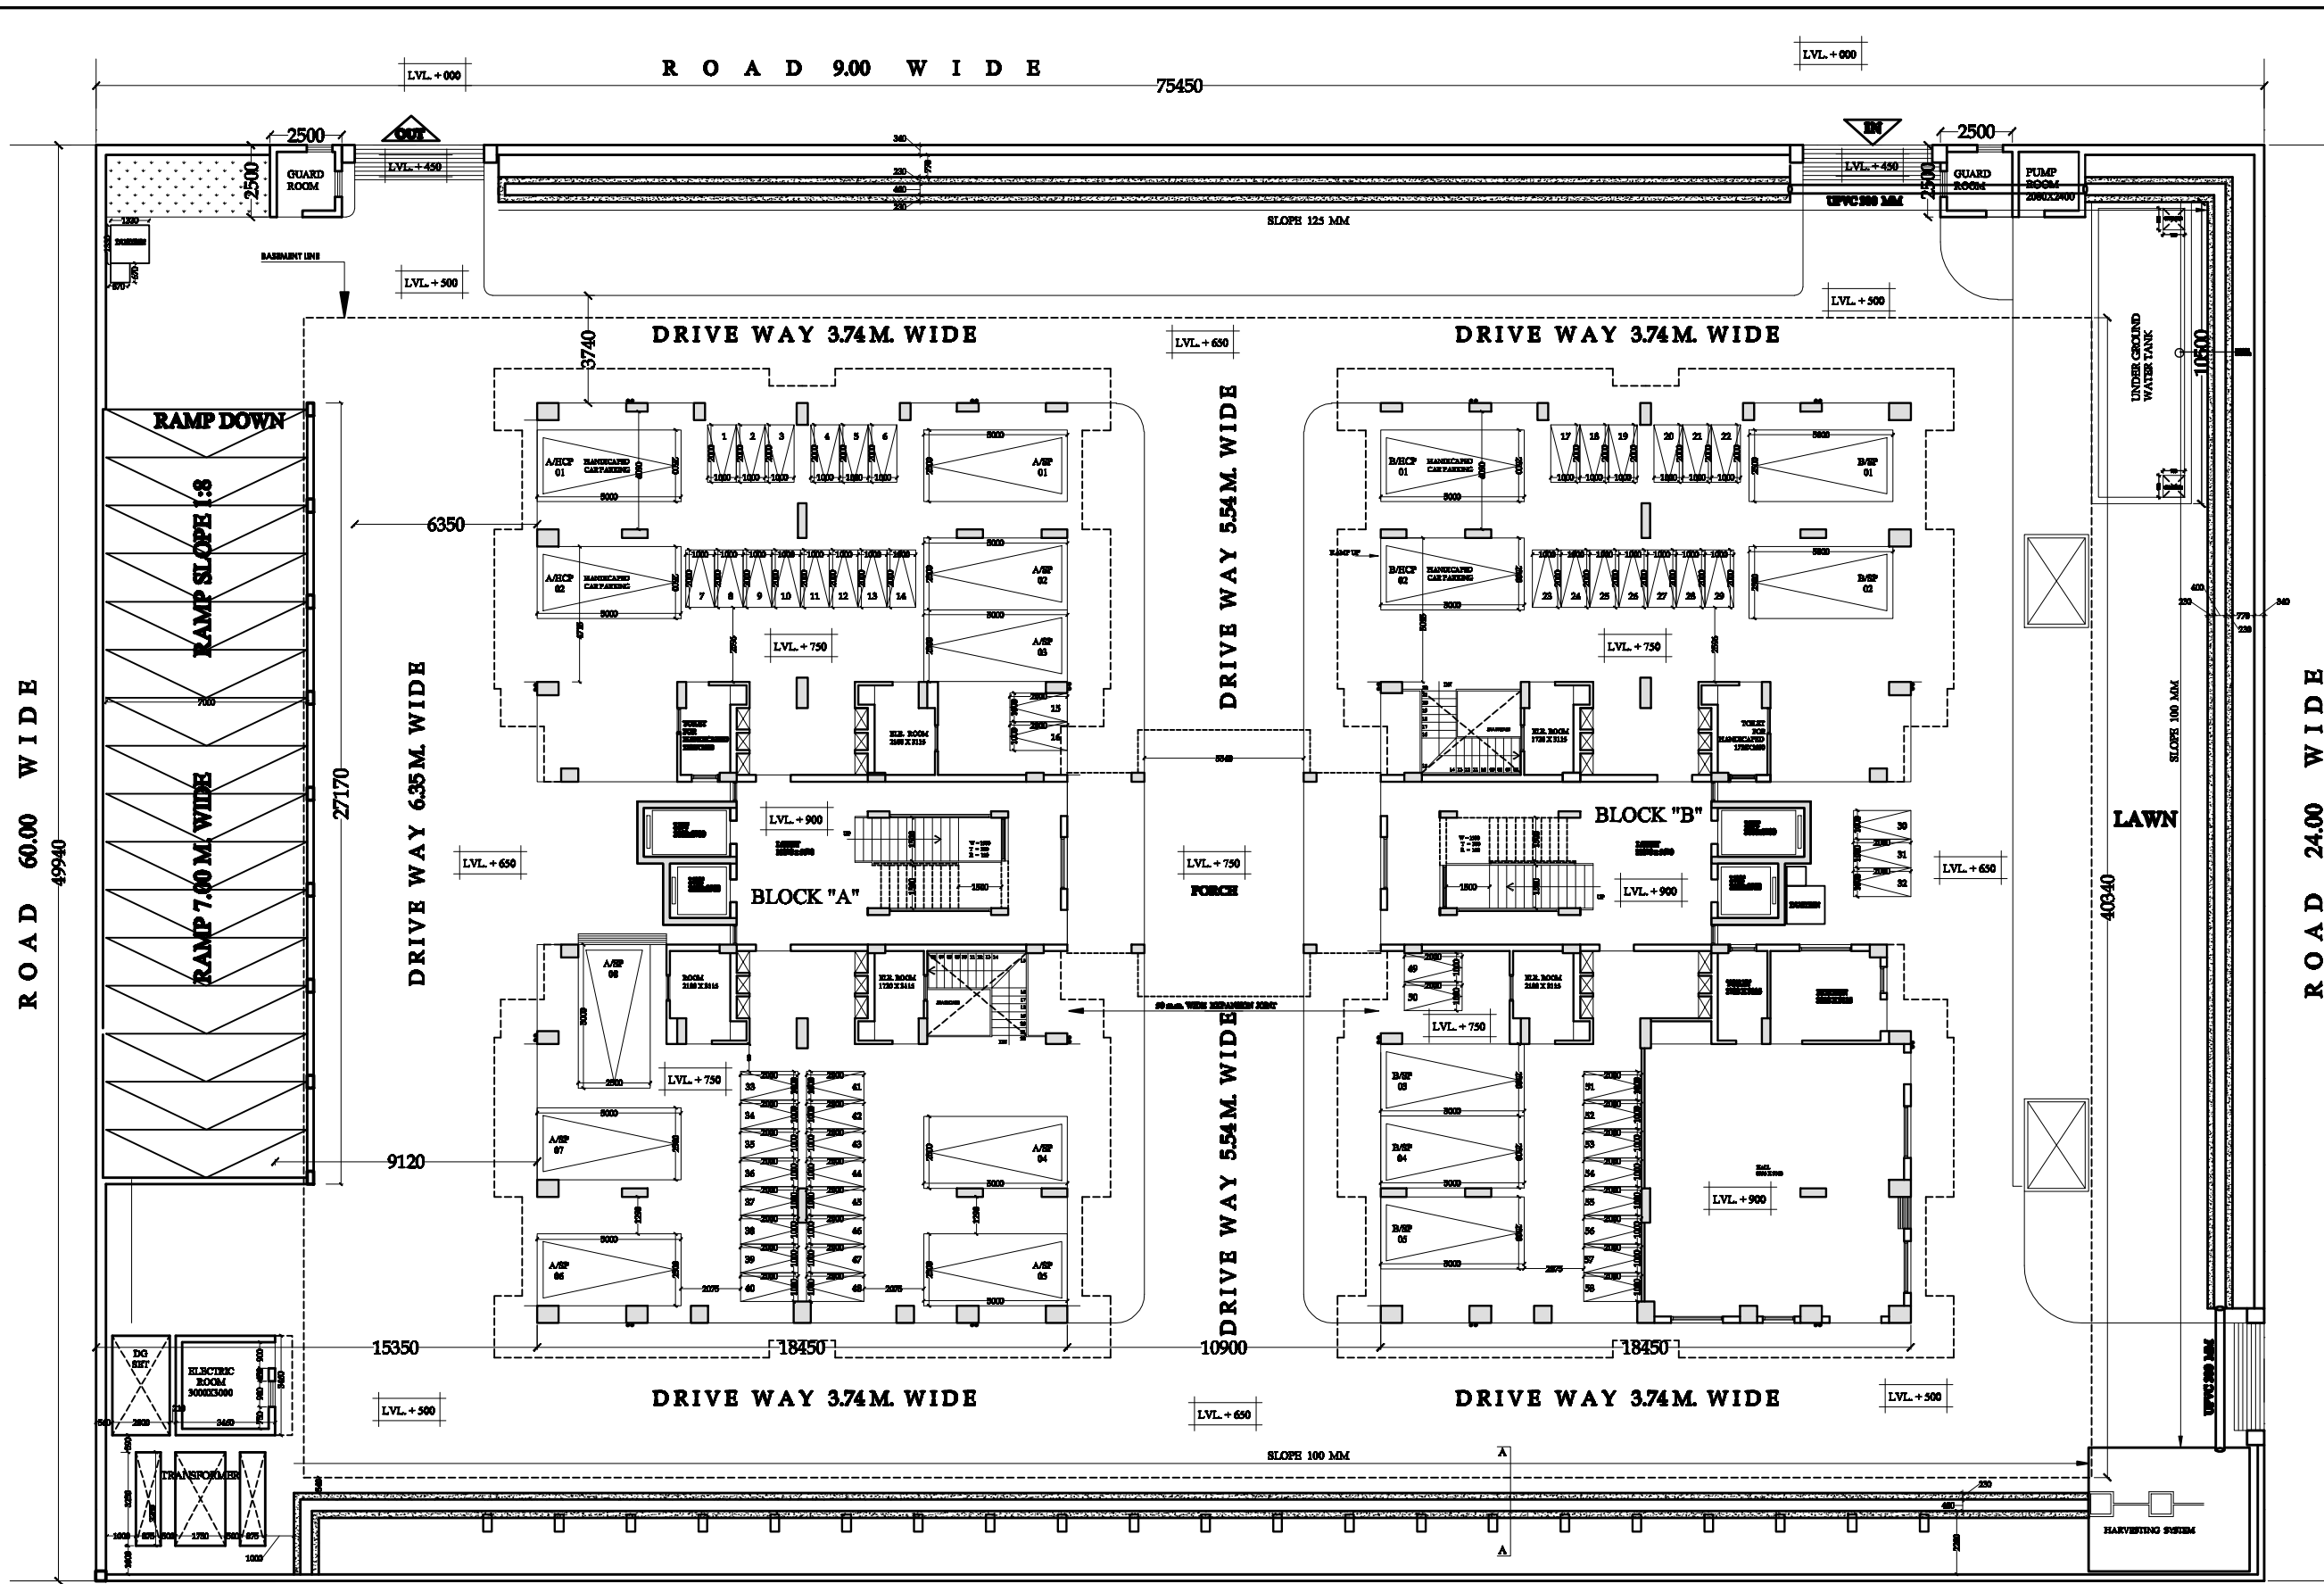

SECTION AA

PROJECT:
PROPOSED LAYOUT PLAN OF HIG.
FLATS (B+STILT+ 9), AT DWARKA MARG,
MANSAROVER,
JAIPUR.

DRAWING TITLE:
SITE PLAN

CLIENT:
RAJASTHAN HOUSING BOARD
JAIPUR.

P. N. BHARGAVA
ARCHITECT-PLANNER
CA/76/745

DESIGNER:
B. I. CONSULTANTS
ARCHITECTS, PLANNERS, ENGINEERS
A-607, BHARATIYA BHAVAN, JALMA
PUNJAB, CHANDIGARH, INDIA
MOBILE: 98150-12345
E-MAIL: biconsultants@gmail.com

SCALE: 1:1000

DATE: 20-04-2022

JOB. NO.:

DRG. NO.:

AB

83