


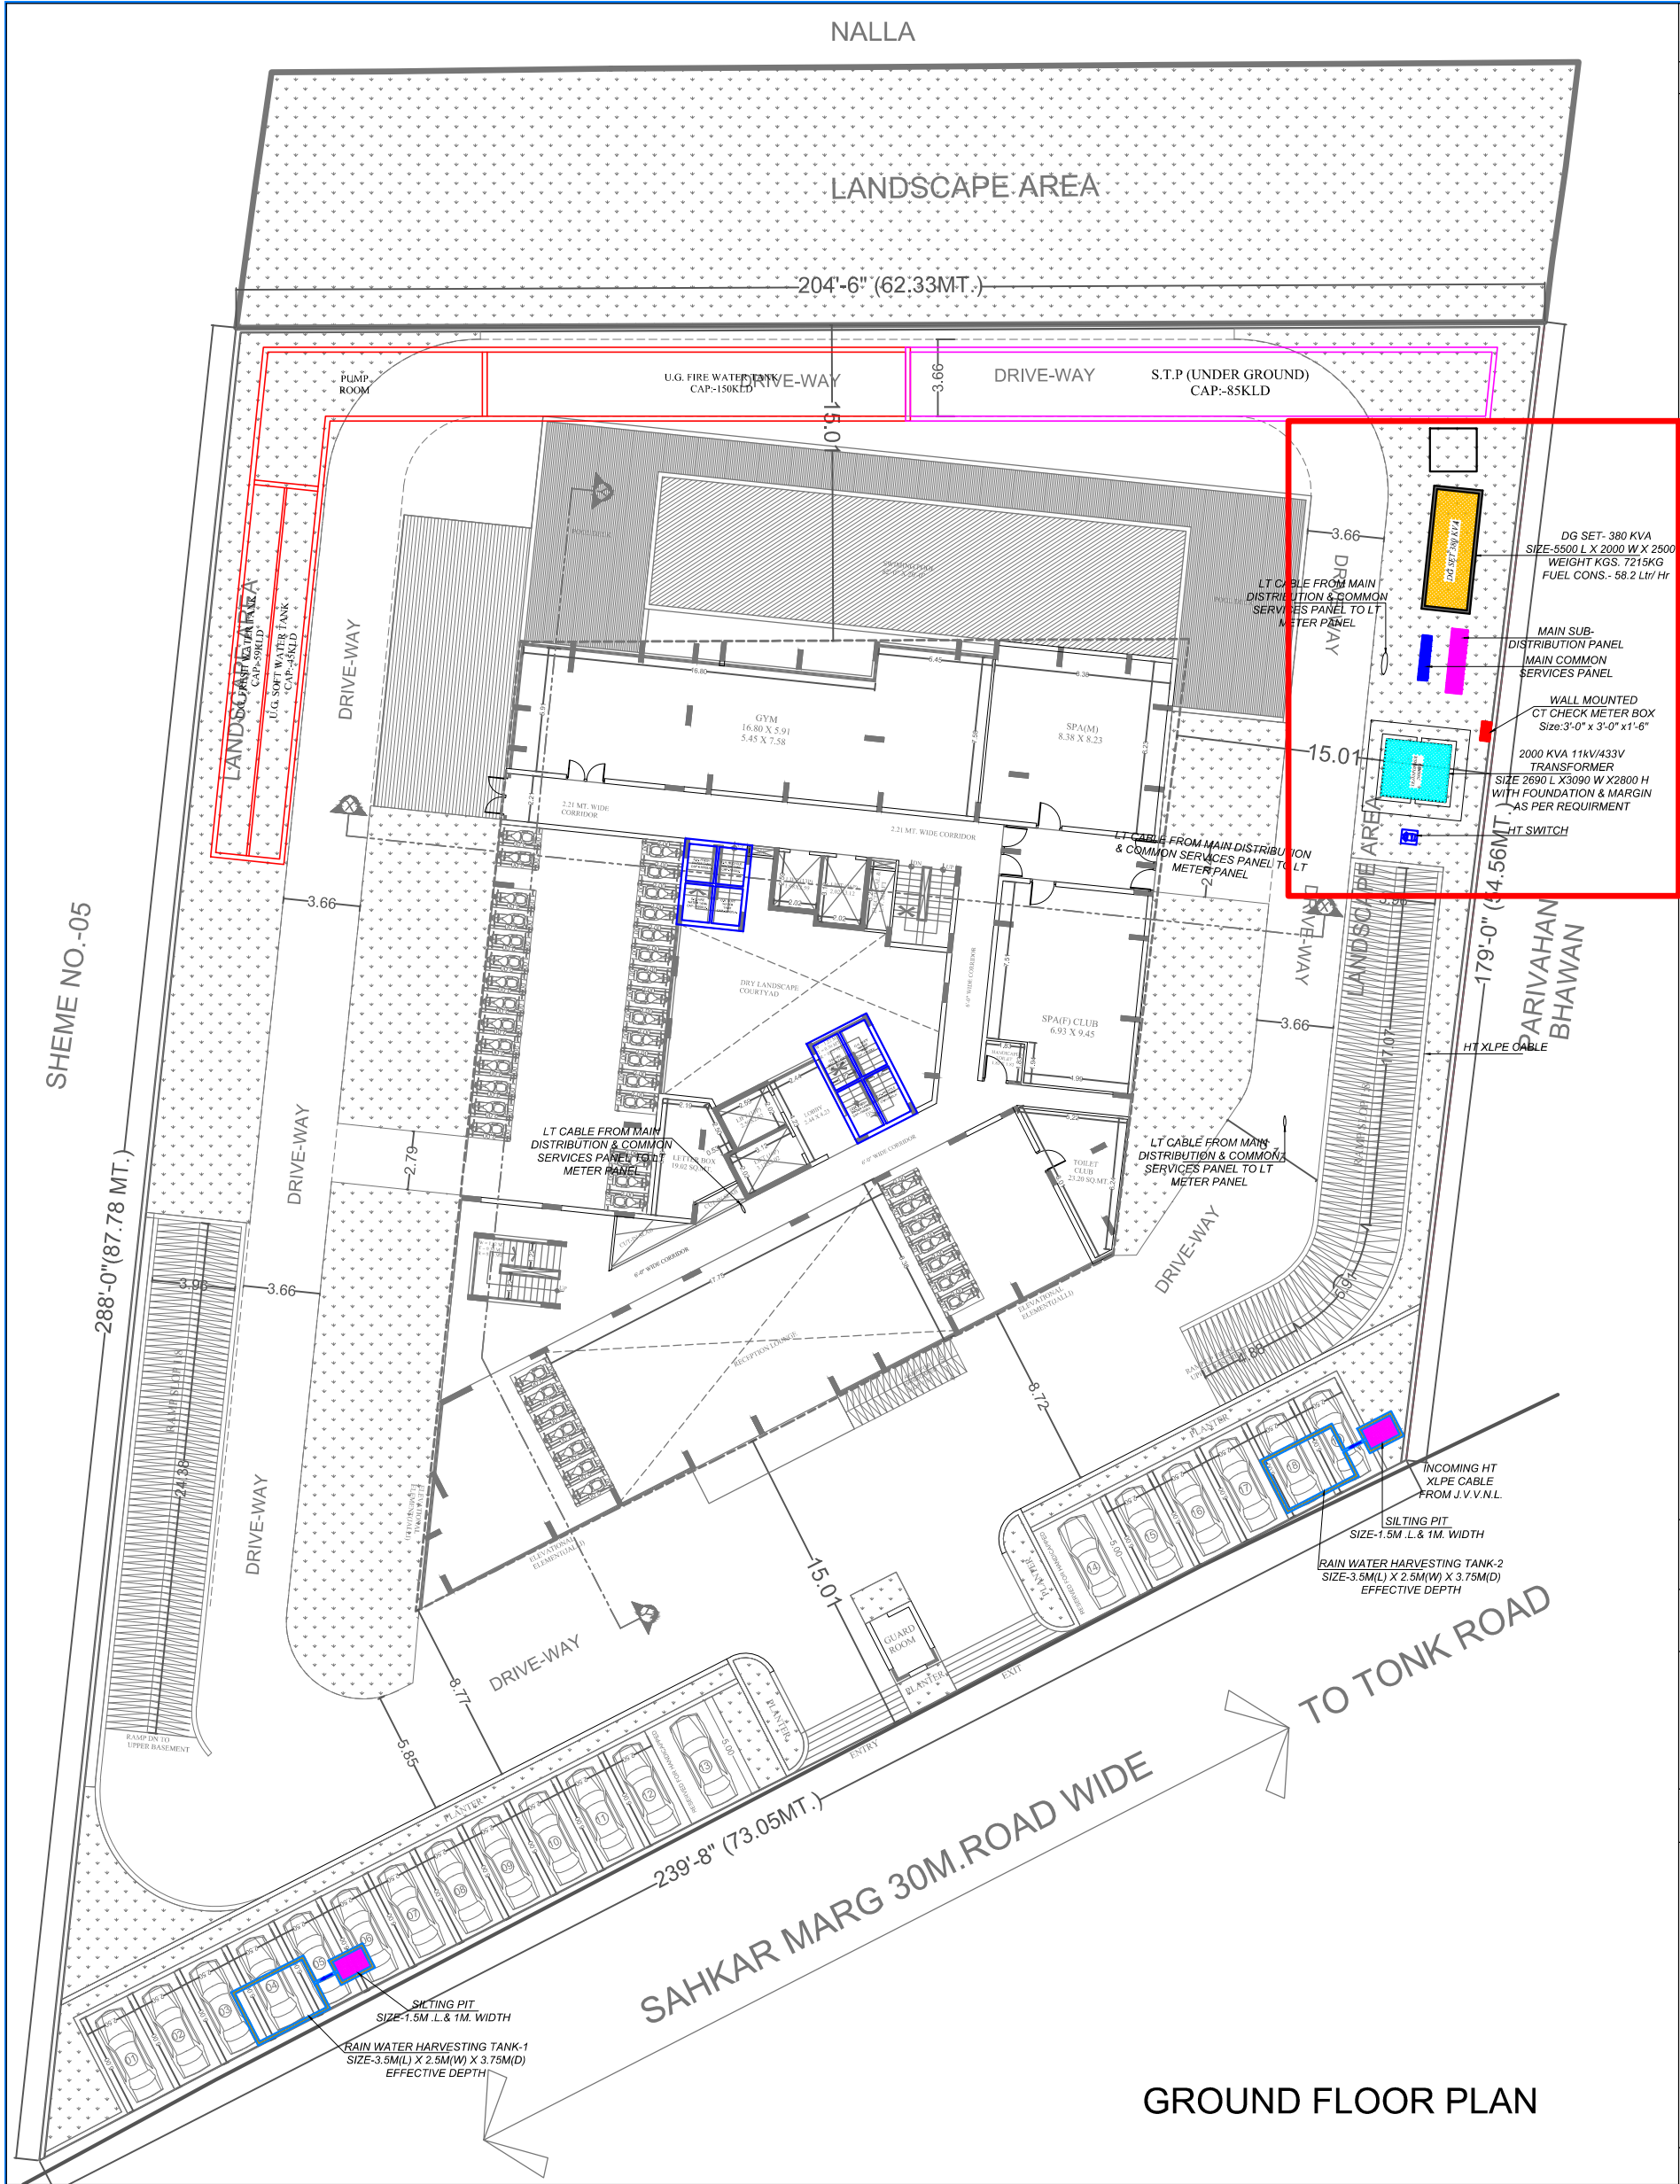

GROUND FLOOR PLAN	
DG SET- 380 KVA SIZE-5500 L X 2000 W X 2500 H WEIGHT KGS. 7215KG FUEL CONS.- 58.2 Ltr/ Hr MAIN SUB-DISTRIBUTION PANEL MAIN COMMON SERVICES PANEL WALL MOUNTED CT CHECK METER BOX Size:3'-0" x 3'-0" x 1'-6" 2000 KVA 11KV/433V TRANSFORMER SIZE 2690 L X 3090 W X 2800 H WITH FOUNDATION & MARGIN AS PER REQUIREMENT HT SWITCH HT XLPE CABLE INCOMING HT XLPE CABLE FROM J.V.V.N.L. SILTING PIT SIZE-1.5M L & 1M. WIDTH RAIN WATER HARVESTING TANK-2 SIZE-3.5M(L) X 2.5M(W) X 3.75M(D) EFFECTIVE DEPTH	
DRAWING TITLE	04_PINNALCE _ELECTRIFICATION (TRANSFORMER)
PROJECT TITLE	PROPOSED RESIDENTIAL APPARTMENT AT KHASRA NO. 35 AT VILLAGE BHOJPURA ON SAHKAR MARG SCHEME LALKOTHI, JAIPUR.
 124, HIMMAT NAGAR , TONK ROAD, JAIPUR PHONE - 0141-2705550	
SCALE 1:150	NORTH POINT
OWNER	ARCHITECT