


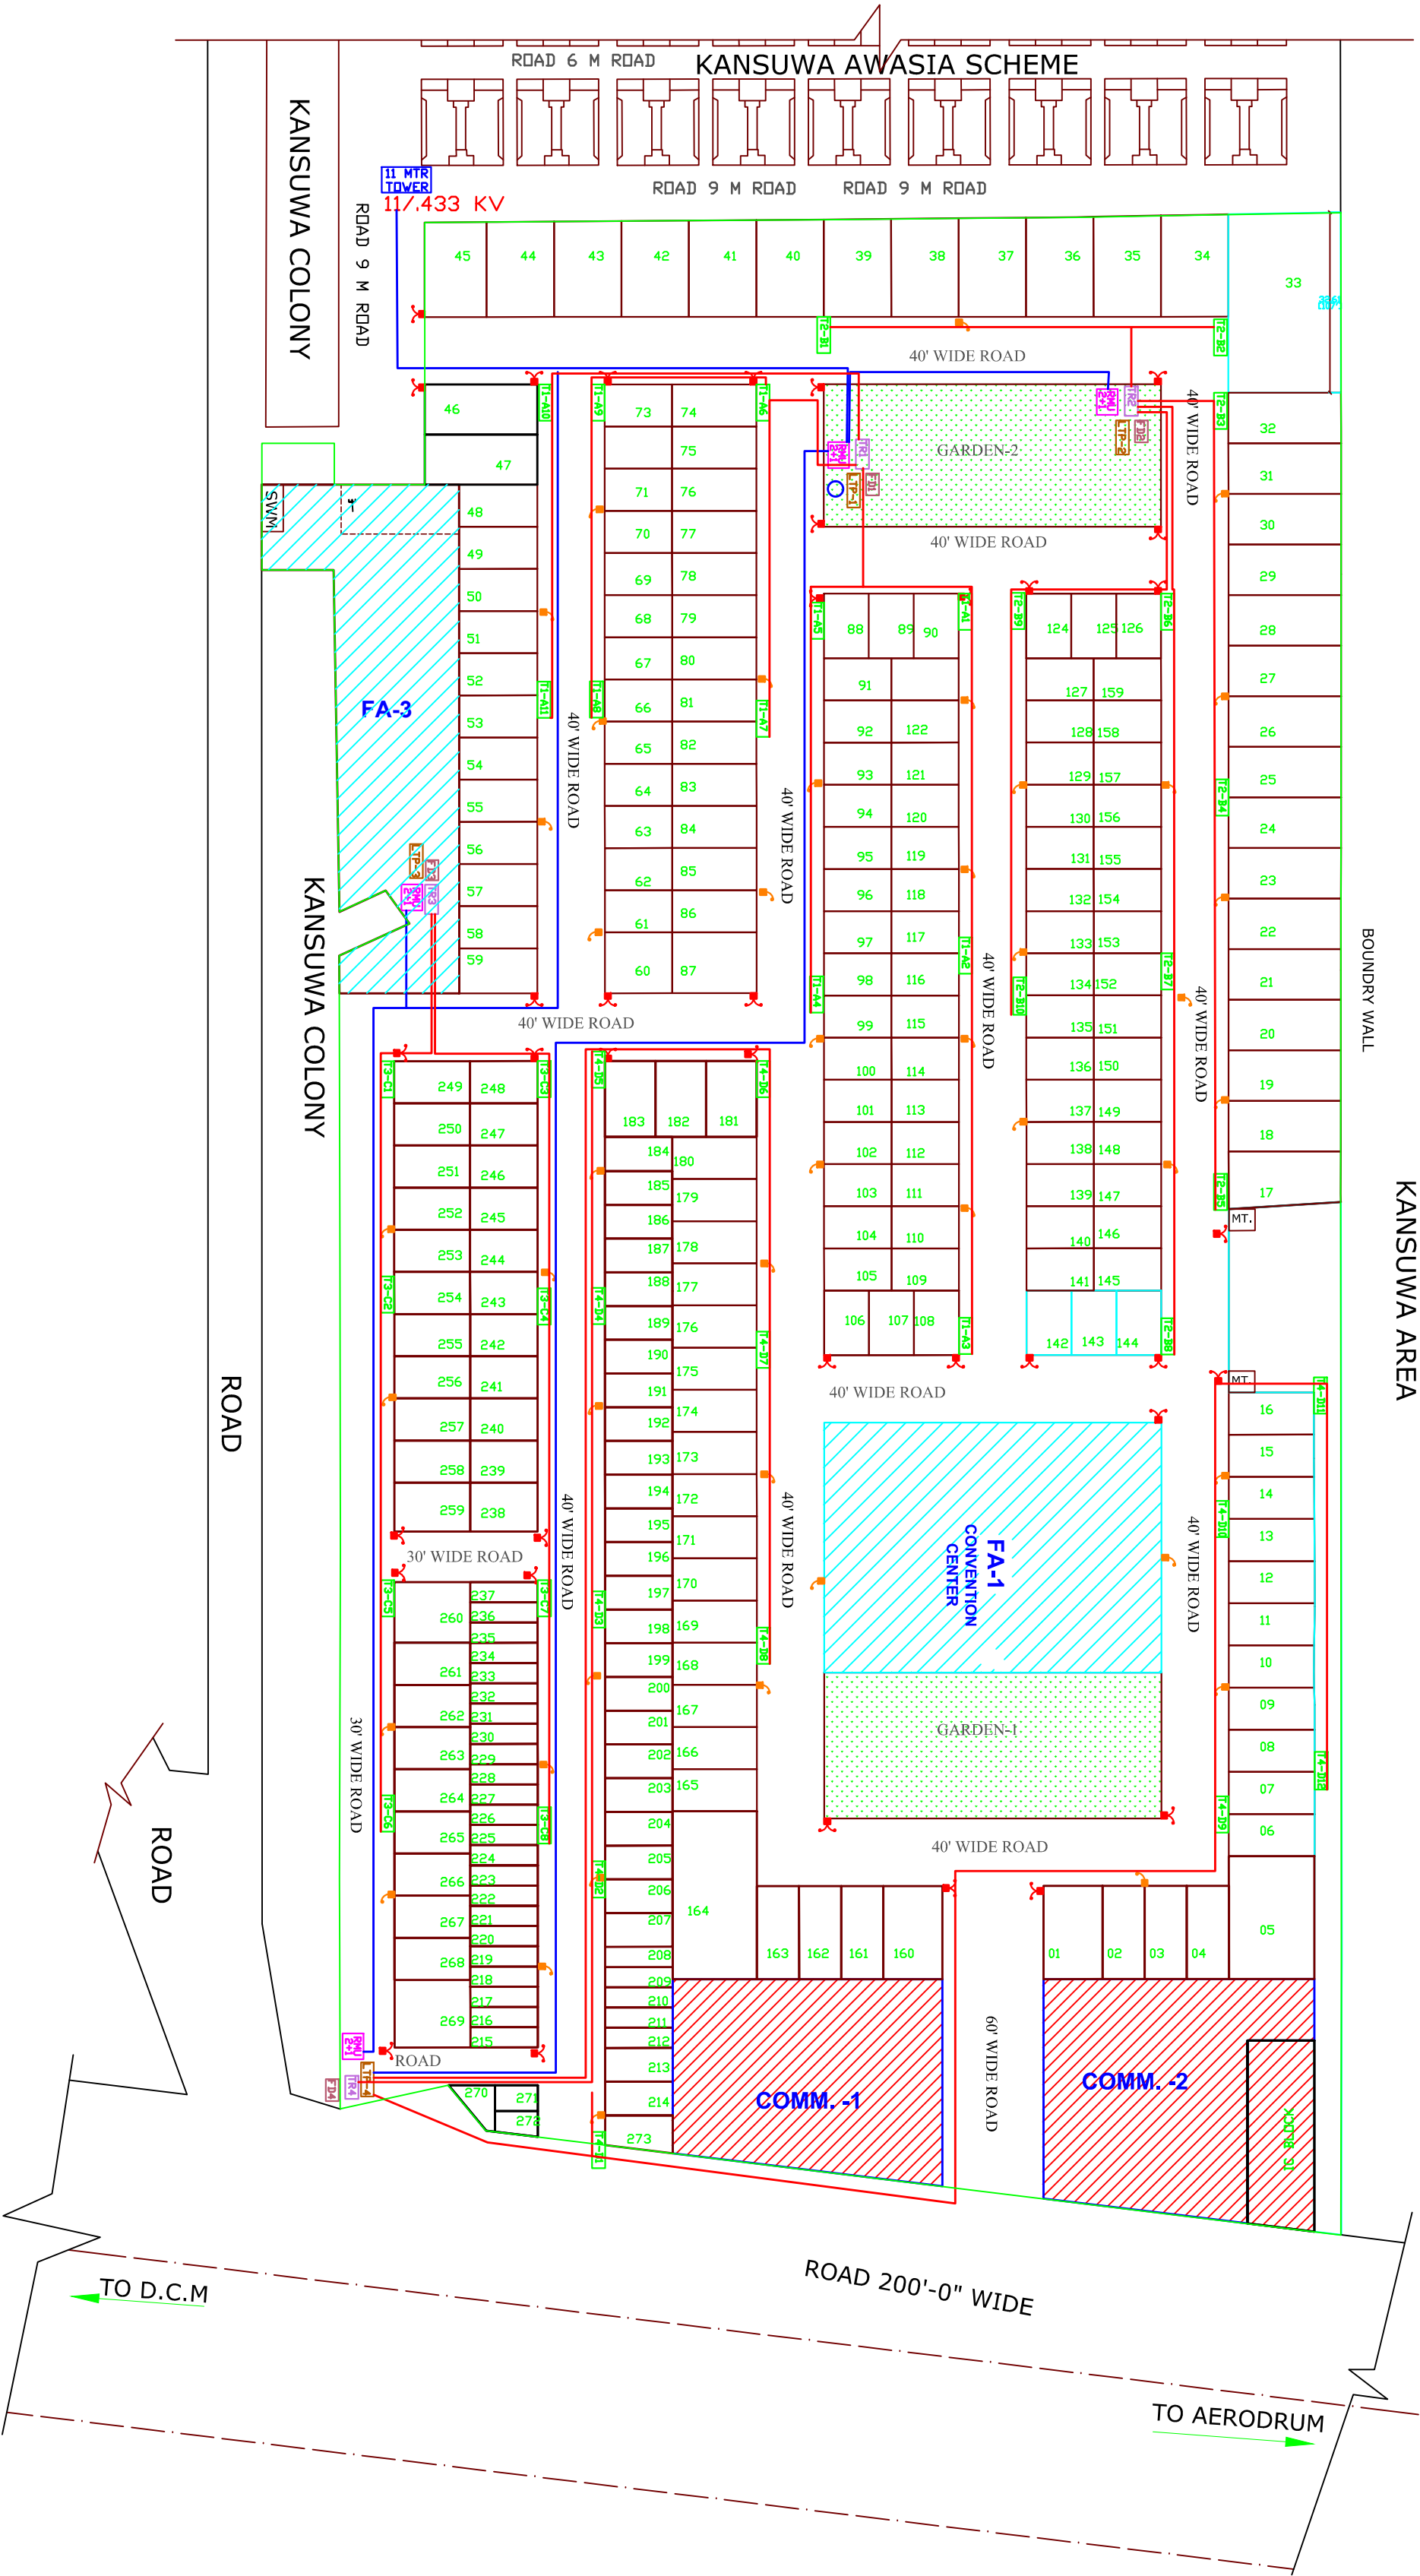

PROPOSED LAYOUT PLAN OF CENTRAL GREENS, PLOT NO. 1, 15, 18 LARGE SCALE INDUSTRIAL AREA , VILLEGE - KANSUWA, KOTA - 324003 RAJASTHAN	
LEGEND	
SYMBOL	DESCRIPTION
	160 KVA TRANSFORMER 11/.433
	STREET LIGHT
	STREET LIGHT POLE DOUBLE ARM
	160AMP DISTRIBUTION PANEL
	RMU 800 AMP 11KV (2 + 1)
	400AMP FEDDER PILLER BOX
	LIGHTING TIMER PANEL
	HT LINE CABLE
	LT LINE CABLE
Project	PROPOSED LAYOUT PLAN OF CENTRAL GREENS, PLOT NO. 1, 15, 18 LARGE SCALE INDUSTRIAL AREA , VILLEGE - KANSUWA, KOTA - 324003 RAJASTHAN
Drawing Title	ELECTRICAL LAYOUT PLAN
SCALE : N.T.S.	NAME OF SCHEME:
LOCATION :	DRAWING NO. - 02
JOB NO. -	DATE - DEC, 14th, 2024