


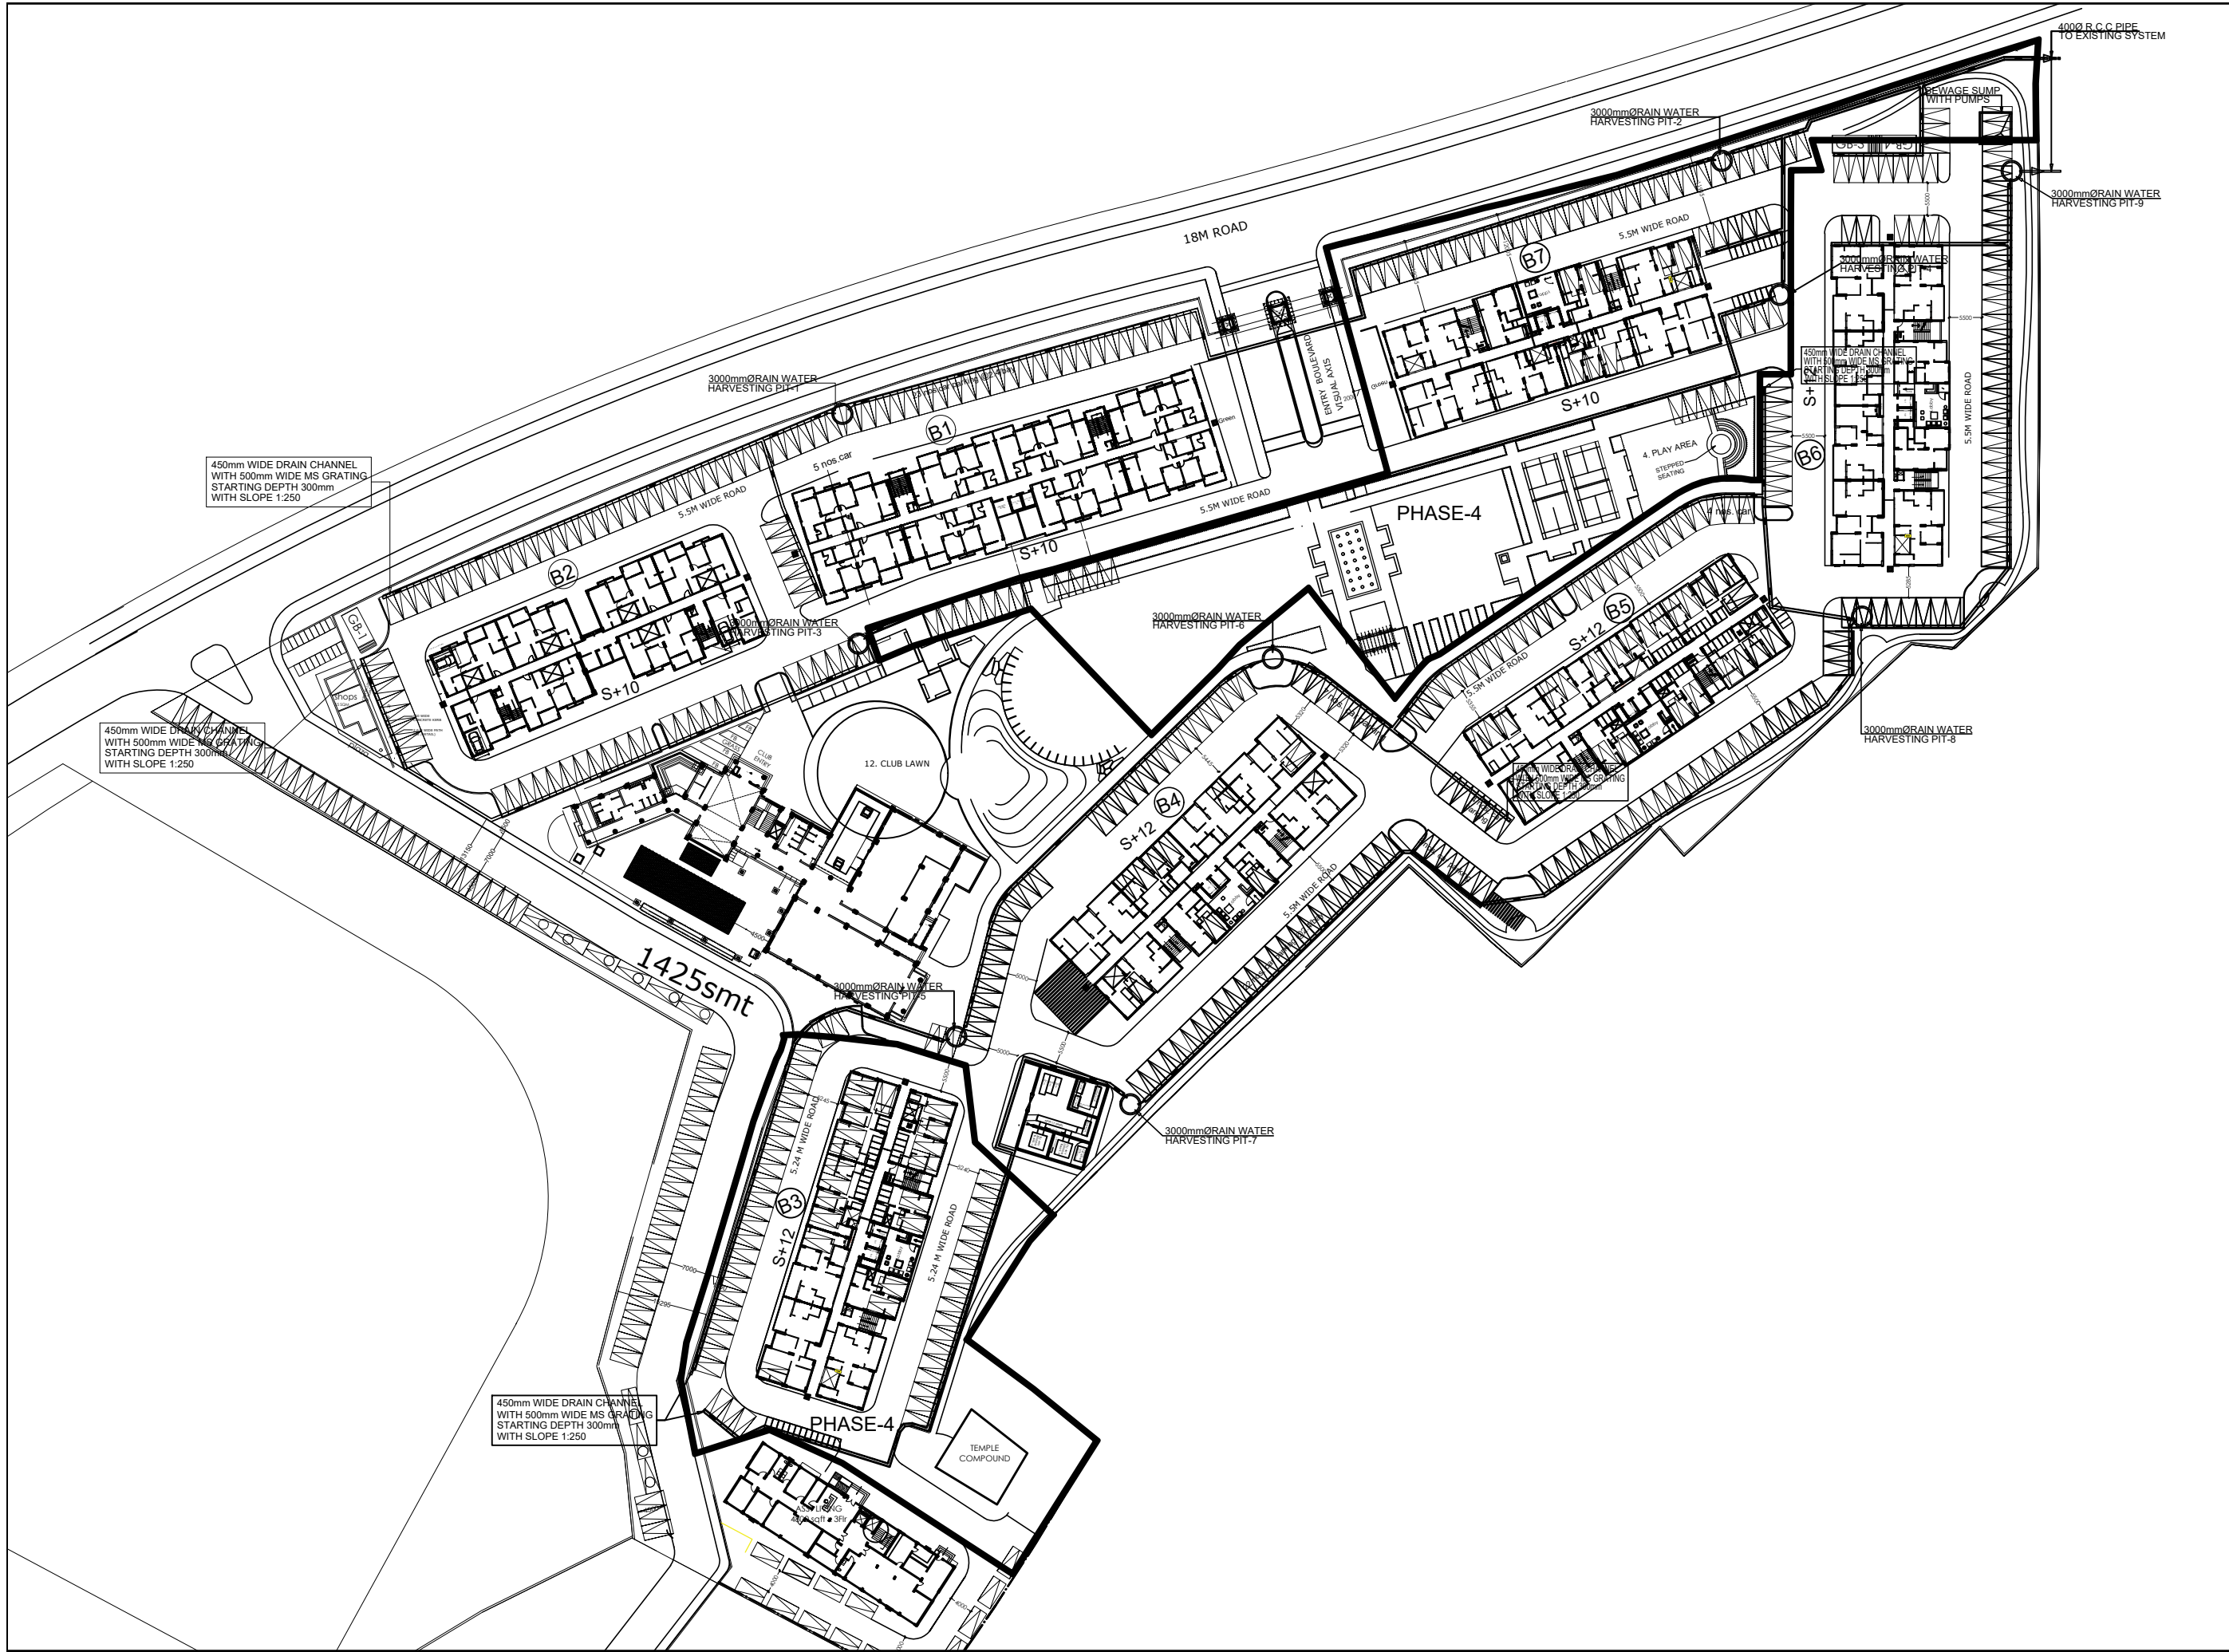

LEGEND:-

SEWERAGE MANHOLE

ILSEWER LINE

CLINVERT LEVEL

CLCONNECTED LEVEL

SCHEDULE OF MANHOLE

DIA (IN mm)	DEPTH
900#	900mm-1650mm
1200#	1650mm-2300mm
1500#	2300mm-9000mm

No.	Date	By	Description
1			FOR APPROVAL
2			G.F.C ISSUE (SOFT COPY)
3			G.F.C ISSUE (SOFT COPY)

ISSUES

No.	Date	By	Description
R3	1		REVISED AS PER CLIENT COMMENTS
R2	2		AS PER REVISED ARCHITECTURE LAYOUT
R1	3		AS PER REVISED ARCHITECTURE LAYOUT

Revisions

CLIENT

ASHIANA HOUSING

ARCHITECTS

MR. BISHWAJIT SENGUPTA

LANDSCAPE ARCHITECT

msykDESIGN
landscape | architecture

Sarai Julena, Okhla Road, New Delhi - 110025
Phone : 26820142

Electro - Mechanical Consultants

ABL
ABL ECOSYSTEM (P) LTD
Electro-Mechanical Consulting Engineers

B-137, Basement, Kalkaji, New Delhi-110019
P: +91-11-41625566, 46524180, 81,82,83,84
F: +91-11-46524182
E-mail: abl@abhospitech.com
abhospitech@gmail.com

PROJECT

Ashiana Nirmay

Drawing Title

SITE PLAN
DRAINAGE LAYOUT

Job No.	Drawing No.
Drawn SARWAJIT	Checked B.SINGH
Date	Scale 1:500

Revisions
1
2
3
4
5
6
7
8
9
10

PL-DR-01





	13-07-17		FOR APPROVAL
	03-07-17		G.F.C ISSUE (SOFT COPY)
	26-06-17		G.F.C ISSUE (SOFT COPY)
No.	Date	By	Description
ISSUES			
B3	13-07-17		REVISED AS PER CLIENT COMMENTS
B2	03-07-17		AS PER REVISED ARCHITECTURE LAYOUT
R1	15-06-17		AS PER REVISED ARCHITECTURE LAYOUT
No.	Date	By	Description
Revisions			
CLIENT			
ASHIANA HOUSING			
ARCHITECTS			
MR. BISHWAJIT SENGUPTA			
LANDSCAPE ARCHITECT			
			
Sarai Julena, Okhla Road, New Delhi - 110025 Phone : 26820142			
167/B,			
110025			
Phone : 26820142			
Electro - Mechanical Consultants			
			
ABHINAV SENGUPTA (P) LTD			
Electro-Mechanical Consulting Engineers			
B-137, Basement, Kalkaji, New Delhi-110019			
P: +91-11-41625566, 46524180, 81,82,83,84			
F: +91-11-46524182			
E-mail: abh@abhospitech.com			
abhospitech@gmail.com			
PROJECT			
Ashiana Nirmay			
Drawing Title			
SITE PLAN SEWERAGE LAYOUT			
Job No.		Drawing No.	
SARAJA-JET		PL-DR-01	
Drawn	Checked	Date	Scale
SARAJA-JET	B.SINGH	02/07/17	1:500
Revisions		Revisions	
R01		R01	