


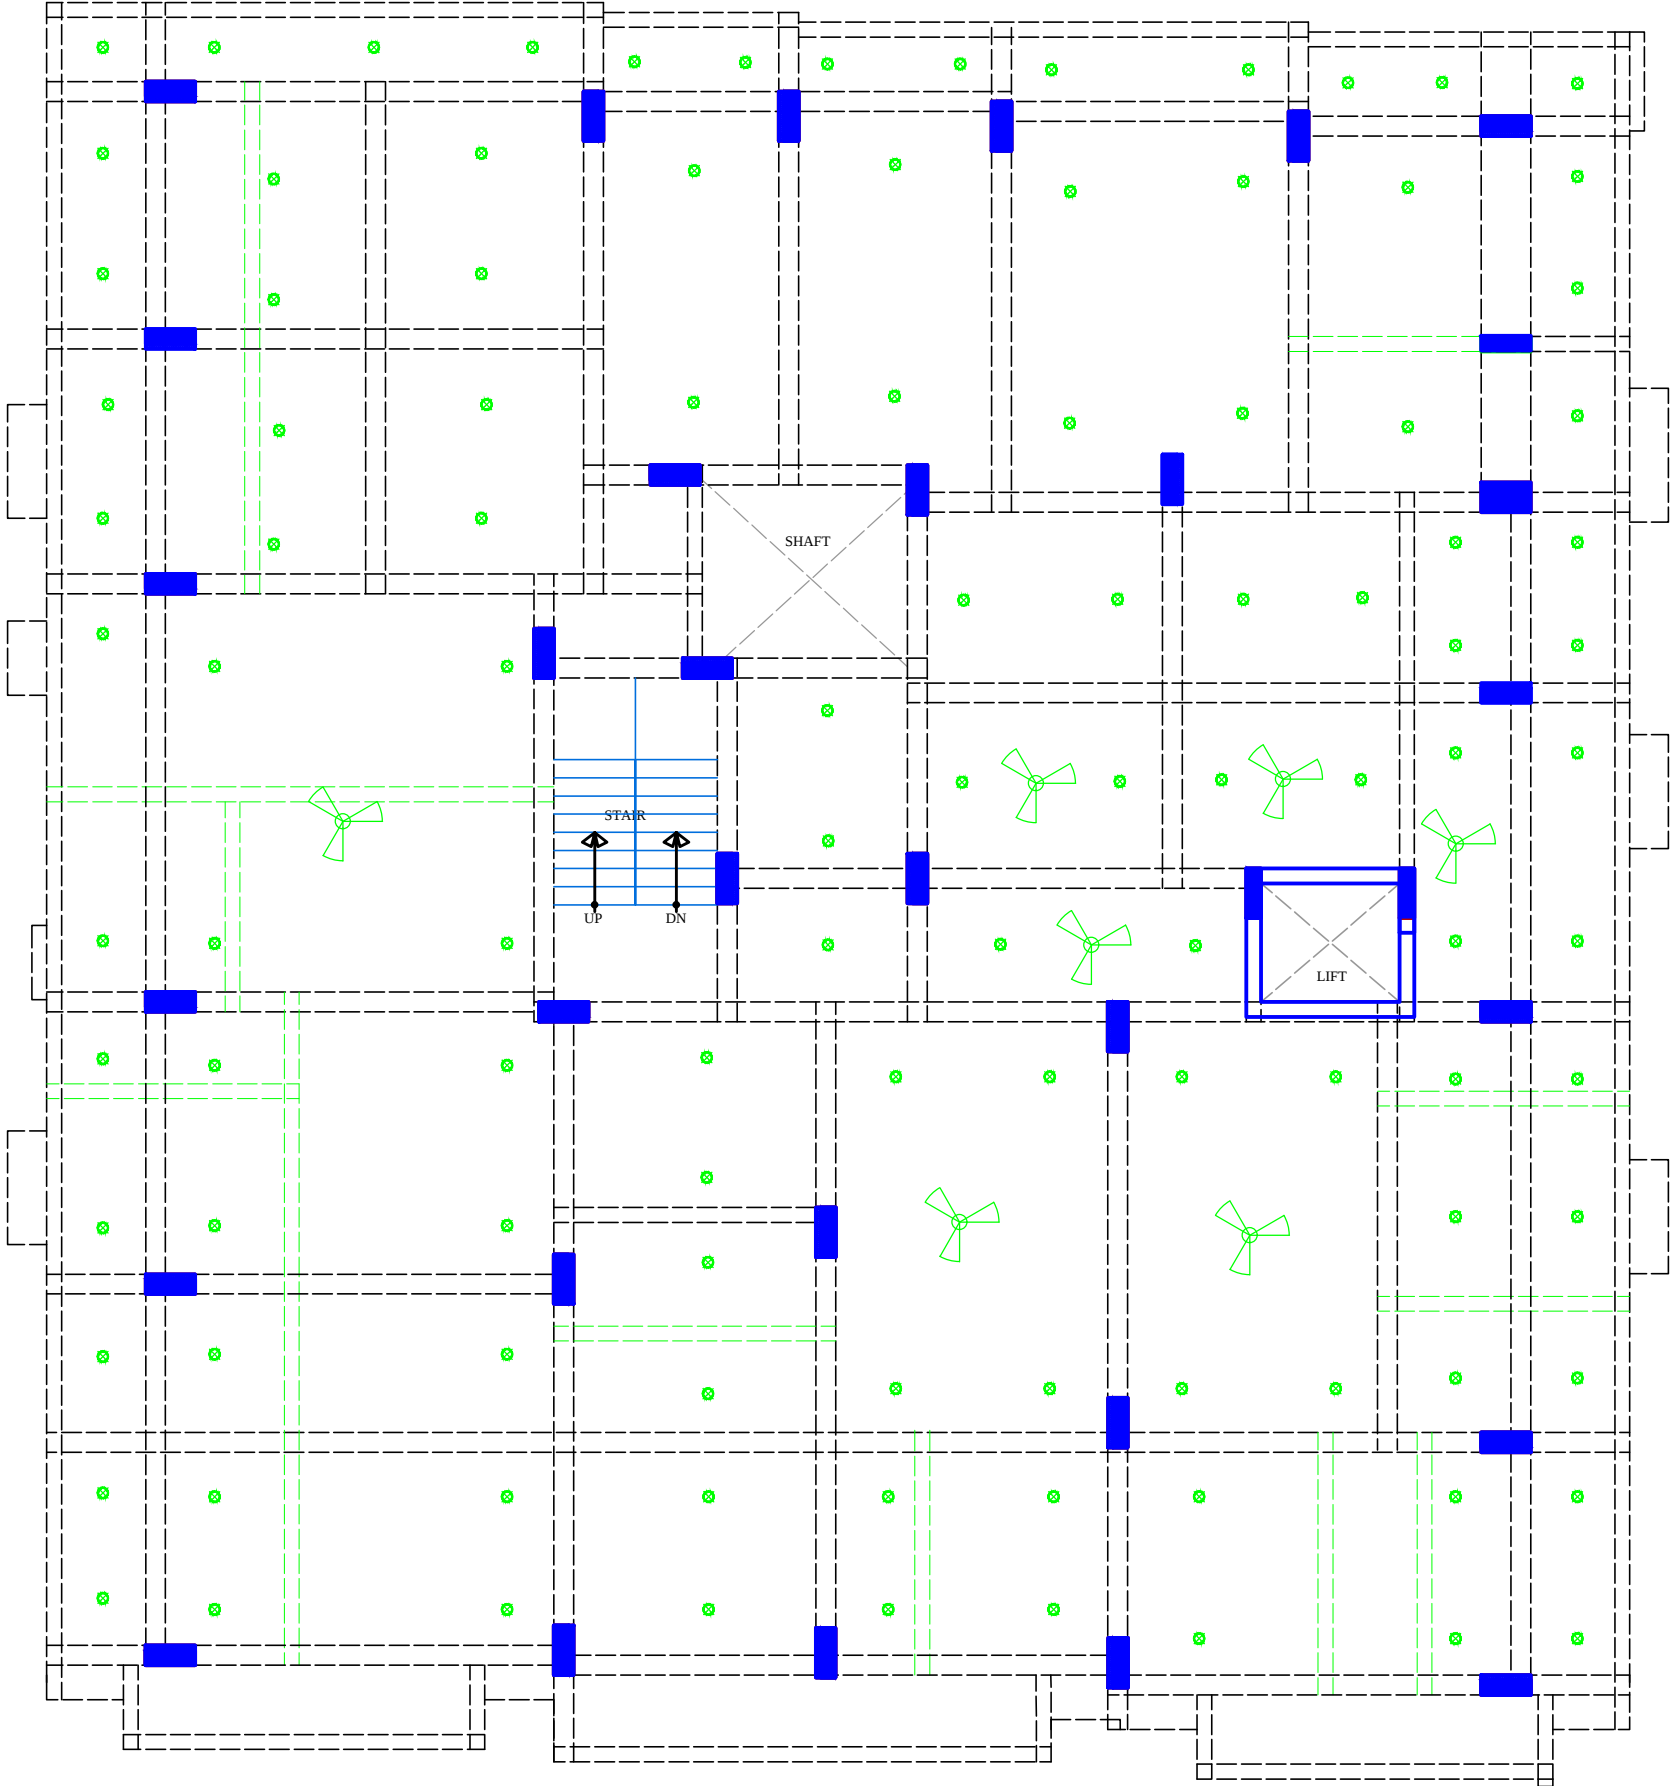


NO	ITEM	SYMBOL
1	CEILING FAN	ROOF
2	TUBE LIGHT	+8'6"
3	BULB	+8'6"
4	POWER POINT	+1'6"
5	BED POINT	+4'3"
6	CEILING LIGHT	ROOF
7	A.C.POINT	+6'6"
8	SWITCH BOARD	+4'3"
9	EXHAUST	VENT
10	TELEPHONE	+1'6"
11	GYSER	+6'0"
12	BELL POINT	+8'6"
13	T.V.	+1'6"
14	M.BOX	M.B.
15	M.C.B.	+6'6"
16	FANCY LIGHT	+8'6"
17	HANGING LIGHT	ROOF

RAMESH KUMAWAT
M.E.P. CONSULTANT
B.E. CIVIL

For B D BUILDERS

Proprietor

PROJECT TITLE :- PROPOSED BUILDING AT PLOT NO. A102, A-103, A-104, A-105, A-122, A-123, A-124 & A-125, NARAYAN VATIKA, AT VILLAGE-DHAWAS, HEERAPURA AJMER ROAD, JAIPUR	BUILDING NAME	DRAWING TITLE :- STILT FLOOR ELECTRIC PLAN	SPACE CONSULTANT PLOT-A-173, JAGDAMBA NAGAR, HEERAPURA POWER HOWER, JAIPUR (RAJ) 302024	DRN. BY		DATE	NORTH
	ANANTAM UTSAV NARAYAN VATIKA			APPD. BY		REVISION	
	DEVELOPER NAME BD BUILDERS			SCALE			

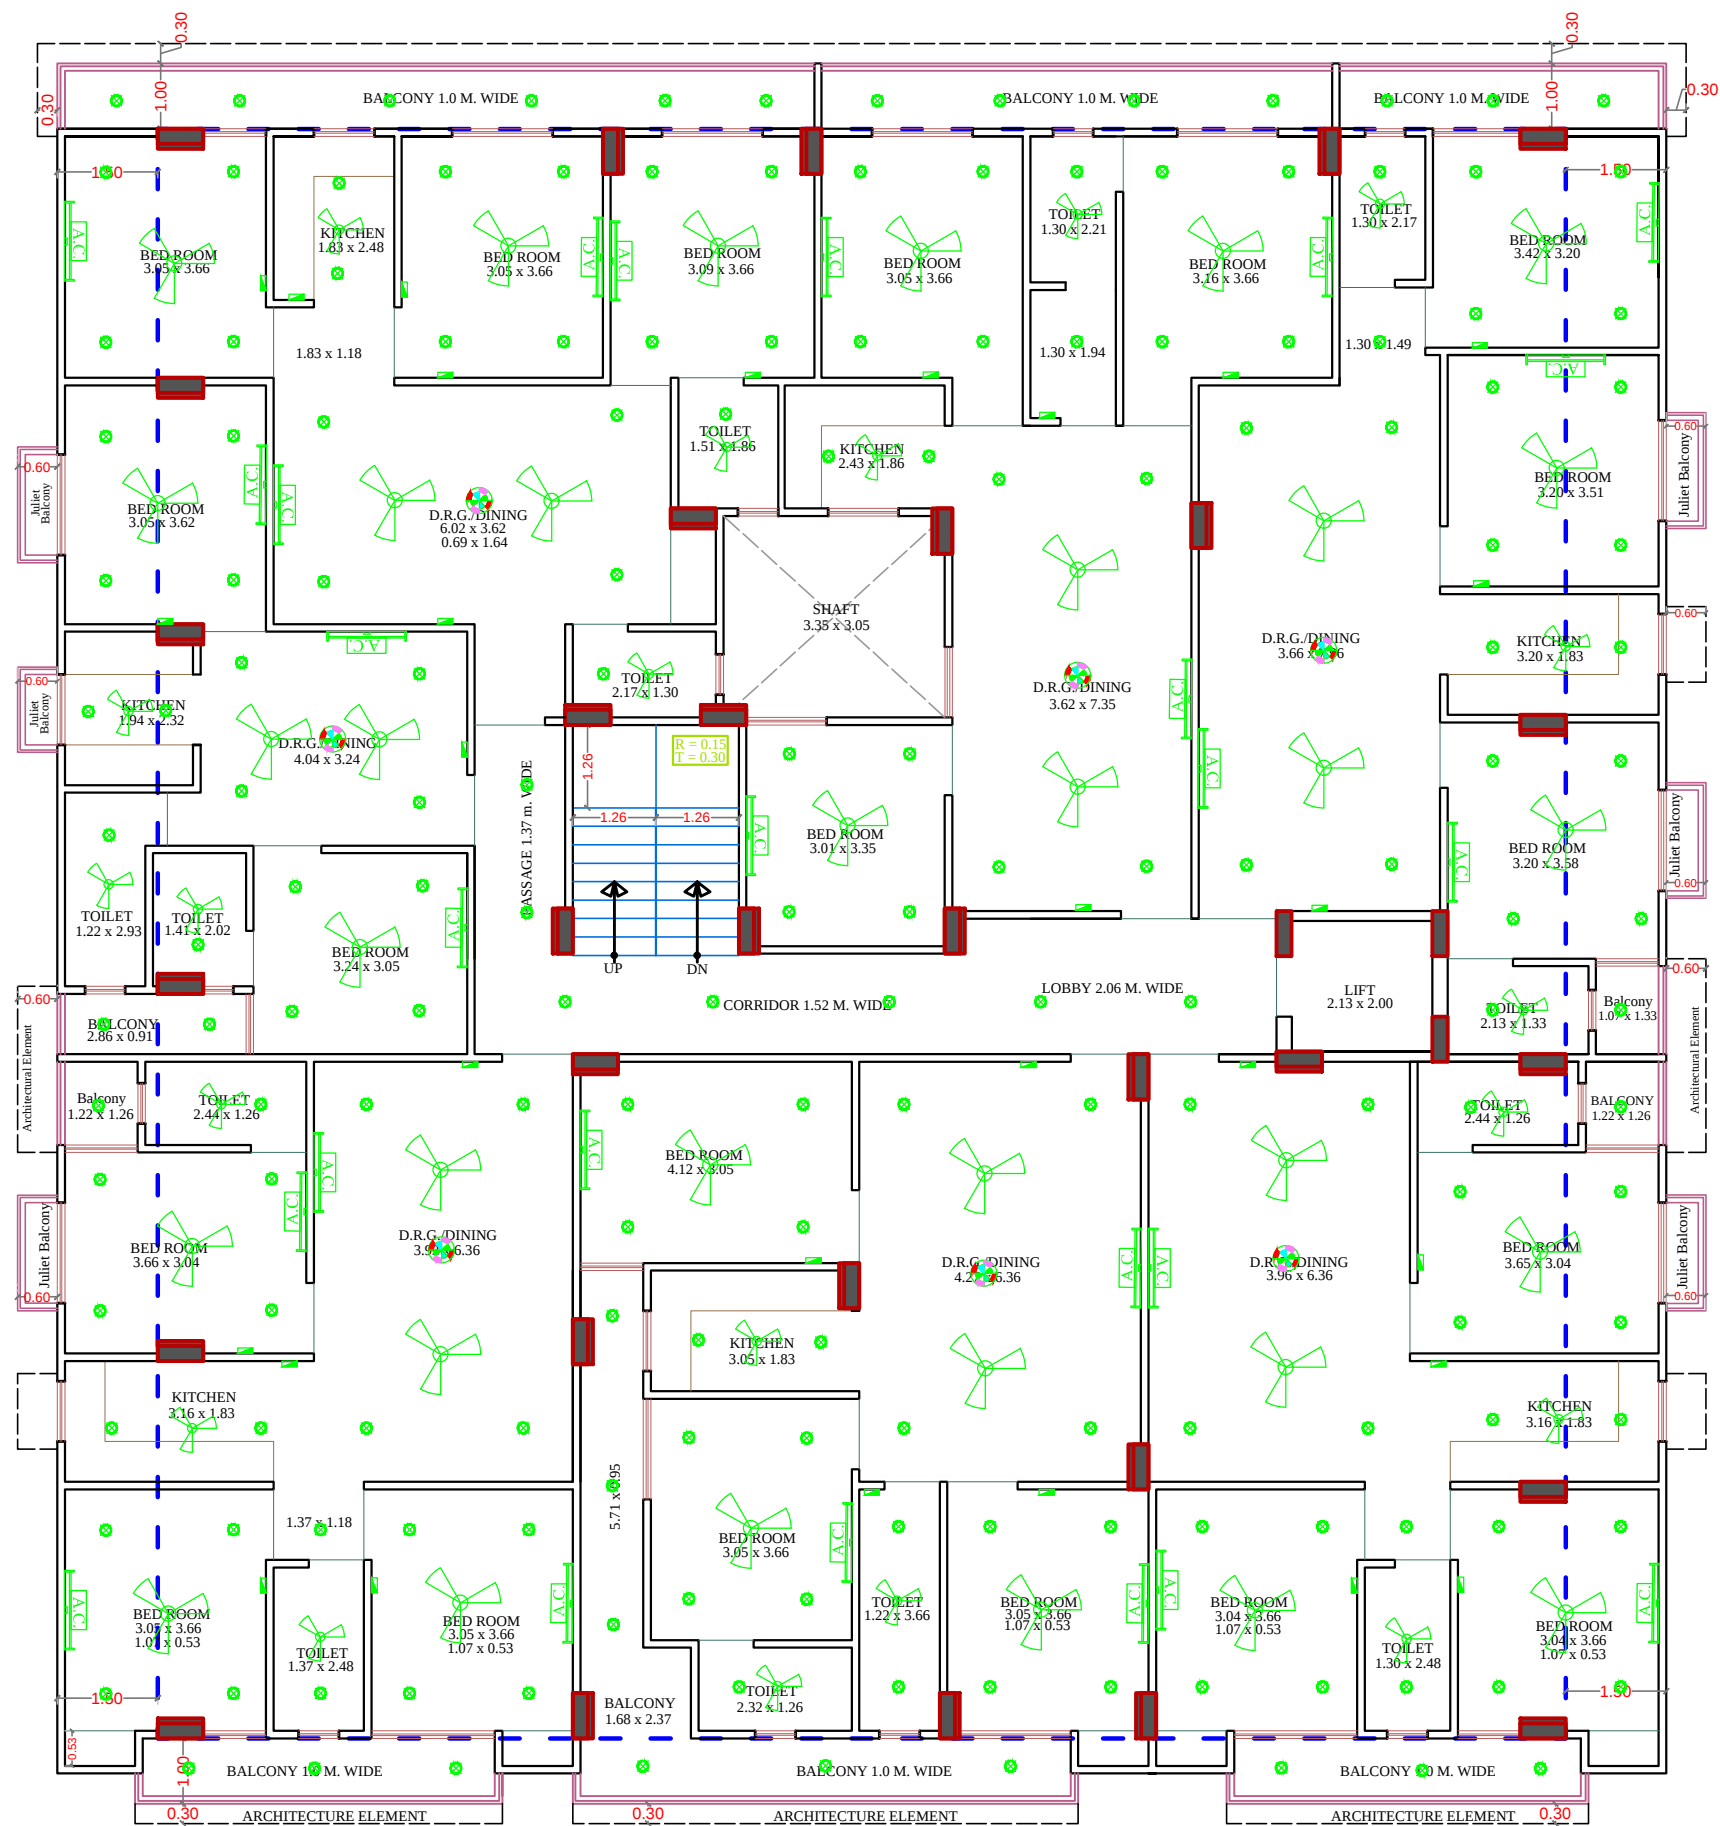


GROUND, 1st TO 5th FLOOR PLAN

NO	ITEM	SYMBOL
1	CEILING FAN	ROOF
2	TUBE LIGHT	+8'6"
3	BULB	+8'6"
4	POWER POINT	+1'6"
5	BED POINT	+4'3"
6	CEILING LIGHT	ROOF
7	A.C.POINT	+6'6"
8	SWITCH BOARD	+4'3"
9	EXHAUST	VENT
10	TELEPHONE	+1'6"
11	GYSER	+6'0"
12	BELL POINT	+8'6"
13	T.V.	+1'6"
14	M.BOX	M.B
15	M.C.B.	M.C.B +6'6"
16	FANCY LIGHT	+8'6"
17	HANGING LIGHT	ROOF

RAMESH KUMAWAT
M.E.P. CONSULTANT
B.E. CIVIL

For B D BUILDERS
Proprietor

PROJECT TITLE :- PROPOSED BUILDING AT PLOT NO. A102, A-103, A-104, A-105, A-122, A-123, A-124 & A-125, NARAYAN VATIKA, AT VILLAGE-DHAWAS, HEERAPURA AJMER ROAD, JAIPUR	BUILDING NAME ANANTAM UTSAV NARAYAN VATIKA DEVELOPER NAME BD BUILDERS	DRAWING TITLE :- TYPICAL FLOOR ELECTRIC PLAN	SPACE CONSULTANT PLOT-A-173, JAGDAMBA NAGAR, HEERAPURA POWER HOWER, JAIPUR (RAJ) 302024	DRN. BY		DATE	NORTH
				APPD. BY		REVISION	
				SCALE			

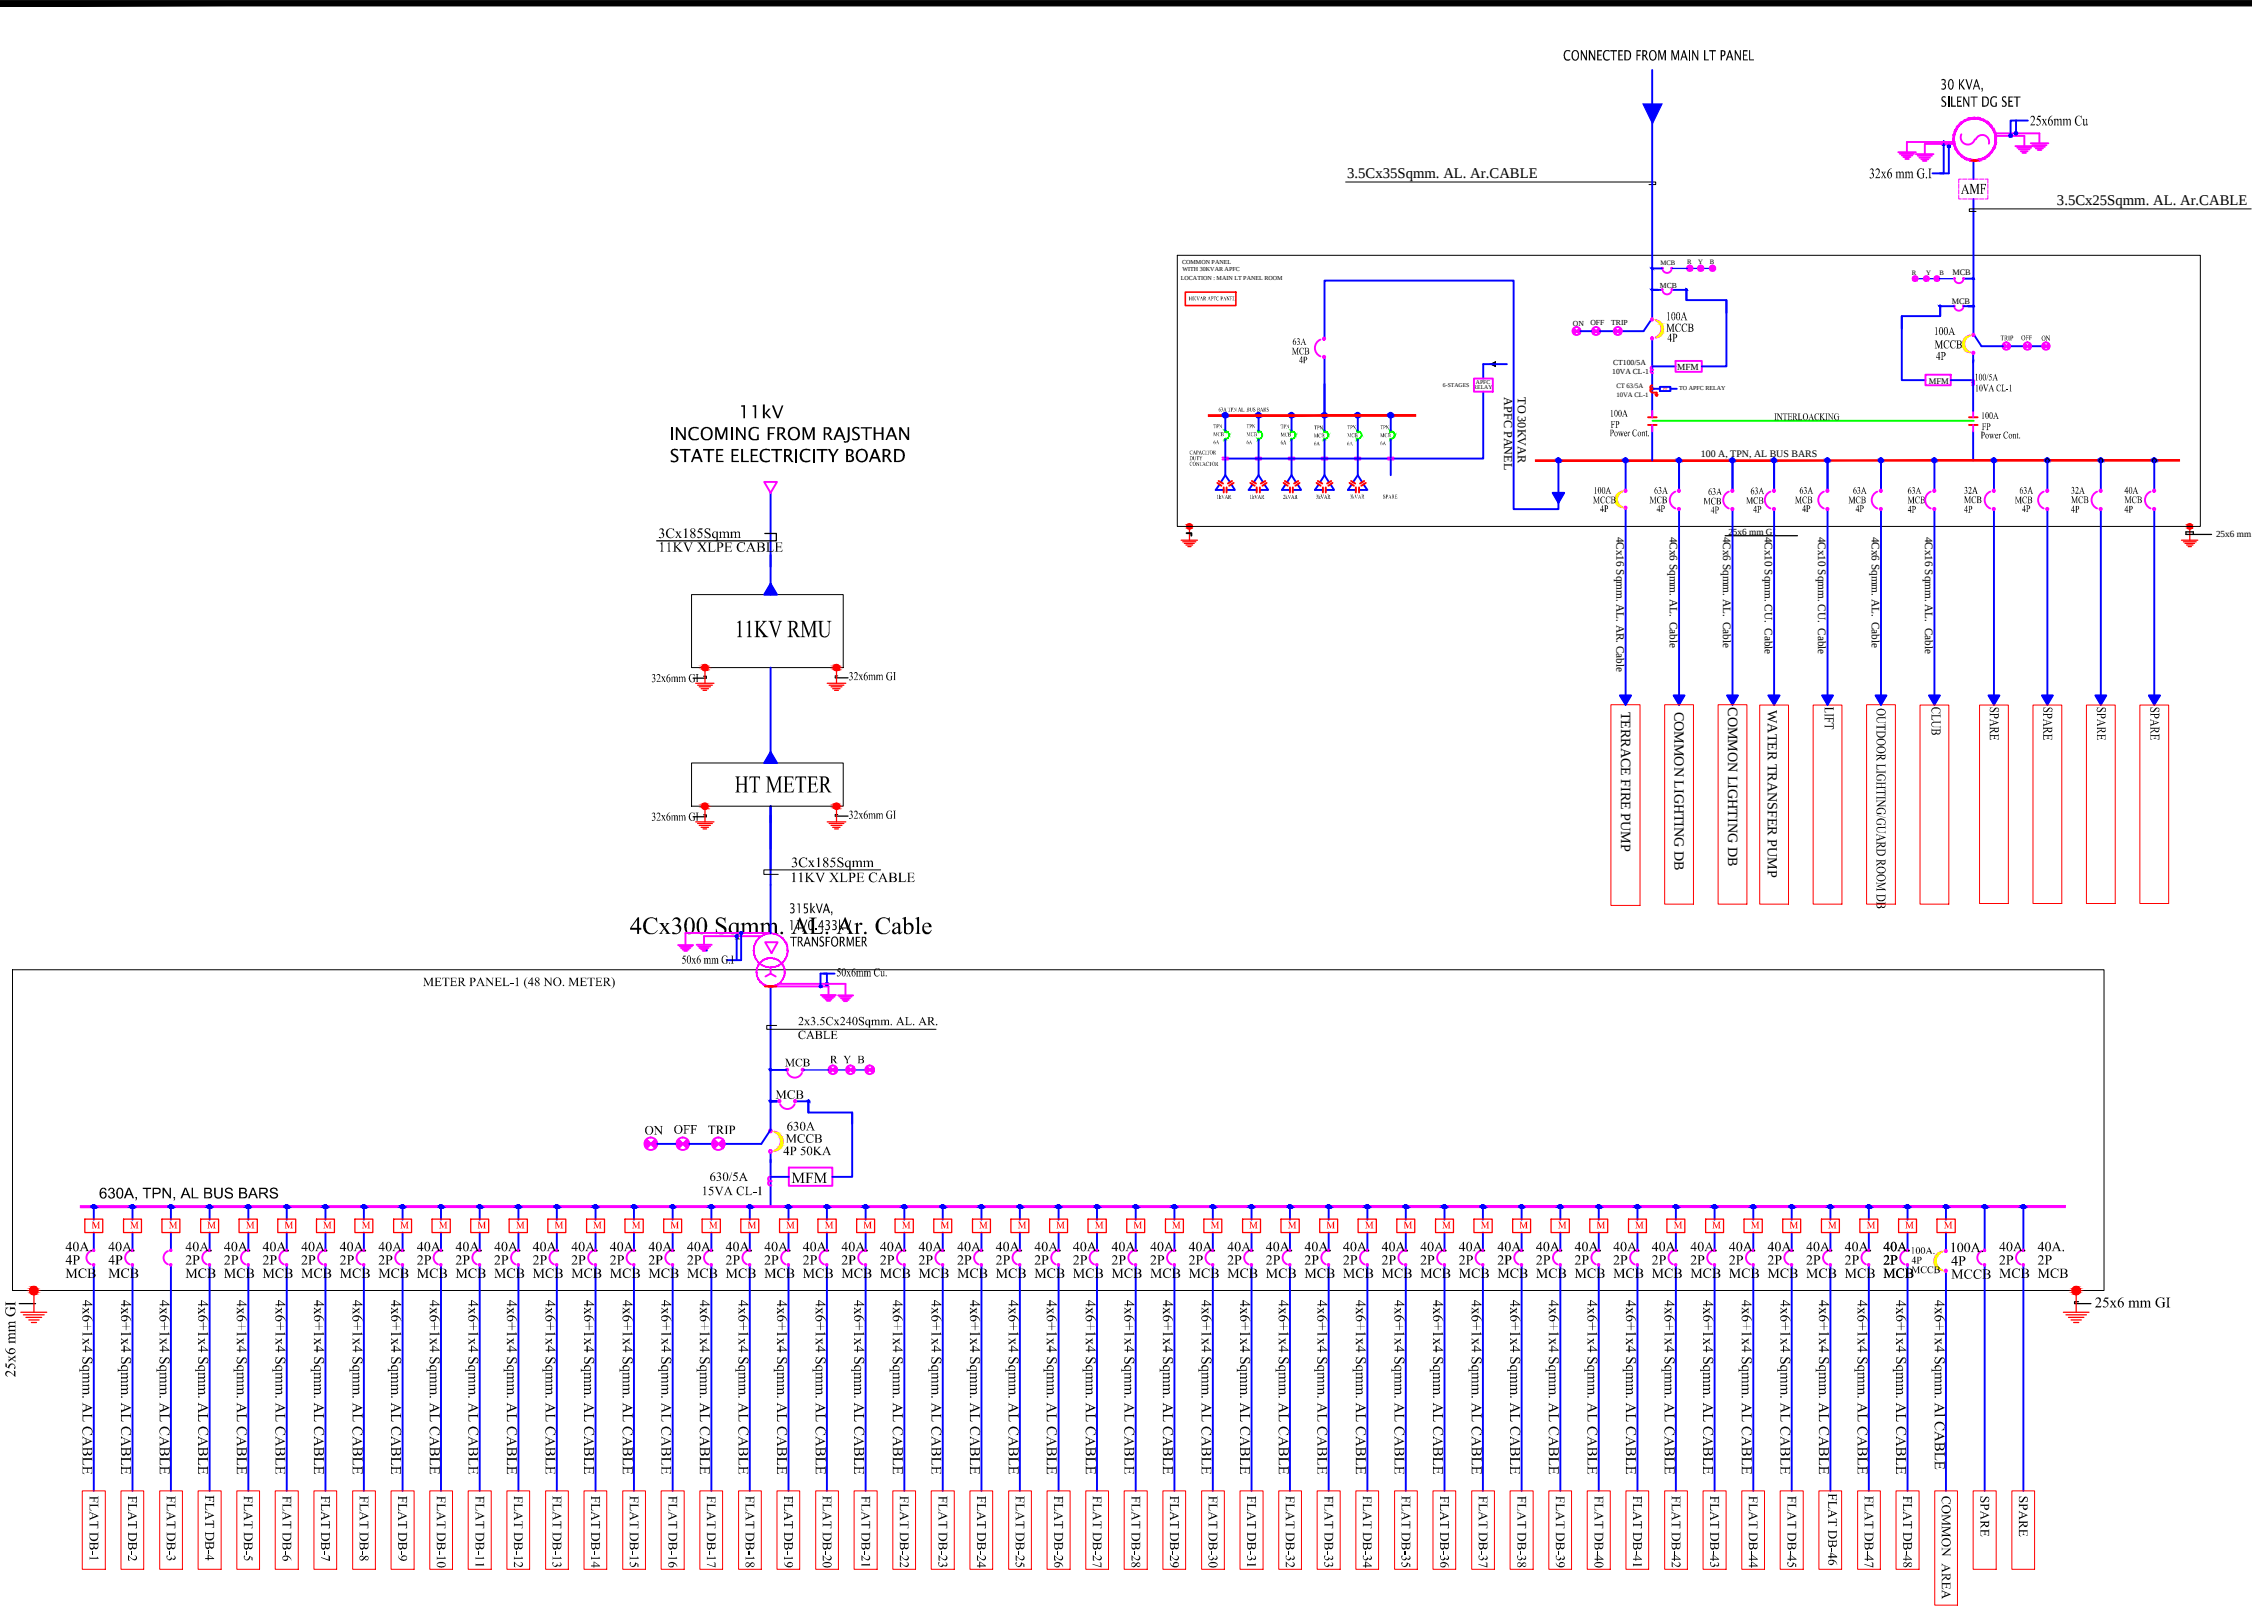

LEGEND	
SYMB.	DESCRIPTION
	AMMETER
	VOLTMETER
	POWER FACTOR METER
	VOLTMETER, AMMETER, FRICTION METER
	FREQUENCY METER
	KILOWATT HOUR METER
	KILOWATT METER
	AMMETER SELECTOR SWITCH
	VOLTMETER SELECTOR SWITCH
	LOCKOUT RELAY
	SUPERVISORY TRIP RELAY
	UNDER VOLTAGE DEVICE
	OVER VOLTAGE DEVICE
	REVERSE POWER PHASE DEVICE
	DIFFERENTIAL PROTECTION RELAY
	OVER CURRENT & EARTH FAULT RELAY
	MULTI FUNCTION REALY
	ELECTRICAL OPERATED MANUALLY DRAWOUT
	CONTROL FUSE
	CURRENT TRANSFORMER
	TRIVECTOR METER
	INDICATING LAMP
	EXHAUST FAN
	OVER LOAD RELAY
	POWER CONTACTOR
	POTENTIAL TRANSFORMER
	DUAL SOURCE ELECTRONIC ENERGY METER
	GROUNDING
	MICRO PROCESSOR BASED RELEASE
	ELECTRONIC ENERGY METER
	AIR CIRCUIT BREAKER
	VACUUM CIRCUIT BREAKER
	MINIATURE CIRCUIT BREAKER
	MOULDED CASE CIRCUIT BREAKER
	MOTOR PROTECTION CIRCUIT BREAKER

REVISION - 00	
GENERAL NOTES :	
1. ALL THE DIMENSIONS ON THE DRAWING ARE IN WRITTEN.	
2. ONLY WRITTEN DIMENSIONS ARE TO BE FOLLOWED, DRAWING SHOULD NOT BE SCALED IN ANY CIRCUMSTANCES.	
3. ALL MEASUREMENTS MUST BE CHECKED AND VERIFIED BY THE CONTRACTORS PRIOR TO EXECUTION OF WORK AT THE SITE.	
4. THIS DRAWING IS TO BE READ IN CONJUNCTION WITH ALL RELEVANT STRUCTURAL, ARCHITECTURAL & FACILITY PLANNING DRAWINGS.	
5. ANY DISCREPANCIES MUST BE BROUGHT TO THE NOTICE OF THE ENGINEER IMMEDIATELY & PRIOR TO EXECUTION AT SITE.	
6. CO-ORDINATION WITH SERVICES SUCH AS HVAC, PLUMBING & ELECTRICAL, ETC. IS THE RESPONSIBILITY OF THE CONTRACTORS.	
7. FOR DETAILS, REFER RELEVANT LARGE SCALE DETAIL DRGS. AS INDICATED.	

LIGHTING LEGEND			
SR.NO.	SYMBOL	DESCRIPTION	HEIGHT FROM FFL
1		CEILING TUBELIGHT POINT	CEILING
2		LED CEILING LIGHT POINT	CEILING
3		LED WALL BRACKET LIGHT POINT AT WALL	+7'-4"
4		6A SOCKET WITH SWITCH	+2'-0"
5		GENERAL POINT 16A SOCKET WITH SWITCH	+2'-0"
6		MDF BOX	+5'-0"
7		CEILING ROSE	+7'-4"
8		SWITCH BOARD	+4'-0"
9		EXHAUST FAN	VENT. HT.
10		LIGHT & POWER DISTRIBUTION BOARD	+5'-1"
11		025MM POINT CONDUIT	CEILING
12		025MM POWER CIRCUIT CONDUIT	CEILING FLOORING
13		025MM LIGHT CIRCUIT CONDUIT	CEILING FLOORING
14		CEILING FAN	CEILING


ARCHITECT	
ARCHITECT :-	
FRANK SQUARE	
ARCHITECTURE PLANNER DESIGNER	
C-49 VIDYA APARTMENT PARAS MARG,	
BAPU NAGAR JAIPUR, (RAJ.)	
Email-afranksquare@gmail.com	
Mobile-9461302542	

PROJECT :-	
PROPOSED BUILDING AT PLOT NO. A102, A-103, A-104, A-105, A-122, A-123, A-124 & A-125, NARAYAN VATIKA, AT VILLAGE-DHAWAS, HEERAPURA AJMER ROAD, JAIPUR	

BUILDER/DEVELOPER/CLIENT:-	
BD BUILDERS	
DRAWING TITLE:- MAIN PANEL SLD	
BUILDING NAME	
ANANTAM UTSAV NARAYAN VATIKA	
SUBMITTED FOR :-	
PRELIMINARY	APPROVAL
PROPOSAL	FOR RERA
DATE :-	NORTH :-
DRAWN :-	
APPROVED :-	
DRAWING NO.:-	SCALE :-

CONSULTANT	
AMP INFRA SERVICES	
VILLA NO 16. SHUBHASIS GEETA	
JAISINGHPURA, BHANKROTA &	
CHIMANPURA,JAIPUR 302026	
EMAIL ID- ampinfrajpr@gmail.com	
CONTACT NO. :- 9462866389	

SCHEMATIC DIAGRAM
LIGHTNING PROTECTION SYSTEM

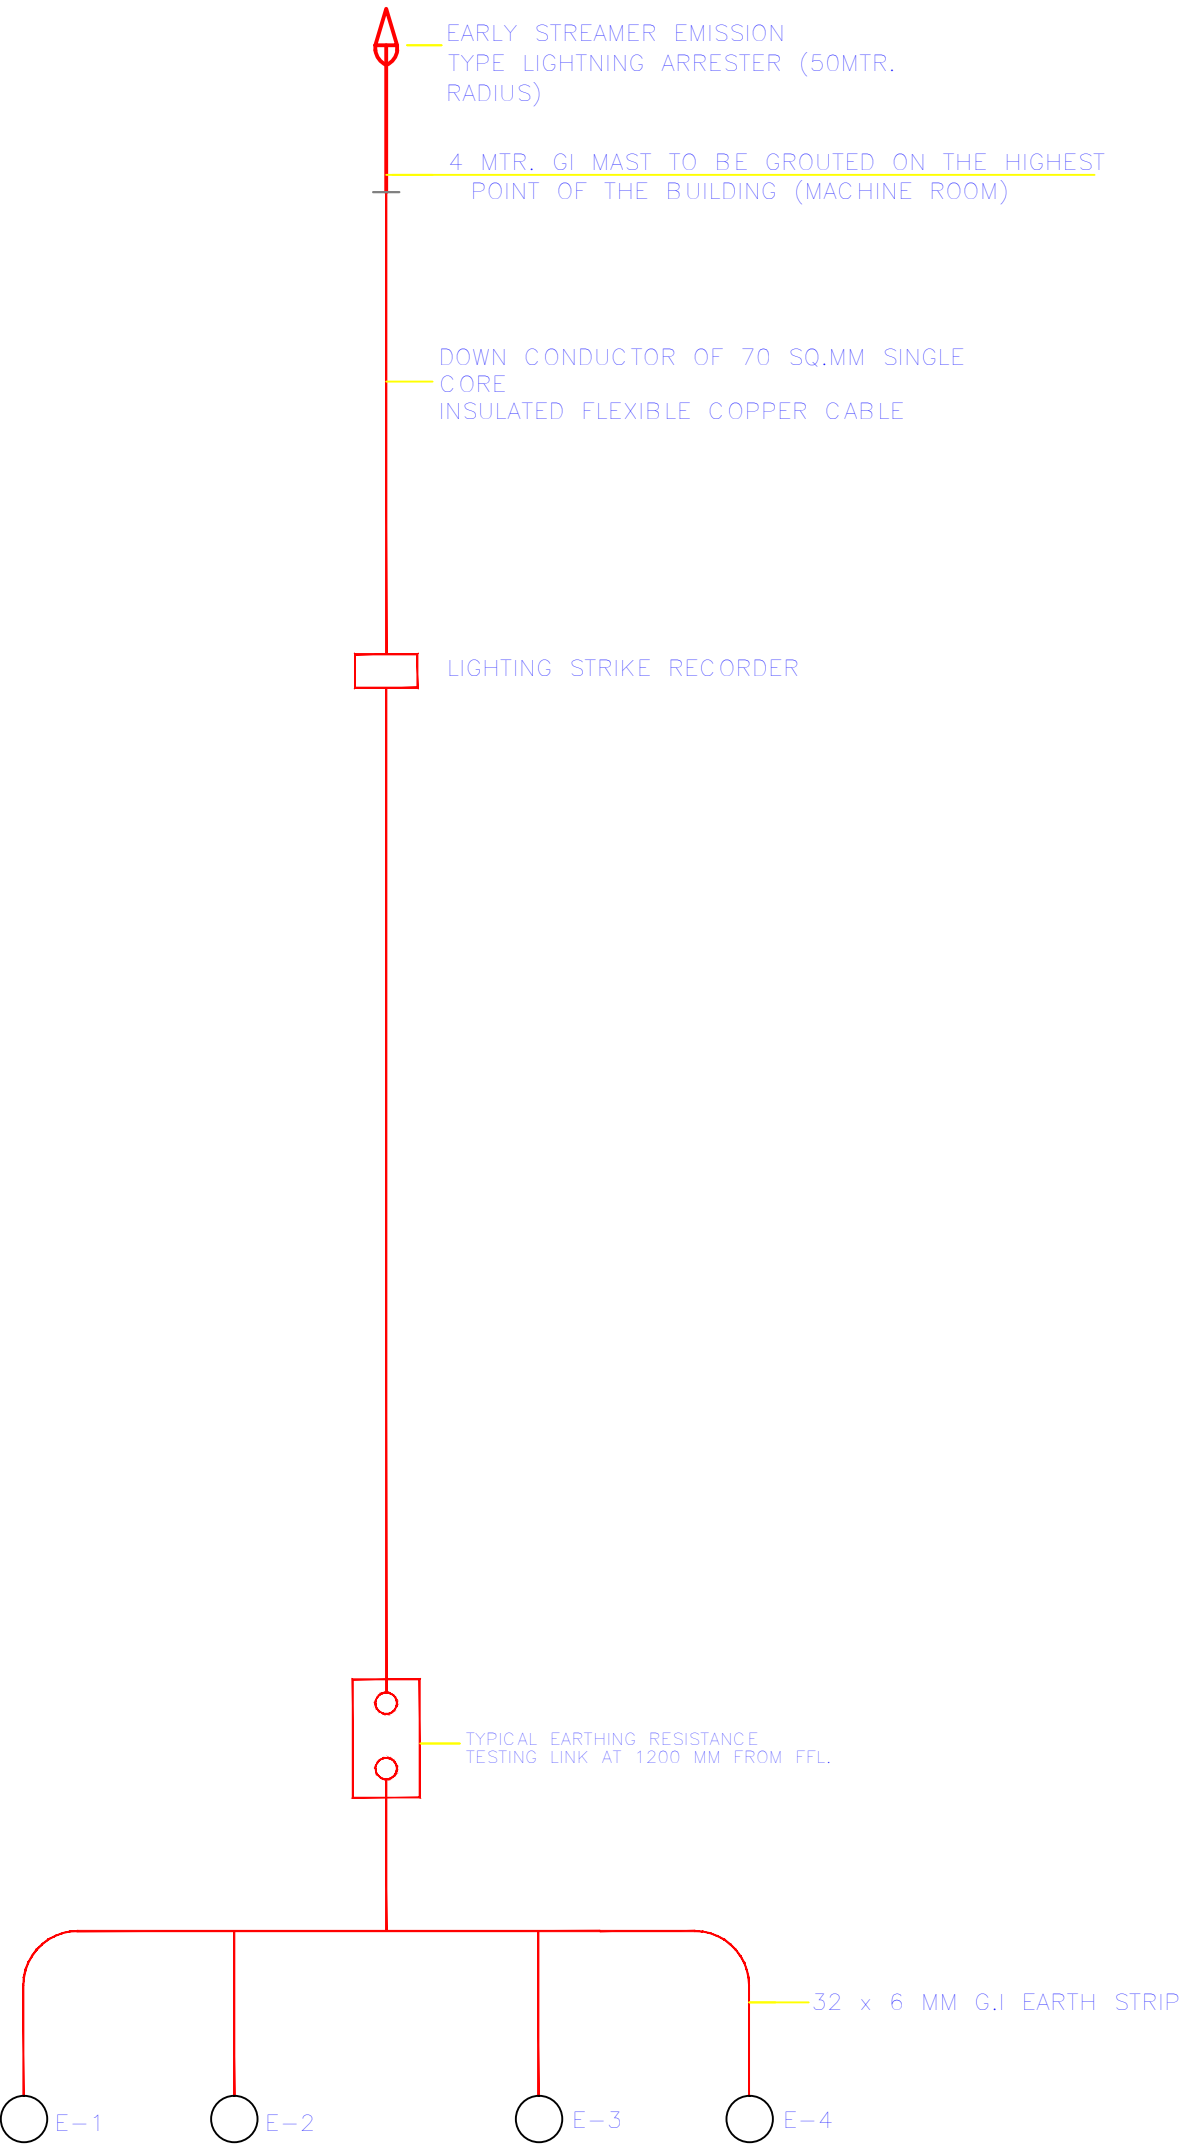

LIGHTENING ARRESTOR SLD

RAMESH KUMAWAT
M.E.P. CONSULTANT
B.E. CIVIL

For B D BUILDERS
Proprietor

PROJECT TITLE :-

PROPOSED BUILDING AT PLOT NO.
A102, A-103, A-104, A-105, A-122,
A-123, A-124 & A-125, NARAYAN
VATIKA, AT VILLAGE-DHAWAS,
HEERAPURA AJMER ROAD, JAIPUR

BUILDING NAME

ANANTAM UTSAV NARAYAN VATIKA

DEVELOPER NAME

BD BUILDERS

DRAWING TITLE :-

LIGHTENING
ARRESTOR SLD

SPACE CONSULTANT

PLOT-A-173, JAGDAMBA NAGAR, HEERAPURA
POWER HOWER, JAIPUR (RAJ) 302024

DRN. BY


APPD. BY

SCALE

DATE

REVISION

NORTH

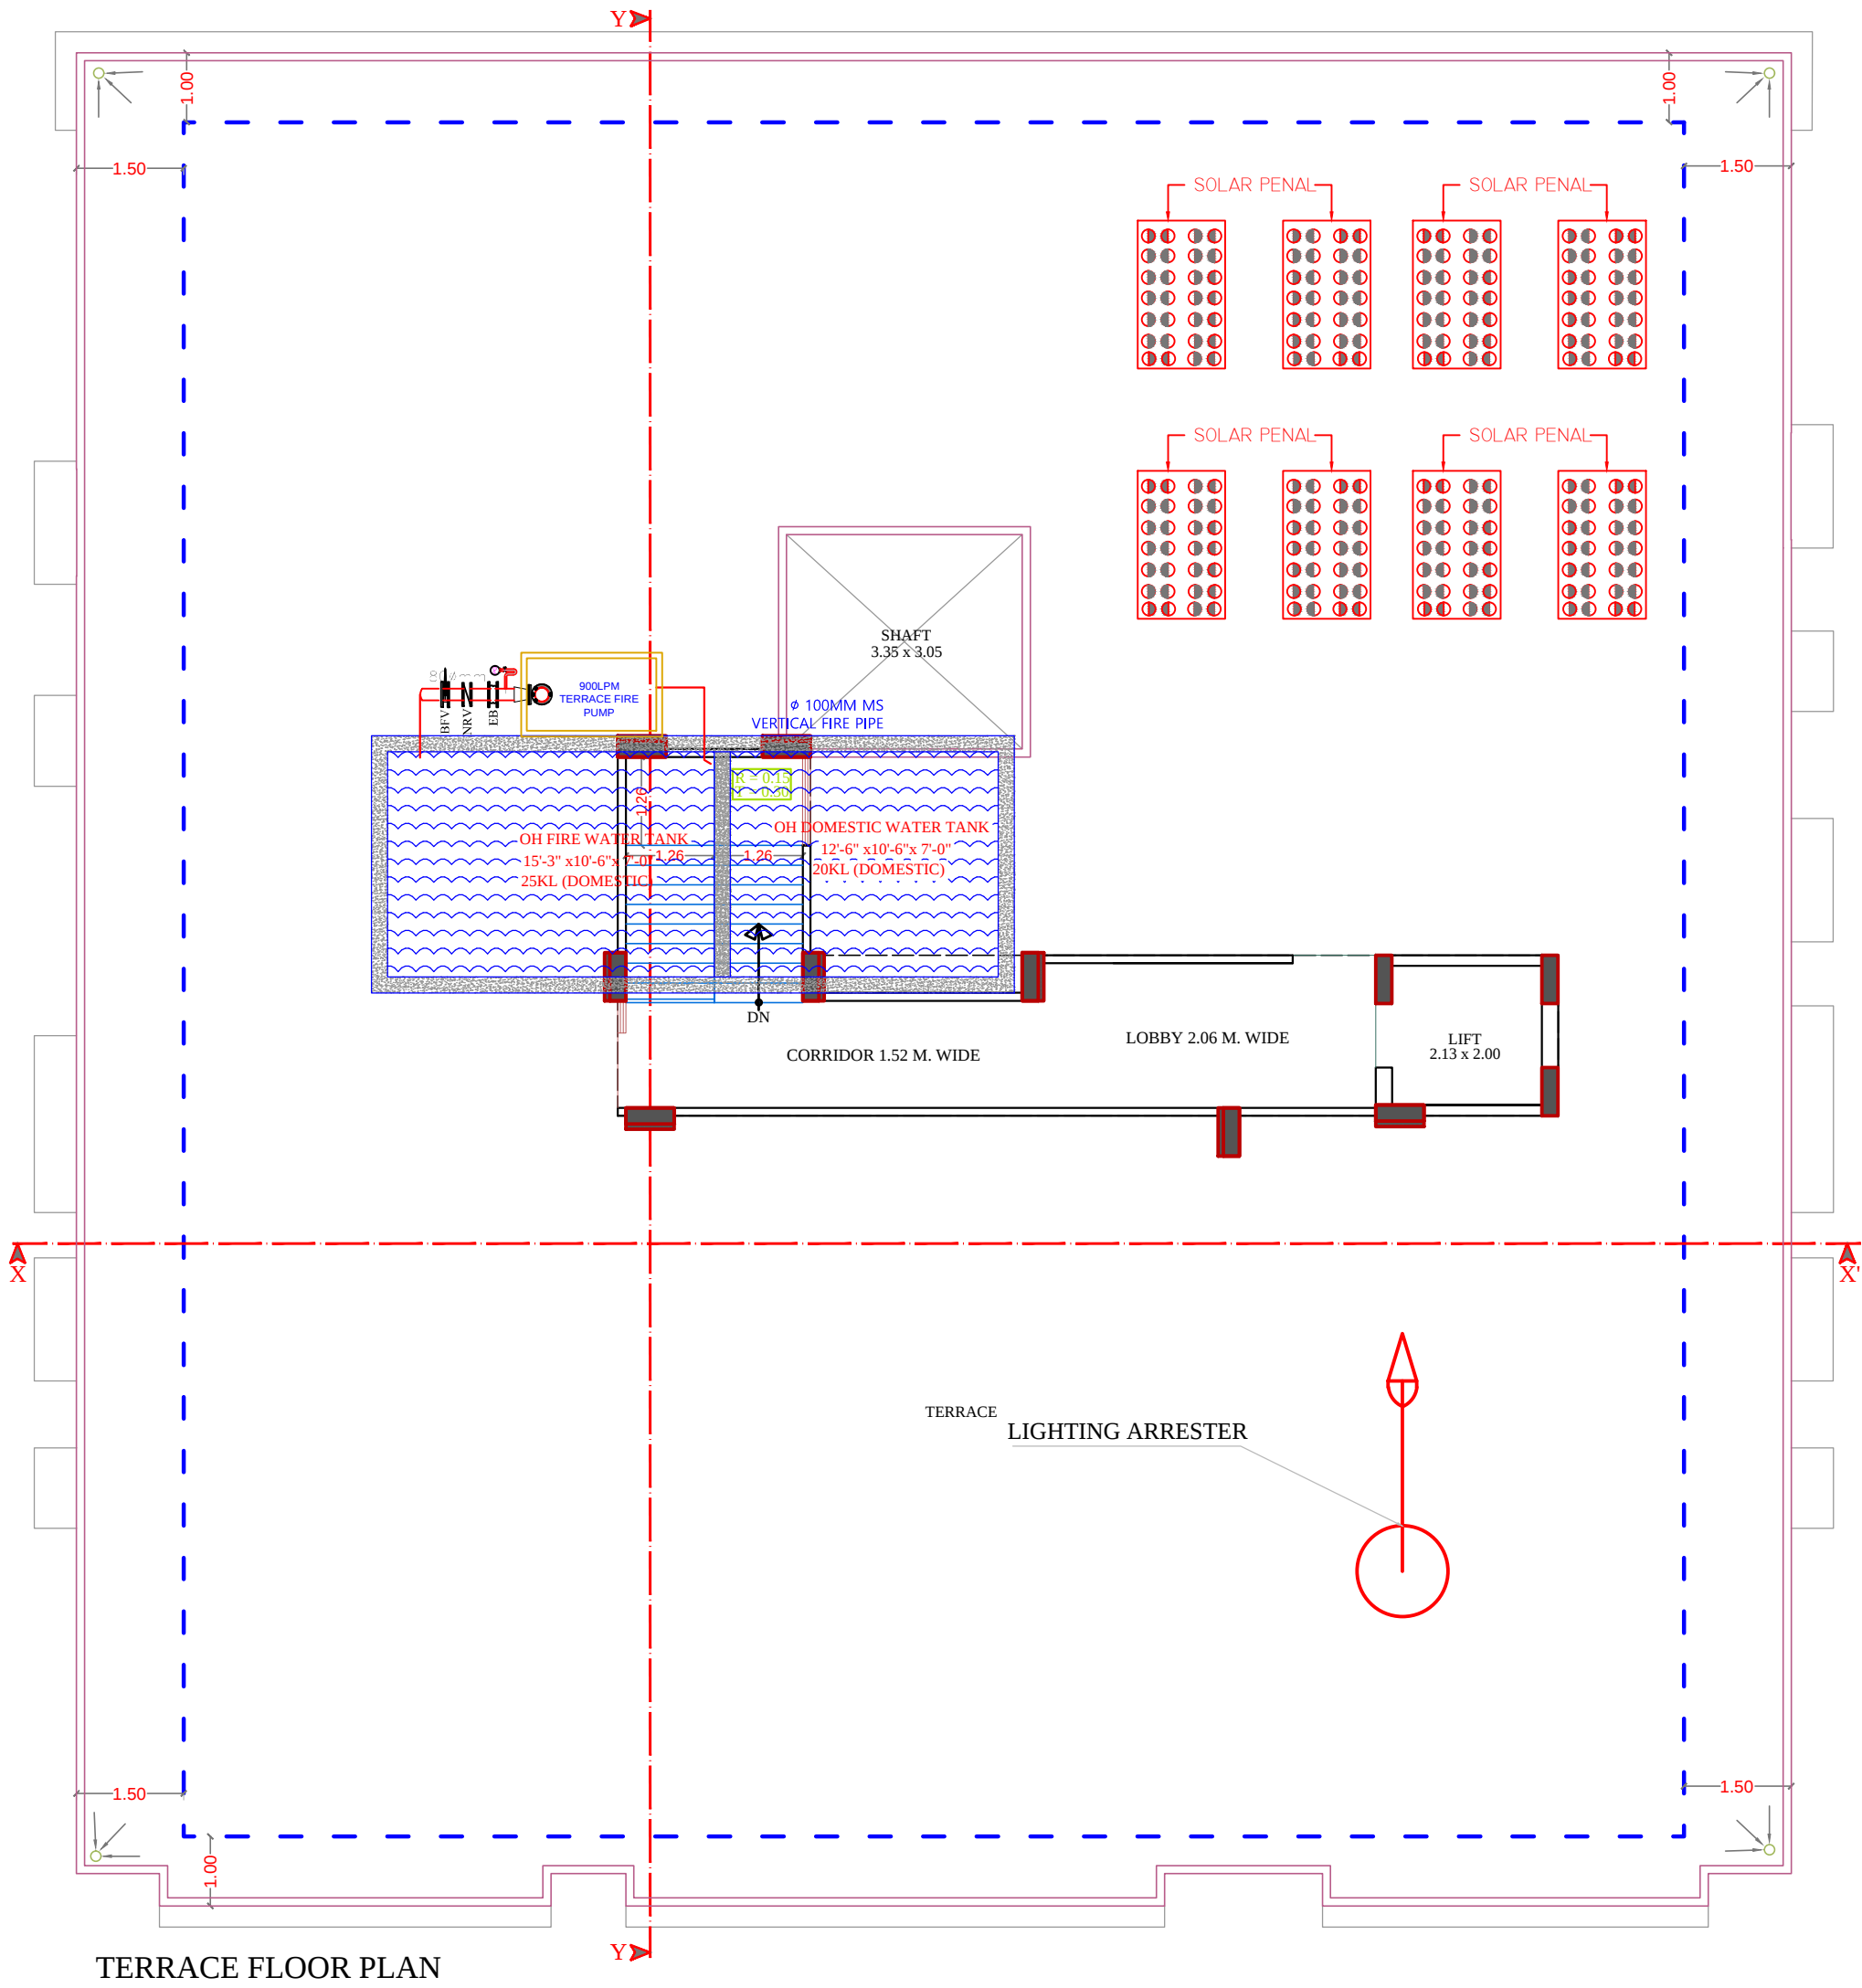

TERRACE FLOOR PLAN

LEGEND

	Symbole	DESCRIPTION
1.		HOSEREEL
2.		FIRE PIPE
3.		FIRE PIPE
4.		FIRE EXTINGUISHER
5.		EXTERNAL YARD HYDRANT

RAMESH KUMAWAT
M.E.P. CONSULTANT
B.E. CIVIL

For B D BUILDERS
Proprietor

PROJECT TITLE :-

PROPOSED BUILDING AT PLOT NO.
A102, A-103, A-104, A-105, A-122,
A-123, A-124 & A-125, NARAYAN
VATIKA, AT VILLAGE-DHAWAS,
HEERAPURA AJMER ROAD, JAIPUR

BUILDING NAME

ANANTAM UTSAV NARAYAN VATIKA

DEVELOPER NAME

BD BUILDERS

DRAWING TITLE :-

TARRACE FLOOR
LIGHTING ARRESTER
LOCATION

SPACE CONSULTANT

PLOT-A-173, JAGDAMBA NAGAR, HEERAPURA
POWER HOWER, JAIPUR (RAJ) 302024

DRN. BY

APPD. BY

SCALE

DATE

REVISION

NORTH