


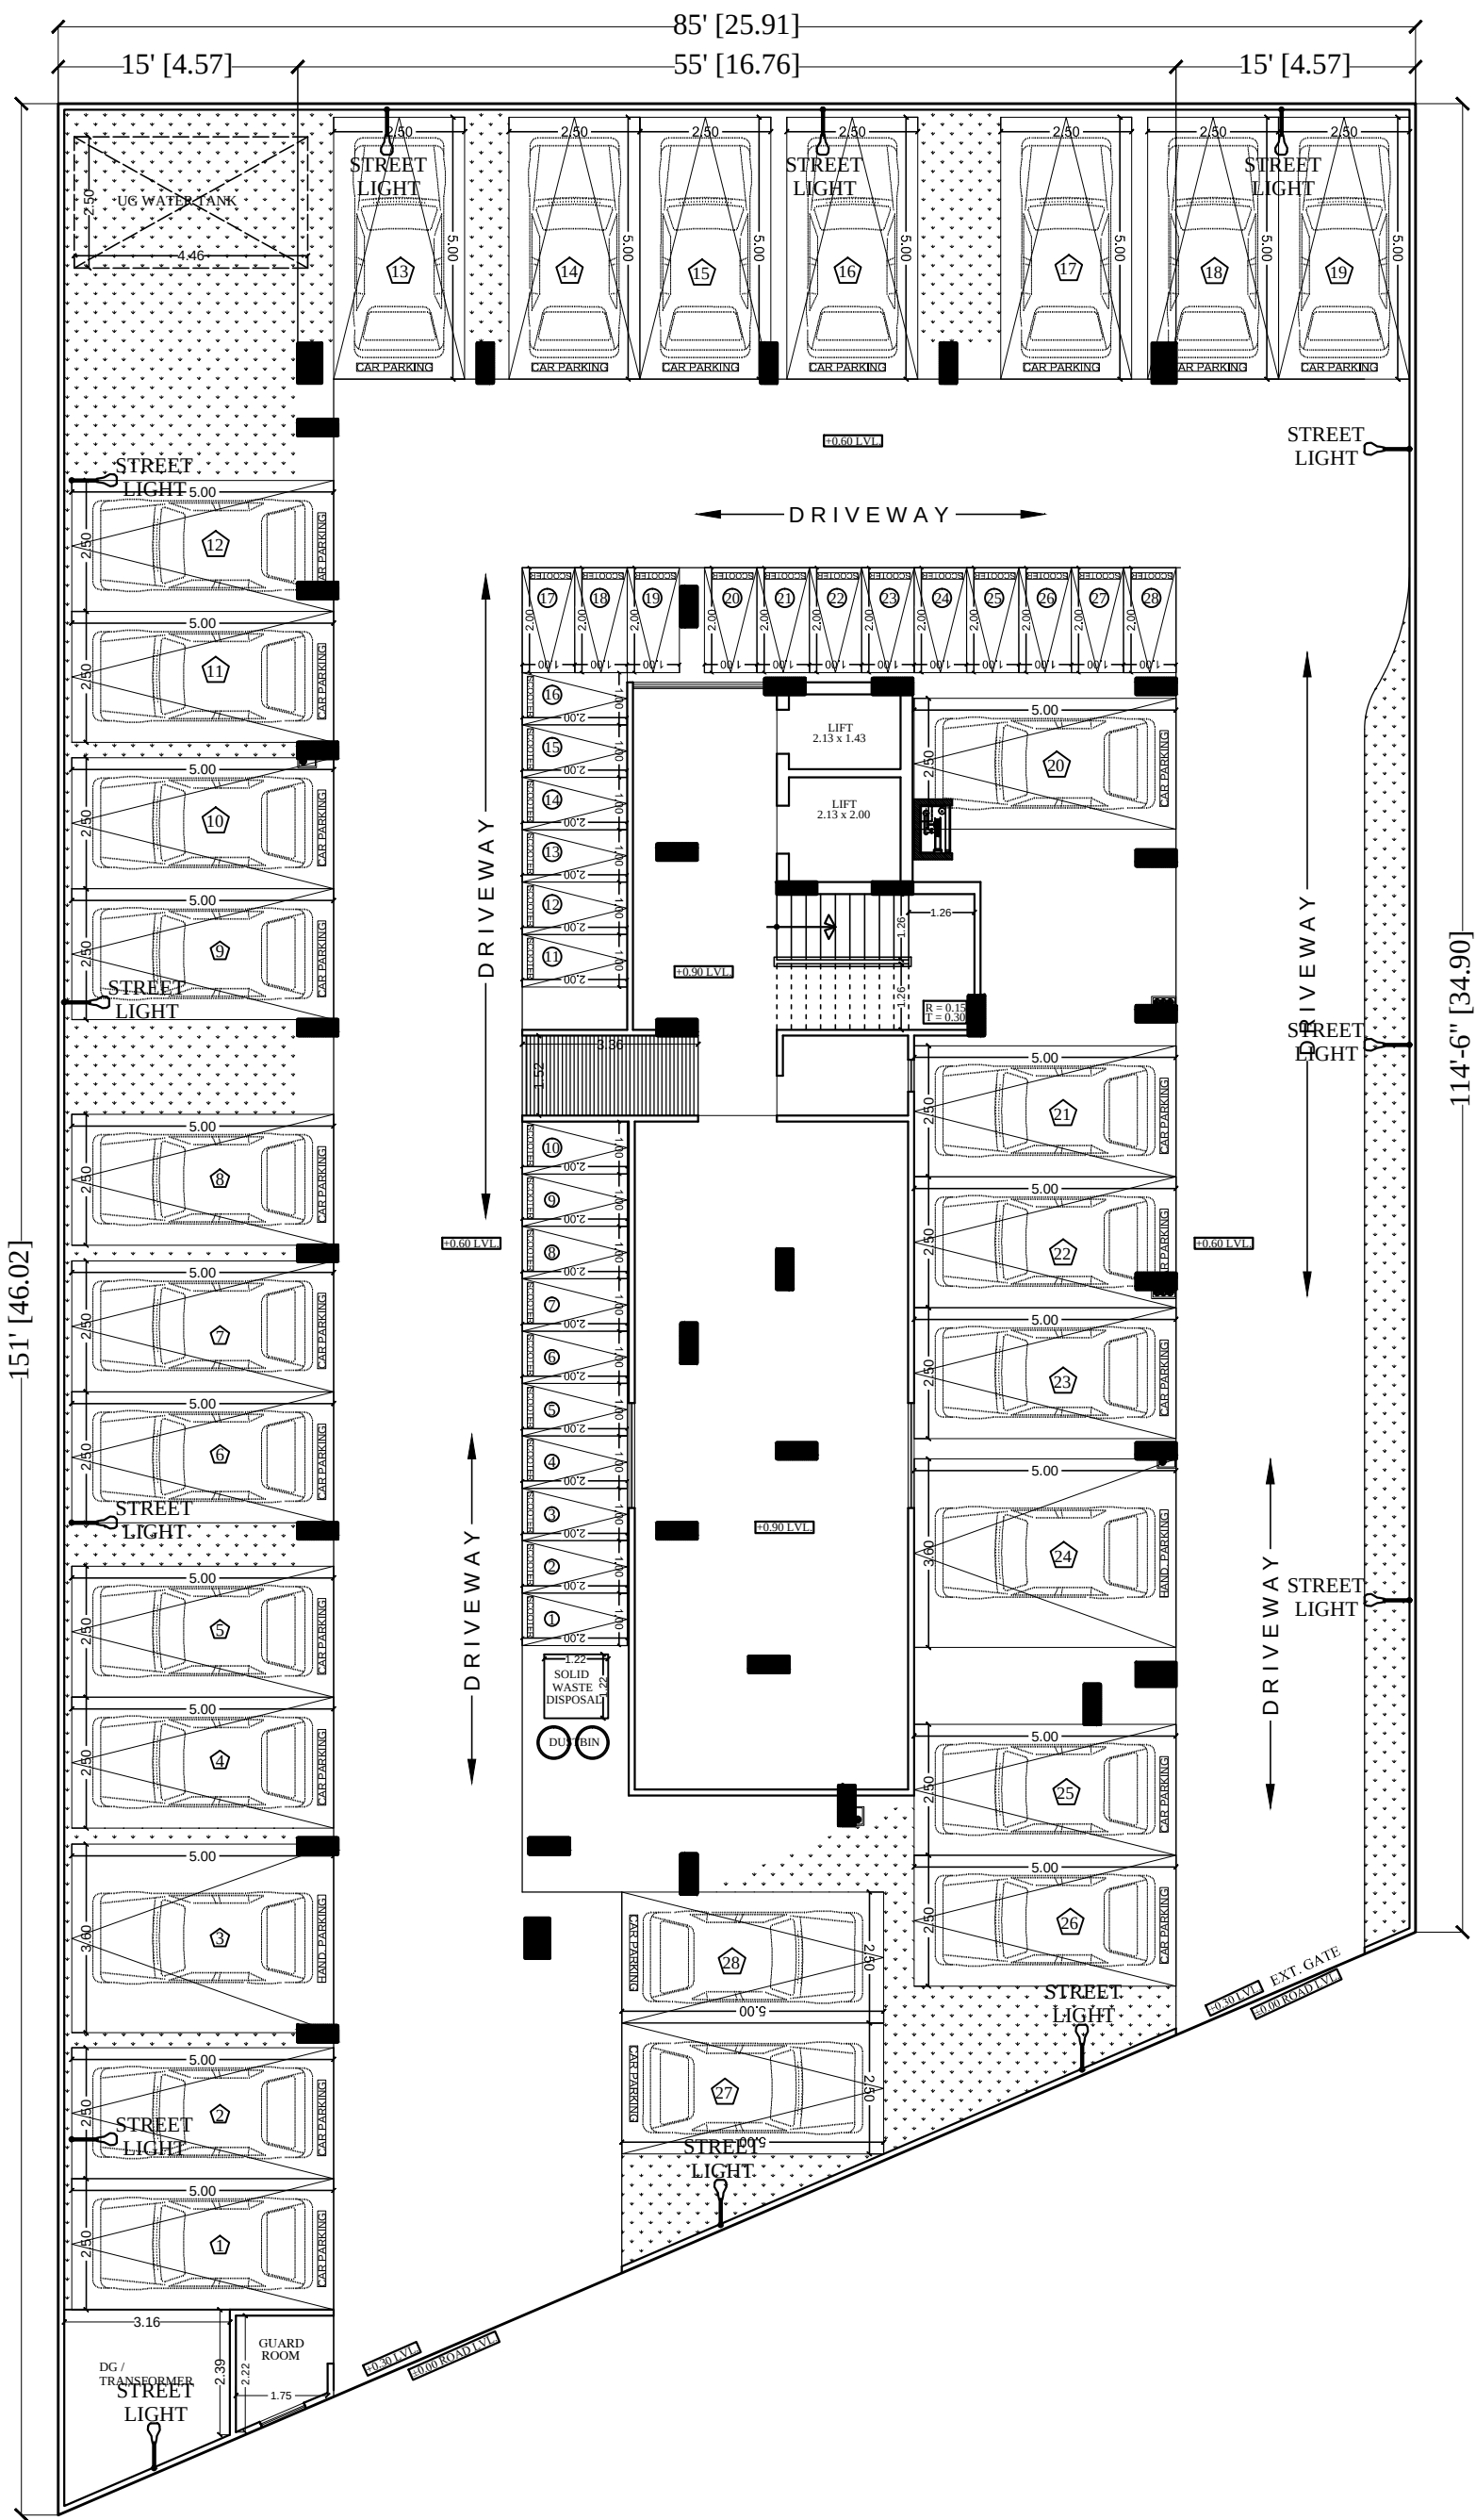

LEGENDS:

Qty.	I D	Symbol	Description
14	PL		STREET LIGHT

SIGN:-

RAMESH KUMAWAT
M.E.P. CONSULTANT
B.E. CIVIL

SPACE CONSULTANT

PLOT-A-173, JAGDAMBA NAGAR, HEERAPURA
POWER HOWER, JAIPUR (RAJ) 302024

ARCHITECT :-


FRANK SQUARE
ARCHITECTURE | PLANNER | DESIGNER
C-49 VIDYA APARTMENT PARAS MARG,
BAPU NAGAR JAIPUR, (RAJ.)
Email-afranksquare@gmail.com
Mobile-9461302542

PROJECT :-
PROPOSED BUILDING AT G.H -30
KRISHNAM PEARL ESTATES,
VILLAGE :- RAM CHANDRAPURA,
TEH - SANGANER JAIPUR

DRAWING:

STILT FLOOR
EXTERNAL STREET LIGHT
FOR RERA SUBMISSION PLAN

DATE	
SCALE:- N.T.S.	

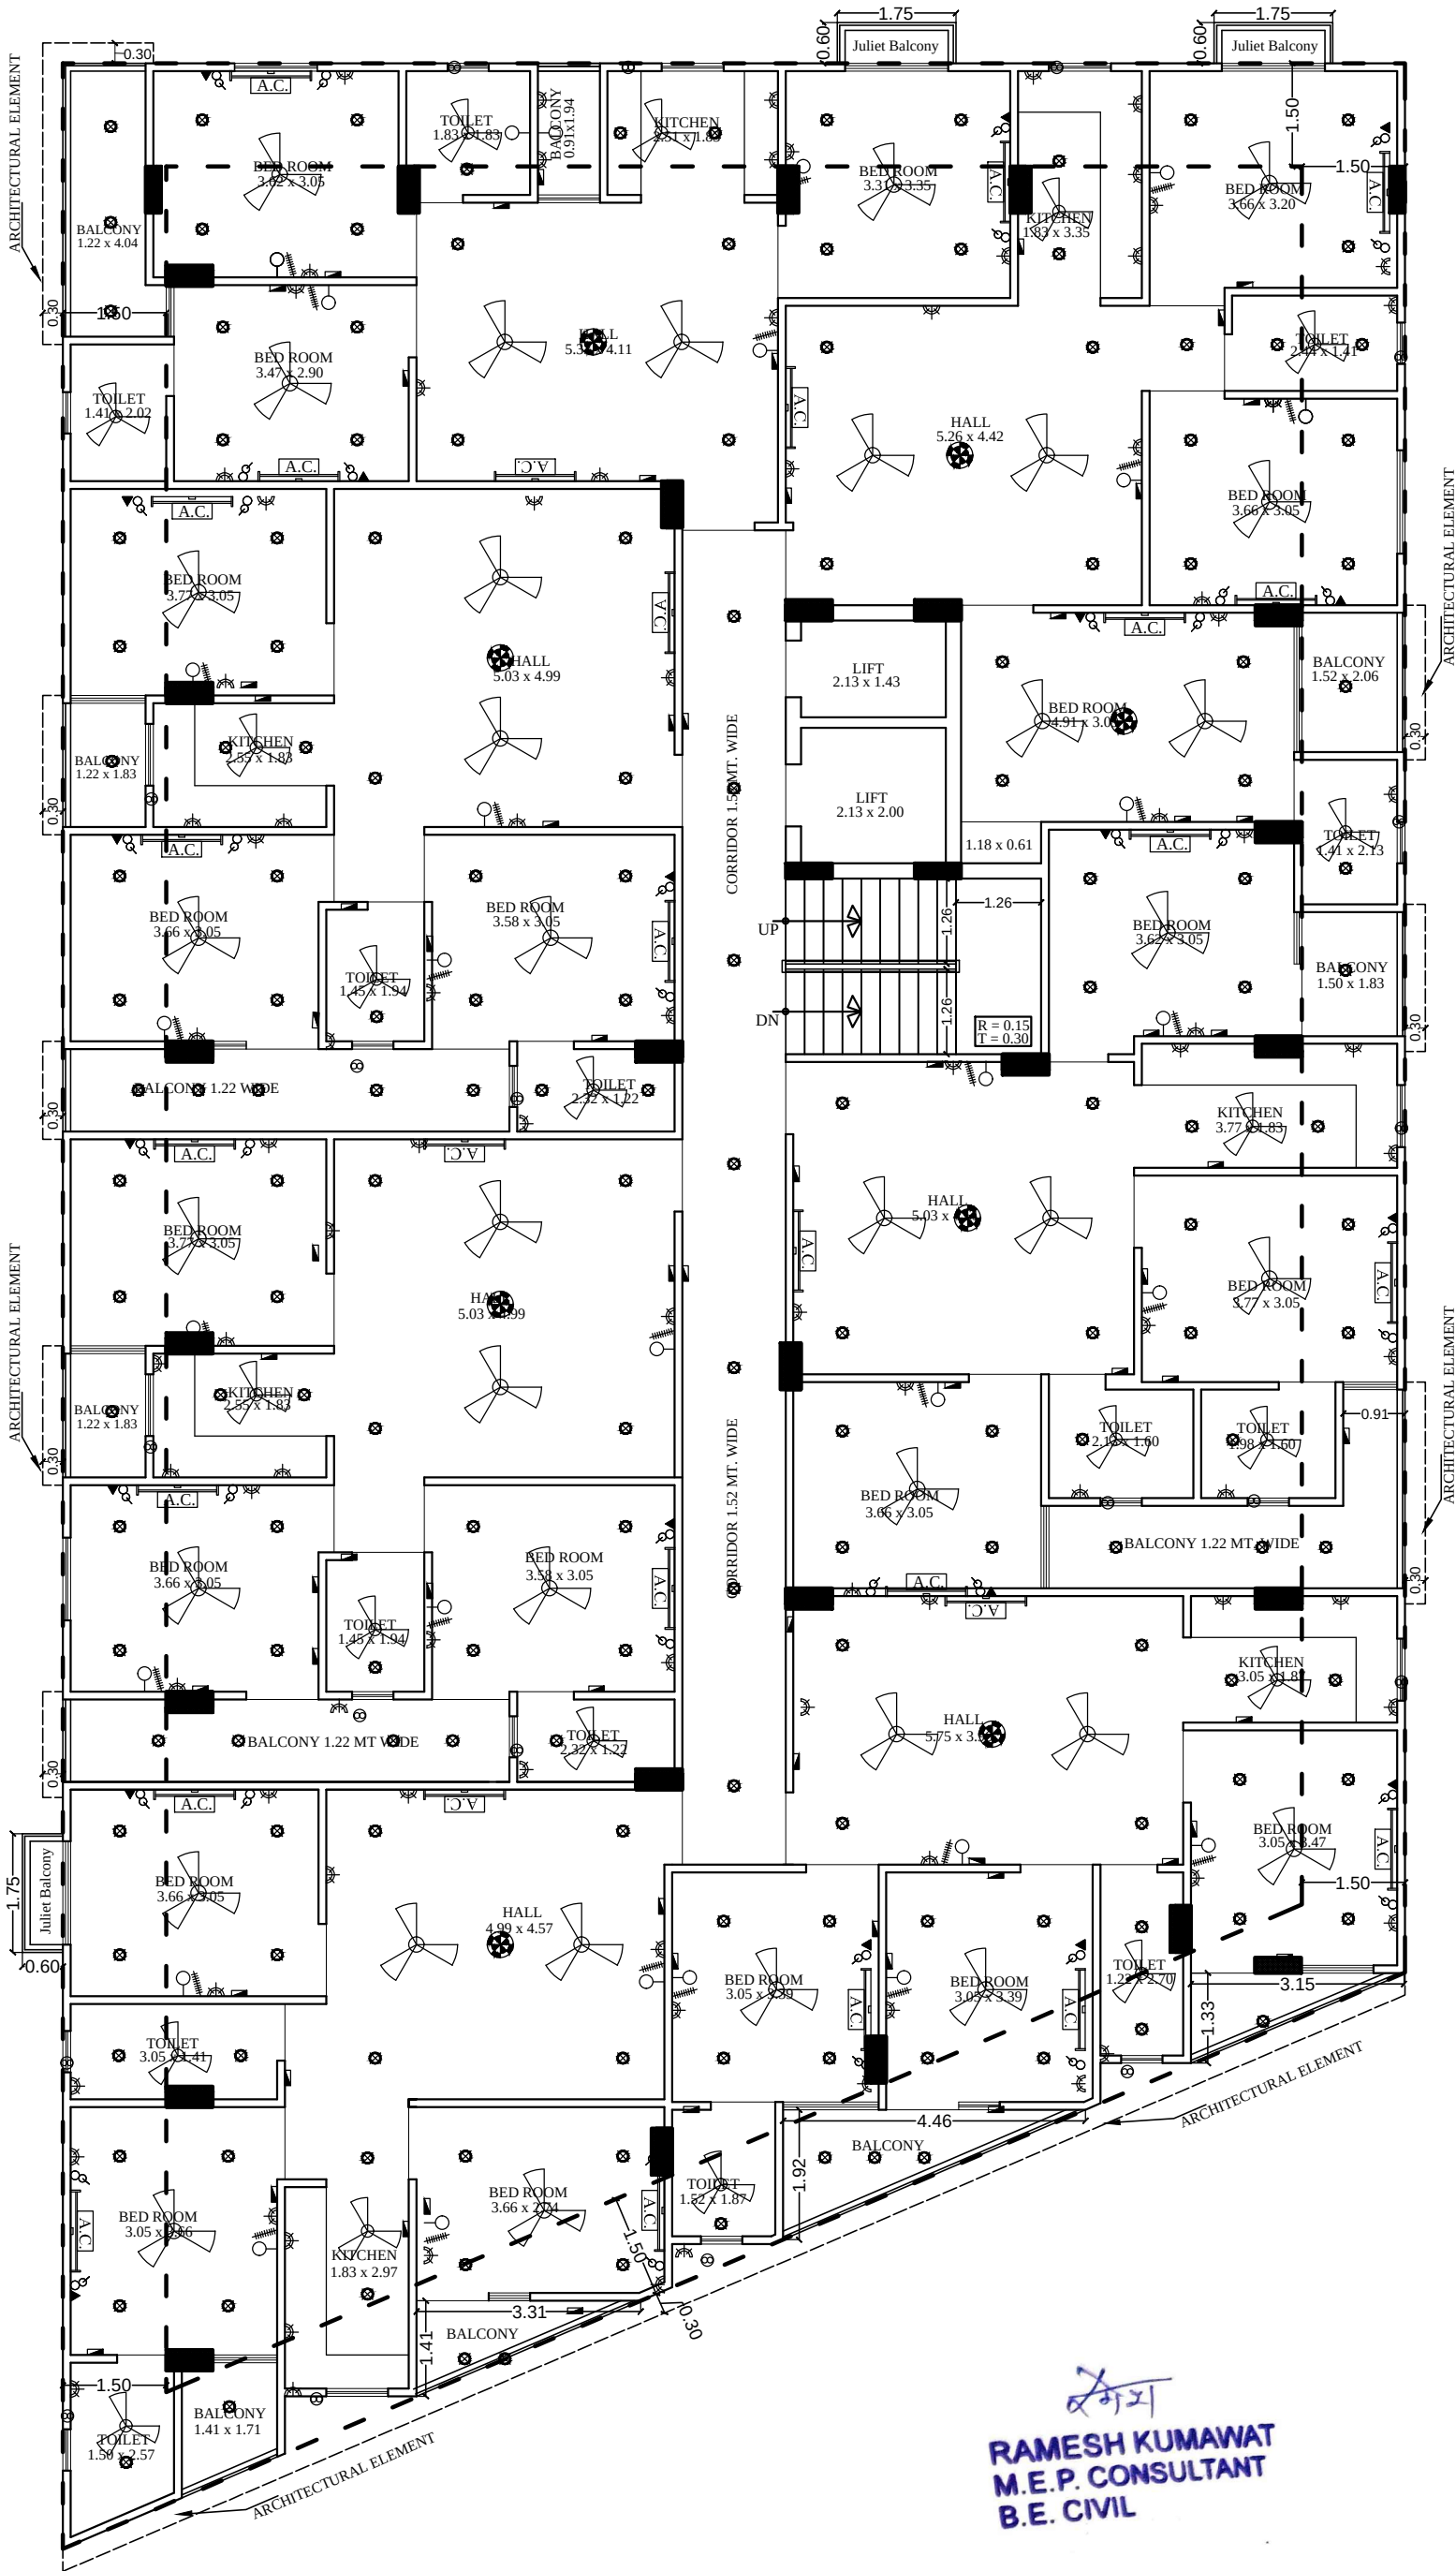

NO	ITEM	SYMBOL
1	CEILING FAN	ROOF
2	TUBE LIGHT	+8'6"
3	BULB	+8'6"
4	POWER POINT	+1'6"
5	BED POINT	+4'3"
6	CEILING LIGHT	ROOF
7	A.C.POINT	+6'6"
8	SWITCH BOARD	+4'3"
9	EXHAUST	VENT
10	TELEPHONE	+1'6"
11	GYSER	+6'0"
12	BELL POINT	+8'6"
13	T.V.	+1'6"
14	M.BOX	M.B
15	M.C.B.	M.C.B +6'6"
16	FANCY LIGHT	+8'6"
17	HANGING LIGHT	ROOF

TYPICAL FLOOR ELECTRIC PLAN

PROJECT TITLE :-
PROPOSED BUILDING AT G.H -30
KRISHNAM PEARL ESTATES,
VILLAGE :- RAM CHANDRAPURA,
TEH - SANGANER JAIPUR

ARCHITECT :-

SERVICES CONSULTANT

DRN. BY		PATH :-	
		DRN.	DATE
APPD. BY		SCALE	REVISION
		N.T.S	



NORTH

E

N

W

S

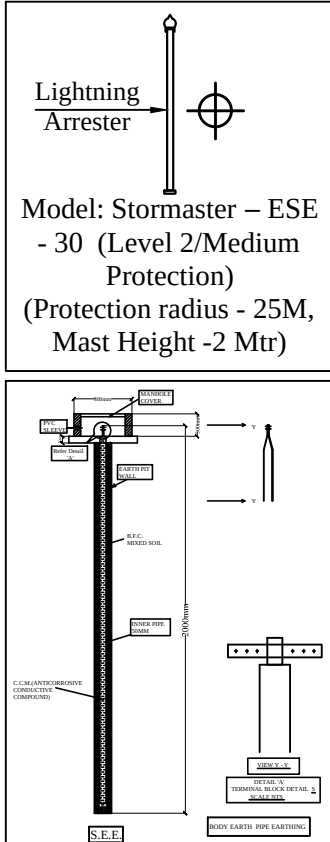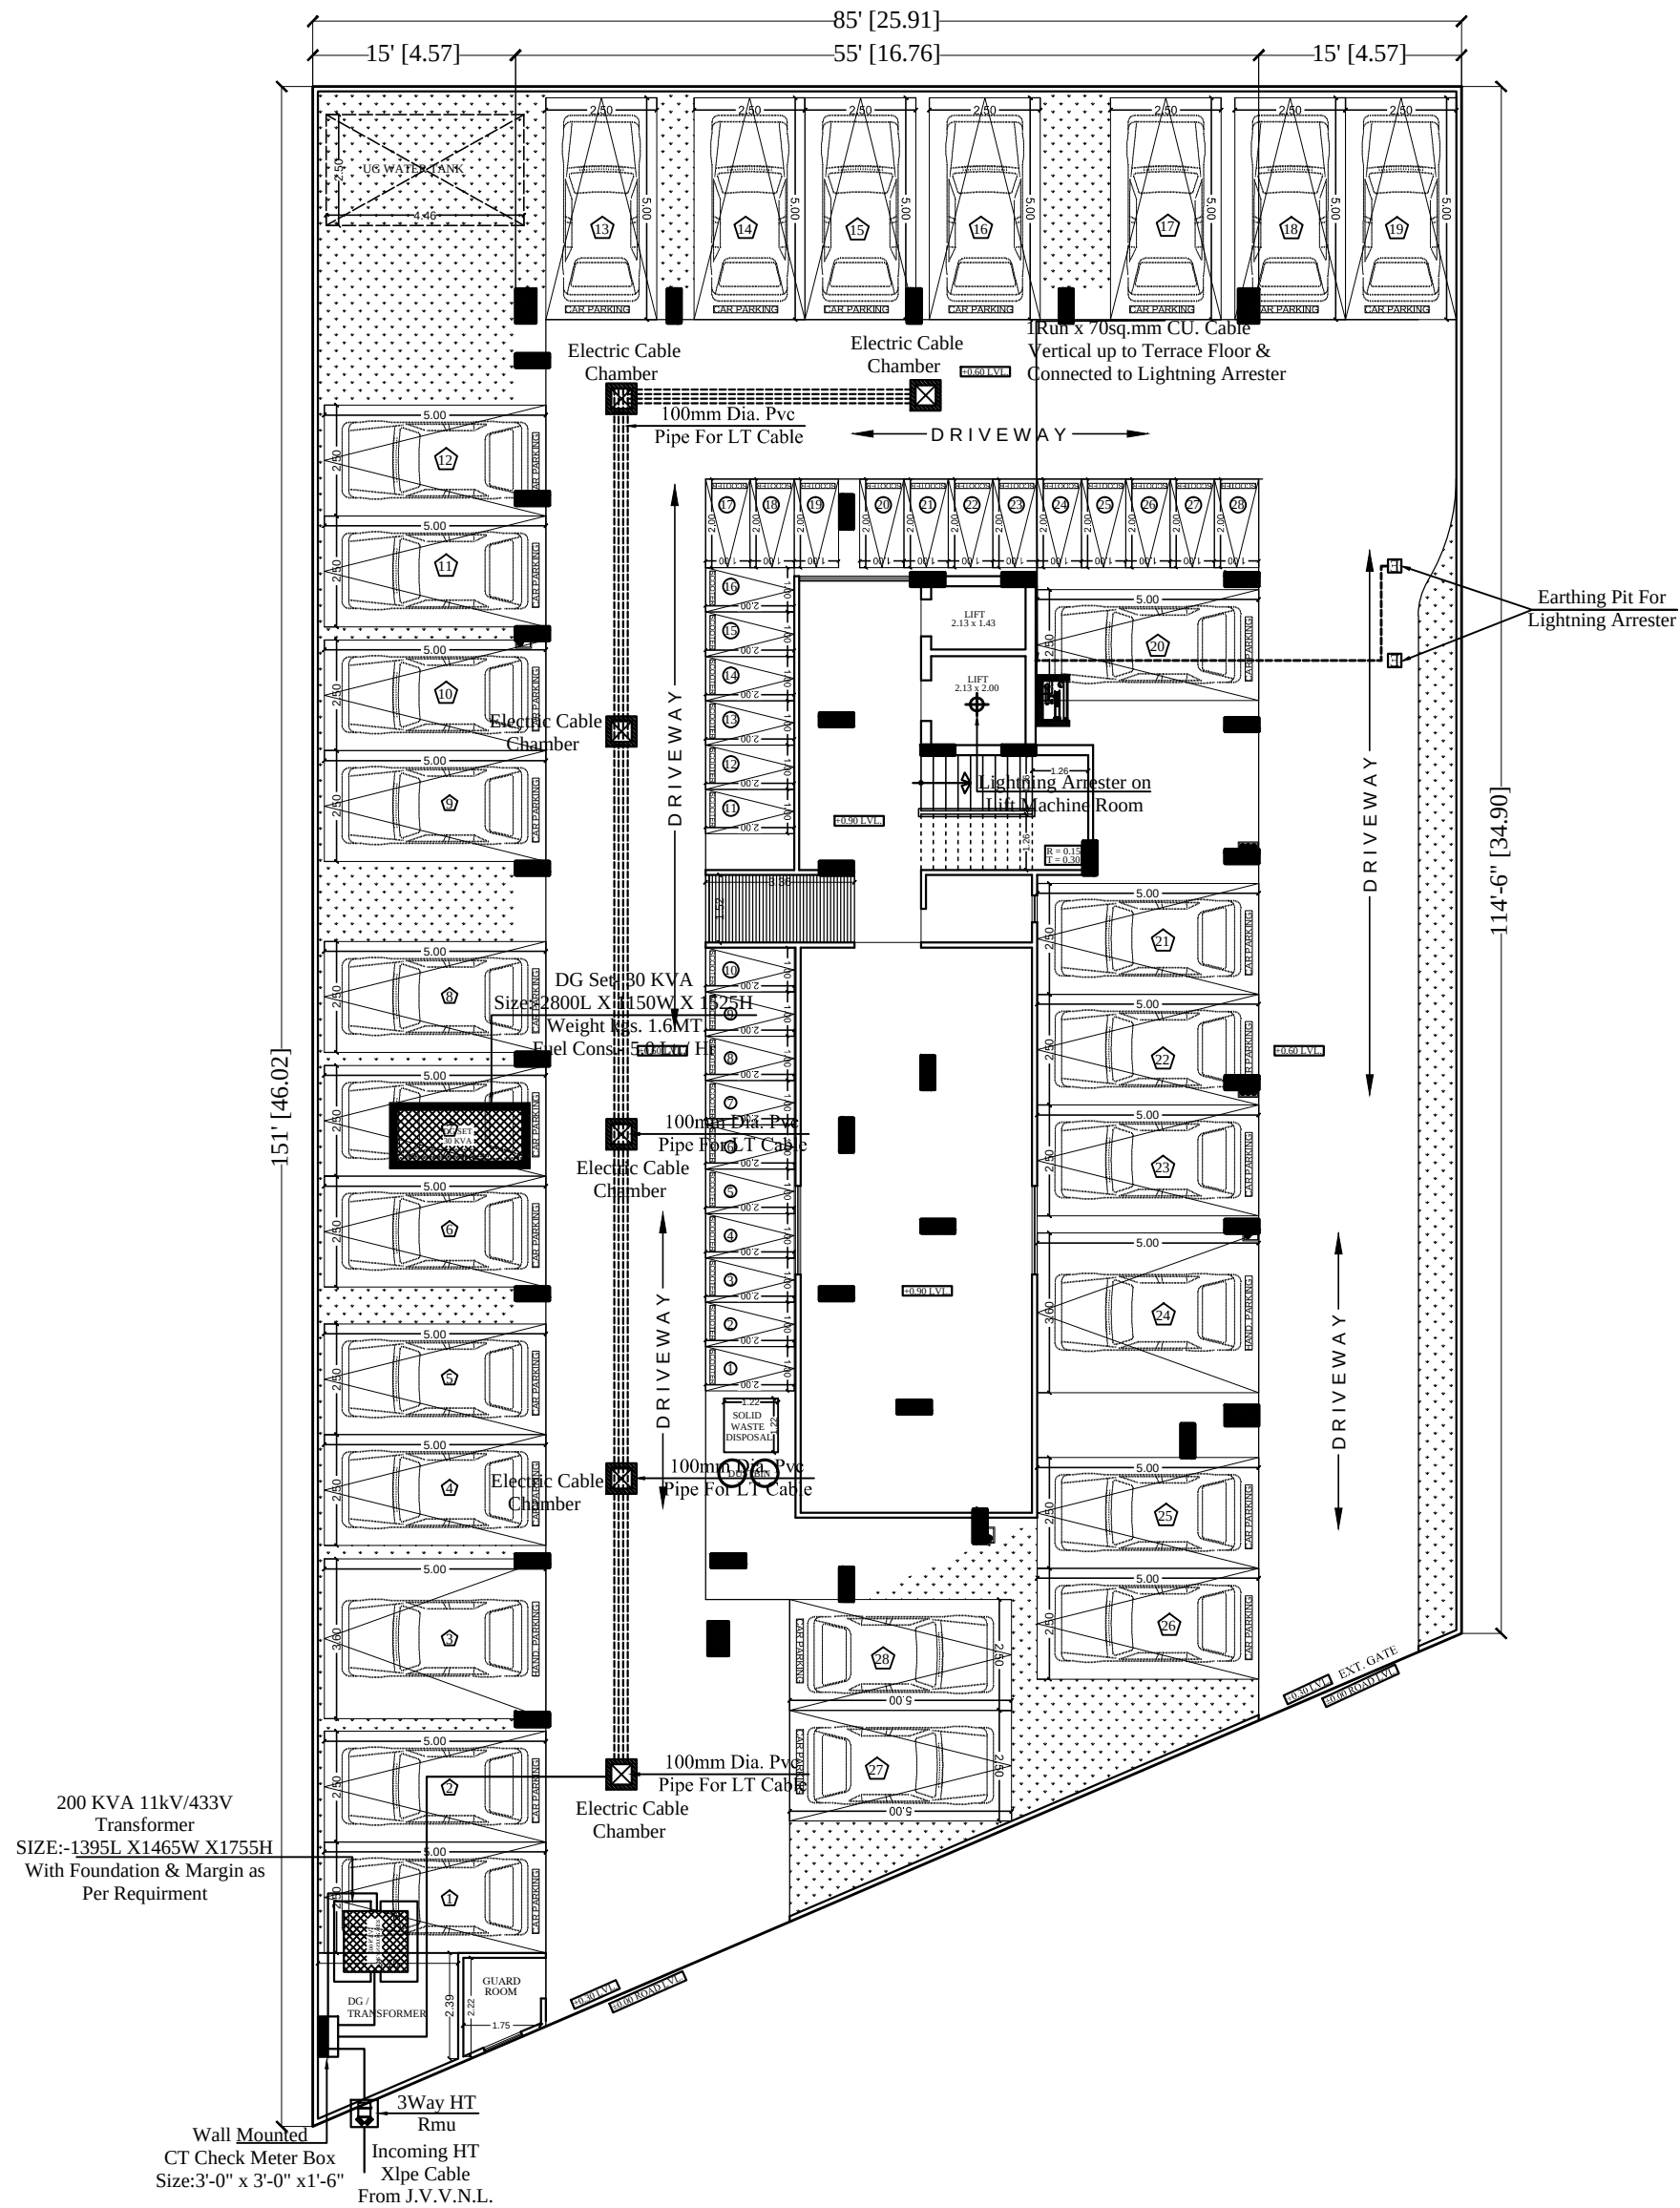

SIGN:-
SEAL:-
RAMESH KUMAWAT
M.E.P. CONSULTANT
B.E. CIVIL

SPACE CONSULTANT
PLOT-A-173, JAGDAMBA NAGAR, HEERAPURA
POWER HOWER, JAIPUR (RAJ) 302024


ARCHITECT :-
FRANK SQUARE
ARCHITECTURE | PLANNER | DESIGNER
C-49 VIDYA APARTMENT PARAS MARG,
BAPU NAGAR JAIPUR, (RAJ.)
Email-afranksquare@gmail.com
Mobile-9461302542

PROJECT :-
PROPOSED BUILDING AT G.H -30
KRISHNAM PEARL ESTATES,
VILLAGE :- RAM CHANDRAPURA,
TEH - SANGANER JAIPUR

DRAWING:
STILT FLOOR
ELECTRIC SUB STATION,
CABLE ROUTE &
LIGHTNING ARRESTER FOR
RERA SUBMISSION PLAN

DATE
SCALE:-
N.T.S.



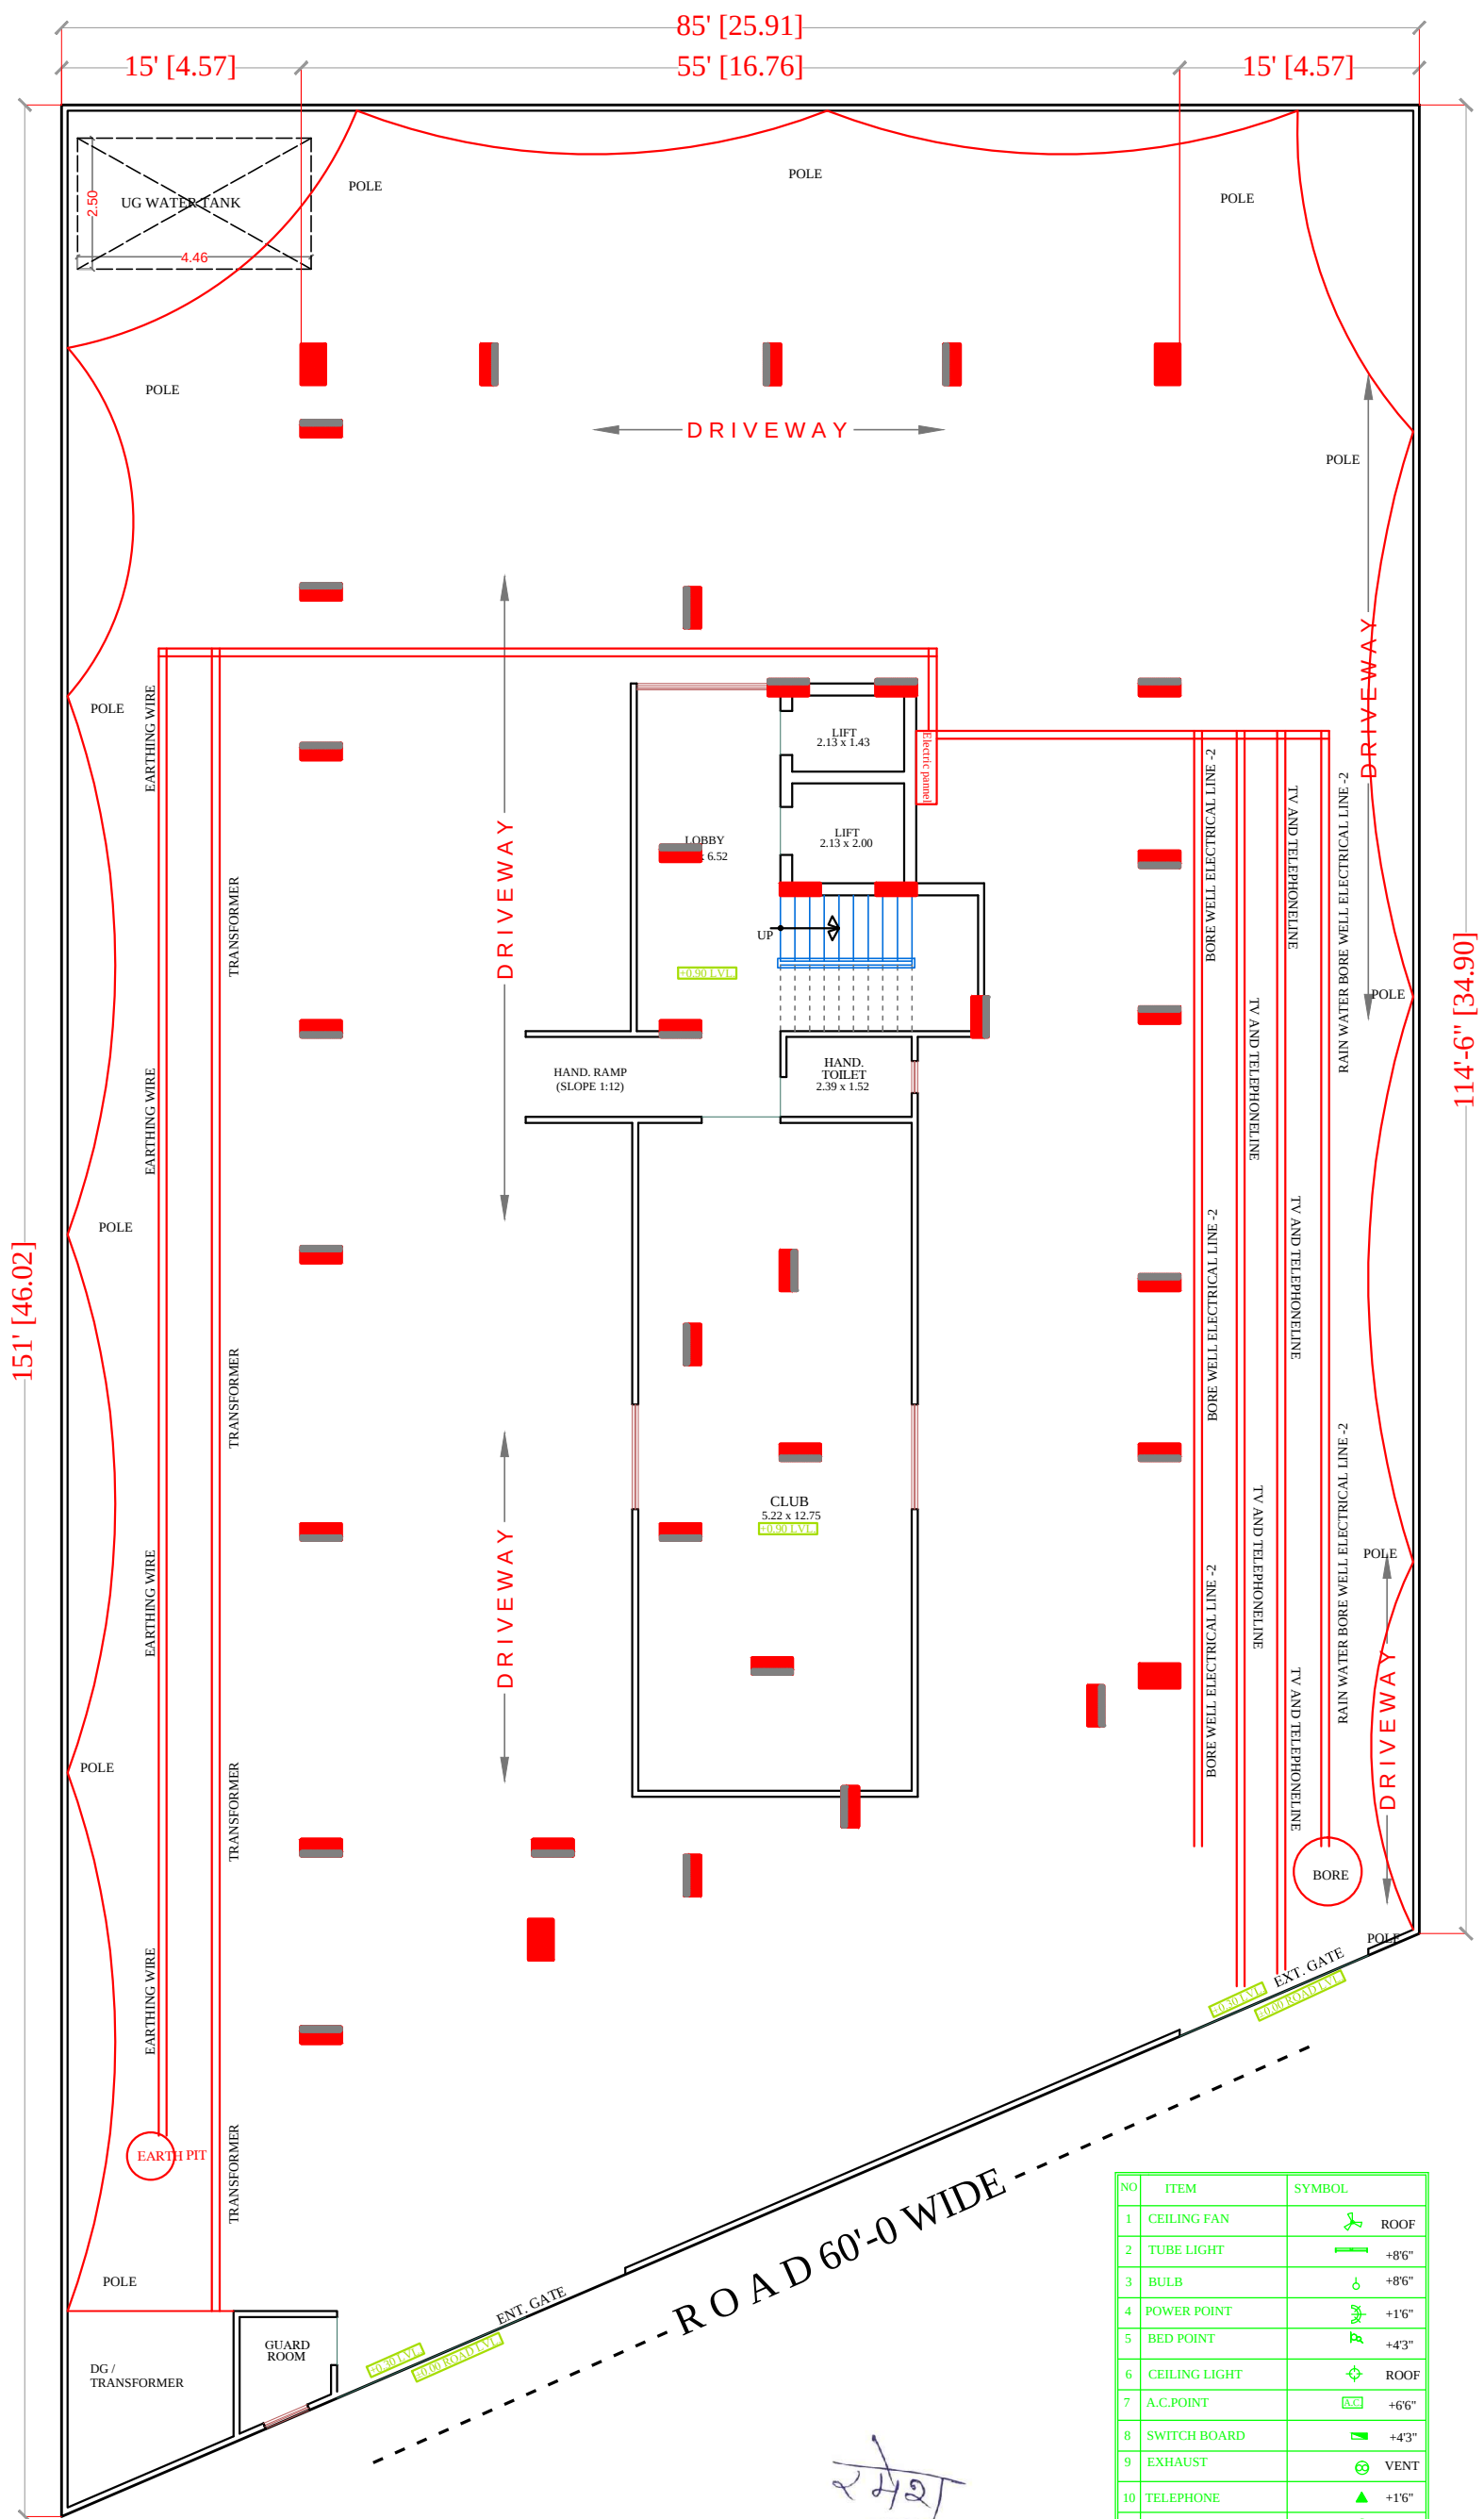

NO	ITEM	SYMBOL
1	CEILING FAN	ROOF
2	TUBE LIGHT	+8'6"
3	BULB	+8'6"
4	POWER POINT	+1'6"
5	BED POINT	+4'3"
6	CEILING LIGHT	ROOF
7	A.C.POINT	+6'6"
8	SWITCH BOARD	+4'3"
9	EXHAUST	VENT
10	TELEPHONE	+1'6"
11	GYSER	+6'0"
12	BELL POINT	+8'6"
13	T.V.	+1'6"
14	M.BOX	M.B.
15	M.C.B.	+6'6"
16	FANCY LIGHT	+8'6"
17	HANGING LIGHT	ROOF

STILT (PARKING) FLOOR PLAN

PROJECT TITLE :-
PROPOSED BUILDING AT G.H -30
KRISHNAM PEARL ESTATES,
VILLAGE :- RAM CHANDRAPURA,
TEH - SANGANER JAIPUR

DRAWING TITLE :-
SERVICE DRAWING SLD/DISTRIBUTION AFTER
LT PANEL, EARTHING LAYOUT,EXTERNAL
LIGHTING PLAN, TV & TELEPHONE
RISER,LIGHTING ARRESTR, & PIT LOCATION
COMMON AREA DG SET TRANSFORMER location

SPACE CONSULTANT PLOT-A-173, JAGDAMBA NAGAR, HEERAPURA POWER HOUSE, JAIPUR (RAJ) 302024	DRN. BY		DATE
	APPD. BY		REVISION
	SCALE	N.T.S	

