


NOTE:- THIS SLD HAS BEEN PREPARED AS PER CONCEPT STAGE DATA AVAILABLE WITH US. KINDLY CONTACT US FOR FINAL SLD & DETAILS BEFORE PLACING ORDER FOR FABRICATION. WE SHALL NOT BE RESPONSIBLE, IF THE PANELS ARE UNDER UTILISED OR OVER LOADED AT ANY STAGE.

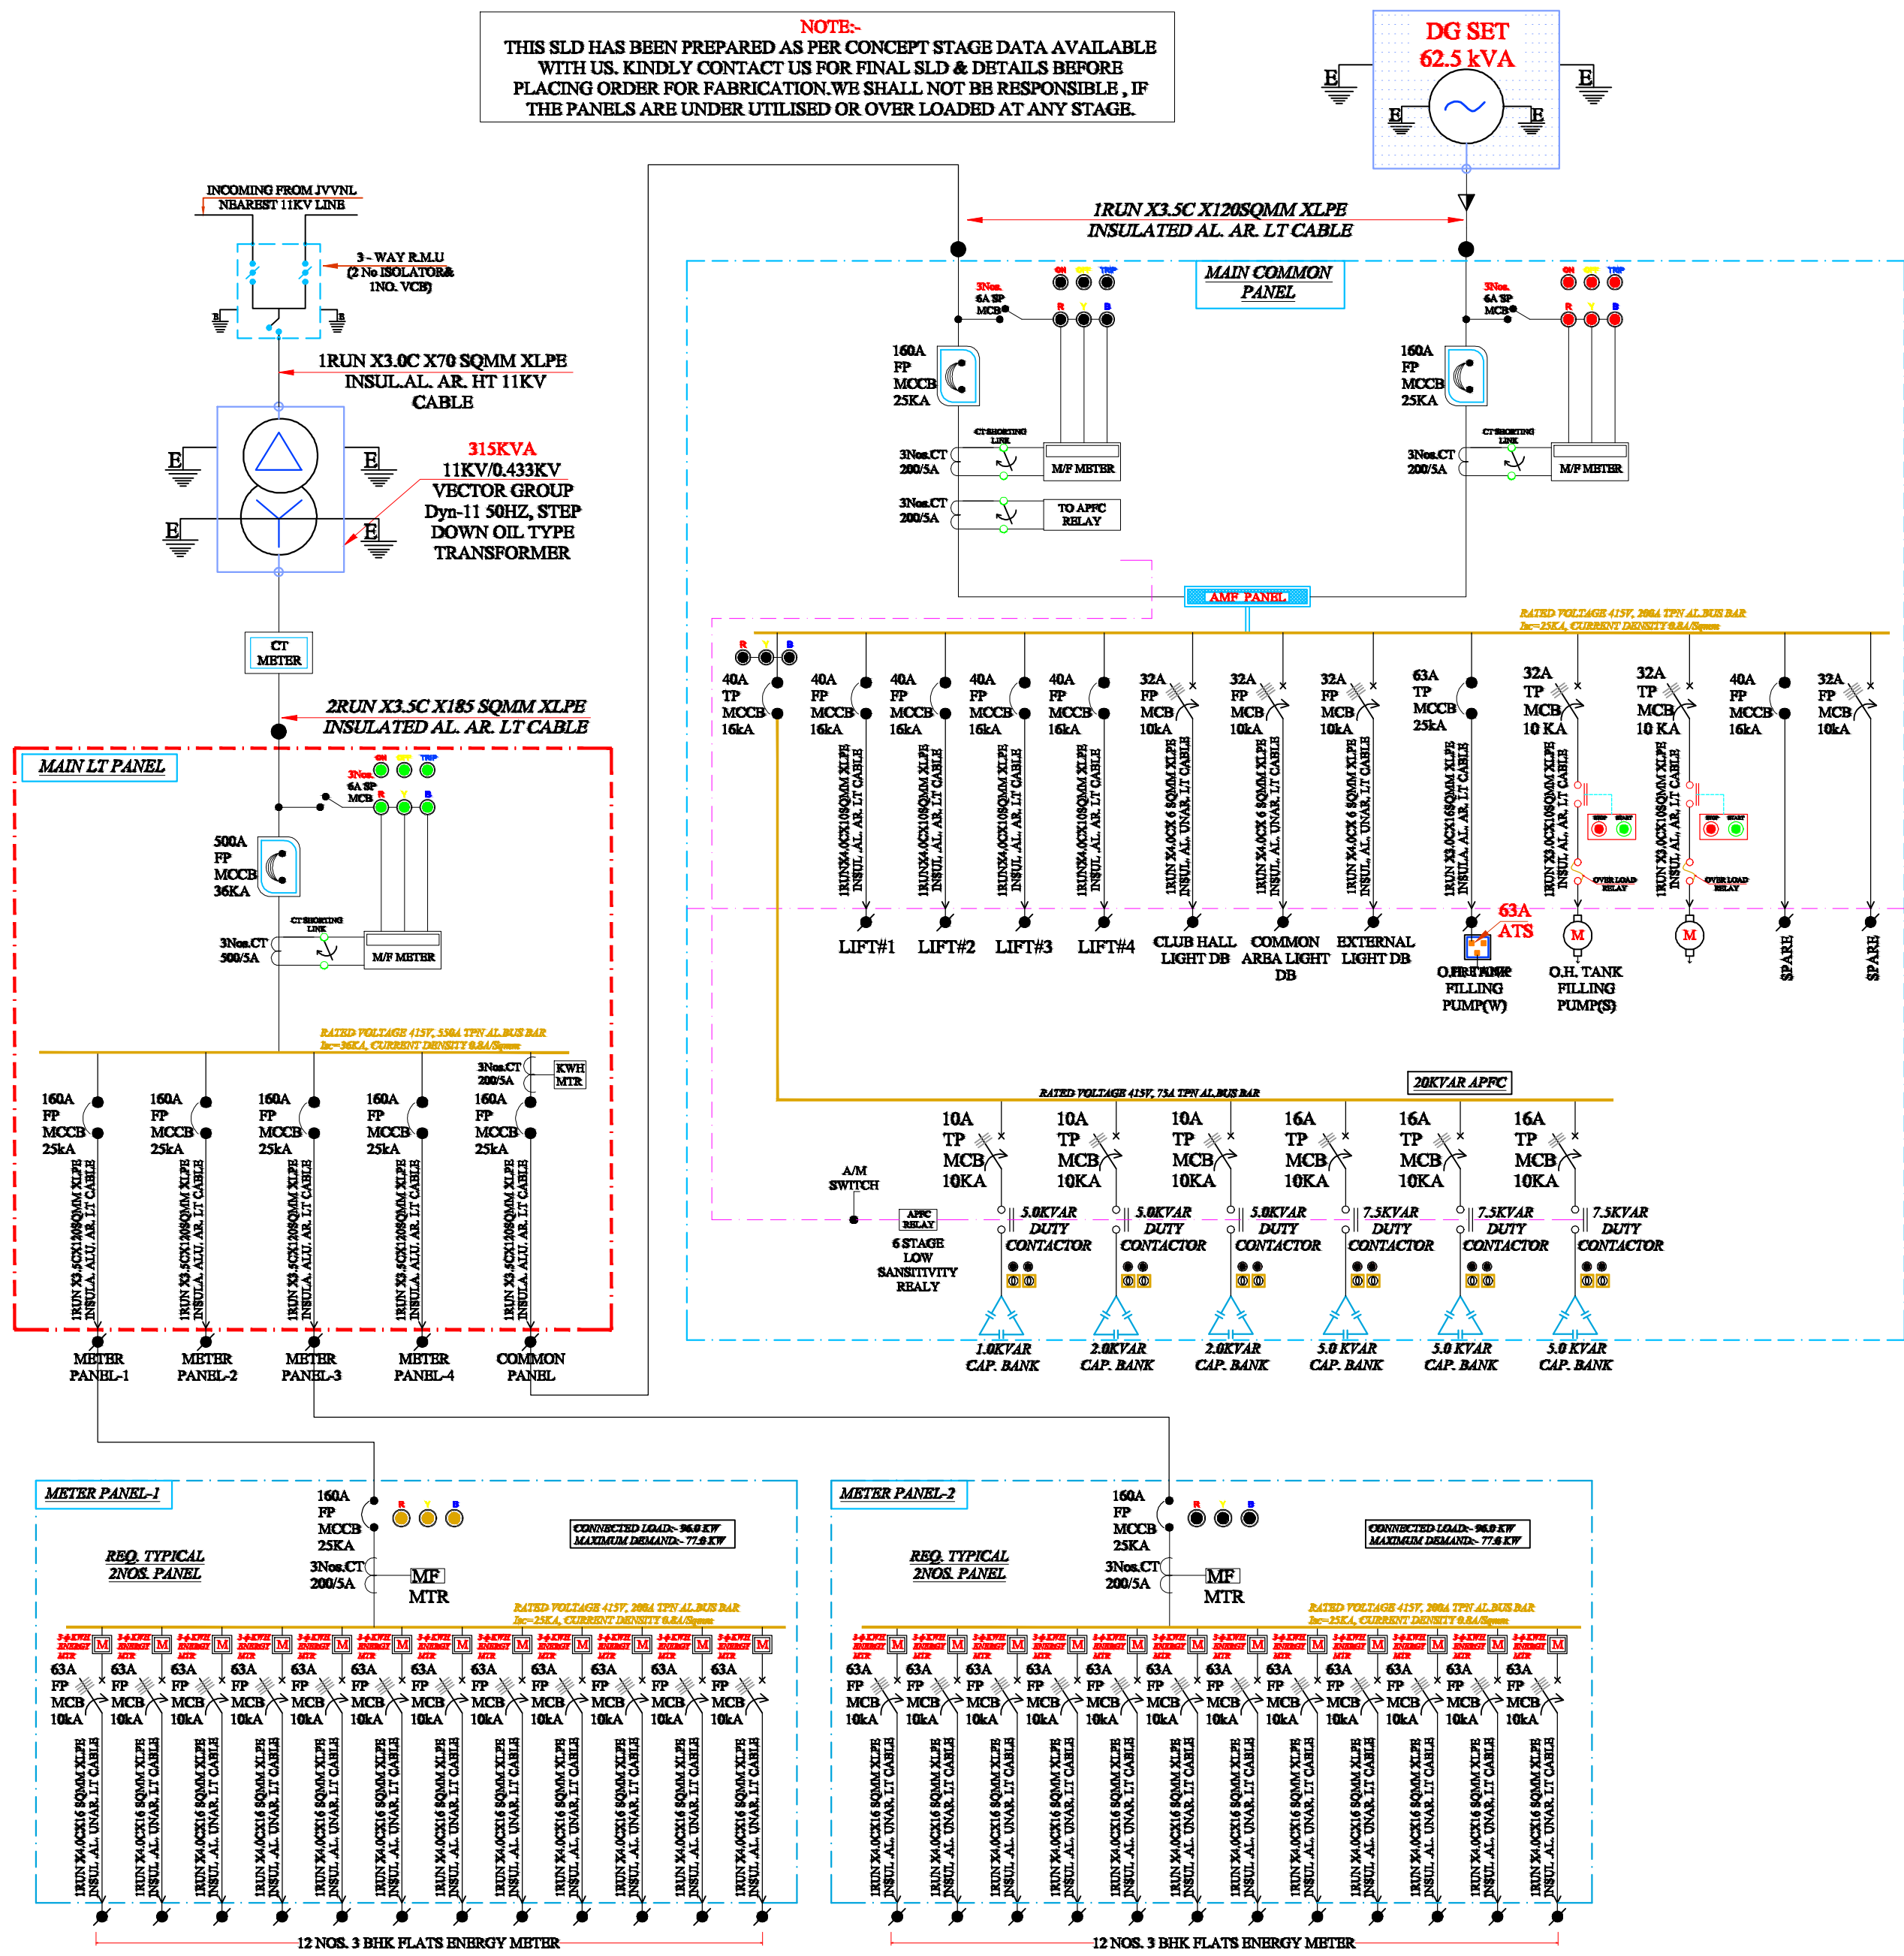

### WARNING

1. This drawing is the sole copyright of Architects **VISTAAR** and should be used for the purpose expressly issued.

### GENERAL NOTES

1. All dimensions are in feet and inches.
2. Do not scale this drawing follow written dimensions only.
3. This drawing should be read in conjunction with other architectural and structural drawings.
4. Any discrepancy in the drawing should be immediately brought to the notice of architect.

### PROJECT TITLE

PUJA PRIME II  
PLOT NO. B-107 & B-138  
VAISHALI ESTATE BLOCK-B SIRSI, JAIPUR

### DRAWING TITLE

ALL DISTRIBUTION PANEL  
SINGLE LINE DIAGRAM

### ARCHITECTS :

### VISTAAR ARCHITECTS & PLANNERS

Architects :: Interior Designers  
B-2/12, Chitrkoot scheme,  
main Gandhi Path, Opp mall of jaipur, Jaipur-21  
Email-Vistaararchitects.web@gmail.com  
PH.- 0141-4116461, 09001010366

### PATH :-

DRN.	DATE	REV.	NORTH
MANOJ KUMAWAT	12-6-2024		
SCALE	JOB NO.		
N.T.S			

For Shree Trupat Balaji Construction Company  
S 1723177  
Proprietor

SACHIN KUMAR  
B. TECH. (CIVIL)