

 
SHEET NO. 01

TITLE: -

TITLE: -
SUBMISSION DRAWING
WATER SUPPLY SCHEMATIC PLAN

DATE : 07-01-2025

SCALE: - 1:100



PROPOSED RESIDENTIAL
APARTMENT AT AURALLIS ,
A-22. SHANTI PATH ,TILAK
NAGAR JAIPUR ,UPASNA
INFRA LLP


ARCHITECT :
m|a architects pvt. Ltd.
Jaipur - Bangalore - Hyderabad
Plot No. -1, Greenwood, Lal Kothi Scheme,
Sahkar Marg Jaipur-302001
Tel : 91 141 4299999
email - studio@maarchitects.in,
web - www.maarchitects.in

OWNER

ARCHITECTS



WATER SUPPLY SCHEMATIC DIAGRAM

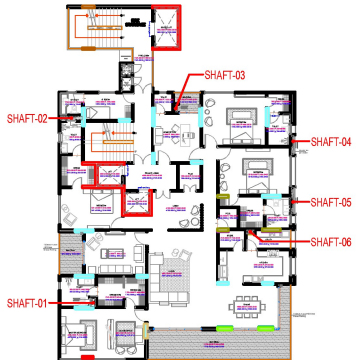

LEGENDS	
S NO.	DESCRIPTION
①	DWS DOMESTIC WATER SUPPLY BELOW FLOOR
②	DWS DOMESTIC WATER SUPPLY TOP THREE FLOOR
③	ALL TERRACE RING(GI PIPE)
④	ALL WATER SUPPLY VERTICAL PIPE
⑤	ARY AIR RELEASE VALVE
TOP THREE FLOORS WATER SUPPLY SYSTEM BY PUMPING	
BELOW FLOORS WATER SUPPLY SYSTEM BY GRAVITY	


SHEET NO. 01

TITLE: -

TITLE: -
SUBMISSION DRAWING
BASEMENT WATER SUPPLY PLAN

DATE : 07-01-2025

SCALE: - 1:100

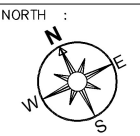

PROPOSED RESIDENTIAL
APARTMENT AT AURALLIS ,
A-22. SHANTI PATH ,TILAK
NAGAR JAIPUR ,UPASNA
INFRA LLP

ARCHITECT :

m | a | r | c | h | i | t | e | c | t | s pvt. ltd.
Jaipur - Bangalore - Hyderabad
Plot No. -1, Greenwoods, Lal Kothi Scheme,
Sahkar Marg Jaipur-302001
Tel : 91 141 4299999
email - studio@maarchitects.in,
web - www.maarchitects.in

OWNER

ARCHITECTS

C110

C109


33.53

8.80

8.80

SEWERAGE SUMP WITH 2 NOS. SUBMERSIBLE PUMP
(1 WORKING+1 STAND BY)
SIZE (1500x1500x2000)
HEAVY DUTY DOUBLE SEAL MANHOLE COVER WITH
1000mm RISE TO GROUND
FLOOR SEWER MANHOLE

1000mm RISE
FLOOR SEWER MANHOLE

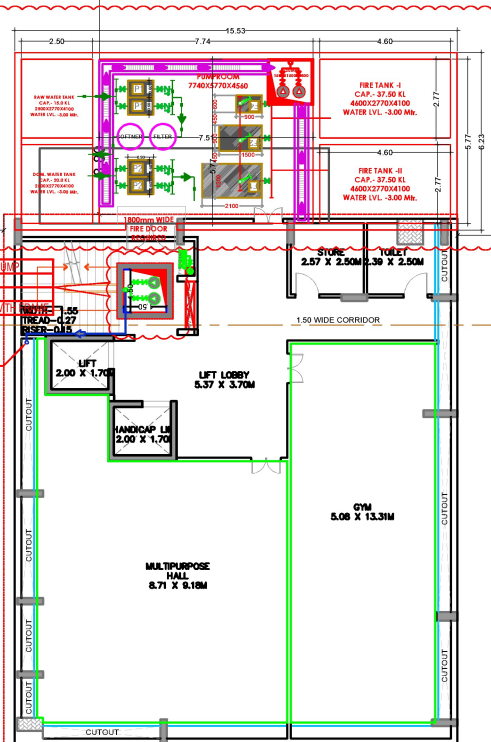



PROPOSED UNDERGROUND
WATER TANK
FIRE WATER TANK - 75 KL
RAW WATER TANK - 20 KL
DOM. WATER TANK - 20 KL

Multipurpose Carpet	936.83 sq.ft
Gym Carpet	726.99 sq.ft

12.19

18M WIDE ROAD

BASEMENT

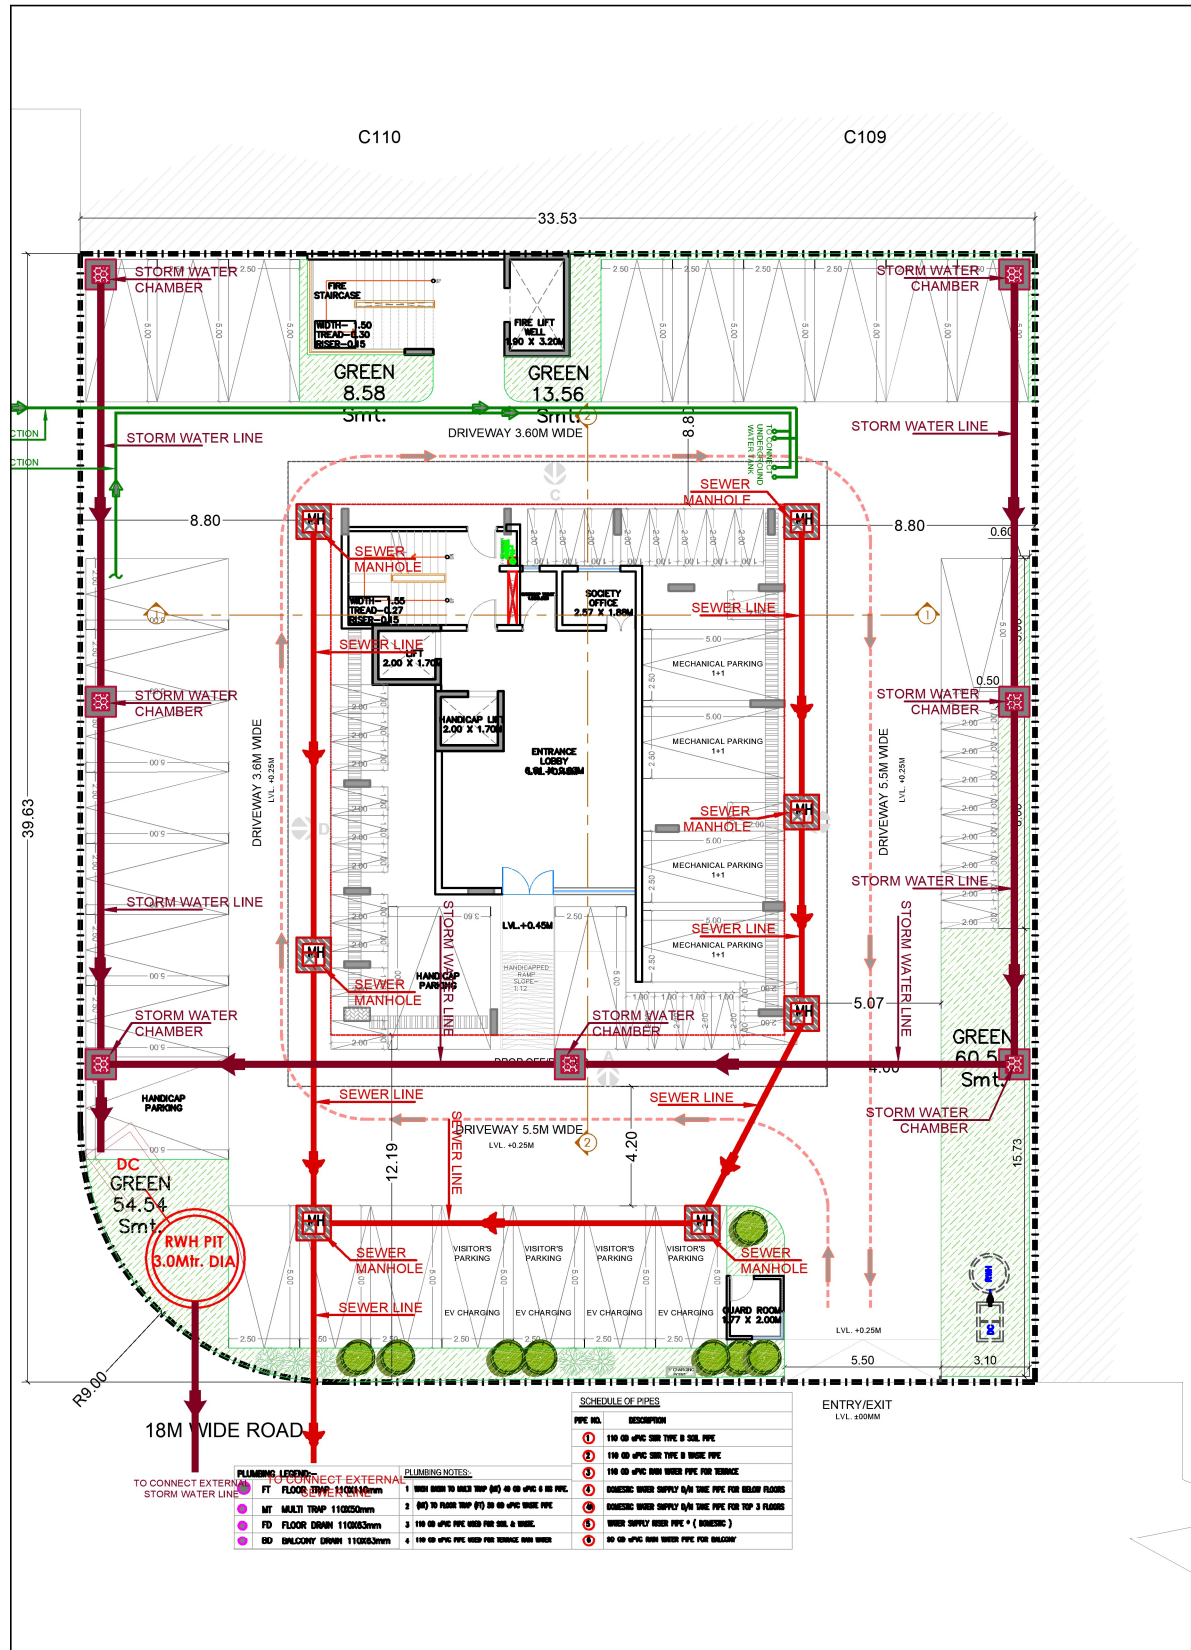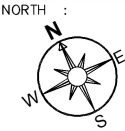

STILT FLOOR PLAN

TITLE: -

KOMANATH BEHARA
ARCHITECTS

TITLE: -
SUBMISSION DRAWING
TYPICAL TO 10TH WATER
SUPPLY PLAN

DATE : 07-01-2025

SCALE: - 1:100



PROPOSED RESIDENTIAL
APARTMENT AT AURALLIS ,
A-22. SHANTI PATH ,TILAK
NAGAR JAIPUR ,UPASNA
INFRA LLP

ARCHITECT :

m | a | r | c | h | i | t | e | c | t | s pvt. ltd.

Jaipur - Bangalore - Hyderabad
Plot No. -1, Greenwoods, Lal Kothi Scheme,
Sahkar Marg Jaipur-302001
Tel : 91 141 4299999
email - studio@maarchitects.in,
web - www.maarchitects.in

OWNER

ARCHITECTS

C110

C109

33.53

8.80

8.80


8.80

12.19

18M WIDE ROAD

(TYPICAL) GROUND
TO 10TH FLOOR PLAN

CARPET AREA (excluding balcony, utility, internal staircase, both lifts, private lobby)	3336.89sq.ft
BALCONY/ UTILITY	520.86 sq.ft
B.U.A	4007.18 sq.ft
S.B.U.A	5610.05 sq.ft

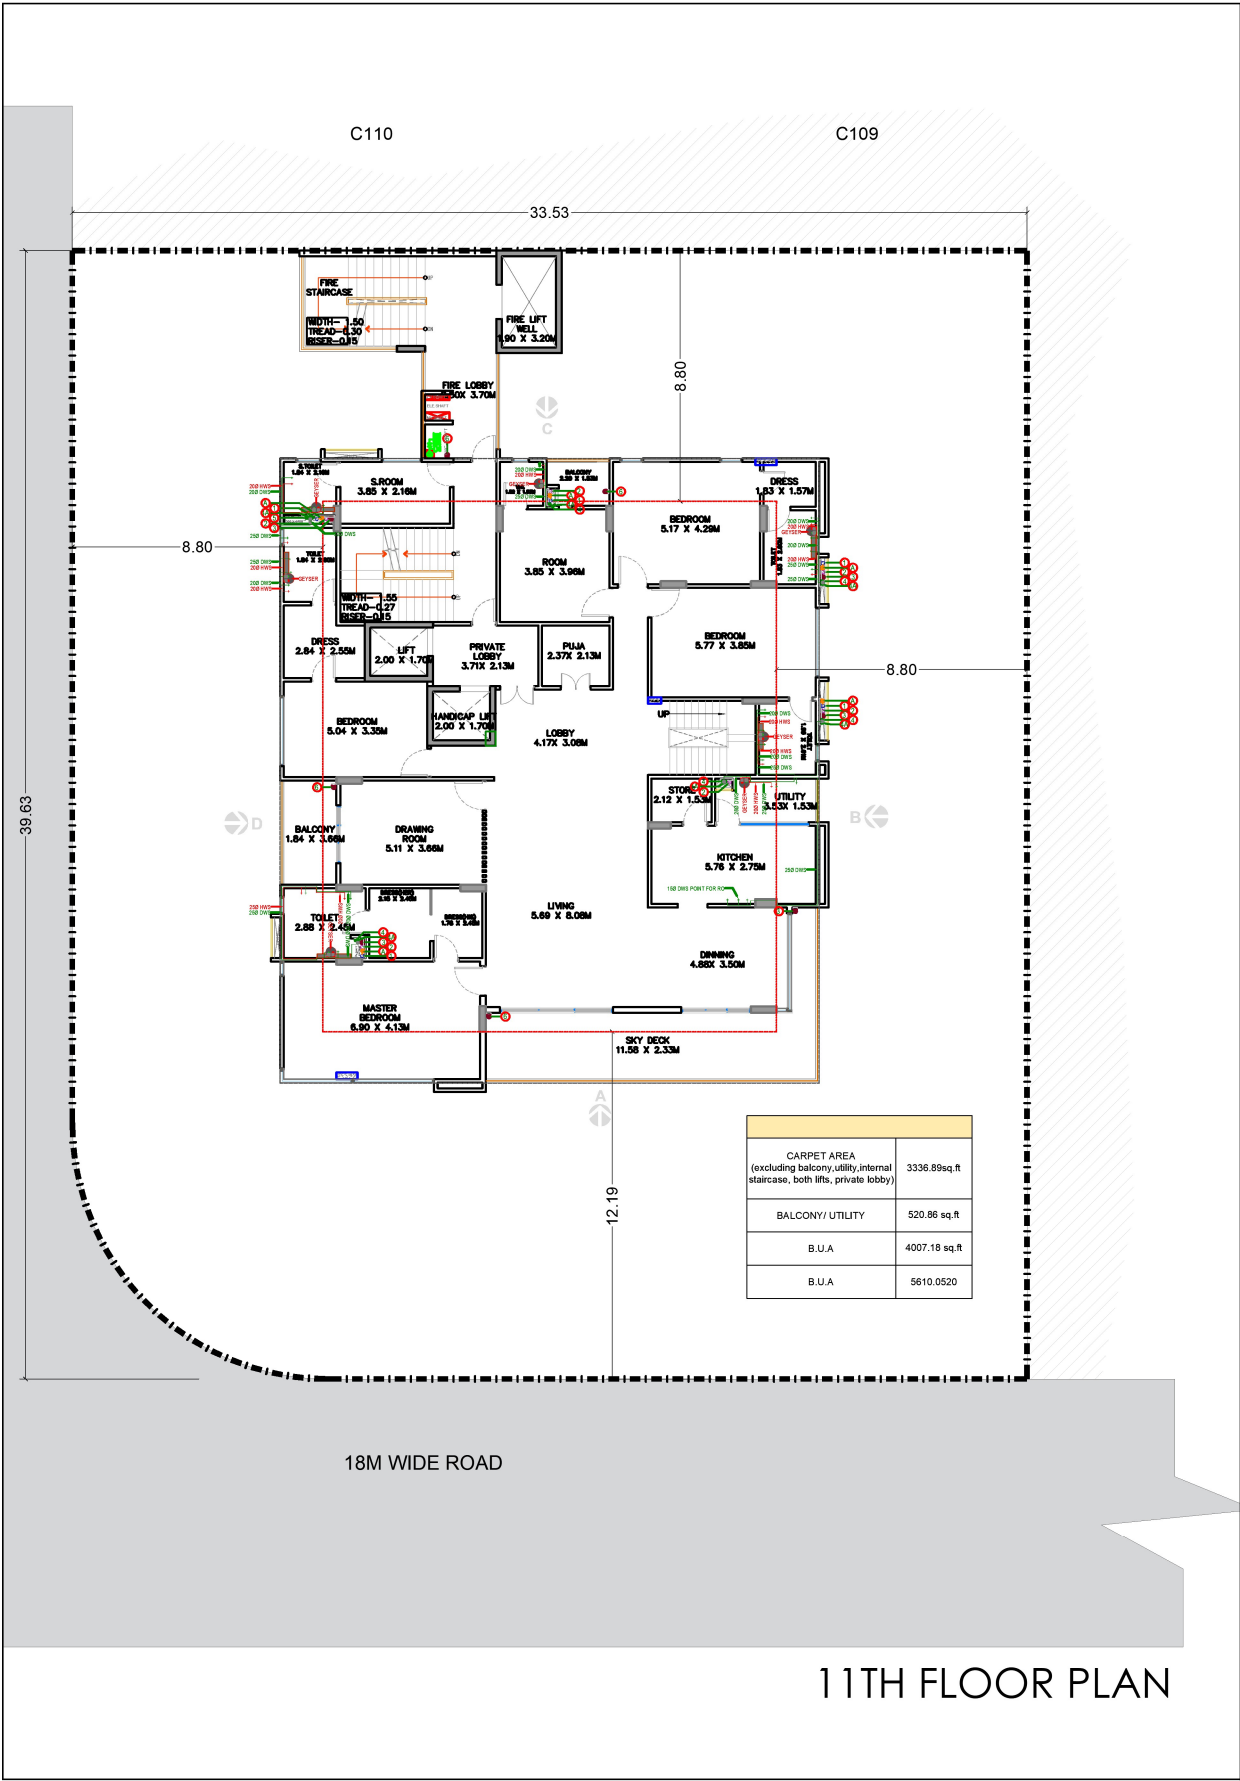

KOMANATH BEHARA
ARCHITECTS

SUBMISSION DRAWING
11TH FLOOR WATER SUPPLY
PLAN

DATE : 07-01-2025

SCALE: - 1:100

NORTH :


PROPOSED RESIDENTIAL
APARTMENT AT AURALLIS ,
A-22. SHANTI PATH ,TILAK
NAGAR JAIPUR ,UPASNA
INFRA LLP

ARCHITECT :

m | a | r | c | h | i | t | e | c | t | s pvt. ltd.

Jaipur - Bangalore - Hyderabad
Plot No. -1, Greenwoods, Lal Kothi Scheme,
Sahkar Marg Jaipur-302001
Tel : 91 141 4299999
email - studio@maarchitects.in,
web - www.maarchitects.in

11TH FLOOR PLAN

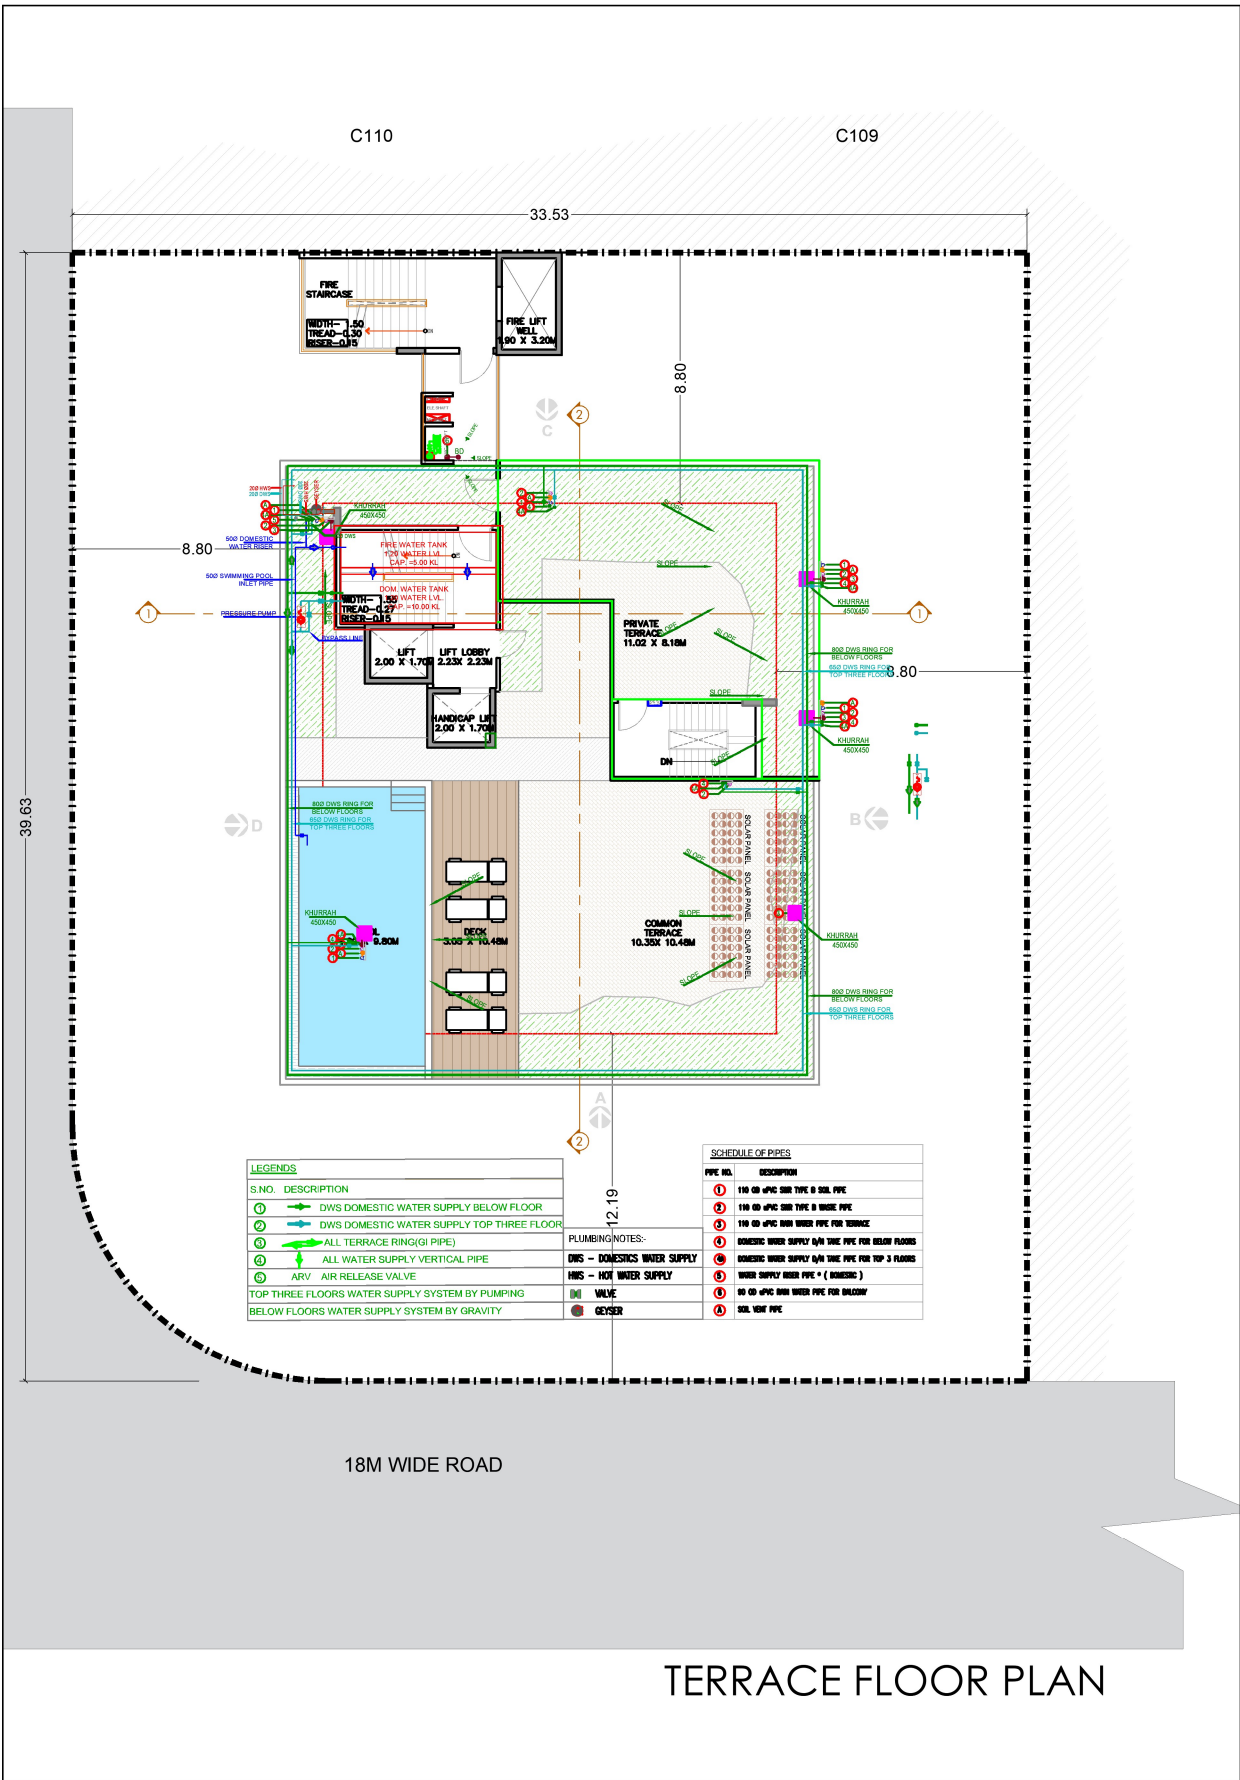

SUBMISSION DRAWING
TERRACE FLOOR WATER
SUPPLY PLAN

DATE : 07-01-2025

SCALE: - 1:100



PROPOSED RESIDENTIAL
APARTMENT AT AURALLIS ,
A-22. SHANTI PATH ,TILAK
NAGAR JAIPUR ,UPASNA
INFRA LLP

ARCHITECT :
m | a | r | c | h | i | t | e | c | t | s pvt. ltd.
Jaipur - Bangalore - Hyderabad
Plot No. -1, Greenwoods, Lal Kothi Scheme,
Sahkar Marg Jaipur-302001
Tel : 91 141 4299999
email - studio@maarchitects.in,
web - www.maarchitects.in

OWNER

ARCHITECTS

TERRACE FLOOR PLAN