




LEGEND	
SR.NO	DESCRIPTION
DWS	DOMESTIC WATER SUPPLY
WWP	WASTE WATER PIPE
SWP	SOIL WATER PIPE
RWP	RAIN WATER PIPE
B.T	BOTTLE TRAP
F.T.	FLOOR TRAP

Dr. Ravi Kant Pareek
M. Tech (Civil)
Ph.d (Environment)

PROJECT TITLE	CONSULTANT	DRAWING TITTLE	CHECKED BY:	DRAWN BY:	NORTH :-	ARCHITECT
PROPOSED RESIDENTIAL SCHEME "RAVI KIRAN VIHAR" AT VILLAGE-MOHANPURA, TEH.-SANGANER, JAIPUR UNDER KHASRA NO - 202, 203/577	AMP INFRA SERVICES VILLA NO 16, SHUBHASIS GEETA JAISINGHPURA, BHANKROTA & CHIMANPURA, JAIPUR 302026 EMAIL ID- ampinfrajpr@gmail.com	GROUND FLOOR DRAINAGE LAYOUT	NARESH	SUFIAN KHAN		AIM ENGINEERS & ARCHITECTS #105 FI. FL., SHIV GYAN AVENUE PLOT NO. -2 YUDHISHTER MARG, OPP. YOJNA BHAWAN, C- SCHEME JAIPUR.
			DATE 19/10/2023	DWG. NO.		

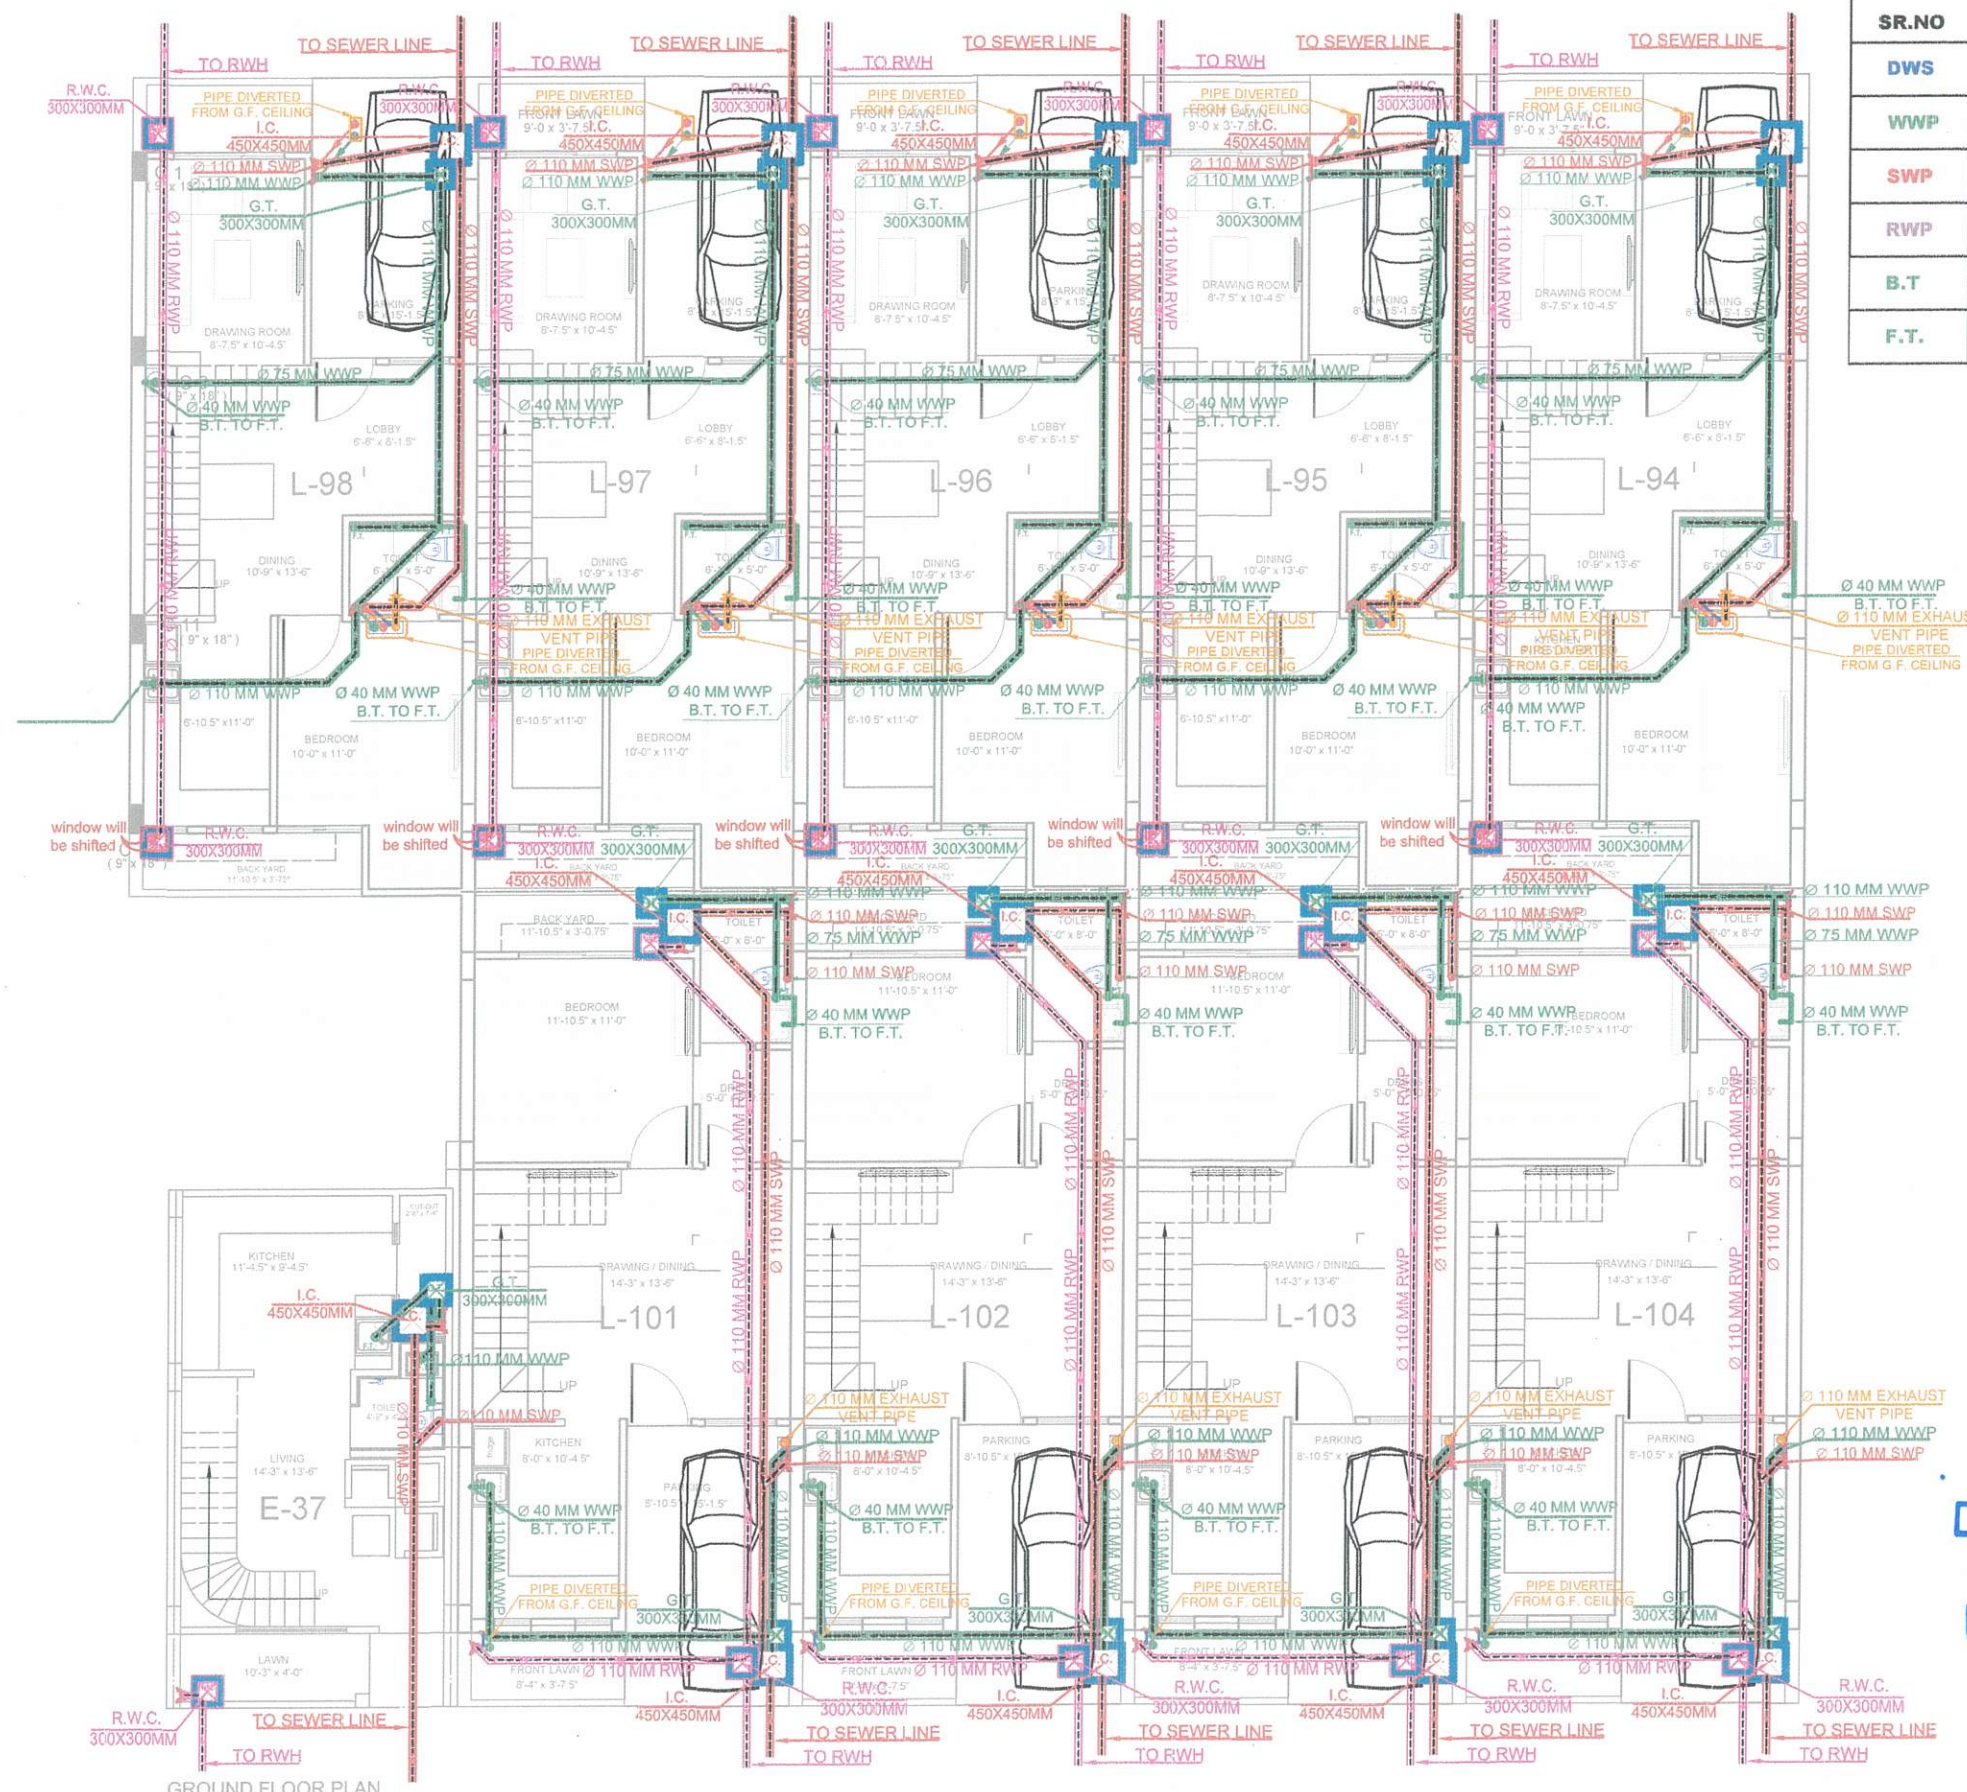

LEGEND	
SR.NO	DESCRIPTION
DWS	DOMESTIC WATER SUPPLY
WWP	WASTE WATER PIPE
SWP	SOIL WATER PIPE
RWP	RAIN WATER PIPE
B.T	BOTTLE TRAP
F.T.	FLOOR TRAP

Signature

Dr. Ravi Kant Pareek
M. Tech (Civil)
Ph.d (Environment)

PROJECT TITLE	CONSULTANT	DRAWING TITTLE	CHECKED BY:	DRAWN BY:	NORTH :-	ARCHITECT
PROPOSED RESIDENTIAL SCHEME "RAVI KIRAN VIHAR" AT VILLAGE-MOHANPURA, TEH.- SANGANER, JAIPUR UNDER KHASRA NO - 202, 203/577	AMP INFRA SERVICES VILLA NO 16, SHUBHASIS GEETA JAISINGHPURA, BHANKROTA & CHIMANPURA, JAIPUR 302026 EMAIL ID- ampinfrajpr@gmail.com	FIRST FLOOR DRAINAGE LAYOUT	NARESH	SUFIAN KHAN		AIM ENGINEERS & ARCHITECTS #105 FI. FL., SHIV GYAN AVENUE PLOT NO. -2 YUDHISHTER MARG, OPP. YOJNA BHAWAN, C- SCHEME JAIPUR.
			DATE 17/10/2023	DWG. NO.		