


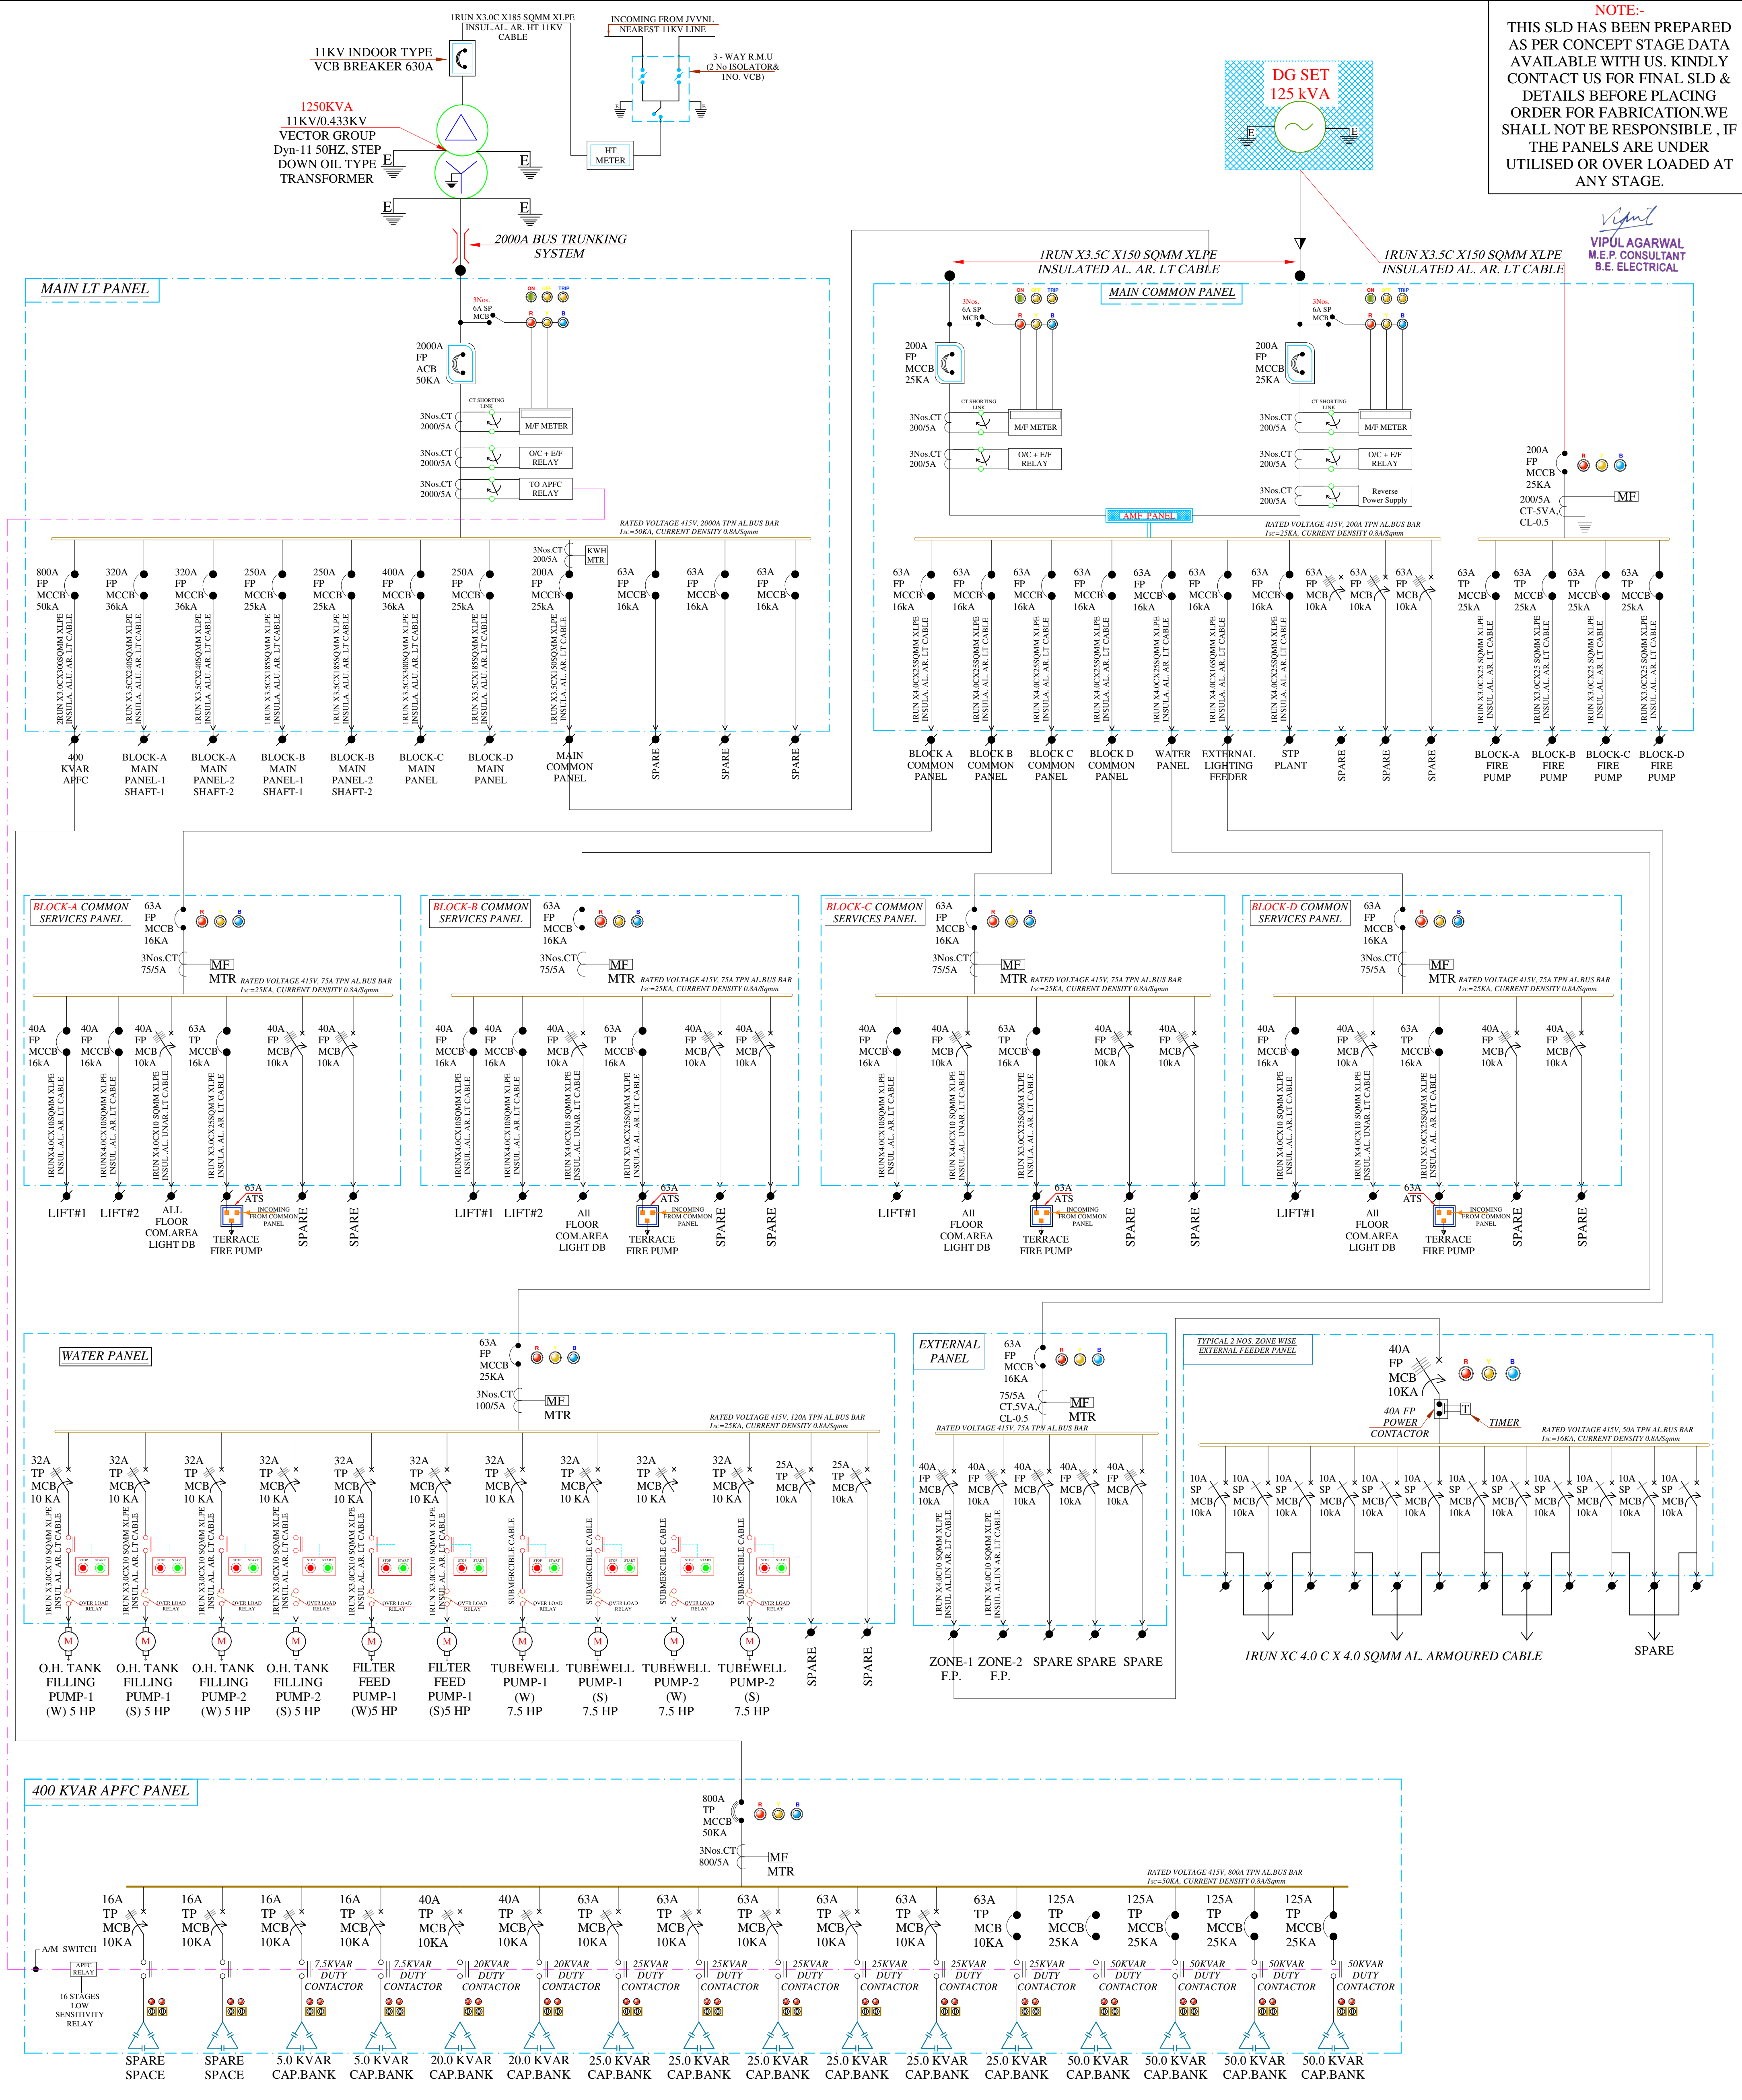


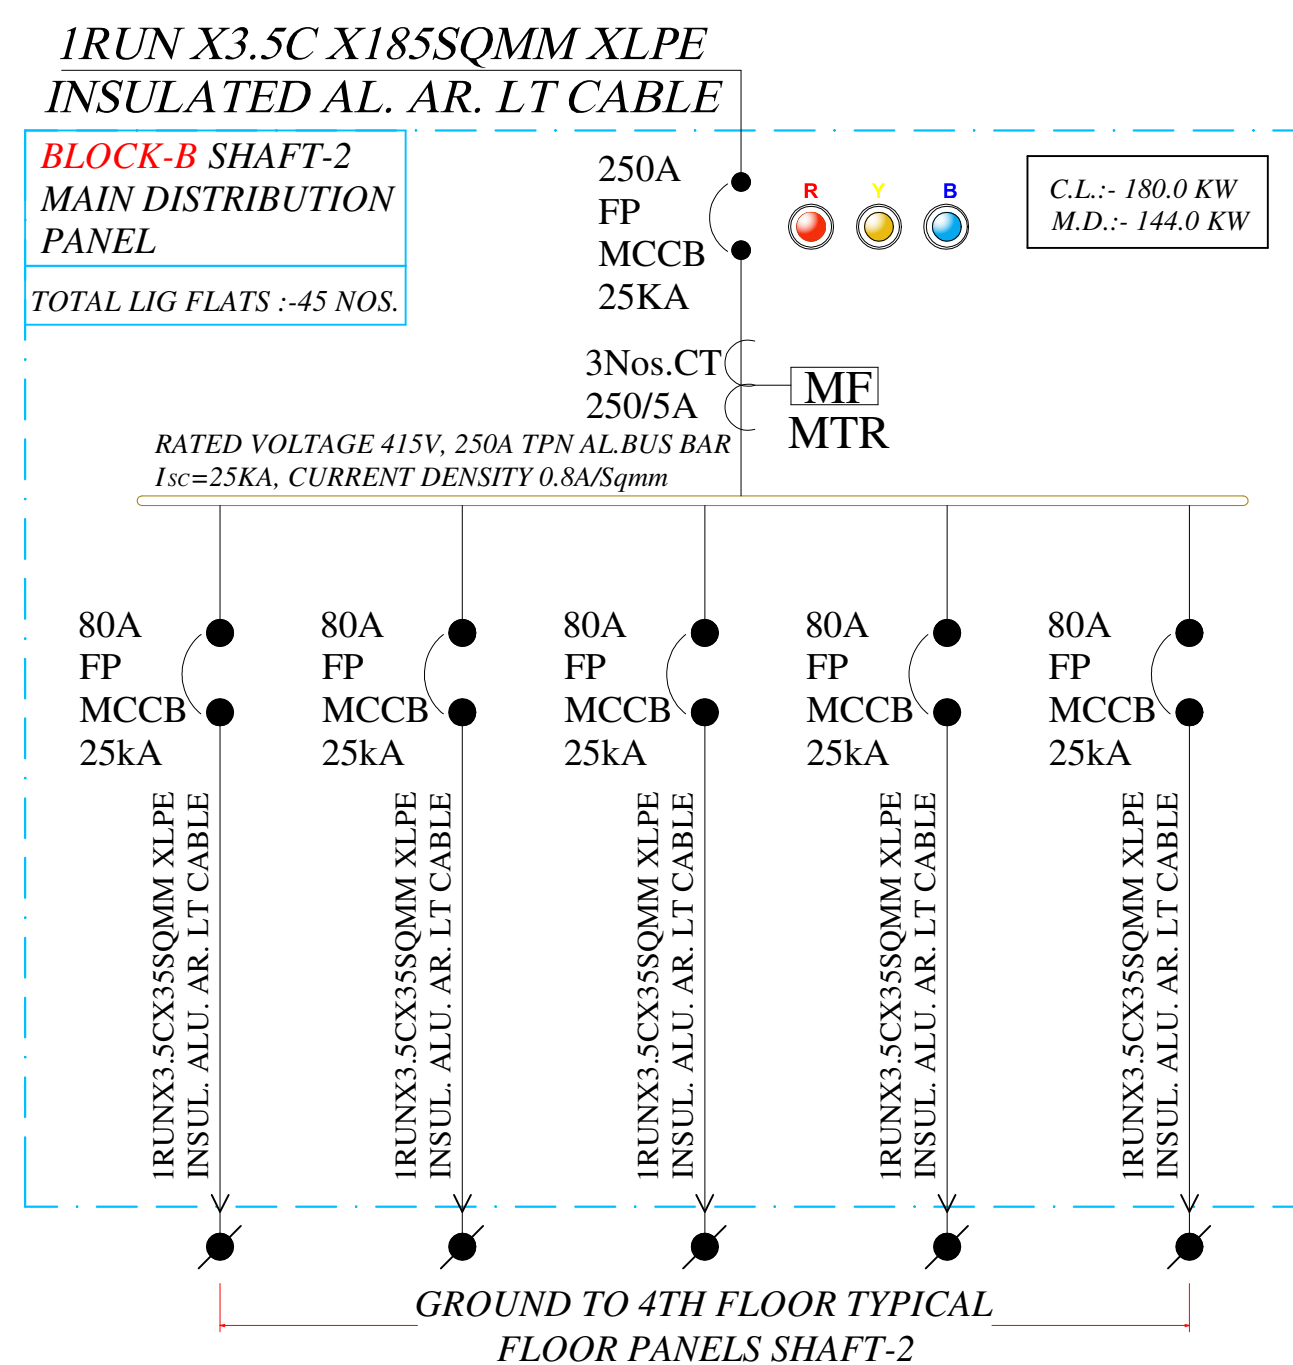





CLIENT :	PROJECT:-	ARCHITECTS :	NAME OF DRAWING:	NORTH:
	PROPOSED GSITE PLAN SHOWING RESIDENTIAL PLOT FOR CHEIF MINISTER JAN AWAS YOJANA SITUATED AT KH. NO. 1296,1306 AT VILLAGE MAKARWALI ,AJMER	GRAPHITE DESIGN STUDIO ARCHITECTS, INTERIOR DESIGNERS, PLANNERS 68, Janak Puri -1st, Inlilwala phatak, Opp Jain Mandir, Jaipur CONTACT NO. +91-9928334414, 0141-2589414 email: studiosgraphite@gmail.com Website: www.graphitedesignstudio.com	ALL DISTRIBUTION PANEL SINGLE LINE DIAGRAM	
			DRN BY:	PROJECT NO. :
			APPD. BY:	DATE: 24-02-2022
				SCALE :
				REV NO. : R-01
				DRAWING NO. :
			VICKY YADAV	SERVICES CONSULTANT: VIPUL CONSULTING. F 9 / 440 , Keshav Marg Chitrakut Scheme Jaipur PH:91-0-93146-10438, 0141-2440946 Mail:vipul8599@yahoo.com
			VIPUL AGARWAL	

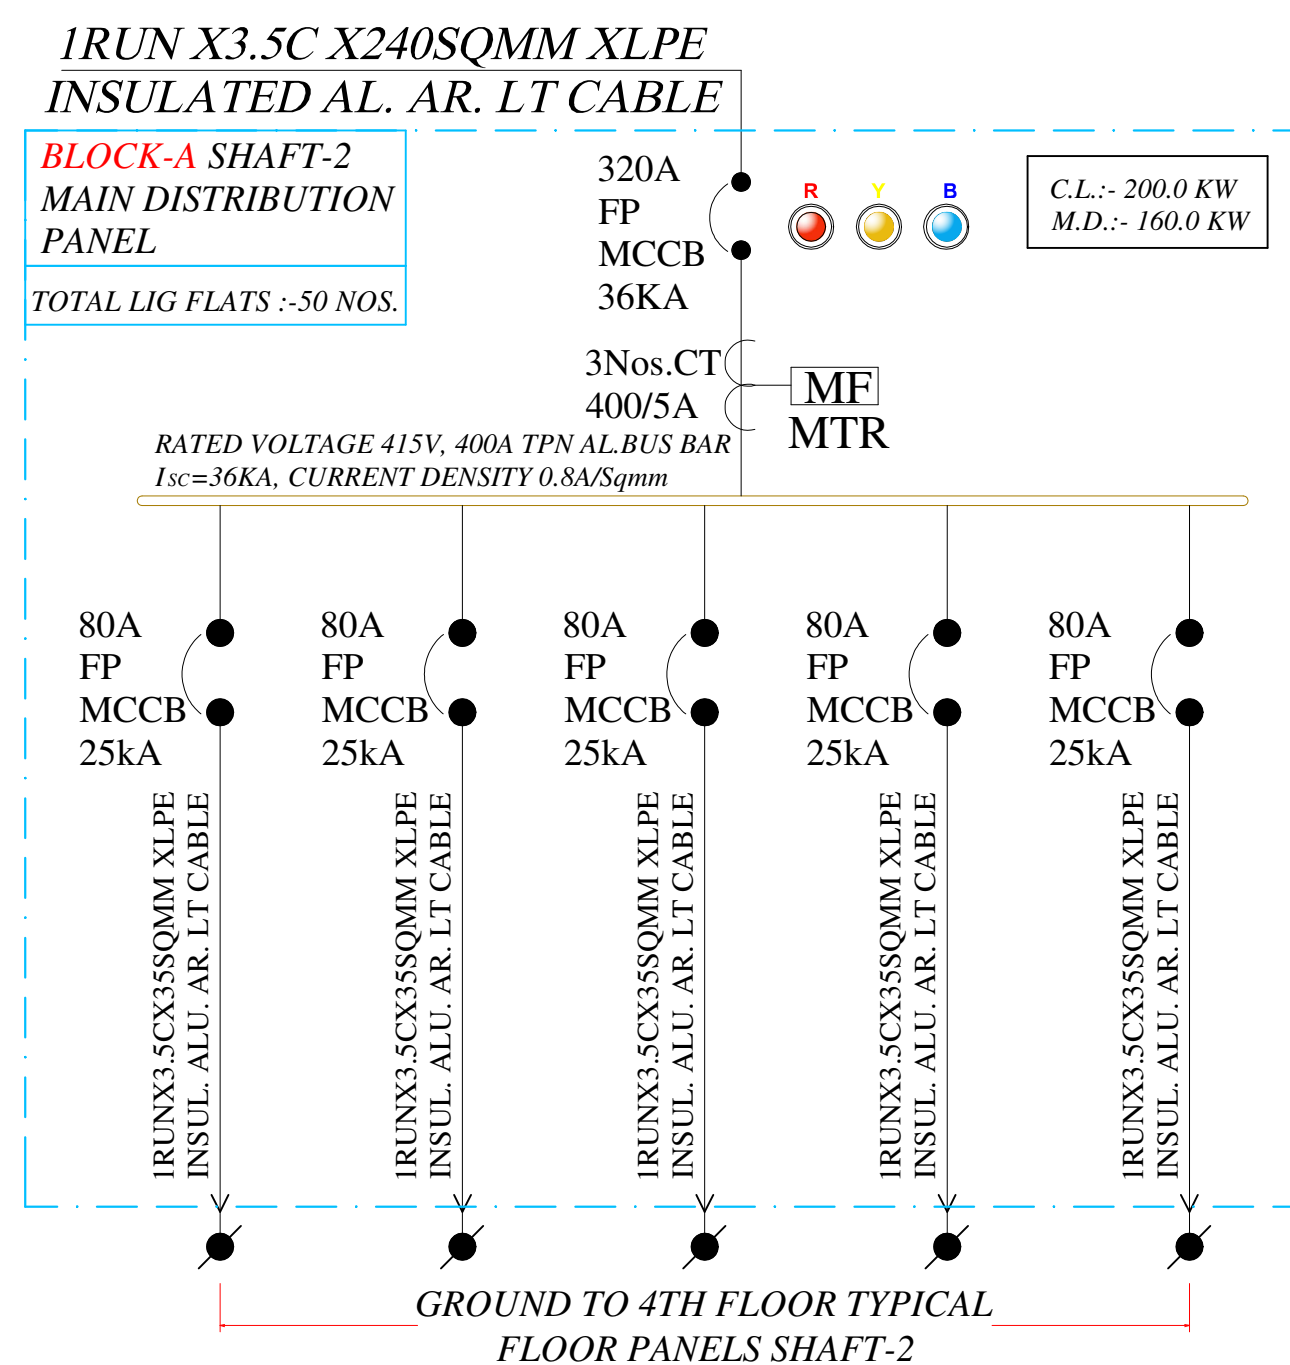

Vipul
VIPUL AGARWAL
M.E.P. CONSULTANT
B.E. ELECTRICAL

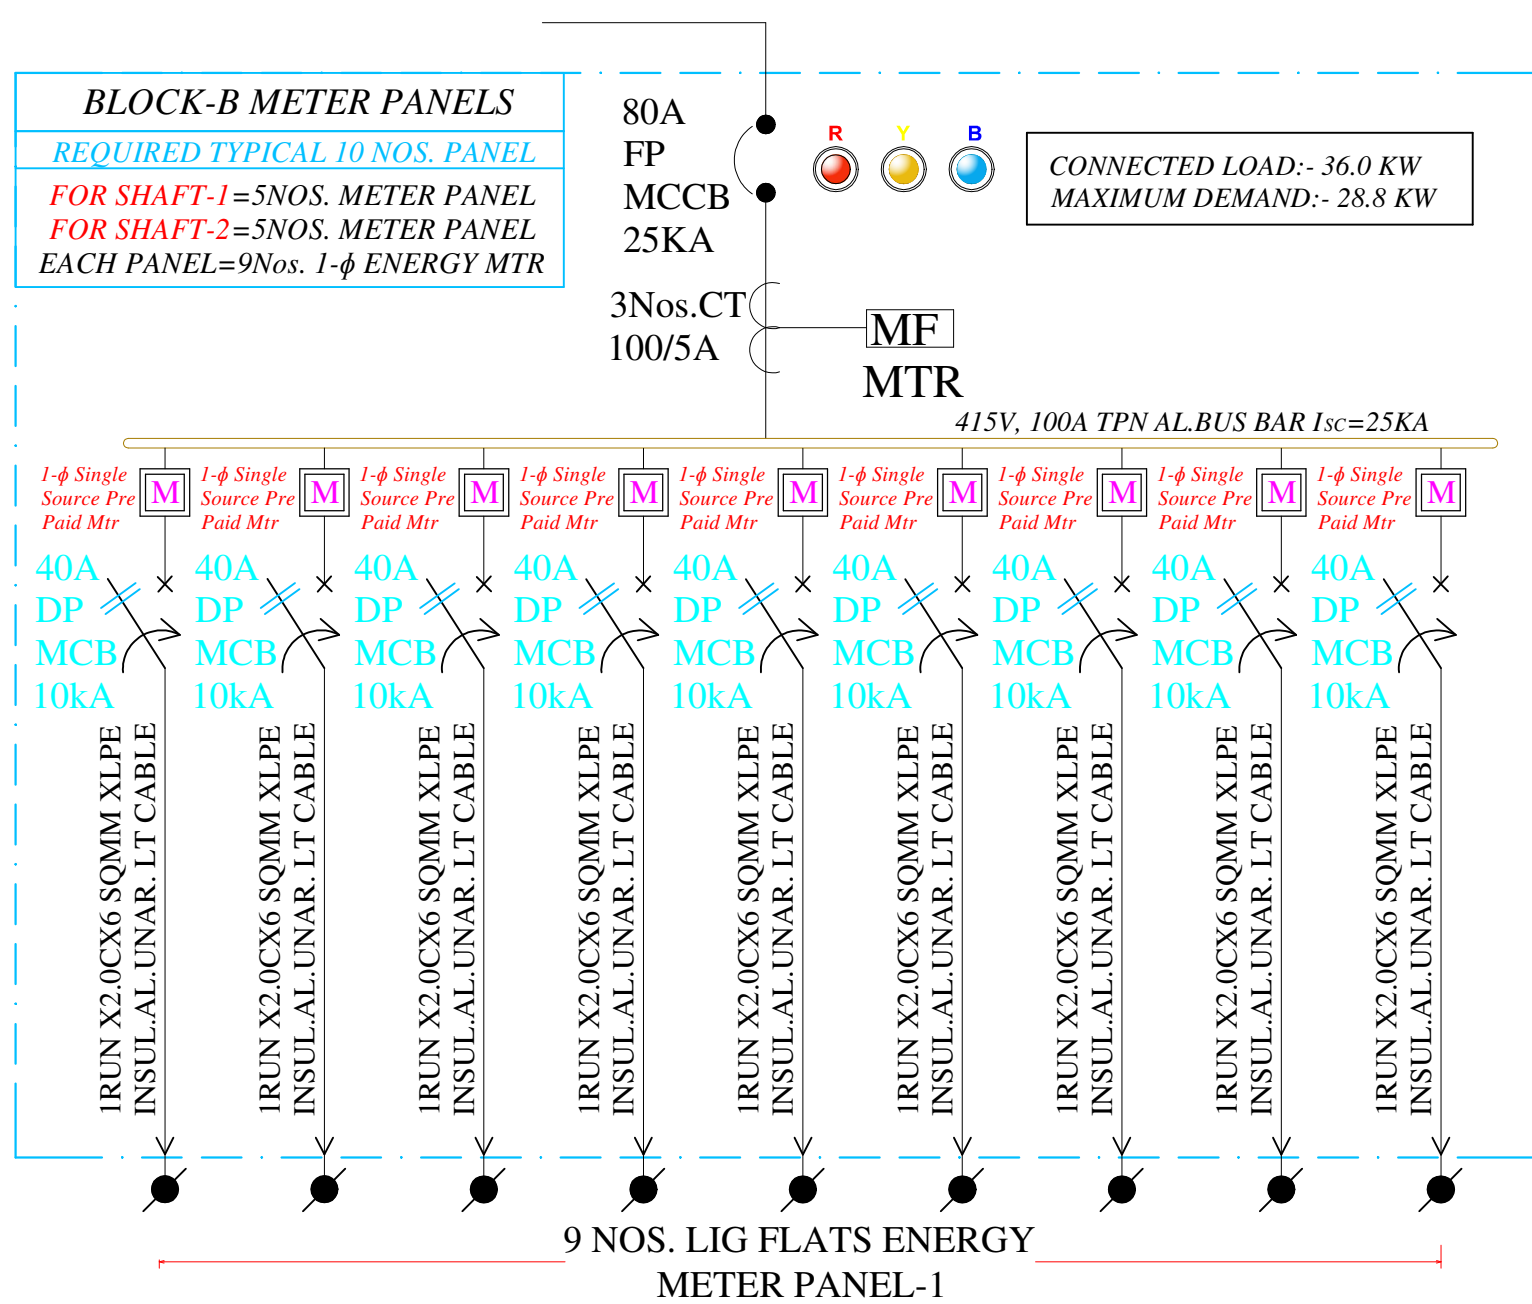

CLIENT :  SAMRIDDHI BUILDERS	PROJECT:- PROPOSED GSITE PLAN SHOWING RESIDENTIAL PLOT FOR CHEIF MINISTER JAN AWAS YOJANA SITUATED AT KH. NO. 1296,1306 AT VILLAGE MAKARWALI ,AJMER	ARCHITECTS : GRAPHITE DESIGN STUDIO ARCHITECTS, INTERIOR DESIGNERS, PLANNERS 68, Janak Puri -1st, Imliwala phatak, Opp Jain Mandir, Jaipur CONTACT NO. +91-9928334414, 0141-2593414 email: studiosgraphite@gmail.com Website : www.graphitedesignstudio.com	NAME OF DRAWING: BLOCK-A & B METER PANELS SINGLE LINE DIAGRAM		NORTH: 	SERVICES CONSULTANT: VIPUL CONSULTING, F 9 / 440 , Keshav Marg Chitrakut Scheme,Jaipur PH:91-0-93146-10438 ,0141-2440946 Mail:vipul8599@yahoo.com
			PROJECT NO. :	DATE : 24-02-2022		
			SCALE :	REV NO. : R-01		
			DRN BY: VICKY YADAV	APPD. BY: VIPUL AGARWAL	DRAWING NO. :	

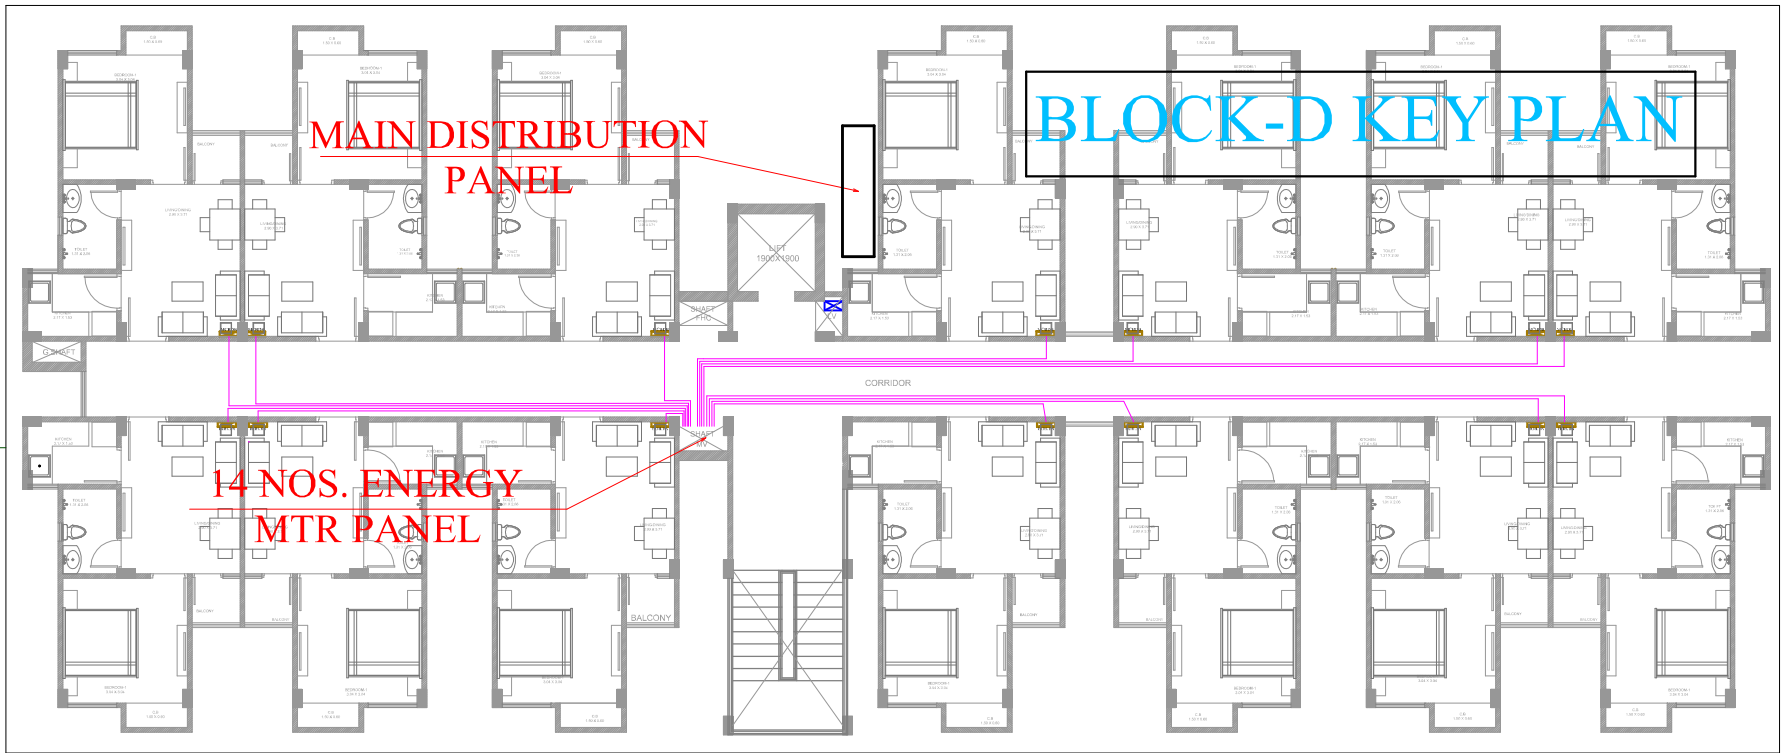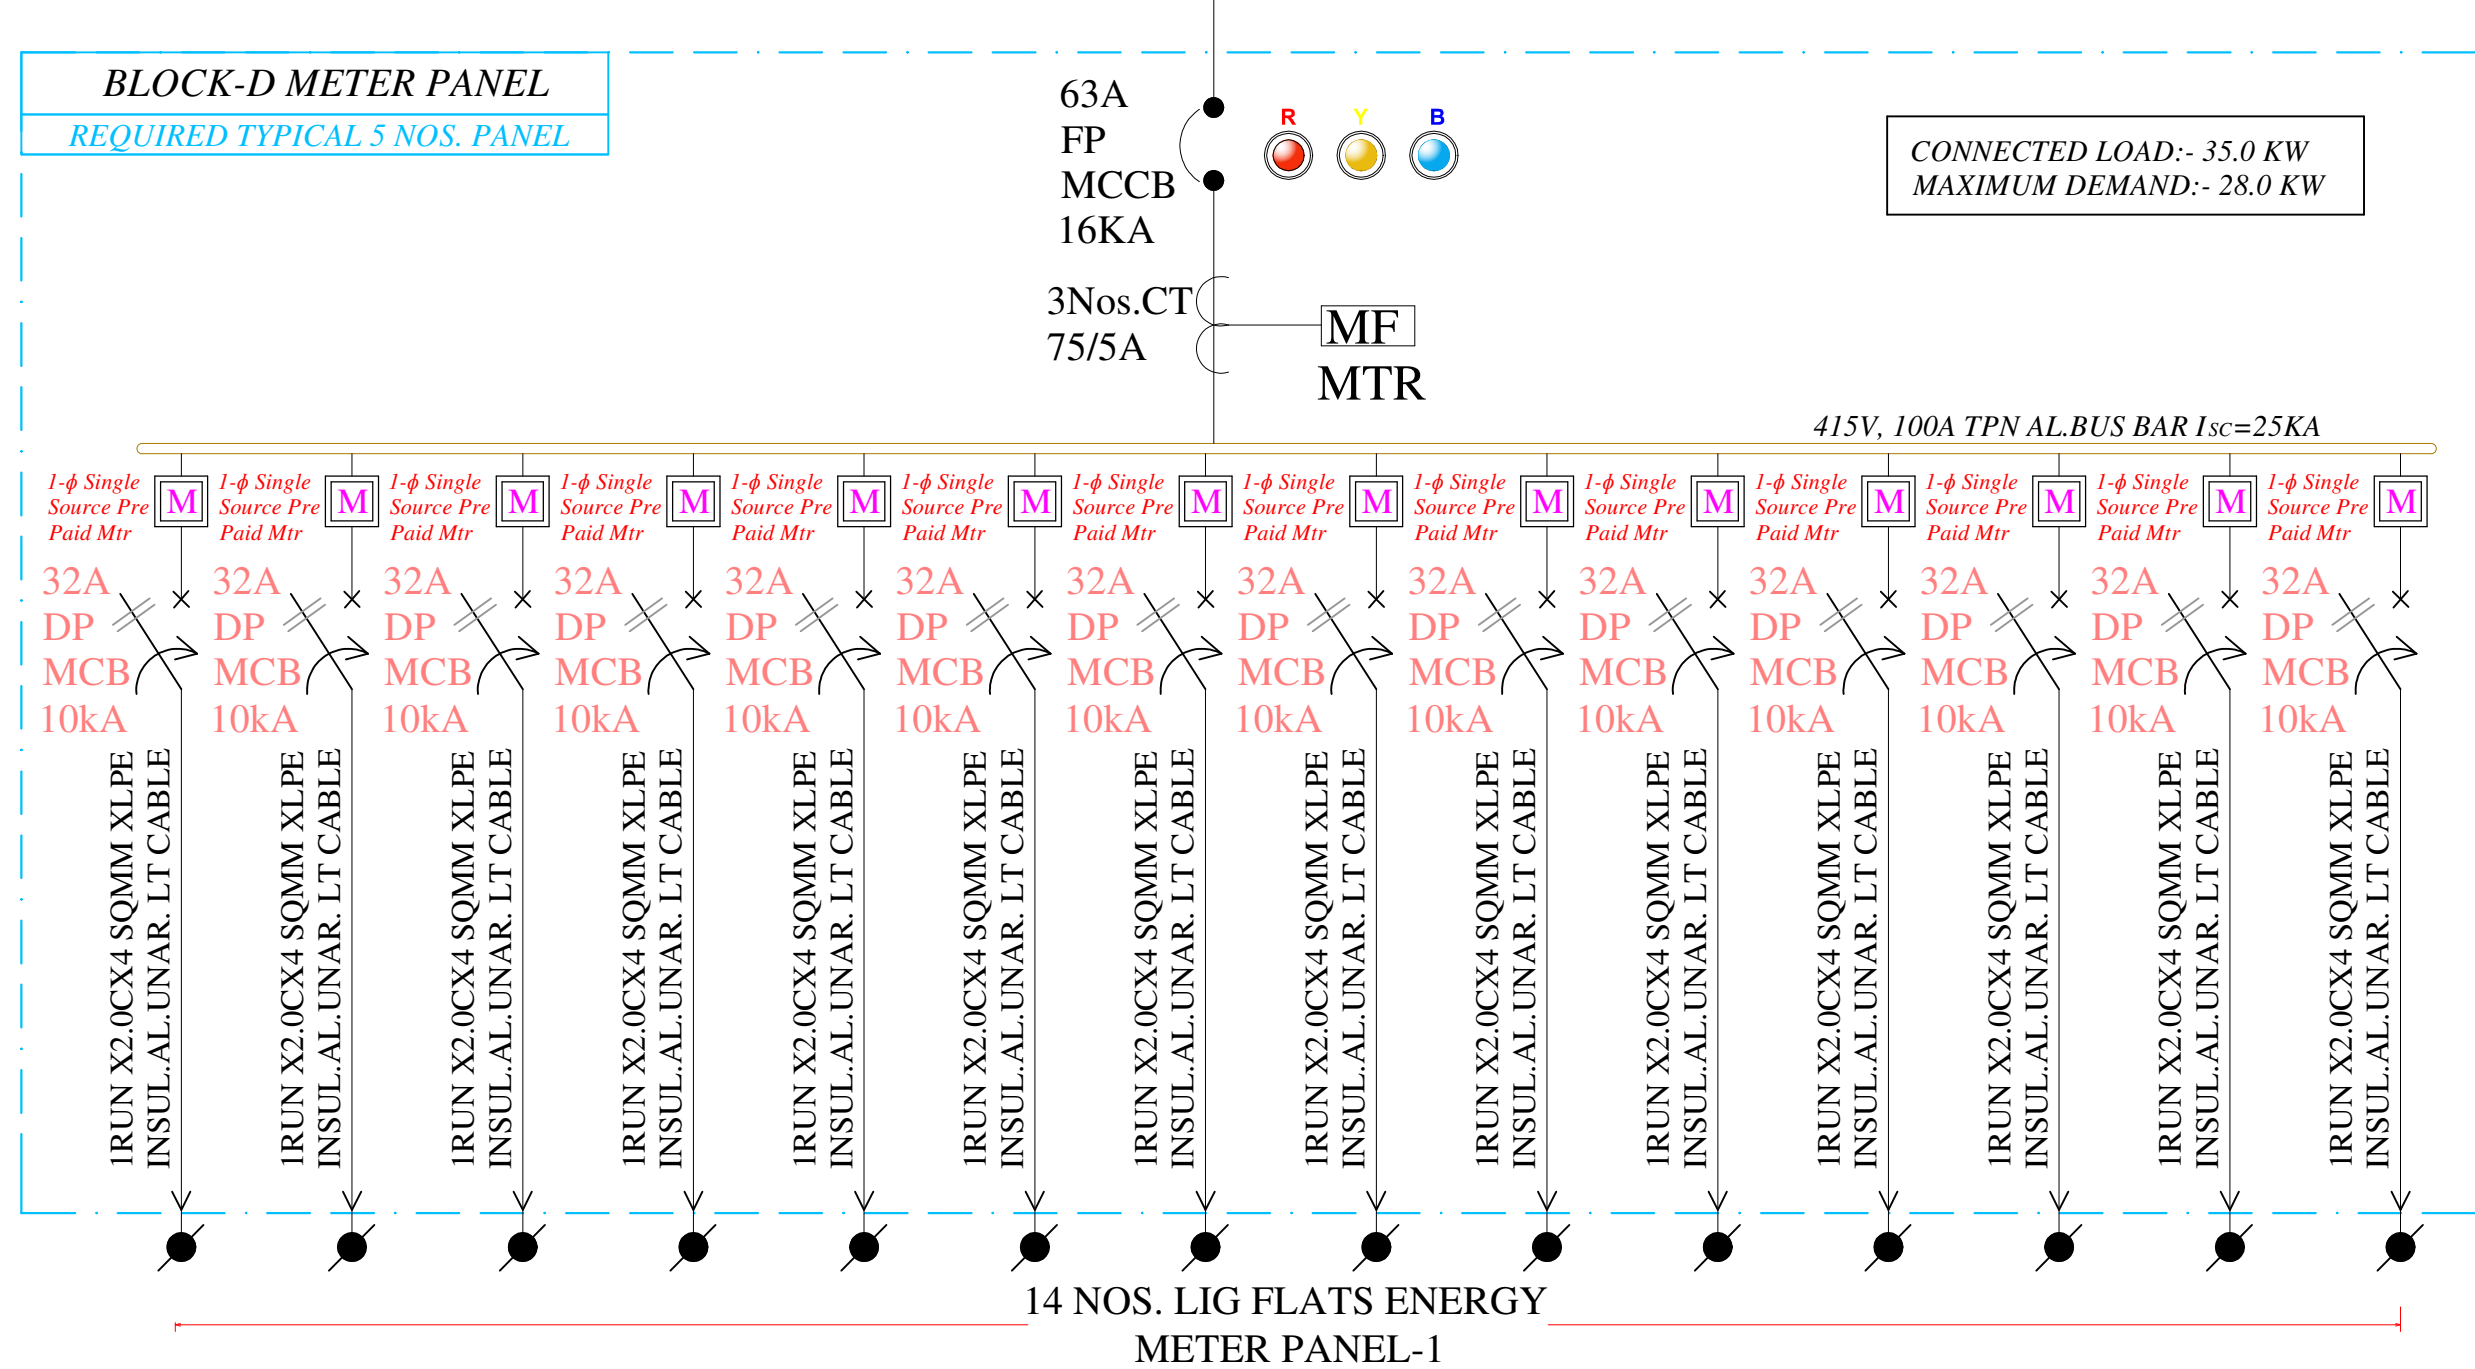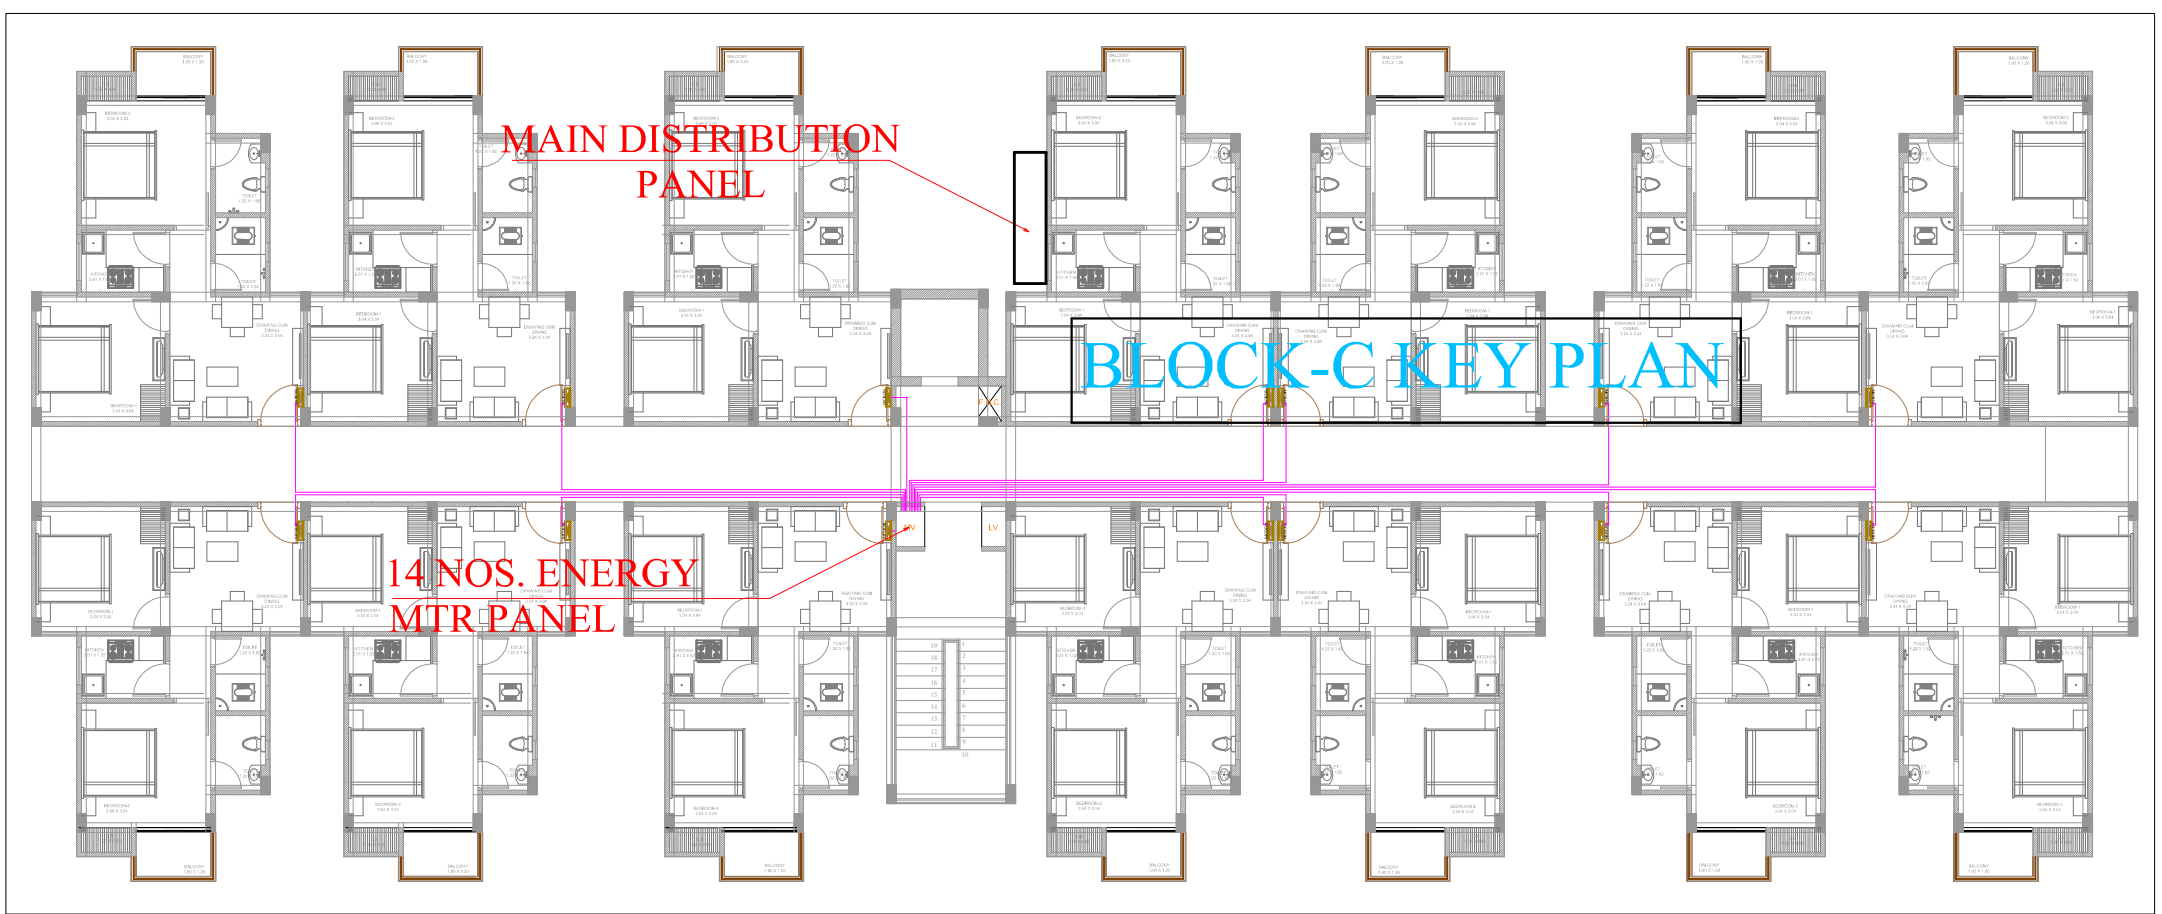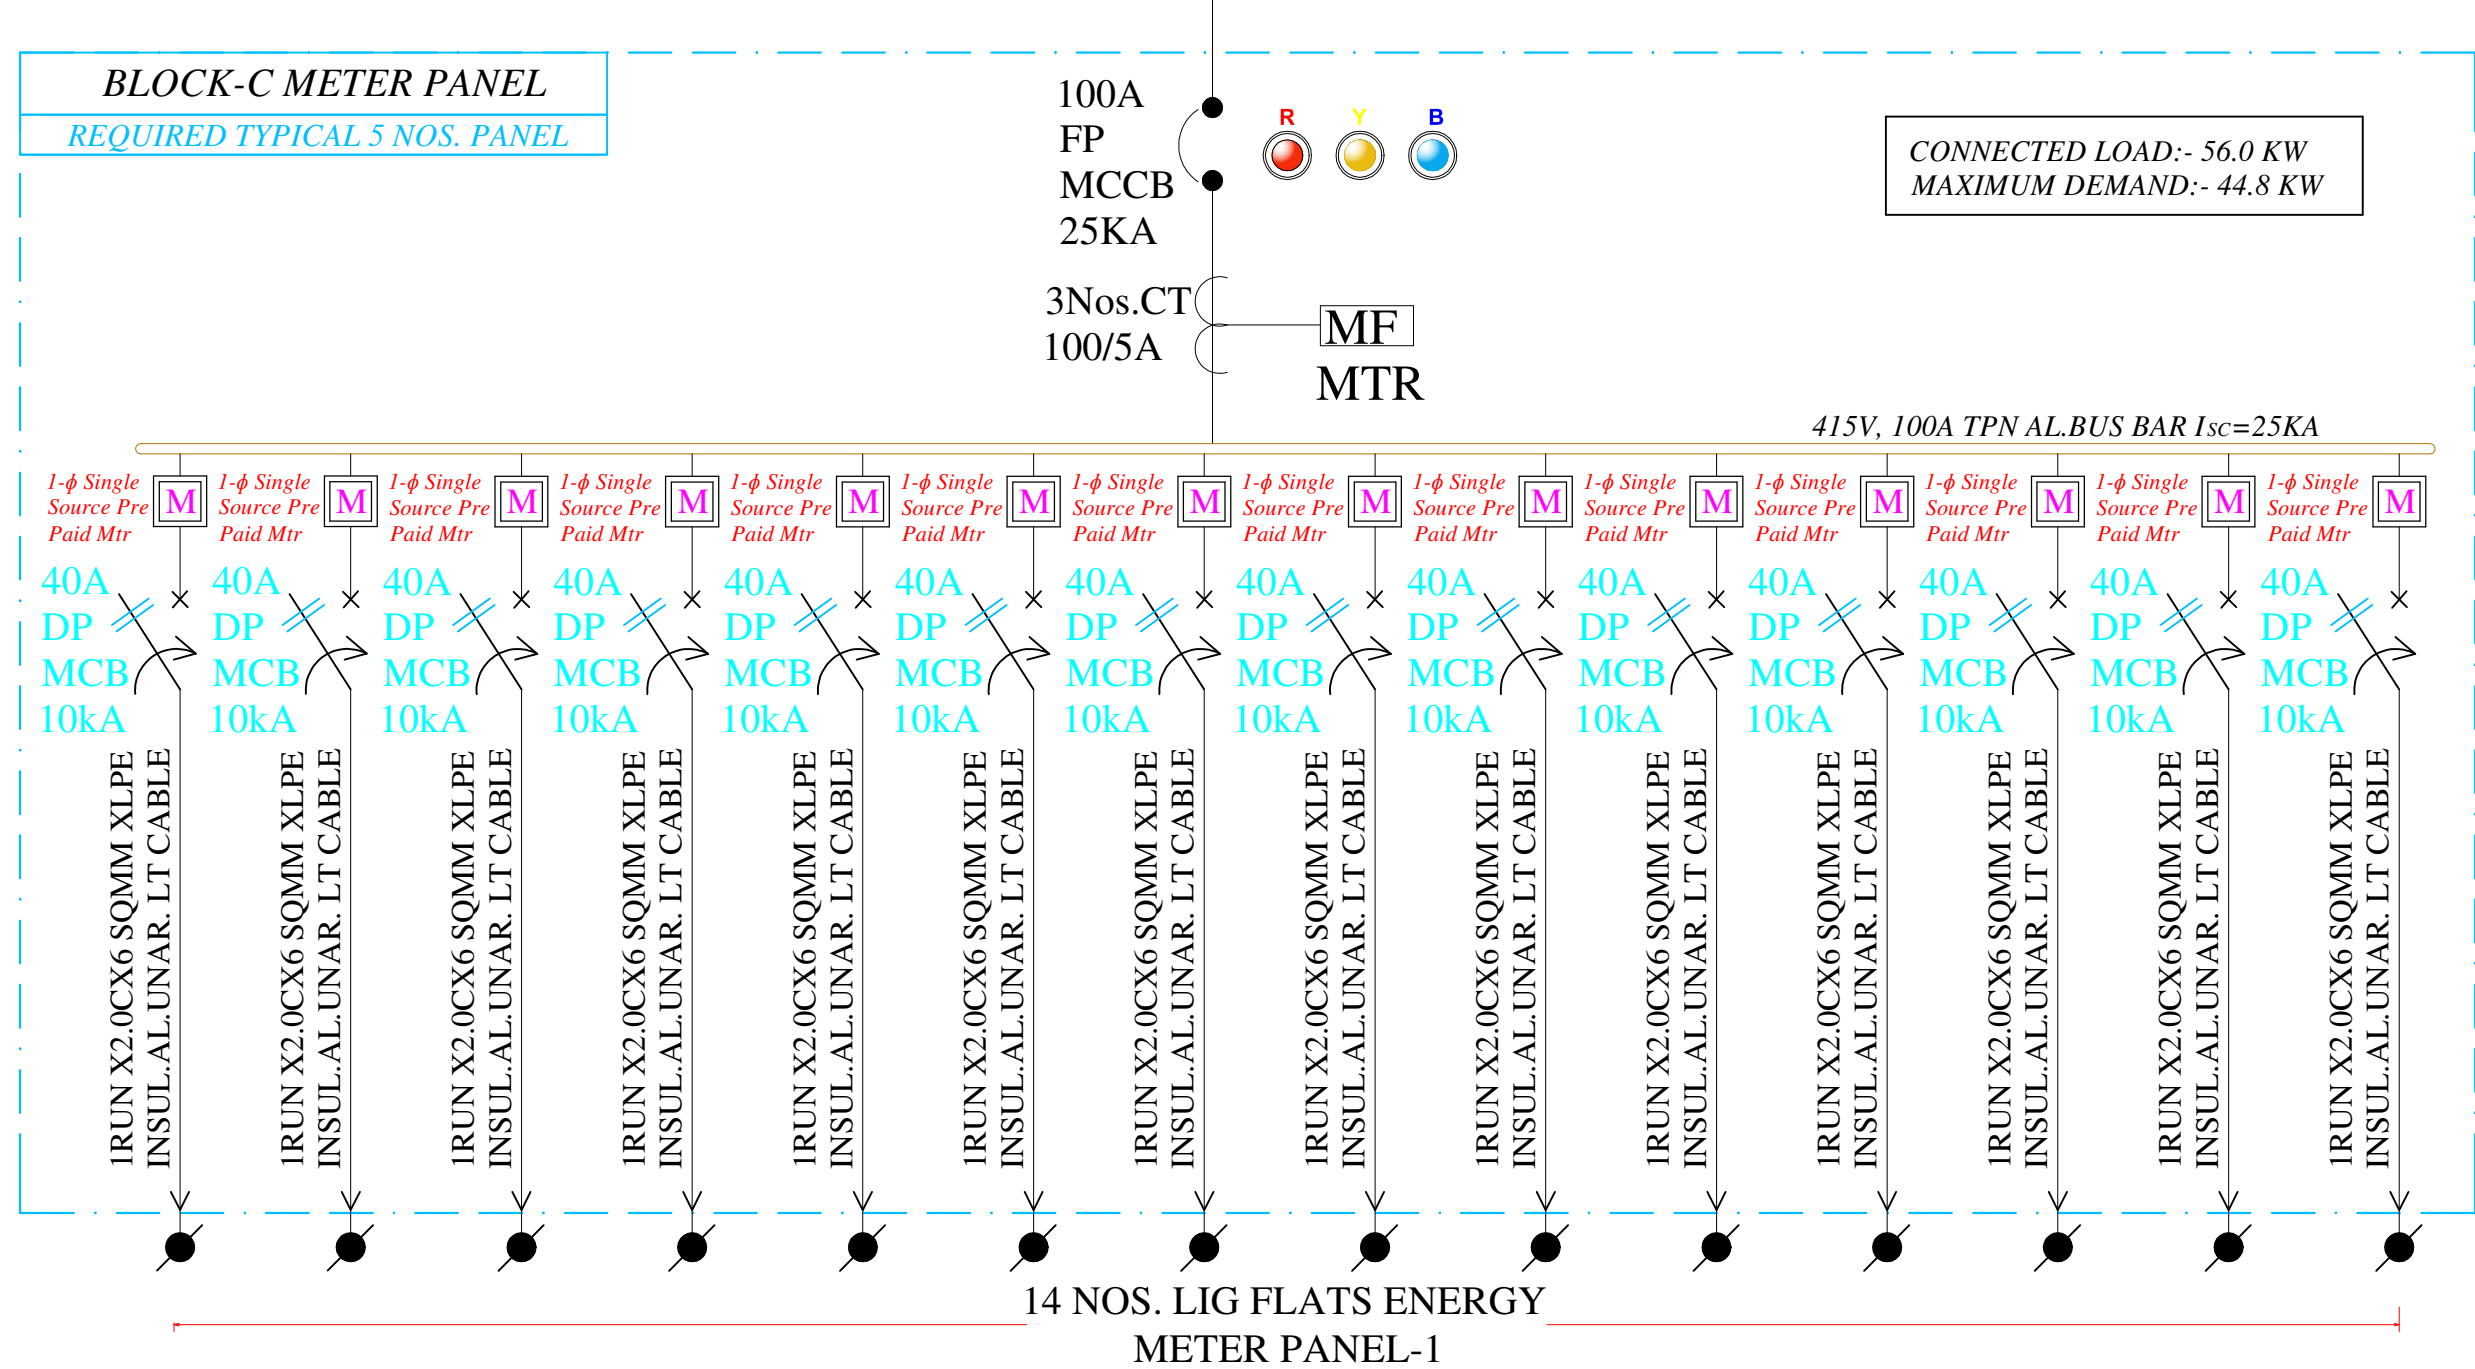

Vipul
VIPUL AGARWAL
M.E.P. CONSULTANT
B.E. ELECTRICAL

CLIENT :	PROJECT:-	ARCHITECTS :	NAME OF DRAWING:			NORTH: 
 SAMRIDDHI BUILDERS	PROPOSED GSITE PLAN SHOWING RESIDENTIAL PLOT FOR CHEIF MINISTER JAN AWAS YOJANA SITUATED AT KH. NO. 1296,1306 AT VILLAGE MAKARWALI ,AJMER	GRAPHITE DESIGN STUDIO ARCHITECTS, INTERIOR DESIGNERS, PLANNERS 68, Janak Puri -1st, Imliwala phatak, Opp Jain Mandir, Jaipur CONTACT NO. +91-9928334414, 0141-2593414 email: studiosgraphite@gmail.com Website : www.graphitedesignstudio.com	<i>BLOCK-C & D METER PANELS</i> <i>SINGLE LINE DIAGRAM</i>		PROJECT NO. :	DATE : 24-02-2022
			DRN BY:	APPD. BY:	SCALE :	REV NO. : R-01
			VICKY YADAV	VIPUL AGARWAL	DRAWING NO. :	SERVICES CONSULTANT: VIPUL CONSULTING, F 9 / 440 , Keshav Marg Chitrakut Scheme,Jaipur PH:91-0-93146-10438 ,0141-2440946 Mail:vipul8599@yahoo.com