



KEY PLAN

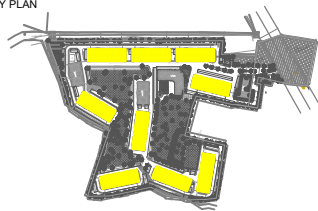

NOTES :-

1. ALL DIMENSION ARE IN MM.
2. FOR LEGENDS AND GENERAL NOTES REFER DRAWING 16280-P-A1-0001
3. FOR PLUMBING TYPICAL DETAILS REFER DRAWING 16280-P-A1-0200

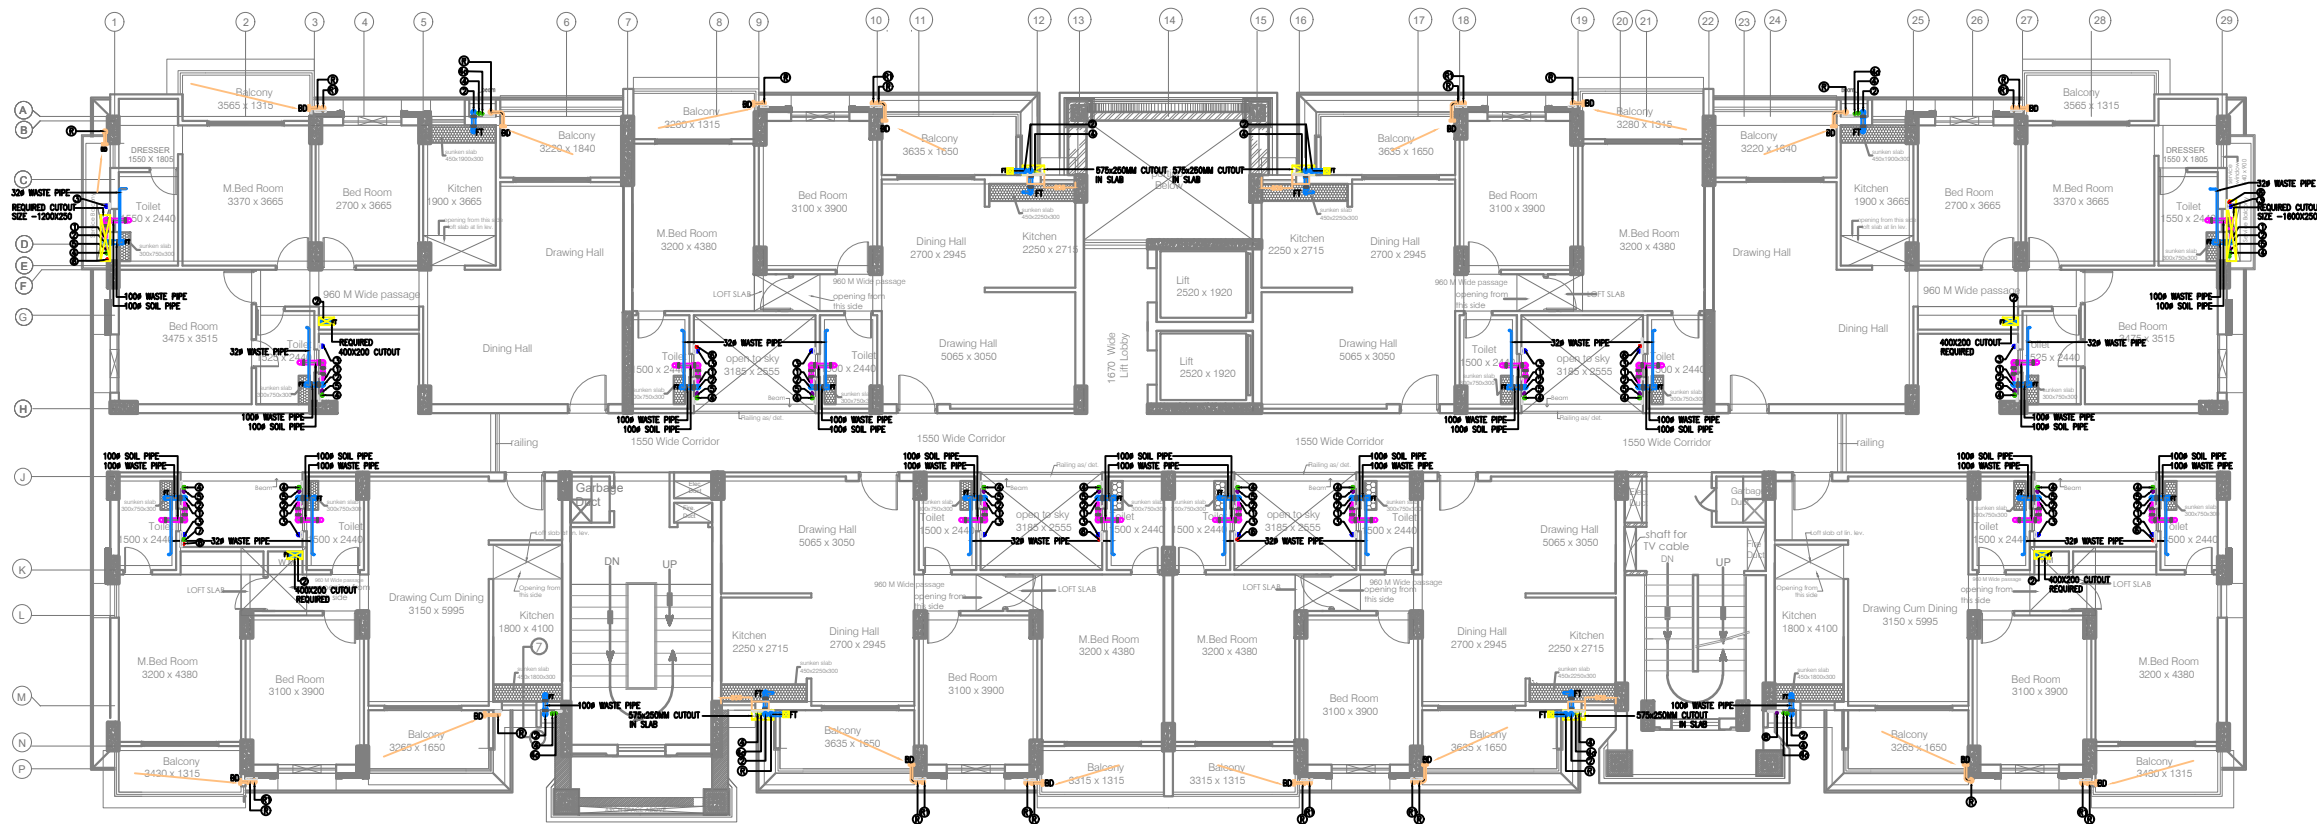

First Floor Plan

Rev	Date	Issued to	Description	By	Chk
R1	16.01.17	ARCH.	GFC ISSUE	DKK	DKT
R0	28.12.16	ARCH.	ISSUED FOR APPROVAL	DKK	DKT

The concepts and information contained in this document are the copyright of think BIM Technical Services Pvt. Ltd. Use or copying of the document in whole or in part without the written permission of think BIM Technical Services Pvt. Ltd. constitutes an infringement of copyright. Do not scale drawings. If in doubt, ask!

ARCHITECTS :

b.sengupta architect

A305,RANGOLI,ASHANAVILLAGE,BHIWADI,
PH . 09887488263

MEP CONSULTANT :



STRUCTURAL CONSULTANT :

Developer:-

ASHIANA HOUSING LTD
Unit no.4 & 5,Plot No.D-2,3rd Floor,
Southern park, saket District Centre,
Saket New Delhi - 110017
Phone no. 011- 42 65 42 65

Project Name

ASHIANA TARANG AT BHIWADI

Title

**TYPICAL FLOOR PLAN
DRAINAGE LAYOUT**

Discipline	Status
PLUMBING SERVICE	GFC
Designed By DKK	Checked By MKS
Project No. 16280	Date 09.05.2016
Drawing No. 16280-P-A1-A-1001	Scale 1:100 (at A1)
Revision R1	

LEGEND:-

SN.	DESCRIPTION
①	100# SOIL AND VENT PIPE
②	100# WASTE AND VENT PIPE
③	75# VENT PIPE
④	COLD WATER SUPPLY DOWN TAKE PIPE
⑤	COLD WATER SUPPLY DOWN TAKE PIPE (TOP 2 FLOOR)
⑥	FLUSHING WATER SUPPLY DOWN TAKE PIPE
⑦	HOT WATER SUPPLY DOWN TAKE PIPE
⑧	COLD WATER TANK FILING LINE
⑨	FLUSHING WATER TANK FILING LINE
⑩	75# BALCONY DRAIN PIPE
⑪	100# RAIN WATER PIPE
⑫	WASTE PIPE
⑬	SOIL PIPE
⑭	FT FLOOR TRAP
⑮	FD FLOOR DRAIN
⑯	BD BALCONY DRAIN
WC	WATER CLOSET
WB	WASH BASIN
DETAIL OF TOILET PIPE CONNECTIONS	
FROM WC TO STACK 100# SOIL PIPE FROM FT TO STACK 100# WASTE PIPE FROM FD TO FT 50# WASTE PIPE FROM BD TO STACK 50# WASTE PIPE FROM SINK TO FT 40# WASTE PIPE FROM WB TO FT 32# WASTE PIPE	