


CITY HOME-ENCLAVE (PHASE -3) KHASRA NO. 177 OF VILLAGE TANAWRA AT JODHPUR.

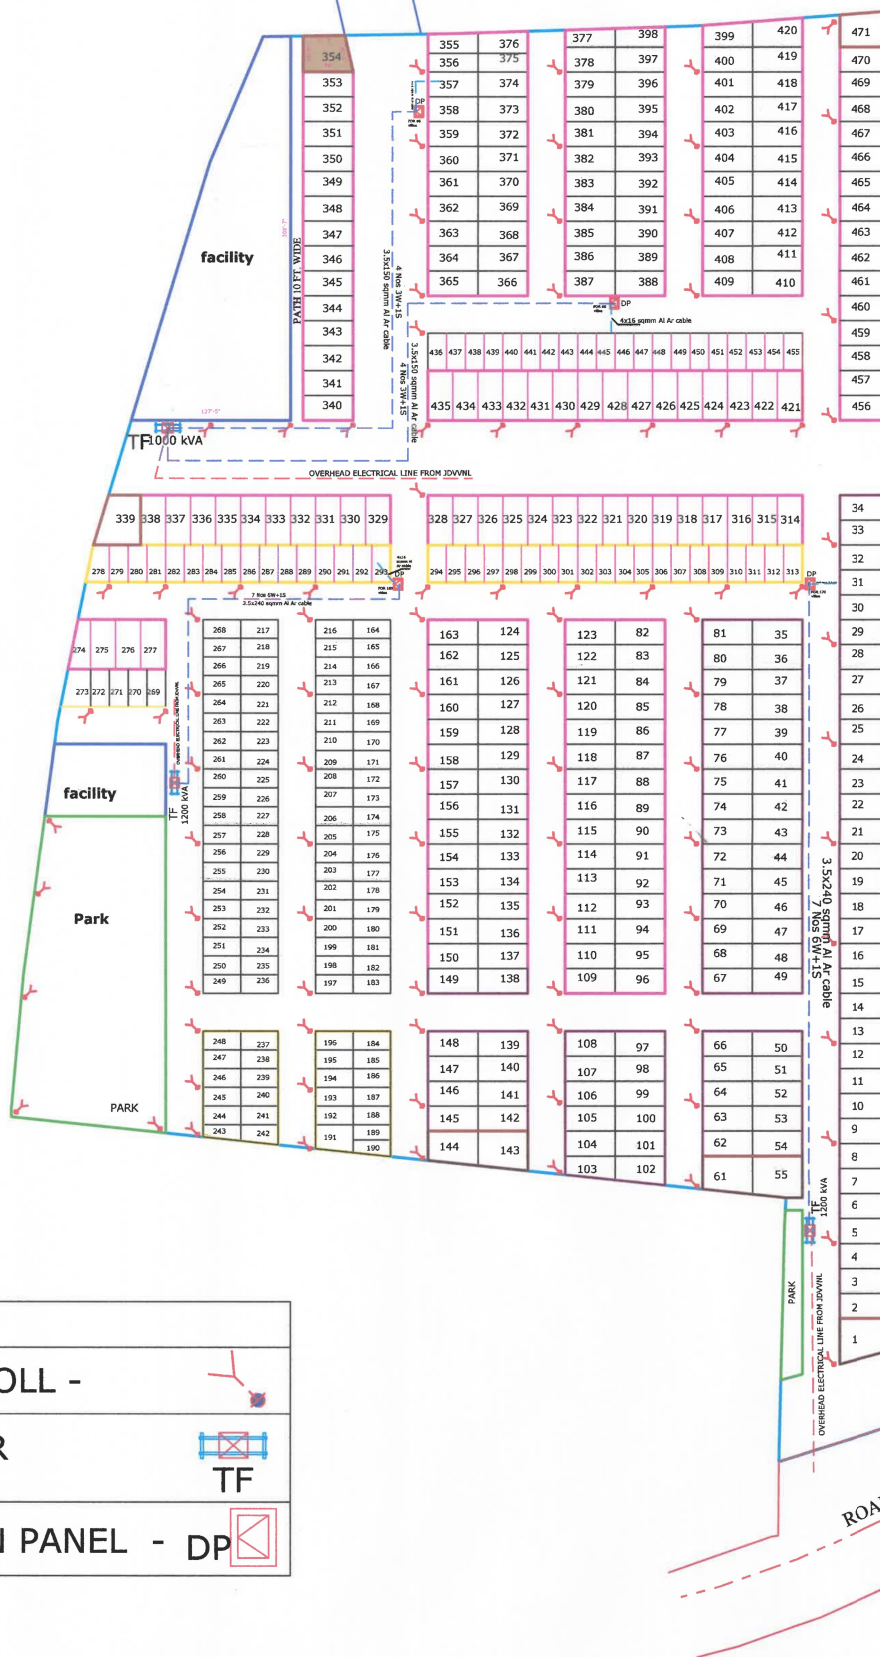

SCALE:- 1"=100'



NOTE -

ELECTRICAL POLL -

TRANSFORMER



TF

DISTRIBUTION PANEL - DP



ELECTRICAL LAYOUT PLAN

PROJECT TITLE :

GENERAL NOTES :

1. ALL DIMENSIONS ARE IN THE FEET OTHERWISE MENTIONED.
2. DO NOT SCALE THE DRAWING. ONLY WRITTEN DIMENSIONS ARE TO BE FOLLOWED.
3. R.C.C. MEMBERS ARE INDICATIVE. REFER ONLY STRUCTURE DRAWING FOR DETAIL.
4. ANY DISCREPANCY IN THE DRAWING IS TO BE BROUGHT TO THE NOTICE OF THE ARCHITECT.
THIS DRAWING IS THE PROPERTY OF BUILDFORM DESIGN CENTER IT SHALL NOT BE COPIED OR USED WITHOUT THEIR WRITTEN PERMISSION NOR MADE KNOWN TO A THIRD PARTY. THE INFORMATION IS ISSUED ON THE UNDERSTANDING THAT NO PART THEREOF SHALL BE DUPLICATE FOR THE PURPOSE OTHER THAN THE EXPRESSED PURPOSE. WRITTEN PERMISSION NOR MADE KNOWN TO A THIRD PARTY. THE INFORMATION IS ISSUED ON THE UNDERSTANDING THAT NO PART THEREOF SHALL BE DUPLICATED FOR THE PURPOSE OTHER THAN THE EXPRESSED PURPOSE.

SITE AT :

DRG. NO. :

SCALE :

MEP CONSULTANT

PROJECT ARCHITECT

ARCHITECTURAL FIRM -

BUILDFORM
Design Center

Block C - 348, GAUTAM MARG,
VAISHALI NAGAR, JAIPUR
PH. 0141-4016649

NORTH :



DATE :

REVISION

ER. ROHIT GOYAL
RAD SERVICE ENCLAVE
13/77, Swarn Path, Mansarovar Jaipur
-302020 (Raj.) INDIA

SIGN.

ROHIT GOYAL
M.E.P. CONSULTANT
B.E. ELECTRICAL

Ar. N.K. SINGH