


40'-0" WIDE ROAD

144'-3"

65'

132'-9"

60'-0" WIDE ROAD

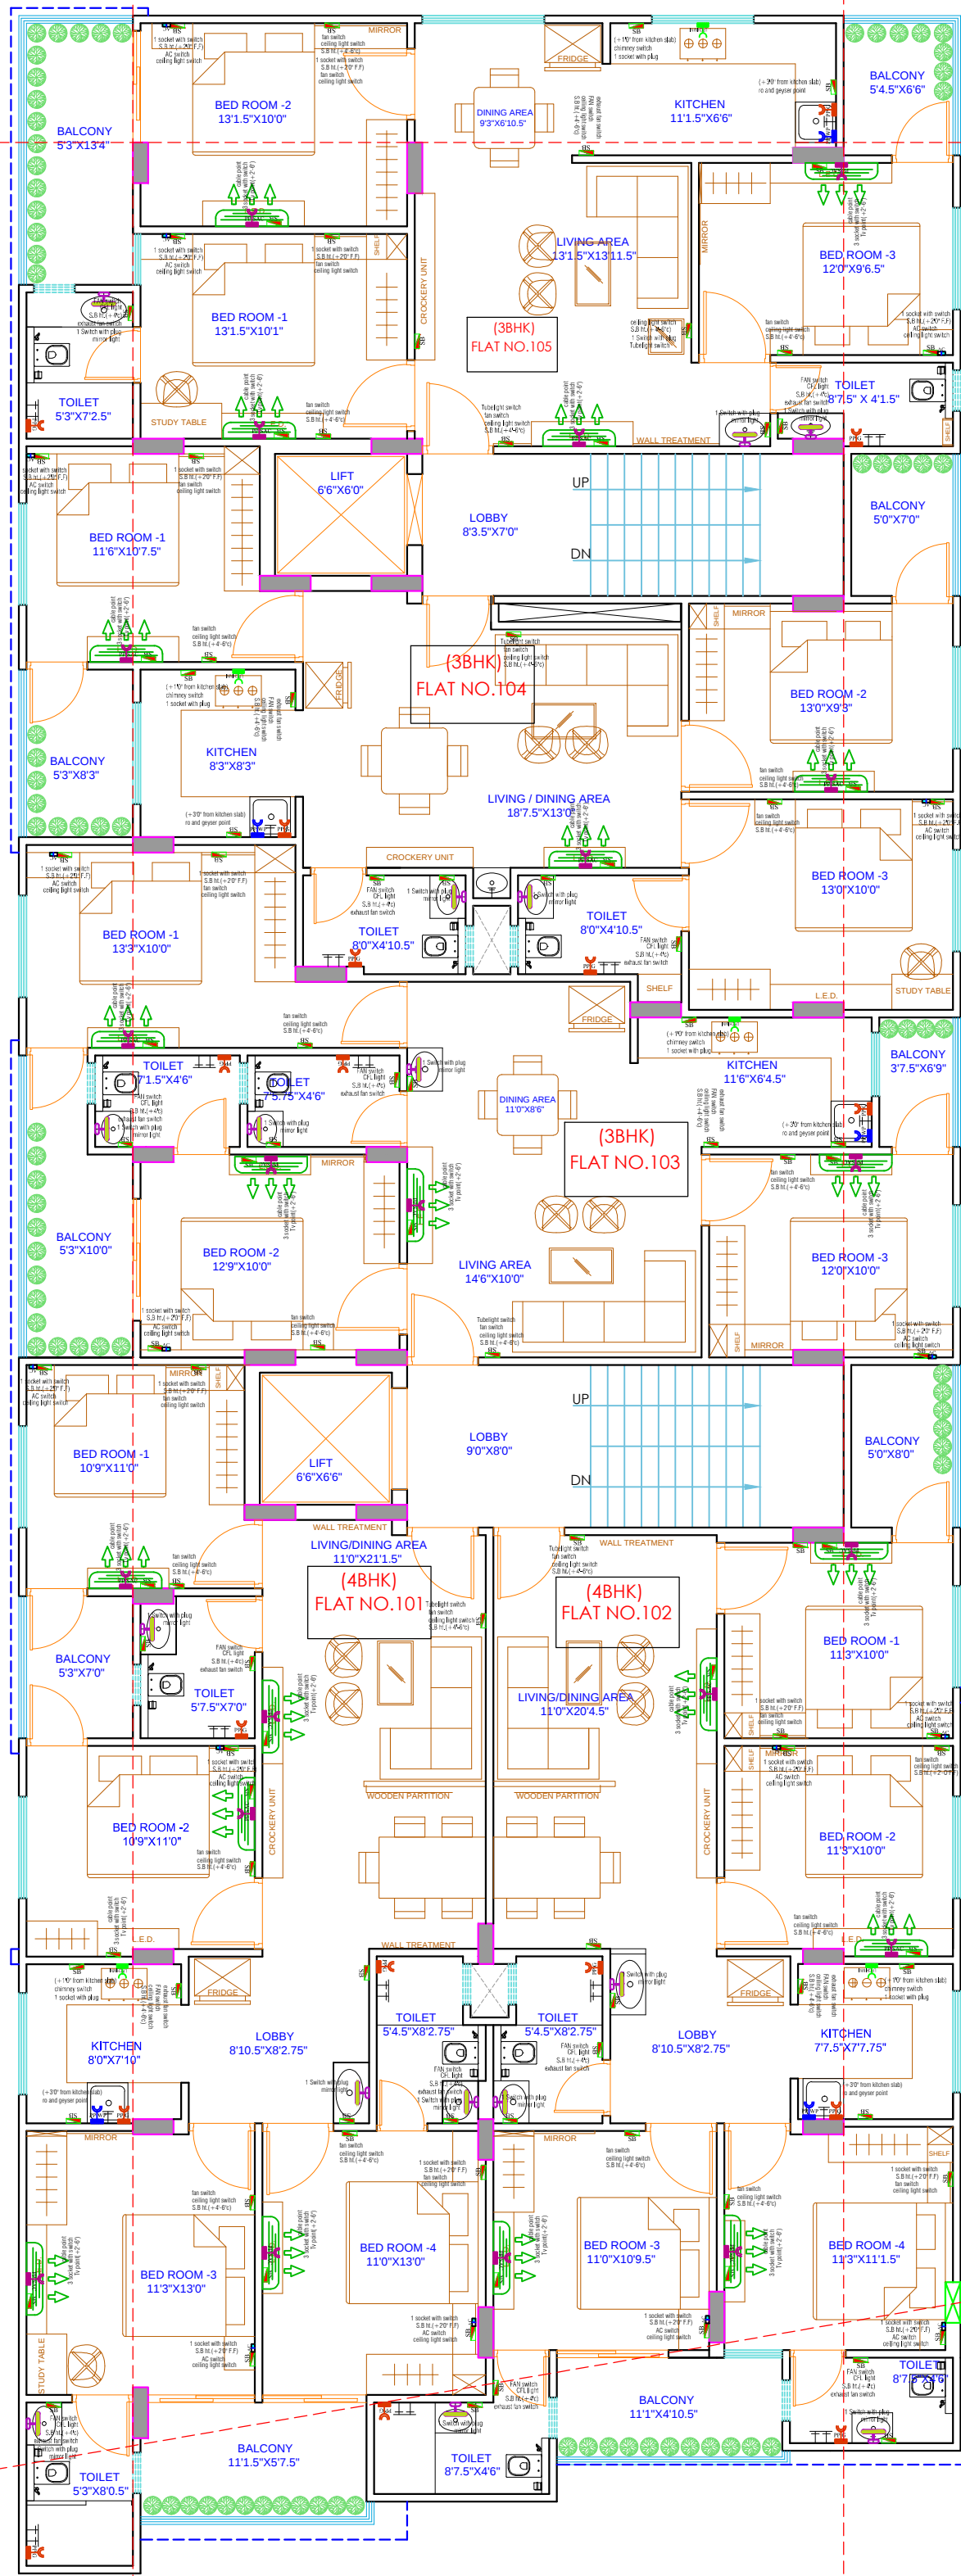

LEGENDS:				
Mounting Height	No.	I D	Symbol	Description
IN FLOOR				CONTROL WIRING
IN CONDUIT				CONTROL WIRING
IN CONDUIT				AC CONTROL WIRING
IN CONDUIT				GYSEK CONTROL WIRING
IN CONDUIT				BUZZER CONTROL WIRING
CEILING	06	FAN48"		CEILING FAN 48"
CEILING	02	FAN30"		CEILING FAN 30"
+90"	04	TL		1X60W WALL TUBELIGHT
+90"	04	BULB		WALL BRACKETS AS DESIGN LIGHT
+90"	01	GL		WALL BRACKETS AS DESIGN FOR GANESH LIGHT
	02	GL		WALL BRACKETS AS DESIGN FOR GATE LIGHT
CEILING	21	CFL		CFL CEILING LIGHT
+21"	02	FL		FOOT LIGHT
+48"	14	SB		SWITCH BOARD
+75"	03	ML		1 X 11 W CFL MIRROR LIGHT
VENTILATOR HT.	03	CR		CEILING ROSE
VENTILATOR HT.	03	EXF		9" DIA FRESH AIR FAN
+24"	02	TEL		TELEPHONE POINT
+27"	03	TV		TV COAXIAL POINT
+24"	02	LP TEL		6 A PLUG POINT FOR TELEPHONE
+27"	03	LP TV		6 A PLUG POINT FOR TV
+24"	02	LP		6 A PLUG POINT
+72"	01	LP-CH		6 A PLUG POINT FOR CHIMNEY
+102"	03	SAC		SPLIT AC
+102"	03	PP-SAC		25 A POWER POINT FOR SPLIT AC
+42"	01	PP-MIX		15 A POWER POINT FOR MIXER
+75"	02	PP-G		15 A POWER POINT FOR GEYSER
+54"	01	PP-F		15 A POWER POINT FOR FRIDGE
+75"	01	PP-WP		15 A POWER POINT FOR WATER PURIFIER
+45"	01	PP-WM		15 A POWER POINT FOR WASHING MACHINE
+42"	02	BP		BELL PUSH SWITCH
+90"	01	BZ		BUZZER POINT
+24"	03	AC		AC STARTER
+60"	01	MCB DB		MCB DISTRIBUTION BOARD
	05		SB1/L1	SWITCH BOARD NO. / LIGHT CIRCUIT NO.
	03		ACI	AC CIRCUIT NO.
	05		PI	POWER CIRCUIT NO.

WARNING

1. This drawing is the sole copyright of Architects VISTAAR and should be used for the purpose expressly issued.

GENERAL NOTES

- 1. All dimensions are in feet and inches.
- 2. Do not scale this drawing follow written dimensions only.
- 3. This drawing should be read in conjunction with other architectural and structural drawings.
- 4. Any discrepancy in the drawing should be immediately brought to the notice of architect.

PROJECT TITLE

CITY PALM
BUILDING AT PLOT-E-84,JAGDAMBA
NAGAR-E,JAIPUR

DRAWING TITLE

5TH FLOOR WALL ELECTRICAL PLAN

ARCHITECTS :

VISTAAR ARCHITECTS & PLANNERS
Architects :: Interior Designers
B-2/12, Chitrkoot scheme,
main Gandhi Path,Opp mall of jaipur,Jaipur
PH. - 0141-4116461,09001010366

PATH :-

DRN.

DATE


REV.

NORTH

SCALE

JOB NO.

N.T.S

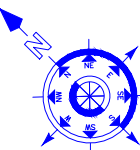

For R K Builders & Developers
Proprietor

Krishna
KRISHNA KUMAR
B. Tech. (Mechanical)
M.E.P Consultant

40'-0" WIDE ROAD

144'-3"


65'

15'

15'

132'-9"

60'-0" WIDE ROAD

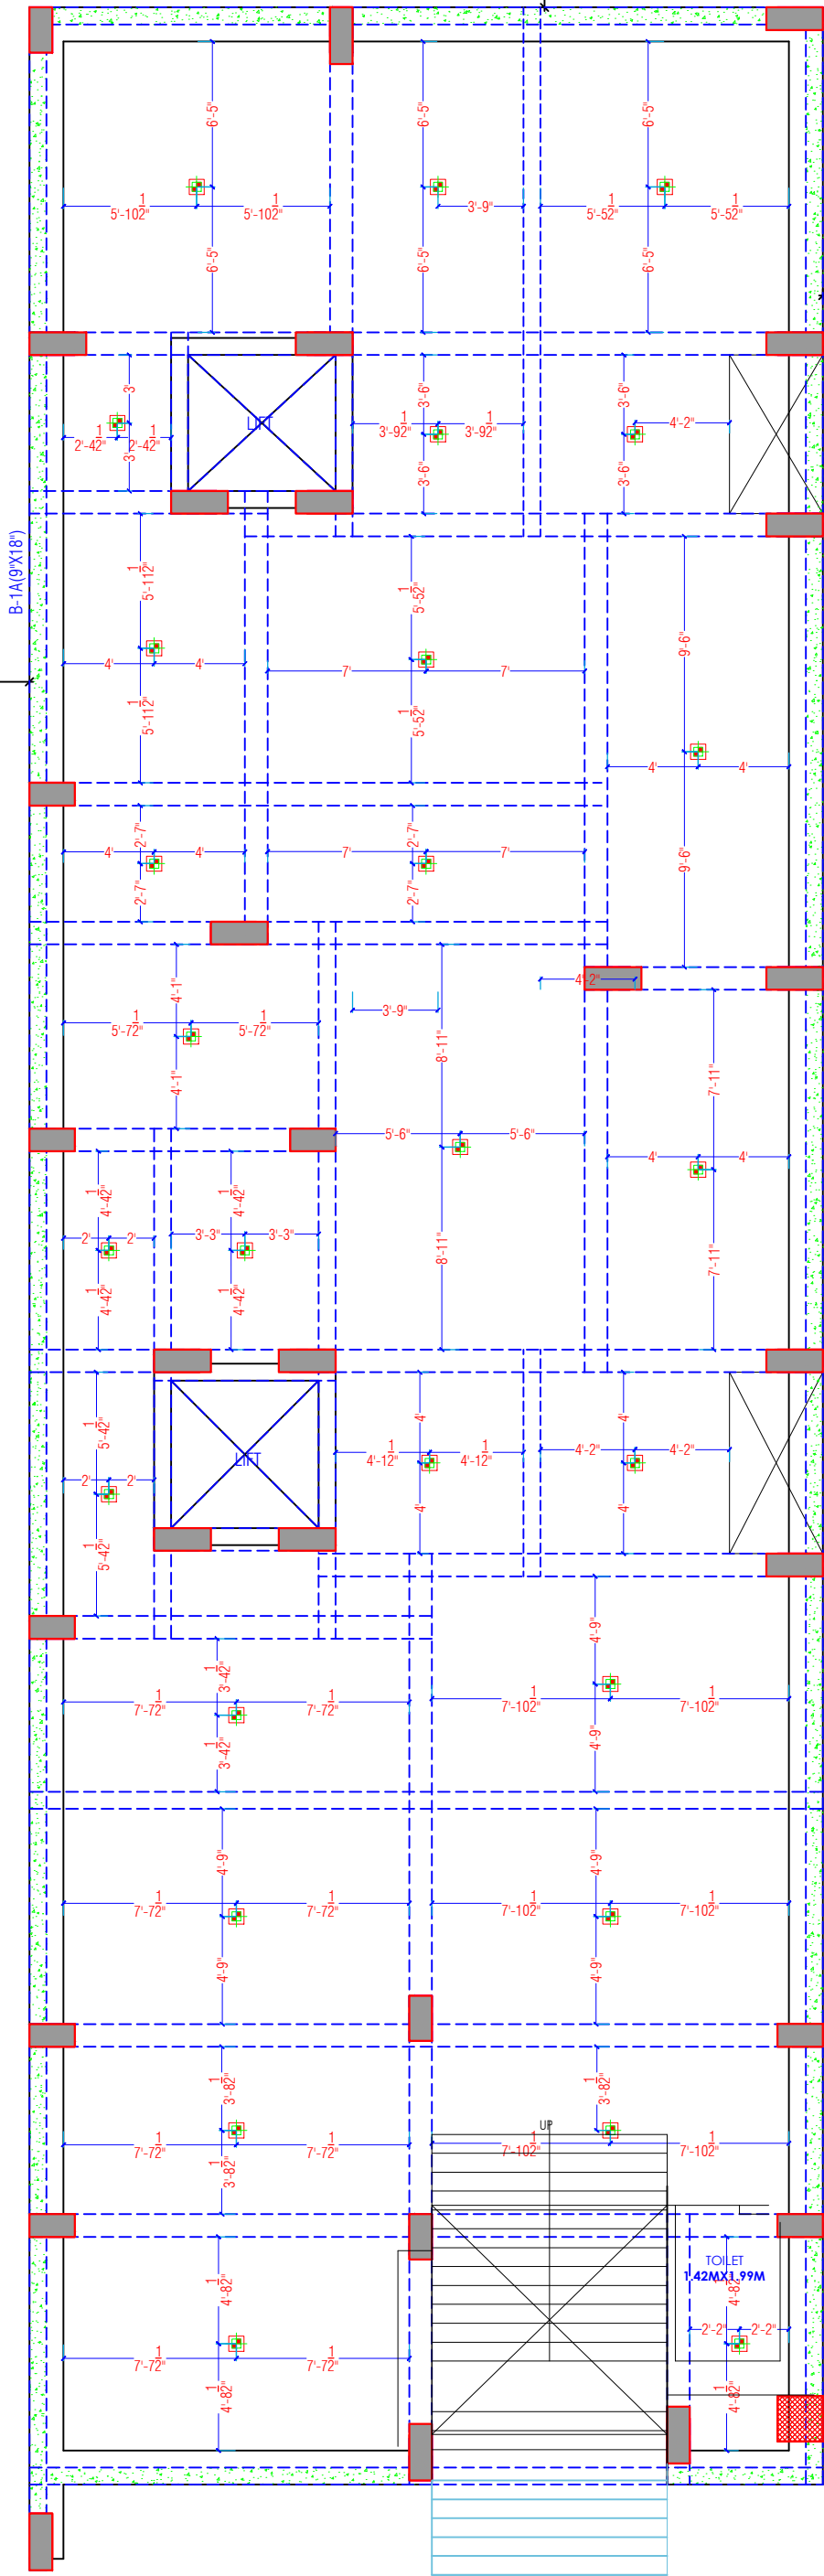

For R K Builders & Developers
B. Tech. (Mechanical)
M.E.P Consultant
Proprietor

For R K Builders & Developers
B. Tech. (Mechanical)
M.E.P Consultant
Proprietor

LEGENDS:				
Mounting Height	No.	I D	Symbol	Description
IN FLOOR				CONTROL WIRING
IN CONDUIT				CONTROL WIRING
IN CONDUIT				AC CONTROL WIRING
IN CONDUIT				GYSER CONTROL WIRING
IN CONDUIT				BUZZER CONTROL WIRING
CEILING	06	FAN48"		CEILING FAN 48"
CEILING	02	FAN30"		CEILING FAN 30"
+90"	04	TL		1X60W WALL TUBELIGHT
+90"	04	BULB		WALL BRACKETS AS DESIGN LIGHT
+90"	01	GL		WALL BRACKETS AS DESIGN FOR GANESH LIGHT
+90"	02	GL		WALL BRACKETS AS DESIGN FOR GATE LIGHT
CEILING	21	CFL		CFL CEILING LIGHT
+21"	02	FL		FOOT LIGHT
+48"	14	SB		SWITCH BOARD
+75"	03	ML		1'X11" W CFL MIRROR LIGHT
VENTILATOR HT.	03	CR		CEILING ROSE
VENTILATOR HT.	03	EXF		9" DIA FRESH AIR FAN
+24"	02	TEL		TELEPHONE POINT
+27"	03	TV		TV COAXIAL POINT
+24"	02	LP TEL		G A PLUG POINT FOR TELEPHONE
+27"	03	LP TV		G A PLUG POINT FOR TV
+24"	02	LP		G A PLUG POINT
+72"	01	LP-CH		G A PLUG POINT FOR CHIMNEY
+102"	03	SAC		SPUT AC
+102"	03	PP-SAC		25 A POWER POINT FOR SPUT AC
+42"	01	PP-MIX		15 A POWER POINT FOR MIXER
+78"	02	PP-G		15 A POWER POINT FOR GEYSER
+54"	01	PP-F		15 A POWER POINT FOR FRIDGE
+78"	01	PP-WP		15 A POWER POINT FOR WATER PURIFIER
+48"	01	PP-WM		15 A POWER POINT FOR WASHING MACHINE
+42"	02	BP		BELL PUSH SWITCH
+90"	01	BZ		BUZZER POINT
+24"	03	AC		AC STARTER
+60"	01	MCB DB		MCB DISTRIBUTION BOARD
	05			SB1/L1
	03			ACI
	05			PI

WARNING

1. This drawing is the sole copyright of Architects **VISTAAR** and should be used for the purpose expressly issued.

GENERAL NOTES

- All dimensions are in feet and inches.
- Do not scale this drawing follow written dimensions only.
- This drawing should be read in conjunction with other architectural and structural drawings.
- Any discrepancy in the drawing should be immediately brought to the notice of architect.

PROJECT TITLE

CITY PALM
BUILDING AT PLOT-E-84,JAGDAMBA
NAGAR-E,JAIPUR


DRAWING TITLE

BASEMENT FLOOR CEILING ELECTRICAL PLAN

ARCHITECTS :

VISTAAR ARCHITECTS & PLANNERS
Architects :: Interior Designers
B-2/12, Chitrkoot scheme,
main Gandhi Path, Opp mall of jaipur,Jaipur
PH. - 0141-4116461,09001010366

PATH :-			
DRN.	DATE	REV.	NORTH
MANOJ KUMAWAT	23-06-2023		
SCALE	JOB NO.		
N.T.S			

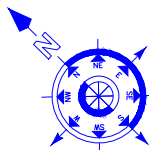

40'-0" WIDE ROAD

144'-3"

106'-3 1/2"

60'-0" WIDE ROAD

65'

15'

32'

15'

132'-9"

LEGENDS:				
Mounting Height	No.	I D	Symbol	Description
IN FLOOR				CONTROL WIRING
IN CONDUIT				CONTROL WIRING
IN CONDUIT				AC CONTROL WIRING
IN CONDUIT				GYSER CONTROL WIRING
IN CONDUIT				BUZZER CONTROL WIRING
CEILING	06	FAN-48"		CEILING FAN 48"
CEILING	02	FAN/30"		CEILING FAN 30"
+90"	04	TL		1X40W WALL TUBELIGHT
+90"	04	BULB		WALL BRACKETS AS DESIGN LIGHT
+90"	01	GL		WALL BRACKETS AS DESIGN FOR GANESH LIGHT
	02	GL		WALL BRACKETS AS DESIGN FOR GATE LIGHT
CEILING	21	CFL		CFL CEILING LIGHT
+21"	02	FL		FOOT LIGHT
+48"	14	SB		SWITCH BOARD
+78"	03	ML		1 X 11" W CFL MIRROR LIGHT
VENTILATOR HT.	03	CR		CEILING ROSE
VENTILATOR HT.	03	EXP		9" DIA FRESH AIR FAN
+24"	02	TEL		TELEPHONE POINT
+27"	03	TV		TV COAXIAL POINT
+24"	02	LP TEL		6 A PLUG POINT FOR TELEPHONE
+27"	03	LP TV		6 A PLUG POINT FOR TV
+24"	02	LP		6 A PLUG POINT
+72"	01	LP-CH		6 A PLUG POINT FOR CHIMNEY
+102"	03	SAC		SPLIT AC
+102"	03	PP-SAC		25 A POWER POINT FOR SPLIT AC
+42"	01	PP-MIX		15 A POWER POINT FOR MIXER
+78"	02	PP-G		15 A POWER POINT FOR GEYSER
+54"	01	PP-F		15 A POWER POINT FOR FRIDGE
+78"	01	PP-WP		15 A POWER POINT FOR WATER PURIFIER
+48"	01	PP-WM		15 A POWER POINT FOR WASHING MACHINE
+42"	02	BP		BELL PUSH SWITCH
+90"	01	BZ		BUZZER POINT
+24"	03	AC		AC STARTER
+60"	01	MCB DB		MCB DISTRIBUTION BOARD
	05		SBI/LI	SWITCH BOARD NO. / LIGHT CIRCUIT NO.
	03		AC	AC CIRCUIT NO.
	05		PI	POWER CIRCUIT NO.

WARNING

1. This drawing is the sole copyright of Architects VISTAAR and should be used for the purpose expressly issued.

GENERAL NOTES

- All dimensions are in feet and inches.
- Do not scale this drawing follow written dimensions only.
- This drawing should be read in conjunction with other architectural and structural drawings.
- Any discrepancy in the drawing should be immediately brought to the notice of architect.

PROJECT TITLE

CITY PALM
BUILDING AT PLOT-E-84,JAGDAMBA
NAGAR-E,JAIPUR

DRAWING TITLE

BASEMENT FLOOR WALL ELECTRICAL PLAN

ARCHITECTS :

VISTAAR ARCHITECTS &
PLANNERS
Architects :: Interior Designers
B-2/12, Chitrkoot scheme,
main Gandhi Path,Opp mall of jaipur,Jaipur
PH. - 0141-4116461,09001010366

PATH :-

DRN.

DATE


REV.

NORTH

SCALE


JOB NO.

N.T.S

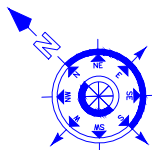

For R K Builders & Developers
21/9/21
Proprietor

Krishna
KRISHNA KUMAR
B. Tech. (Mechanical)
M.E.P Consultant

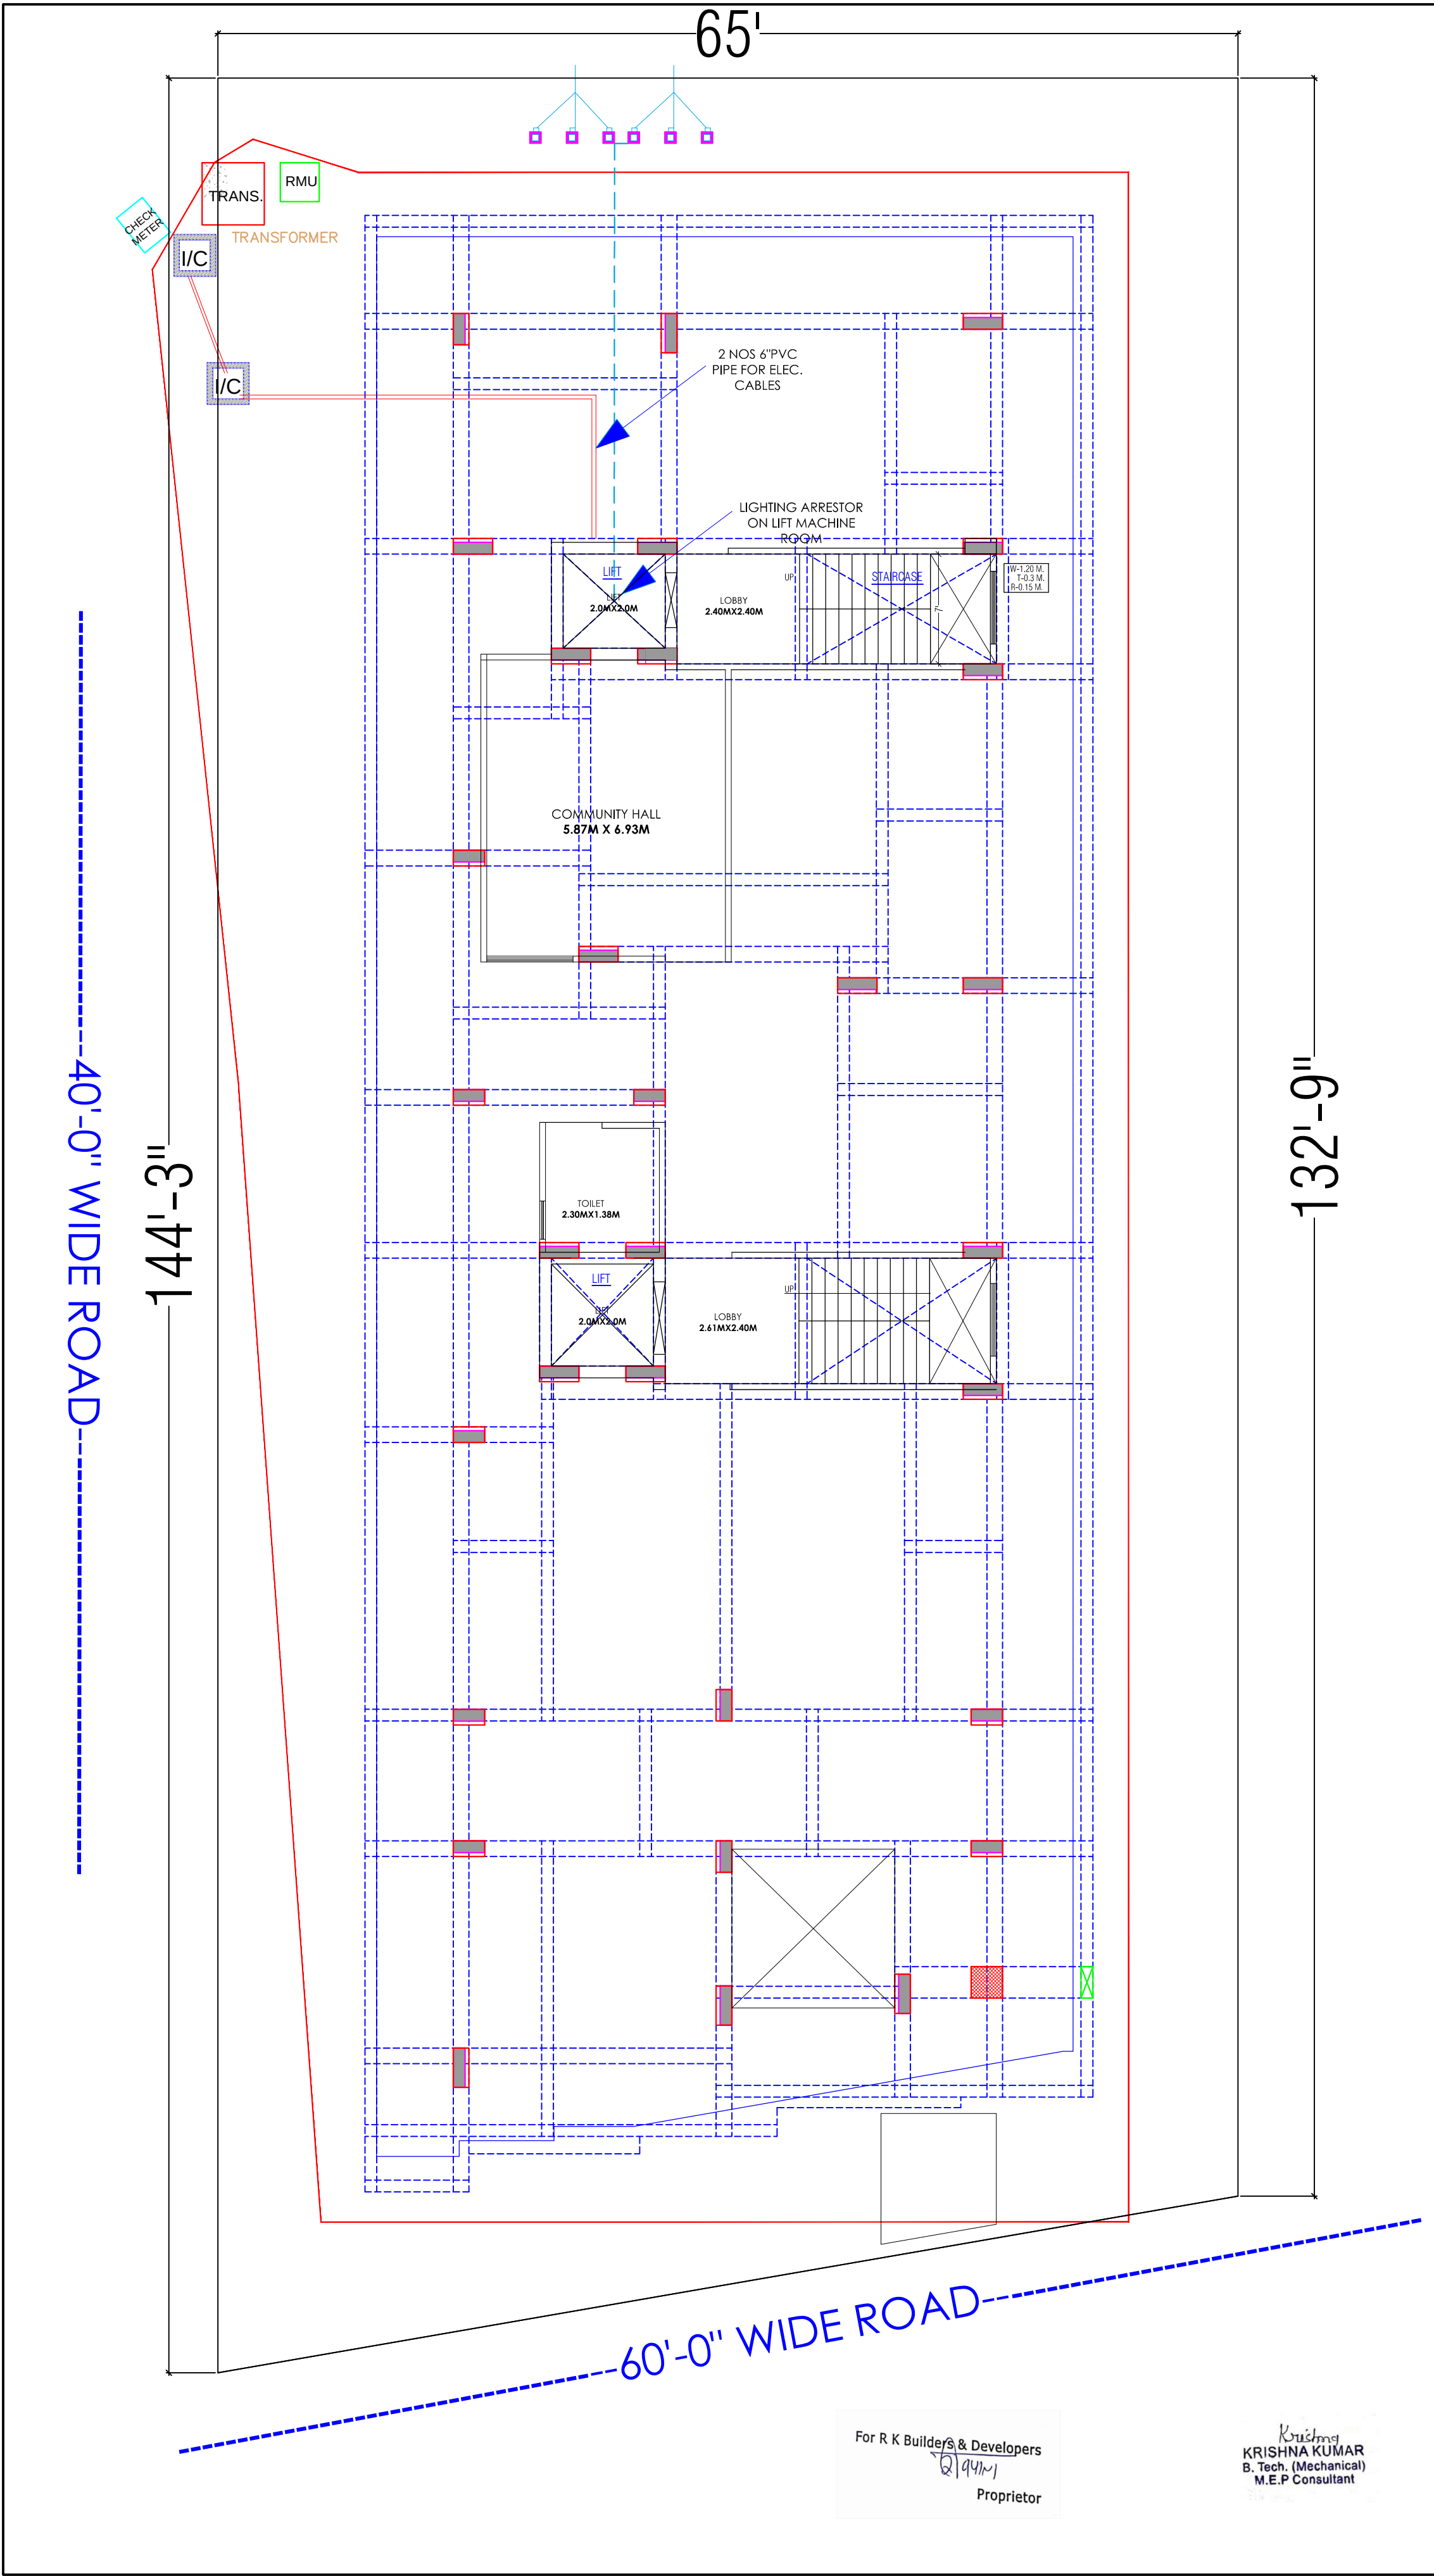

WARNING

1. This drawing is the sole copyright of Architects **VISTAAR** and should be used for the purpose expressly issued.

GENERAL NOTES

1. All dimensions are in feet and inches.
2. Do not scale this drawing follow written dimensions only.
3. This drawing should be read in conjunction with other architectural and structural drawings.
4. Any discrepancy in the drawing should be immediately brought to the notice of architect.

PROJECT TITLE

CITY PALM
BUILDING AT PLOT-E-84,JAGDAMBA
NAGAR-E,JAIPUR

DRAWING TITLE

PROPOSED STILT FLOOR ELECTRIC
SUB-STATION CABLE ROUTE & LIGHTING
AREESTER & EARTHING PLAN

ARCHITECTS :

**VISTAAR ARCHITECTS &
PLANNERS**

Architects :: Interior Designers
B-2/12, Chitrkoot scheme,
main Gandhi Path,Opp mall of jaipur,Jaipur
PH. - 0141-4116461,09001010366

PATH :-

DRN.

DATE


REV.

NORTH

SCALE

JOB NO.

N.T.S

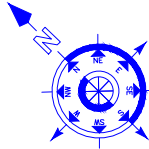

For R K Builders & Developers
Proprietor

Krishna
KRISHNA KUMAR
B. Tech. (Mechanical)
M.E.P Consultant


40'-0" WIDE ROAD

144'-3"

65'

132'-9"

60'-0" WIDE ROAD

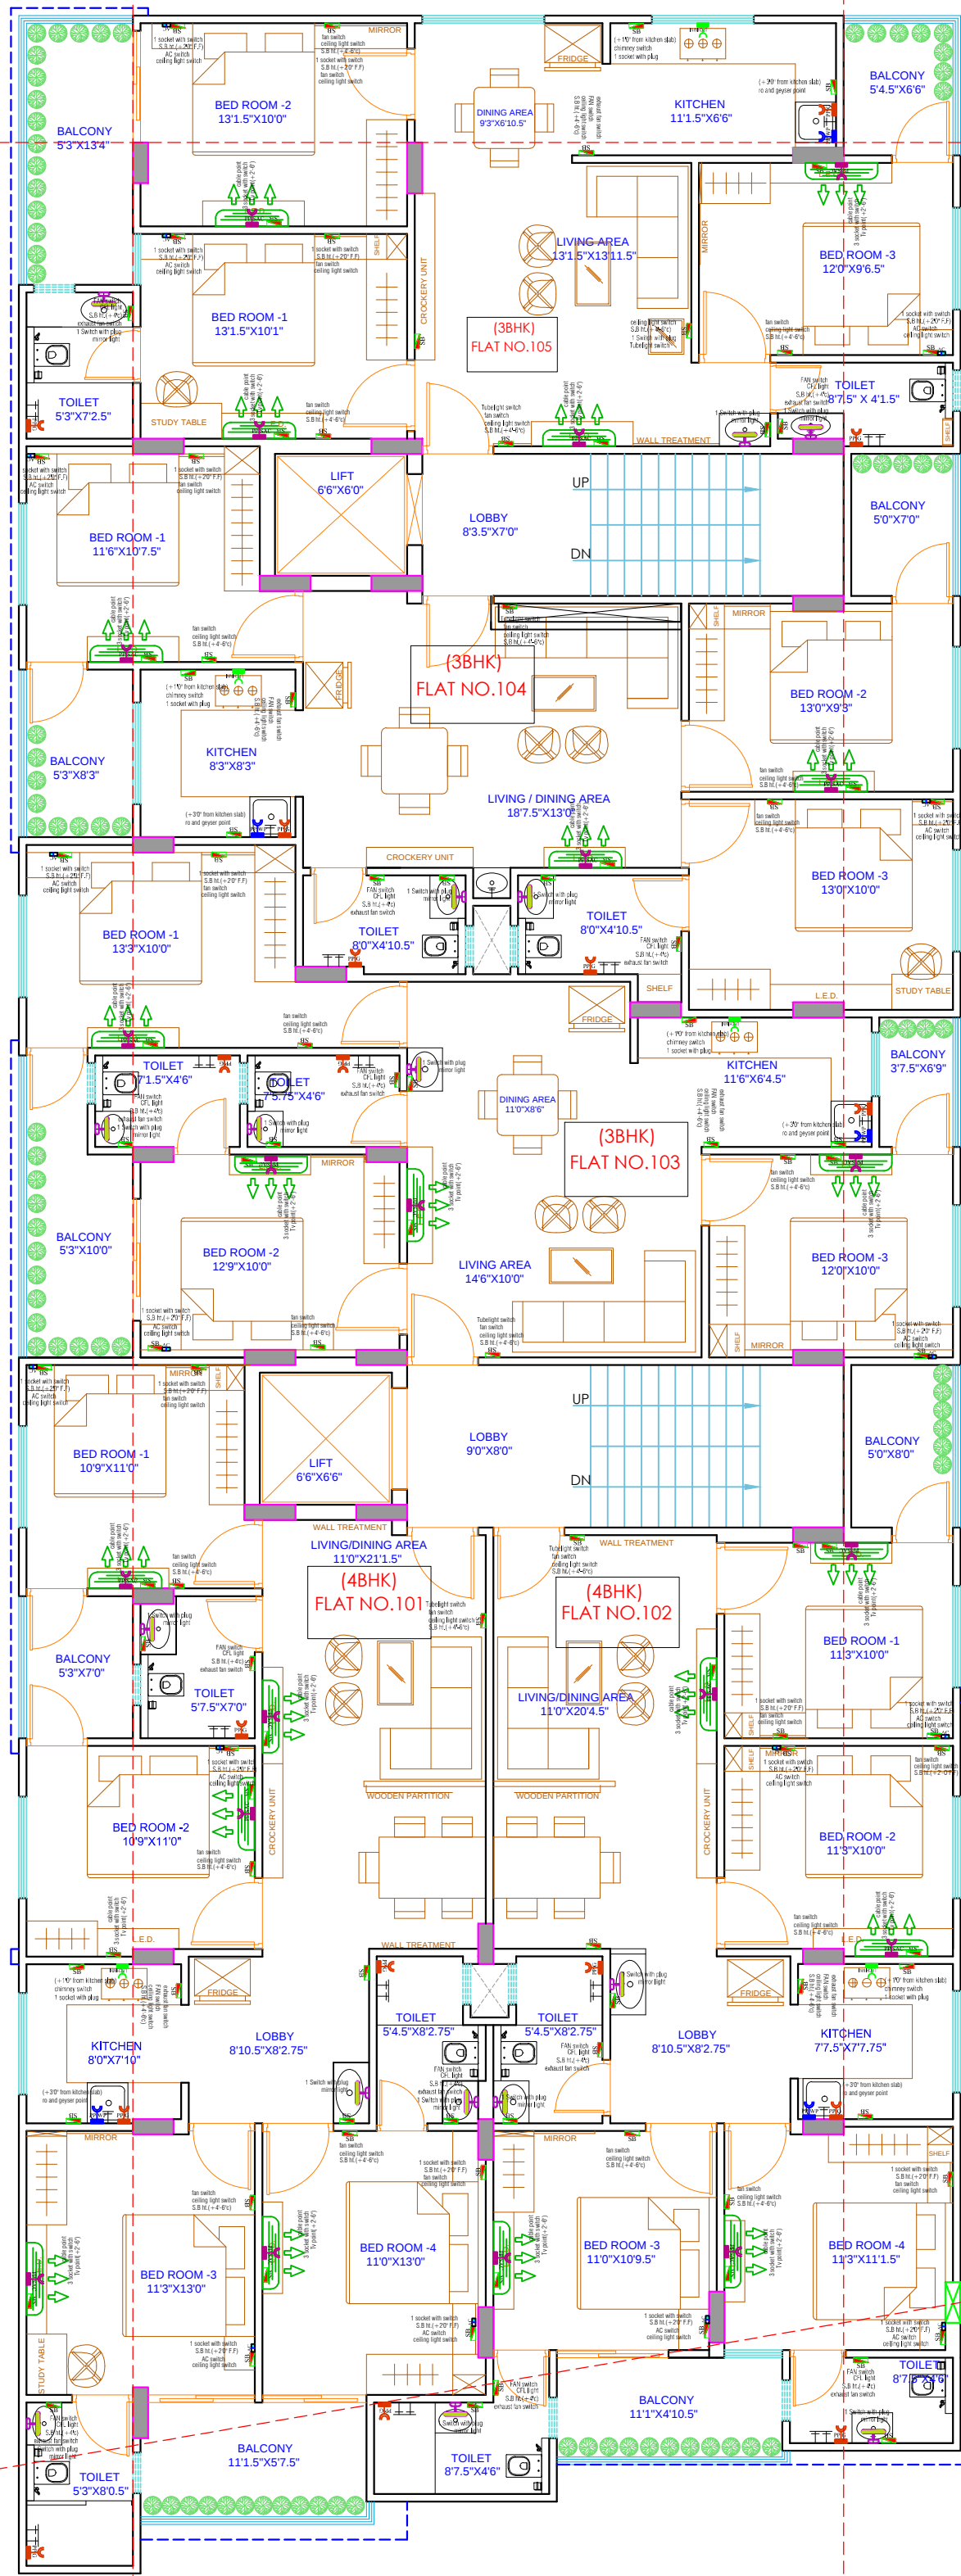

For R K Builders & Developers
Proprietor

Krishna
KRISHNA KUMAR
B. Tech. (Mechanical)
M.E.P Consultant

LEGENDS:				
Mounting Height	No.	I D	Symbol	Description
IN FLOOR				CONTROL WIRING
IN CONDUIT				CONTROL WIRING
IN CONDUIT				AC CONTROL WIRING
IN CONDUIT				GEYSER CONTROL WIRING
IN CONDUIT				BUZZER CONTROL WIRING
CEILING	06	FAN/48"		CEILING FAN 48"
CEILING	02	FAN/30"		CEILING FAN 30"
+90"	04	TL		1X40W WALL TUBELIGHT
+90"	04	BULB		WALL BRACKETS AS DESIGN LIGHT
+90"	01	GL		WALL BRACKETS AS DESIGN FOR GANESH LIGHT
	02	GL		WALL BRACKETS AS DESIGN FOR GATE LIGHT
CEILING	21	CFL		CFL CEILING LIGHT
+21"	02	FL		FOOT LIGHT
+48"	14	SB		SWITCH BOARD
+75"	03	ML		1 X 11 W CFL MIRROR LIGHT
VENTILATOR HT	03	CR		CEILING ROSE
VENTILATOR HT	03	EXP		9" DIA FRESH AIR FAN
+24"	02	TEL		TELEPHONE POINT
+27"	03	TV		TV COAXIAL POINT
+24"	02	LP TEL		G A PLUG POINT FOR TELEPHONE
+27"	03	LP TV		G A PLUG POINT FOR TV
+24"	02	LP		G A PLUG POINT
+72"	01	LP-CH		G A PLUG POINT FOR CHIMNEY
+102"	03	SAC		SPILT AC
+102"	03	PP-SAC		25 A POWER POINT FOR SPILT AC
+42"	01	PP-MIX		15 A POWER POINT FOR MIXER
+78"	02	PP-G		15 A POWER POINT FOR GEYSER
+54"	01	PP-F		15 A POWER POINT FOR FRIDGE
+78"	01	PP-WP		15 A POWER POINT FOR WATER PURIFIER
+48"	01	PP-WM		15 A POWER POINT FOR WASHING MACHINE
+42"	02	BP		BELL PUSH SWITCH
+90"	01	BZ		BUZZER POINT
+24"	03	AC		AC STARTER
+60"	01	MCB DB		MCB DISTRIBUTION BOARD
	05		SB/L/L	SWITCH BOARD NO./ LIGHT CIRCUIT NO.
	03		AC	AC CIRCUIT NO.
	05		PI	POWER CIRCUIT NO.

WARNING

1. This drawing is the sole copyright of Architects **VISTAAR** and should be used for the purpose expressly issued.

GENERAL NOTES

1. All dimensions are in feet and inches.
2. Do not scale this drawing follow written dimensions only.
3. This drawing should be read in conjunction with other architectural and structural drawings.
4. Any discrepancy in the drawing should be immediately brought to the notice of architect.

PROJECT TITLE

CITY PALM
BUILDING AT PLOT-E-84,JAGDAMBA
NAGAR-E,JAIPUR

DRAWING TITLE

GROUND TO 4TH FLOOR WALL ELECTRICAL PLAN

ARCHITECTS :

VISTAAR ARCHITECTS & PLANNERS

Architects :: Interior Designers
B-2/12, Chitrkoot scheme,
main Gandhi Path, Opp mall of jaipur,Jaipur
PH. - 0141-4116461,09001010366

PATH :-

DRN.

DATE


REV.

NORTH

SCALE

JOB NO.

N.T.S

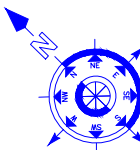


40'-0" WIDE ROAD

144'-3"

65'

132'-9"

60'-0" WIDE ROAD

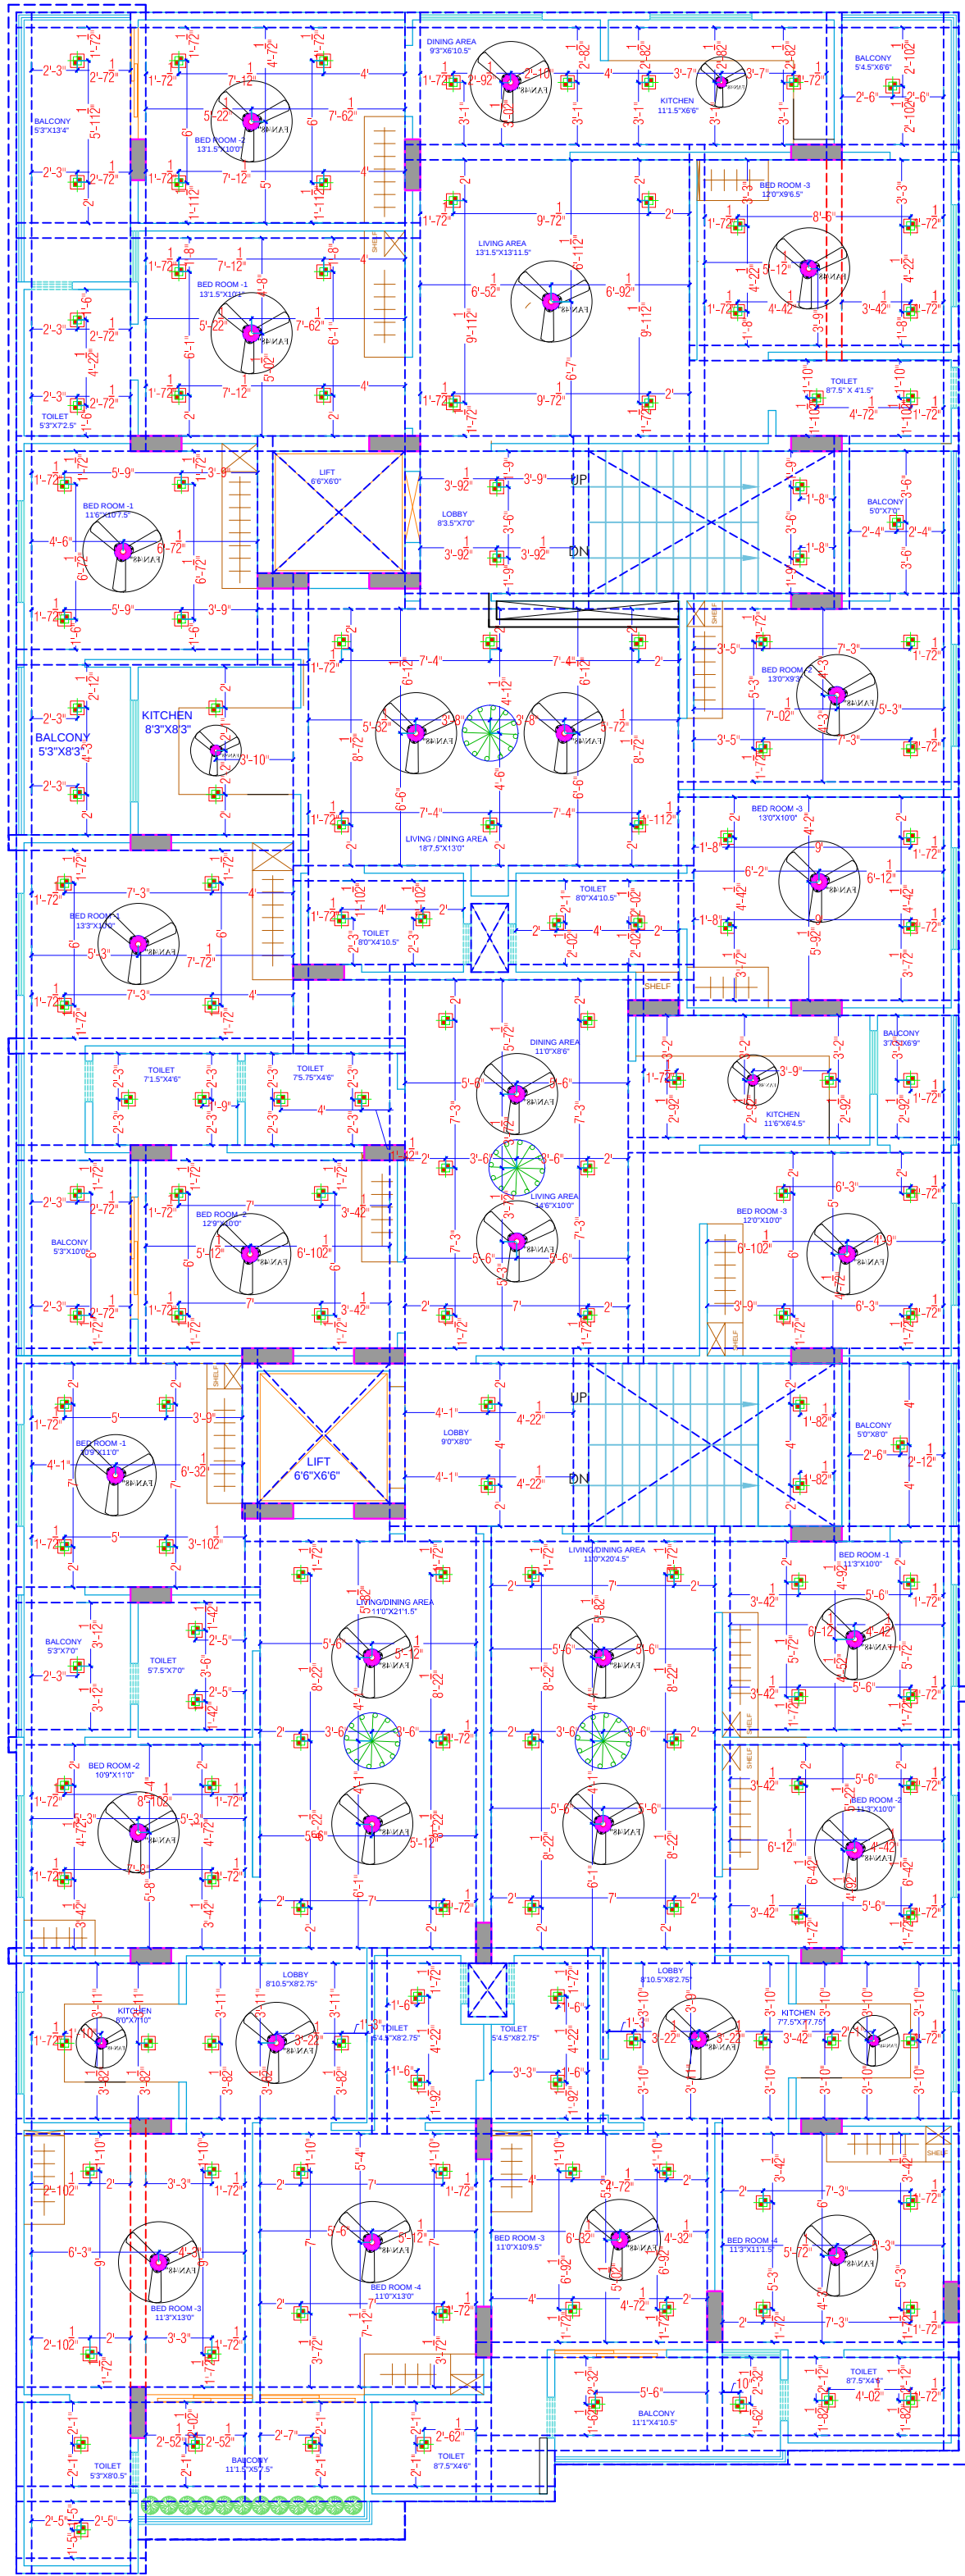

LEGENDS:				
Mounting Height	No.	ID	Symbol	Description
IN FLOOR				CONTROL WIRING
IN CONDUIT				CONTROL WIRING
IN CONDUIT				AC CONTROL WIRING
IN CONDUIT				GYSER CONTROL WIRING
IN CONDUIT				BUZZER CONTROL WIRING
CEILING	06	FAN/48"		CEILING FAN 48"
CEILING	02	FAN/30"		CEILING FAN 30"
+90"	04	TL		1X40W WALL TUBELIGHT
+90"	04	BULB		WALL BRACKETS AS DESIGN LIGHT
+90"	01	GL		WALL BRACKETS AS DESIGN FOR GANESH LIGHT
	02	GL		WALL BRACKETS AS DESIGN FOR GATE LIGHT
CEILING	21	CFL		CFL CEILING LIGHT
+21"	02	FL		FOOT LIGHT
+48"	14	SB		SWITCH BOARD
+75"	03	ML		1 X 11" W CFL MIRROR LIGHT
VENTILATOR HT.	03	CR		CEILING ROSE
VENTILATOR HT.	03	EXP		9" DIA FRESH AIR FAN
+24"	02	TEL		TELEPHONE POINT
+27"	03	TV		TV COAXIAL POINT
+24"	02	LP TEL		6 A PLUG POINT FOR TELEPHONE
+27"	03	LP TV		6 A PLUG POINT FOR TV
+24"	02	LP		6 A PLUG POINT
+72"	01	LP-CH		6 A PLUG POINT FOR CHIMNEY
+102"	03	SAC		SPILT AC
+102"	03	PP-SAC		25 A POWER POINT FOR SPILT AC
+42"	01	PP-MIX		15 A POWER POINT FOR MIXER
+78"	02	PP-G		15 A POWER POINT FOR GEYSER
+54"	01	PP-F		15 A POWER POINT FOR FRIDGE
+78"	01	PP-WP		15 A POWER POINT FOR WATER PURIFIER
+48"	01	PP-WM		15 A POWER POINT FOR WASHING MACHINE
+42"	02	BP		BELL PUSH SWITCH
+90"	01	BZ		BUZZER POINT
+24"	03	AC		AC STARTER
+60"	01	MCB DB		MCB DISTRIBUTION BOARD
	05		SBL/L	SWITCH BOARD NO./ LIGHT CIRCUIT NO.
	03		ACI	AC CIRCUIT NO.
	05		PI	POWER CIRCUIT NO.

WARNING

1. This drawing is the sole copyright of Architects VISTAAR and should be used for the purpose expressly issued.

GENERAL NOTES

- All dimensions are in feet and inches.
- Do not scale this drawing follow written dimensions only.
- This drawing should be read in conjunction with other architectural and structural drawings.
- Any discrepancy in the drawing should be immediately brought to the notice of architect.

PROJECT TITLE

CITY PALM
BUILDING AT PLOT-E-84,JAGDAMBA
NAGAR-E,JAIPUR

DRAWING TITLE

GROUND TO 4TH FLOOR ELECTRICAL PLAN

ARCHITECTS :

VISTAAR ARCHITECTS &
PLANNERS
Architects :: Interior Designers
B-2/12, Chitrkoot scheme,
main Gandhi Path,Opp mall of jaipur,Jaipur
PH. - 0141-4116461,09001010366

PATH :-

DRN.

DATE


REV.

NORTH

SCALE


JOB NO.

N.T.S

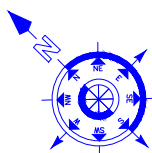

For R K Builders & Developers
21/9/2021
Proprietor

Krishna
KRISHNA KUMAR
B. Tech. (Mechanical)
M.E.P Consultant

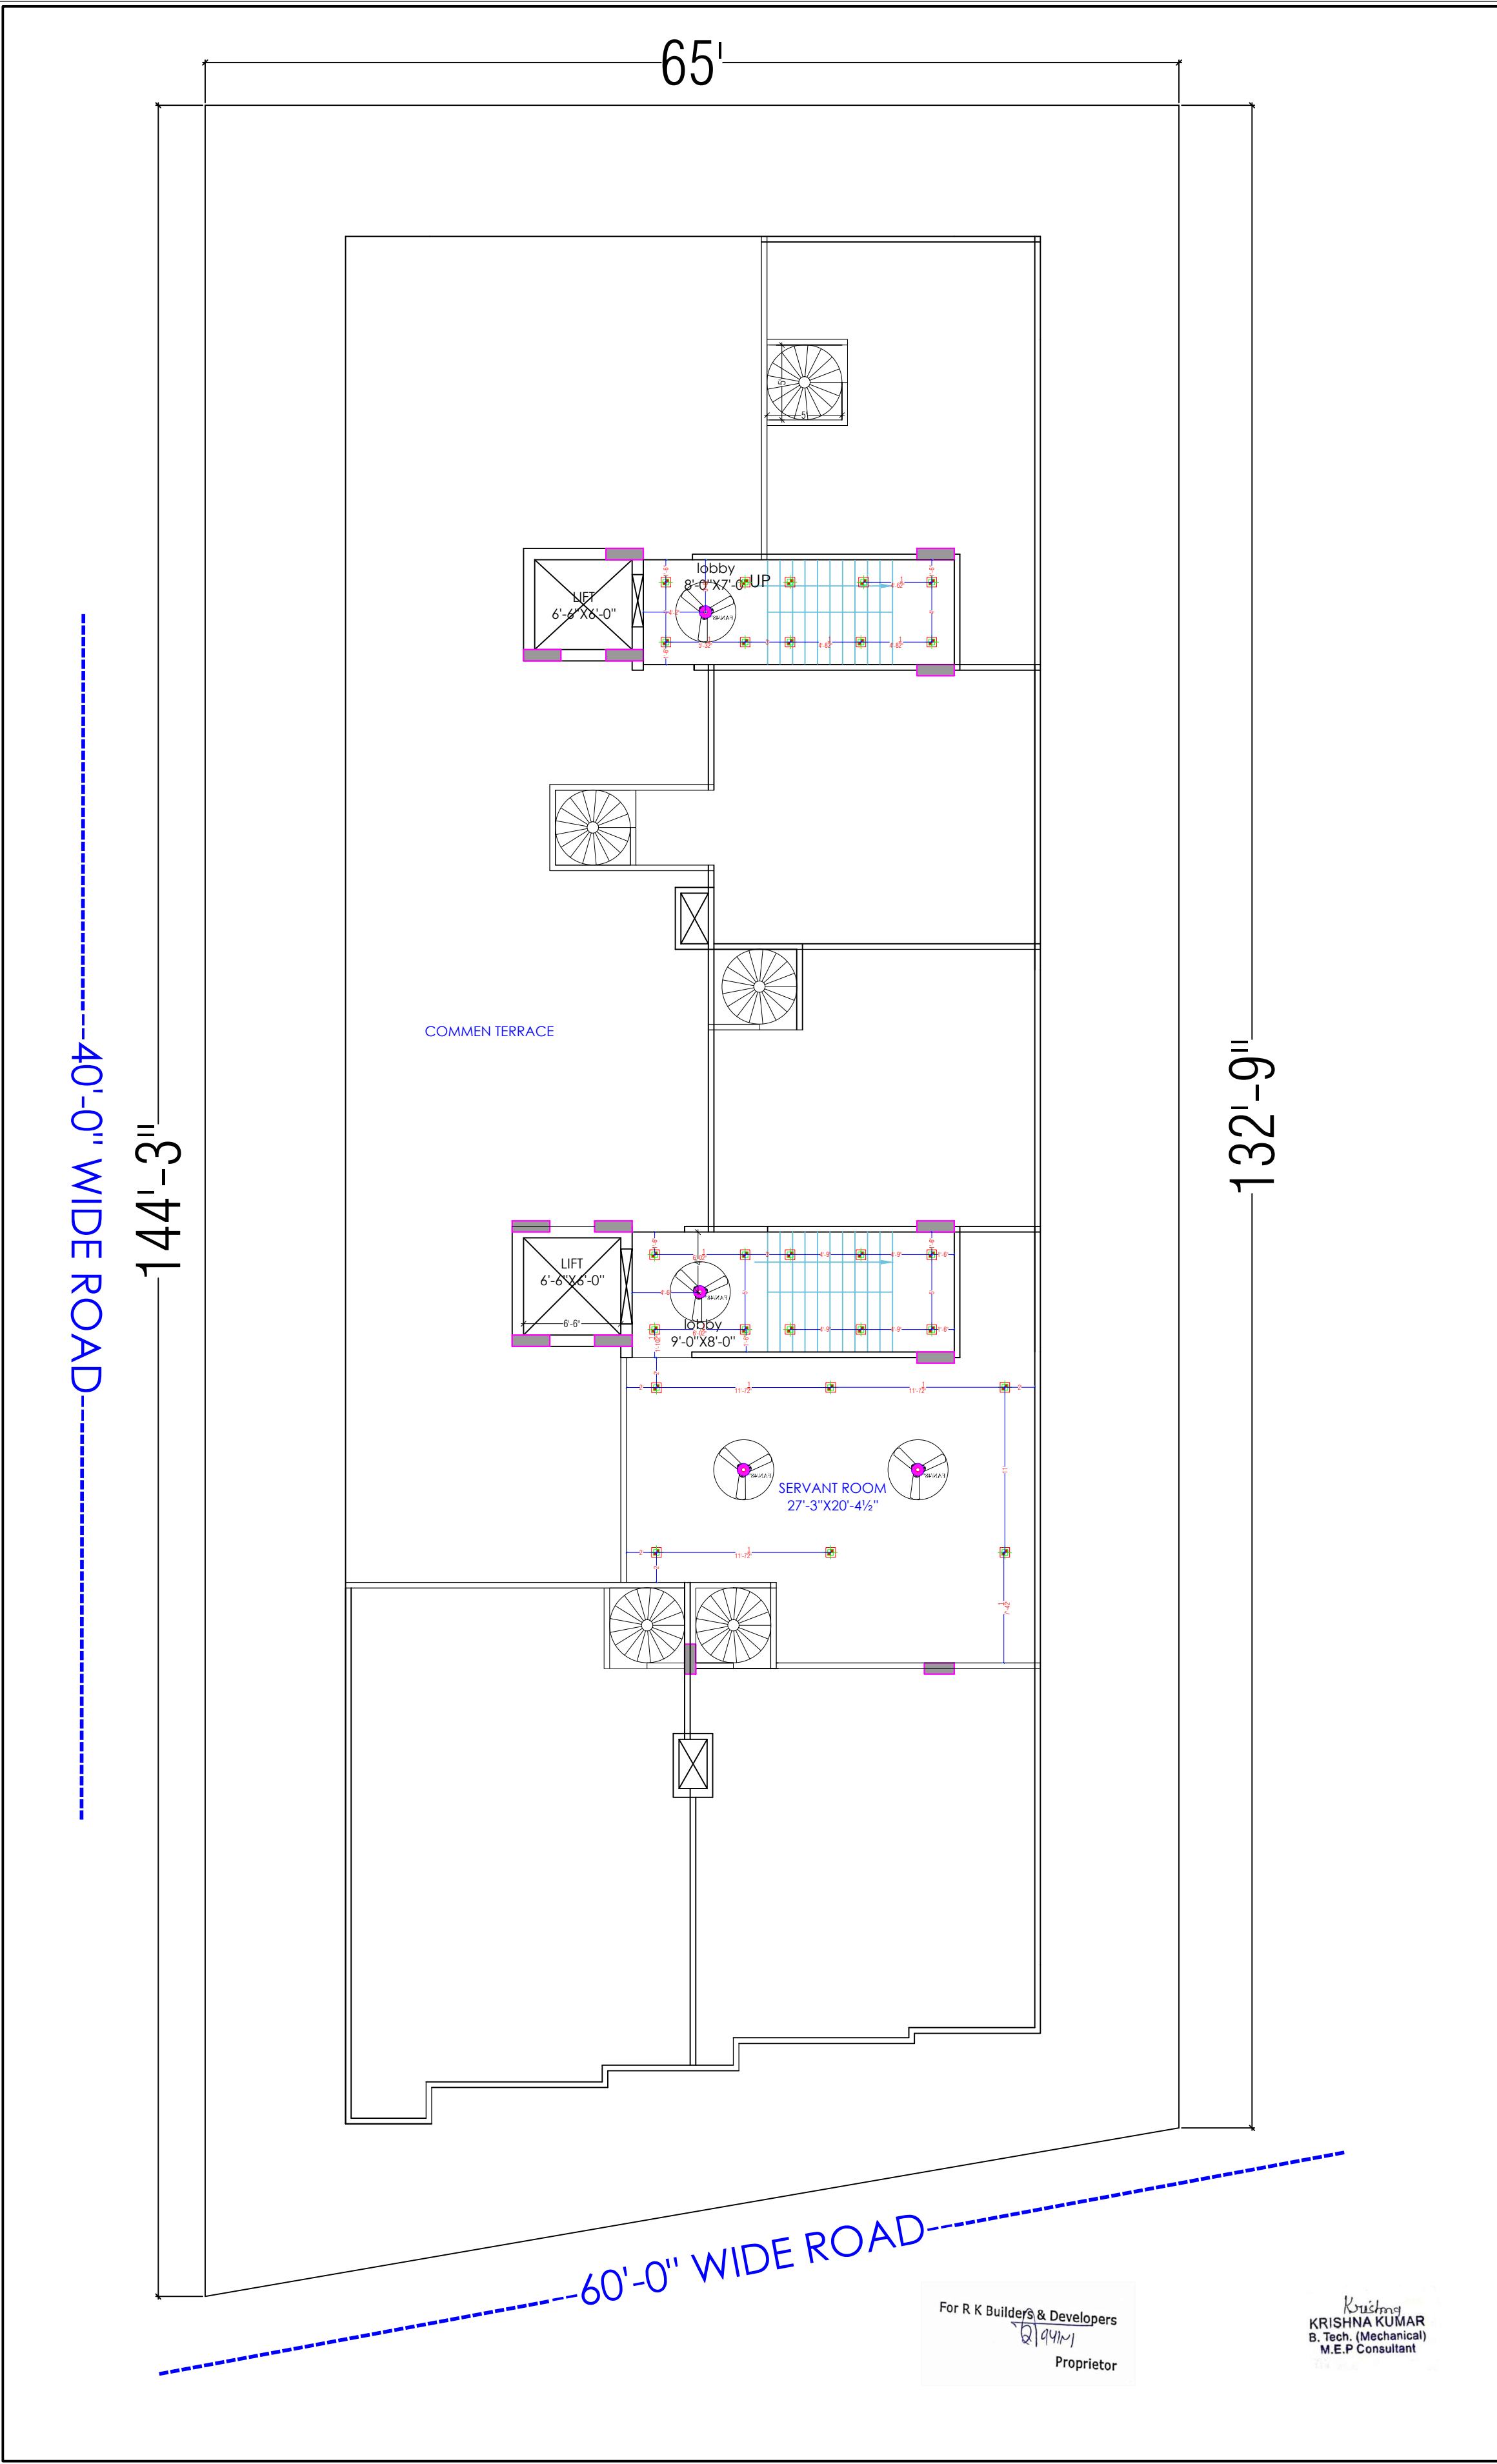

LEGENDS:				
Mounting Height	No.	I D	Symbol	Description
IN FLOOR				CONTROL WIRING
IN CONDUIT				CONTROL WIRING
IN CONDUIT				AC CONTROL WIRING
IN CONDUIT				GEYSER CONTROL WIRING
IN CONDUIT				BUZZER CONTROL WIRING
CEILING	FAN/48"			CEILING FAN 48"
CEILING	FAN/30"			CEILING FAN 30"
+90"	TL			1X40W WALL TUBELIGHT
+90"	BULB			WALL BRACKETS AS DESIGN LIGHT
+90"	GL			WALL BRACKETS AS DESIGN FOR GANESH LIGHT
	GL			WALL BRACKETS AS DESIGN FOR GATE LIGHT
CEILING	CFL			CFL CEILING LIGHT
+21"	FL			FOOT LIGHT
+48"	SB			SWITCH BOARD
+7'0"	ML			1 X 11 W CFL MIRROR LIGHT
VENTILATOR HT.	CR			CEILING ROSE
VENTILATOR HT.	EXF			8" DIA FRESH AIR FAN
+24"	TEL			TELEPHONE POINT
+27"	TV			TV COAXIAL POINT.
+27"	LP-TV			6 A PLUG POINT FOR TV
+72"	LP-CH			6 A PLUG POINT FOR CHIMNEY
+102"	SAC			SPUT AC
+102"	PP-SAC			25 A POWER POINT FOR SPUT AC
+42"	PP-MIX			15 A POWER POINT FOR MIXER
+78"	PP-G			15 A POWER POINT FOR GEYSER
+54"	PP-F			15 A POWER POINT FOR FRIDGE
+78"	PP-WP			15 A POWER POINT FOR WATER PURIFIER
+48"	PP-WM			15 A POWER POINT FOR WASHING MACHINE
+42"	BP			BELL PUSH SWITCH
+90"	BZ			BUZZER POINT
+48"	AC			AC STARTER
+60"	MCB DB			MCB DISTRIBUTION BOARD

WARNING

1. This drawing is the sole copyright of Architects VISTAAR and should be used for the purpose expressly issued.

GENERAL NOTES

- 1. All dimensions are in feet and inches.
- 2. Do not scale this drawing follow written dimensions only.
- 3. This drawing should be read in conjunction with other architectural and structural drawings.
- 4. Any discrepancy in the drawing should be immediately brought to the notice of architect.

PROJECT TITLE			
CITY PALM BUILDING AT PLOT-E-84,JAGDAMBA NAGAR-E,JAIPUR			
DRAWING TITLE			
TERRACE FLOOR CELING ELECTRICAL PLAN			
ARCHITECTS :			
VISTAAR ARCHITECTS & PLANNERS Architects :: Interior Designers B-2/12, Chitrkoot scheme, main Gandhi Path,Opp mall of jaipur,Jaipur PH.- 0141-4116461,09001010366			
PATH :-			
DRN.	DATE	REV.	NORTH
MANOJ KUMAWAT	23-06-2023		
SCALE	JOB NO.		
N.T.S			

For R K Builders & Developers
21/9/23
Proprietor

Krishna
KRISHNA KUMAR
B. Tech. (Mechanical)
M.E.P Consultant

40'-0" WIDE ROAD


144'-3"

65'

132'-9"

COMMEN TERRACE

SERVANT ROOM
27'-3"X20'-4 1/4"

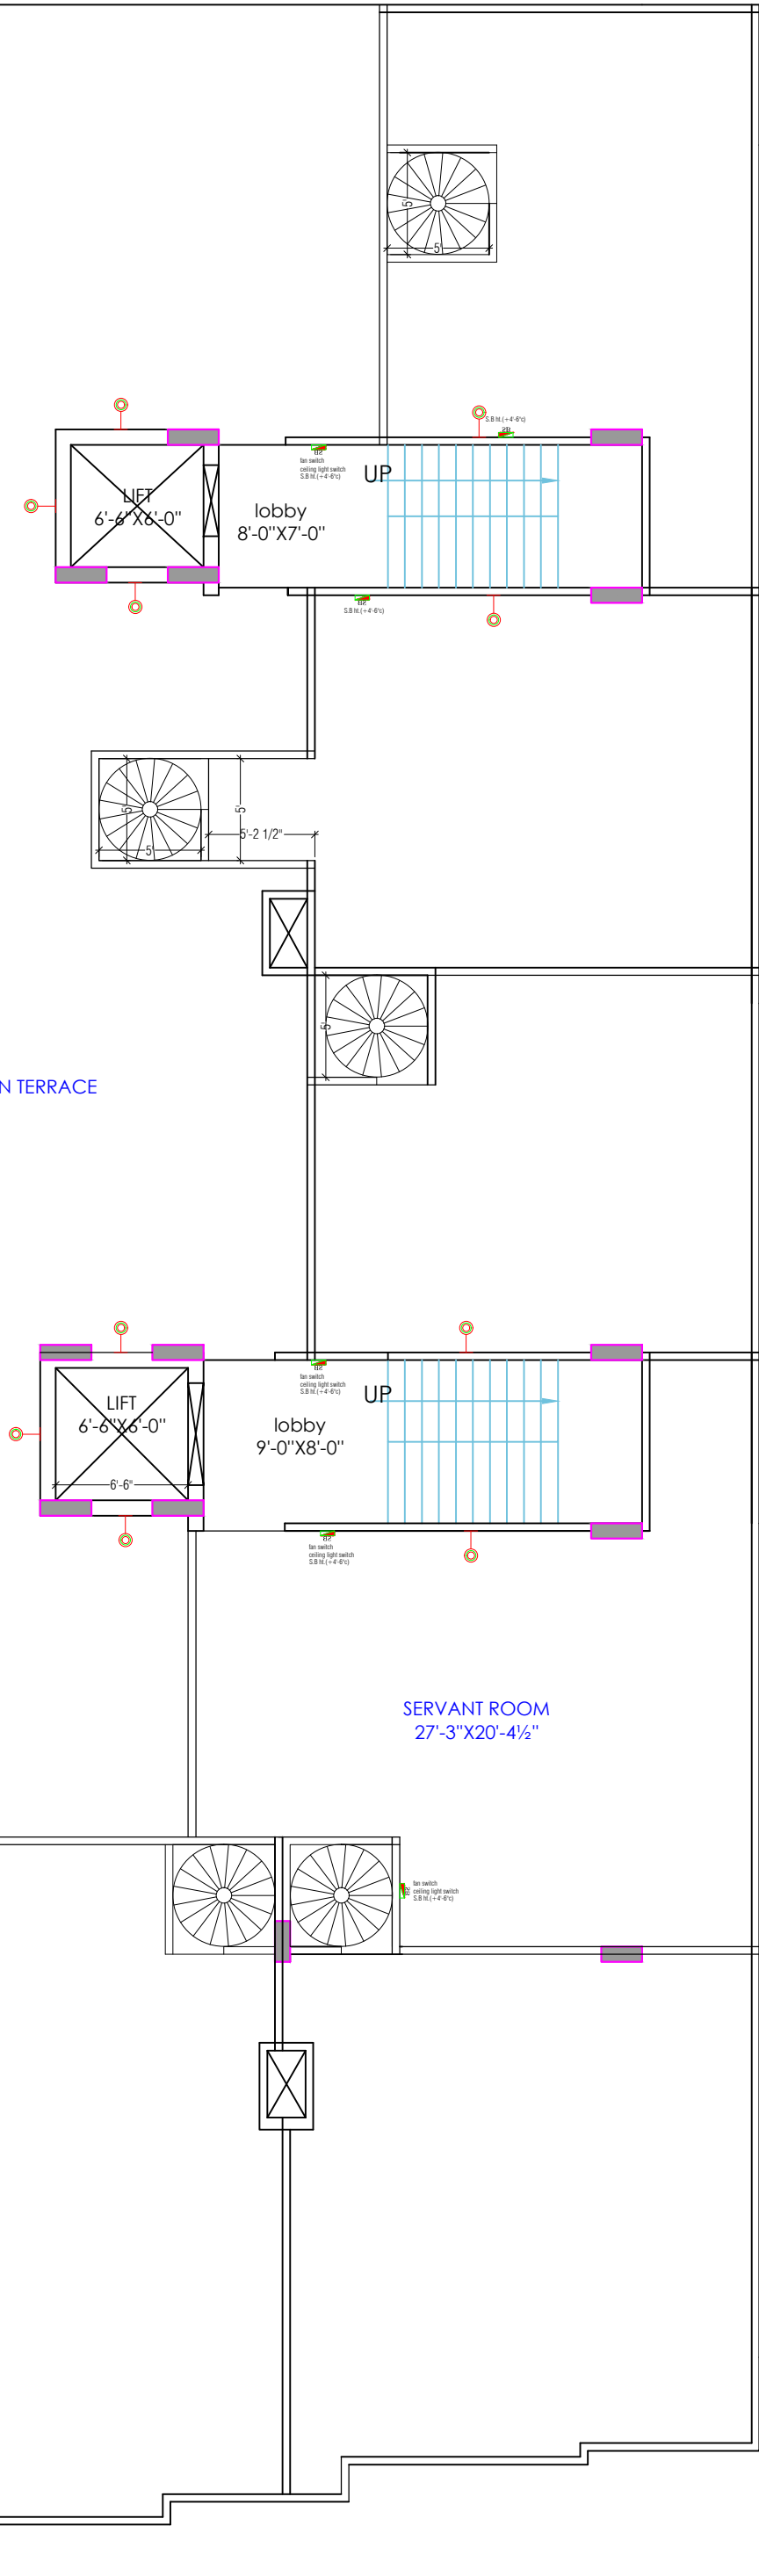

LEGENDS:				
Mounting Height	No.	I D	Symbol	Description
IN FLOOR			---	CONTROL WIRING
IN CONDUIT			---	CONTROL WIRING
IN CONDUIT			---	AC CONTROL WIRING
IN CONDUIT			---	GYSER CONTROL WIRING
IN CONDUIT			---	BUZZER CONTROL WIRING
CEILING	FAN/48"			CEILING FAN 48"
CEILING	FAN/30"			CEILING FAN 30"
+90"	TL			1X40W WALL TUBELIGHT
+90"	BULB			WALL BRACKETS AS DESIGN LIGHT
+90"	GL			WALL BRACKETS AS DESIGN FOR GANESH LIGHT
	GL			WALL BRACKETS AS DESIGN FOR GATE LIGHT
CEILING	CFL			CFL CEILING LIGHT
+21"	FL			FOOT LIGHT
+48"	SB			SWITCH BOARD
+7'0"	ML			1 X 11 W CFL MIRROR LIGHT
VENTILATOR HT.	CR			CEILING ROSE
VENTILATOR HT.	EXF			8" DIA FRESH AIR FAN
+24"	TEL			TELEPHONE POINT
+27"	TV			TV COAXIAL POINT
+27"	LP TV			6 A PLUG POINT FOR TV
+72"	LP-CH			6 A PLUG POINT FOR CHIMNEY
+102"	SAC			SPLIT AC
+102"	PP-SAC			25 A POWER POINT FOR SPLIT AC
+42"	PP-MIX			15 A POWER POINT FOR MIXER
+78"	PP-G			15 A POWER POINT FOR GEYSER
+54"	PP-F			15 A POWER POINT FOR FRIDGE
+78"	PP-WP			15 A POWER POINT FOR WATER PURIFIER
+48"	PP-WM			15 A POWER POINT FOR WASHING MACHINE
+42"	BP			BELL PUSH SWITCH
+90"	BZ			BUZZER POINT
+48"	AC			AC STARTER
+60"	MCB DB			MCB DISTRIBUTION BOARD

WARNING

1. This drawing is the sole copyright of Architects **VISTAAR** and should be used for the purpose expressly issued.

GENERAL NOTES

1. All dimensions are in feets and inches.
2. Do not scale this drawing follow written dimensions only.
3. This drawing should be read in conjunction with other architectural and structural drawings.
4. Any discripancy in the drawing should be immediately brought to the notice of architect.

PROJECT TITLE

CITY PALM
BUILDING AT PLOT-E-84,JAGDAMBA
NAGAR-E,JAIPUR

DRAWING TITLE

TERRACE FLOOR WALL ELECTRICAL PLAN

ARCHITECTS :

VISTAAR ARCHITECTS & PLANNERS
Architects :: Interior Designers
B-2/12, Chitrkoot scheme,
main Gandhi Path,Opp mall of jaipur,Jaipur
PH.- 0141-4116461,09001010366

PATH ::			
DRN.	DATE	REV.	NORTH
MANOJ KUMAWAT	23-06-2023		
SCALE	JOB NO.		
N.T.S			

For R K Builders & Developers
B. Tech. (Mechanical)
Proprietor

Krishna
KRISHNA KUMAR
B. Tech. (Mechanical)
M.E.P Consultant