

NO. OF UNITS = 552


open parking=241car
stilt parking=176car
podium parking=193 car

total car parking = 610 cars

scooter parking = 309

LEGEND :-

	INTERNAL HYDRANT WITH HOSE REEL
	YARD HYDRANT
	SLUICE VALVE
	BUTTER FLY VALVE
	NON RETURN VALVE
	FIRE BRIGADE INLET CONNECTION
	FIRE BRIGADE OUT-LET CONNECTION
	FOAM TYPE FIRE EXTINGUISHER
	ABC FIRE EXTINGUISHER
	ABC FIRE EXTINGUISHER
	HUME PIPE
	MANUAL CALL POINT & HOOTER
	SMOKE DETECTOR
	HEAT DETECTOR
	FIRE EXIT SIGN

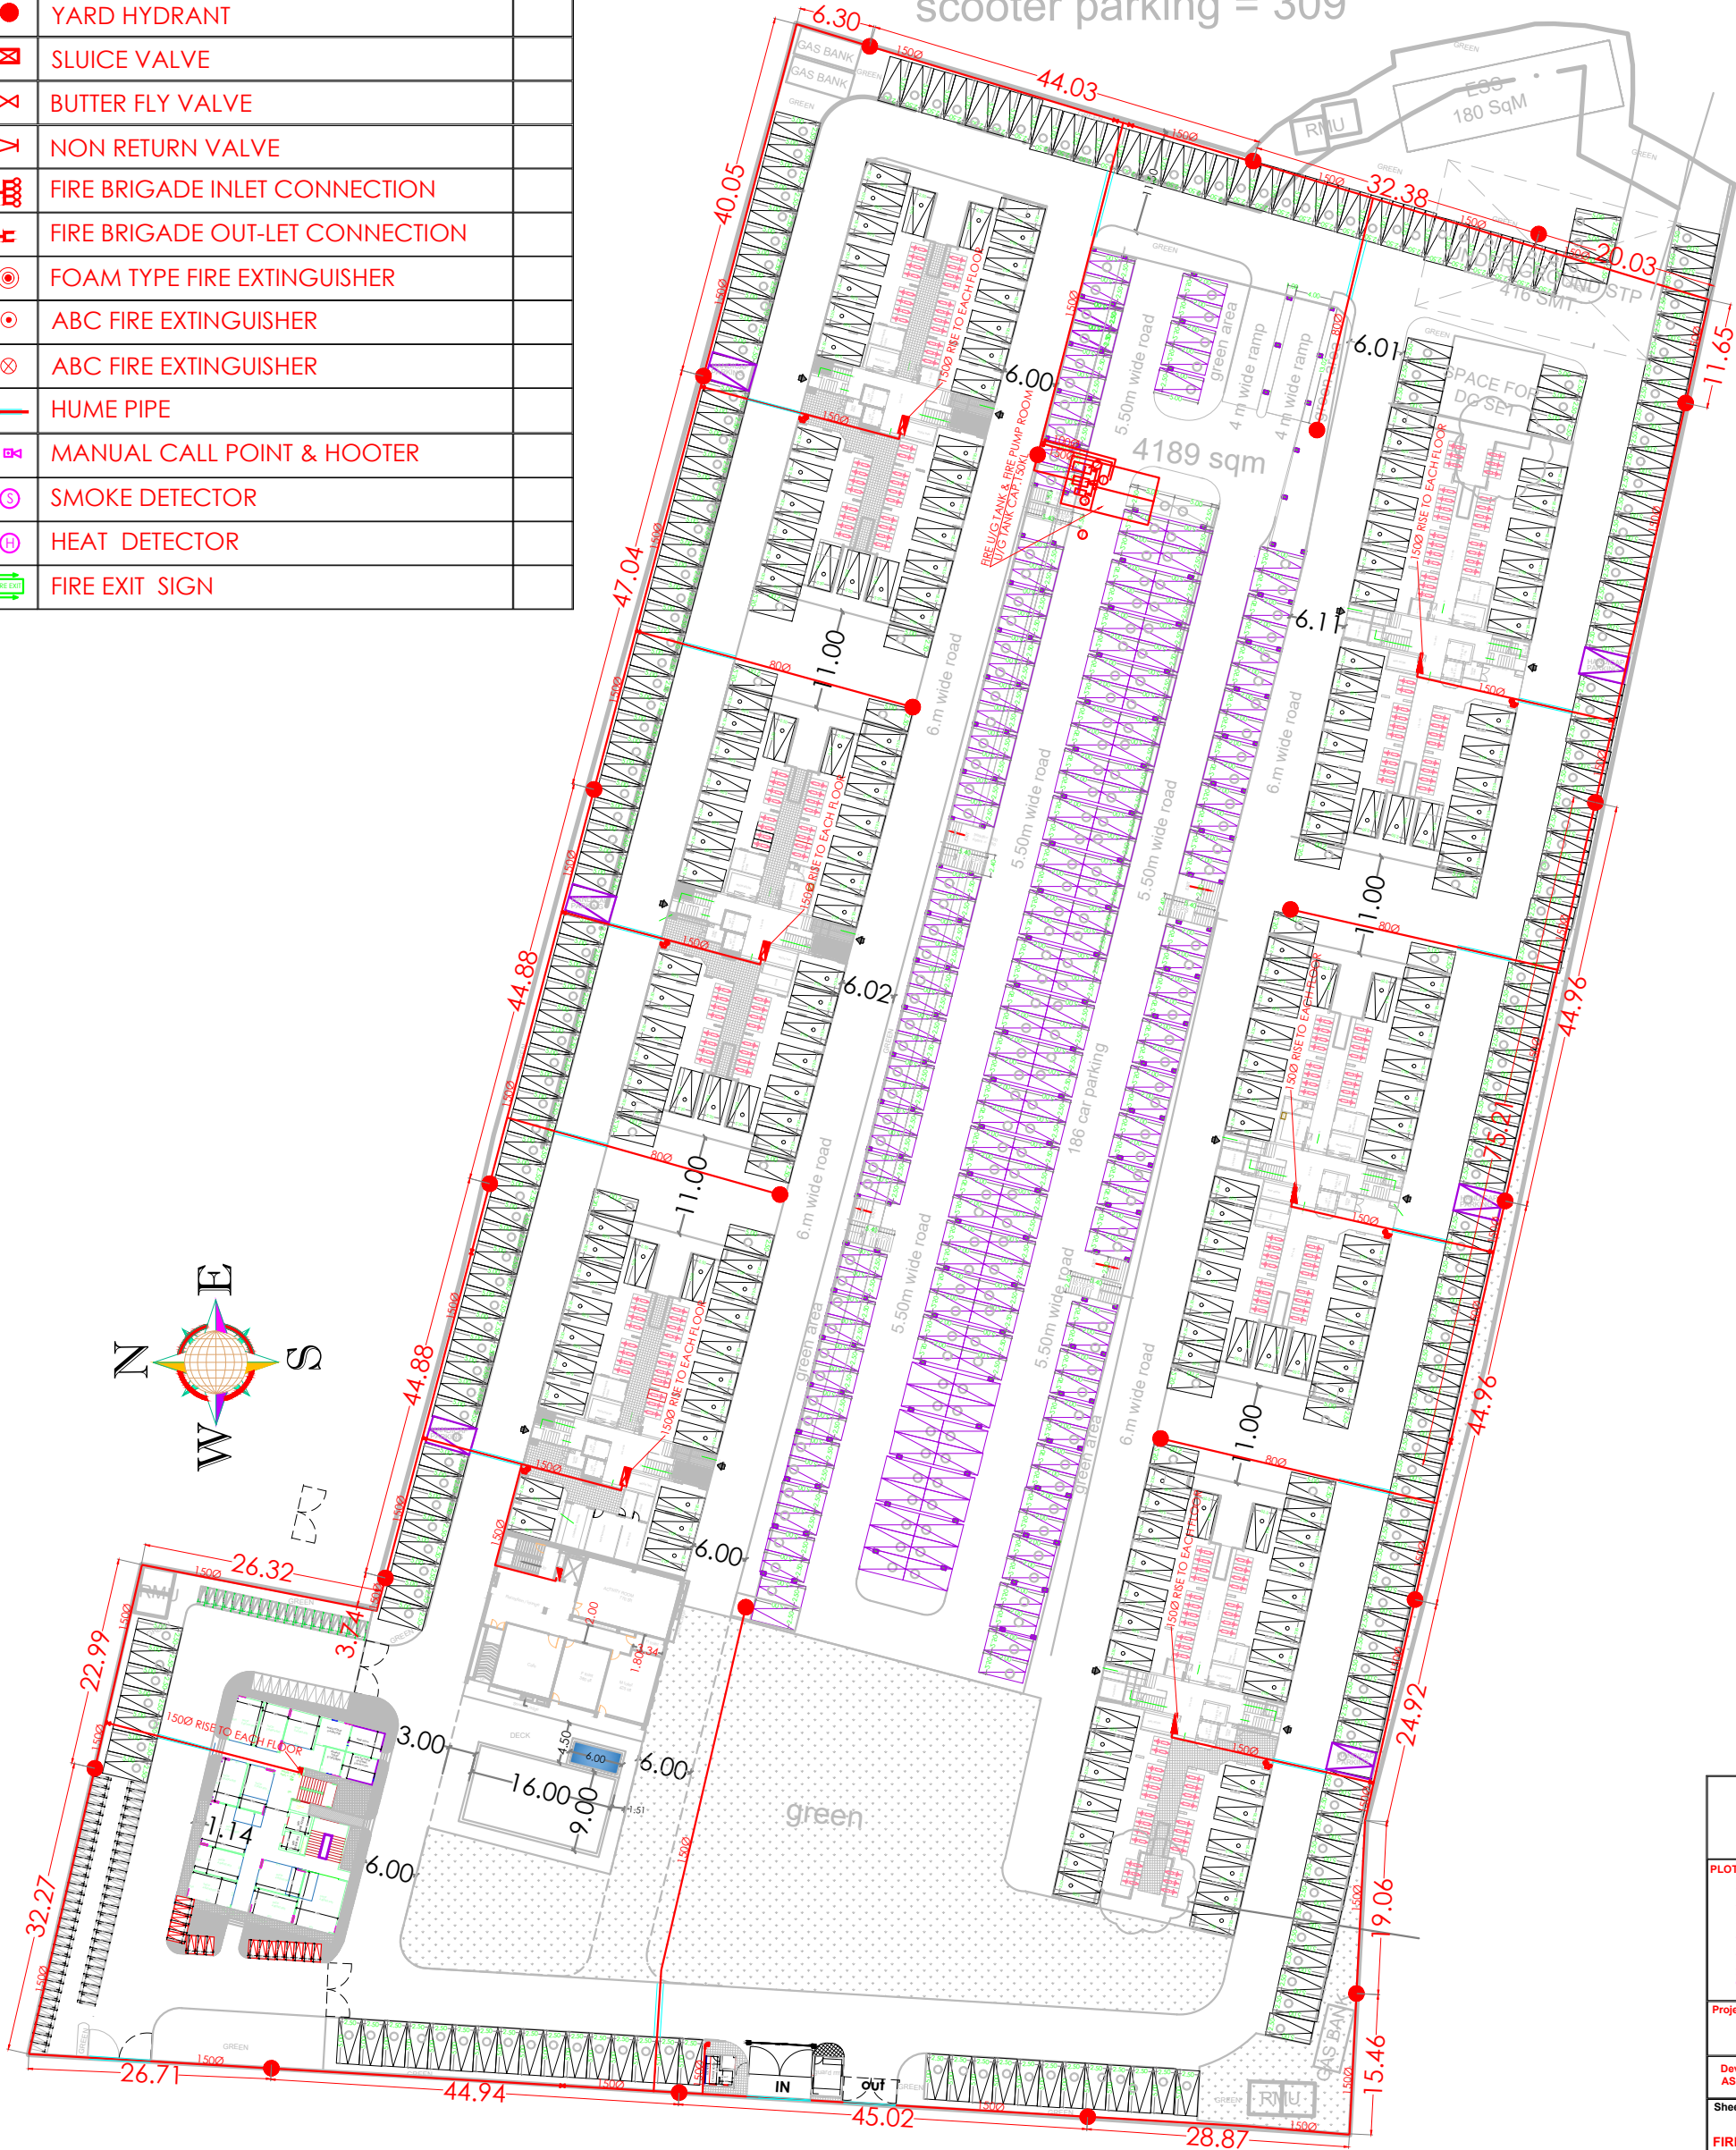

FIRE PUMPS:-

- 1 - 2280 LPM 90M HEAD AUTOMATIC ELECT. FIRE PUMP
- 2 - 2280 LPM 90M HEAD AUTOMATIC DIESEL. FIRE PUMP
- 3 - 180 LPM 90M HEAD AUTOMATIC ELECT. JOCKEY PUMP



Gulshan Khurana

PLOT DETAILS:-
Proposed Group Housing at Jaipur
Ashiana Housing Ltd
Khasra No.419,420,421,422,423,424,425,
426,427, 428,429,430, 431,432,433,434,
435,436 &437,
in Revenue Village Shri kishanpura
Teh. Sanganer, Jaipur

Project:
Ashiana Daksh at Jaipur

Developer:
ASHIANA HOUSING LTD

Sheet title:- FIRE FIGHTING LAYOUT	SITE PLAN
---	------------------

SCALE:- 1:175	NORTH variable/site plan
SIGNATURE OF AUTHORITY	SIGNATURE OF ARCHITECT