
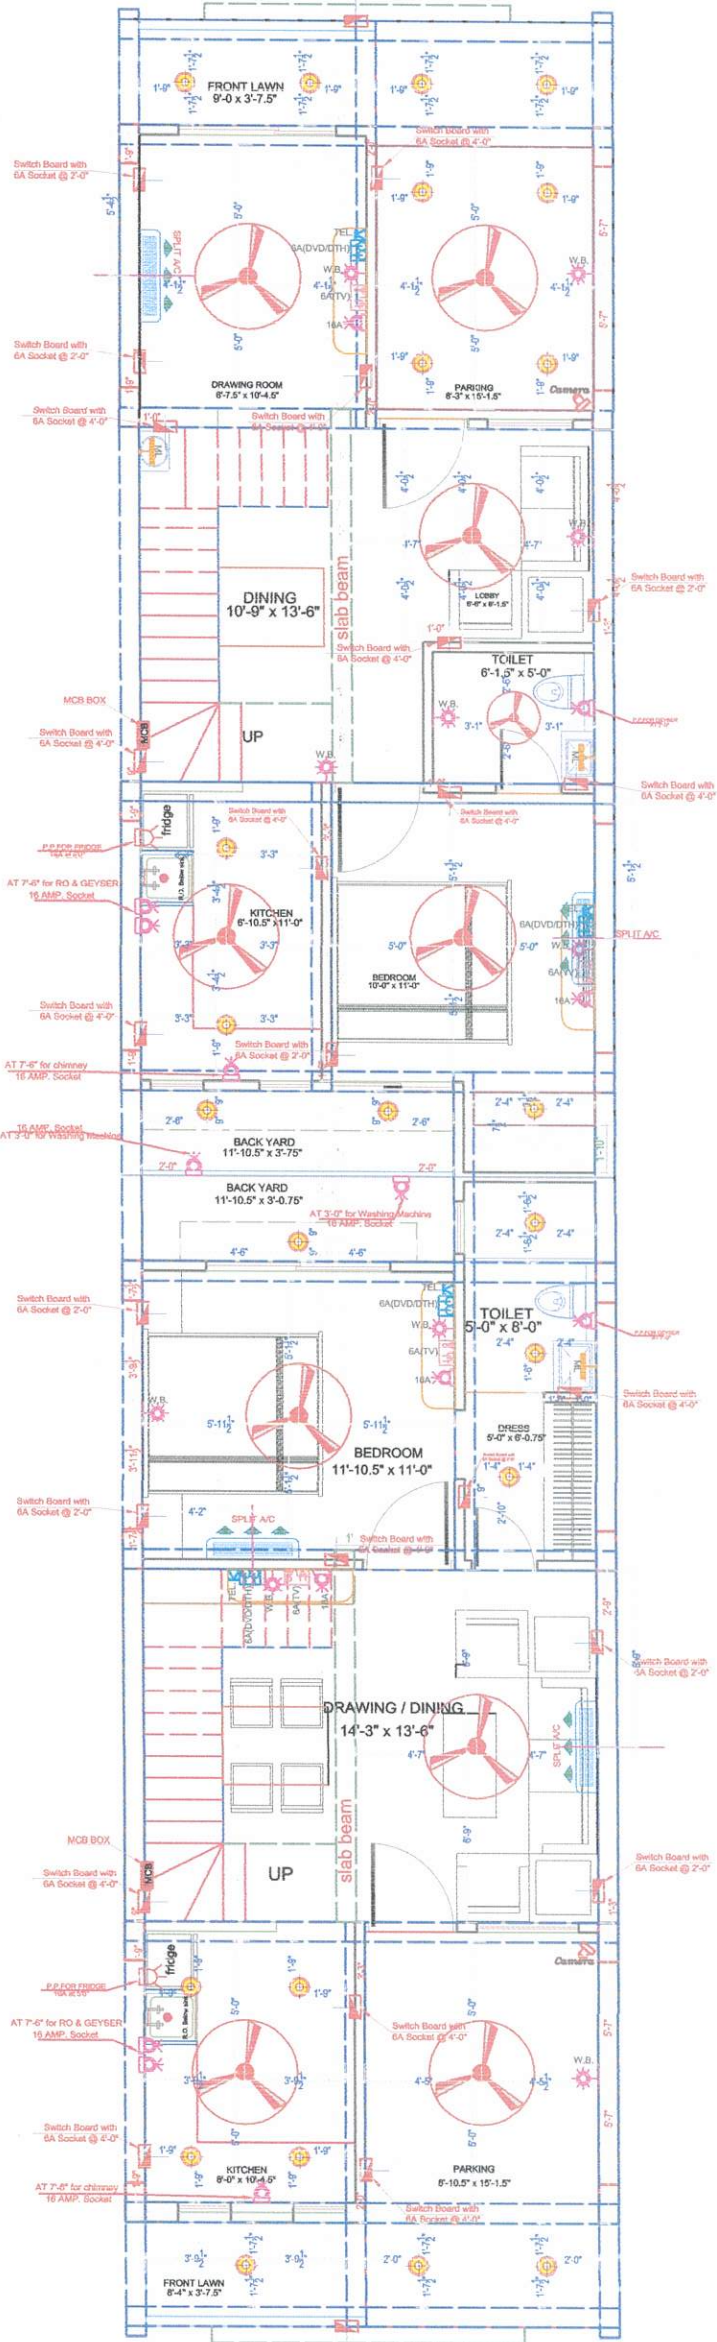
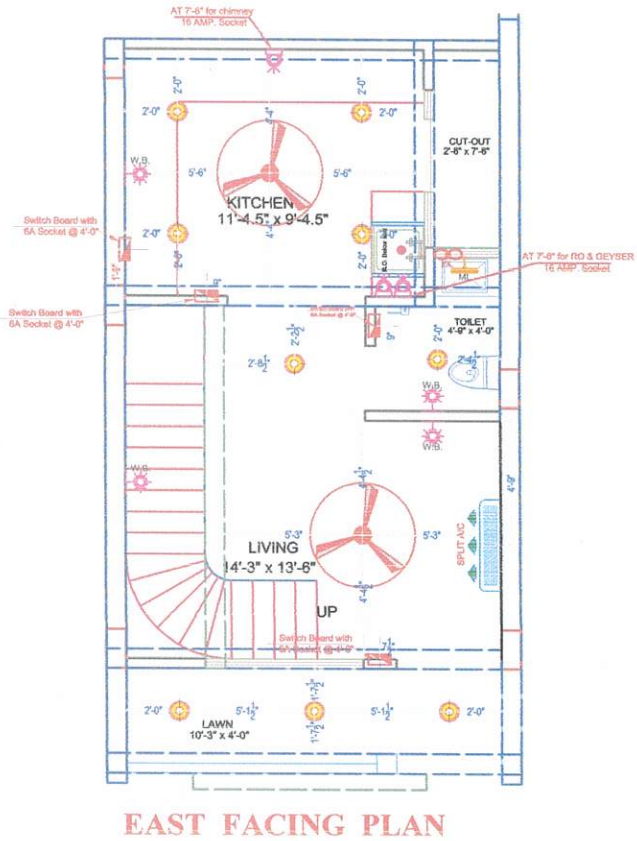



LEGEND	
NAME	SYMBOL
MIRROR LIGHT	
MCB	
WALL LIGHT	
BRACKET FAN	
CFL	
EXHAUST	
FAN	
CEILING LIGHT	
PLUG POINT	
PHONE	
POWER POINT	
SWITCH BOARD	
TELEVISION	
TUBE LIGHT	
TWO WAY	
FOOT LIGHT	
CHANDELIAR	
HALOGEN	
SPEAKER	
SPLIT A.C.	
FOOT LIGHT	
WALL FAN	
BELL POINT	
BUZZER BELL	
WALL MOUNTED CAMERA (CCTV)	
SPEAKER	
VEDIO DOOR PHONE	
TELEPHONE	

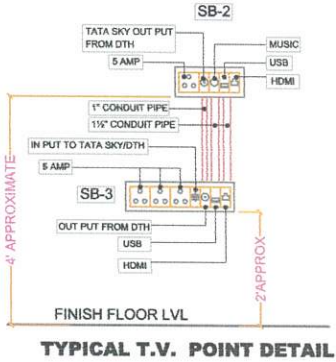

Er. PARNESHWAR
B.Tech. (Electrical)
M.Tech. (Power System)


GENERAL NOTES		PROJECT TITLE	CONSULTANT	SUBMITTED FOR :-		ARCHITECTS
1. ALL THE DIMENSIONS ON THE DRAWING ARE IN METERS. 2. ALL THE DIMENSIONS ARE TO BE FOR FINISH. 3. ALL THE DIMENSIONS ARE TO BE FOR FINISH. 4. ALL THE DIMENSIONS ARE TO BE FOR FINISH. 5. ALL THE DIMENSIONS ARE TO BE FOR FINISH. 6. ALL THE DIMENSIONS ARE TO BE FOR FINISH. 7. ALL THE DIMENSIONS ARE TO BE FOR FINISH. 8. ALL THE DIMENSIONS ARE TO BE FOR FINISH. 9. ALL THE DIMENSIONS ARE TO BE FOR FINISH. 10. ALL THE DIMENSIONS ARE TO BE FOR FINISH.		PROPOSED RESIDENTIAL SCHEME "RAVI KIRAN VIHAR" AT VILLAGE-MOHANPURA, TEH.- SANGANER, JAIPUR UNDER KHASRA NO - 202, 203/577	AMP INFRA SERVICES VILLA NO 16. SHUBHASIS GEETA JAISINGHPURA, BHANKROTA & CHIMANPURA, JAIPUR 302026 EMAIL ID- ampinfrajpr@gmail.com	PRELIMINARY ☐ APPROVAL ☐ PROPOSAL ☐ GFC ☐ DATE :- 08 DEC 2023 DRAWN :- SUFIAN KHAN APPROVED :- NARESH DRAWING NO.- 00	NORTH :- SCALE :- N.T.S.	AIM ENGINEERS & ARCHITECTS #105 FI. FL., SHIV GYAN AVENUE PLOT NO. -2 YUDHISHTER MARG, OPP. YOJNA BHAWAN, C- SCHEME JAIPUR.
DRAWING TITLE		TYPICAL GROUND FLOOR ELECTRICAL PLAN (EAST & WEST)				

WEST FACING PLAN

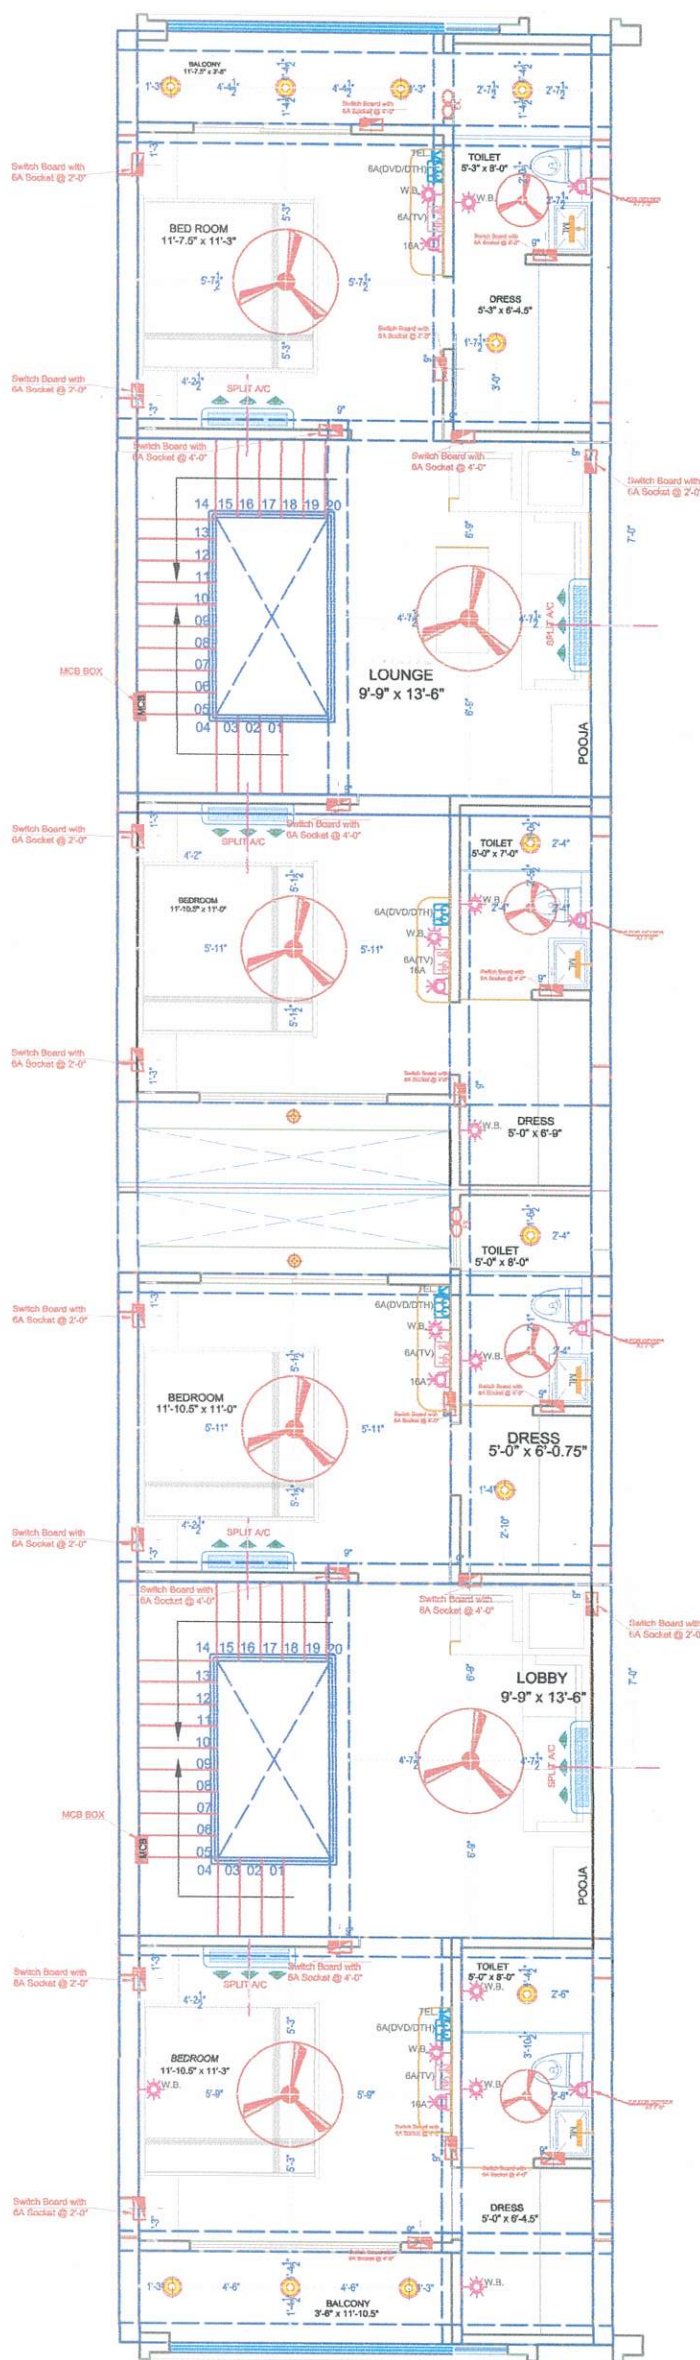


EAST FACING PLAN

LEGEND	
NAME	SYMBOL
MIRROR LIGHT	
MCB	
WALL LIGHT	
BRACKET FAN	
CFL	
EXHAUST	
FAN	
CEILING LIGHT	
PLUG POINT	
PHONE	
POWER POINT	
SWITCH BOARD	
TELEVISION	
TUBE LIGHT	
TWO WAY	
FOOT LIGHT	
CHANDELIAR	
HALOGEN	
SPEAKER	
SPLIT A.C.	
FOOT LIGHT	
WALL FAN	
BELL POINT	
BUZZER BELL	
WALL MOUNTED CAMERA (CCTV)	
SPEAKER	
VEDIO DOOR PHONE	
TELEPHONE	

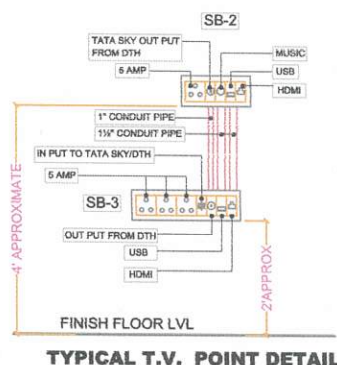

TYPICAL T.V. POINT DETAIL


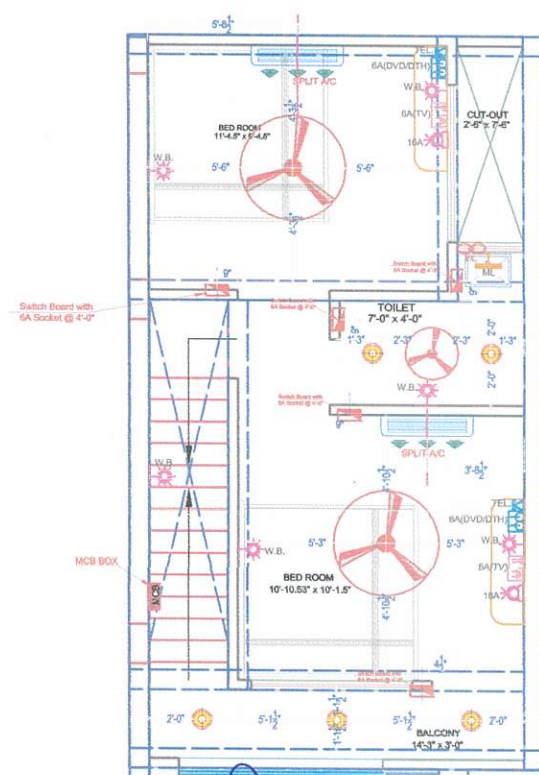


EAST FACING PLAN


Er. PARNESHWAR
B.Tech. (Electrical)
M.Tech. (Power System)

GENERAL NOTES:- 1. ALL THE DIMENSIONS ON THE DRAWING ARE IN METERS. 2. UNLESS SPECIFIED, DIMENSIONS ARE TO BE FOLLOWED AS SHOWN ON THE DRAWING. 3. ALL WORK SHALL BE DONE IN ACCORDANCE WITH THE LATEST VERSIONS OF THE IS CODES. 4. ALL WORK SHALL BE DONE IN ACCORDANCE WITH THE LATEST VERSIONS OF THE IS CODES. 5. THIS DRAWING IS TO BE READ IN CONJUNCTION WITH THE RELEVANT SPECIFICATIONS, SPECIFICATIONS AND EXPLANATIONS. 6. ANY WORK REQUIRED TO BE DONE IN ACCORDANCE WITH THE RELEVANT SPECIFICATIONS, SPECIFICATIONS AND EXPLANATIONS. 7. THE DRAWING IS TO BE READ IN CONJUNCTION WITH THE RELEVANT SPECIFICATIONS, SPECIFICATIONS AND EXPLANATIONS. 8. THE DRAWING IS TO BE READ IN CONJUNCTION WITH THE RELEVANT SPECIFICATIONS, SPECIFICATIONS AND EXPLANATIONS. 9. THE DRAWING IS TO BE READ IN CONJUNCTION WITH THE RELEVANT SPECIFICATIONS, SPECIFICATIONS AND EXPLANATIONS. 10. THE DRAWING IS TO BE READ IN CONJUNCTION WITH THE RELEVANT SPECIFICATIONS, SPECIFICATIONS AND EXPLANATIONS.	PROJECT TITLE PROPOSED RESIDENTIAL SCHEME "RAVI KIRAN VIHAR" AT VILLAGE -MOHANPURA, TEH- SANGANER, JAIPUR UNDER KHASRA NO - 202, 203/577	CONSULTANT AMP INFRA SERVICES VILLA NO 16. SHUBHASIS GEETA JAISINGHPURA, BHANKROTA & CHIMANPURA, JAIPUR 302026 EMAIL ID - ampinfrajr@gmail.com	SUBMITTED FOR :- PRELIMINARY PROPOSAL DATE :- DRAWN :- APPROVED :- DRAWING NO. :- APPROVAL GFC 08 DEC. 2023 SUFIAN KHAN NARESH 00 NORTH:- SCALE :- N.T.S.	ARCHITECTS  AIM ENGINEERS & ARCHITECTS #105 FI. FL., SHIV GYAN AVENUE PLOT NO. -2 YUDHISHTER MARG, OPP. YOJNA BHAWAN, C- SCHEME JAIPUR.	
			DRAWING TITLE TYPICAL FIRST FLOOR ELECTRICAL PLAN (EAST & WEST)		

LEGEND	
NAME	SYMBOL
MIRROR LIGHT	
MCB	
WALL LIGHT	
BRACKET FAN	
CFL	
EXHAUST	
FAN	
CEILING LIGHT	
PLUG POINT	
PHONE	
POWER POINT	
SWITCH BOARD	
TELEVISION	
TUBE LIGHT	
TWO WAY	
FOOT LIGHT	
CHANDELIAR	
HALOGEN	
SPEAKER	
SPLIT A.C.	
FOOT LIGHT	
WALL FAN	
BELL POINT	
BUZZER BELL	
WALL MOUNTED CAMERA (CCTV)	
SPEAKER	
VEDIO DOOR PHONE	
TELEPHONE	

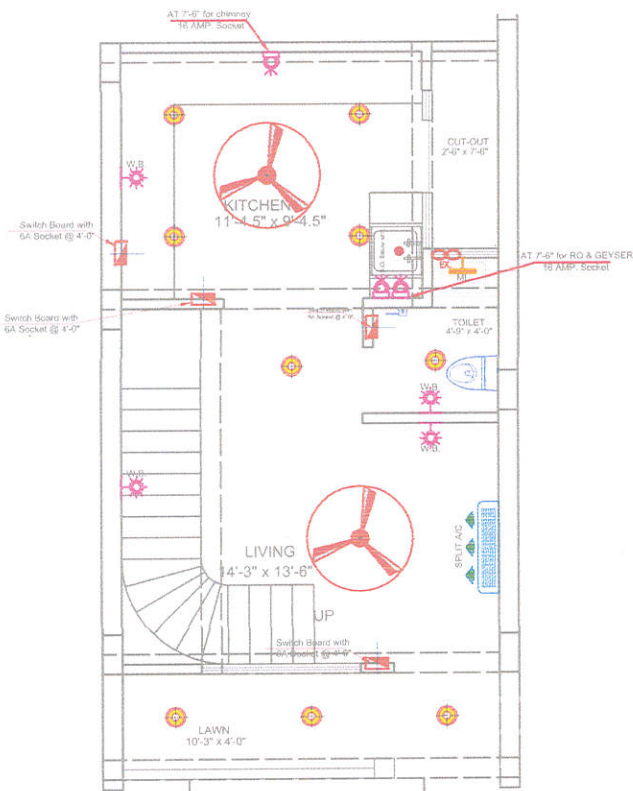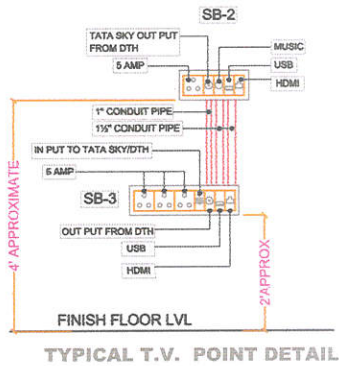


EAST FACING PLAN

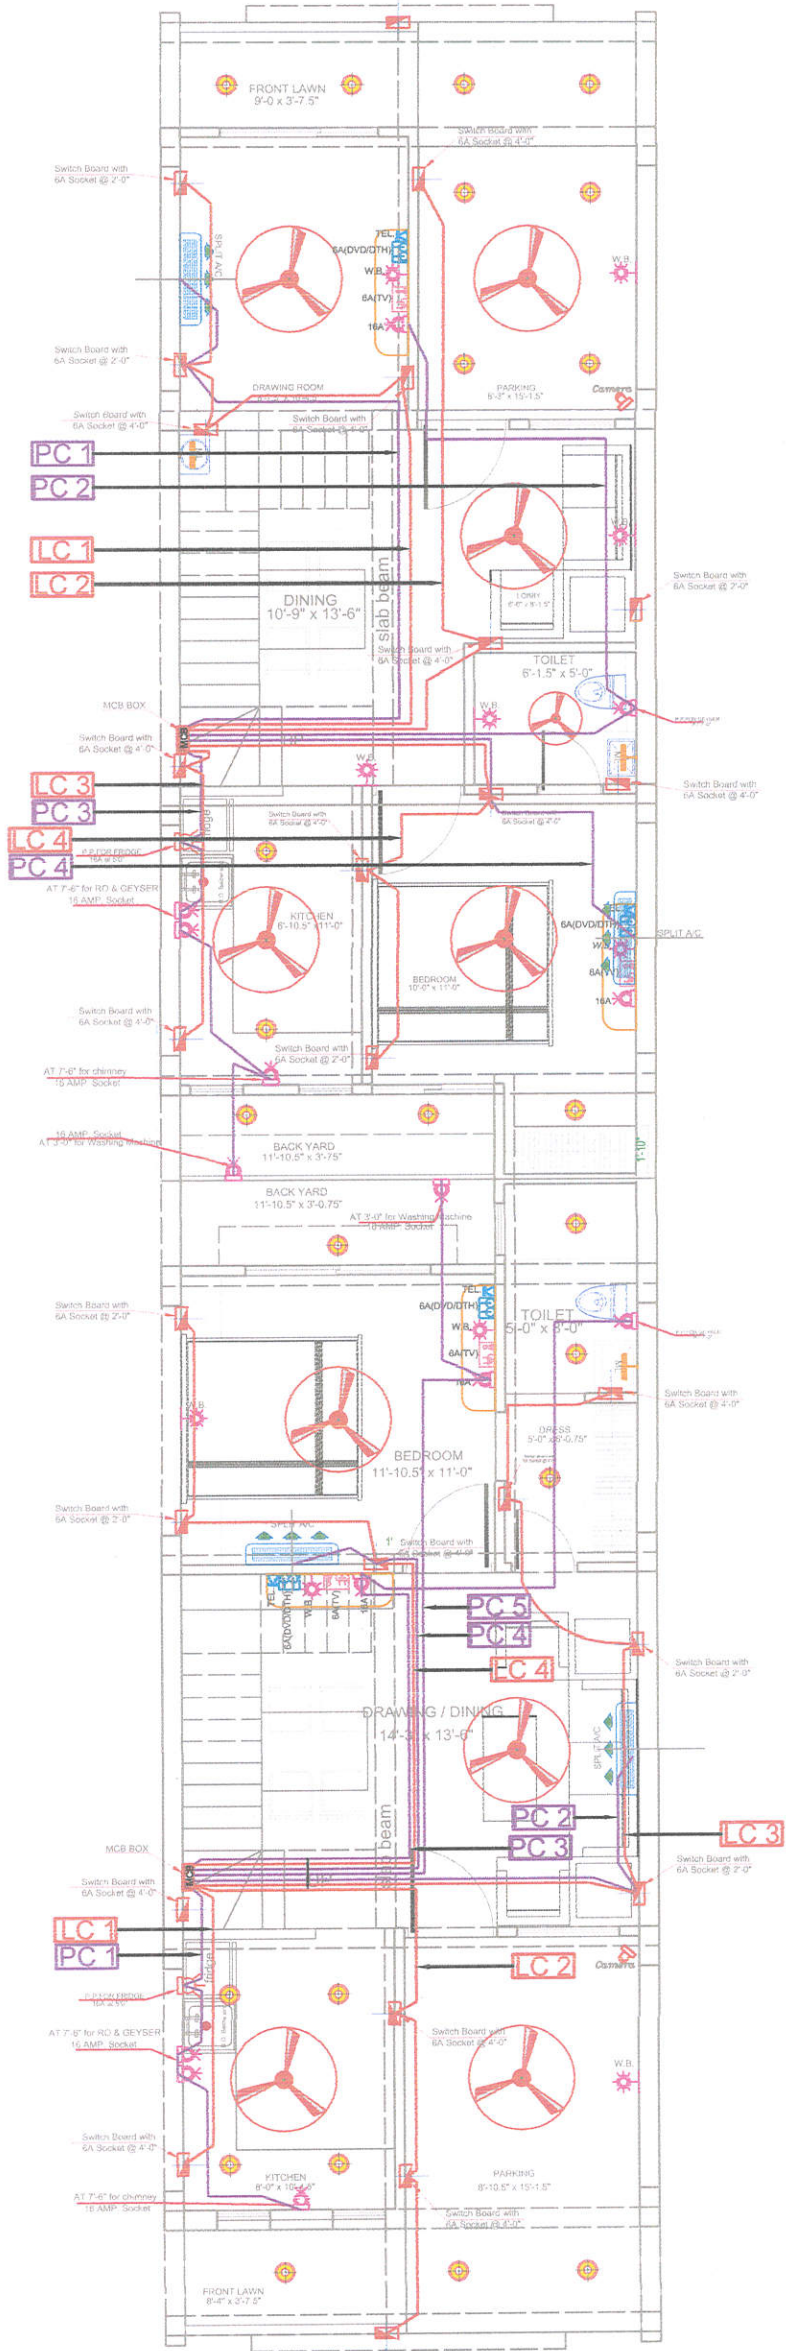

Er. PARMESHWAR
B.Tech. (Electrical)
M.Tech. (Power System)

GENERAL NOTES		PROJECT TITLE	CONSULTANT	SUBMITTED FOR :-		ARCHITECTS	
1. ALL THE DIMENSIONS ON THE DRAWING ARE IN METERS. 2. ONLY THE DIMENSIONS ON THE DRAWING ARE TO BE FOLLOWED. 3. ALL THE DIMENSIONS ON THE DRAWING ARE TO BE FOLLOWED. 4. ALL THE DIMENSIONS ON THE DRAWING ARE TO BE FOLLOWED. 5. ALL THE DIMENSIONS ON THE DRAWING ARE TO BE FOLLOWED. 6. ALL THE DIMENSIONS ON THE DRAWING ARE TO BE FOLLOWED. 7. ALL THE DIMENSIONS ON THE DRAWING ARE TO BE FOLLOWED. 8. ALL THE DIMENSIONS ON THE DRAWING ARE TO BE FOLLOWED. 9. ALL THE DIMENSIONS ON THE DRAWING ARE TO BE FOLLOWED. 10. ALL THE DIMENSIONS ON THE DRAWING ARE TO BE FOLLOWED.		PROPOSED RESIDENTIAL SCHEME "RAVI KIRAN VIHAR" AT VILLAGE-MOHANPURA, TEH.- SANGANER, JAIPUR UNDER KHASRA NO - 202, 203/577	AMP INFRA SERVICES VILLA NO 16, SHUBHASIS GEETA JAISINGHPURA, BHANKROTA & CHIMANPURA, JAIPUR 302026 EMAIL ID- ampinfrajr@gmail.com	PRELIMINARY PROPOSAL	APPROVAL GFC	AIM ENGINEERS & ARCHITECTS #105 FL. FL., SHIV GYAN AVENUE PLOT NO. -2 YUDHISHTER MARG, OPP. YOJNA BHAWAN, C- SCHEME JAIPUR.	
DATE :- 08 DEC. 2023 DRAWN :- SUFIAN KHAN APPROVED :- NARESH DRAWING NO. :- 00		DRAWING TITLE		TYPICAL GROUND FLOOR ELECTRICAL PLAN (EAST & WEST)		NORTH :- SCALE :- N.T.S.	

The diagram illustrates the typical T.V. point detail. It shows two boxes, SB-2 and SB-3, mounted on a wall above the finish floor level. SB-2 is connected to TATA SKY OUT PUT FROM DTH (5 AMP) and has outputs for MUSIC, USB, and HDMI. SB-3 is connected to IN PUT TO TATA SKY/DTH (5 AMP) and has outputs for OUT PUT FROM DTH, USB, and HDMI. A 1" CONDUIT PIPE and a 1 1/2" CONDUIT PIPE are shown running between the boxes. The distance between the boxes is approximately 4 feet, and the distance from the boxes to the finish floor level is approximately 2 feet.

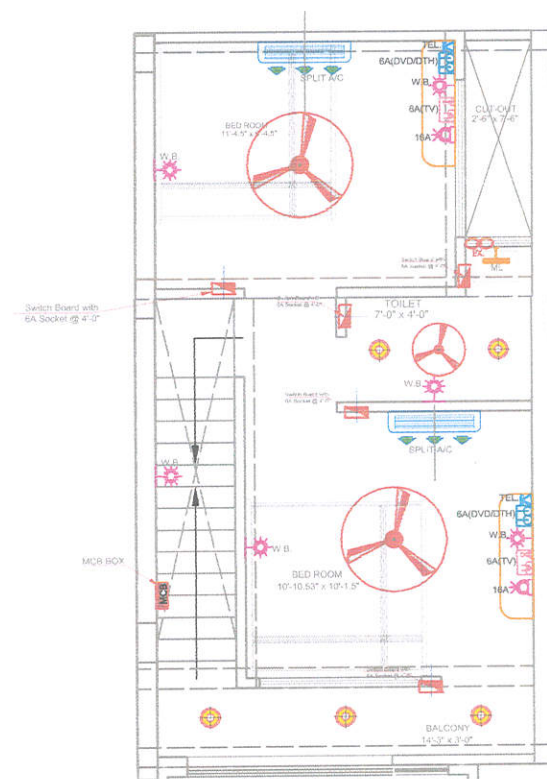


Er. PARMESHWAR
B.Tech. (Electrical)
M.Tech. (Power System)

GENERAL NOTES 1. ALL THE DIMENSIONS ON THE DRAWING ARE IN METERS. 2. ALL THE WORKING DIMENSIONS ARE TO BE MEASURED FROM THE EXTERIOR FACE OF THE WALLS UNLESS OTHERWISE SPECIFIED. 3. ALL DIMENSIONS ARE TO BE CHECKED AND VERIFIED BY THE ARCHITECT BEFORE THE START OF THE WORK. 4. THE ARCHITECT SHALL BE RESPONSIBLE FOR THE ACCURACY OF THE DIMENSIONS AND THE POSITION OF THE WALLS AND THE LOCATION OF THE STRUCTURE. 5. THE ARCHITECT SHALL BE RESPONSIBLE FOR THE POSITION OF THE STRUCTURE AND THE LOCATION OF THE STRUCTURE. 6. THE ARCHITECT SHALL BE RESPONSIBLE FOR THE POSITION OF THE STRUCTURE AND THE LOCATION OF THE STRUCTURE.	PROJECT TITLE PROPOSED RESIDENTIAL SCHEME "RAVI KIRAN VIHAR" AT VILLAGE.-MOHANPURA ,TEH.- SANGANER, JAIPUR UNDER KHASRA NO - 202, 203/577	CONSULTANT AMP INFRA SERVICES VILLA NO 16, SHUBHASIS GEETA JAISINGHPURA, BHANKROTA & CHIMANPURA. JAIPUR 302026 EMAIL ID- ampinfrajr@gmail.com	SUBMITTED FOR :- PRELIMINARY PROPOSAL DATE :- DRAWN :- APPROVED :- DRAWING NO. :- ☐ ☒ 08 DEC. 2023 SUFIAN KHAN NARESH 00 APPROVAL GFC NORTH :- SCALE :- N.T.S. ☐ ☒ 	ARCHITECTS AIM ENGINEERS & ARCHITECTS #105 FI. FL., SHIV GYAN AVENUE PLOT NO. -2 YUDHISHTER MARG, OPP. YOJNA BHAWAN, C- SCHEME JAIPUR.	
			DRAWING TITLE TYPICAL FIRST FLOOR ELECTRICAL PLAN (EAST & WEST)		

GROUND FLOOR 6 WAY TPN LIGHT & POWER DB

LC = LIGHT CIRCUIT

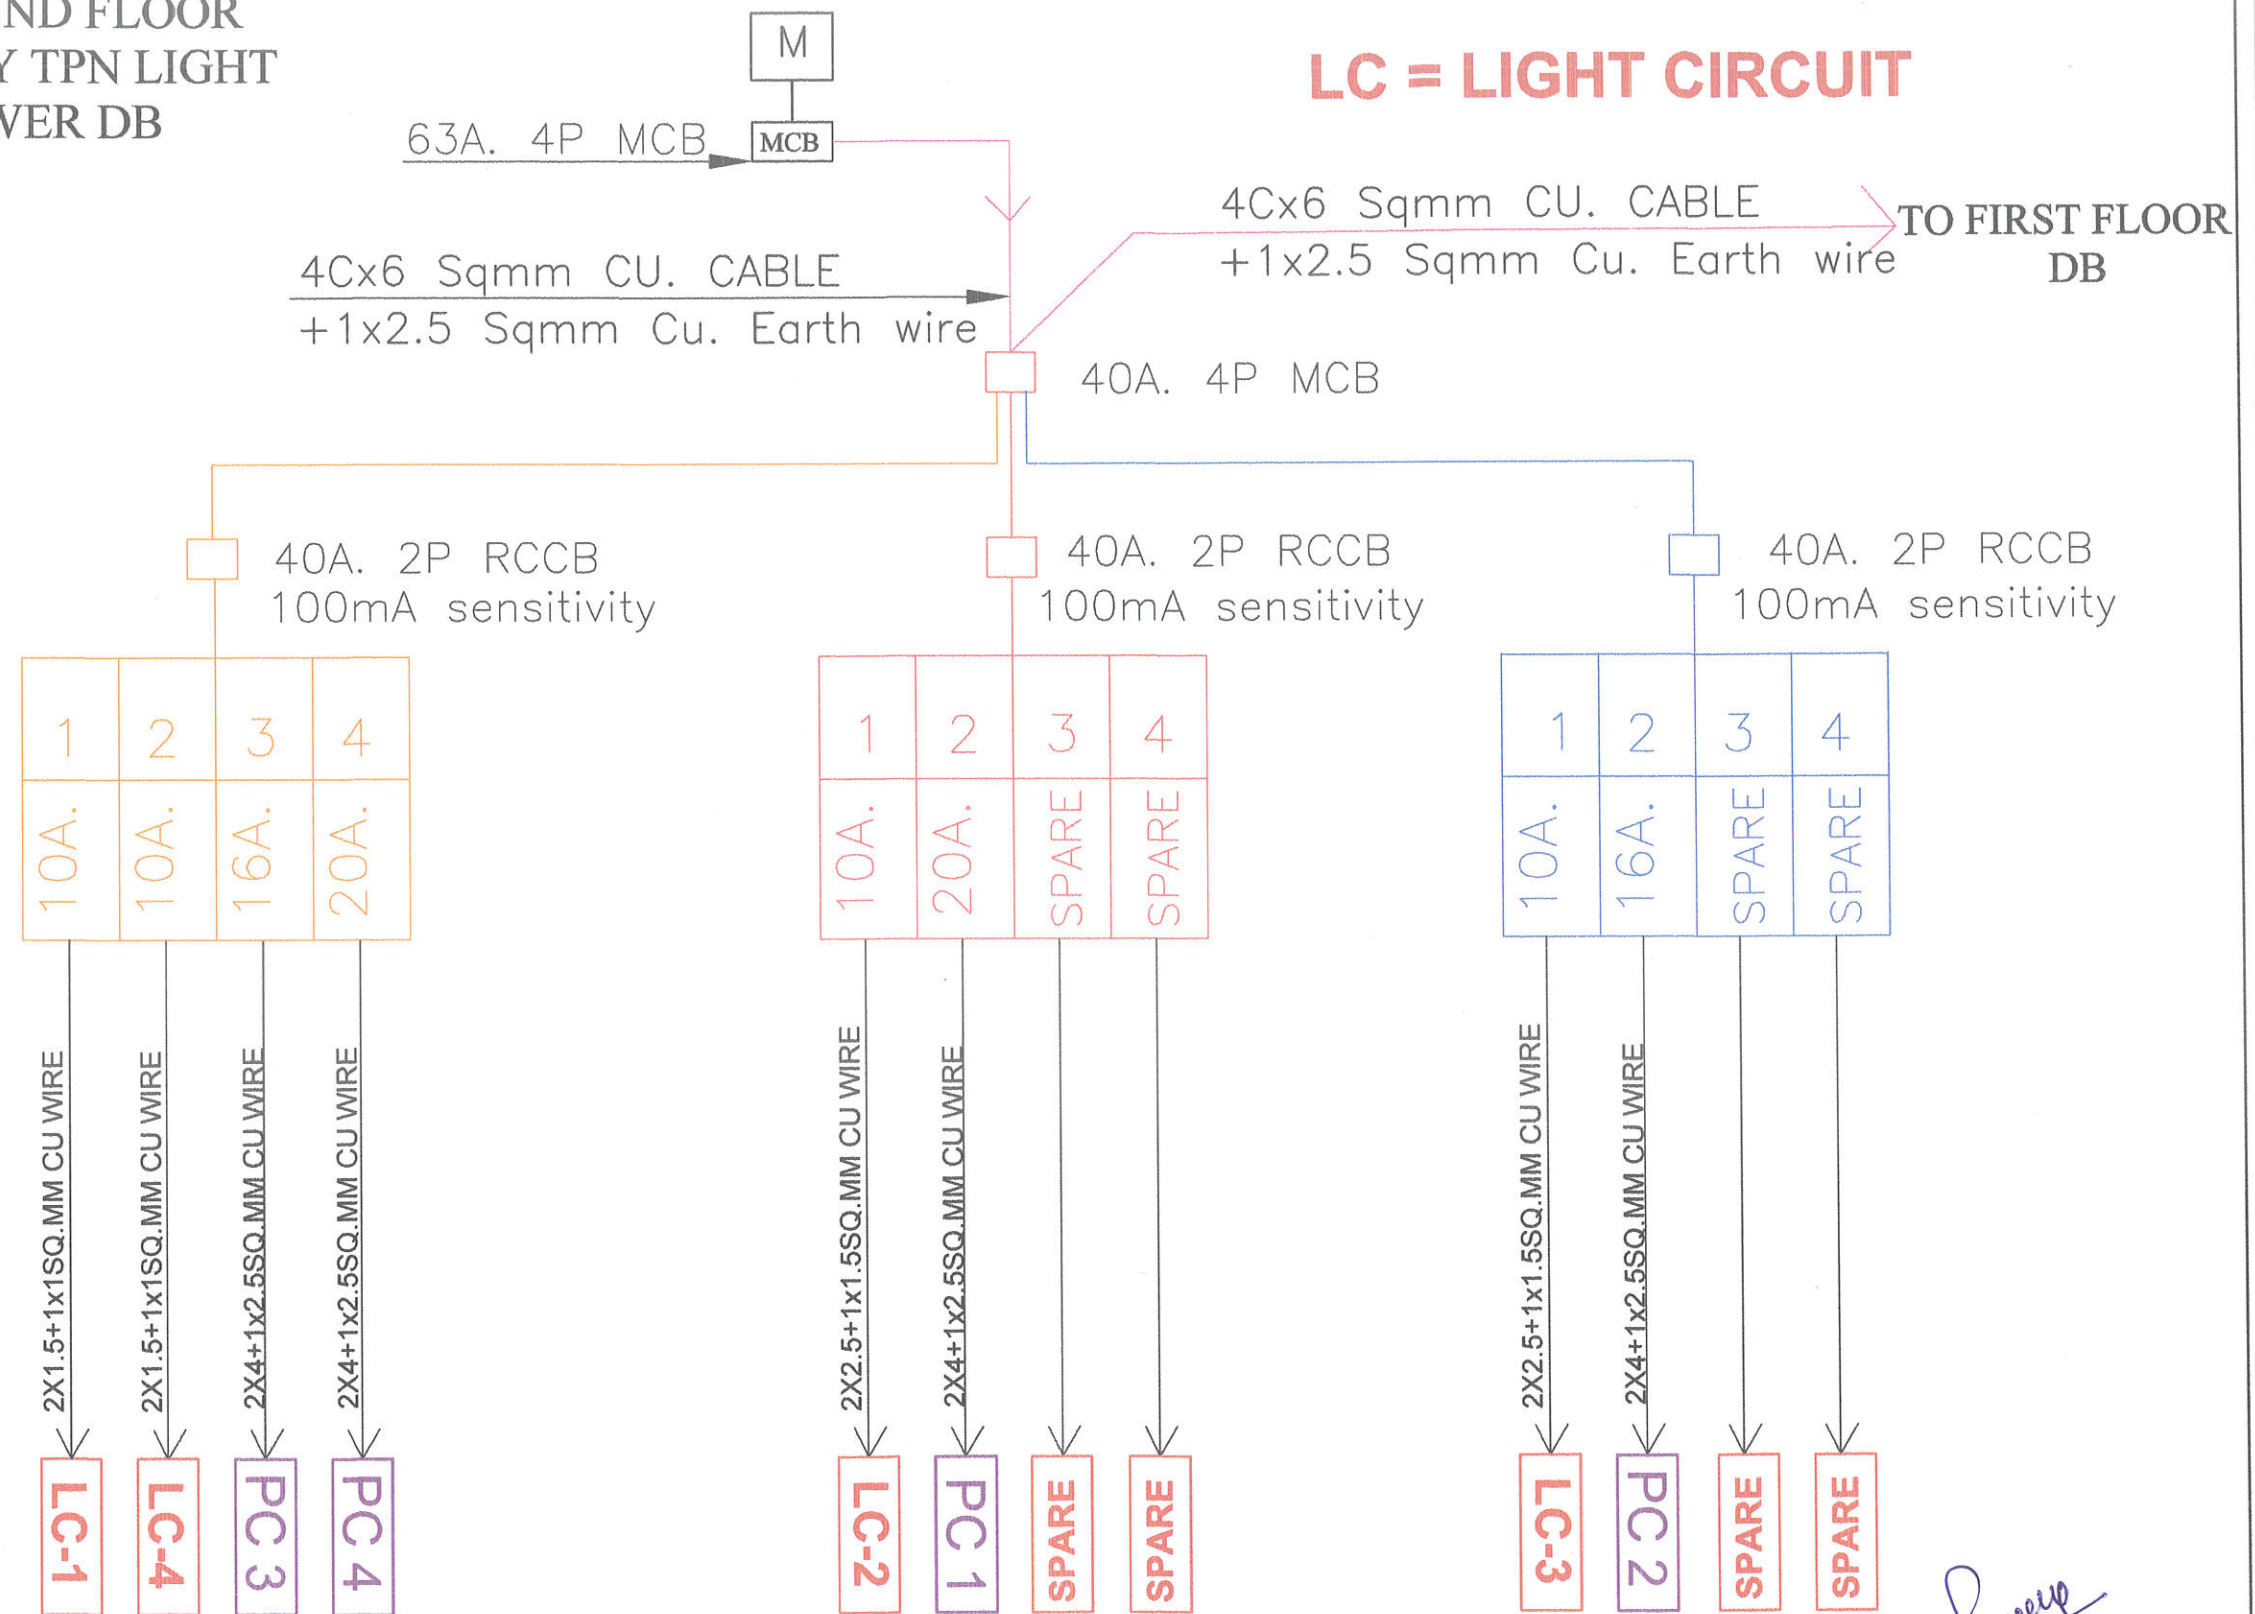

Dr. PARMESHWAR
B.Tech. (Electrical)
M.Tech. (Power System)

GENERAL NOTES :

1. ALL THE DIMENSIONS ON THE DRAWING ARE IN WRITTEN.
2. ONLY WRITTEN DIMENSIONS ARE TO BE FOLLOWED, DRAWING SHOULD NOT BE SCALED IN ANY CIRCUMSTANCES.
3. ALL MEASUREMENTS MUST BE CHECKED AND VERIFIED BY THE CONTRACTORS PRIOR TO EXECUTION OF WORK AT THE SITE.
4. THIS DRAWING IS TO BE READ IN CONJUNCTION WITH ALL RELEVANT STRUCTURAL, ARCHITECTURAL & FACILITY PLANNING DRAWINGS.
5. ANY DISCREPANCIES MUST BE BROUGHT TO THE NOTICE OF THE ENGINEER IMMEDIATELY & PRIOR TO EXECUTION AT SITE.
6. CO-ORDINATION WITH SERVICES SUCH AS HVAC, PLUMBING & ELECTRICAL, ETC. IS THE RESPONSIBILITY OF THE CONTRACTORS.
7. FOR DETAILS, REFER RELEVANT LARGE SCALE DETAIL DRGS. AS INDICATED.

SERVICES CONSULTANT:

AMP INFRA SERVICES
VILLA-16, SUBHASHIS GEETA, BHANKROTA
& CHIMANPURA, JAIPUR
E-mail: - ampinfrajpr@gmail.com
MOB.: - +91 9950152270, 9462866389

CLIENT :

PROJECT :

PROPOSED RESIDENTIAL SCHEME
"RAVI KIRAN VIHAR"
AT VILLAGE-MOHANPURA, TEH- SANGANER, JAIPUR
UNDER KHASRA NO - 202, 203/577

ARCHITECT :



AIM
ENGINEERS & ARCHITECTS
#105 FI. FL., SHIV GYAN AVENUE
PLOT NO. -2 YUDHISHTER MARG,
OPP. YOJNA BHAWAN, C- SCHEME
JAIPUR.


DRAWING TITLE :

**TYPICAL GROUND FLOOR
WEST FACING DB SLD**

SCALE :		DATE :	19.10.24
DEALT BY :	RAKESH	APP. BY :	NARESH
NORTH	DWG NO.		
	PATH :		

FIRST FLOOR
6 WAY TPN LIGHT & POWER DB

LC = LIGHT CIRCUIT

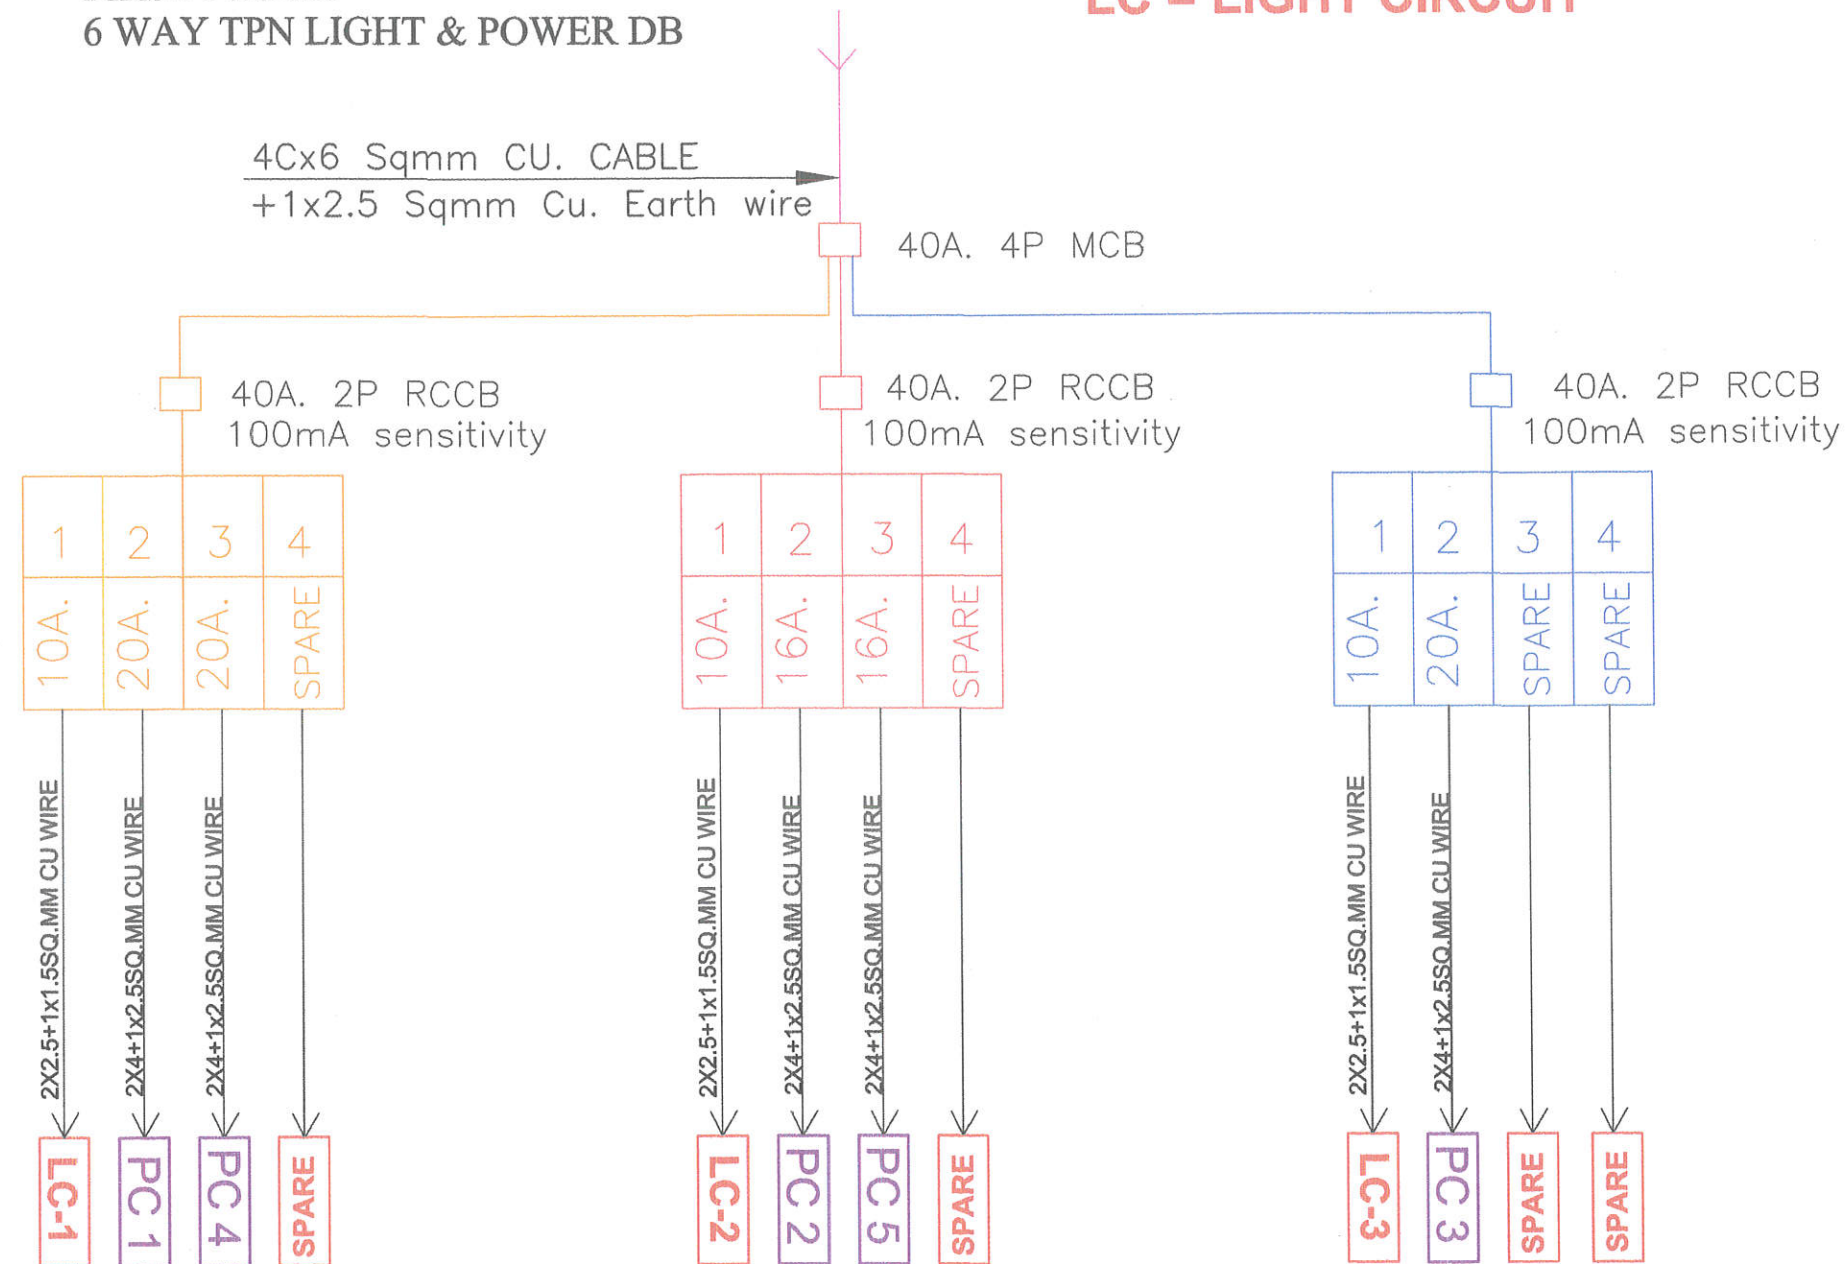

Er. PARMESHWAR
B.Tech. (Electrical)
M.Tech. (Power System)

GENERAL NOTES :

1. ALL THE DIMENSIONS ON THE DRAWING ARE IN WRITTEN.
2. ONLY WRITTEN DIMENSIONS ARE TO BE FOLLOWED, DRAWING SHOULD NOT BE SCALED IN ANY CIRCUMSTANCES.
3. ALL MEASUREMENTS MUST BE CHECKED AND VERIFIED BY THE CONTRACTORS PRIOR TO EXECUTION OF WORK AT THE SITE.
4. THIS DRAWING IS TO BE READ IN CONJUNCTION WITH ALL RELEVANT STRUCTURAL, ARCHITECTURAL & FACILITY PLANNING DRAWINGS.
5. ANY DISCREPANCIES MUST BE BROUGHT TO THE NOTICE OF THE ENGINEER IMMEDIATELY & PRIOR TO EXECUTION AT SITE.
6. CO-ORDINATION WITH SERVICES SUCH AS HVAC, PLUMBING & ELECTRICAL, ETC. IS THE RESPONSIBILITY OF THE CONTRACTORS.
7. FOR DETAILS, REFER RELEVANT LARGE SCALE DETAIL DRGS. AS INDICATED.

SERVICES CONSULTANT:

AMP INFRA SERVICES
VILLA-16, SUBHASHIS GEETA, BHANKROTA
& CHIMANPURA, JAIPUR
E-mail: - ampinfrajpr@gmail.com
MOB.: - +91 9950152270, 9462866389

CLIENT :

PROJECT :

PROPOSED RESIDENTIAL SCHEME
"RAVI KIRAN VIHAR"
AT VILLAGE - MOHANPURA, TEH.-
SANGANER, JAIPUR

ARCHITECT :

AIM
ENGINEERS & ARCHITECTS
#105 FI. FL., SHIV GYAN AVENUE
PLOT NO. -2 YUDHISHTER MARG,
OPP. YOJNA BHAWAN, C- SCHEME
JAIPUR.


DRAWING TITLE :

**TYPICAL FIRST FLOOR WEST
FACING DB SLD**

SCALE :		DATE :	19.10.24
DEALT BY :	RAKESH	APP. BY :	NARESH
NORTH		DWG NO.	
		PATH :	

FIRST FLOOR
6 WAY TPN LIGHT & POWER DB

LC = LIGHT CIRCUIT

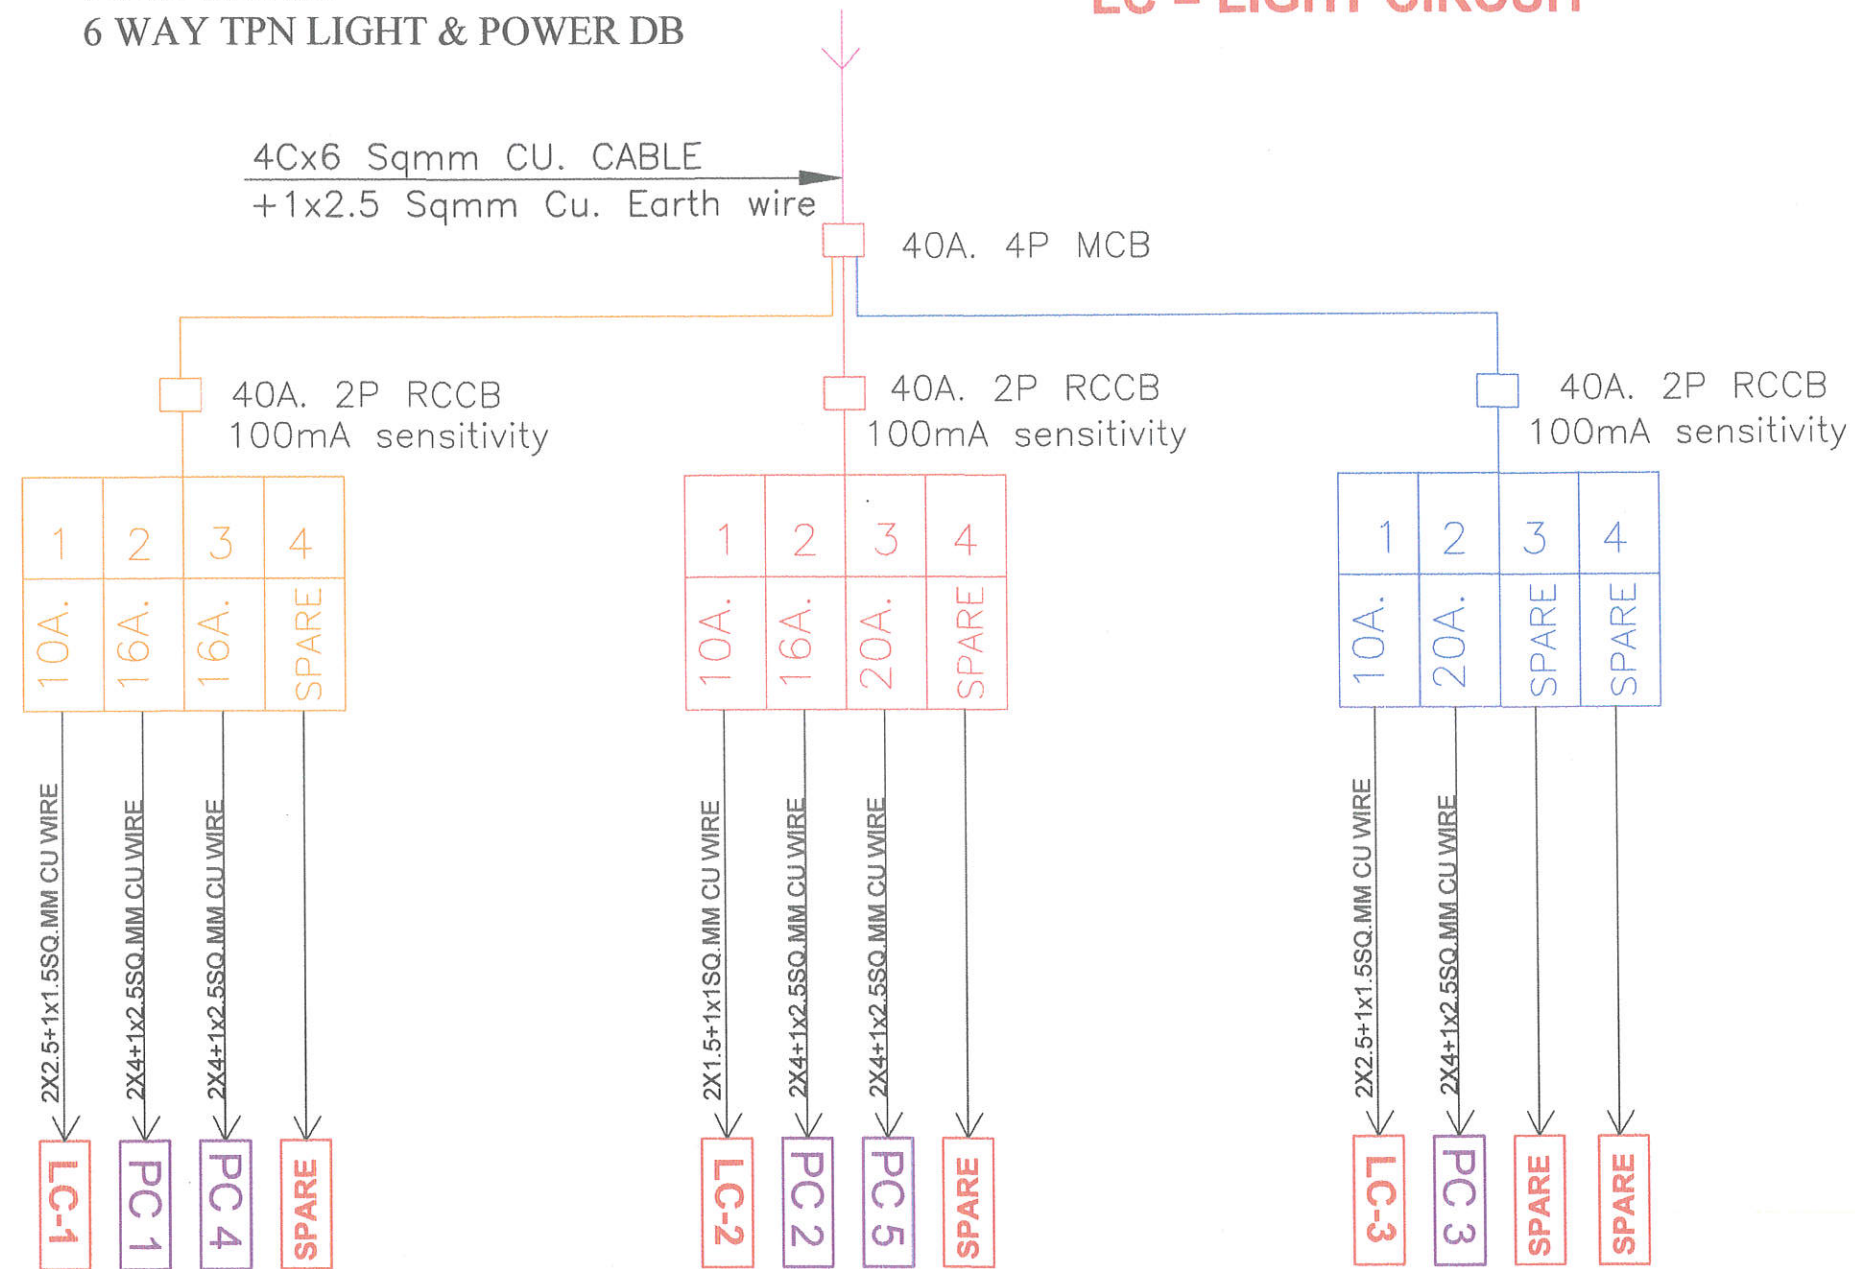

Er. PARMESHWAR
E.Tech. (Electrical)
M.Tech. (Power System)

GENERAL NOTES :

1. ALL THE DIMENSIONS ON THE DRAWING ARE IN WRITTEN.
2. ONLY WRITTEN DIMENSIONS ARE TO BE FOLLOWED, DRAWING SHOULD NOT BE SCALED IN ANY CIRCUMSTANCES.
3. ALL MEASUREMENTS MUST BE CHECKED AND VERIFIED BY THE CONTRACTORS PRIOR TO EXECUTION OF WORK AT THE SITE.
4. THIS DRAWING IS TO BE READ IN CONJUNCTION WITH ALL RELEVANT STRUCTURAL, ARCHITECTURAL & FACILITY PLANNING DRAWINGS.
5. ANY DISCREPANCIES MUST BE BROUGHT TO THE NOTICE OF THE ENGINEER IMMEDIATELY & PRIOR TO EXECUTION AT SITE.
6. CO-ORDINATION WITH SERVICES SUCH AS HVAC, PLUMBING & ELECTRICAL, ETC. IS THE RESPONSIBILITY OF THE CONTRACTORS.
7. FOR DETAILS, REFER RELEVANT LARGE SCALE DETAIL DRGS. AS INDICATED.

SERVICES CONSULTANT:

AMP INFRA SERVICES
VILLA-16, SUBHASHIS GEETA, BHANKROTA
& CHIMANPURA, JAIPUR
E-mail: - ampinfrajpr@gmail.com
MOB.: - +91 9950152270, 9462866389

CLIENT :

PROJECT :

PROPOSED RESIDENTIAL SCHEME
"RAVI KIRAN VIHAR"
AT VILLAGE-MOHANPURA, TEH.-SANGANER, JAIPUR
UNDER KHASRA NO - 202, 203/577

ARCHITECT :

AIM
ENGINEERS & ARCHITECTS
#105 FI. FL., SHIV GYAN AVENUE
PLOT NO. -2 YUDHISHTER MARG,
OPP. YOJNA BHAWAN, C- SCHEME
JAIPUR.


DRAWING TITLE :

TYPICAL FIRST FLOOR EAST
FACING DB SLD

SCALE :		DATE :	19.10.24
DEALT BY :	RAKESH	APP. BY :	NARESH
NORTH	DWG NO.		
	PATH :		

GROUND FLOOR
6 WAY TPN LIGHT
& POWER DB

LC = LIGHT CIRCUIT

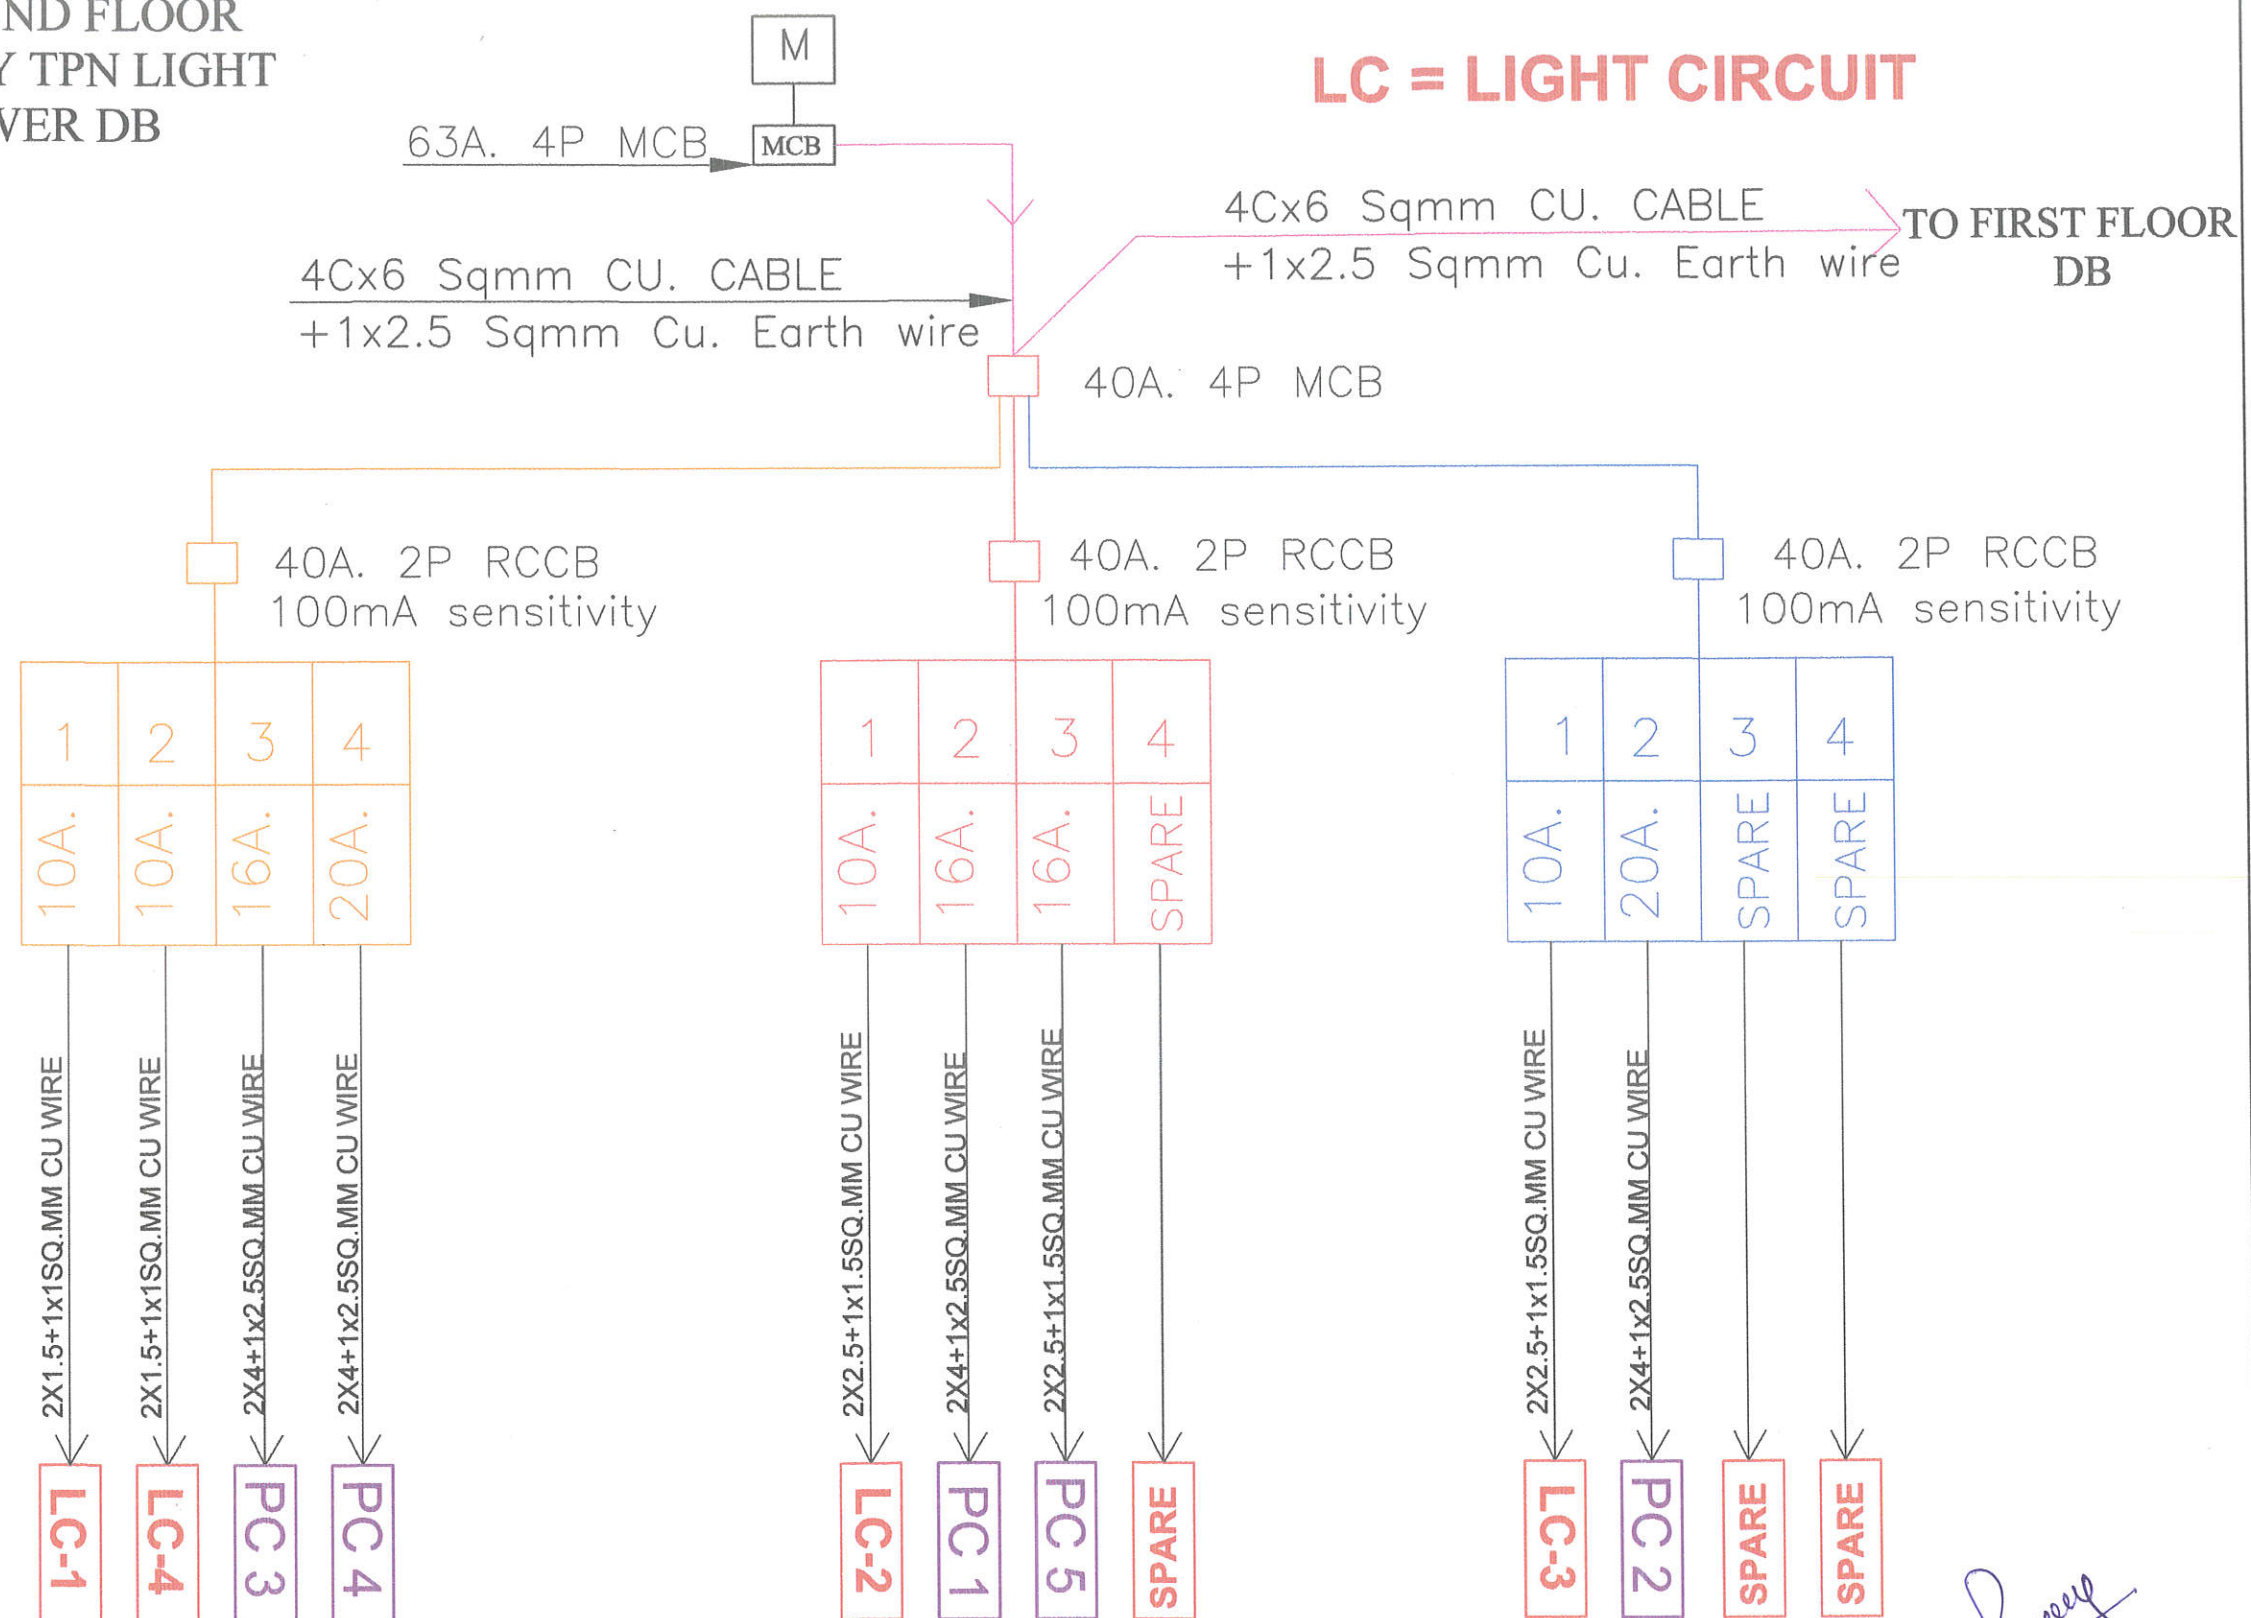

Er. PARNESHWAR
B. Tech. (Electrical)
M.Tech. (Power System)

GENERAL NOTES:

1. ALL THE DIMENSIONS ON THE DRAWING ARE IN WRITTEN.
2. ONLY WRITTEN DIMENSIONS ARE TO BE FOLLOWED, DRAWING SHOULD NOT BE SCALED IN ANY CIRCUMSTANCES.
3. ALL MEASUREMENTS MUST BE CHECKED AND VERIFIED BY THE CONTRACTOR PRIOR TO EXECUTION OF WORK AT THE SITE.
4. THIS DRAWING IS TO BE READ IN CONJUNCTION WITH ALL RELEVANT STRUCTURAL, ARCHITECTURAL & FACILITY PLANNING DRAWINGS.
5. ANY DISCREPANCIES MUST BE BROUGHT TO THE NOTICE OF THE ENGINEER IMMEDIATELY & PRIOR TO EXECUTION AT SITE.
6. CO-ORDINATION WITH SERVICES SUCH AS HVAC, PLUMBING & ELECTRICAL, ETC. IS THE RESPONSIBILITY OF THE CONTRACTOR.
7. FOR DETAILS, REFER RELEVANT LARGE SCALE DETAIL DRGS. AS INDICATED.

SERVICES CONSULTANT:


AMP INFRA SERVICES
VILLA-16, SUBHASHIS GEETA, BHANKROTA
& CHIMANPURA, JAIPUR
E-mail: - ampinfrajpr@gmail.com
MOB.: - +91 9950152270, 9462866389

CLIENT :

PROJECT :

PROPOSED RESIDENTIAL SCHEME
"RAVI KIRAN VIHAR"
AT VILLAGE-MOHANPURA, TEH.-SANGANER, JAIPUR
UNDER KHASRA NO - 202, 203/577

ARCHITECT :

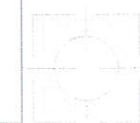

AIM
ENGINEERS & ARCHITECTS
#105 FI. FL., SHIV GYAN AVENUE
PLOT NO. -2 YUDHISHTER MARG,
OPP. YOJNA BHAWAN, C- SCHEME
JAIPUR.

DRAWING TITLE :

TYPICAL GROUND FLOOR
EAST FACING DB SLD

SCALE :		DATE :	19.10.24
DEALT BY :	RAKESH	APP. BY :	NARESH
NORTH		DWG NO.	
		PATH :	