


IN PROGRESS


NOT FOR CONSTRUCTION

KEY PLAN

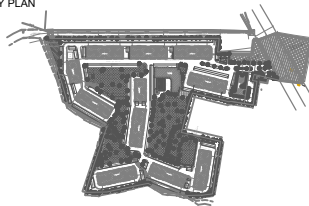


NOTES:-

1: ALL DIMENSION ARE IN MM.

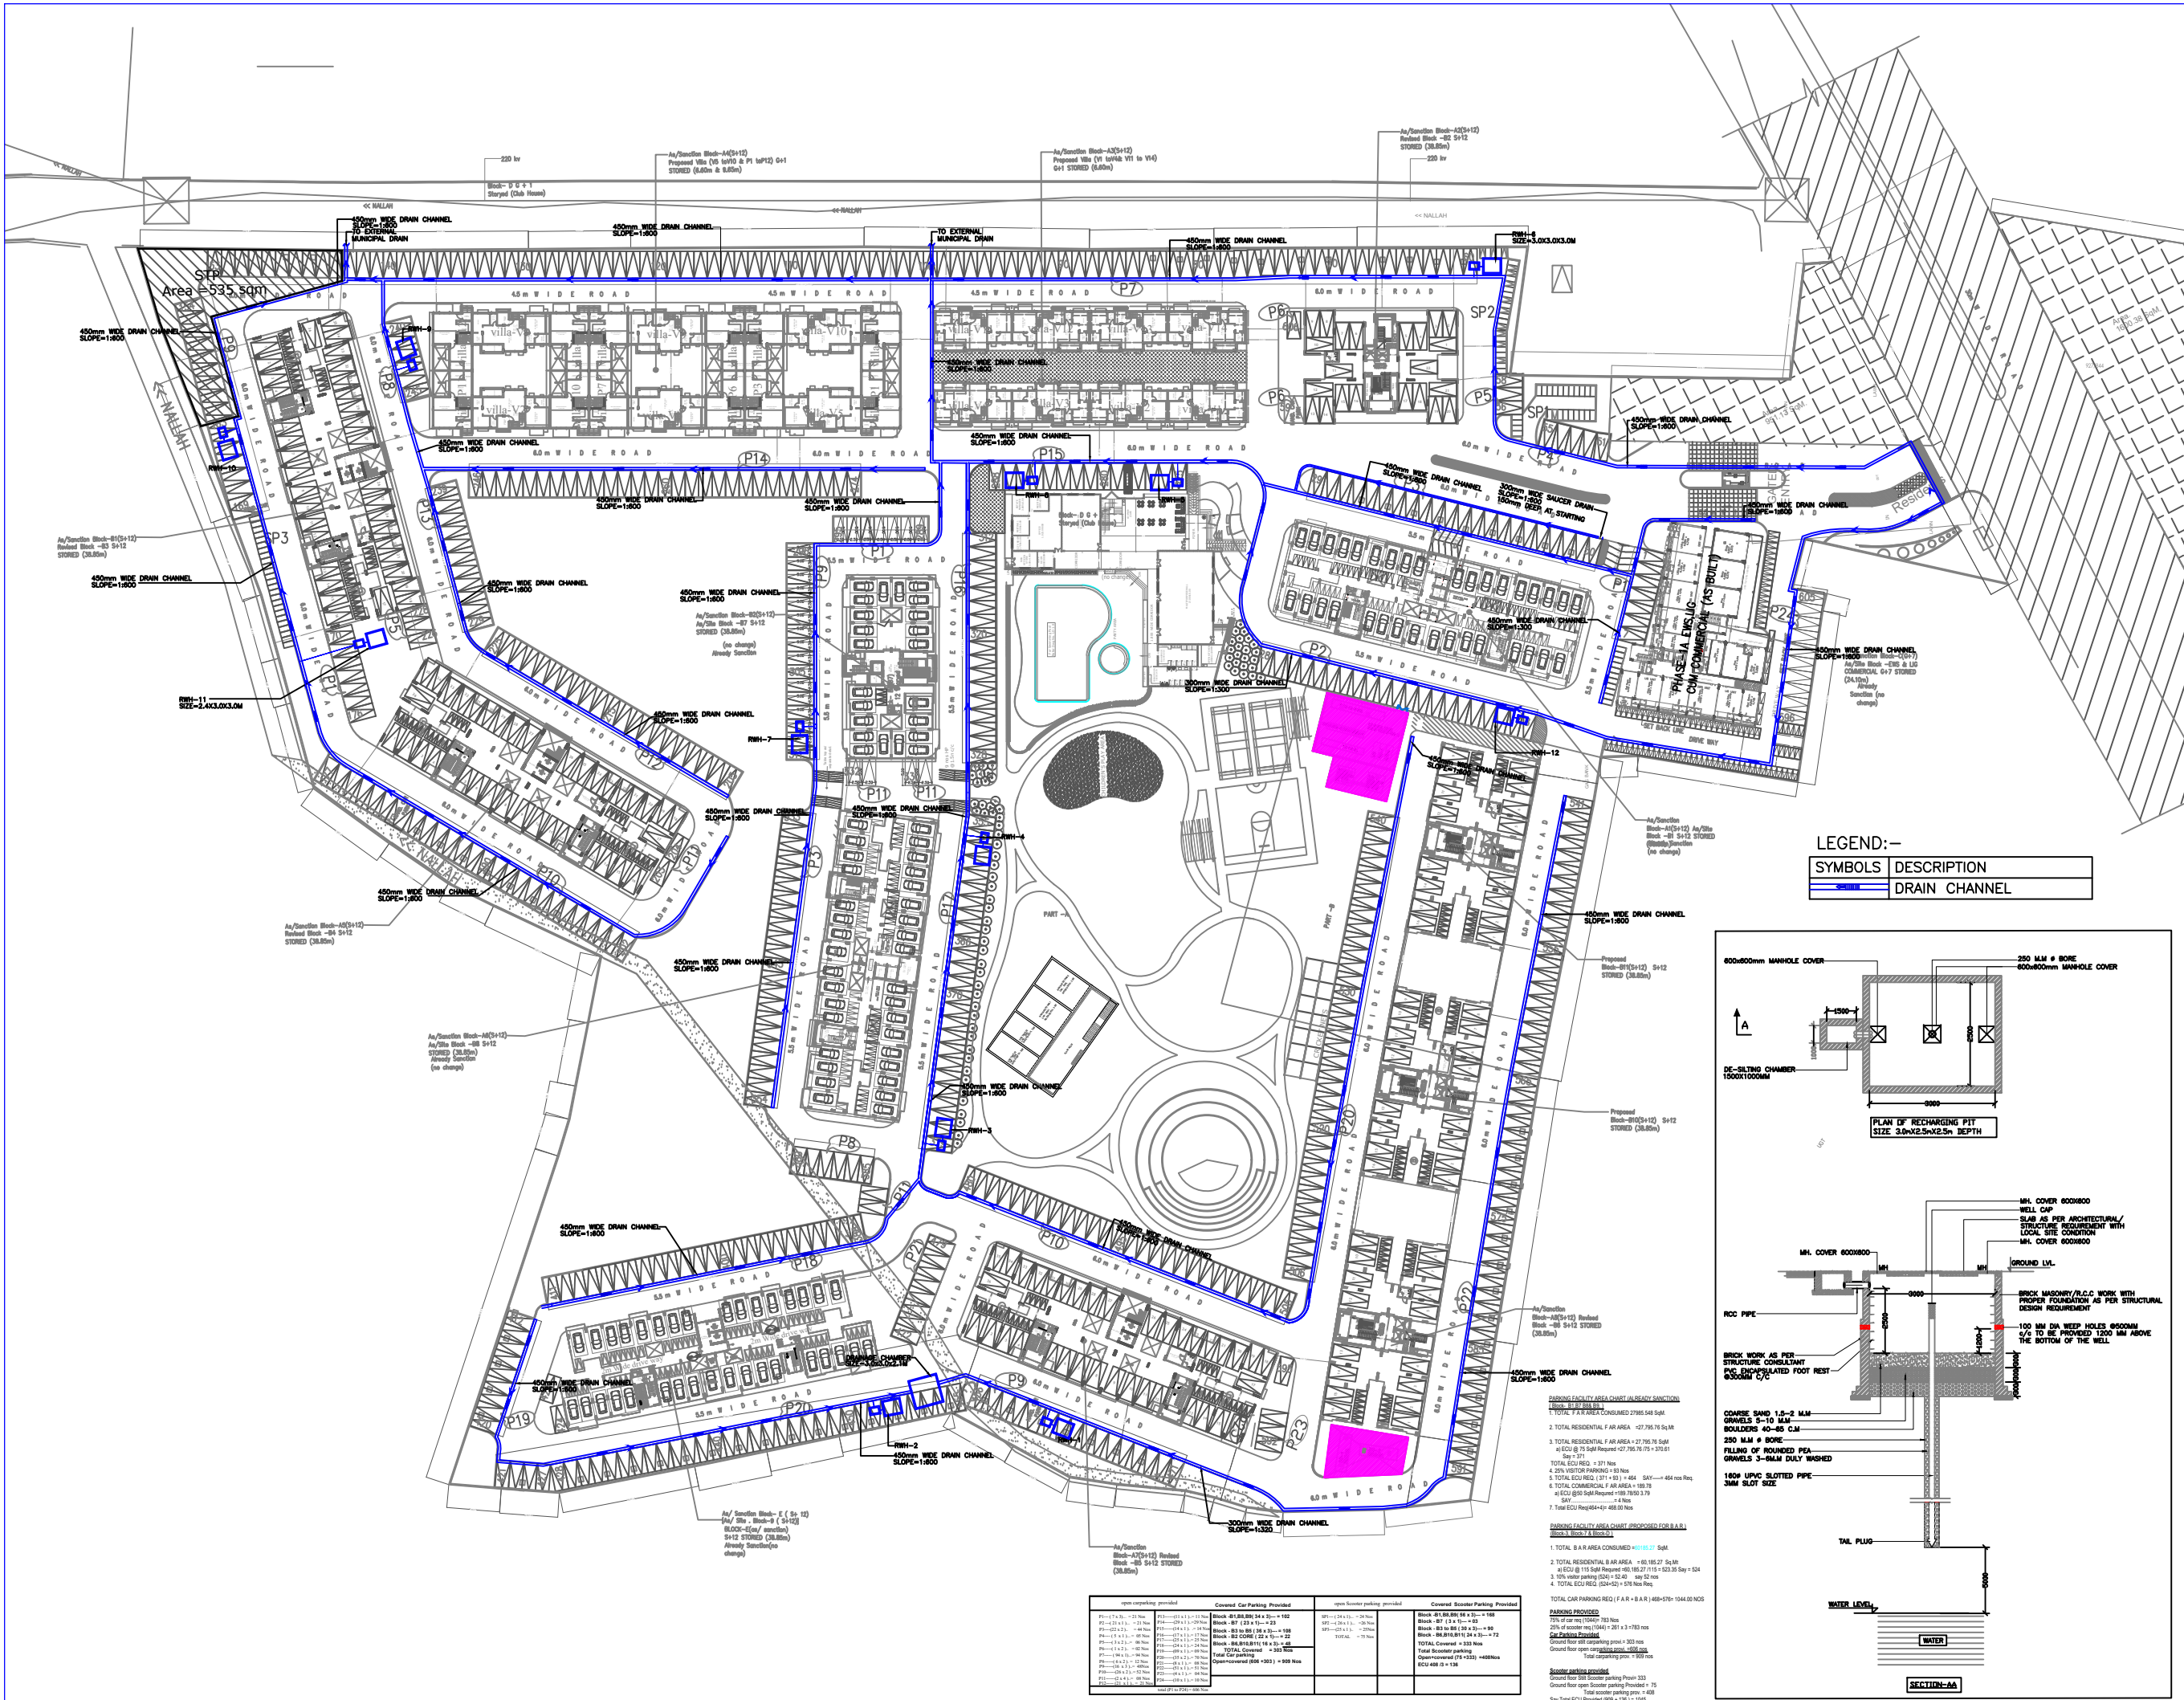

LEGEND:-

SYMBOLS	DESCRIPTION
	DRAIN CHANNEL

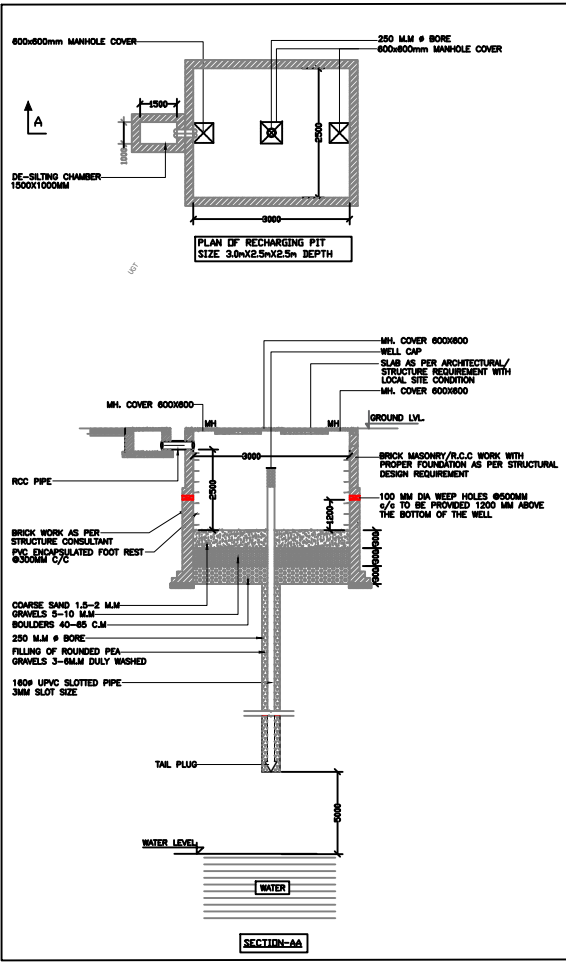

R1	25.11.21	ARCH.	ISSUE FOR EIA SUBMISSION	ANK	DVA
R0	16.09.15	ARCH.	ISSUE FOR EIA SUBMISSION	ANS	SHS

Rev	Date	Issued to	Description	By	Chk

The concepts and information contained in this document are the copyright of Black & White Engineering Services Pvt. Ltd. Use or copying of the document in whole or in part without the written permission of Black & White Engineering Services Pvt. Ltd. constitutes an infringement of copyright. Do not scale drawings. If in doubt, ask!

ARCHITECTS :-

b.sengupta architect
A305,RANGOLI,ASHIANA,VILLAGE,BHIWADI.
PH. 0988748263

MEP CONSULTANT :-



STRUCTURAL CONSULTANT :-

Developer:-

ASHIANA HOUSING LTD
Unit no.4 & 5,Plot No.D-2,3rd Floor,
Southern park, saket District Centre,
Saket New Delhi - 110017
Phone no. 011- 42 65 42 65

Project Name

ASHIANA TARANG AT BHIWADI

Title
**SITE PLAN
DRAINAGE LAYOUT**

Discipline PLUMBING SERVICE	Status EIA SUBMISSION
Designed By ANS	Checked By SHS
Project No. 15280	Date 15.09.2015
Drawing No. 15280-P-A0-0400	Scale 1:400
	Revision R1