

For R K Builders & Developers
21/9/21
Proprietor

Krishna
KRISHNA KUMAR
B. Tech. (Mechanical)
M.E.P Consultant

WARNING
1. This drawing is the sole copyright of Architects **VISTAAR** and should be used for the purpose expressly issued.

GENERAL NOTES
1. All dimensions are in feet and inches.
2. Do not scale this drawing follow written dimensions only.
3. This drawing should be read in conjunction with other architectural and structural drawings.
4. Any discrepancy in the drawing should be immediately brought to the notice of architect.

PROJECT TITLE

 
CITY PALM
BUILDING AT PLOT-E-84,JAGDAMBA
NAGAR-E,JAIPUR

DRAWING TITLE


WATER SUPPLY DIAGRAM

ARCHITECTS :

VISTAAR ARCHITECTS & PLANNERS
Architects :: Interior Designers
B-2/12, Chitrkoot scheme,
main Gandhi Path,Opp mall of jaipur,Jaipur
PH.- 0141-4116461,09001010366

DRN.	DATE	REV.	NORTH
MANOJ KUMARWAT		23-06-2023	
SCALE	JOB NO.		
NTS			

40'-0" WIDE ROAD

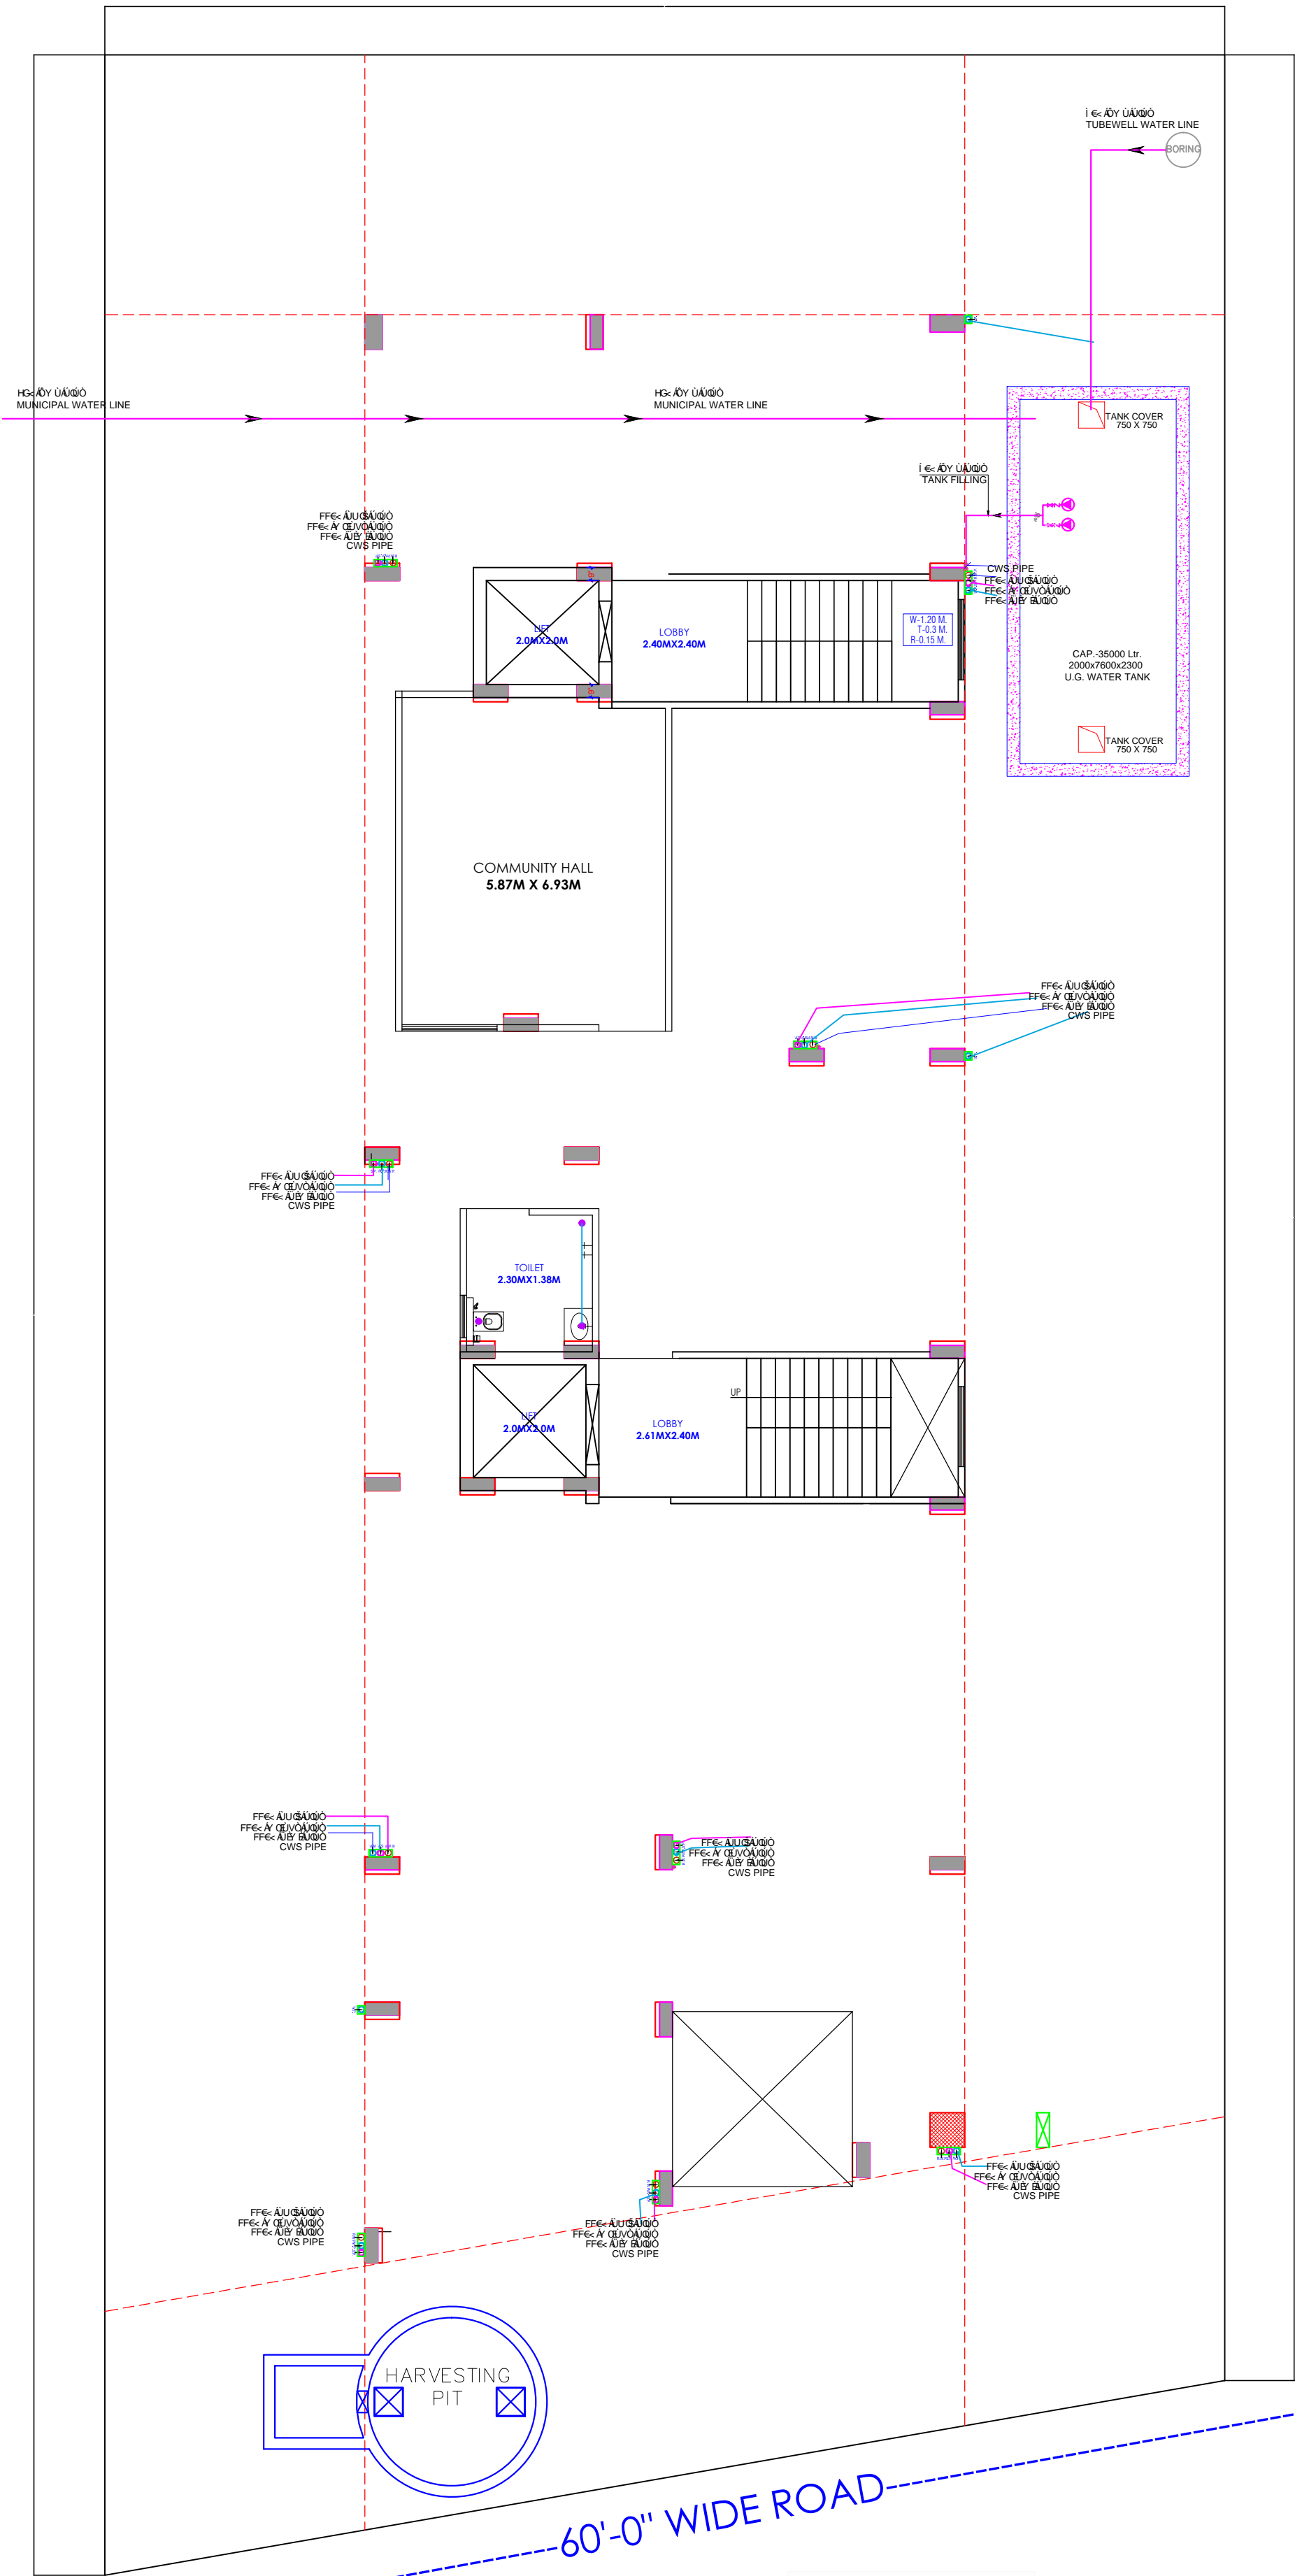

①	RAIN WATER PIPE		
②	WEST WATER PIPE		
③	SOIL WATER PIPE		
④	INSPECTION CHAMBER / GULLY TRAP		2'6" DEPTH
⑤	MAN HOLE		2'6" DEPTH
⑥	ELECTRICAL PIPELINE		

LEGENDS		
S.NO.	SYMBOL	DESCRIPTION
1.		SDR-11 Fresh Water Pipe
2.		SDR-11 Solar Water Pipe
3.		Waste Water Pipe (W.P.)
4.		Soil Pipe (S.P.)
5.		Rain Water Pipe (R.W.P.)
6.		Butter Fly Valve(B.F.V.)
7.		Geyser
8.		RO
9.		Single Lever Diverter
10.		Concealed Valve
11.		Angle Valve
12.		Nahani Trap
13.		P-Trap
14.		Tap
15.		Floor Drain (F.D.)
16.		Plain Tee (P-tee)
17.		Gully Trap (G.T.)
18.		

WARNING

1. This drawing is the sole copyright of Architects **VISTAAR** and should be used for the purpose expressly issued.

GENERAL NOTES

1. All dimensions are in feet and inches.
2. Do not scale this drawing follow written dimensions only.
3. This drawing should be read in conjunction with other architectural and structural drawings.
4. Any discrepancy in the drawing should be immediately brought to the notice of architect.

PROJECT TITLE

CITY PALM
BUILDING AT PLOT-E-84,JAGDAMBA
NAGAR-E,JAIPUR

DRAWING TITLE

STILT FLOOR PLAN
COMMON AREA WATER SUPPLY PLAN

ARCHITECTS :

VISTAAR ARCHITECTS & PLANNERS
Architects :: Interior Designers
B-2/12, Chitrkoot scheme,
main Gandhi Path,Opp mall of jaipur,Jaipur
PH. - 0141-4116461,09001010366

PATH :-

DRN.

DATE

REV.

NORTH


MANOJ KUMAWAT

23-06-2023

SCALE

JOB NO.

N.T.S

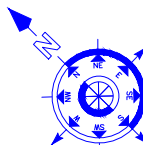

For R K Builders & Developers
Proprietor

Krishna
KRISHNA KUMAR
B. Tech. (Mechanical)
M.E.P Consultant