
 


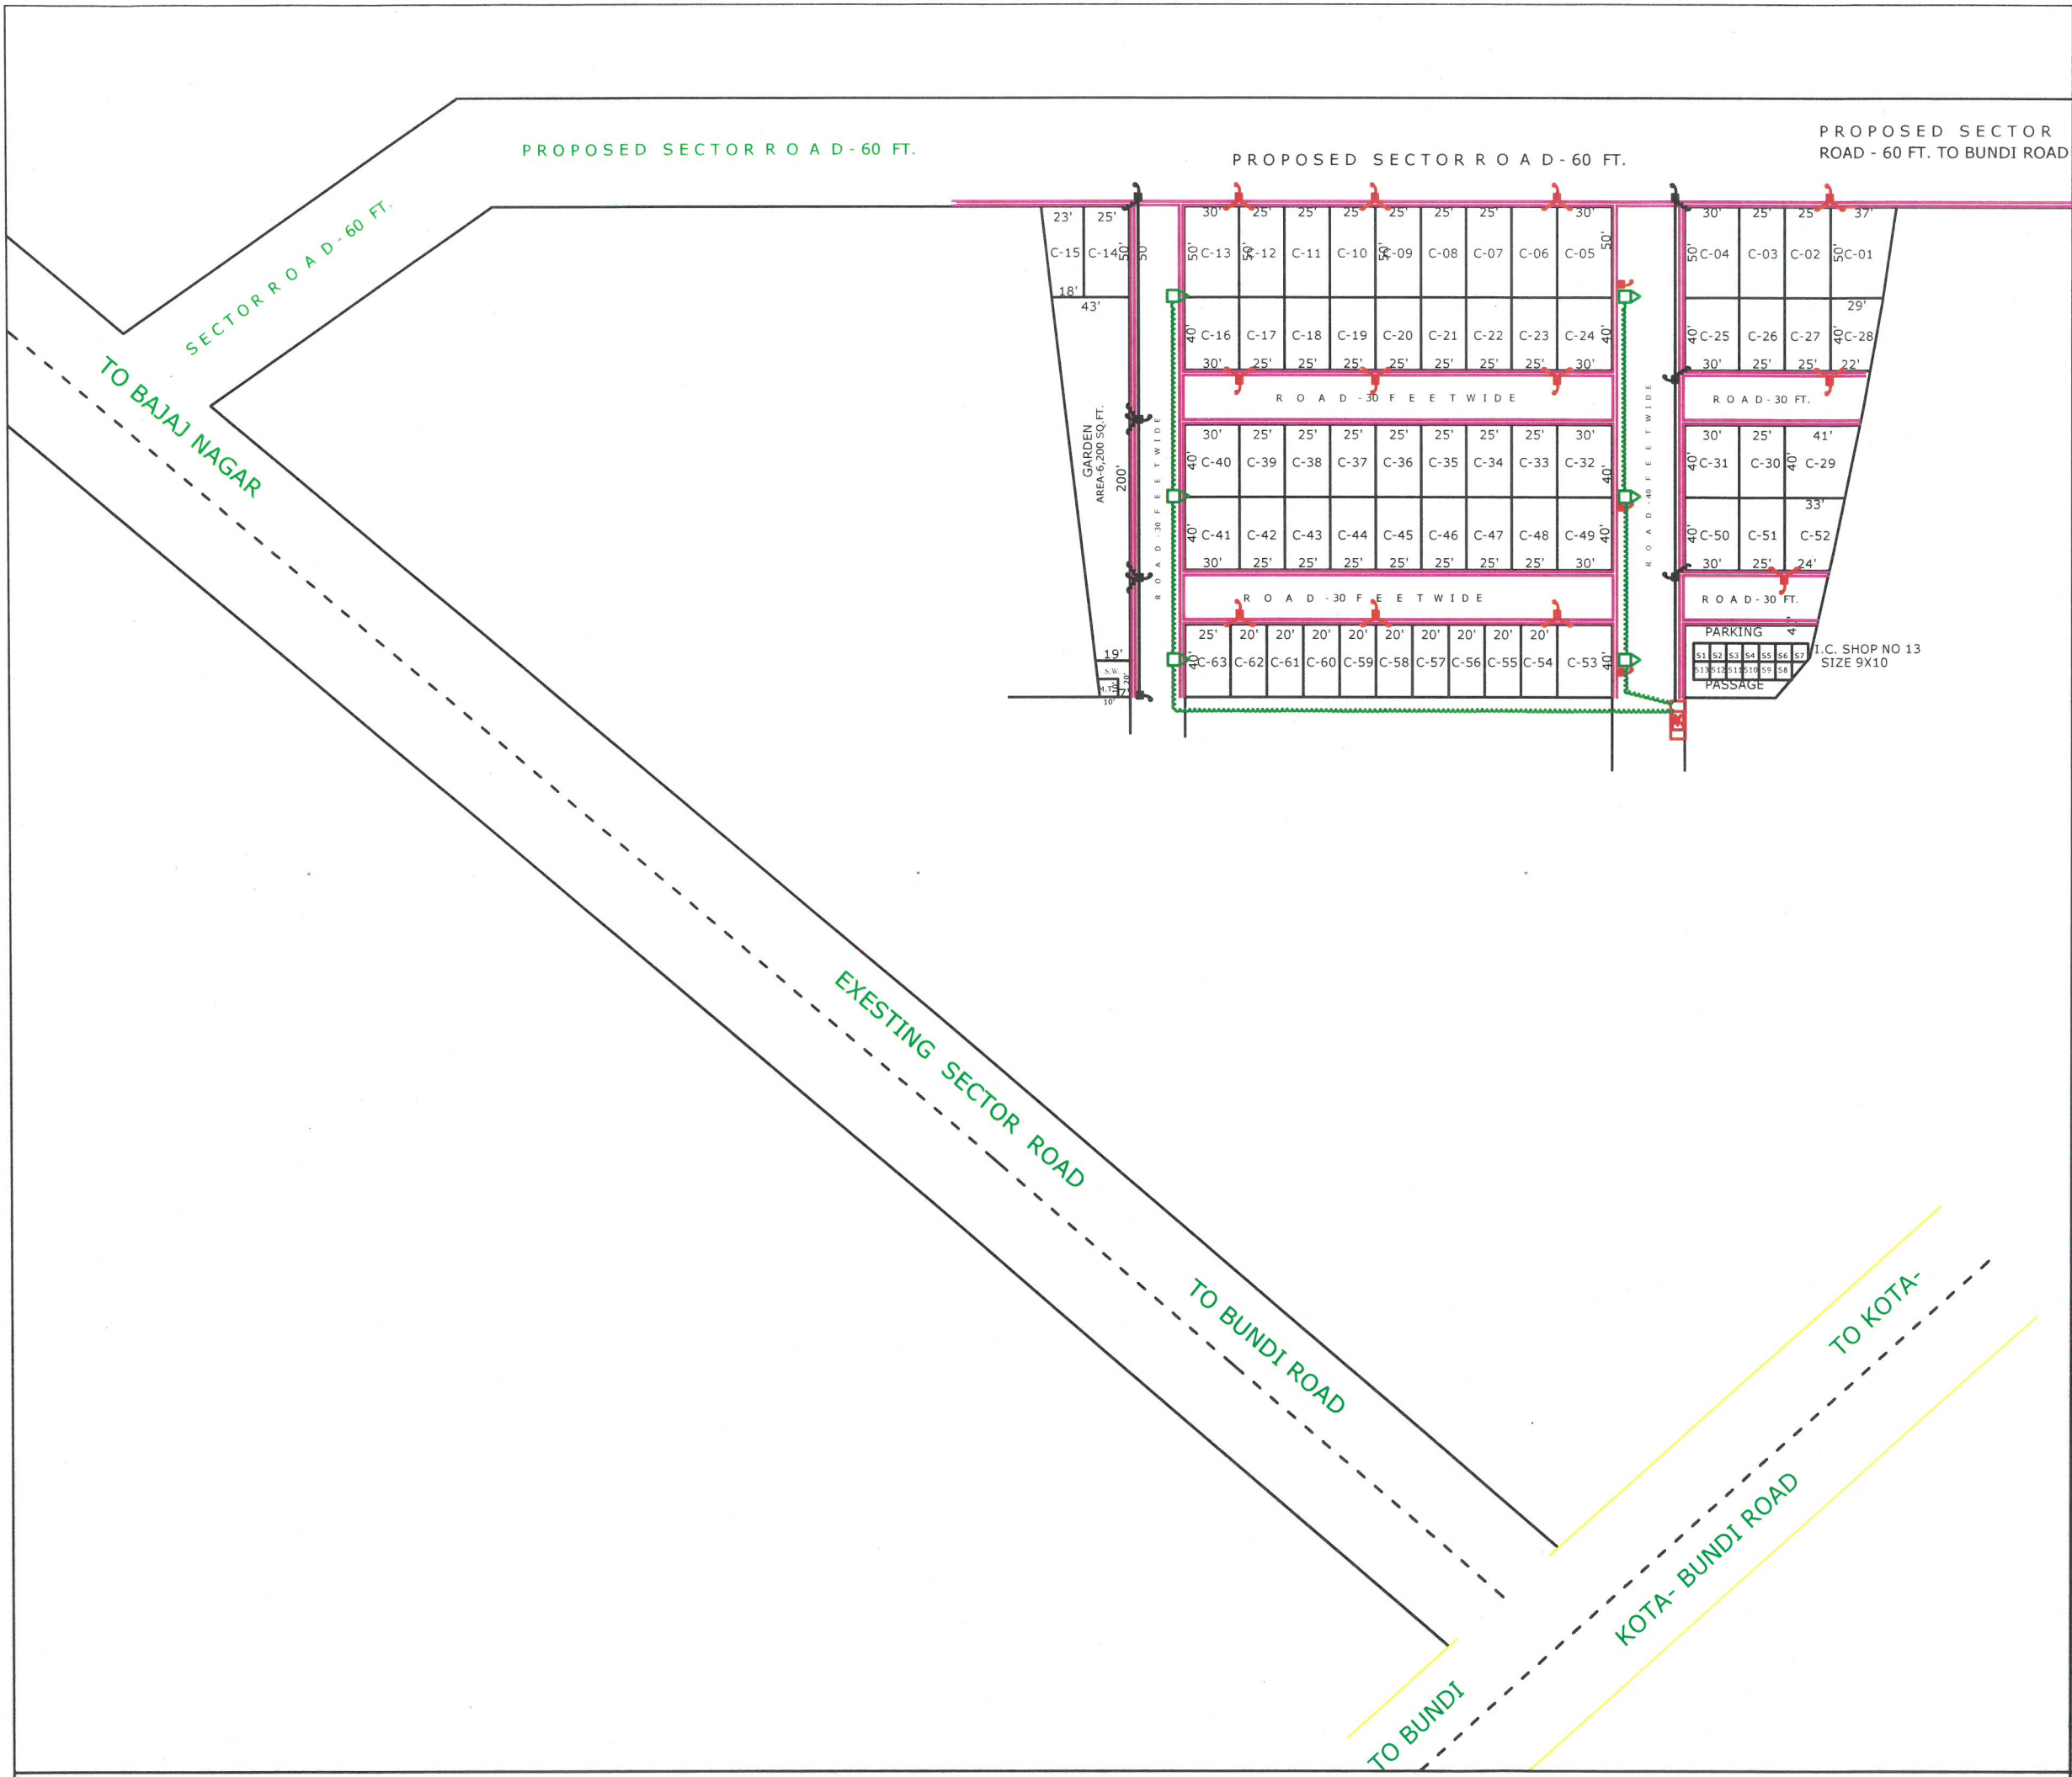

RIDDHI MENSION ,
KUNHADI
PROPOSED LAYOUT PLAN FOR
RISIDENTIAL PLOT'S SCHEME
NEAR EXOTICA GARDEN BUNDI
ROAD IN KHASRA NO.: -76(PART)
VILLAGE :KUNARI
TEH. LADPURA,DIST. KOTA (RAJ.)

LEGEND	
SYMBOL	DESCRIPTION
	LT LINE OVER HEAD
	HT LINE & LT LINE COMPOSITE OVER HEAD
	TRANSFORMER
	STREET LIGHT
	STREET LIGHT POLE DOUBLE ARM
	LT CABLE UNDER GROUND
	LT DISTRIBUTION PANEL

B. LAHOTY
B.E. (Civil), MIE (Arch. Engg.)
Chartered Engineer No.- M-119028-2
Govt. Approved Valuer CAT-1/105/CCIT/T-63/96-97



Client	
Project PROPOSED LAYOUT PLAN FOR RISIDENTIAL PLOT'S SCHEME NEAR EXOTICA GARDEN BUNDI ROAD IN KHASRA NO.: -76(PART) VILLAGE :KUNARI TEH. LADPURA,DIST. KOTA (RAJ.)	
Drawing Title ELECTRICAL LAYOUT PLAN	
SCALE : 1"=40'	NAME OF SCHEME:
LOCATION :	DRAWING NO. -
JOB NO. -	DATE - APR., 27th, 2024

ELECTRICAL LAYOUT PLAN