


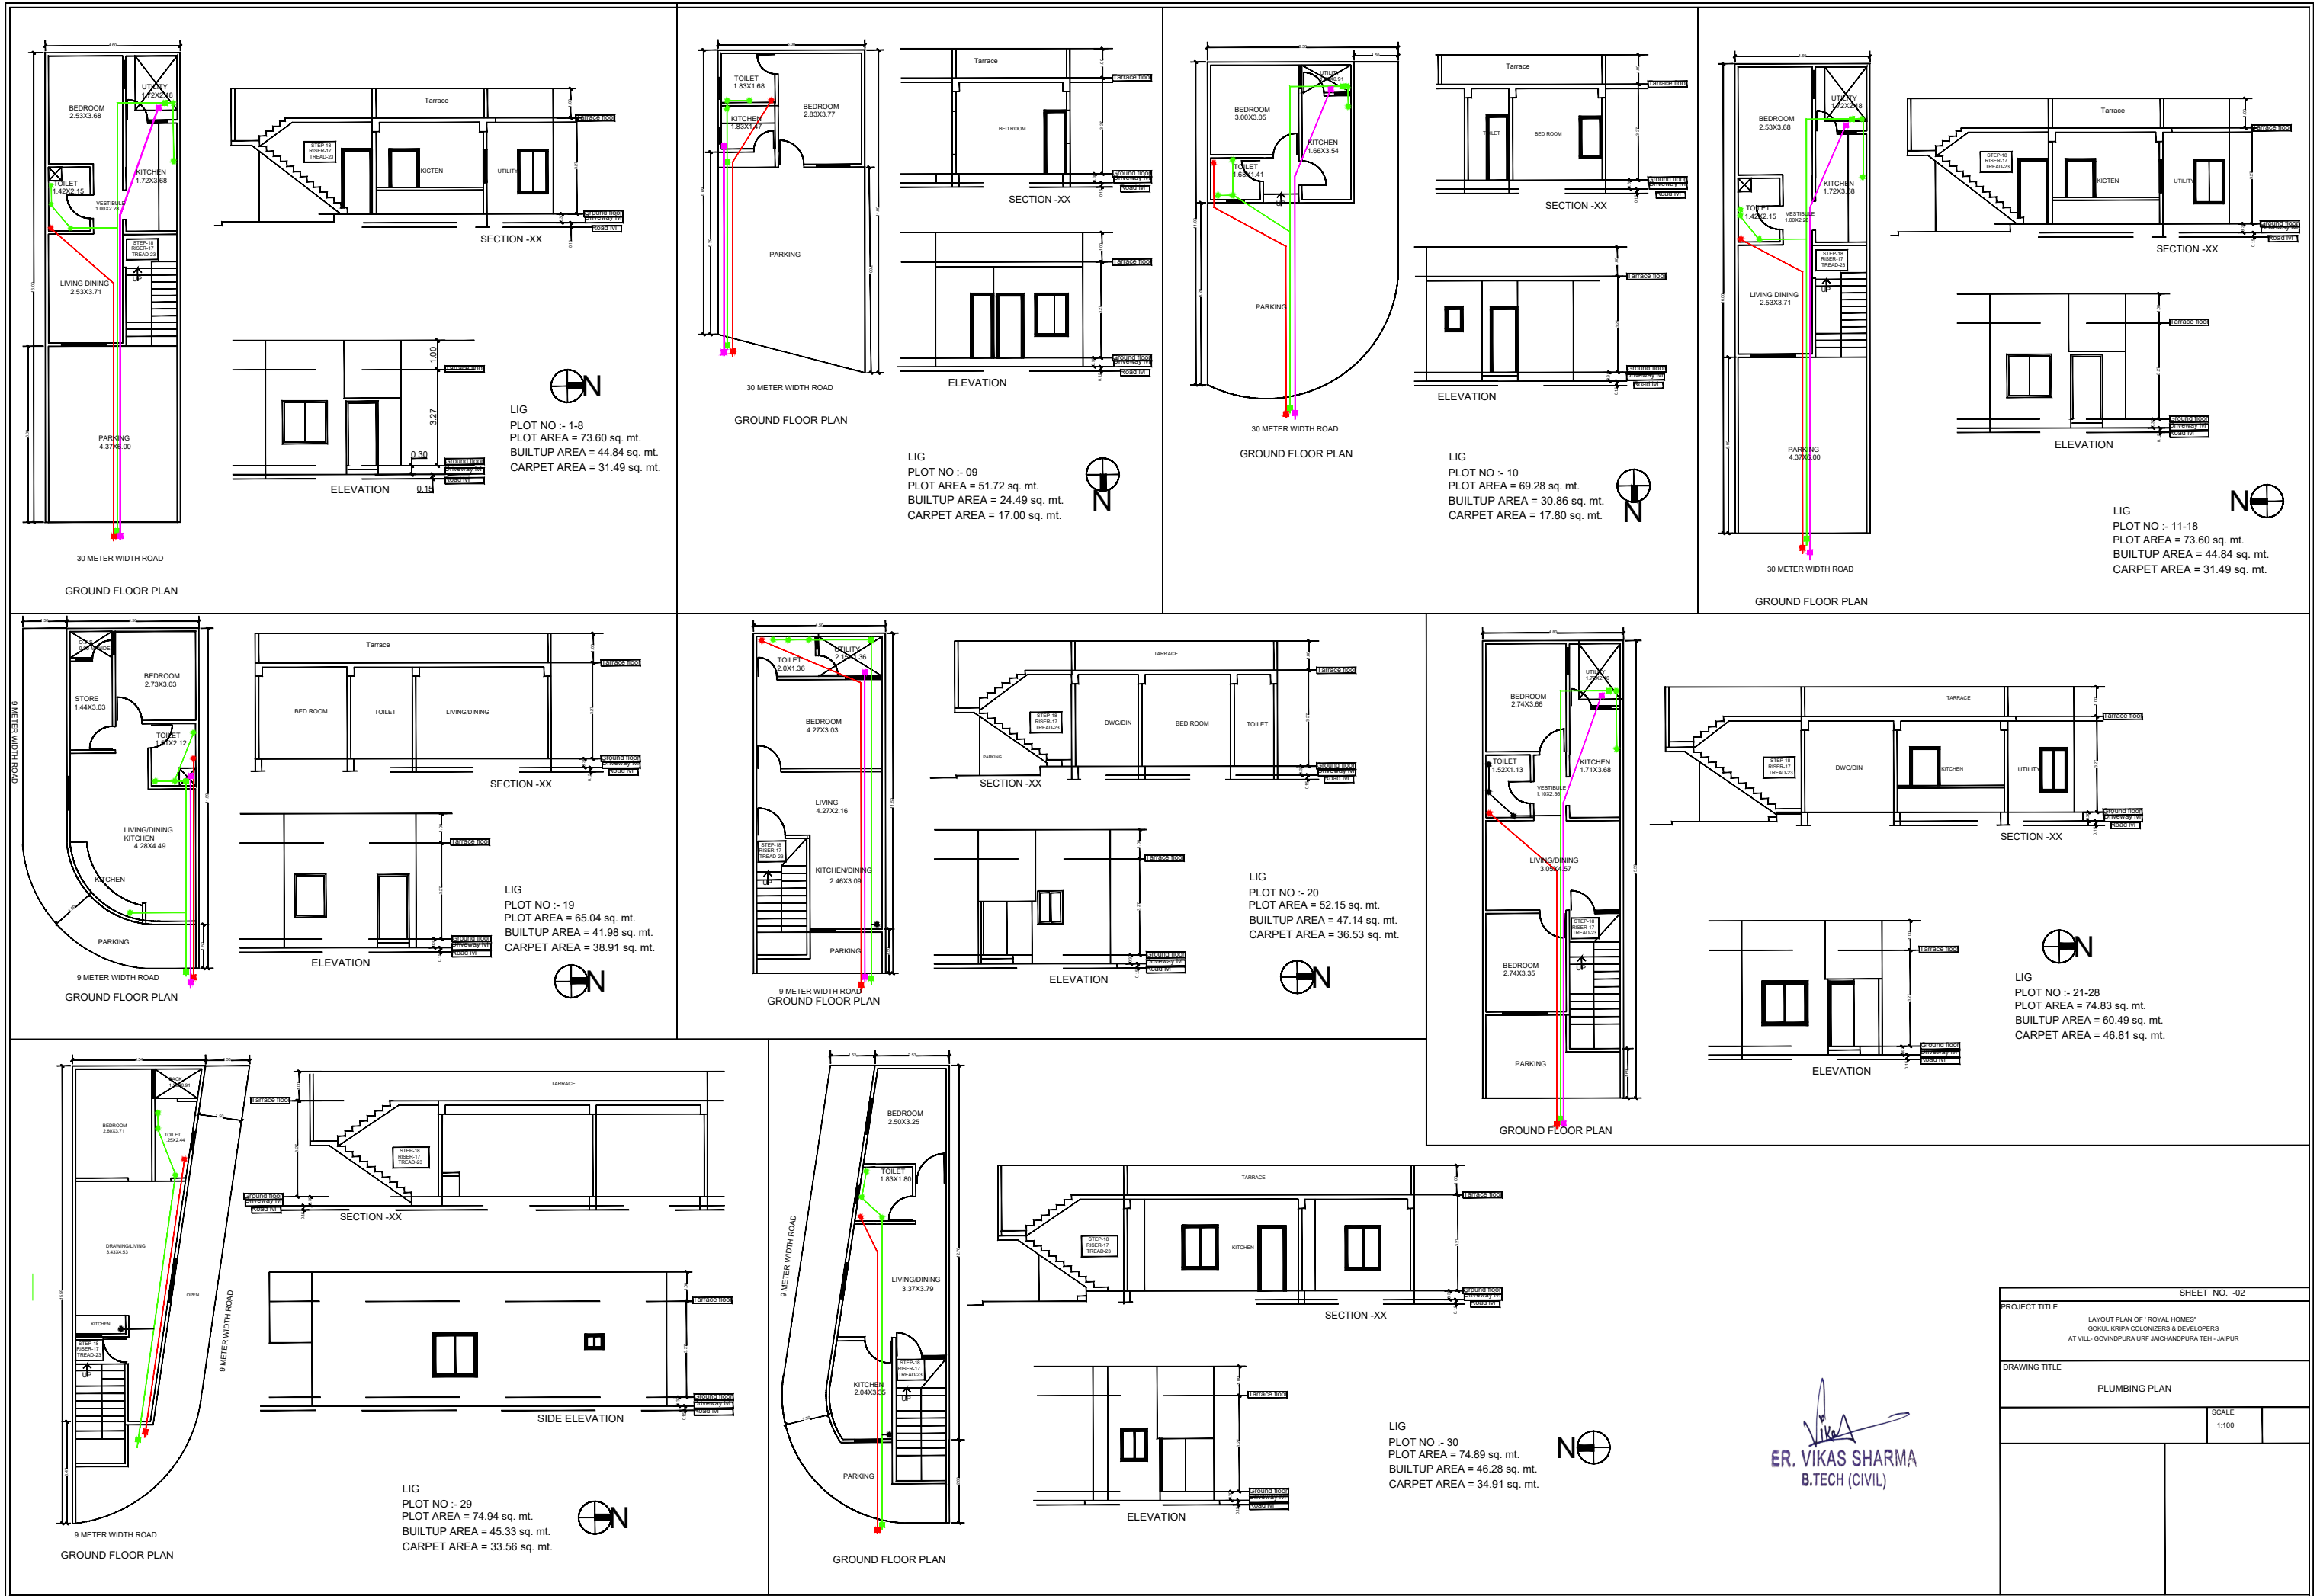


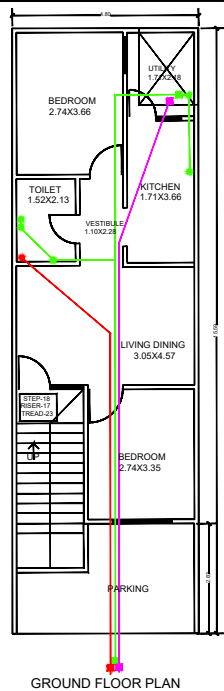


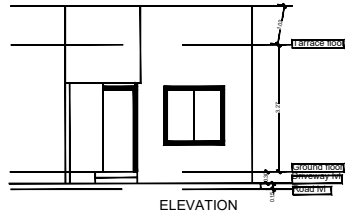



GROUND FLOOR PLAN

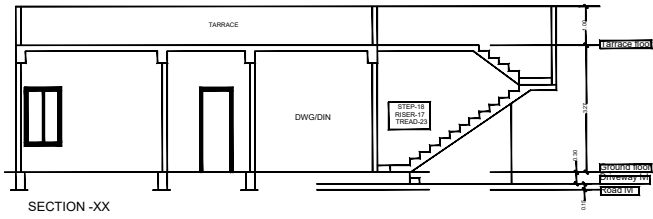


LIG
PLOT NO :- 31-38
PLOT AREA = 74.83 sq. mt.
BUILTUP AREA = 60.49 sq. mt.
CARPET AREA = 46.81 sq. mt.

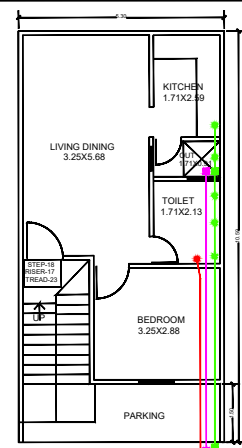



GROUND FLOOR PLAN

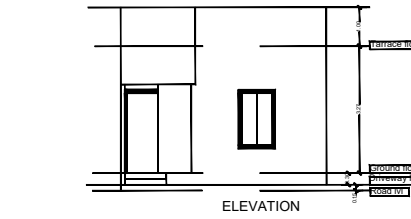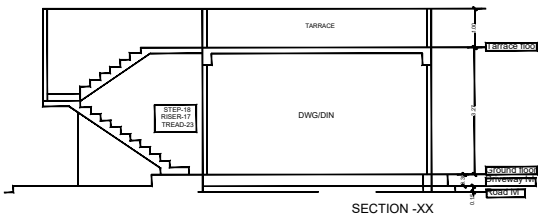


LIG
PLOT NO :- 39
PLOT AREA = 56.12 sq. mt.
BUILTUP AREA = 49.92 sq. mt.
CARPET AREA = 36.98 sq. mt.

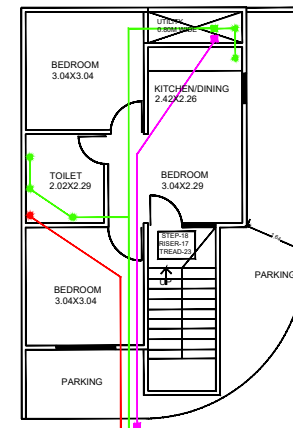



GROUND FLOOR PLAN

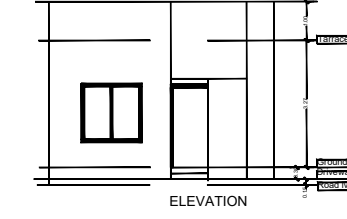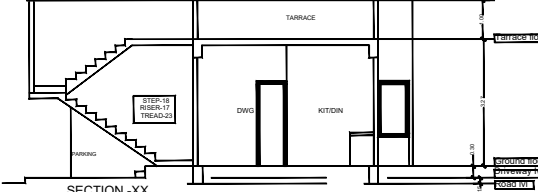


LIG
PLOT NO :- 40
PLOT AREA = 72.80 sq. mt.
BUILTUP AREA = 48.75 sq. mt.
CARPET AREA = 37.64 sq. mt.

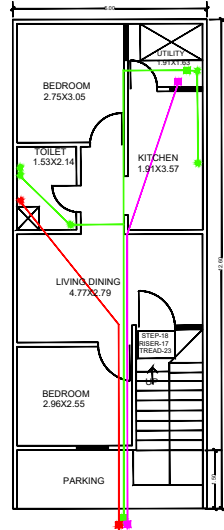



GROUND FLOOR PLAN

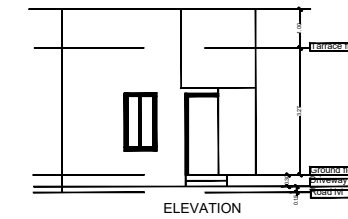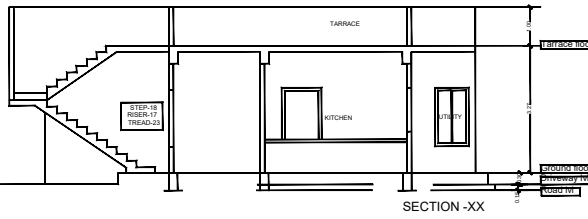


LIG
PLOT NO :- 41
PLOT AREA = 63.00 sq. mt.
BUILTUP AREA = 55.47 sq. mt.
CARPET AREA = 42.70 sq. mt.

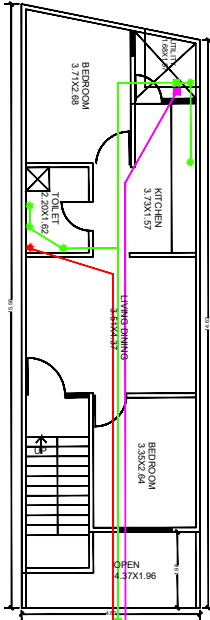



GROUND FLOOR PLAN

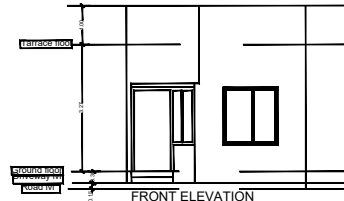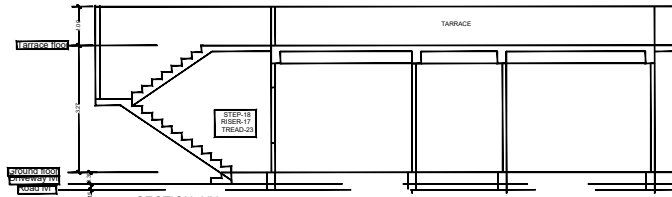


LIG
PLOT NO :- 42
PLOT AREA = 69.44 sq. mt.
BUILTUP AREA = 60.34 sq. mt.
CARPET AREA = 47.35 sq. mt.

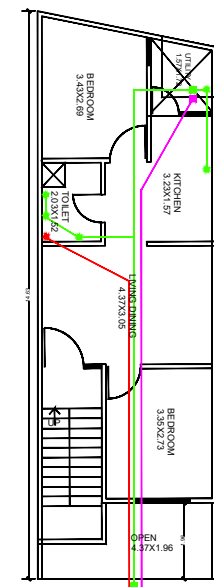



GROUND FLOOR PLAN

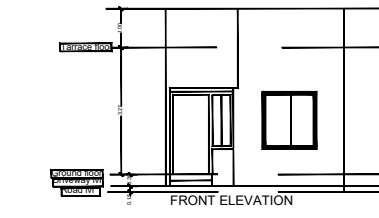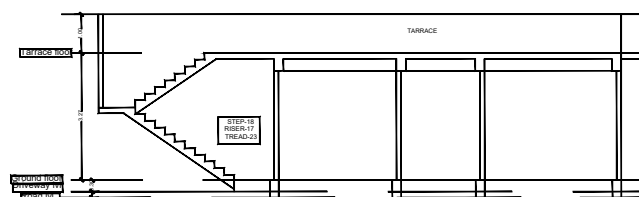


LIG
PLOT NO :- 43
PLOT AREA = 65.17 sq. mt.
BUILTUP AREA = 55.94 sq. mt.
CARPET AREA = 43.56 sq. mt.

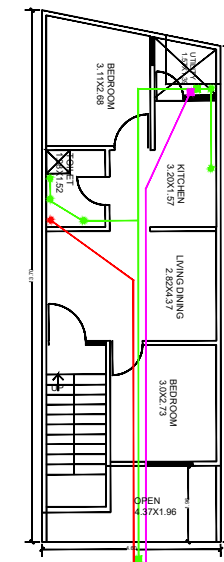



GROUND FLOOR PLAN

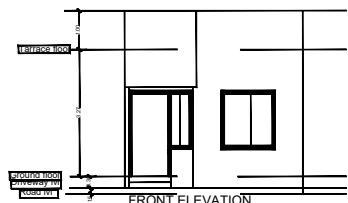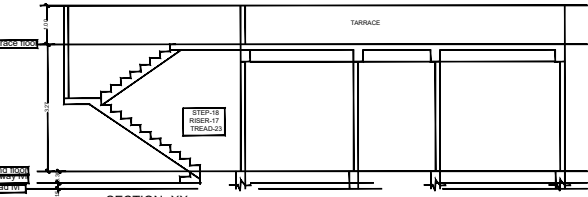


LIG
PLOT NO :- 44
PLOT AREA = 60.91 sq. mt.
BUILTUP AREA = 52.30 sq. mt.
CARPET AREA = 40.58 sq. mt.

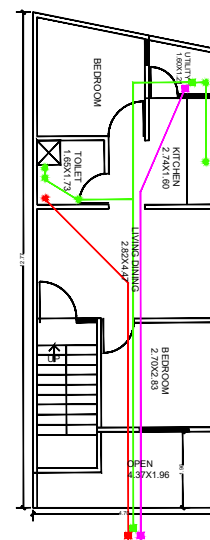



GROUND FLOOR PLAN

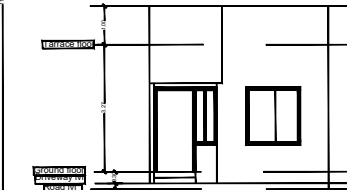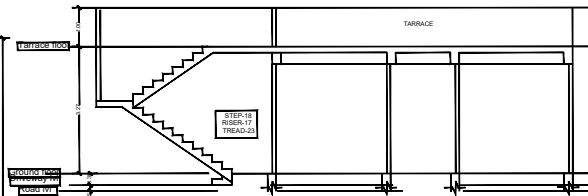

LIG
PLOT NO :- 45
PLOT AREA = 57.81 sq. mt.
BUILTUP AREA = 48.77 sq. mt.
CARPET AREA = 38.27 sq. mt.

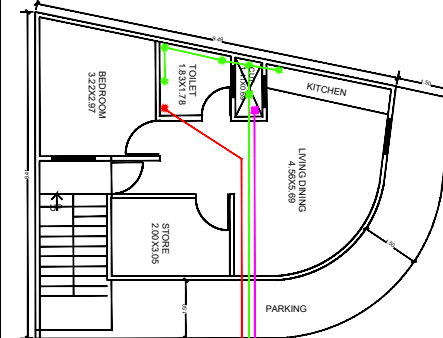









GROUND FLOOR PLAN

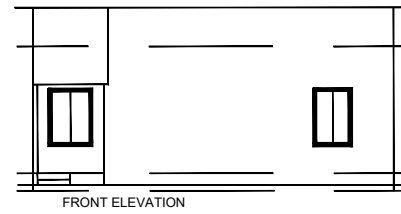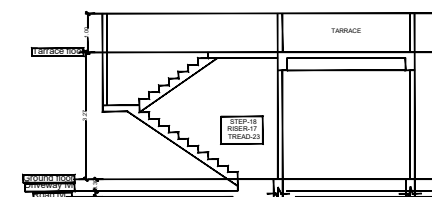

LIG
PLOT NO :- 46
PLOT AREA = 72.95 sq. mt.
BUILTUP AREA = 54.63 sq. mt.
CARPET AREA = 41.88 sq. mt.










ER. VIKAS SHARMA
B.TECH (CIVIL)

PROJECT TITLE		SHEET NO. - 03	
LAYOUT PLAN OF "ROYAL HOMES"			
GOKUL KRISHA COLONIZERS & DEVELOPERS			
AT VILL - GOVINDPURA URF JAICHANDPURA TEH - JAIPUR			
DRAWING TITLE			
PLUMBING PLAN			
		SCALE	1:100

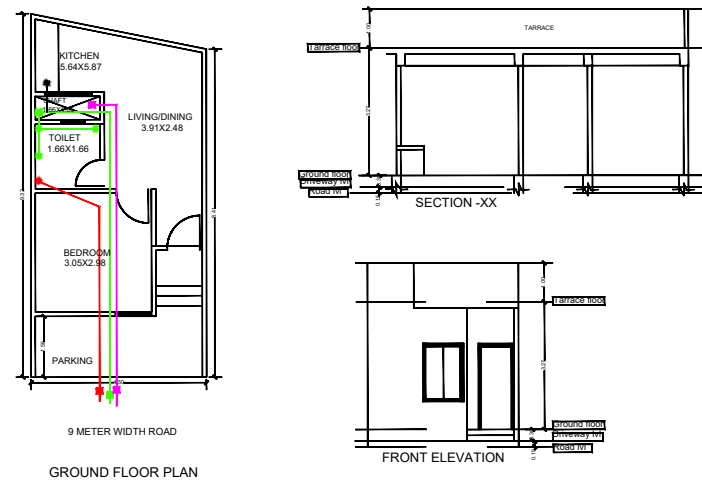
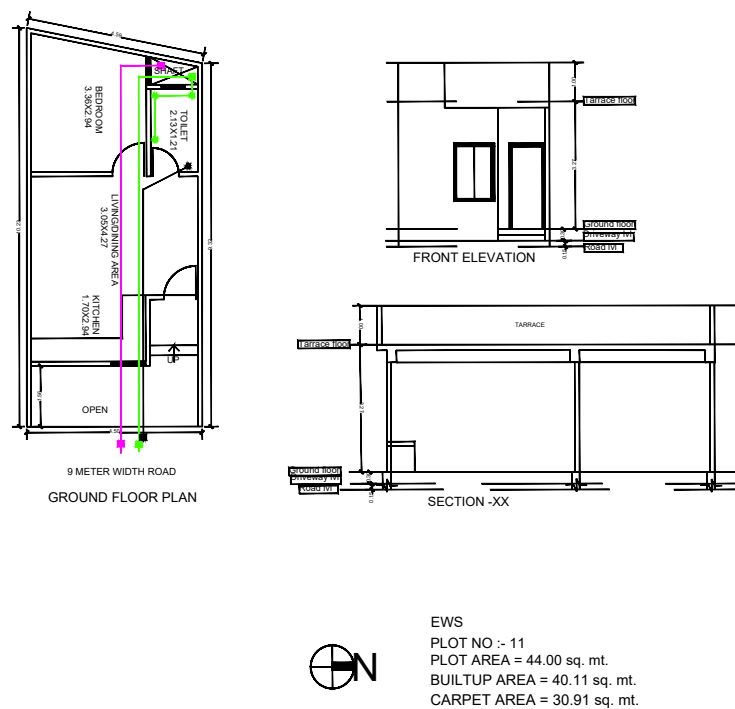
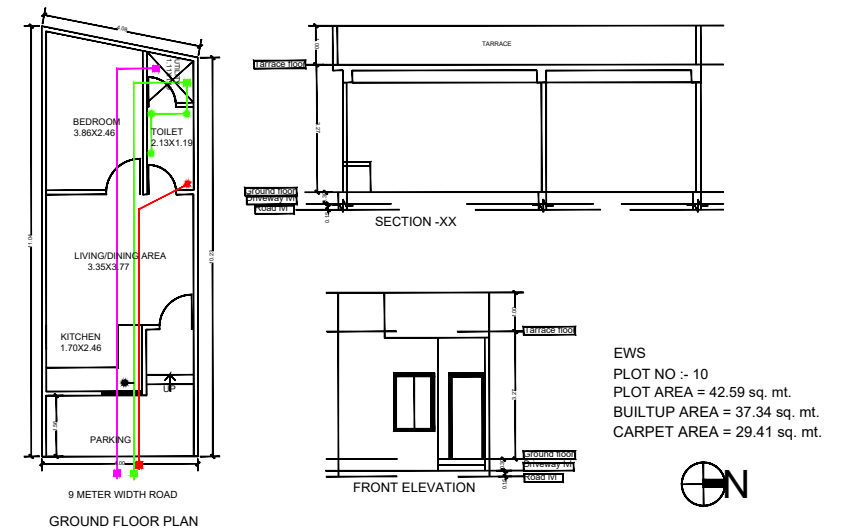
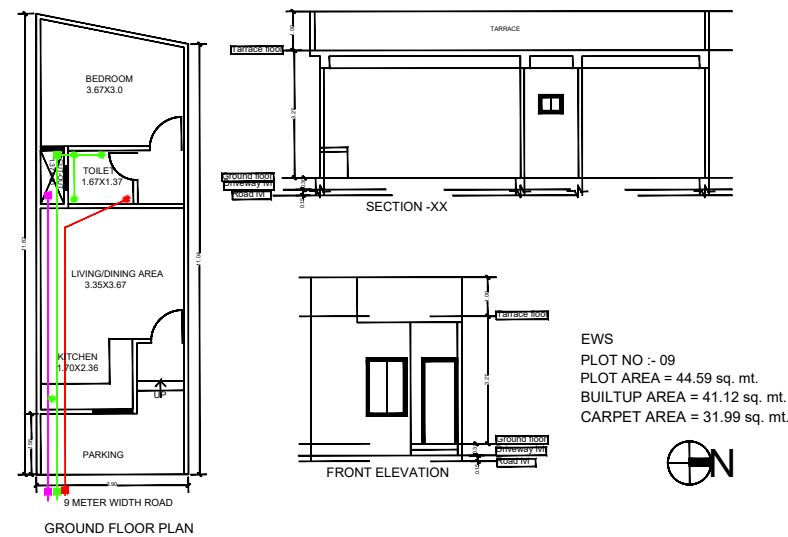
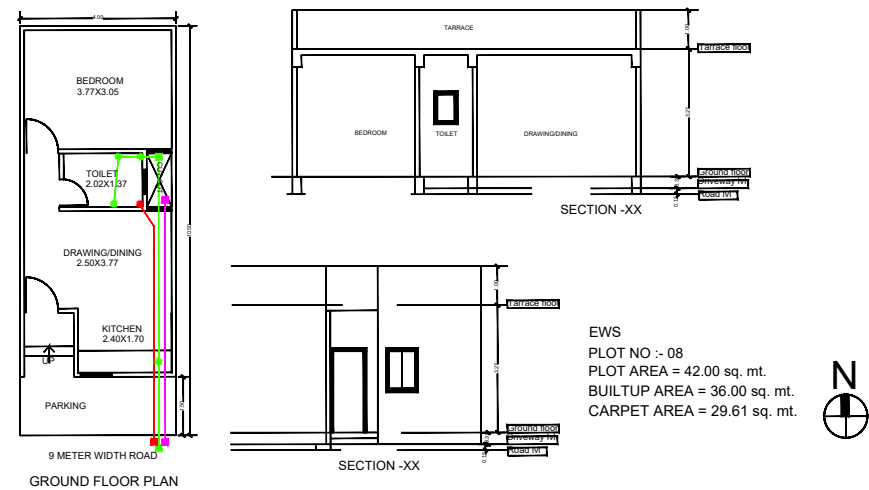
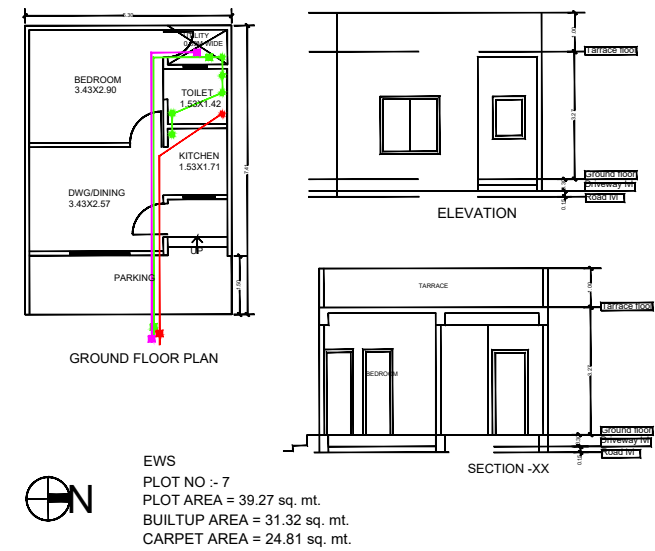
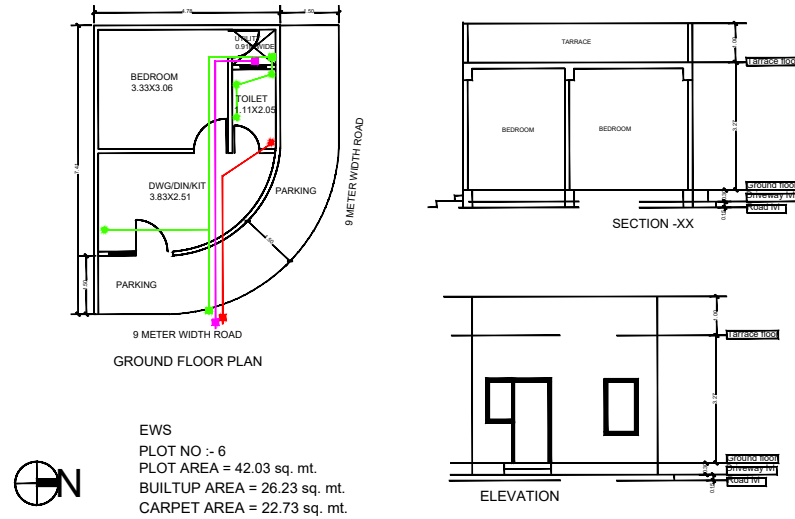
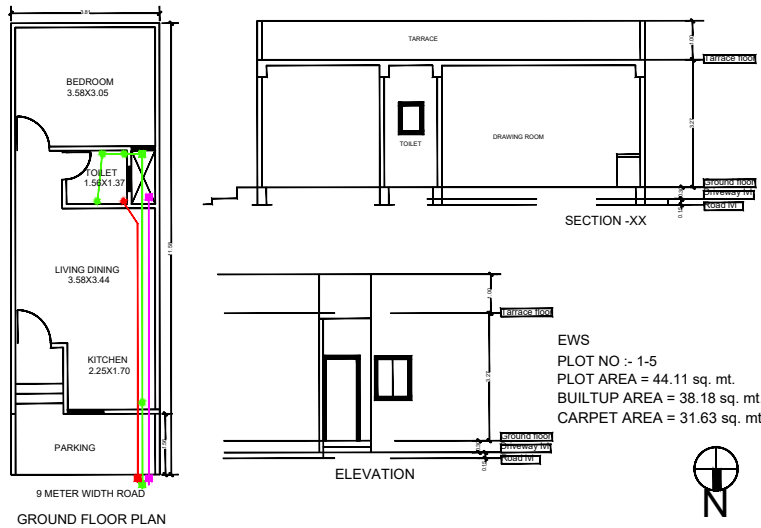


ER. VIKAS SHARMA
B.TECH (CIVIL)

PROJECT TITLE		SHEET NO. -04	
LAYOUT PLAN OF "ROYAL HOMES"			
GOKUL KRIPA COLONIZERS & DEVELOPERS			
AT VILL. GOVINDPURA URF, JAICHANDPURA TEH - JAJPUR			
DRAWING TITLE		PLUMBING PLAN	
		SCALE	1:100

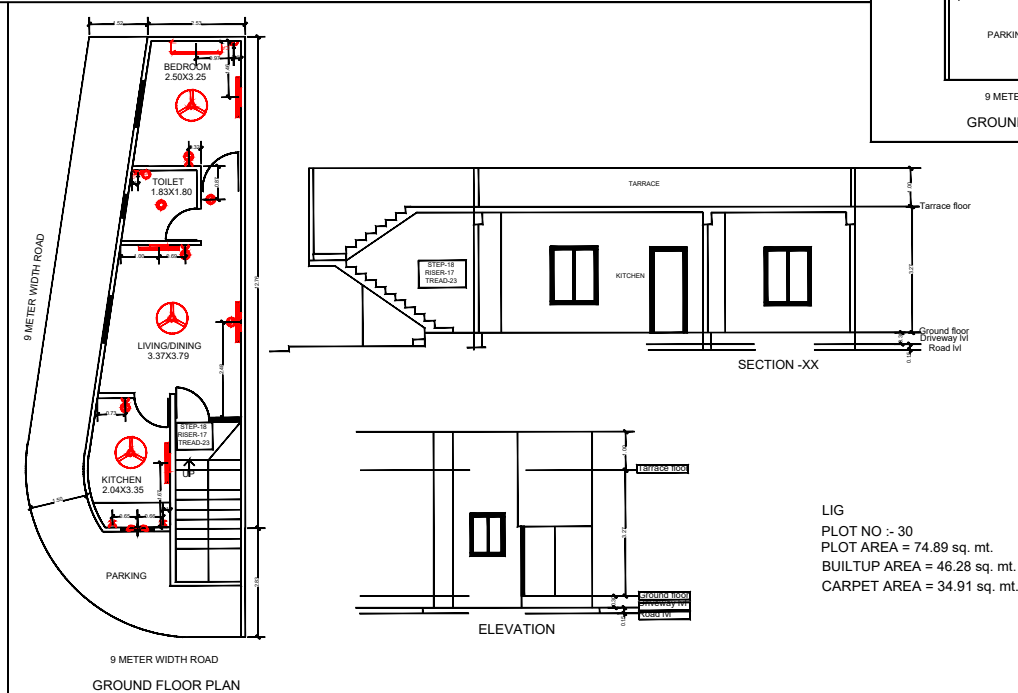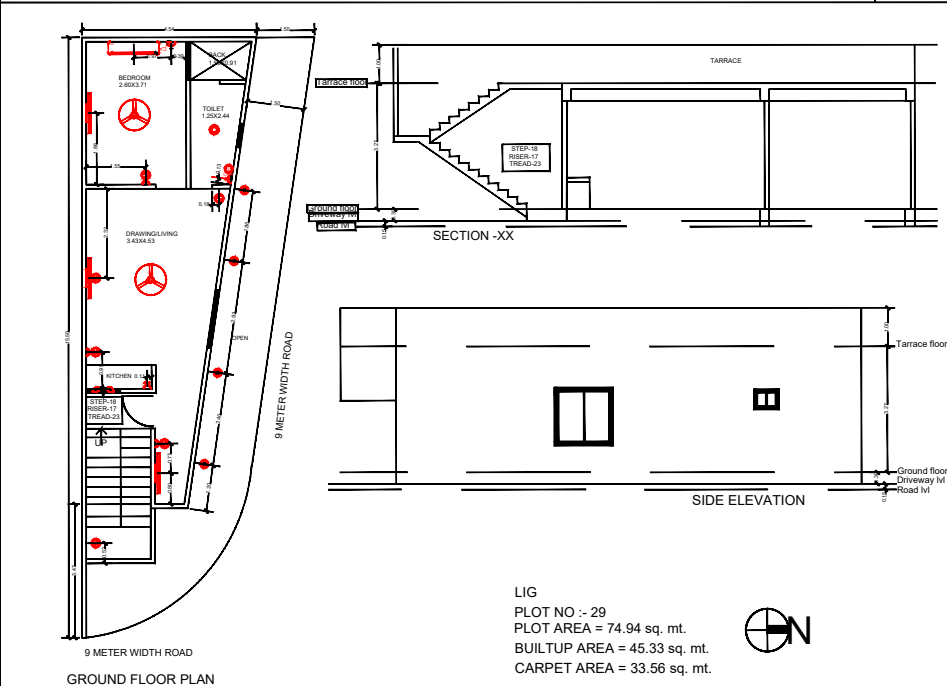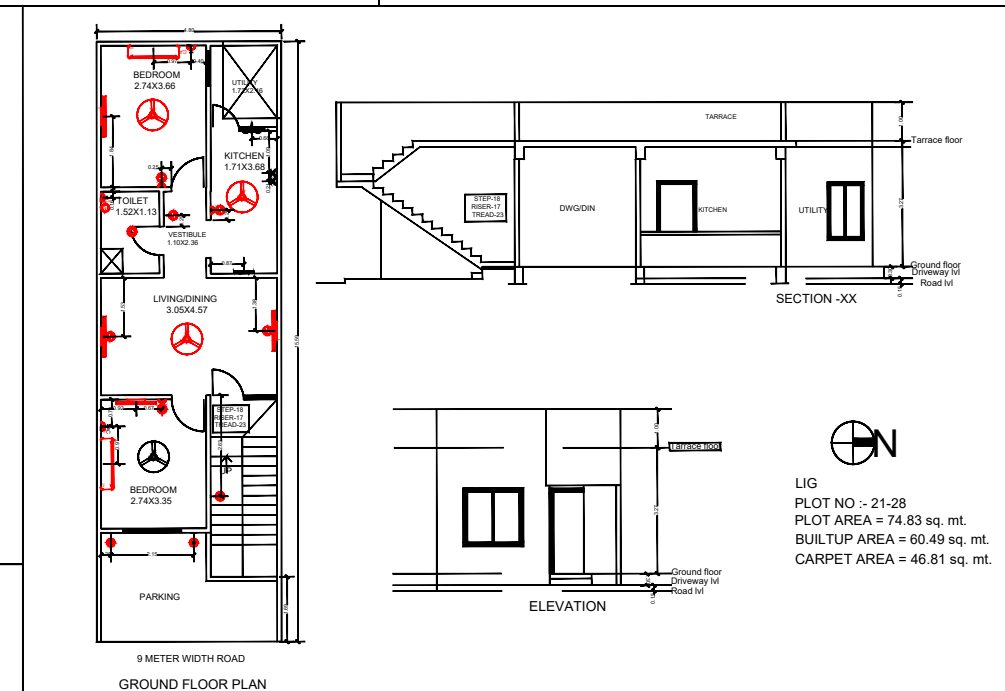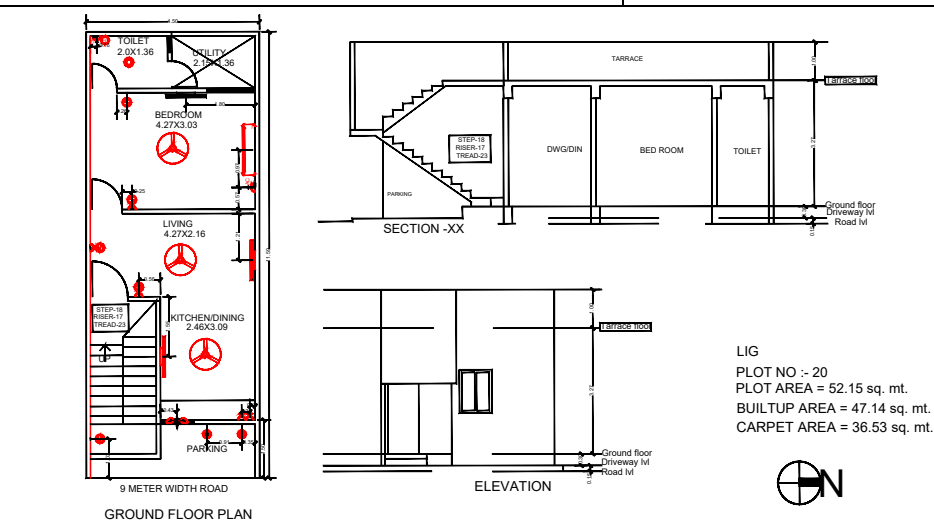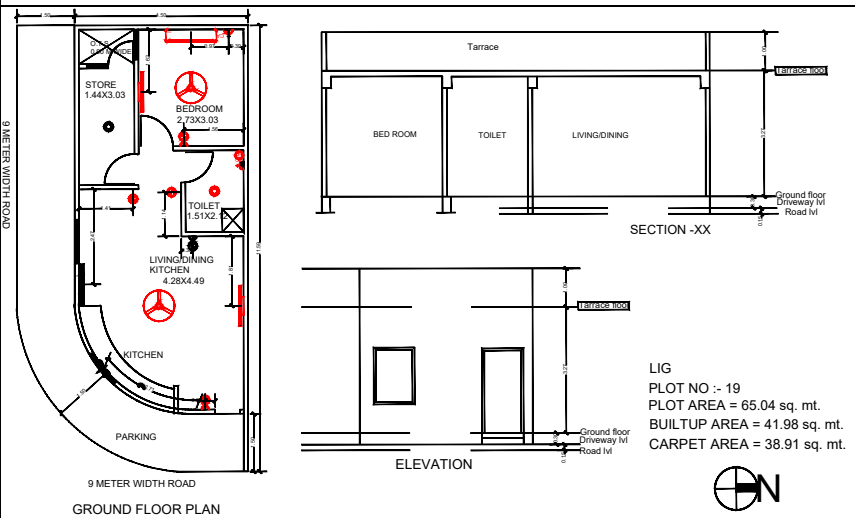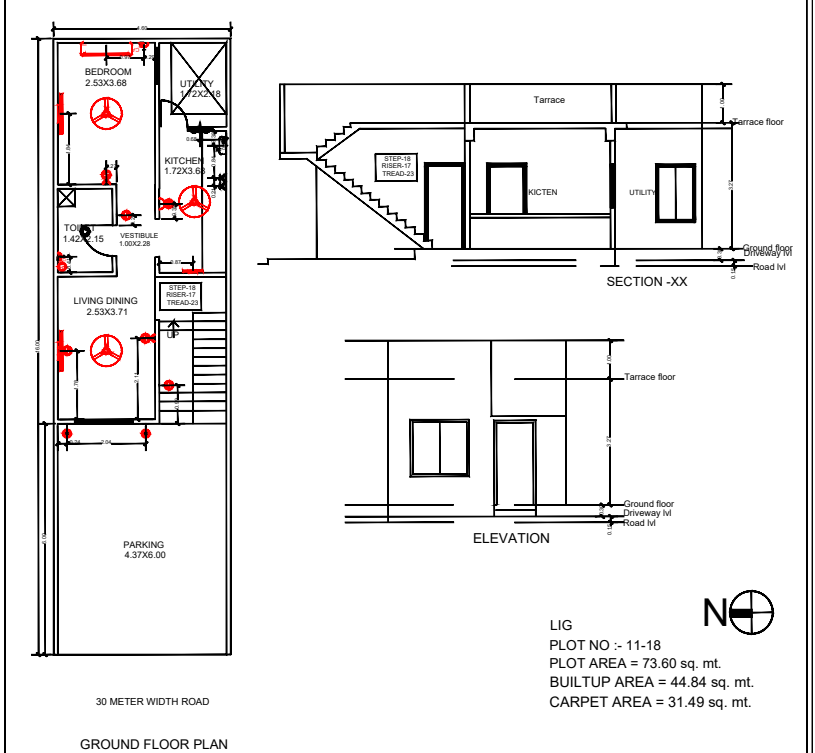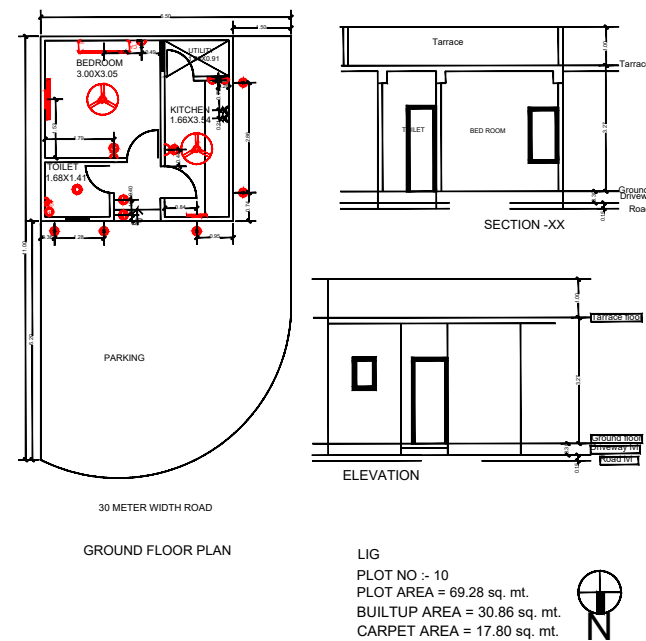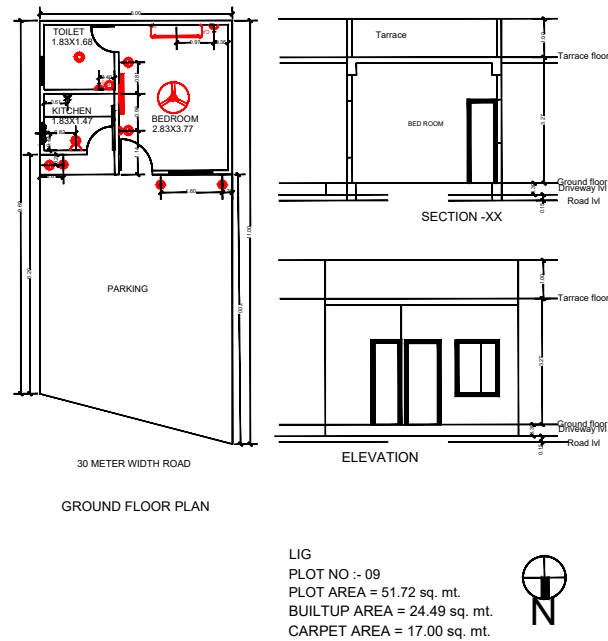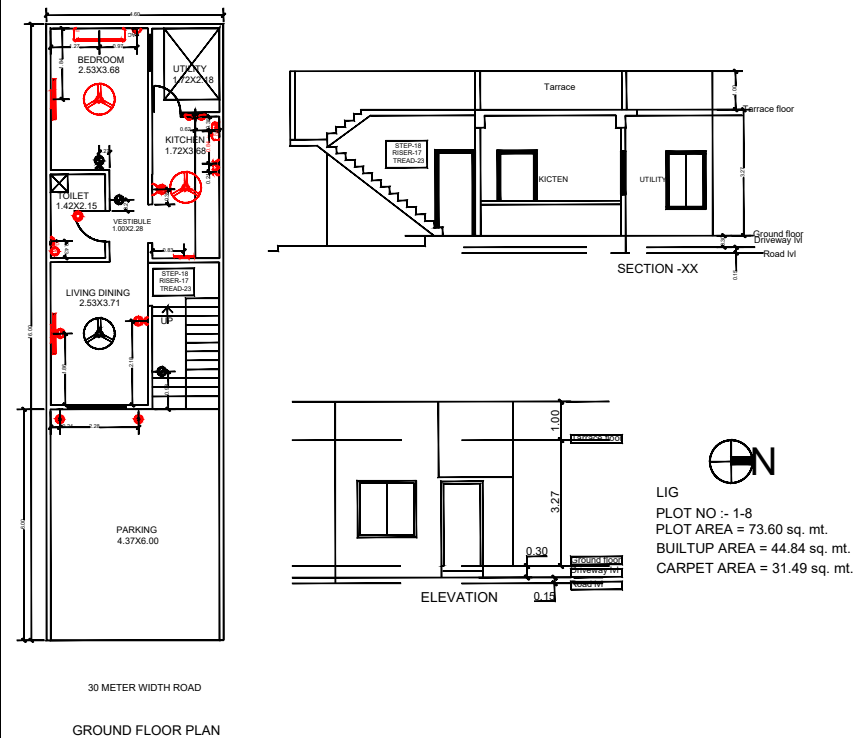

PROJECT TITLE		
LAYOUT PLAN OF "ROYAL HOMES" GOKUL KRISH COLONIZERS & DEVELOPERS AT VILL- GOVINDPURA URF JAICHANDPURA TEH - JAIPUR		
DRAWING TITLE		
ELECTRIC PLAN		
SCALE 1:100		

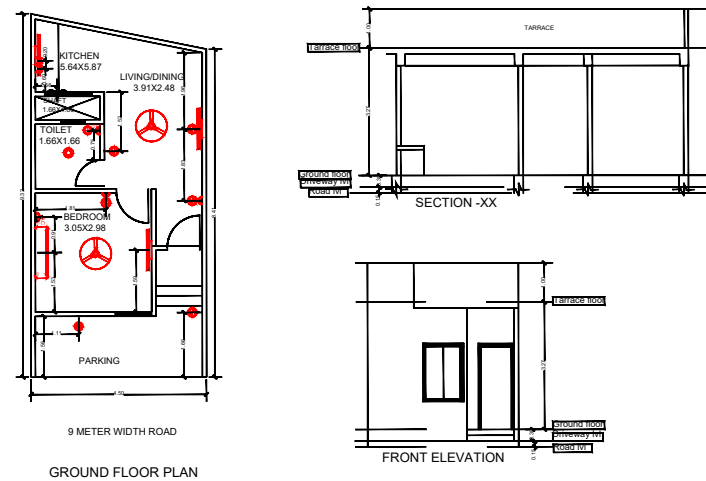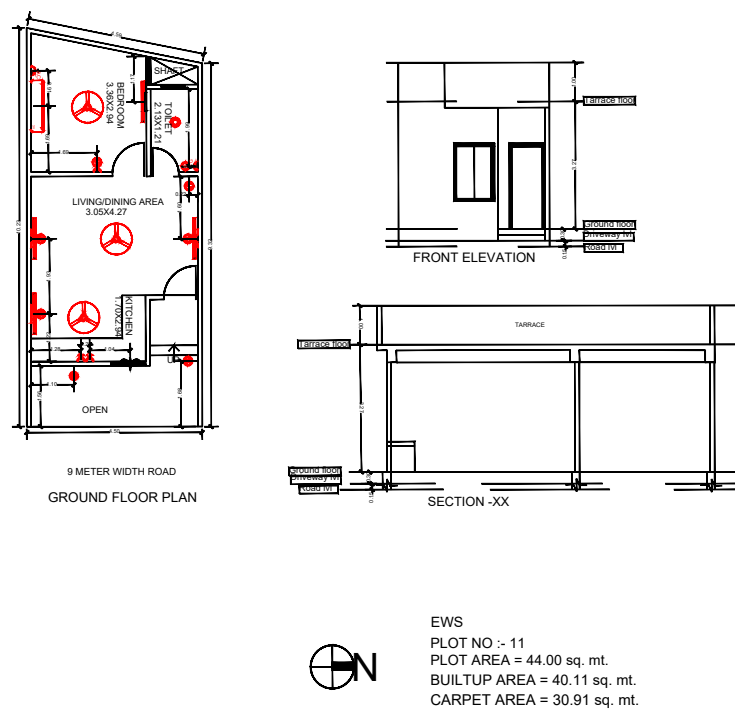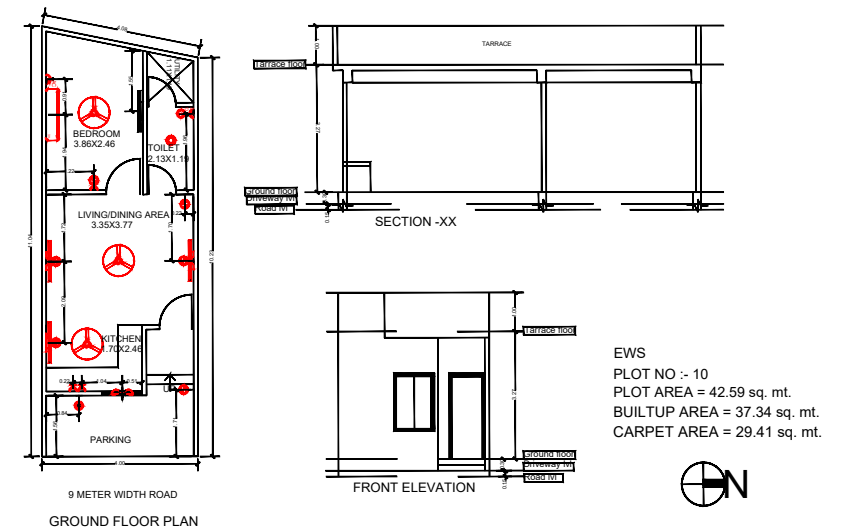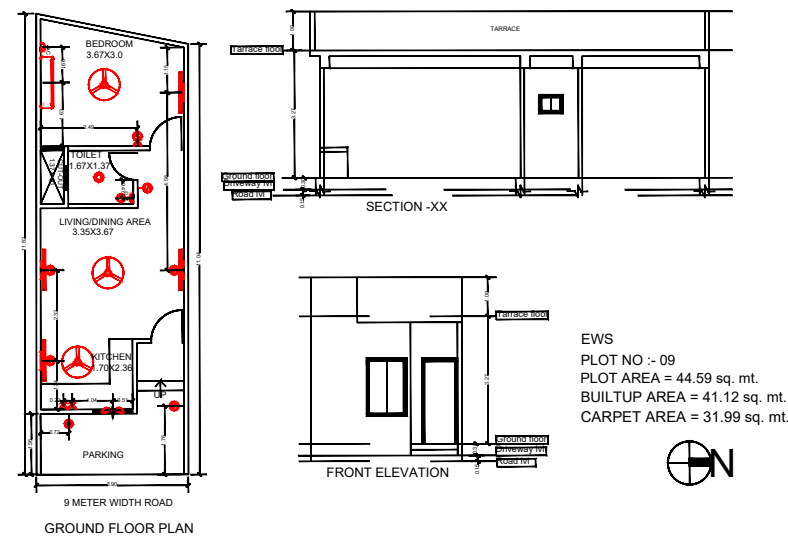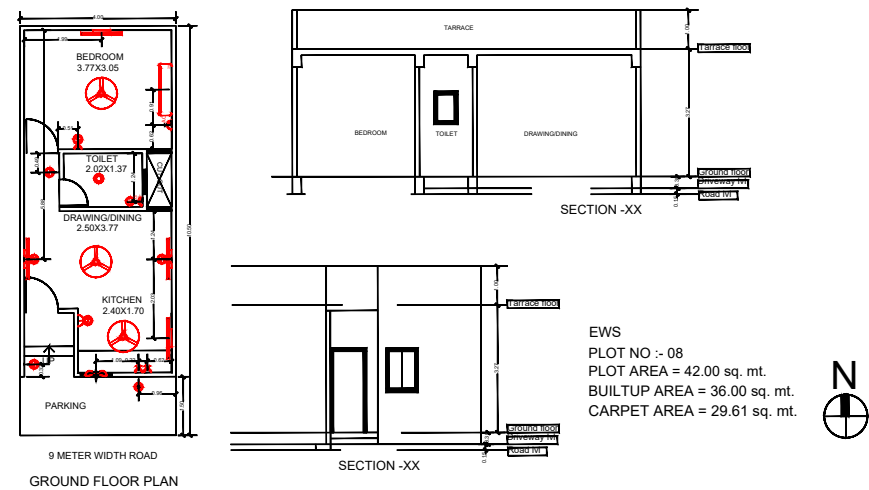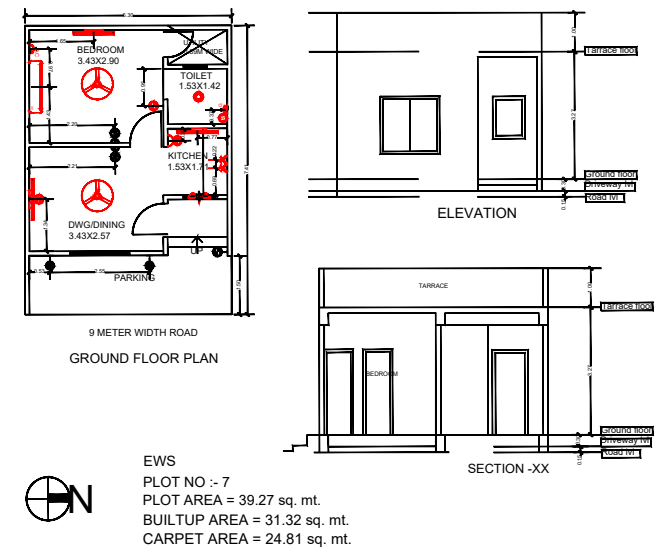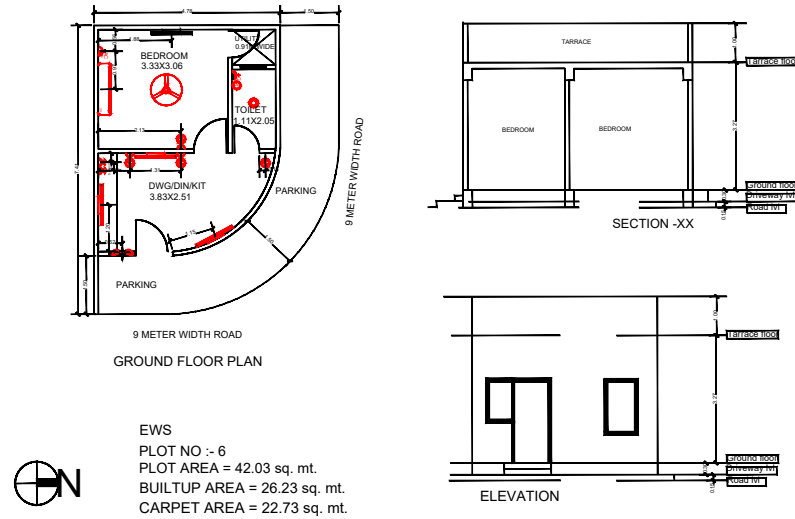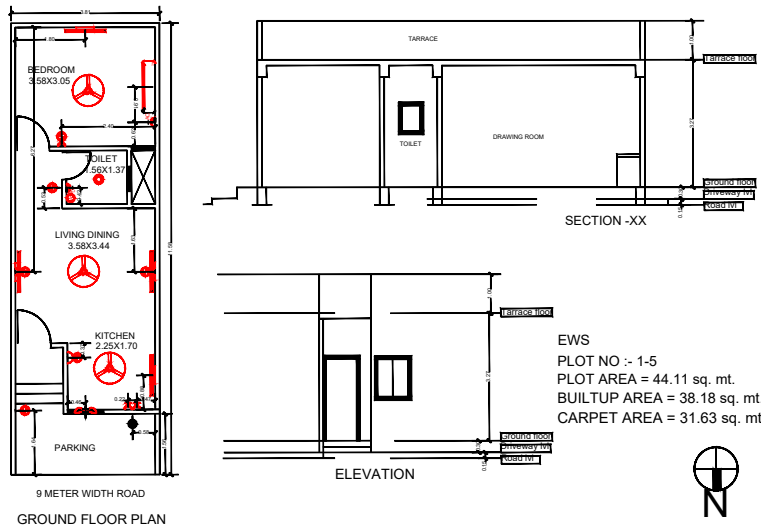

ER. VIKAS SHARMA
B.TECH (CIVIL)

SHEET NO. -04		
PROJECT TITLE		
LAYOUT PLAN OF "ROYAL HOMES" GOKUL KRIPA COLONIZERS & DEVELOPERS AT VILL- GOVINDPURA URF JAICHANDPURA TEH - JAJPUR		
DRAWING TITLE		
ELECTRIC PLAN		
		SCALE
		1:100

