


NOTE:-
I. ALL ROAD CROSSING ARE RCC HUMPE PIPE(NP3) UMO.

S.NO.	SYMBOL	LEGEND FOR SWD.	DESCRIPTION
1.		450X500mm	CATCH BASIN
2.		800X900mm	MANHOLE
3.		300Ø RCC PIPE (Slope 1:12/5)	
4.		250Ø/300Ø OVER FLOW PIPE	
5.		300mm WIDE DRAIN WITH SFRC GRATING (Slope 1:125/200/750)	
6.		300mm WIDE DRAIN WITH MS GRATING (Slope 1:750)	
7.		TUBE WELL	
8.		3.0X3.0X3.0 mt. RAIN WATER HARVESTING PIT WITH DE - SILLING CHAMBER	
9.		1200X1200X1200mm DRAINAGE SUMP	

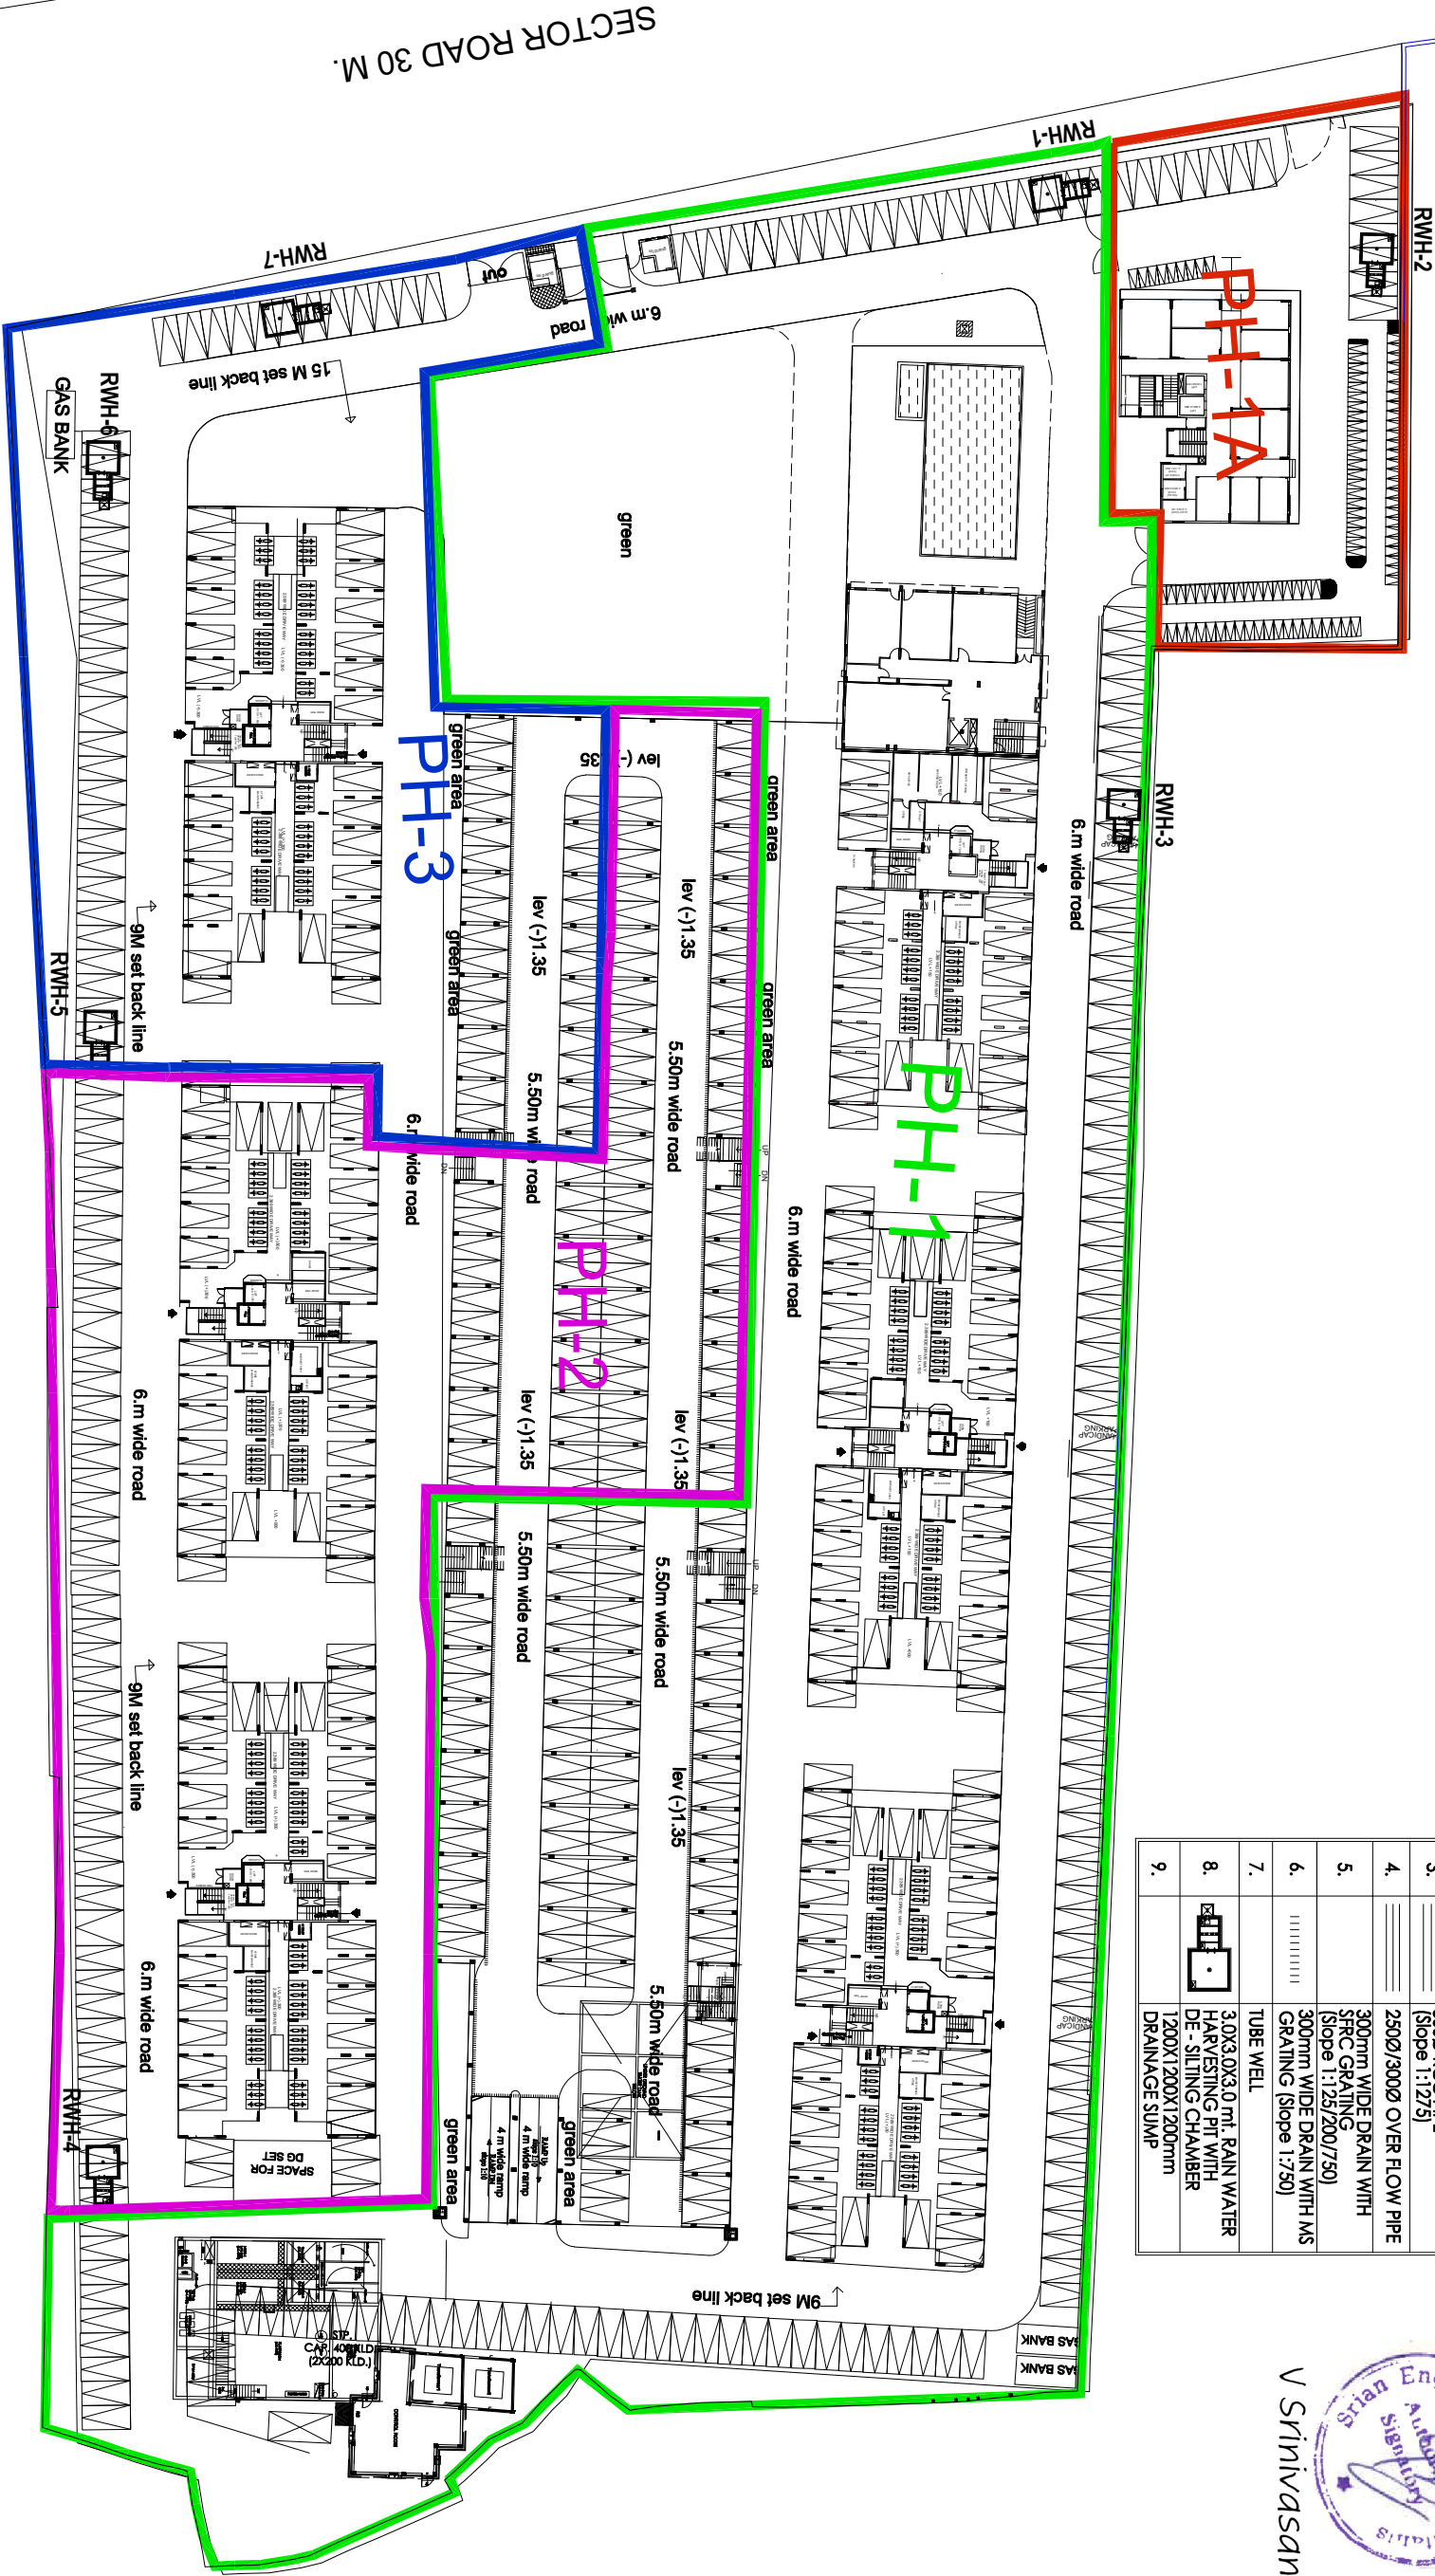

PLUMBING DWG.



PROJECT :

ASHIANA DAKSH

OWNERS NAME

Ashiana Housing Ltd.

304, Southern park, saket District Centre,
Saket New Delhi - 110017
Phone no. 011- 42 65 42 65

Services consultants:-

SRIAN ENGINEERING CONSULTANTS
(Building Engineering Services)
C2/357, 1st Floor, JANAKPURI, NEW DELHI - 110058
Tel: 011-40532854
Email: srianpie@gmail.com

DRG. TITLE:

Site plan
SVD. system
Plumbing dwg.

SCALE:

DATE:

Drawn By

Checked By

Approved By

Rev.No.

Rev.Date

Remarks


GFC Drawing

NOTE:-
1. ALL ROAD CROSSING ARE RCC HUME PIPE(NP3) UMO.

PLUMBING DWG.

S.NO.	SYMBOL	LEGEND FOR SWD	DESCRIPTION
1.		450x500mm	CATCH BASIN
2.		800x900mm	MANHOLE
3.		300mm RCC PIPE	(slope 1:12/5)
4.		250/300mm OVER FLOW PIPE	
5.		300mm WIDE DRAIN WITH SPPC GRATING	(slope 1:125/200/750)
6.		300mm WIDE DRAIN WITH MS GRATING	(slope 1:750)
7.		TUBE WELL	
8.		3.0x3.0x3.0 m ³ RAIN WATER HARVESTING PIT WITH DE - SILTING CHAMBER	
9.		1200X1200X1200mm	DRAINAGE SUMP

V Srinivasan
Srian Engineering Consultants
Signature

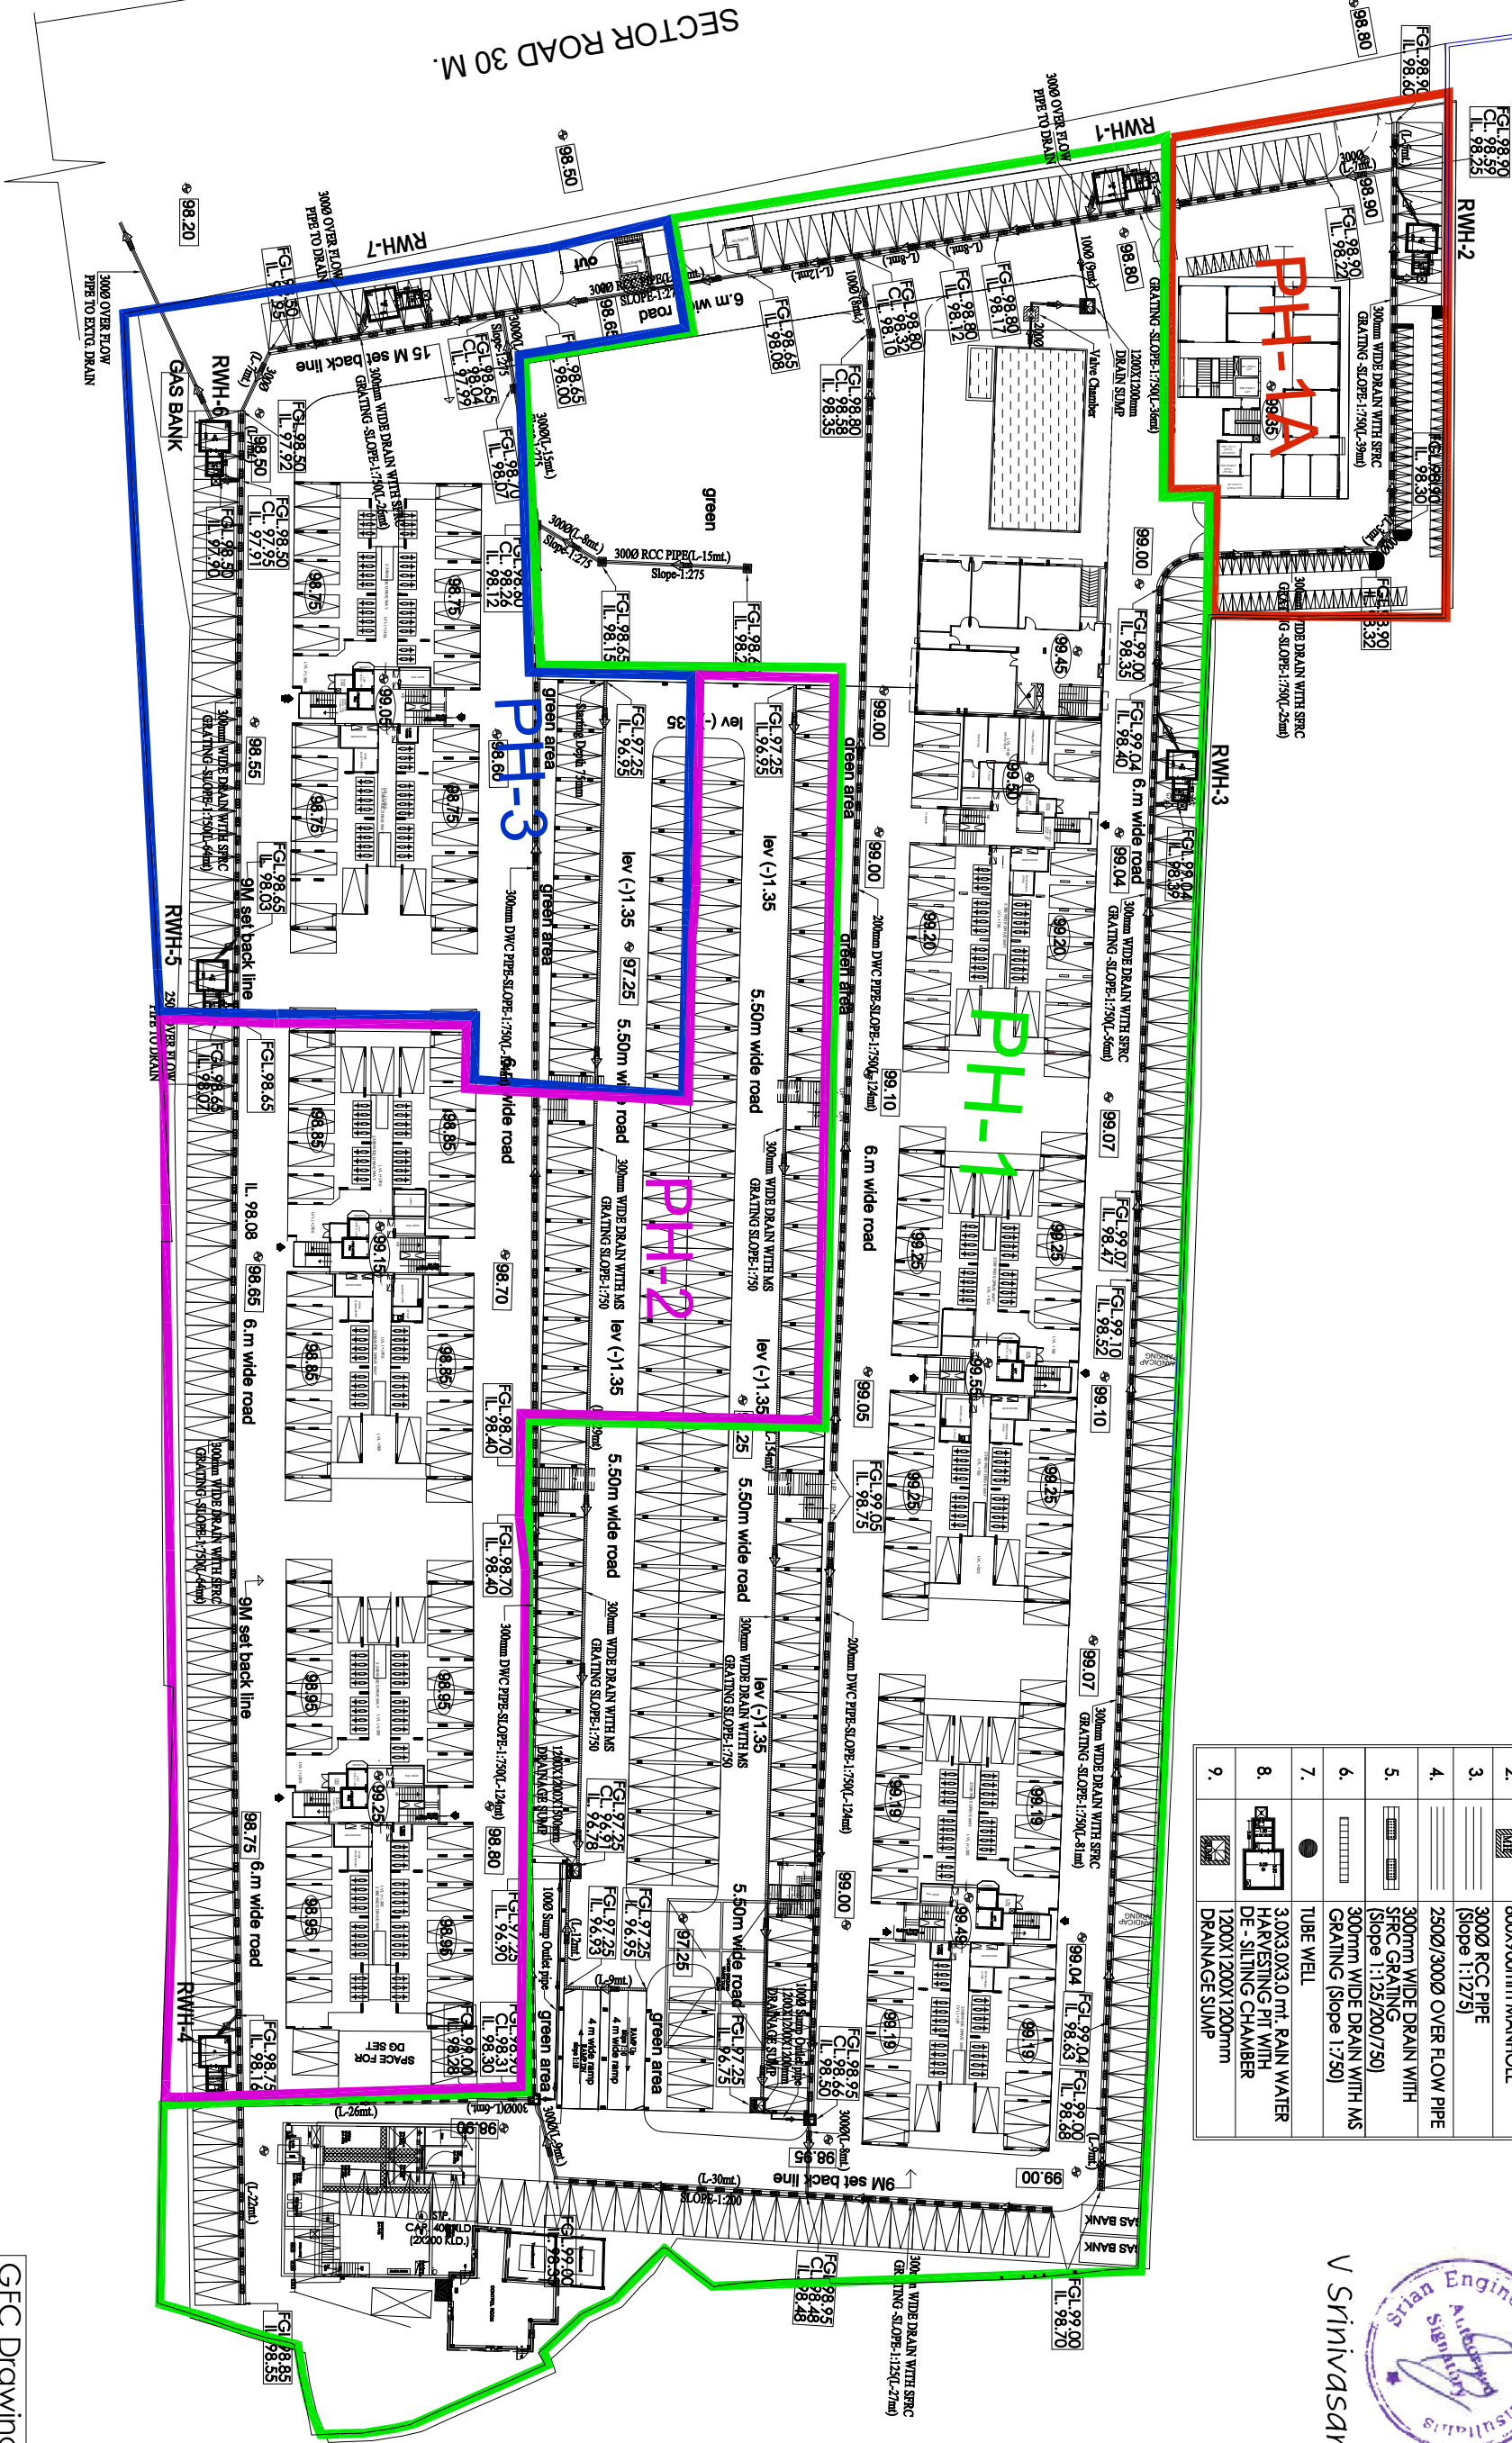

PROJECT :

ASHIANA DAKSH

OWNERS NAME
Ashiana Housing Ltd.

304, Southern park, saket District Centre,
Saket New Delhi - 110017
Phone no. 011- 42 65 42 65

Services consultants:-

SRIAN ENGINEERING CONSULTANTS
(Building Engineering Services)
C2/357, 1st Floor, JNAAPIRA, NEW DELHI - 110088
Tel: 011-40532854
Email: srianpe@gmail.com

DRG. TITLE:

Site plan
SVD. system
Plumbing dwg.

SCALE: DATE:

Drawn By

Checked By

Approved By


Rev.No.

Rev.Date

Remarks

GFC Drawing

LEGEND FOR WATER SUPPLY	
S.NO	SYMBOL DESCRIPTION
1.	— 110mm OD DOM. WATER SUPPLY RING MAIN (uPVC /CPVC)
2.	— 90mm OD FLUSHING WATER SUPPLY RING MAIN (uPVC/CPVC)
3.	— 90mm OD IRRIGATION WATER SUPPLY RING MAIN (uPVC)
4.	 VALVE CHAMBER (900X900X1200)
5.	 VALVE CHAMBER (300X300X600)
6.	— RISER PIPE TO DOM. OHT (Rt)
7.	— RISER PIPE TO FLU. OHT (R)
8.	— 50mm OD uPVC WATER SUPPLY PIPE FROM AUTH.
9.	 GARDEN HYDRANT (GH.)
10.	
11.	

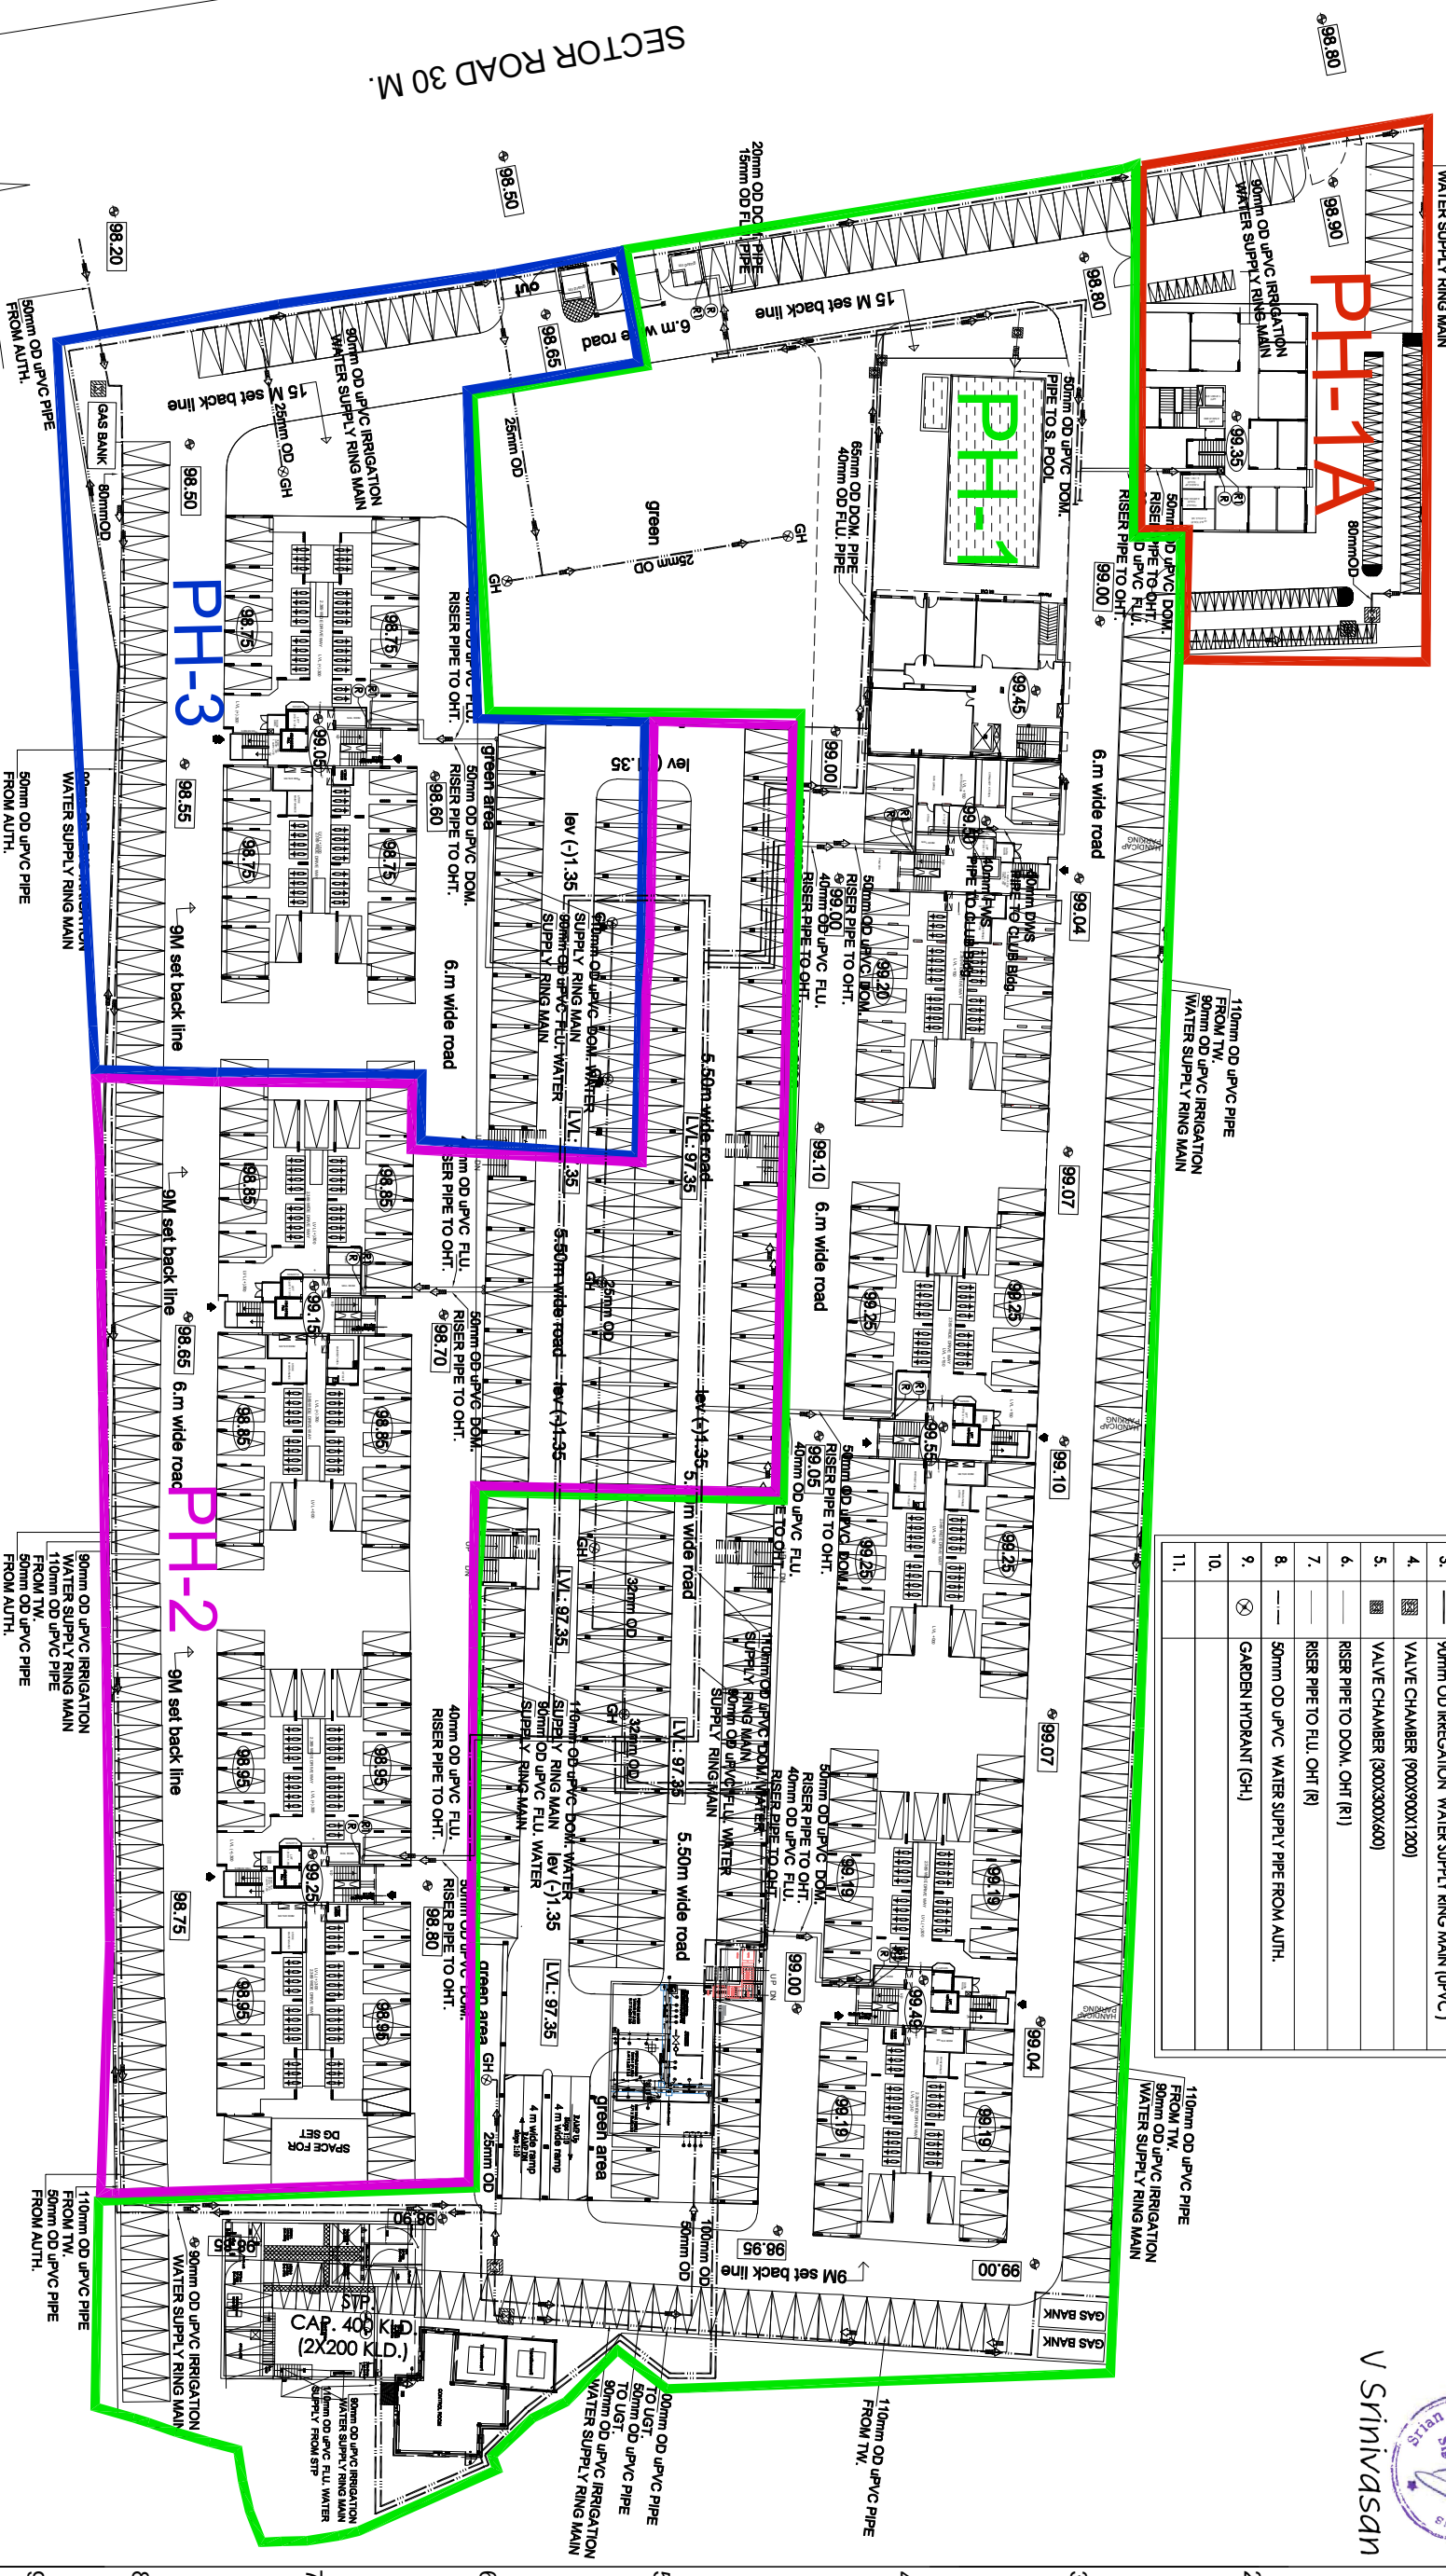 1 | ldg. Shown | |

--	--	--

NO. OF UNITS = 552


open parking=241car
stilt parking=176car
podium parking=193 car

total car parking = 610 cars

scooter parking = 309

LEGEND :-

	INTERNAL HYDRANT WITH HOSE REEL
	YARD HYDRANT
	SLUICE VALVE
	BUTTER FLY VALVE
	NON RETURN VALVE
	FIRE BRIGADE INLET CONNECTION
	FIRE BRIGADE OUT-LET CONNECTION
	FOAM TYPE FIRE EXTINGUISHER
	ABC FIRE EXTINGUISHER
	ABC FIRE EXTINGUISHER
	HUME PIPE
	MANUAL CALL POINT & HOOTER
	SMOKE DETECTOR
	HEAT DETECTOR
	FIRE EXIT SIGN

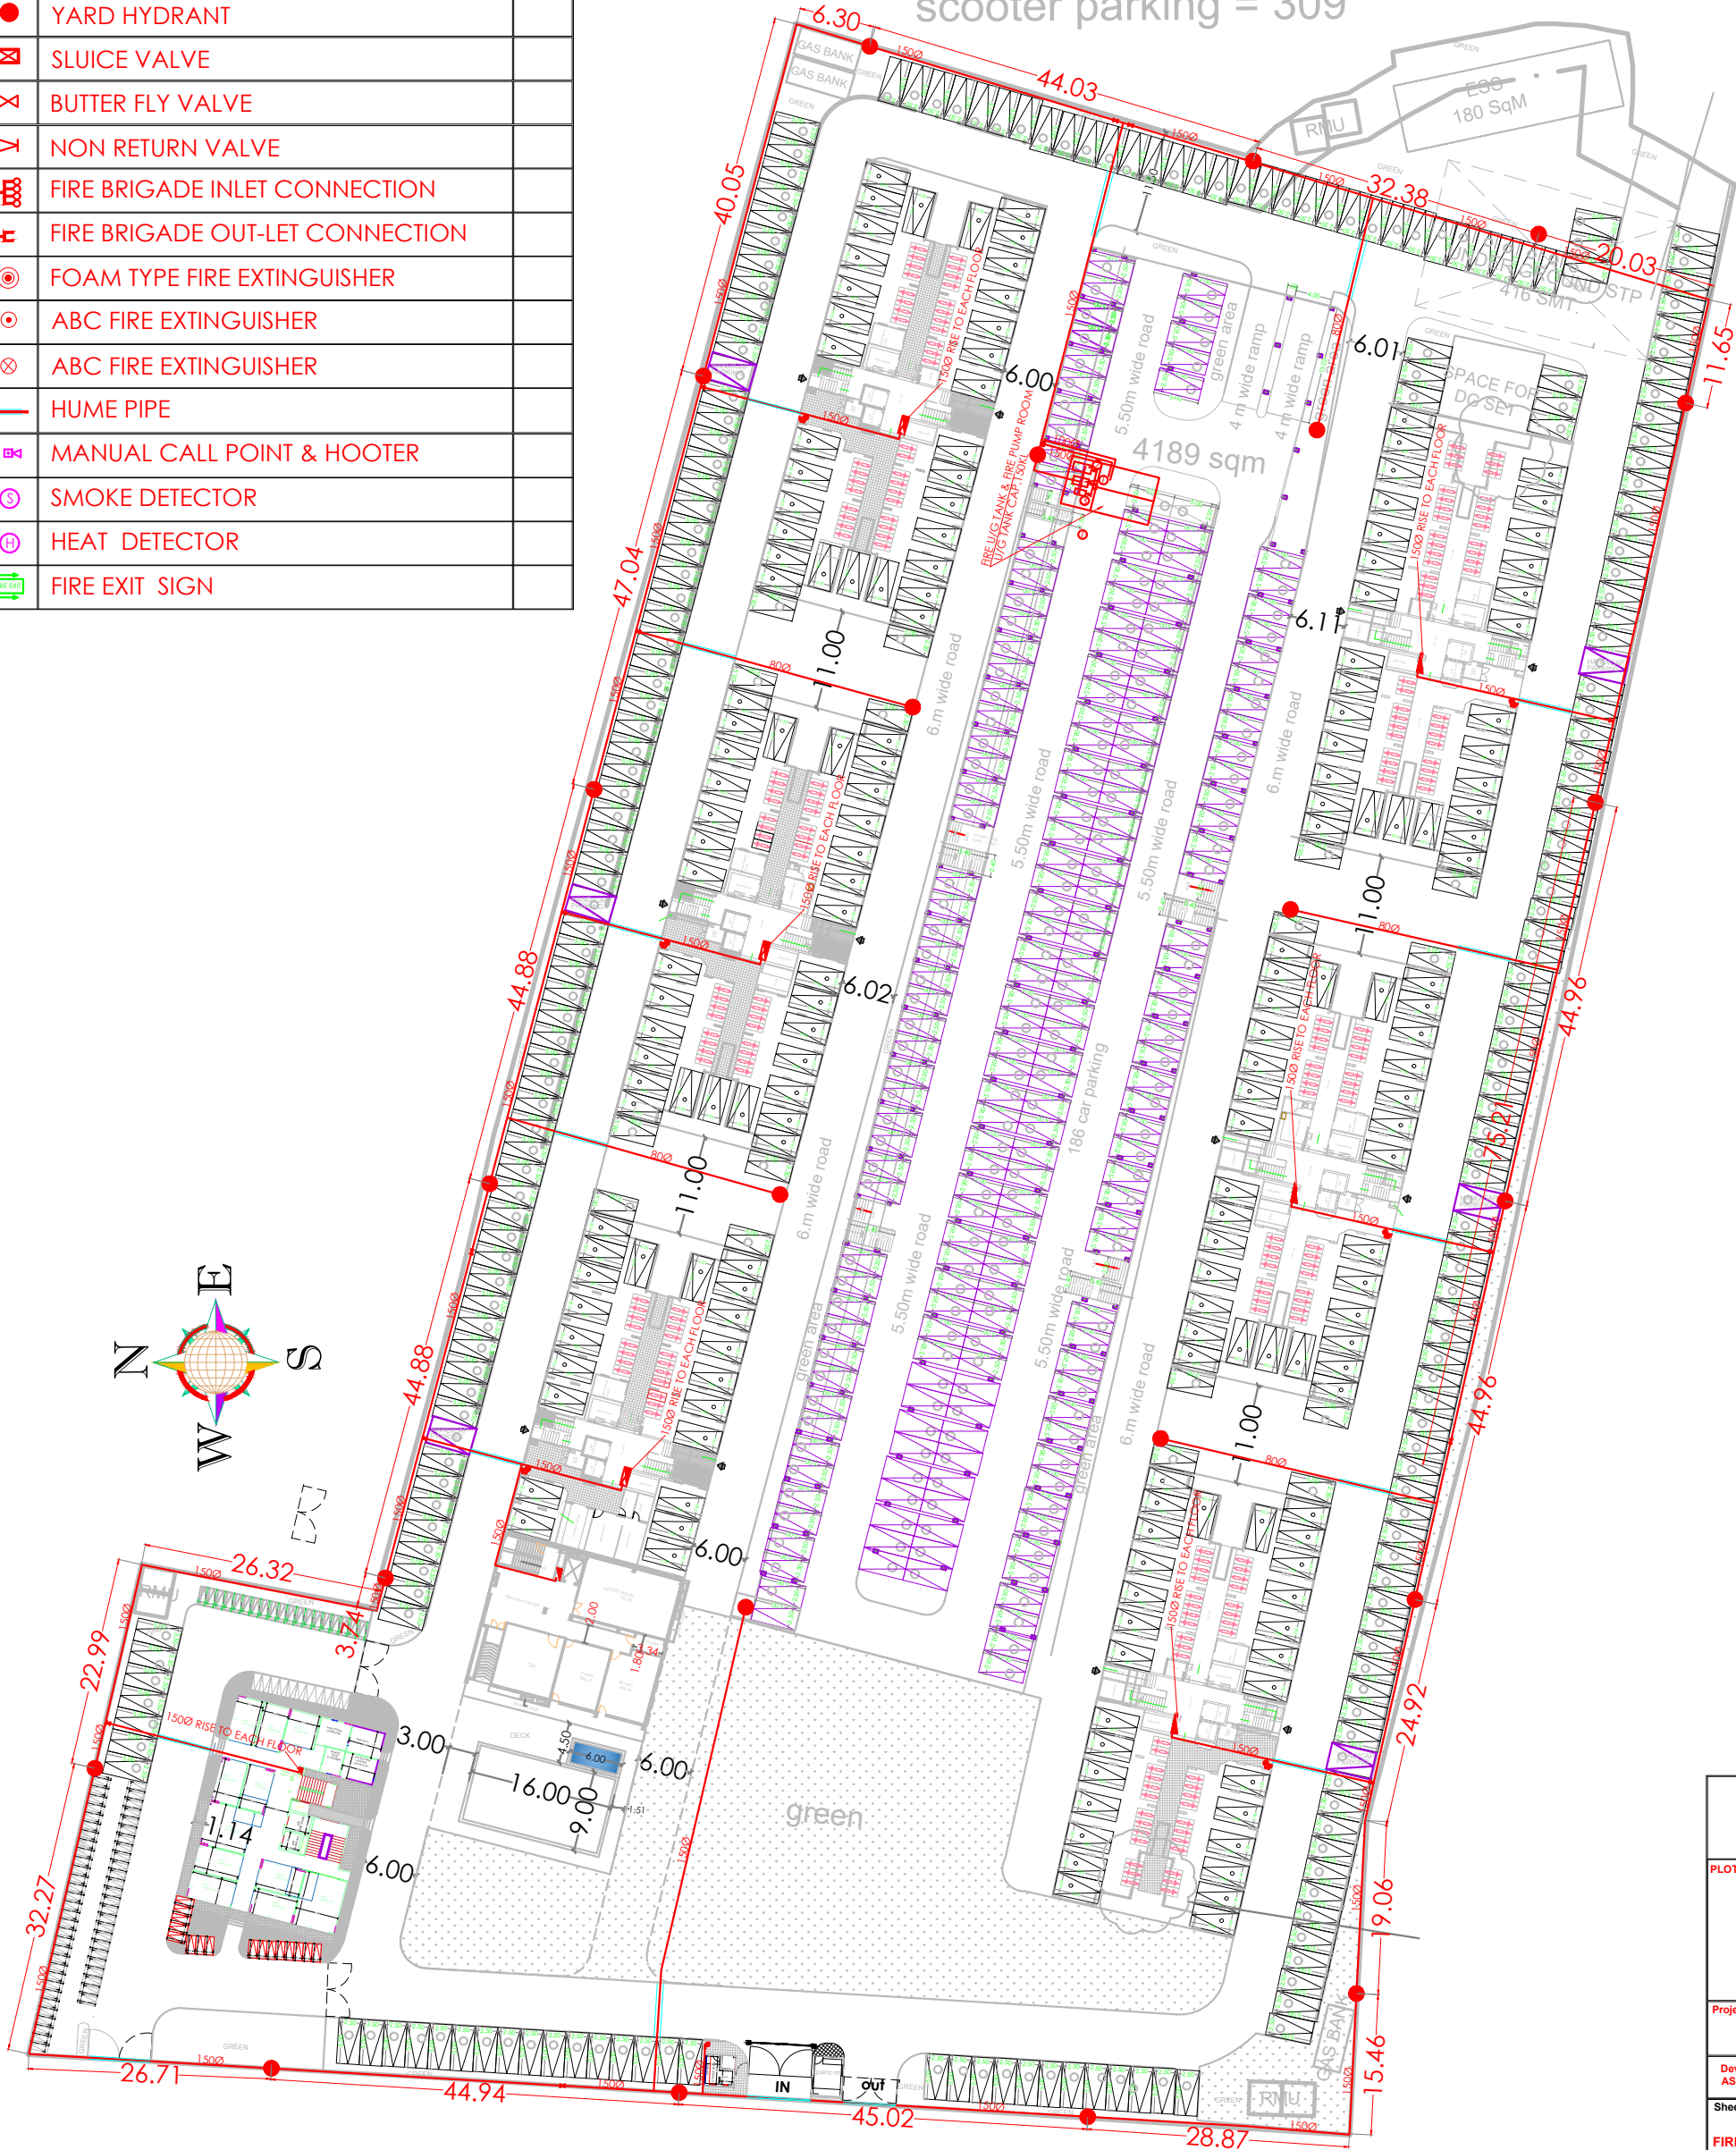

FIRE PUMPS:-

- 1 - 2280 LPM 90M HEAD AUTOMATIC ELECT. FIRE PUMP
- 2 - 2280 LPM 90M HEAD AUTOMATIC DIESEL. FIRE PUMP
- 3 - 180 LPM 90M HEAD AUTOMATIC ELECT. JOCKEY PUMP



Gulshan Khurana

PLOT DETAILS:-
Proposed Group Housing at Jaipur
Ashiana Housing Ltd
Khasra No.419,420,421,422,423,424,425,
426,427, 428,429,430, 431,432,433,434,
435,436 &437,
in Revenue Village Shri kishanpura
Teh. Sanganer, Jaipur

Project:
Ashiana Daksh at Jaipur

Developer:
ASHIANA HOUSING LTD

Sheet title:-
FIRE FIGHTING LAYOUT SITE PLAN

SCALE:- 1:175
NORTH
variable/site plan
SIGNATURE OF AUTHORITY
SIGNATURE OF ARCHITECT