




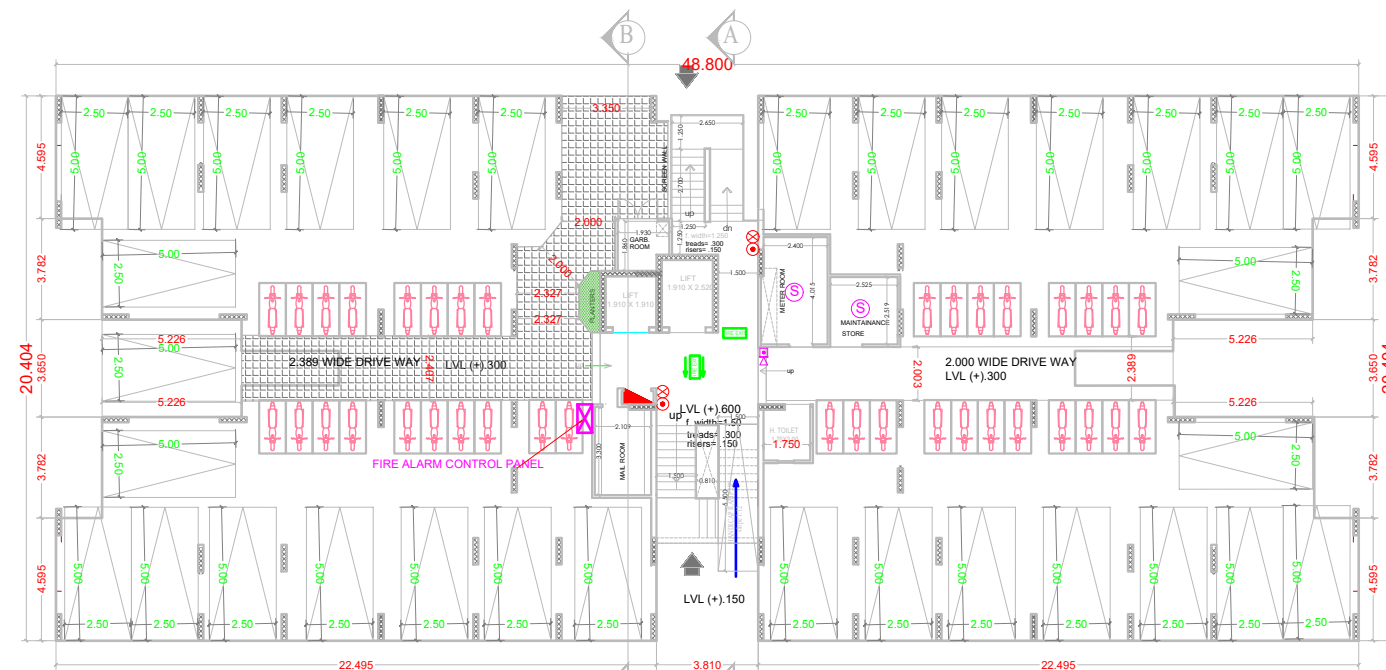


STILT FLOOR PLAN (BLOCKS 1, 3 & 4)

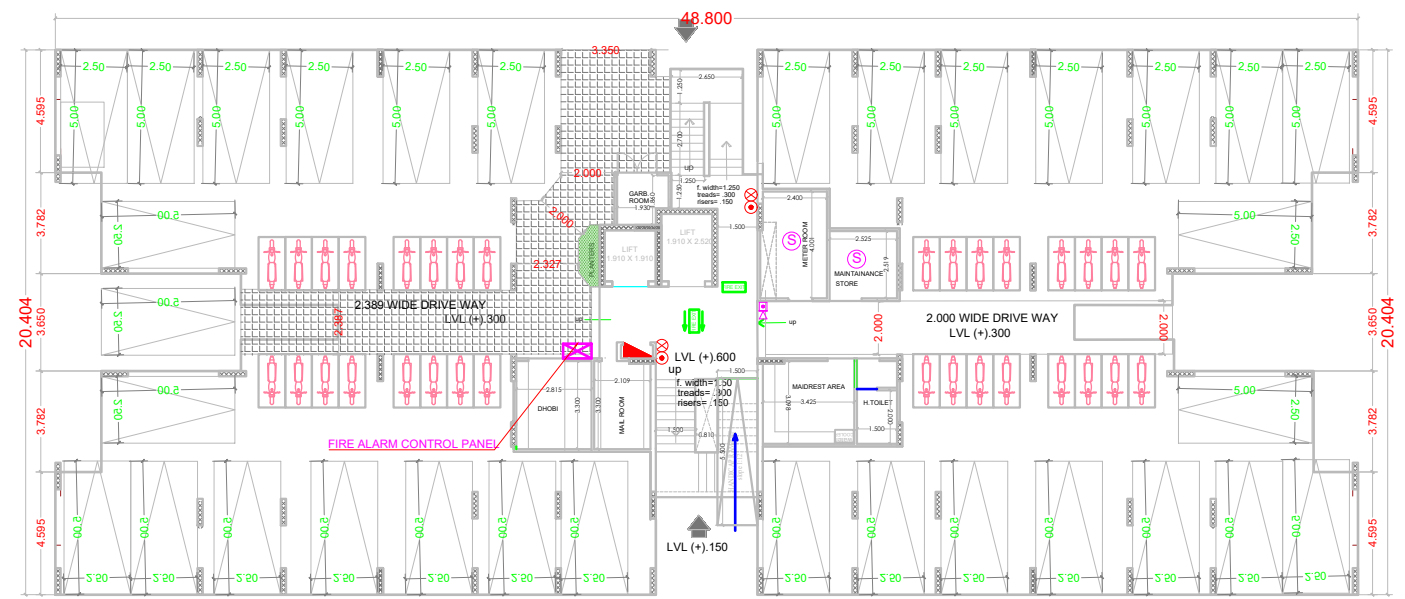

STILT FLOOR PLAN (BLOCKS 2 & 5)

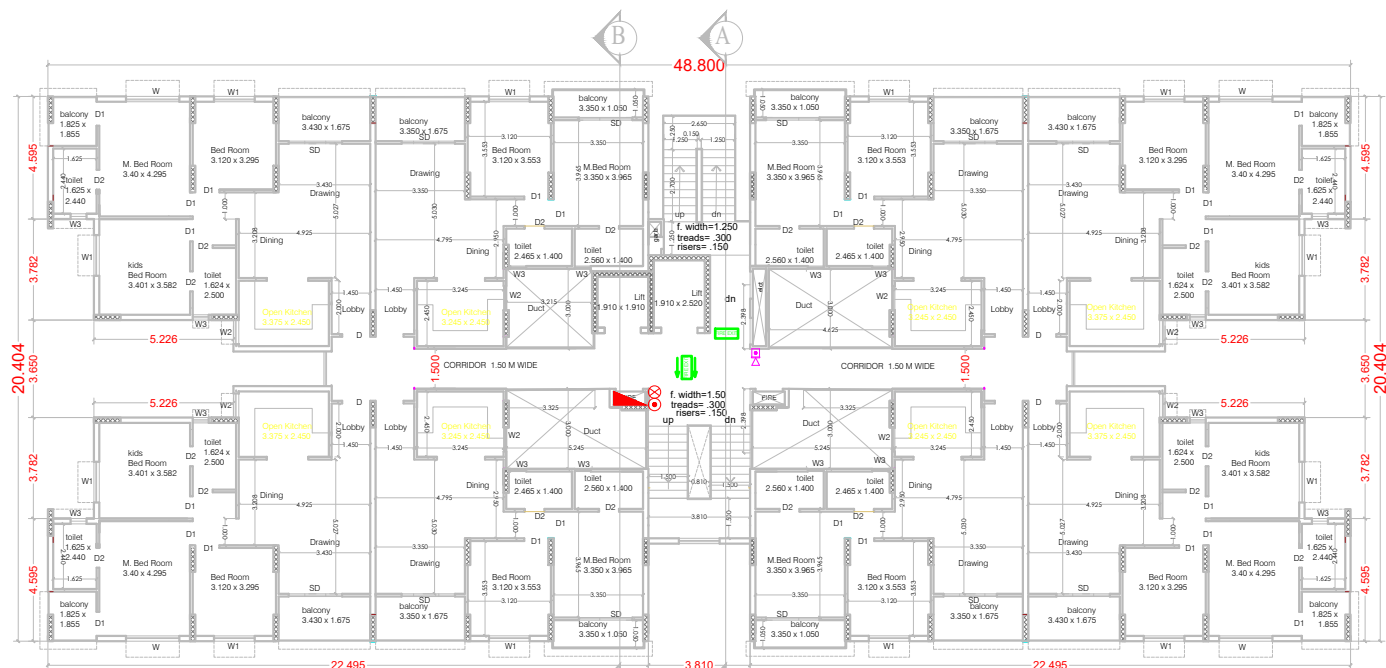

TYPICAL FLOOR PLAN (BLOCKS 1, 2, 3, 4 & 5)

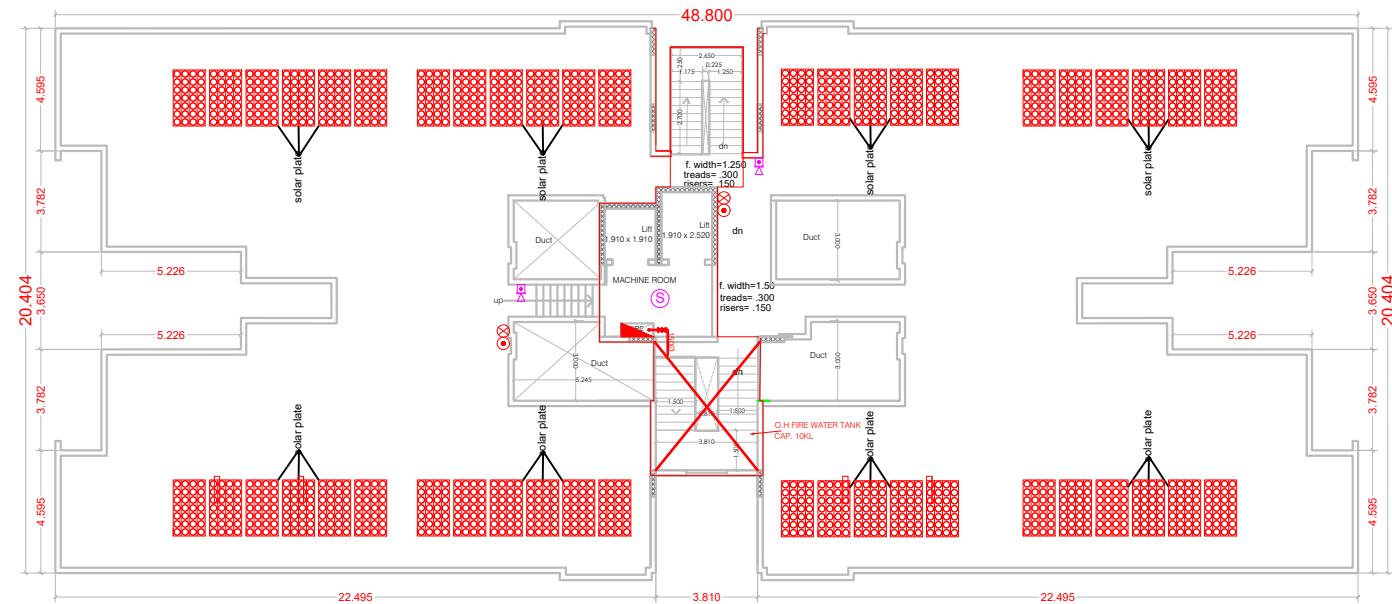

TERRACE FLOOR PLAN (BLOCKS 1, 2, 3, 4 & 5)

LEGEND :-

- INTERNAL HYDRANT WITH HOSE REEL
- CO2 TYPE FIRE EXTINGUISHER
- ABC TYPE FIRE EXTINGUISHER
- SMOKE DETECTOR
- SMOKE DETECTOR
- MANUAL CALL POINT & HOOTER
- BUTTER FLY VALVE
- NON RETURN VALVE



Gulshan Khurana

PLOT DETAILS:-

Proposed Group Housing
 Kharsa No.419,420,421,422,423,424,425,
 426,427, 428,429,430, 431,432,433,434,
 435,436 & 437,
 in Revenue Village Shri kishanpura
 Teh. Sanganer, Jaipur

Project:

Ashiana Daksh

Developer:

ASHIANA HOUSING LTD

Sheet title:-

FIRE ALARM & FIRE
FIGHTING SYSTEM LAYOUTBlock-B1,B2,
B3,B4& B5
RESIDENTIAL

SCALE- 1:100

NORTH
variable/site plan

SIGNATURE OF AUTHORITY

SIGNATURE OF ARCHITECT