



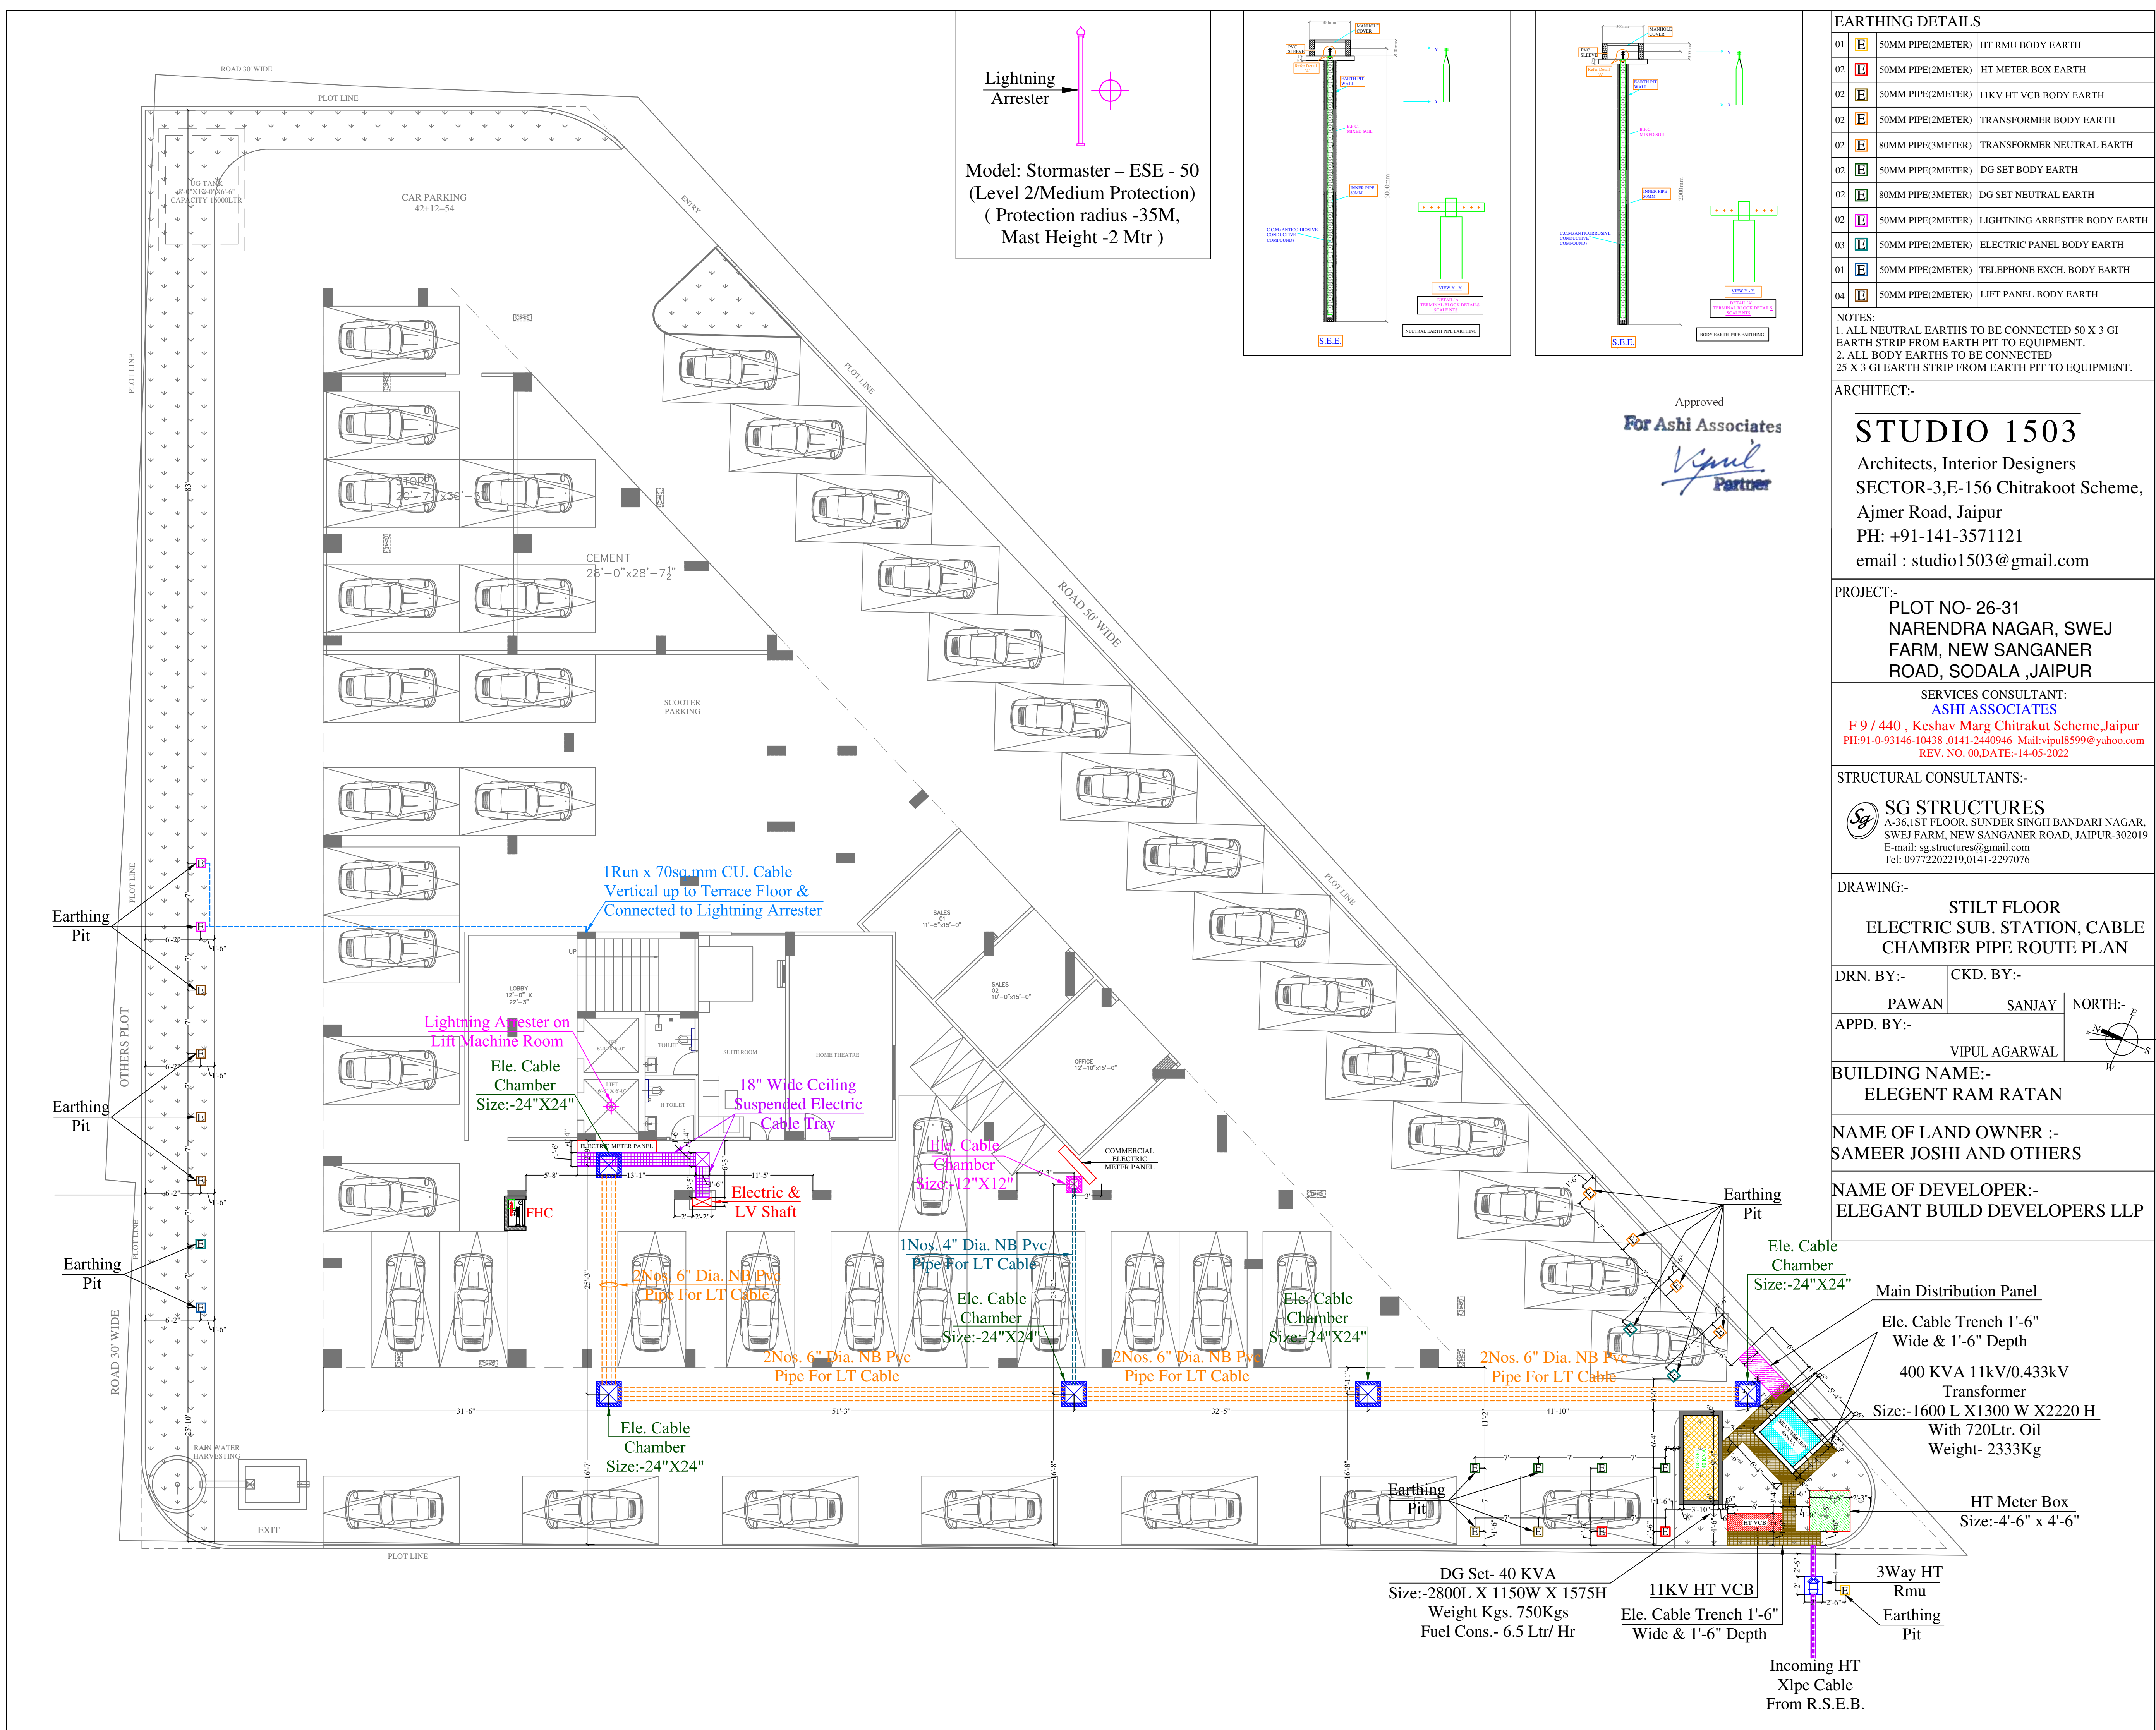

Lightning Arrester

Model: Stormaster – ESE - 50
(Level 2/Medium Protection)
(Protection radius -35M,
Mast Height -2 Mtr)

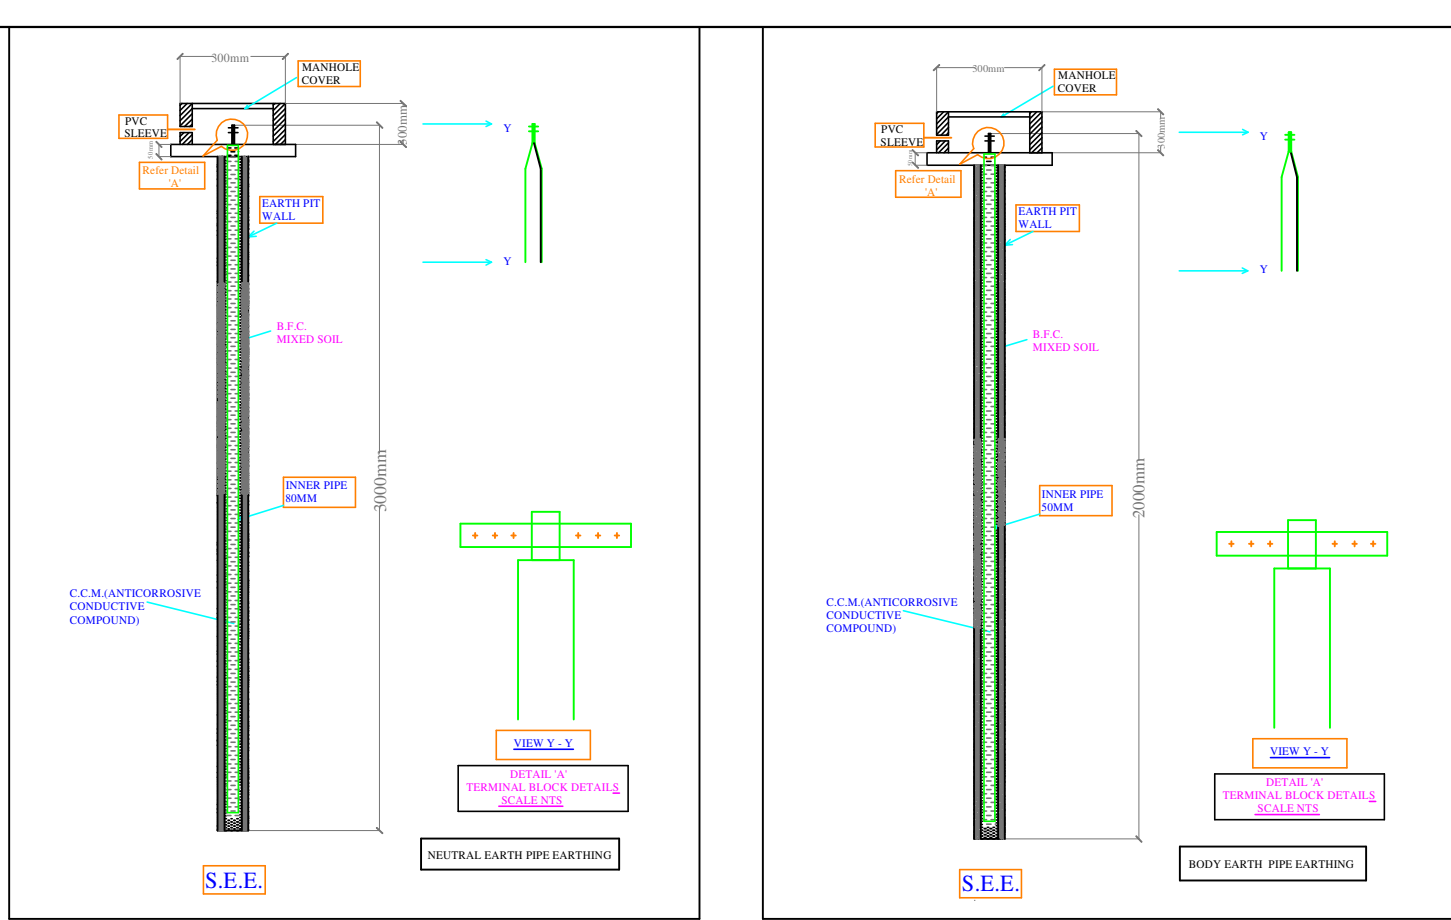

Approved
For Ashi Associates
Vipul
Partner

EARTHING DETAILS		
01	50MM PIPE(2METER)	HT RMU BODY EARTH
02	50MM PIPE(2METER)	HT METER BOX EARTH
02	50MM PIPE(2METER)	11KV HT VCB BODY EARTH
02	50MM PIPE(2METER)	TRANSFORMER BODY EARTH
02	80MM PIPE(3METER)	TRANSFORMER NEUTRAL EARTH
02	50MM PIPE(2METER)	DG SET BODY EARTH
02	80MM PIPE(3METER)	DG SET NEUTRAL EARTH
02	50MM PIPE(2METER)	LIGHTNING ARRESTER BODY EARTH
03	50MM PIPE(2METER)	ELECTRIC PANEL BODY EARTH
01	50MM PIPE(2METER)	TELEPHONE EXCH. BODY EARTH
04	50MM PIPE(2METER)	LIFT PANEL BODY EARTH

NOTES:
1. ALL NEUTRAL EARTHS TO BE CONNECTED 50 X 3 GI EARTH STRIP FROM EARTH PIT TO EQUIPMENT.
2. ALL BODY EARTHS TO BE CONNECTED 25 X 3 GI EARTH STRIP FROM EARTH PIT TO EQUIPMENT.

ARCHITECT:-
STUDIO 1503
Architects, Interior Designers
SECTOR-3,E-156 Chitrakoot Scheme,
Ajmer Road, Jaipur
PH: +91-141-3571121
email : studio1503@gmail.com

PROJECT:-
PLOT NO- 26-31
NARENDRA NAGAR, SWEJ
FARM, NEW SANGANER
ROAD, SODALA ,JAIPUR

SERVICES CONSULTANT:
ASHI ASSOCIATES
F 9 / 440 , Keshav Marg Chitrakut Scheme,Jaipur
PH:91-0-93146-10438 ,0141-2440946 Mail:vipul8599@yahoo.com
REV. NO. 00,DATE:-14-05-2022

STRUCTURAL CONSULTANTS:-
SG STRUCTURES
A-36,1ST FLOOR, SUNDER SINGH BANDARI NAGAR,
SWEJ FARM, NEW SANGANER ROAD, JAIPUR-302019
E-mail: sg.structures@gmail.com
Tel: 09772202219,0141-2297076

DRAWING:-
**STILT FLOOR
ELECTRIC SUB. STATION, CABLE
CHAMBER PIPE ROUTE PLAN**

DRN. BY:-
PAWAN
APPD. BY:-
SANJAY
NORTH:-
VIPUL AGARWAL

BUILDING NAME:-
ELEGENT RAM RATAN

NAME OF LAND OWNER :-
SAMEER JOSHI AND OTHERS

NAME OF DEVELOPER:-
ELEGANT BUILD DEVELOPERS LLP

Ele. Cable Chamber Size:-24"X24"

Main Distribution Panel

Ele. Cable Trench 1'-6" Wide & 1'-6" Depth

400 KVA 11kV/0.433kV Transformer
Size:-1600 L X1300 W X2220 H
With 720Ltr. Oil
Weight- 2333Kg

HT Meter Box
Size:-4'-6" x 4'-6"

3Way HT Rmu Earthing Pit

Incoming HT Xlpe Cable From R.S.E.B.

11KV HT VCB
Ele. Cable Trench 1'-6" Wide & 1'-6" Depth

DG Set- 40 KVA
Size:-2800L X 1150W X 1575H
Weight Kgs. 750Kgs
Fuel Cons.- 6.5 Ltr/ Hr

Earthing Pit

2Nos. 6" Dia. NB Pvc Pipe For LT Cable

Ele. Cable Chamber Size:-24"X24"

1Nos. 4" Dia. NB Pvc Pipe For LT Cable

Ele. Cable Chamber Size:-24"X24"

18" Wide Ceiling Suspended Electric Cable Tray

Lightning Arrester on Lift Machine Room

Ele. Cable Chamber Size:-24"X24"

1Run x 70sq.mm CU. Cable Vertical up to Terrace Floor & Connected to Lightning Arrester

Electric & LV Shaft

Commercial Electric Meter Panel

Office 12'-0"X15'-0"

Sales 02 10'-0"X15'-0"

Sales 01 11'-5"X15'-0"

Home Theatre

Suite Room

Toilet

H Toilet

Lift 6'-0"X6'-0"

Lobby 12'-0" X 22'-3"

UP

CEMENT 28'-0"X28'-7 1/2"

SCOOTER PARKING

CAR PARKING 42+12=54

ROAD 30' WIDE

ROAD 50' WIDE

PLOT LINE

OTHERS PLOT



Earthing Pit

Earthing Pit

Earthing Pit

RAIN WATER HARVESTING

EXIT

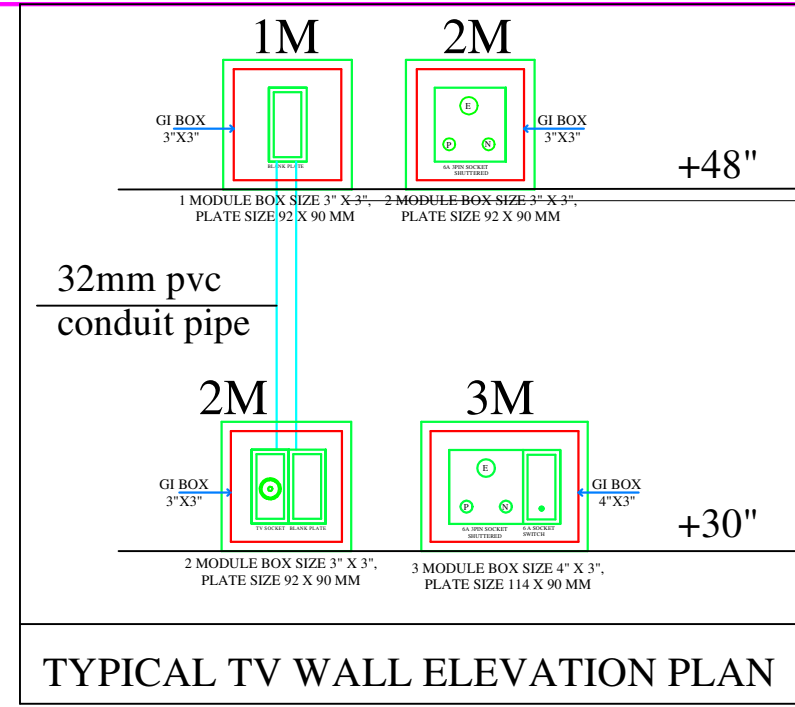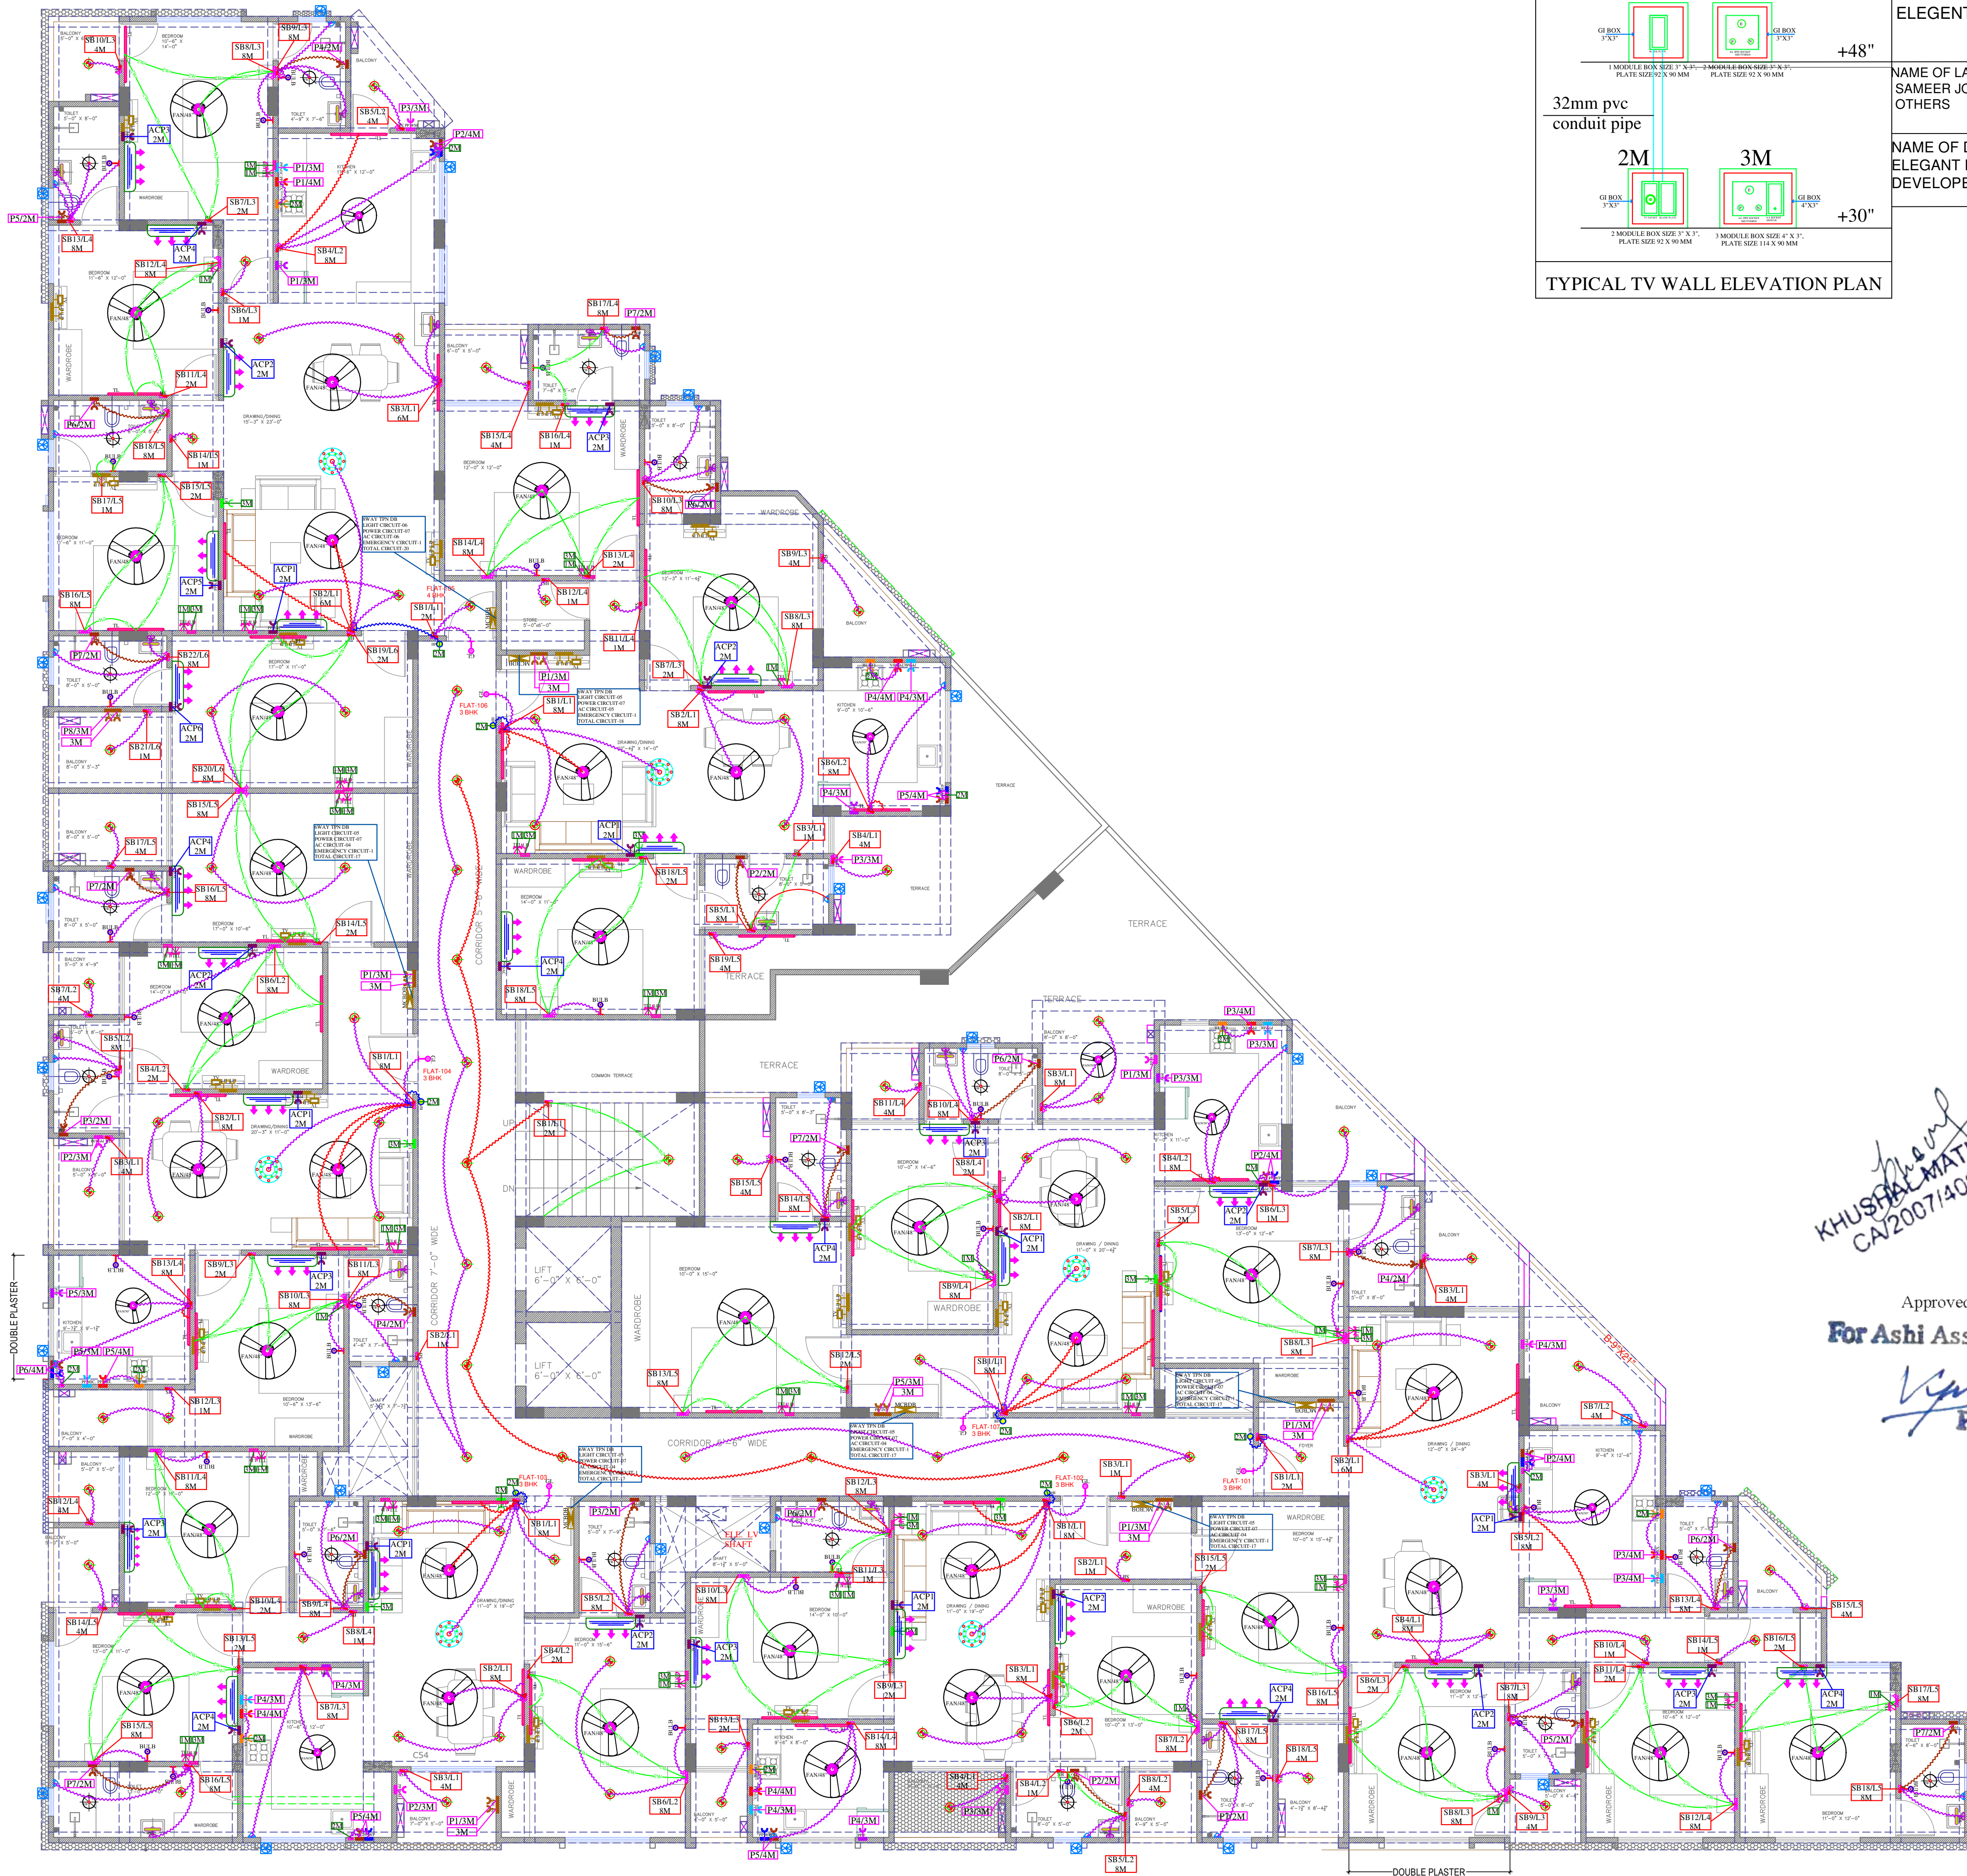

BUILDING NAME:-
ELEGANT RAM RATAN

NAME OF LAND OWNER :-
SAMEER JOSHI AND
OTHERS

NAME OF DEVELOPER:-
ELEGANT BUILD
DEVELOPERS LLP

LEGENDS:				
Mounting Height	No.	I D	Symbol	Description
IN CONDUIT				Control Wiring For Geyser
IN CONDUIT				4 sqmm Red (Phase), Black (Neutral), 2.5 sqmm Green (Earth)
IN CONDUIT				Control Wiring For 2 Way Light Point
IN CONDUIT				2.5 sqmm Red (Phase), Black (Neutral), 2.5 sqmm Green (Earth)
IN CONDUIT				Control Wiring For Light Point
IN CONDUIT				2.5 sqmm Red (Phase), Black (Neutral), 2.5 sqmm Green (Earth)
IN CONDUIT				Control Wiring For Bell Push
IN CONDUIT				2.5 sqmm Red (Phase), Black (Neutral), 2.5 sqmm Green (Earth)
IN CONDUIT				Control Wiring For Emergency Point
IN CONDUIT				2.5 sqmm Red (Phase), Black (Neutral), 2.5 sqmm Green (Earth)
IN CONDUIT				AC Circuit
IN CONDUIT				4.0 sqmm Red (Phase), Black (Neutral), 2.5 sqmm Green (Earth)
CEILING	37	FAN/48"		CEILING FAN 48"
CEILING	08	FAN/30"		CEILING FAN 30"
CEILING	22	FB		FAN BOX
CEILING	04	CH1		CHANDLIER
+90"	44	TLW		Led Wall Tube Light Make: Syka Led Cat no: SSK-TL-20W
+90"	39	BULB		Led Bulb 20W Make: Syka Led Cat no: SSK-20W 5.7K/1K
+90"	07	GL		WALL BRACKETS AS DESIGN FOR CANSER LIGHT
+78"	24	ML		12x2 Led Mirror Light Make: Syka Led Cat no: FTL-12x2
CEILING	93	DL		Led 6" Down Lighter 20W (Surface Mounted) Make: Syka Led Cat no: SSK-15W GLD 6.5K/4K
VENTILATOR	29	CR		CEILING ROSE
VENTILATOR	29	EXF		9" DIA FRESH AIR FAN
+24"	22	2 WAY SB		2WAY SWITCH BOARD
+42"	136	SB		SWITCH BOARD
+24"	29	TEL		TELEPHONE POINT
+24"	29	LP TEL		6 A PLUG POINT FOR TELEPHONE
+48"	27	TV		TV COAXIAL POINT
+24"	08	LP		6 A PLUG POINT FOR SIDE TABLE
+72"	07	LP-CH		6 A PLUG POINT FOR CHIMNEY
+90"	30	SAC		SPLIT AC INDOOR UNIT
+90"	30	PP-SAC		25 A POWER POINT FOR SPLIT AC
+42"	07	PP-MIX		16 A POWER POINT FOR MIXER
+42"	07	PP-MIC		16 A POWER POINT FOR MICROWAVE
+78"	29	PP-G		16 A POWER POINT FOR GEYSER
+54"	07	PP-F		16 A POWER POINT FOR FRIDGE
+78"	07	PP-WP		16 A POWER POINT FOR WATER PURIFIER
+48"	07	PP-WM		16 A POWER POINT FOR WASHING MACHINE
+12"	07	PP-INV		16 A POWER POINT FOR INVERTER
+60"	07	BP		6 A BELL PUSH
+90"	07	BZ		BUZZER FOR CALL BELL
+60"	07	MCB DB		MCB DISTRIBUTION BOARD
				6A SC
				6A SOCKET ON SWITCH BOARD
				SWITCH BOARD NO./ LIGHT CIRCUIT NO./ MODULAR NO.
				POWER CIRCUIT NO./ MODULAR NO.
				AC CIRCUIT NO.
				MODULAR NO.
				EMERGENCY LIGHT POINT

Khushal Mathur
CA2007/40651

Approved
For Ashi Associates
Vipul Partner

STUDIO 1503

Architects, Interior Designers
SECTOR-3, E-156 Chitrakoot Scheme,
Ajmer Road, Jaipur
PH: +91-141-4971223
email : studio1503@gmail.com

PLOT NO- 26-31
NARENDRA NAGAR, SWEJ FARM,
NEW SANGANER ROAD, SODALA ,
JAIPUR

SERVICES CONSULTANT:


ASHI ASSOCIATES
F 9 / 440 , Keshav Marg Chitrakut Scheme Jaipur
PH:91-093146-10438 , 0141-2440946 Mail:vipul8599@yahoo.com



STRUCTURAL CONSULTANTS:-

SG STRUCTURES
A-36, 1ST FLOOR, SUNDER SINGH BANDARI NAGAR,
SWEJ FARM, NEW SANGANER ROAD, JAIPUR-302019
E-mail: sg.structures@gmail.com
Tel: 09772202219, 0141-2297076

LAYOUT PLAN
DATE: 01.11.2021
DESIGNER: RAJENDRA
CHKD: SANJAY
APPR: AGARWAL
NORTH:-

TYPICAL FLOOR ELECTRIC
CONTROL WIRING PLAN

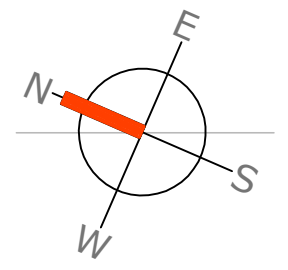

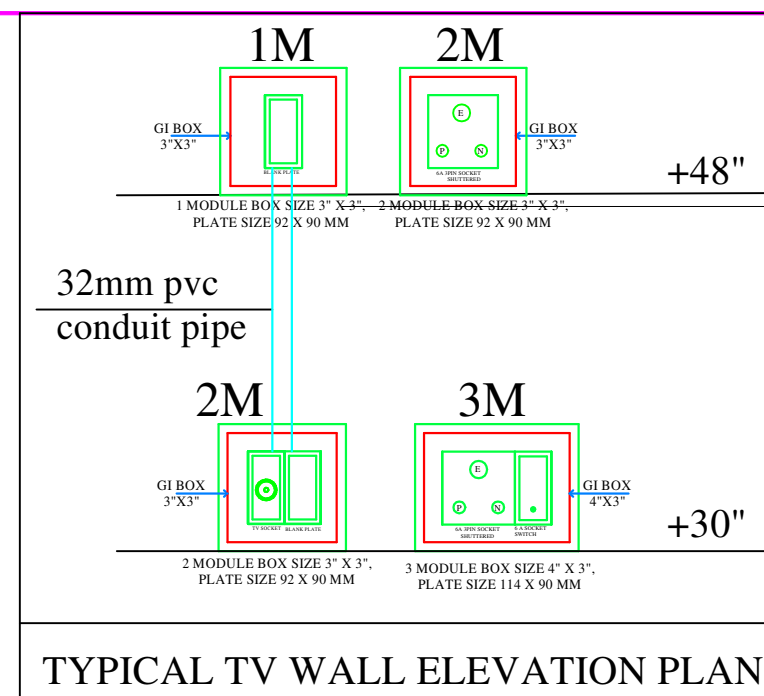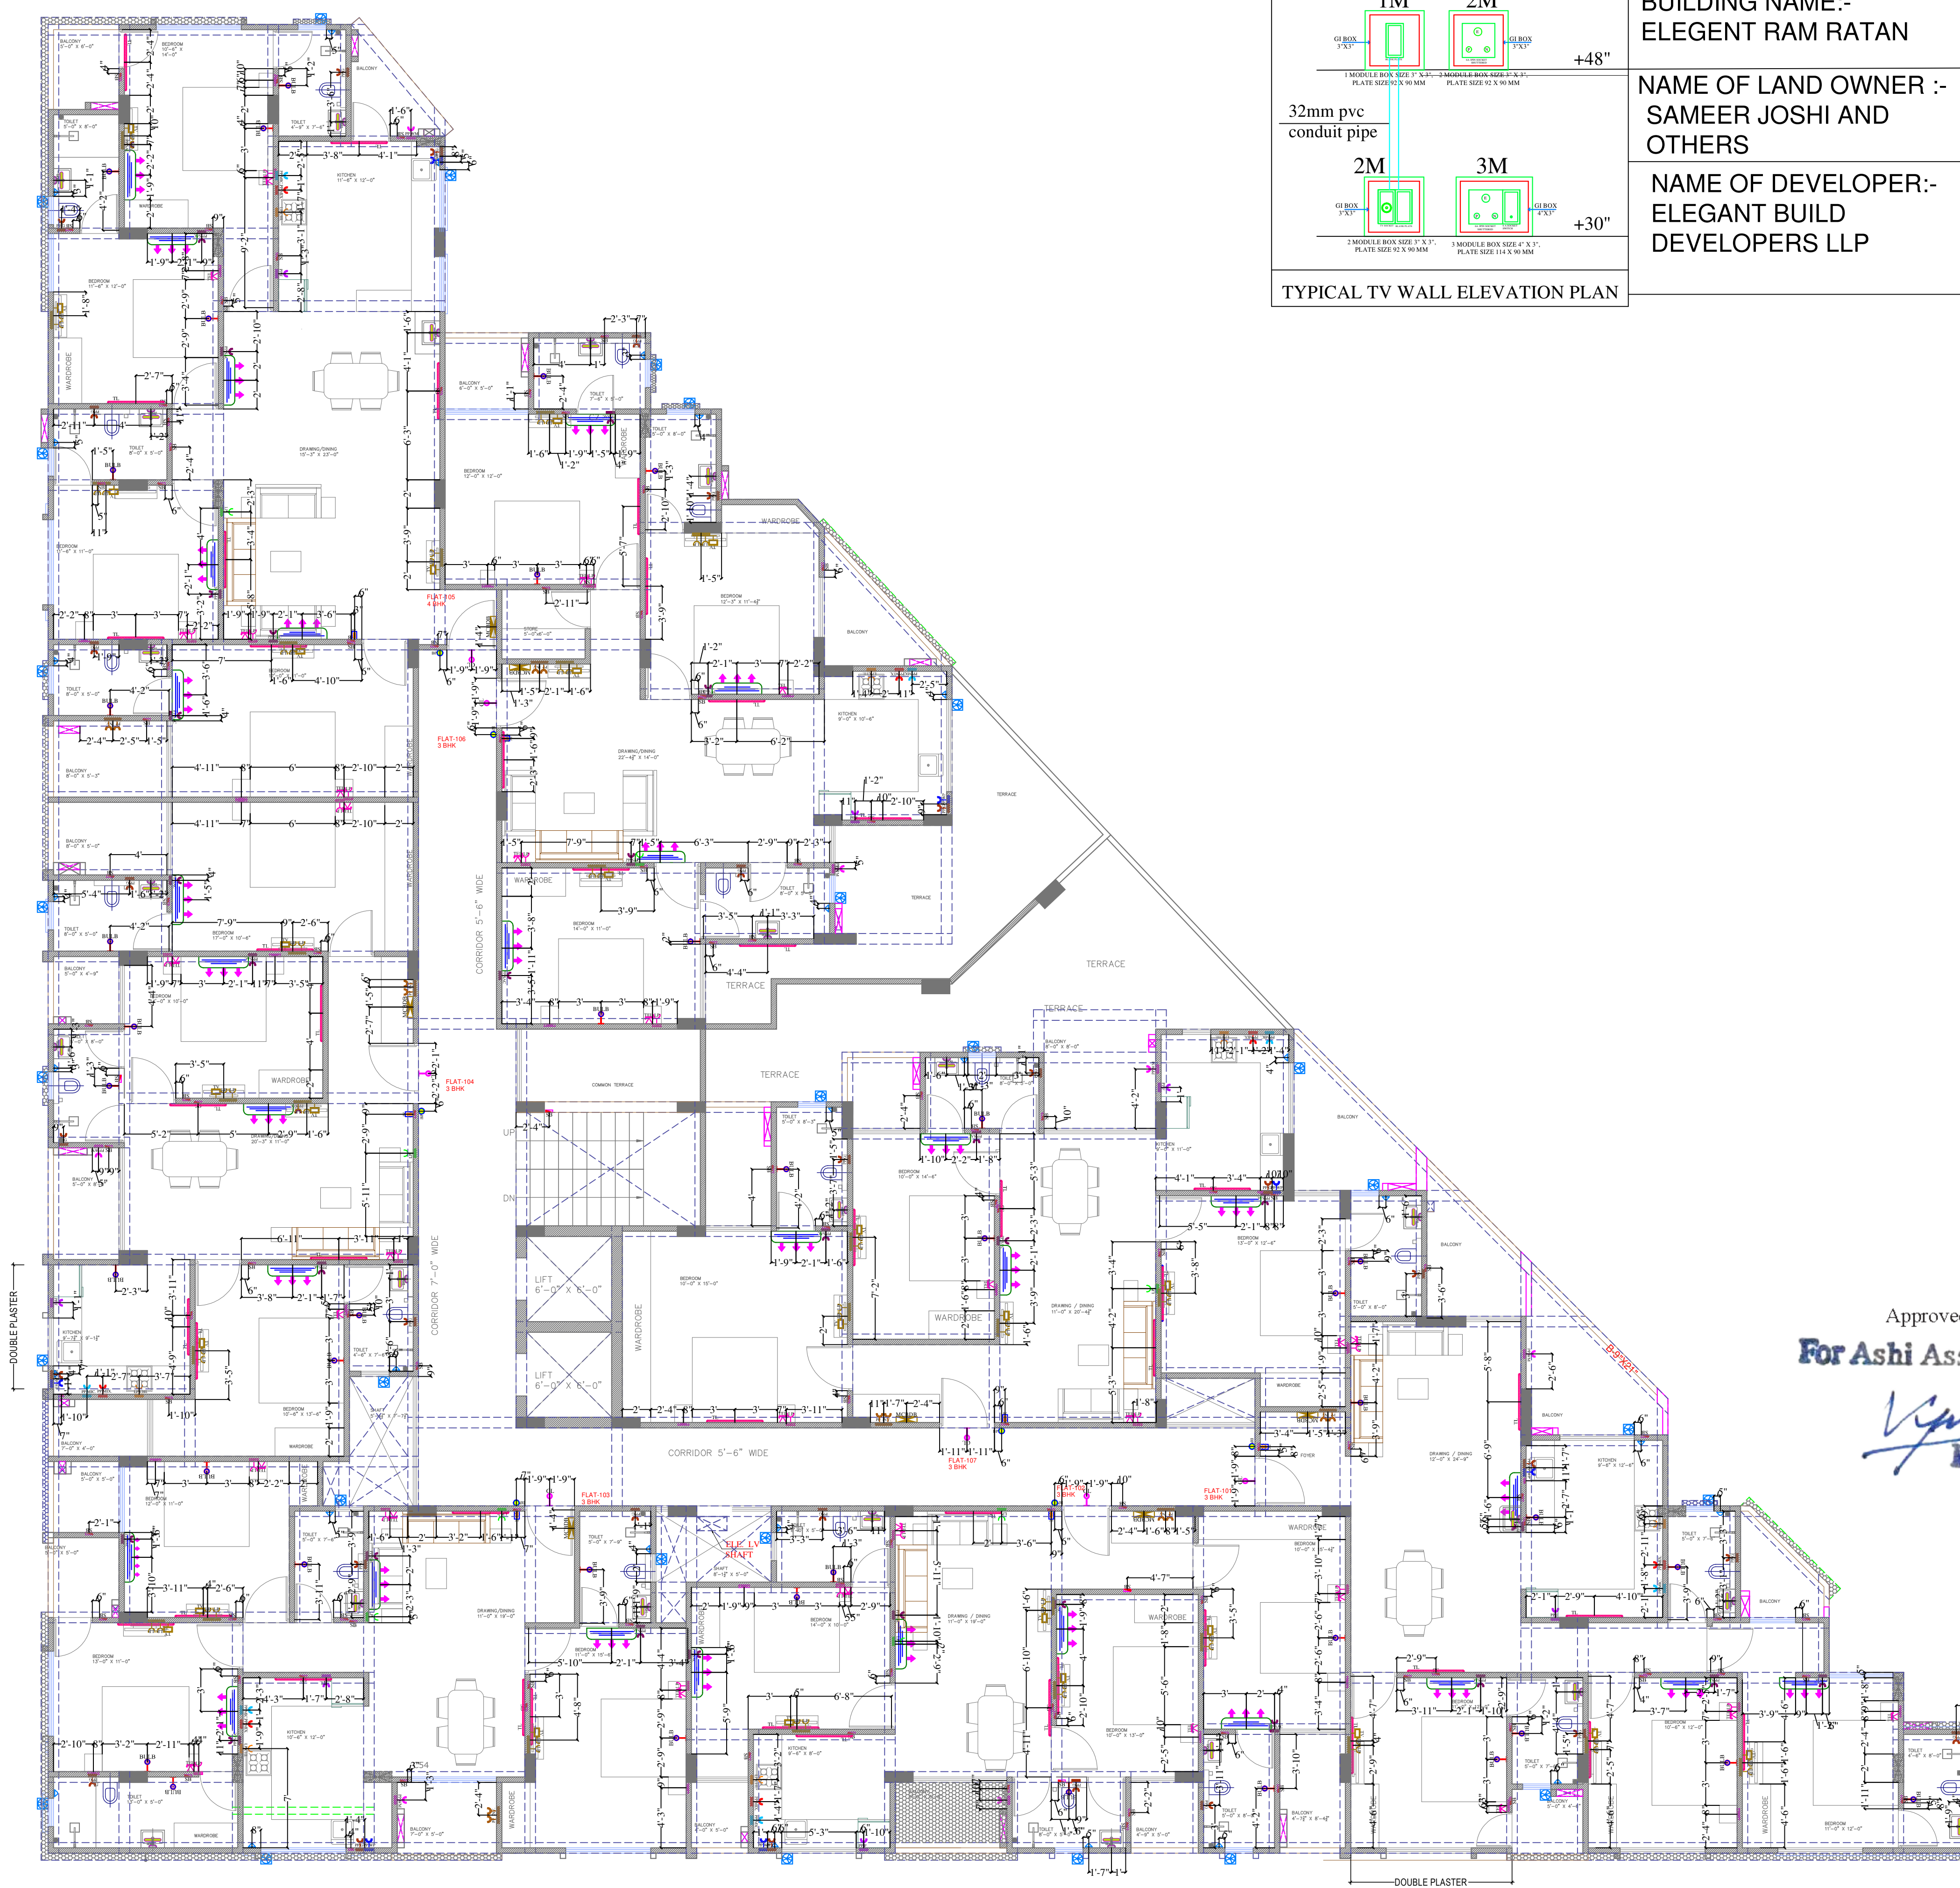

BUILDING NAME:-
ELEGENT RAM RATAN

NAME OF LAND OWNER :-
SAMEER JOSHI AND
OTHERS

NAME OF DEVELOPER:-
ELEGANT BUILD
DEVELOPERS LLP

LEGENDS:				
Mounting Height	No.	I D	Symbol	Description
IN CONDUIT	WIRE			Control Wiring For Geyser 4.0 sqmm Red (Phase), Black (Neutral), 2.5 sqmm Green (Earth)
				Control Wiring For 2 Way Light Point 5.5 sqmm Red (Phase), Black (Neutral), 2.5 sqmm Green (Earth)
				Control Wiring For Light Point 5.5 sqmm Red (Phase), Black (Neutral), 2.5 sqmm Green (Earth)
IN CONDUIT	WIRE			Control Wiring For Bell Push 5.5 sqmm Red (Phase), Black (Neutral), 2.5 sqmm Green (Earth)
				Control Wiring For Emergency Point 5.5 sqmm Red (Phase), Black (Neutral), 2.5 sqmm Green (Earth)
				Light Circuit 2.5 sqmm Red (Phase), Black (Neutral), 2.5 sqmm Green (Earth)
IN CONDUIT	WIRE			AC Circuit 4.0 sqmm Red (Phase), Black (Neutral), 2.5 sqmm Green (Earth)
CEILING	37	FAN/48"		CEILING FAN 48"
CEILING	08	FAN/30"		CEILING FAN 30"
CEILING	22	FB		FAN BOX
CEILING	04	CHI		CHANDLER
+90"	44	TLW		LED Wall Tube Light Make:- Syka Led Cat no:- SYKA-TS-20W
+90"	39	BULB		LED Bulb-20W Make:- Syka Led Cat no:- SYKA-20W-57K/3K
+90"	07	GL		WALL BRACKETS AS DESIGN FOR GANESH LIGHT
+78"	24	ML		12x2 Led Mirror Light Make:- Syka Led Cat no:- FPL-12x2
CEILING	93	DL		LED 6" Down Light 20W (Surface Mounted) Make:- Syka Led Cat no:- SYKA-15W GLD 6.5K/3K
VENTILATOR HT	29	CR		CEILING ROSE
VENTILATOR HT	29	EXP		9" DIA FRESH AIR FAN
+24"	22	2WAY SB		2WAY SWITCH BOARD
+42"	116	SB		SWITCH BOARD
+24"	29	TEL		TELEPHONE POINT
+24"	29	LP-TEL		6 A PLUG POINT FOR TELEPHONE
+48"	27	TV		TV COAXIAL POINT
+48"	54	LP-TV		6 A PLUG POINT FOR TV
+24"	08	LP		6 A PLUG POINT FOR SIDE TABLE
+72"	07	LP-CH		6 A PLUG POINT FOR CHIMNEY
+90"	30	SAC		SPLIT AC INDOOR UNIT
+90"	30	PP-SAC		25 A POWER POINT FOR SPLIT AC
+42"	07	PP-MIX		16 A POWER POINT FOR MIXER
+42"	07	PP-MIC		16 A POWER POINT FOR MICROWAVE
+78"	29	PP-G		16 A POWER POINT FOR GEYSER
+54"	07	PP-F		16 A POWER POINT FOR FRIDGE
+78"	07	PP-WP		16 A POWER POINT FOR WATER PURIFIER
+48"	07	PP-WM		16 A POWER POINT FOR WASHING MACHINE
+12"	07	PP-INV		16 A POWER POINT FOR INVERTOR
+60"	07	BP		6 A BELL PUSH
+90"	07	BZ		BUZZER FOR CALL BELL
+60"	07	MCB DB		MCB DISTRIBUTION BOARD
		SS SC		SS SOCKET ON SWITCH BOARD
				SWITCH BOARD NO./LIGHT CIRCUIT NO./MODULAR NO.
				POWER CIRCUIT NO./MODULAR NO.
				AC CIRCUIT NO.
				MODULAR NO.
				EMERGENCY LIGHT POINT

Approved
For Ashi Associates
Vipul
Partner

STUDIO 1503
Architects, Interior Designers
SECTOR-3,E-156 Chitrakoot
Scheme,
Ajmer Road, Jaipur
PH: +91-141-4971223
email : studio1503@gmail.com

PLOT NO- 26-31
NARENDRA NAGAR, SWEJ FARM,
NEW SANGANER ROAD, SODALA,
JAIPUR

SERVICES CONSULTANT:
ASHI ASSOCIATES
F 9 / 440 , Keshav Marg Chitrakut Scheme,Jaipur
PH:91-0-93146-10438 ,0141-2440946 Mail:vipul8599@yahoo.com

STRUCTURAL CONSULTANTS:-
SG STRUCTURES
A-36/1ST FLOOR, SUNDER SINGH BANDARI NAGAR,
SWEJ FARM, NEW SANGANER ROAD, JAIPUR-302019
E-mail: sg.structures@gmail.com
Tel: 0977222219,0141-2297076

LAYOUT PLAN

DATE: 01-11-2021

DRAWN BY: RAJENDRA

CHECKED BY: SANJAY


PROJECT: VIPUL KARNAL

SCALE: 1/10

DRAWING NO.: PWD/01

NORTH:




 KHUSHAL MATHUR
 CA/2007/40651

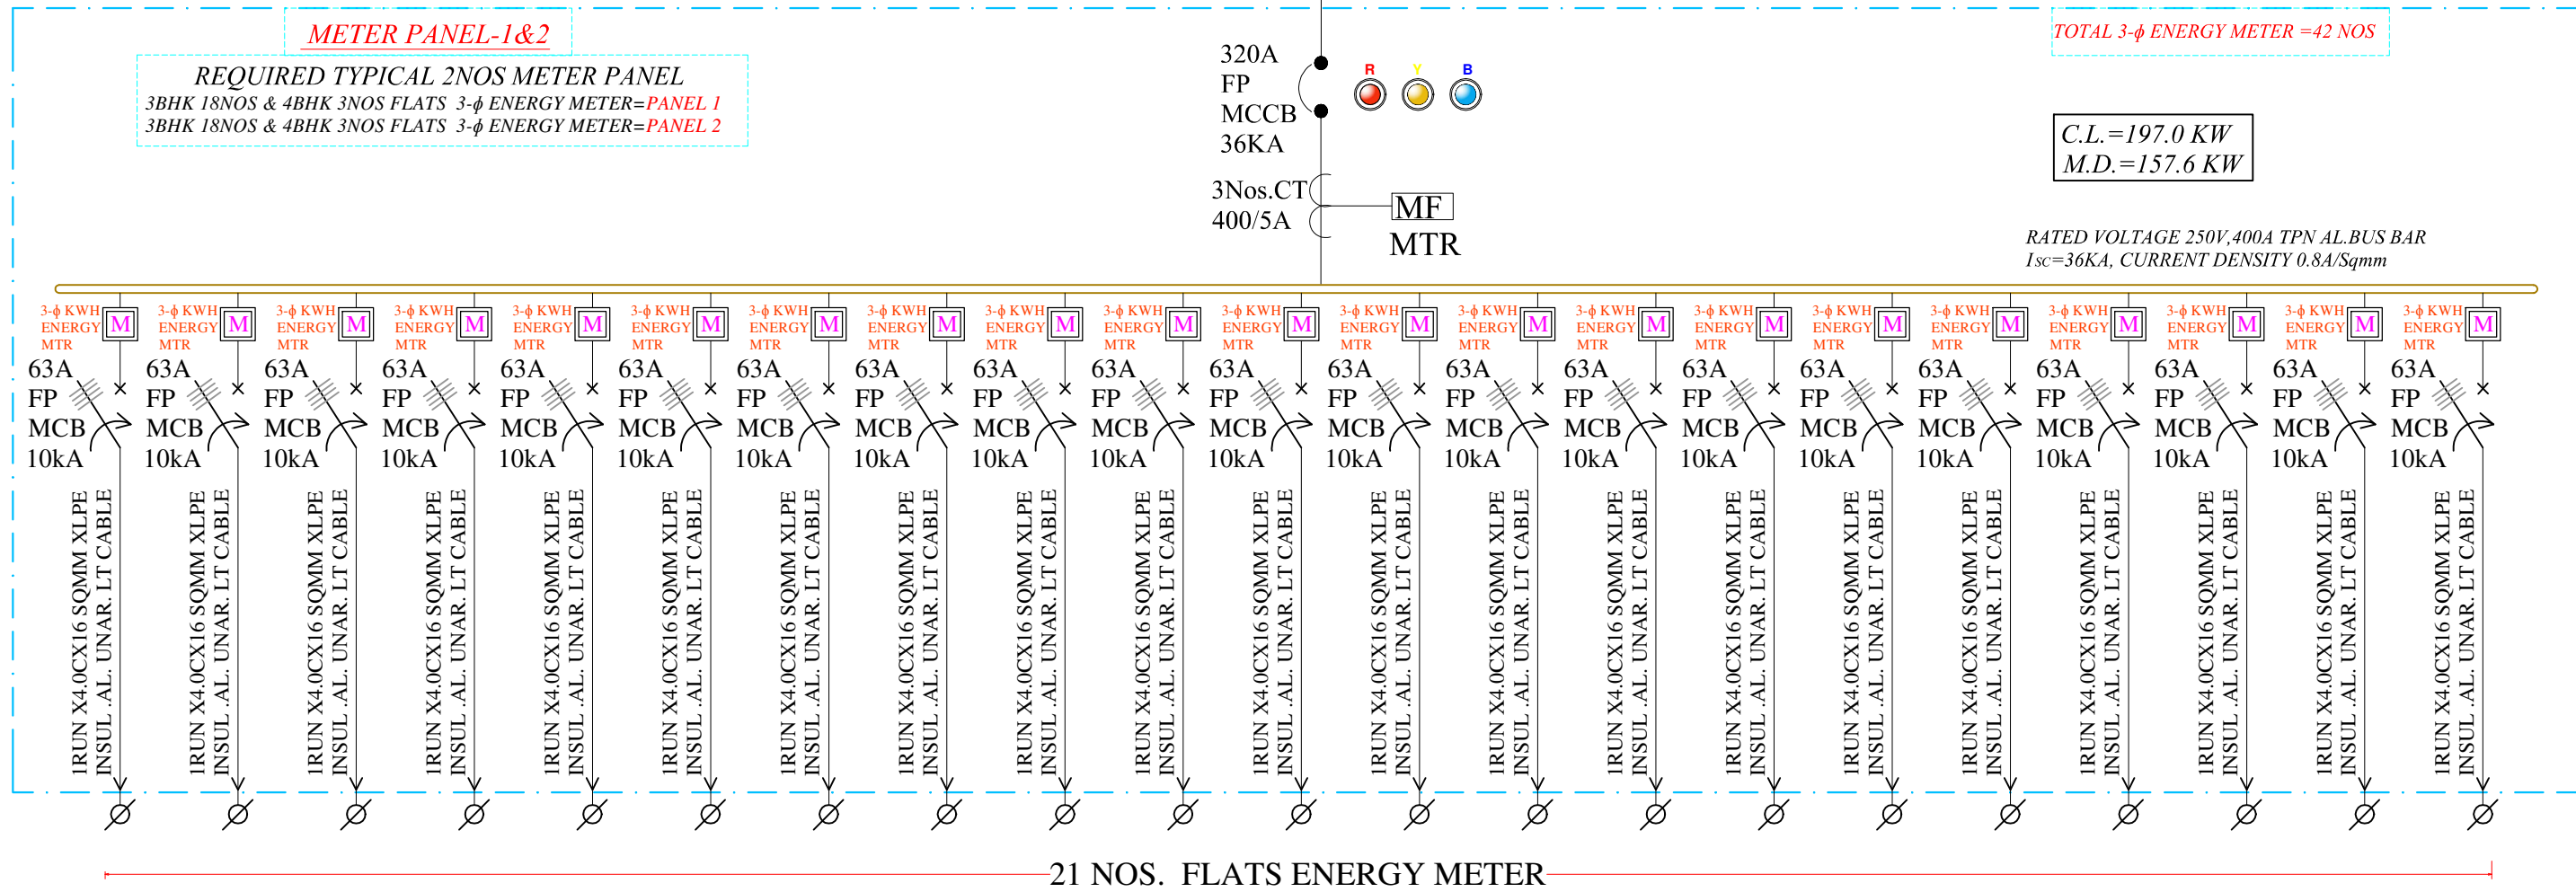

PROJECT:- SWEJ FARM AT NARENDRA NAGAR, JAIPUR	
TITLE:- ALL DISTRIBUTION PANEL	
DRAWING:- SINGLE LINE DIAGRAM	
DATE:- 05-10-2021	REV:- 00
DRAWN BY:- SURENDER YADAV	
CHECKED BY:- VIPUL AGARWAL	



by *[Signature]*
KHUSHAL MATHUR
CA/2007/40651

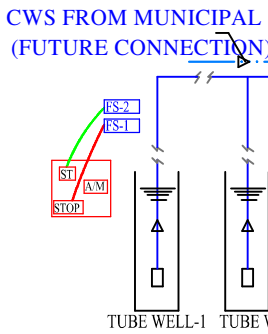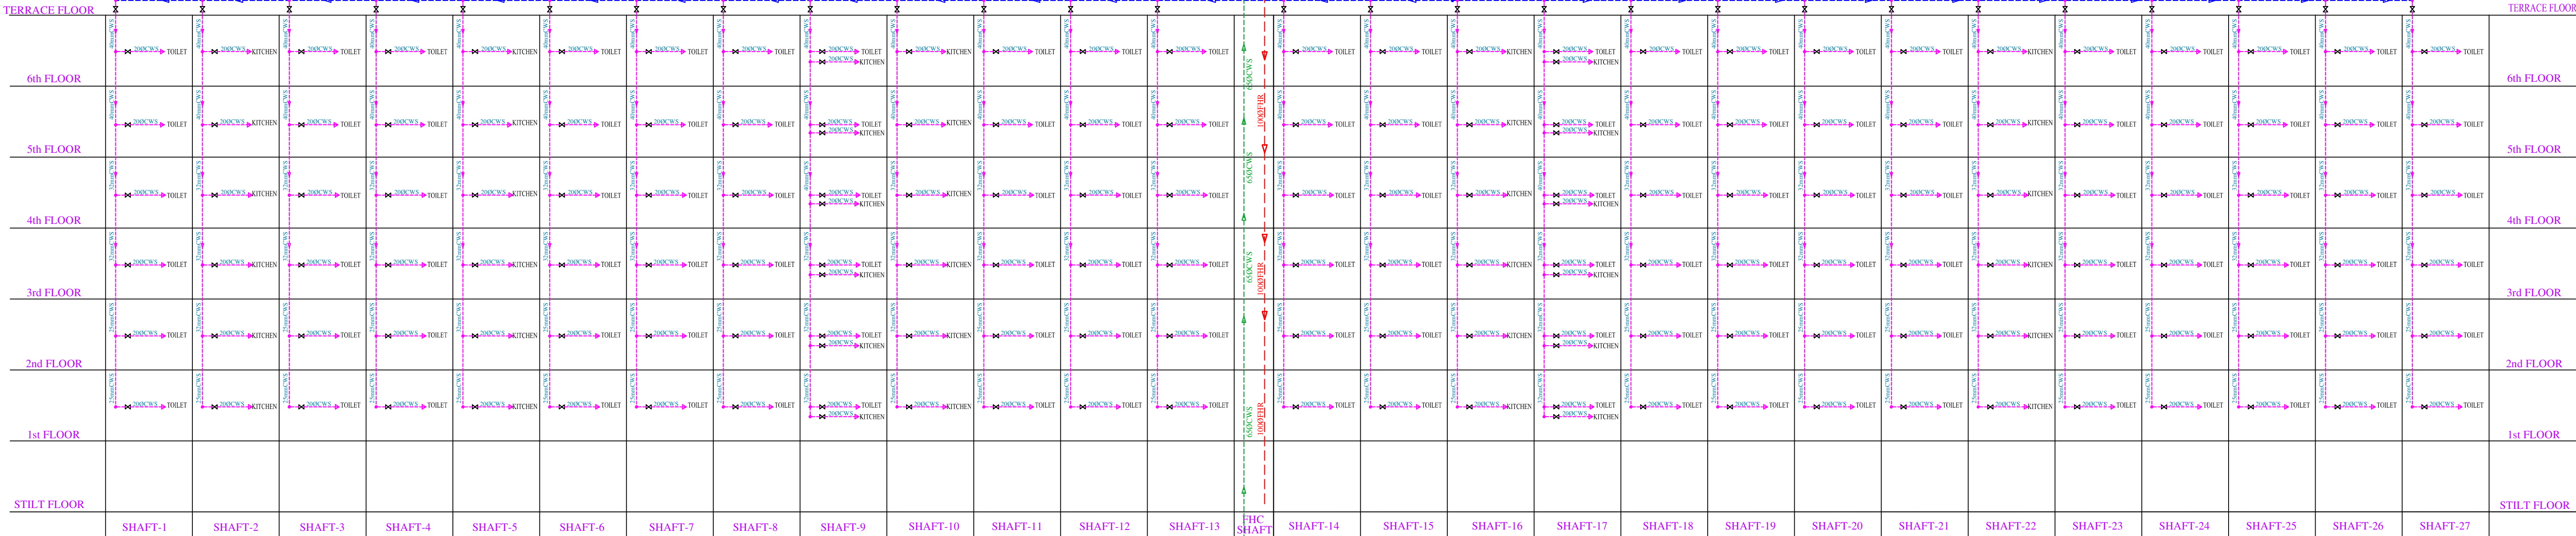

PLOT NO- 26-31
NARENDRA NAGAR, SWEJ
FARM, NEW SANGANER ROAD,
SODALA, JAIPUR

SERVICES CONSULTA
ASHI ASSOCITES

Architects, Interior Designers
SECTOR-3,E-156 Chitrakoot Scheme,
Ajmer Road, Jaipur
PH: +91-141-4971223
email : studio1503@gmail.com

BUILDING NAME:-
ELEGANT BAM BATAN


DEALT BY:-
RS FALGUN

SANJAY

WATER SUPPLY SCHEMATIC DIAGRAM PLAN

DRAWING No.:

MEP/CWS/SLD-01

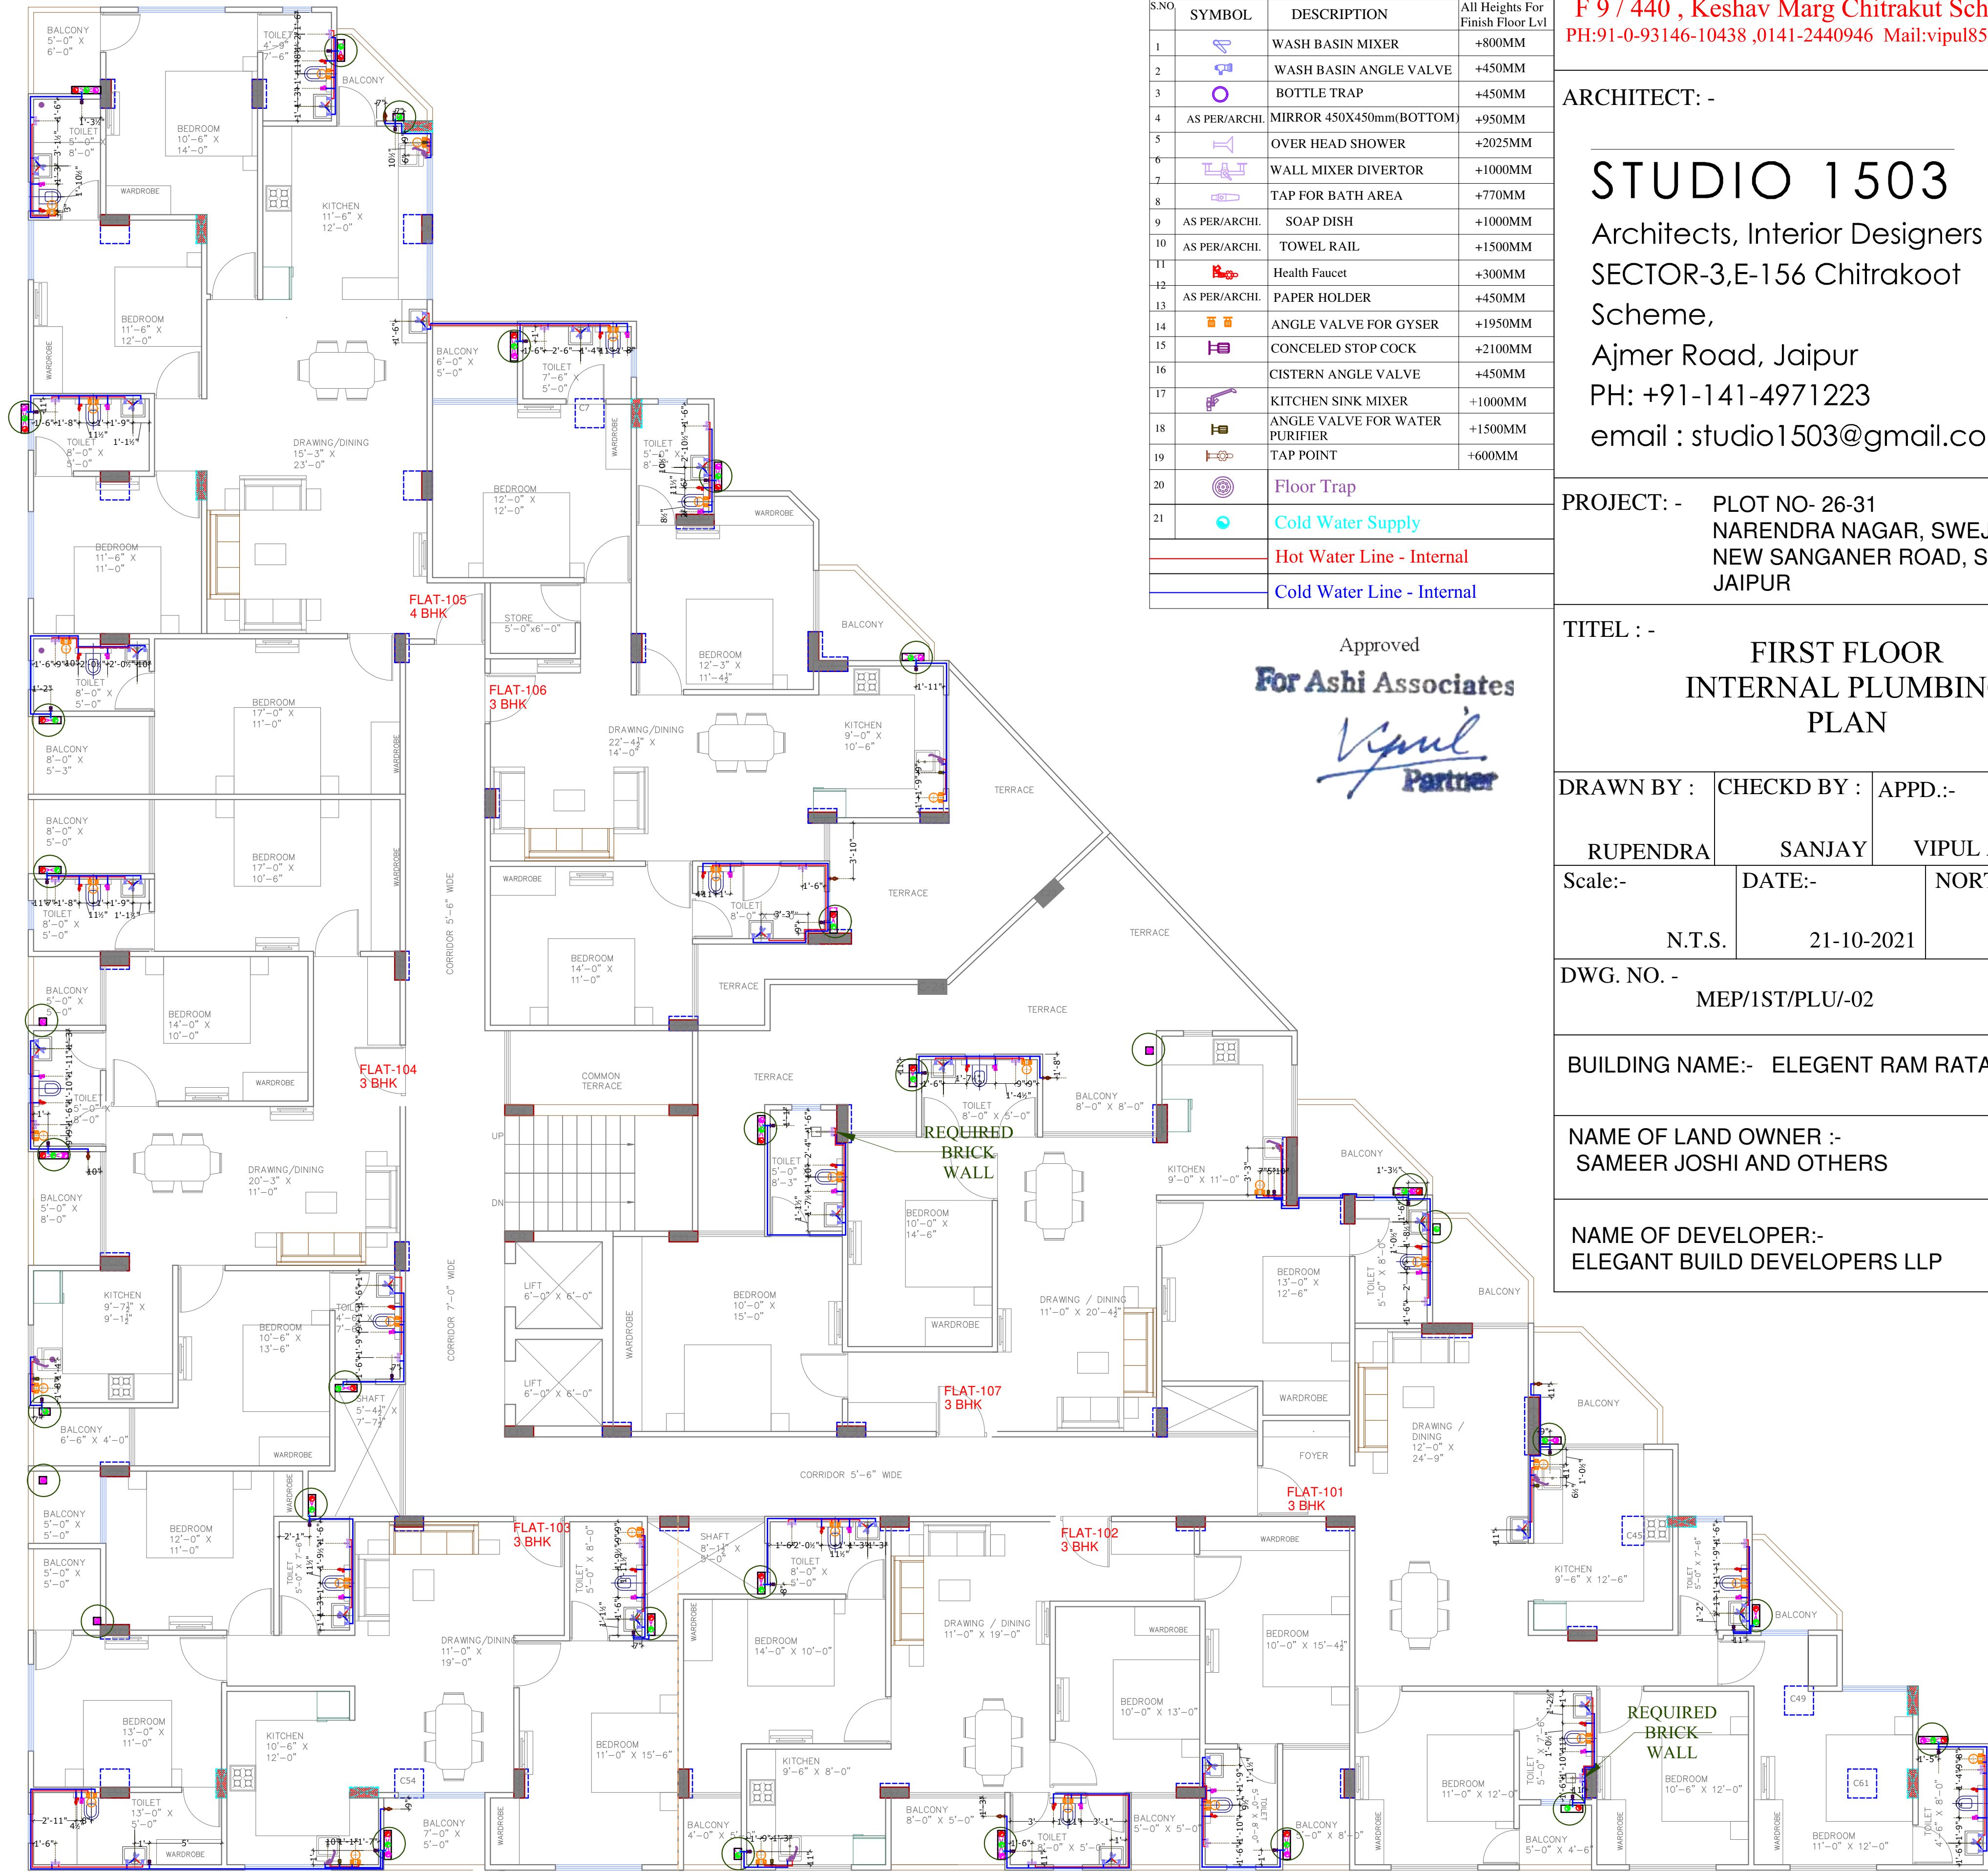

NOTE:-			
STANDARDS SANITARY APPLIANCES HEIGHTS/AS PER AR.DETAILS			
S.NO	SYMBOL	DESCRIPTION	All Heights For Finish Floor Lvl
1		WASH BASIN MIXER	+800MM
2		WASH BASIN ANGLE VALVE	+450MM
3		BOTTLE TRAP	+450MM
4	AS PER/ARCHI.	MIRROR 450X450mm(BOTTOM)	+950MM
5		OVER HEAD SHOWER	+2025MM
6		WALL MIXER DIVERTOR	+1000MM
7		TAP FOR BATH AREA	+770MM
9	AS PER/ARCHI.	SOAP DISH	+1000MM
10	AS PER/ARCHI.	TOWEL RAIL	+1500MM
11		Health Faucet	+300MM
12	AS PER/ARCHI.	PAPER HOLDER	+450MM
13		ANGLE VALVE FOR GYSER	+1950MM
15		CONCELED STOP COCK	+2100MM
16		CISTERN ANGLE VALVE	+450MM
17		KITCHEN SINK MIXER	+1000MM
18		ANGLE VALVE FOR WATER PURIFIER	+1500MM
19		TAP POINT	+600MM
20		Floor Trap	
21		Cold Water Supply	
		Hot Water Line - Internal	
		Cold Water Line - Internal	

Approved
For Ashi Associates
Vipul
Partner

SERVICES CONSULTANT:
ASHI ASSOCIATES
F 9 / 440 , Keshav Marg Chitrakut Scheme,Jaipur
PH:91-0-93146-10438 ,0141-2440946 Mail:vipul8599@yahoo.com

ARCHITECT: -
STUDIO 1503
Architected, Interior Designers
SECTOR-3,E-156 Chitrakoot
Scheme,
Ajmer Road, Jaipur
PH: +91-141-4971223
email : studio1503@gmail.com

PROJECT: - PLOT NO- 26-31
NARENDRA NAGAR, SWEJ FARM,
NEW SANGANER ROAD, SODALA
JAIPUR

TITEL : -
**FIRST FLOOR
INTERNAL PLUMBING
PLAN**

DRAWN BY :	CHECKD BY :	APPD.:-
RUPENDRA	SANJAY	VIPUL AGARWAL
Scale:-	DATE:-	NORTH : -
N.T.S.	21-10-2021	


DWG. NO. -
MEP/1ST/PLU/-02

BUILDING NAME:- ELEGENT RAM RATAN

NAME OF LAND OWNER :-
SAMEER JOSHI AND OTHERS

NAME OF DEVELOPER:-
ELEGANT BUILD DEVELOPERS LLP

FIRST FLOOR

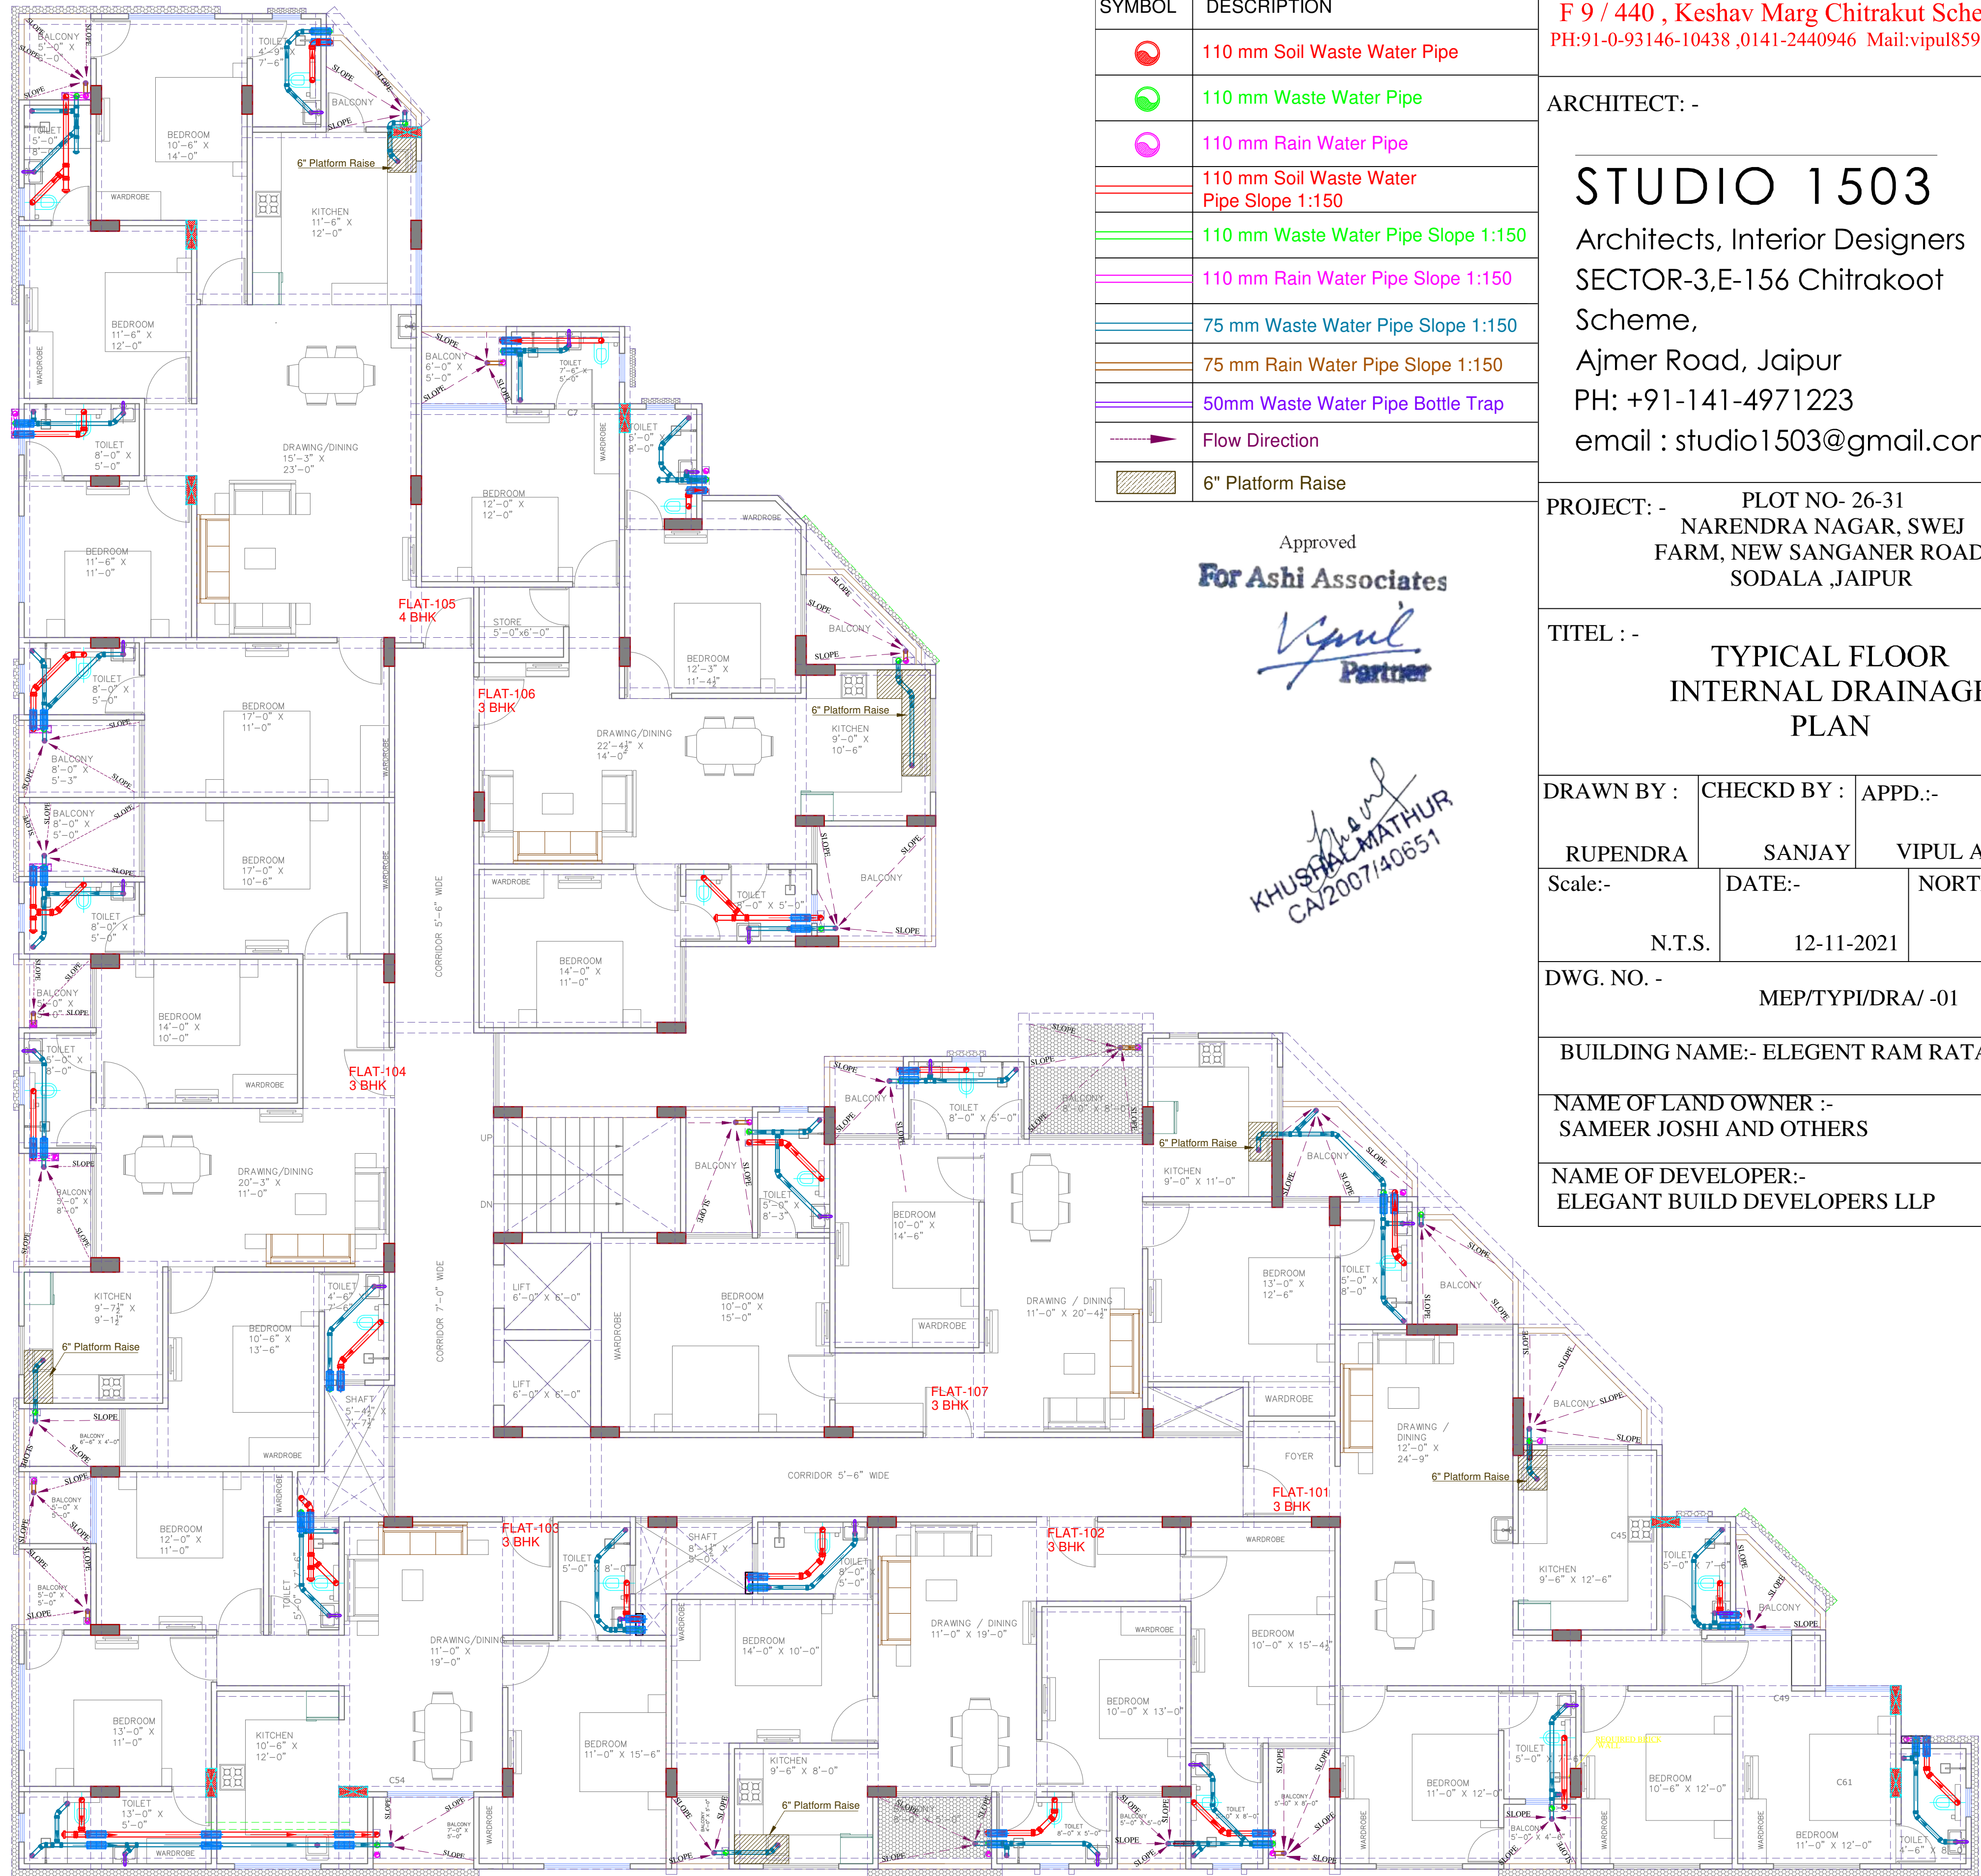

NOTE:-

SYMBOL	DESCRIPTION
	110 mm Soil Waste Water Pipe
	110 mm Waste Water Pipe
	110 mm Rain Water Pipe
	110 mm Soil Waste Water Pipe Slope 1:150
	110 mm Waste Water Pipe Slope 1:150
	110 mm Rain Water Pipe Slope 1:150
	75 mm Waste Water Pipe Slope 1:150
	75 mm Rain Water Pipe Slope 1:150
	50mm Waste Water Pipe Bottle Trap
	Flow Direction
	6" Platform Raise

Approved
For Ashi Associates
Vipul
Partner

Khusal
KHUSHAL MATHUR
CA2007/40851

SERVICES CONSULTANT:
ASHI ASSOCIATES

F 9 / 440 , Keshav Marg Chitrakut Scheme,Jaipur
PH:91-0-93146-10438 ,0141-2440946 Mail:vipul8599@yahoo.com

ARCHITECT: -

STUDIO 1503

Architects, Interior Designers
SECTOR-3,E-156 Chitrakoot
Scheme,
Ajmer Road, Jaipur
PH: +91-141-4971223
email : studio1503@gmail.com

PROJECT: - PLOT NO- 26-31
NARENDRA NAGAR, SWEJ
FARM, NEW SANGANER ROAD,
SODALA ,JAIPUR

TITEL : -
TYPICAL FLOOR
INTERNAL DRAINAGE
PLAN

DRAWN BY :	CHECKD BY :	APPD:-
RUPENDRA	SANJAY	VIPUL AGARWAL

Scale:-	DATE:-	NORTH : -
N.T.S.	12-11-2021	


DWG. NO. - MEP/TYPI/DRA/ -01

BUILDING NAME:- ELEGENT RAM RATAN

NAME OF LAND OWNER :-
SAMEER JOSHI AND OTHERS

NAME OF DEVELOPER:-
ELEGANT BUILD DEVELOPERS LLP

TYPICAL FLOOR

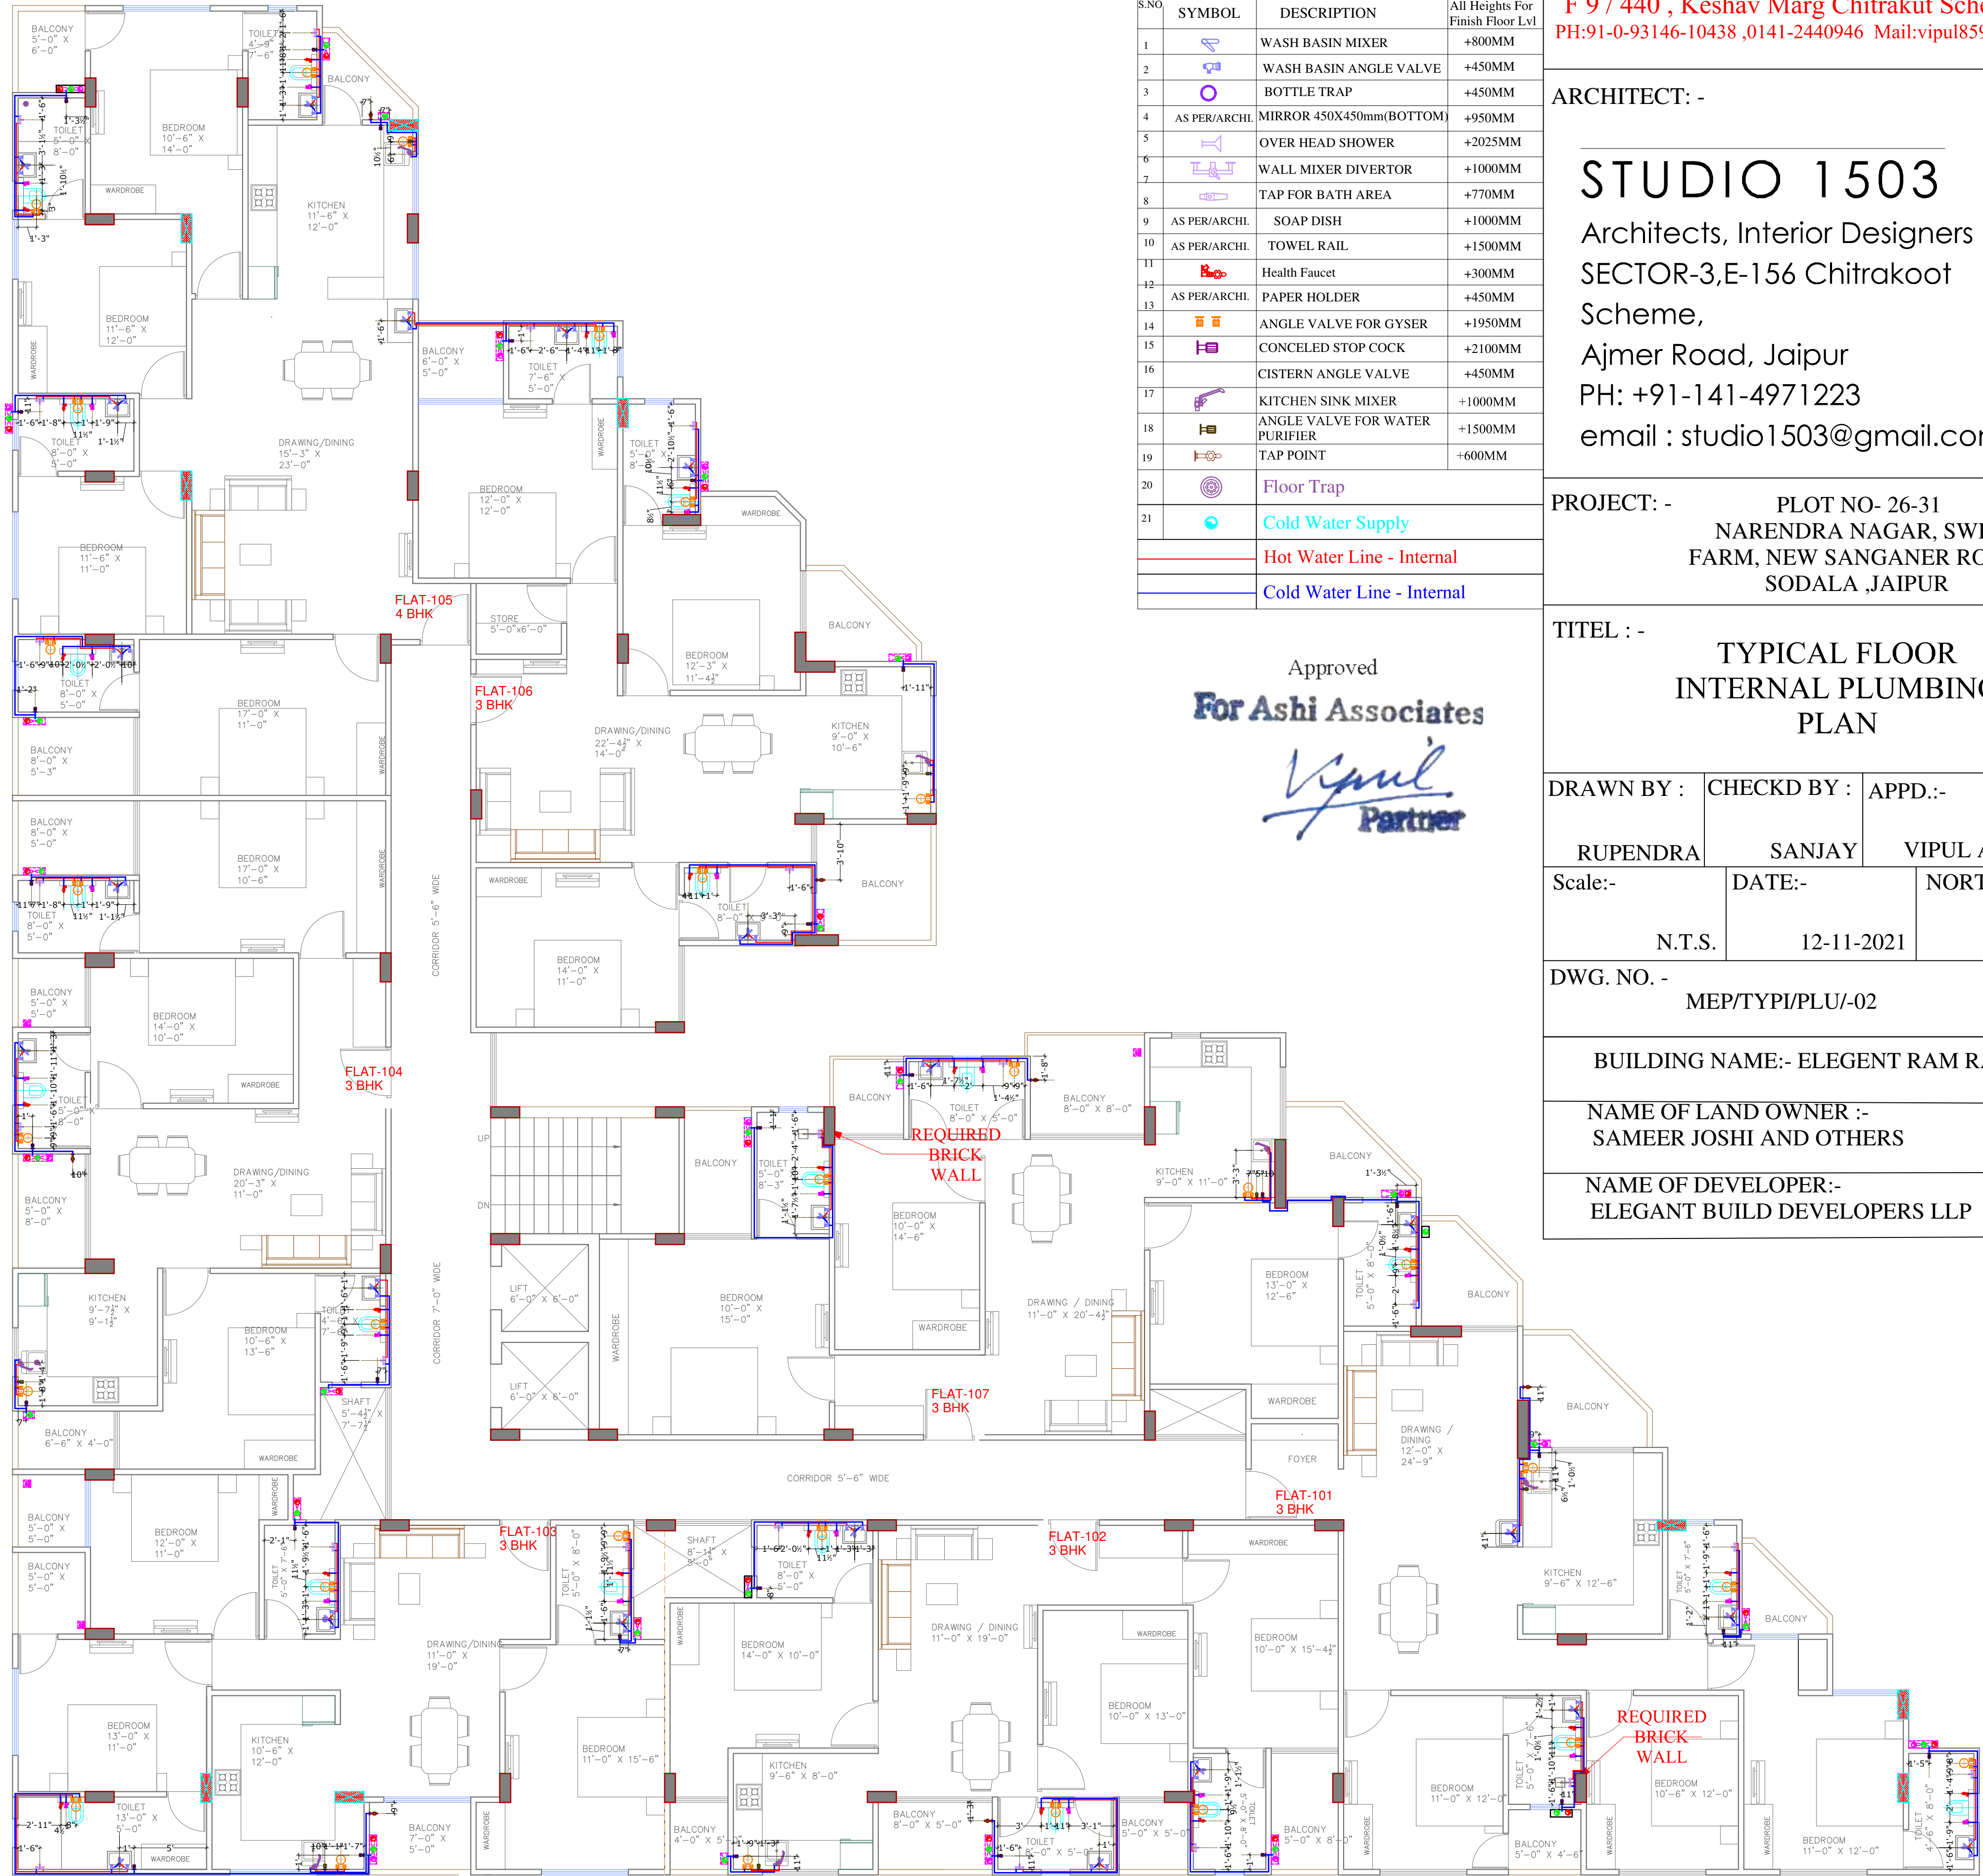

NOTE:-			
STANDARDS SANITARY APPLIANCES HEIGHTS/AS PER AR.DETAILS			
S.NO	SYMBOL	DESCRIPTION	All Heights For Finish Floor Lvl
1		WASH BASIN MIXER	+800MM
2		WASH BASIN ANGLE VALVE	+450MM
3		BOTTLE TRAP	+450MM
4	AS PER/ARCHT.	MIRROR 450X450mm(BOTTOM)	+950MM
5		OVER HEAD SHOWER	+2025MM
6		WALL MIXER DIVERTOR	+1000MM
7		TAP FOR BATH AREA	+770MM
8	AS PER/ARCHT.	SOAP DISH	+1000MM
10	AS PER/ARCHT.	TOWEL RAIL	+1500MM
11		Health Faucet	+300MM
12	AS PER/ARCHT.	PAPER HOLDER	+450MM
14		ANGLE VALVE FOR GYSER	+1950MM
15		CONCELED STOP COCK	+2100MM
16		CISTERN ANGLE VALVE	+450MM
17		KITCHEN SINK MIXER	+1000MM
18		ANGLE VALVE FOR WATER PURIFIER	+1500MM
19		TAP POINT	+600MM
20		Floor Trap	
21		Cold Water Supply	
		Hot Water Line - Internal	
		Cold Water Line - Internal	

Approved
For Ashi Associates

SERVICES CONSULTANT:
ASHI ASSOCIATES
F 9 / 440 , Keshav Marg Chitrakut Scheme,Jaipur
PH:91-0-93146-10438 ,0141-2440946 Mail:vipul8599@yahoo.com

ARCHITECT: -

STUDIO 1503
Architects, Interior Designers
SECTOR-3,E-156 Chitrakoot Scheme,
Ajmer Road, Jaipur
PH: +91-141-4971223
email : studio1503@gmail.com

PROJECT: - PLOT NO- 26-31
NARENDRA NAGAR, SWEJ FARM, NEW SANGANER ROAD, SODALA ,JAIPUR

TITEL : -
**TYPICAL FLOOR
INTERNAL PLUMBING
PLAN**

DRAWN BY :	CHECKD BY :	APPD.:-
RUPENDRA	SANJAY	VIPUL AGARWAL
Scale:-	DATE:-	NORTH : -
N.T.S.	12-11-2021	

DWG. NO. -
MEP/TYPI/PLU/-02


BUILDING NAME:- ELEGENT RAM RATAN

NAME OF LAND OWNER :-
SAMEER JOSHI AND OTHERS

NAME OF DEVELOPER:-
ELEGANT BUILD DEVELOPERS LLP

TYPICAL FLOOR

ROAD 30' WIDE

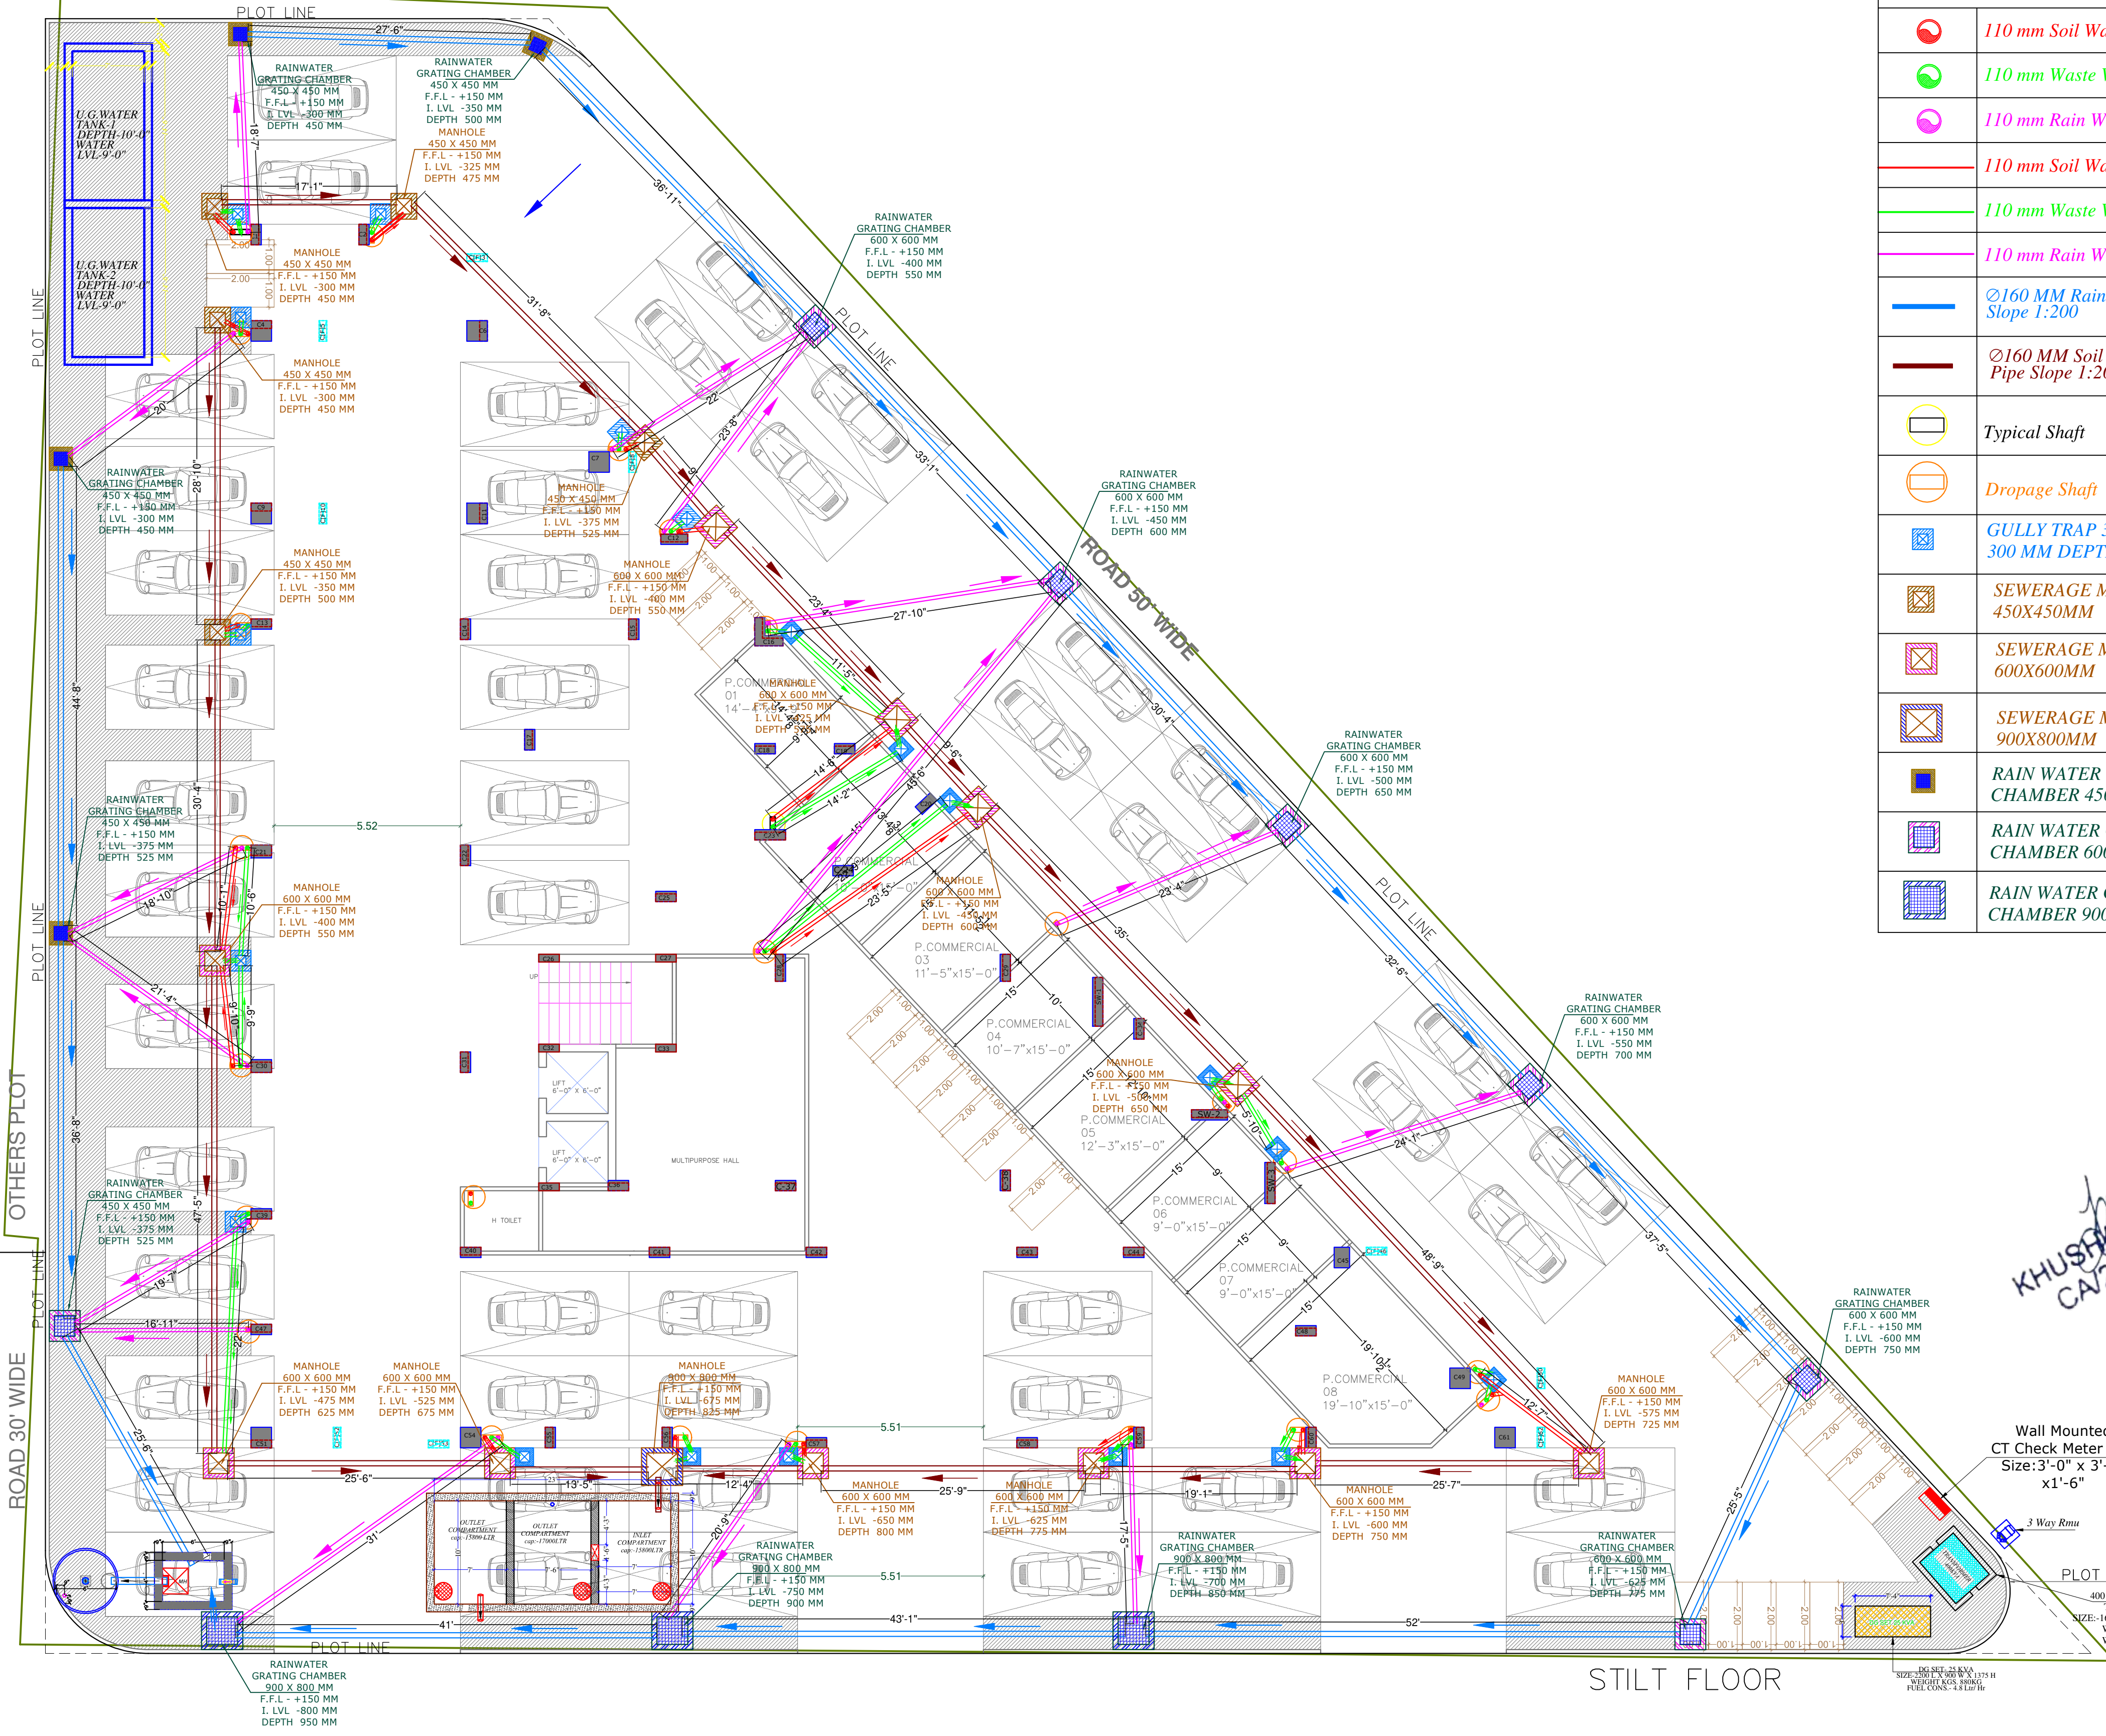

SYMBOL	DESCRIPTION
	110 mm Soil Waste Water Pipe
	110 mm Waste Water Pipe
	110 mm Rain Water Pipe
	110 mm Soil Waste Water Pipe
	110 mm Waste Water Pipe
	110 mm Rain Water Pipe
	Ø160 MM Rain Water Pipe Slope 1:200
	Ø160 MM Soil Waste Water Pipe Slope 1:200
	Typical Shaft
	Dropage Shaft
	GULLY TRAP 300X300MM - 300 MM DEPTH
	SEWERAGE MANHOLE 450X450MM
	SEWERAGE MANHOLE 600X600MM
	SEWERAGE MANHOLE 900X800MM
	RAIN WATER GRATING CHAMBER 450X450MM
	RAIN WATER GRATING CHAMBER 600X600MM
	RAIN WATER GRATING CHAMBER 900X800MM

Approved
For Ashi Associates

03.		03.	
02.		02.	
01.		01.	
S.No.	DATE	REVISION DESCRIPTION	S.No. DATE ISSUED TO

GENERAL NOTES:-

1. All Dimension On This Drawing Are In Feet & Inches.
2. Only Written Dimensions Are To Be Followed. Drawing Should Not Be Scaled Under Any Circumstances.
3. All Measurements Must Be Checked & Verified By The Contractors Prior To Execution Of Work At The Site.
4. This Drawing Is To Be Read In Conjunction With All Relevant Structural, Services & Facility Planning Drawings.
5. Architectural Drawings Are To Be Followed For The Location Of All Structural Members & Masonry Walls For Size & Reinforcement Details Of Structural Members. Relevant Structural Drawings Are To Be Refered.
6. Any Discrepancies Between Architectural, Structural & Services Drawings Must Be Brought To The Notice Of The Architects Immediately & Prior To Execution At Site.
7. Coordination With Services Such As HVAC, Plumbing & Electrical Is The Responsibility Of The Contractors.
8. All Masonry Walls Should Be Aligned With The Columns As Indicated On The Plan, Respective Of The Position As Calculated With The Dimensioning.
9. For Details Refer Relevant Large Scale Detail Drawings As Indicated.

STUDIO 1503
Architects, Interior Designers
SECTOR-3, E-156 Chitrakoot
Scheme,
Ajmer Road, Jaipur
PH: +91-141-4971223
email : studio1503@gmail.com

BUILDING NAME:- ELEGENT RAM RATAN

NAME OF LAND OWNER :- SAMEER JOSHI AND OTHERS


NAME OF DEVELOPER:- ELEGANT BUILD DEVELOPERS LLP

PLOT NO- 26-31
NARENDRA NAGAR, SWEJ FARM, NEW SANGANER ROAD, SODALA ,JAIPUR

SERVICES CONSULTANT:
ASSHI ASSOCIATES
F 9 / 440 , Keshav Marg Chitrakut Scheme, Jaipur
PH: 91-0-93146-10438 , 0141-2440946 Mail: vipul8599@yahoo.com

STRUCTURAL CONSULTANTS:-
SG STRUCTURES
A-36, 1ST FLOOR, SUNDER SINGH BANDARI NAGAR, SWEJ FARM, NEW SANGANER ROAD, JAIPUR-302019
E-mail: sg.structures@gmail.com
Tel: 09772202219, 0141-2297076

SEPTIC TANK PLAN	DRAWING:-
DATE:- 21-07-2021	EXTERNAL SEWERAGE & RAIN WATER ROUTE PLAN
DETAIL:-	
CHD:- SANJAY	REV:-
APPD:- VIPUL AGARWAL	DRAWING NO:-
	MEP/EX/SEWRAIN-01

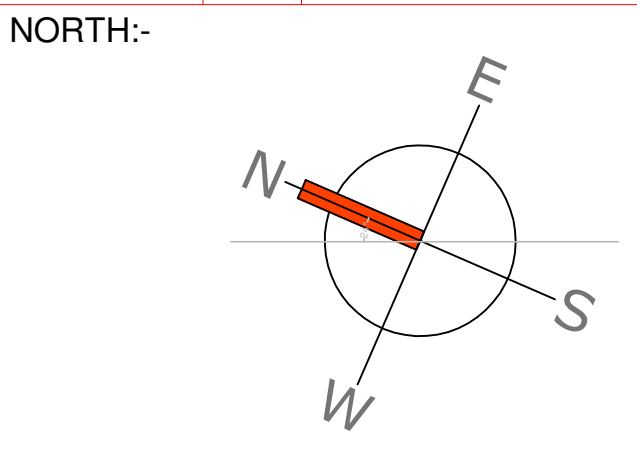

Handwritten signature
KHUSHAL MATHUR
CA2007/40651

Wall Mounted
CT Check Meter Box
Size: 3'-0" x 3'-0"
x1'-6"

3 Way Rnu

400 KVA 11kV/0.433kV
TRANSFORMER
SIZE: 1600 L X 1300 W X 2220 H
WITH 200Ltr OIL
WEIGHT: 2333Kg

STILT FLOOR

BUILDING NAME:- ELEGENT
RAM RATAN

NAME OF LAND OWNER :-
SAMEER JOSHI AND OTHERS

NAME OF DEVELOPER:-
ELEGANT BUILD DEVELOPERS
LLP

03.		03.	
02.		02.	
01.		01.	
S.No.	DATE	REVISION DESCRIPTION	S.No. DATE ISSUED TO

GENERAL NOTES:-
1. All Dimensions On This Drawing Are In Feet & Inches.
2. Only Written Dimensions Are To Be Followed. Drawing Should Not Be Scaled Under Any Circumstances.
3. All Measurements Must Be Checked & Verified By The Contractors Prior To Execution Of Work At The Site.
4. This Drawing Is To Be Read In Conjunction With All Relevant Structural, Services & Facility Planning Drawings.
5. Architectural Drawings Are To Be Followed For The Location Of All Structural Members, Relevant Masonry Walls, For Sizing & Reinforcement Details. Of Structural Members, Relevant Structural Drawings Are To Be Refered.
6. Any Discrepancies Between Architectural, Structural & Services Drawings Must Be Brought To The Notice Of The Architect Immediately & Prior To Execution At Site.
7. Coordination With Services Such As HVAC, Plumbing & Electrical Is The Responsibility Of The Contractor.
8. All Masonry Walls Should Be Aligned With The Columns As Indicated On The Plan, Respective Of The Position As Calculated With The Dimensioning.
9. For Details Refer Relevant Larger Scale Detail Drawings, As Indicated.

STUDIO 1503

Architects, Interior Designers
SECTOR-3, E-156 Chitrakoot
Scheme,
Ajmer Road, Jaipur
PH: +91-141-4971223
email : studio1503@gmail.com



PLOT NO- 26,27,28,29,30 & 31
NARENDRA NAGAR, SWEJ
FARM, JAIPUR


SERVICES CONSULTANT:
ASSHI ASSOCIATES
F 9 / 440 , Keshav Marg Chitrakut Scheme, Jaipur
PH: 91-0-93146-10438 , 0141-2440946 Mail: vipul8599@yahoo.com

STRUCTURAL CONSULTANTS:-

SG STRUCTURES
A-36, 1ST FLOOR, SUNDER SINGH BANDARI NAGAR,
SWEJ FARM, NEW SANGANER ROAD, JAIPUR-302019
E-mail: sg_structures@gmail.com
Tel: 09772202219, 0141-2297076

SEPTIC TANK PLAN	DRAWING:-
DATE:- 21-07-2021	SEPTIC TANK SECTION DETAILS PLAN
DETAIL:- FALGUNI	
CHKD:- SANJAY	REV:-
APPROD:- VIPUL AGARWAL	DRAWING No. MEP-ST-01
	R.00
NORTH:-	

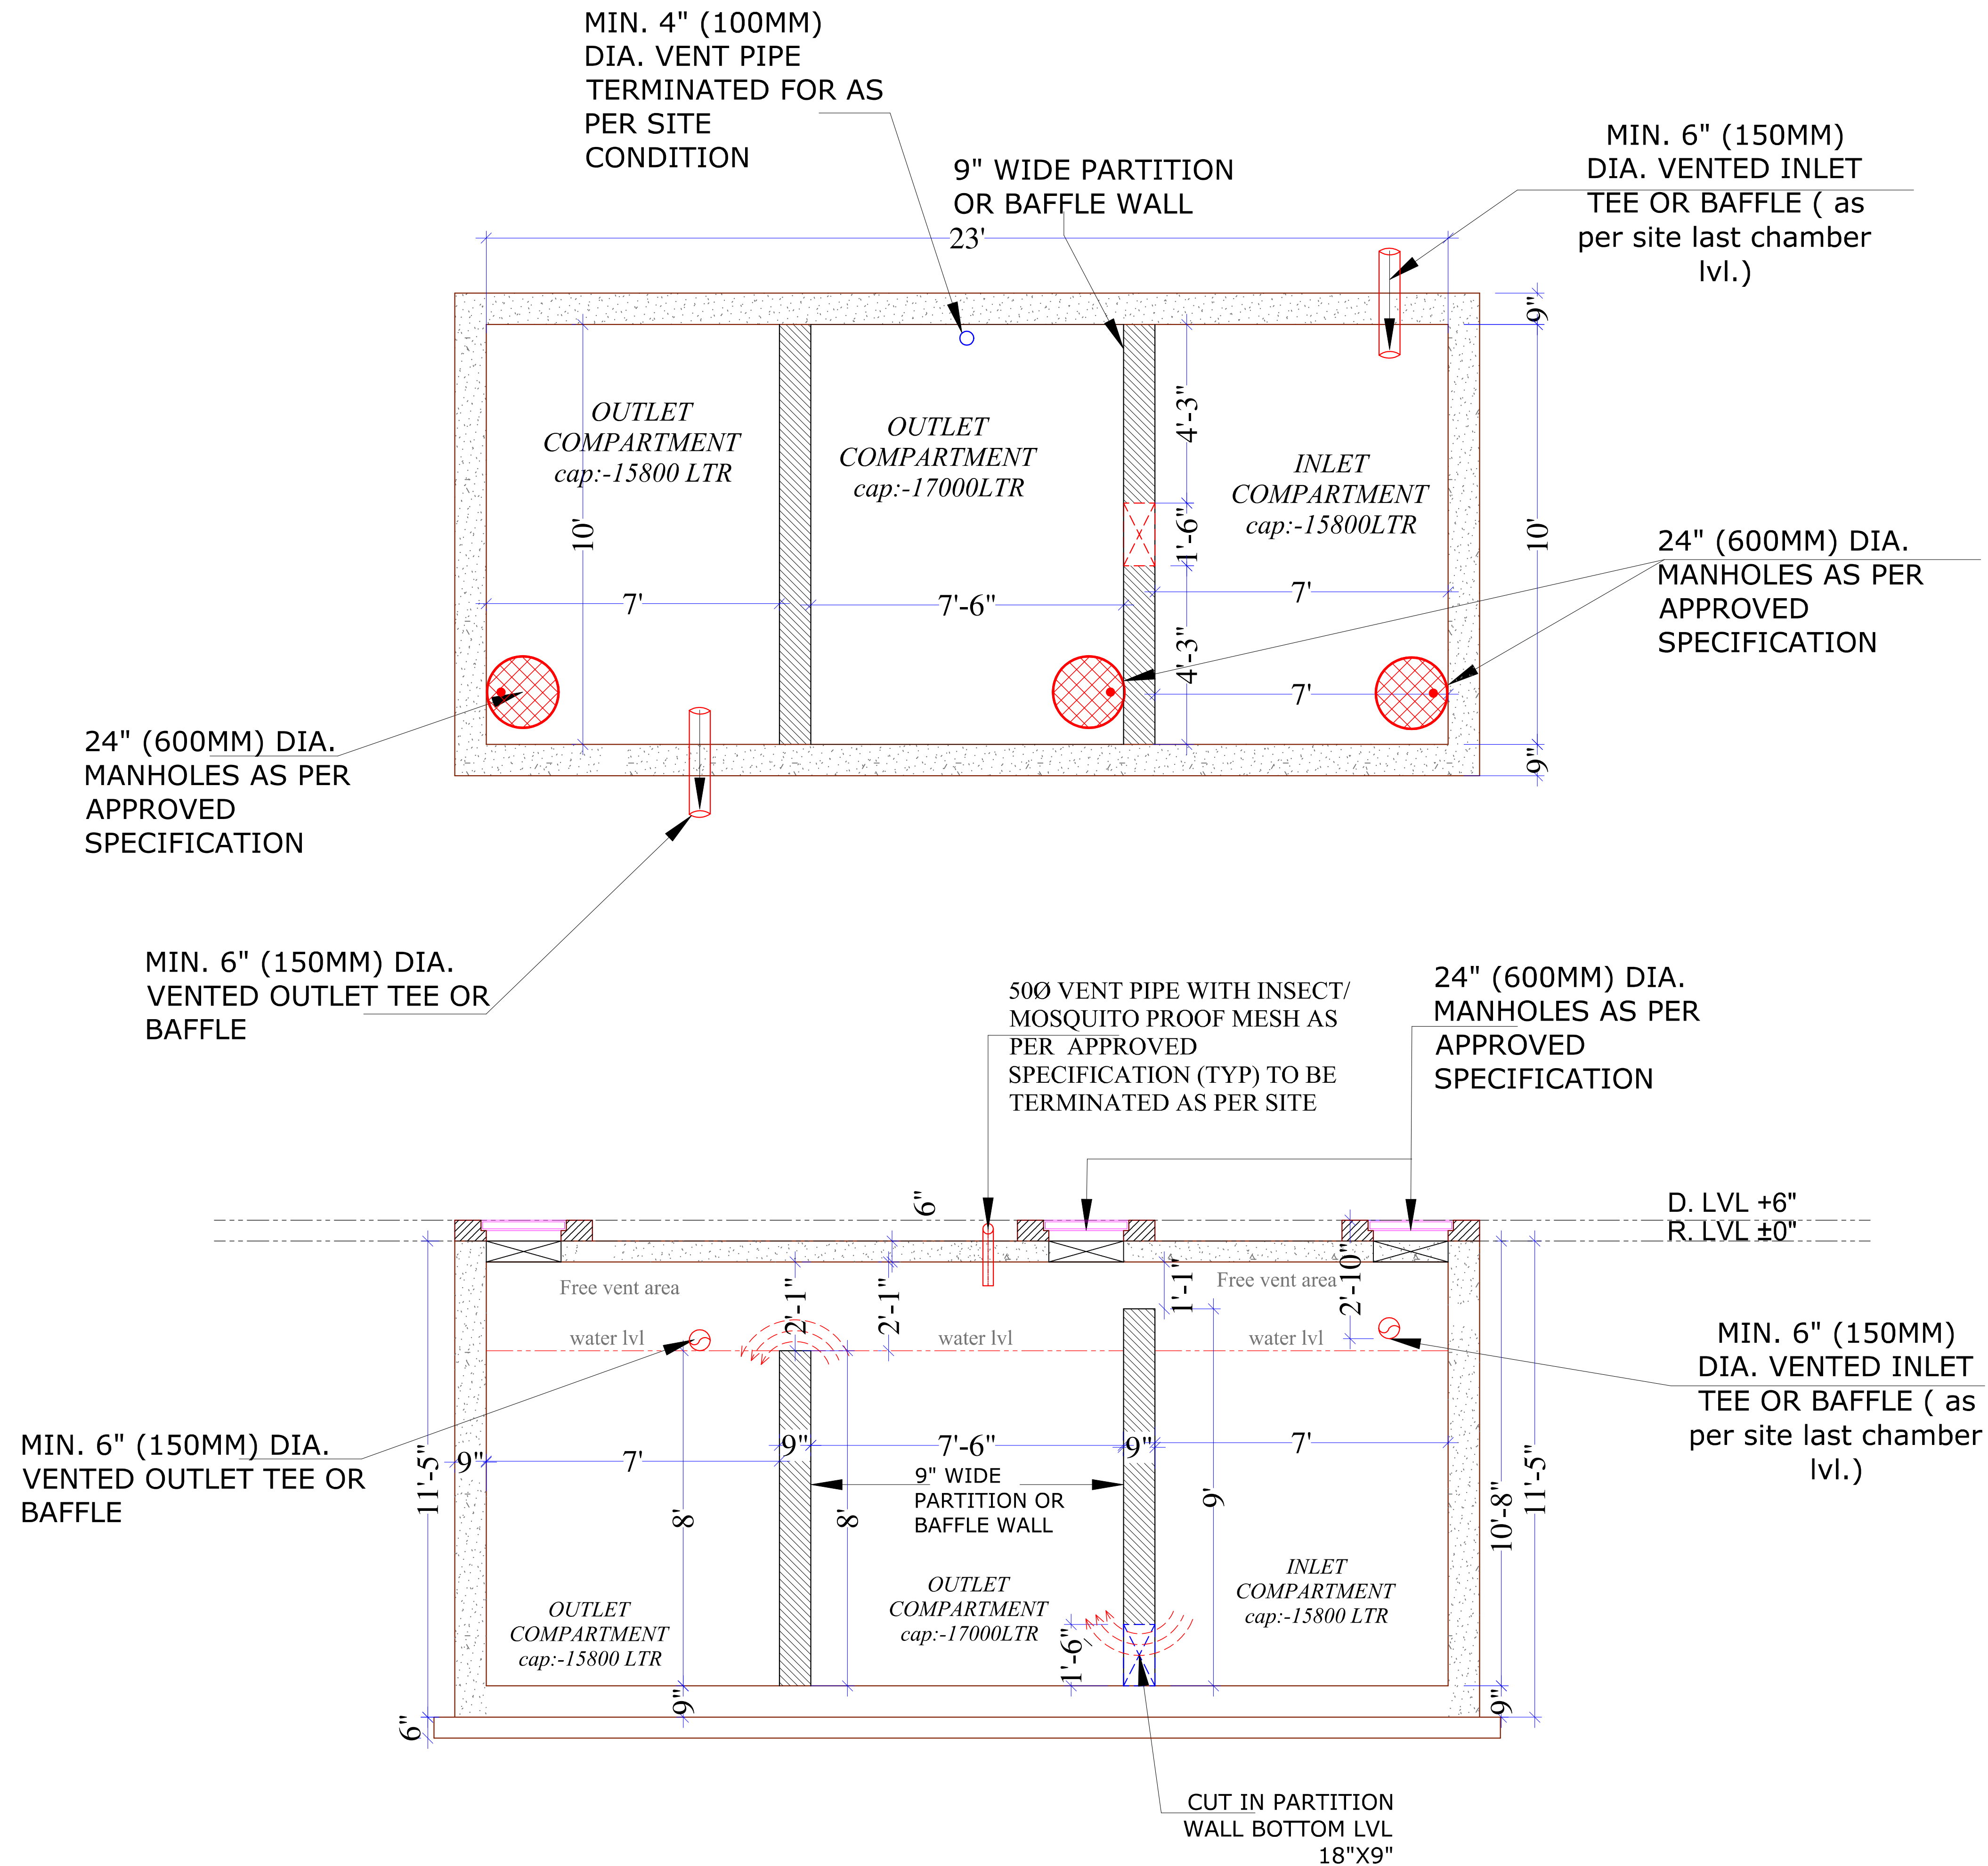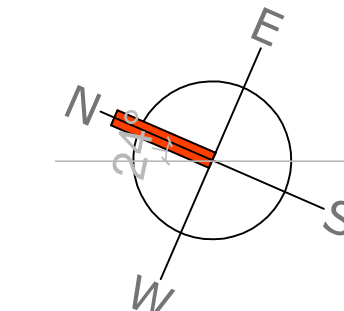

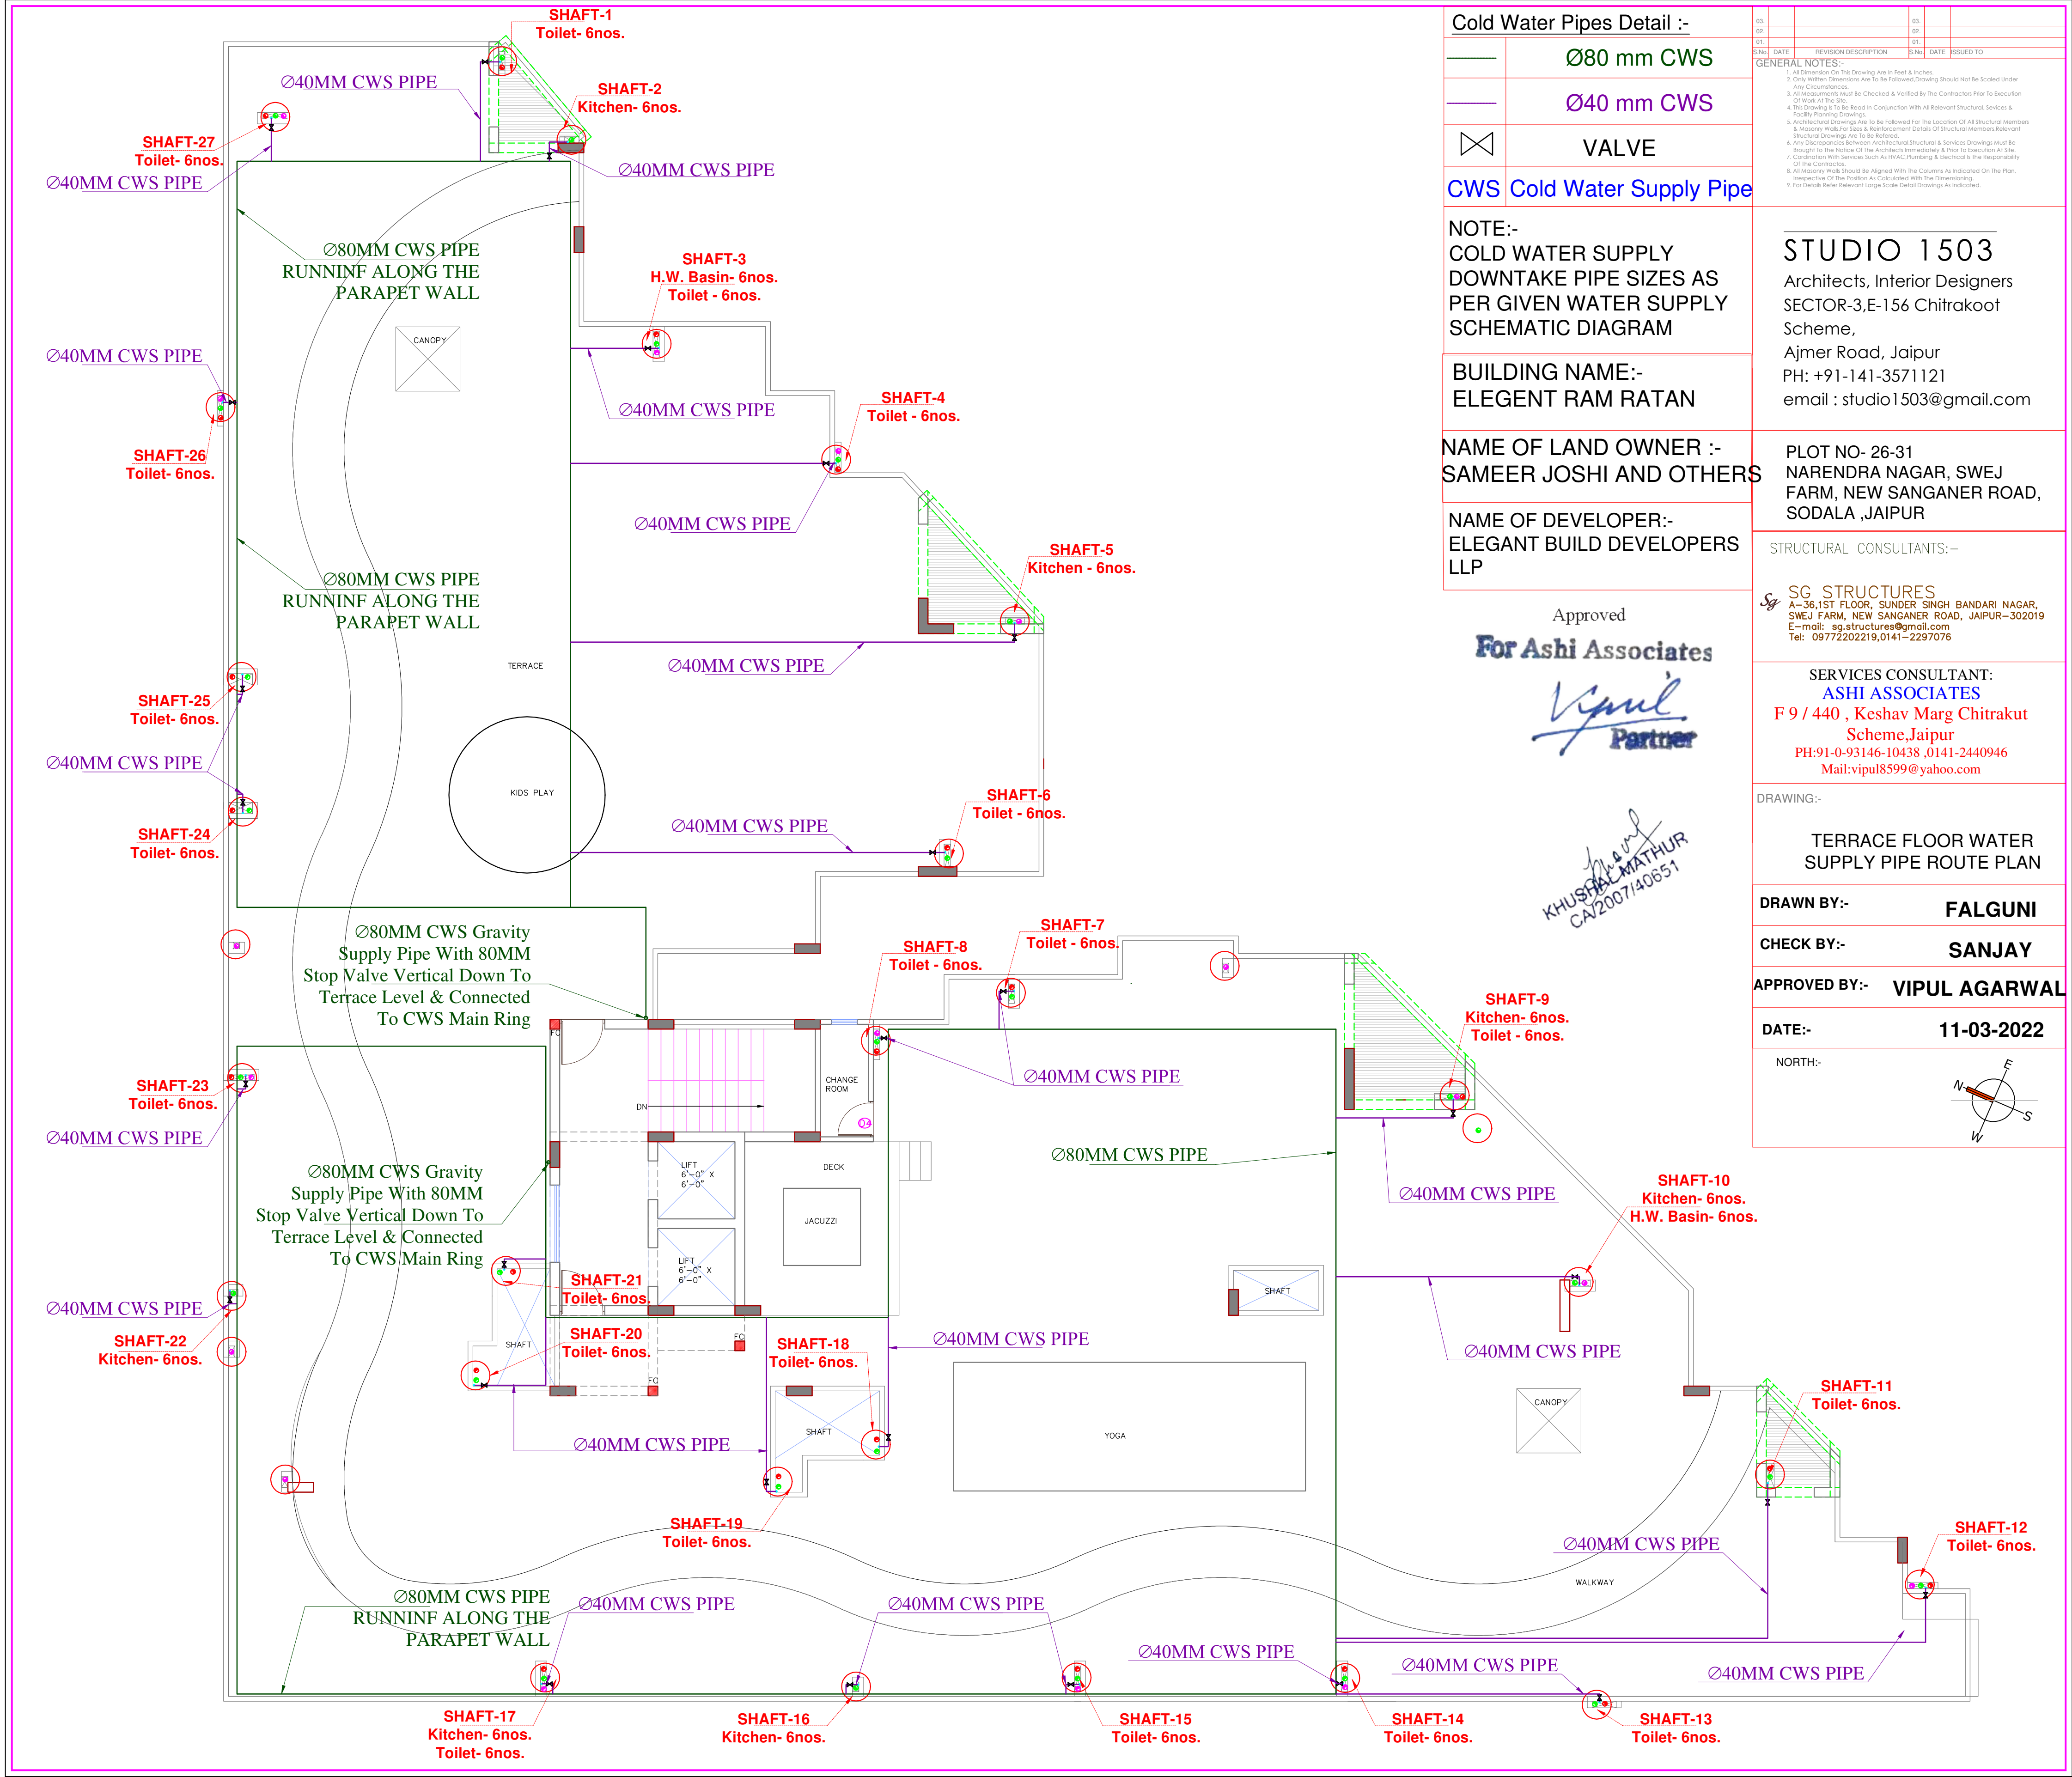

Cold Water Pipes Detail :-

	Ø80 mm CWS
	Ø40 mm CWS
	VALVE

CWS Cold Water Supply Pipe

NOTE:-
COLD WATER SUPPLY
DOWNTAKE PIPE SIZES AS
PER GIVEN WATER SUPPLY
SCHEMATIC DIAGRAM

BUILDING NAME:-
ELEGENT RAM RATAN


NAME OF LAND OWNER :-
SAMEER JOSHI AND OTHERS

NAME OF DEVELOPER:-
ELEGANT BUILD DEVELOPERS
LLP

Approved
For Ashi Associates

KHUSHAL MATHUR
CA2007140651

05	06	07	08
09	10	11	12
13	14	15	16
997	998	999	1000

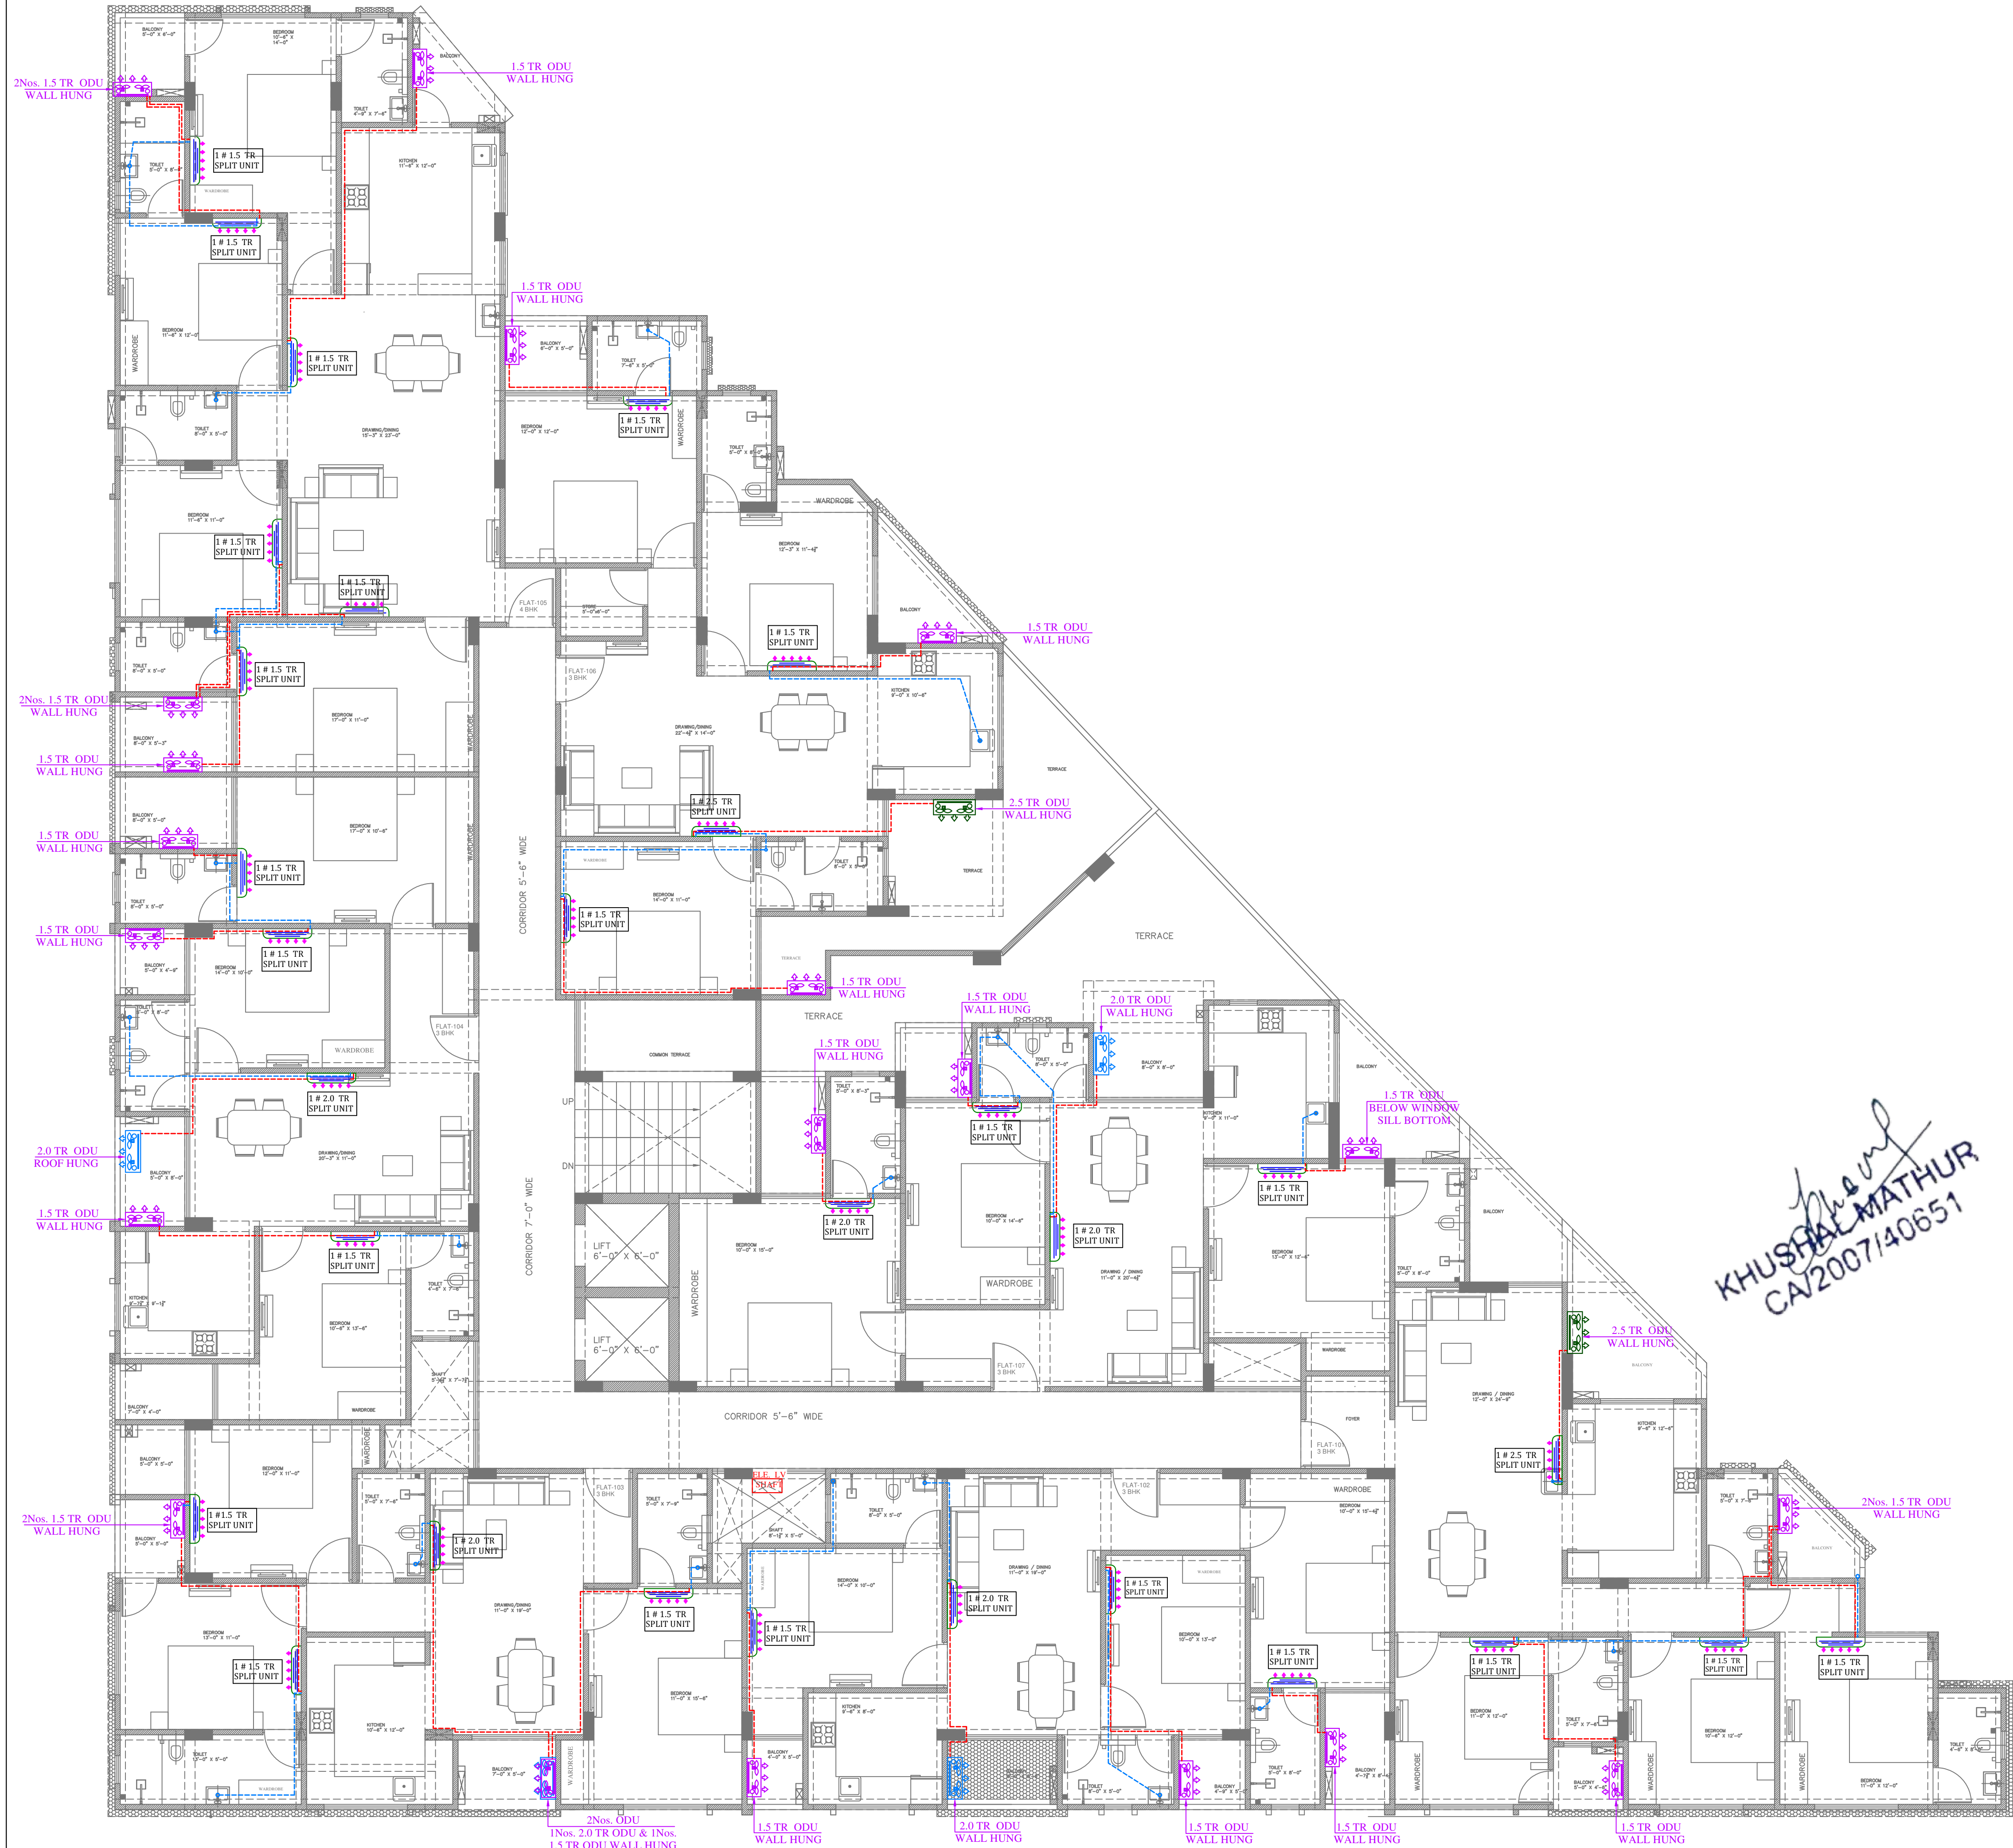

BUILDING NAME:-
ELEGENT RAM RATAN

NAME OF LAND OWNER :-
SAMEER JOSHI AND OTHERS

NAME OF DEVELOPER:-
ELEGANT BUILD DEVELOPERS LLP

Approved
For Ashi Associates
Vipul
Partner

LEGENDS:

QTY.No.	ID	Symbol	Description
02	SAC		2.5 TR SPLIT UNIT SIZE:-1050wX238dX290h(MM) AC Copper Pipe (Gas Pipe-Ø15.9mm & Liquid Pipe-Ø9.5mm)
02	ODU		2.5 TR. OUT DOOR UNIT SIZE:-900X320X770H(MM)
04	SAC		2.0 TR SPLIT UNIT SIZE:-1050wX238dX290h(MM) AC Copper Pipe (Gas Pipe-Ø15.9mm & Liquid Pipe-Ø9.5mm)
04	ODU		2.0 TR. OUT DOOR UNIT SIZE:-900X320X770H(MM)
24	SAC		1.5 TR SPLIT UNIT SIZE:-1050wX238dX290h(MM) AC Copper Pipe (Gas Pipe-Ø12.7mm & Liquid Pipe-Ø6.4mm)
24	ODU		1.5 TR. OUT DOOR UNIT SIZE:-825X300X735H(MM) AC Gas & Liquid Pipe Connected to Out Door Unit.
			AC Gas & Liquid Pipe Connected to Out Door Unit.
			Ø25 mm Pvc Pipe AC Drain in Nearest Floor Trap

STUDIO 1503

Architects, Interior Designers
SECTOR-3,E-156 Chitrakoot Scheme,
Ajmer Road, Jaipur
PH: +91-141-4971223
email : studio1503@gmail.com

STRUCTURAL CONSULTANTS:-

A-36,1ST FLOOR, SUNDER SINGH BANDARI NAGAR,
SWEJ FARM, NEW SANGANER ROAD, JAIPUR-302019
E-mail: sg_structures@gmail.com
Tel:- 09772202219,0141-2297076

PROJECT:-
PLOT NO- 26-31
NARENDRA NAGAR, SWEJ
FARM, NEW SANGANER
ROAD, SODALA ,JAIPUR

LAYOUT PLAN	DRAWING:-
DATE:- 18-01-2022	FIRST FLOOR HVAC LAYOUT
DRAWN:- PAWAN	
DETAIL:- SANJAY	REV:- DRAWING No.:-
APPD.:- VIPUL AGARWAL	R-0 MEP/SF/TY.FL/HVAC-01

