
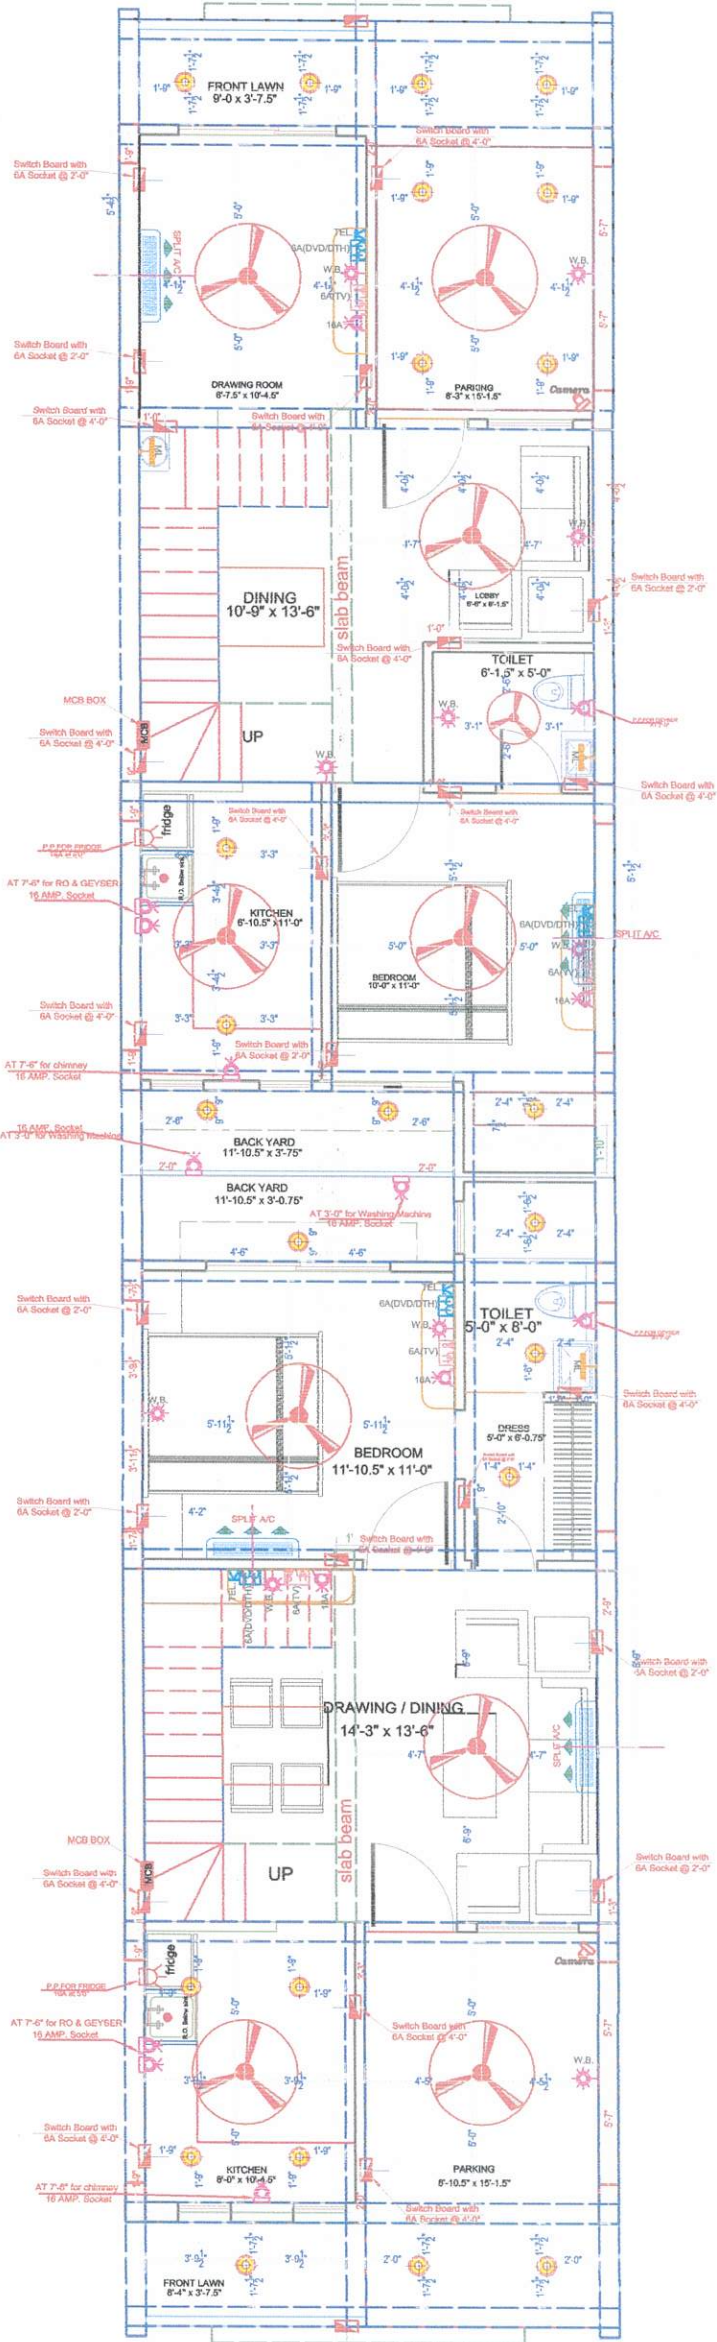
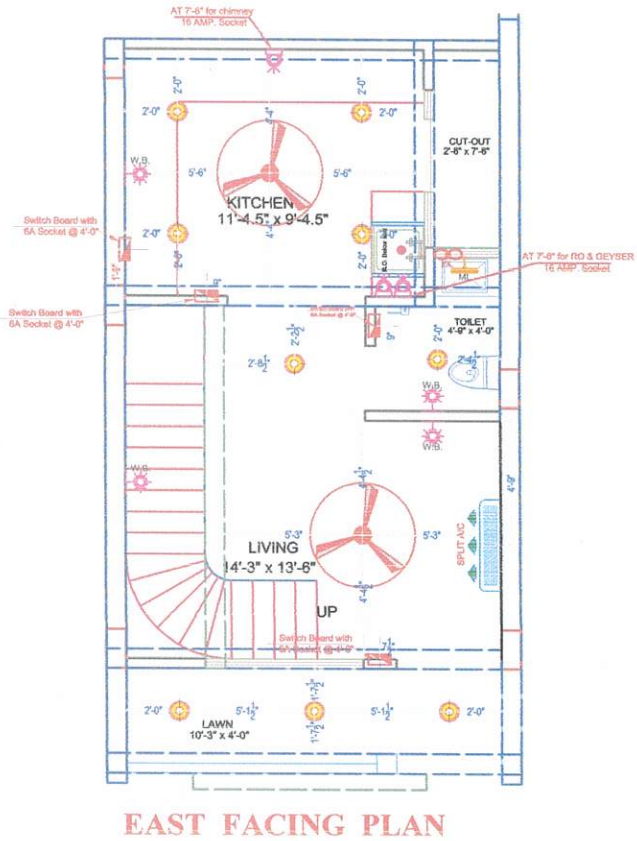



LEGEND	
NAME	SYMBOL
MIRROR LIGHT	
MCB	
WALL LIGHT	
BRACKET FAN	
CFL	
EXHAUST	
FAN	
CEILING LIGHT	
PLUG POINT	
PHONE	
POWER POINT	
SWITCH BOARD	
TELEVISION	
TUBE LIGHT	
TWO WAY	
FOOT LIGHT	
CHANDELIAR	
HALOGEN	
SPEAKER	
SPLIT A.C.	
FOOT LIGHT	
WALL FAN	
BELL POINT	
BUZZER BELL	
WALL MOUNTED CAMERA (CCTV)	
SPEAKER	
VEDIO DOOR PHONE	
TELEPHONE	

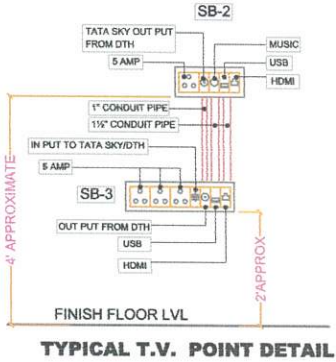

Er. PARNESHWAR
B.Tech. (Electrical)
M.Tech. (Power System)

GENERAL NOTES		PROJECT TITLE	CONSULTANT	SUBMITTED FOR :-		ARCHITECTS
1. ALL THE DIMENSIONS ON THE DRAWING ARE IN METERS. 2. ALL THE DIMENSIONS ARE TO BE FOR FINISHED WORK. 3. ALL THE DIMENSIONS ARE TO BE FOR FINISHED WORK. 4. THE DRAWING IS TO BE READ IN CONJUNCTION WITH ALL RELEVANT ELECTRICAL, MECHANICAL & PLUMBING DRAWINGS. 5. ANY DISCREPANCIES MUST BE BROUGHT TO THE NOTICE OF THE ENGINEER IMMEDIATELY & PRIOR TO EXECUTION OF THE WORK. 6. COORDINATION WITH SERVICES SUCH AS RAIL, PLUMBING & MECHANICAL, ETC. IS THE RESPONSIBILITY OF THE CONSULTANT. 7. THE DRAWING IS NOT TO BE USED FOR ANY OTHER PURPOSE WITHOUT THE WRITTEN PERMISSION OF THE CONSULTANT.		"RAVI KIRAN VIHAR" AT VILLAGE-MOHANPURA, TEH- SANGANER, JAIPUR UNDER KHASRA NO - 202, 203/577	AMP INFRA SERVICES VILLA NO 16, SHUBHASIS GEETA JAISINGHPURA, BHANKROTA & CHIMANPURA, JAIPUR 302026 EMAIL ID- ampinfrajpr@gmail.com	PRELIMINARY PROPOSAL DATE :- 08 DEC 2023 DRAWN :- SUFIAN KHAN APPROVED :- NARESH DRAWING NO. :- 00	APPROVAL GFC NORTH :- SCALE :- N.T.S.	AIM ENGINEERS & ARCHITECTS #105 FI. FL., SHIV GYAN AVENUE PLOT NO. -2 YUDHISHTER MARG, OPP. YOJNA BHAWAN, C- SCHEME JAIPUR.
DRAWING TITLE		TYPICAL GROUND FLOOR ELECTRICAL PLAN (EAST & WEST)				

AT VILLAGE-.MOHANPURA ,TEH.- SANGANER, JAIPUR
UNDER KHASRA NO - 202, 203/577
UNDER CMJAY PROVISIONAL -3C

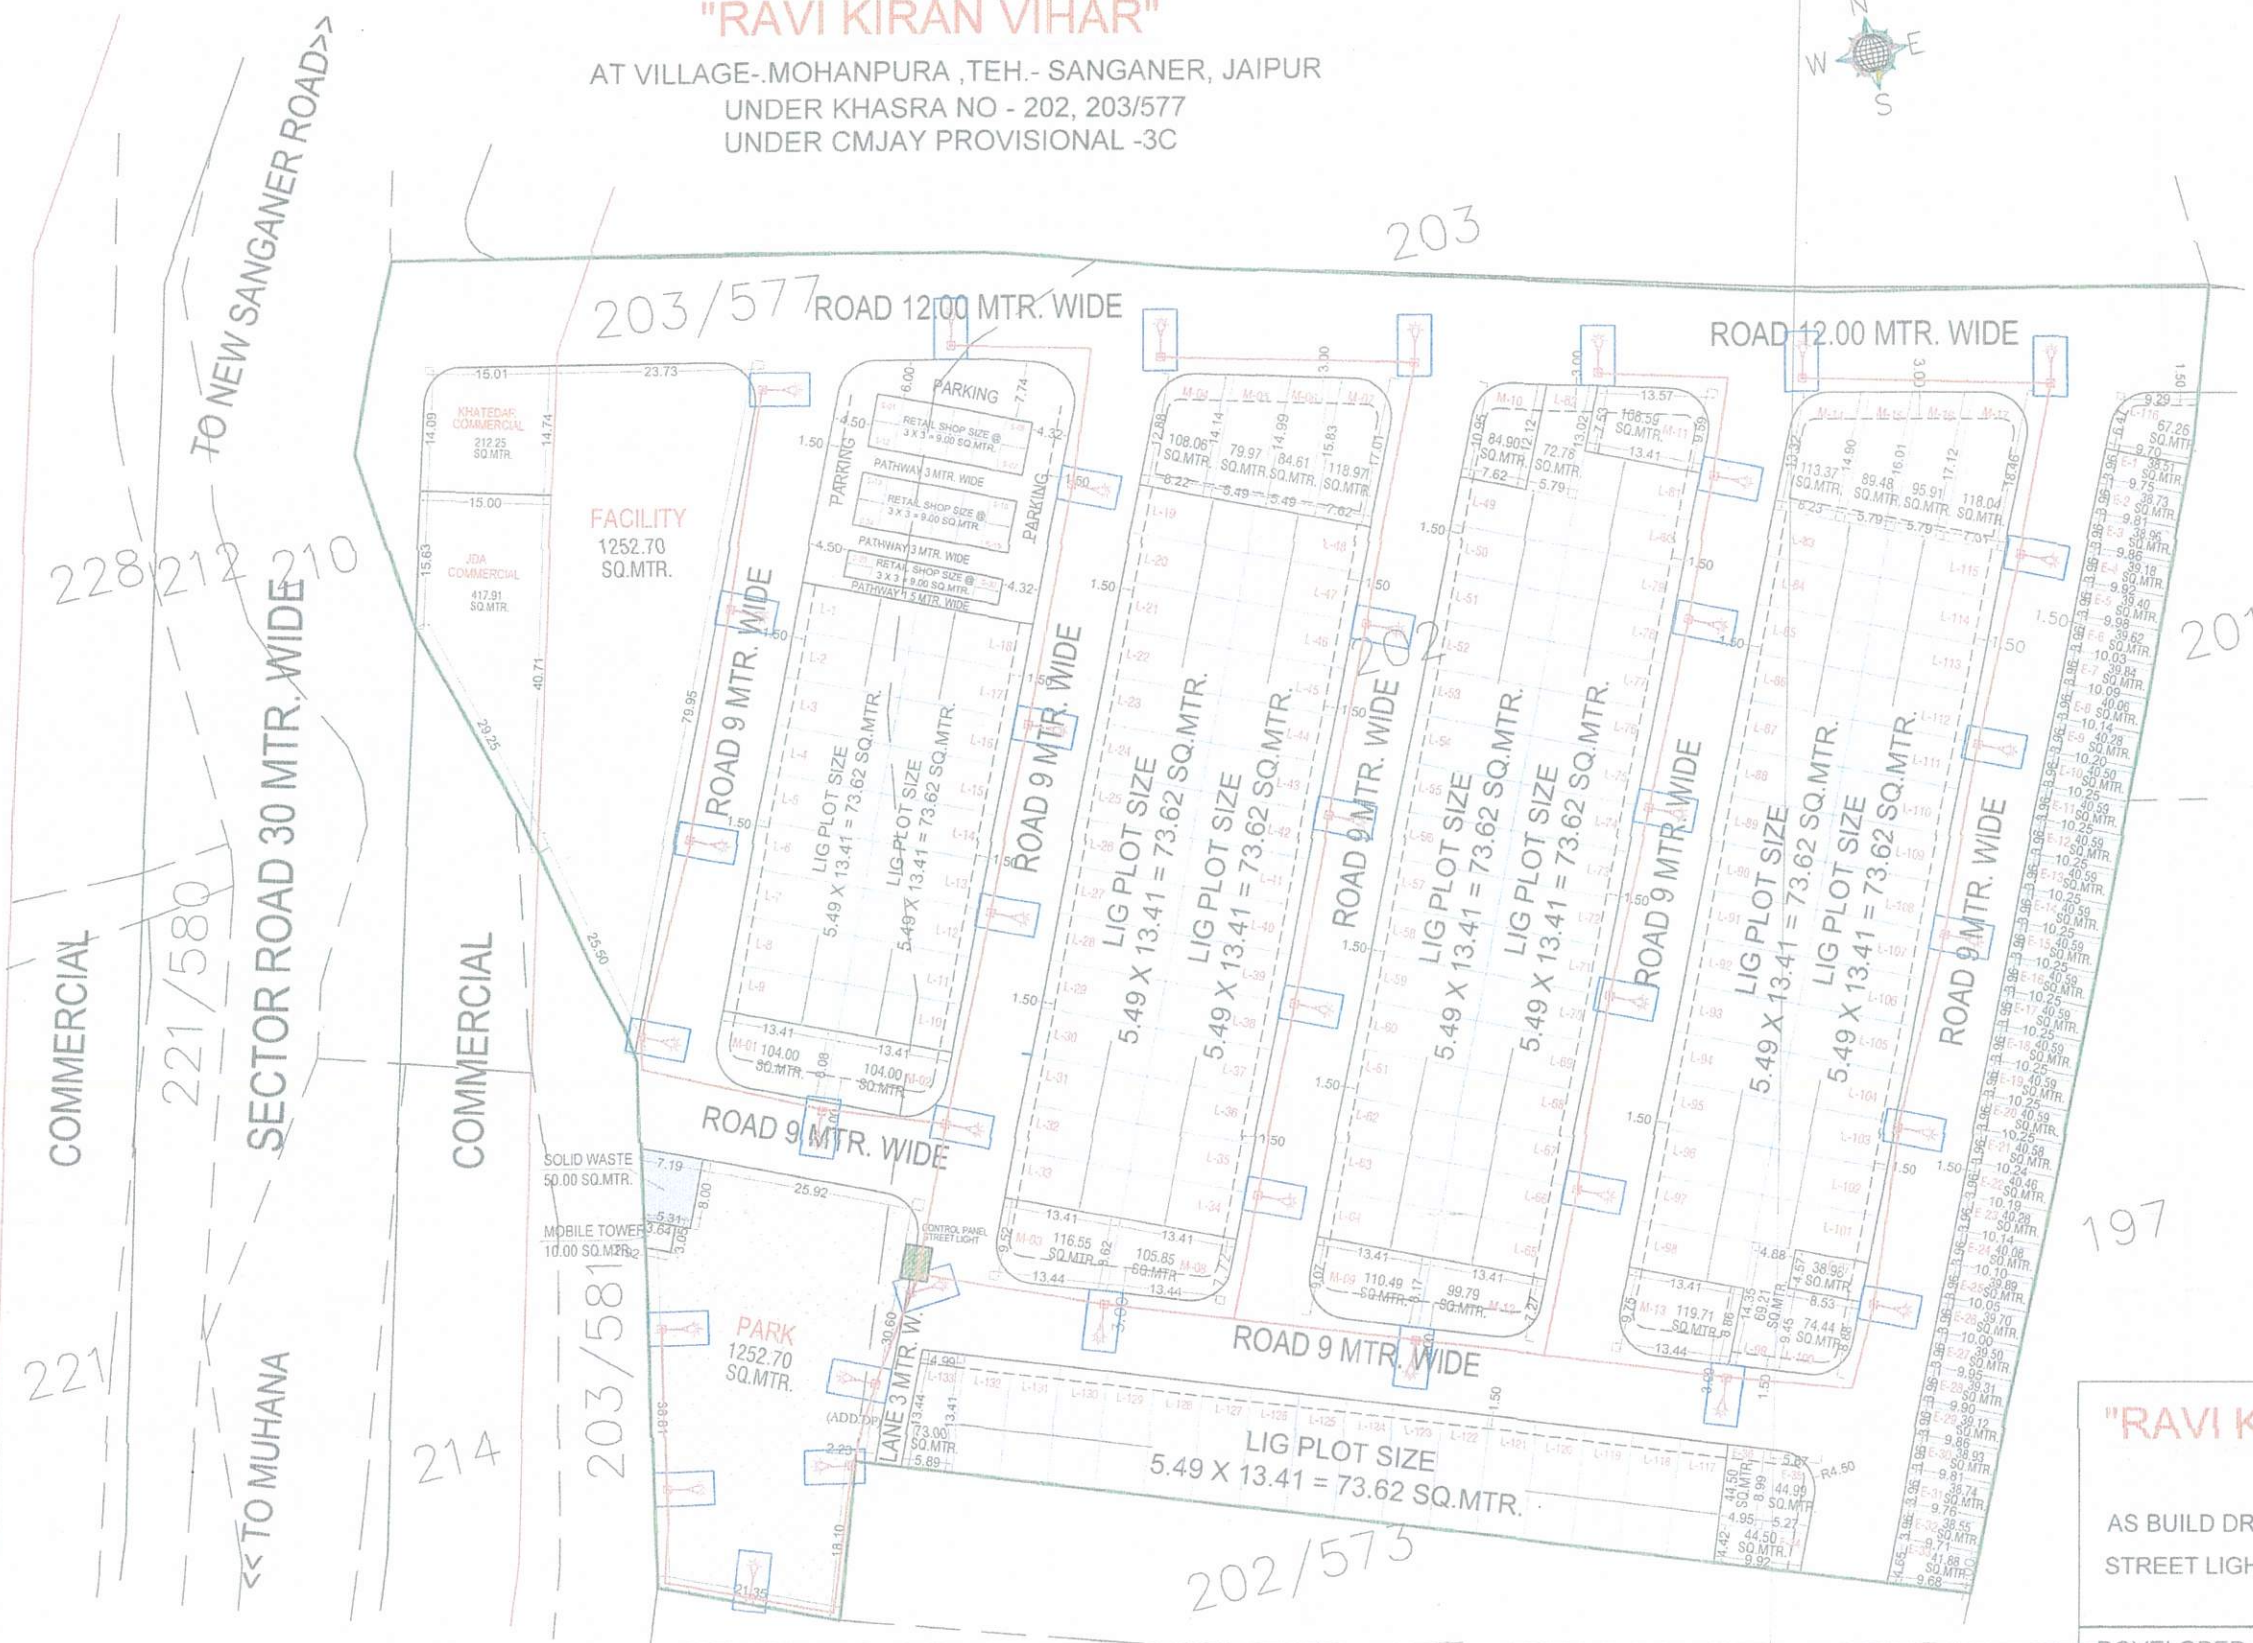

AS BUILD DRAWING OF :-
STREET LIGHT

DEVELOPED BY:-



RADHIKA ENGINEERS

Er. PARMESHWAR
B.Tech. (Electrical)
M.Tech. (Power System)

-  6 mtr Height Pole
 Street Light Panel
 Street Light Cable

"RAVI KIRAN VIHAR"

AT VILLAGE-MOHANPURA ,TEH.- SANGANER, JAIPUR
UNDER KHASRA NO - 202, 203/577
UNDER CMJAY PROVISIONAL -3C

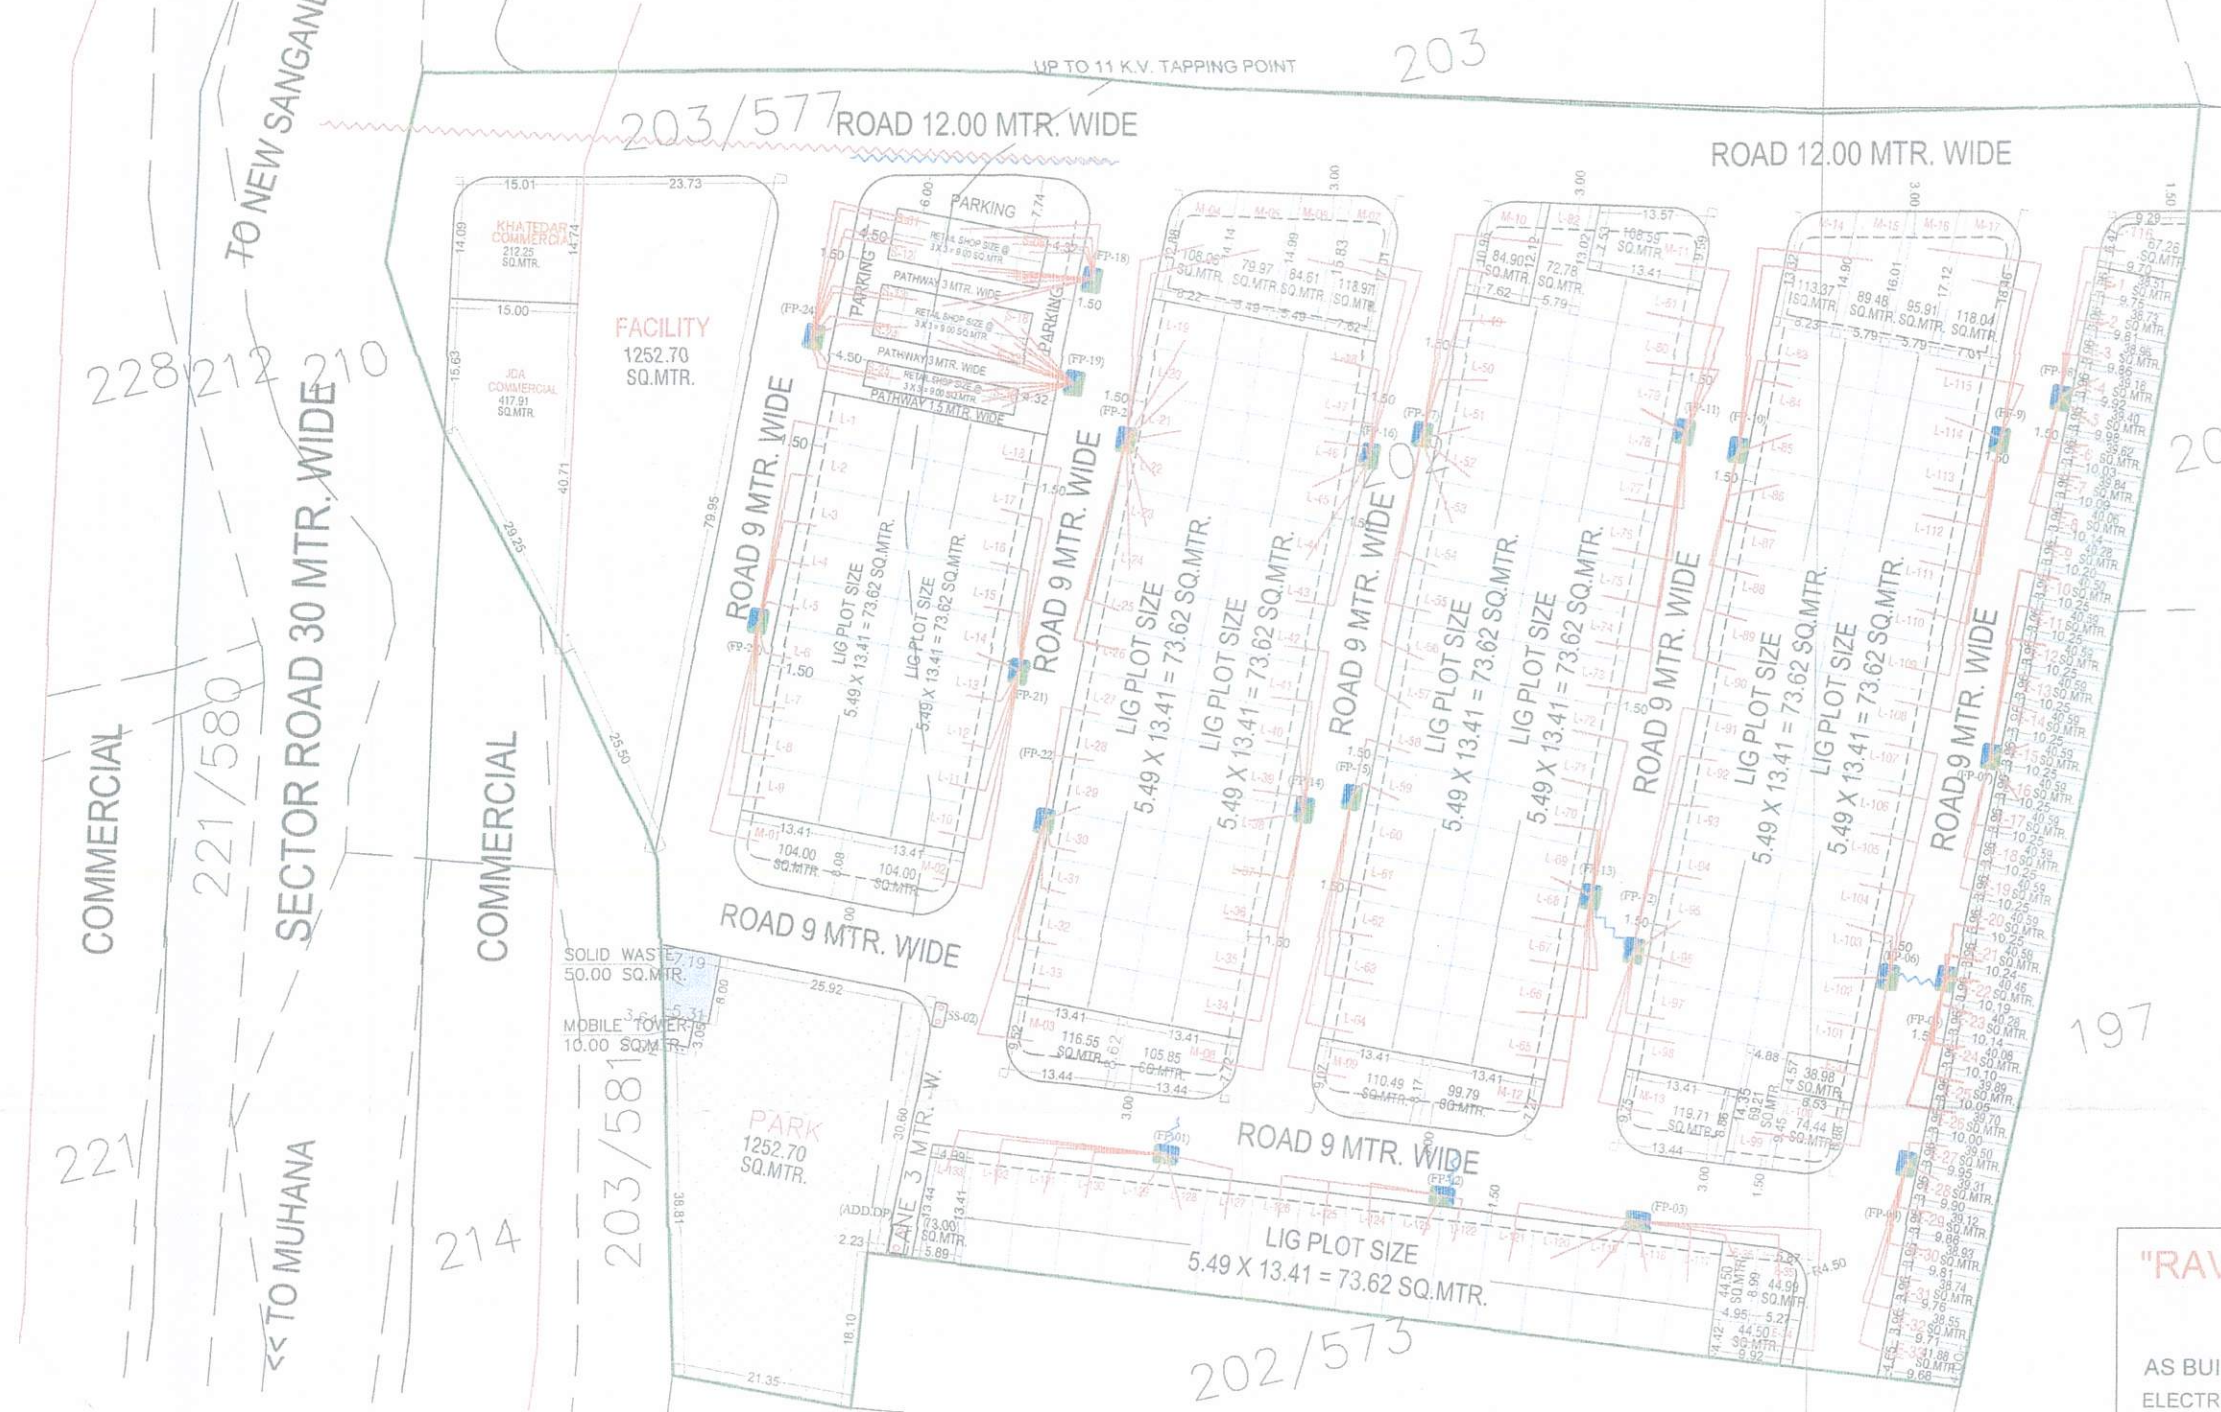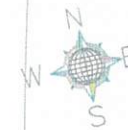

"RAVI KIRAN VIHAR"

AS BUILD DRAWING OF :-
ELECTRIC HOUSE CONNECTION

DEVELOPED BY :-

RADHIKA ENGINEERS



L.T. Feeder Pillars for
House Connection



HOUSE ELEC. CONNECTION CABLE

Er. PARMESHWAR
B.Tech. (Electrical)
M.Tech. (Power System)

For RADHIKA ENGINEERS

PARTNER