


40'-0" WIDE ROAD

144'-3"

65'

132'-9"

60'-0" WIDE ROAD

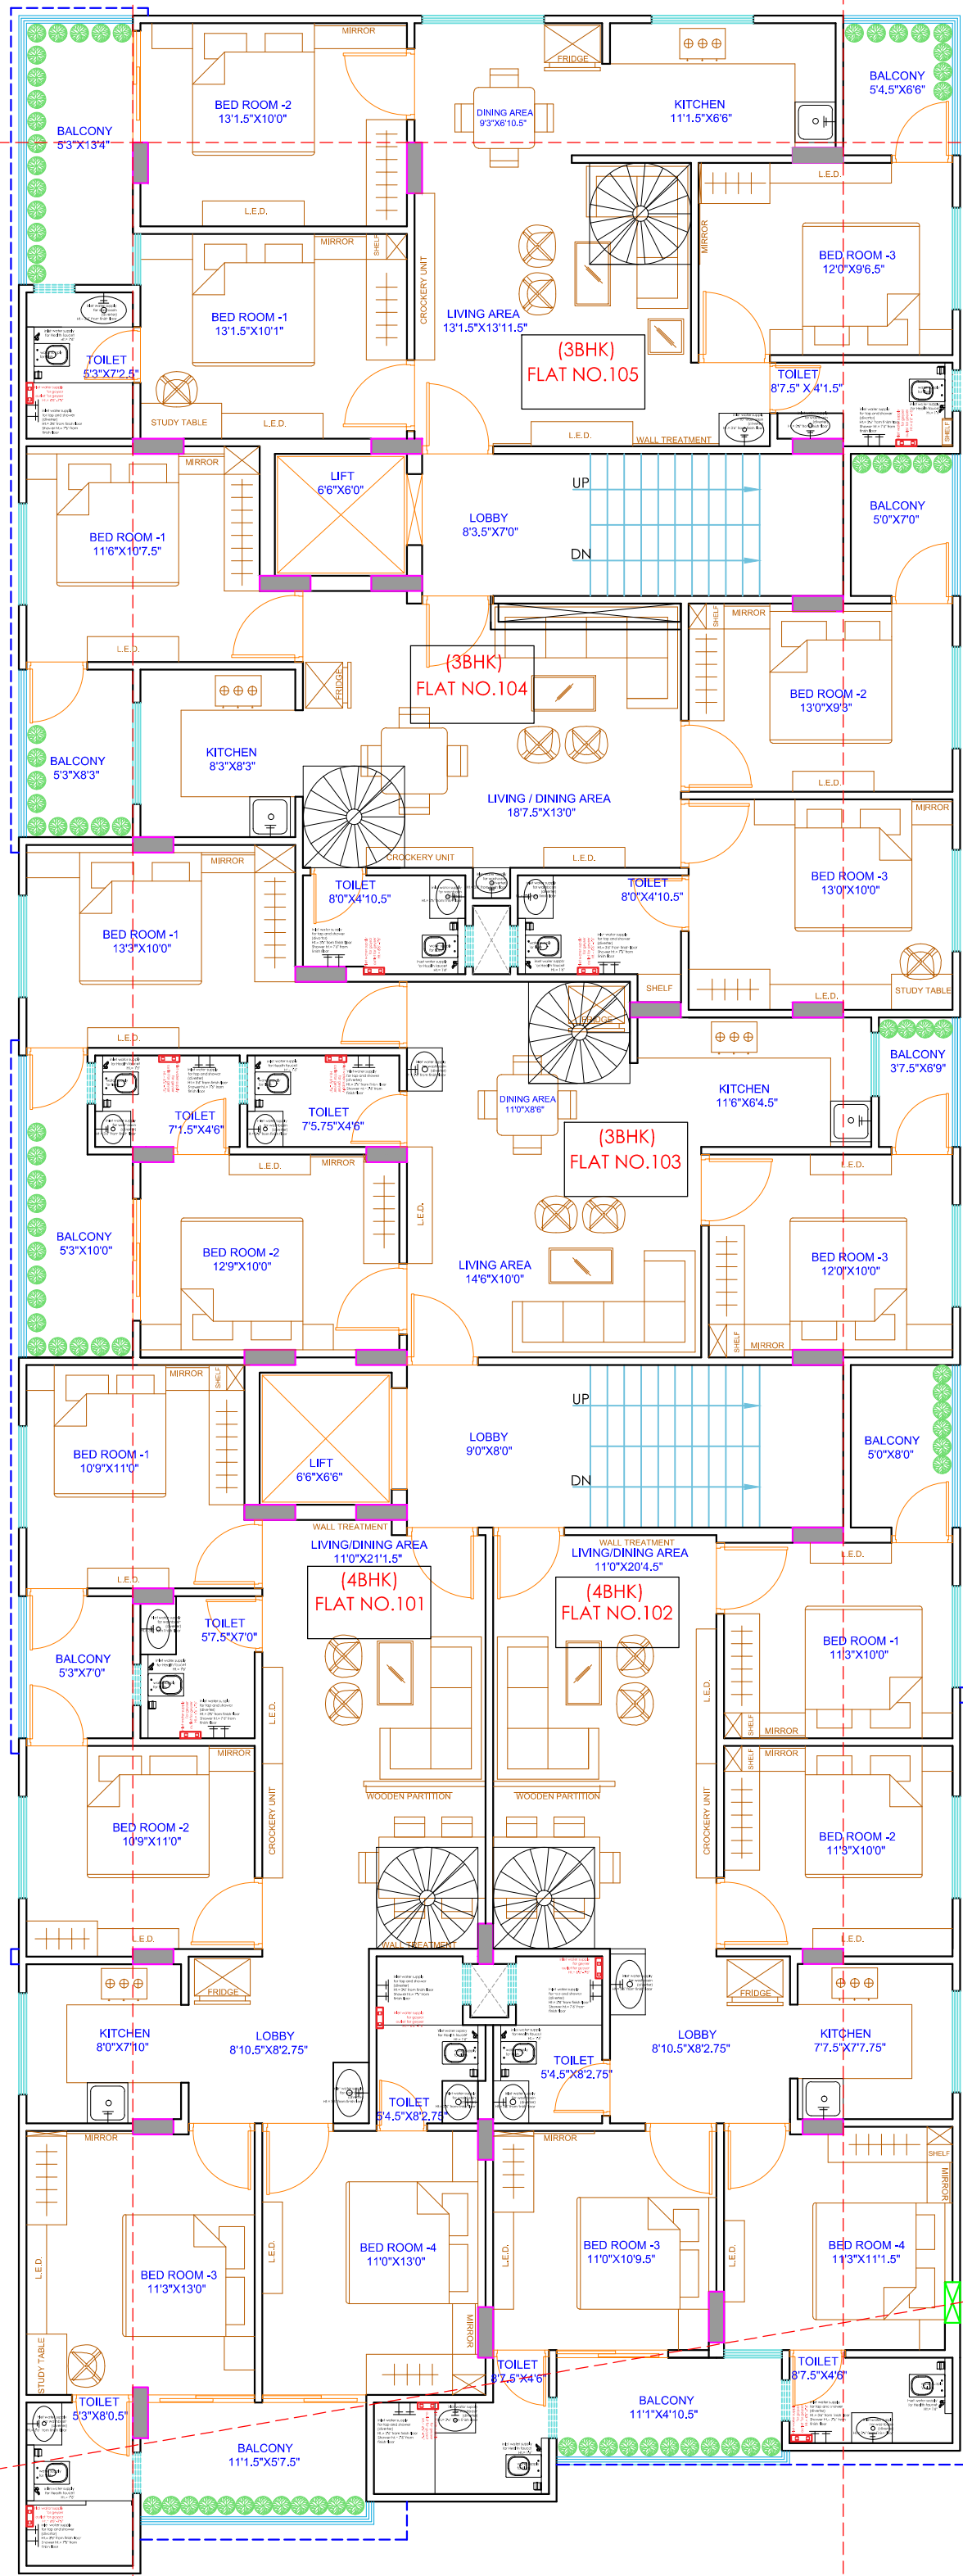

LEGENDS		
S.NO.	SYMBOL	DESCRIPTION
1.		SDR-11 Fresh Water Pipe
2.		SDR-11 Solar Water Pipe
3.		Waste Water Pipe (W.P.)
4.		Soil Pipe (S.P.)
5.		Rain Water Pipe (R.W.P.)
6.		Butter Fly Valve (B.F.V.)
7.		Geyser
8.		RO
9.		Single Lever Diverter
10.		Concealed Valve
11.		Angle Valve
12.		Nahani Trap
13.		P-Trap
14.		Tap
15.		Floor Drain (F.D.)
16.		Plain Tee (P-tee)
17.		Gully Trap (G.T.)
18.		

WARNING

1. This drawing is the sole copyright of Architects **VISTAAR** and should be used for the purpose expressly issued.

GENERAL NOTES

1. All dimensions are in feet and inches.
2. Do not scale this drawing follow written dimensions only.
3. This drawing should be read in conjunction with other architectural and structural drawings.
4. Any discrepancy in the drawing should be immediately brought to the notice of architect.

PROJECT TITLE

CITY PALM
BUILDING AT PLOT-E-84,JAGDAMBA
NAGAR-E,JAIPUR

DRAWING TITLE

5TH FLOOR PLUMBING PLAN

ARCHITECTS :

VISTAAR ARCHITECTS & PLANNERS
Architects :: Interior Designers
B-2/12, Chitrkoot scheme,
main Gandhi Path,Opp mall of jaipur,Jaipur
PH.- 0141-4116461,09001010366

PATH :-

DRN.

DATE

REV.

NORTH

SCALE

JOB NO.

N.T.S


For R K Builders & Developers
21/9/21
Proprietor

Krishna
KRISHNA KUMAR
B. Tech. (Mechanical)
M.E.P Consultant



40'-0" WIDE ROAD

144'-3"

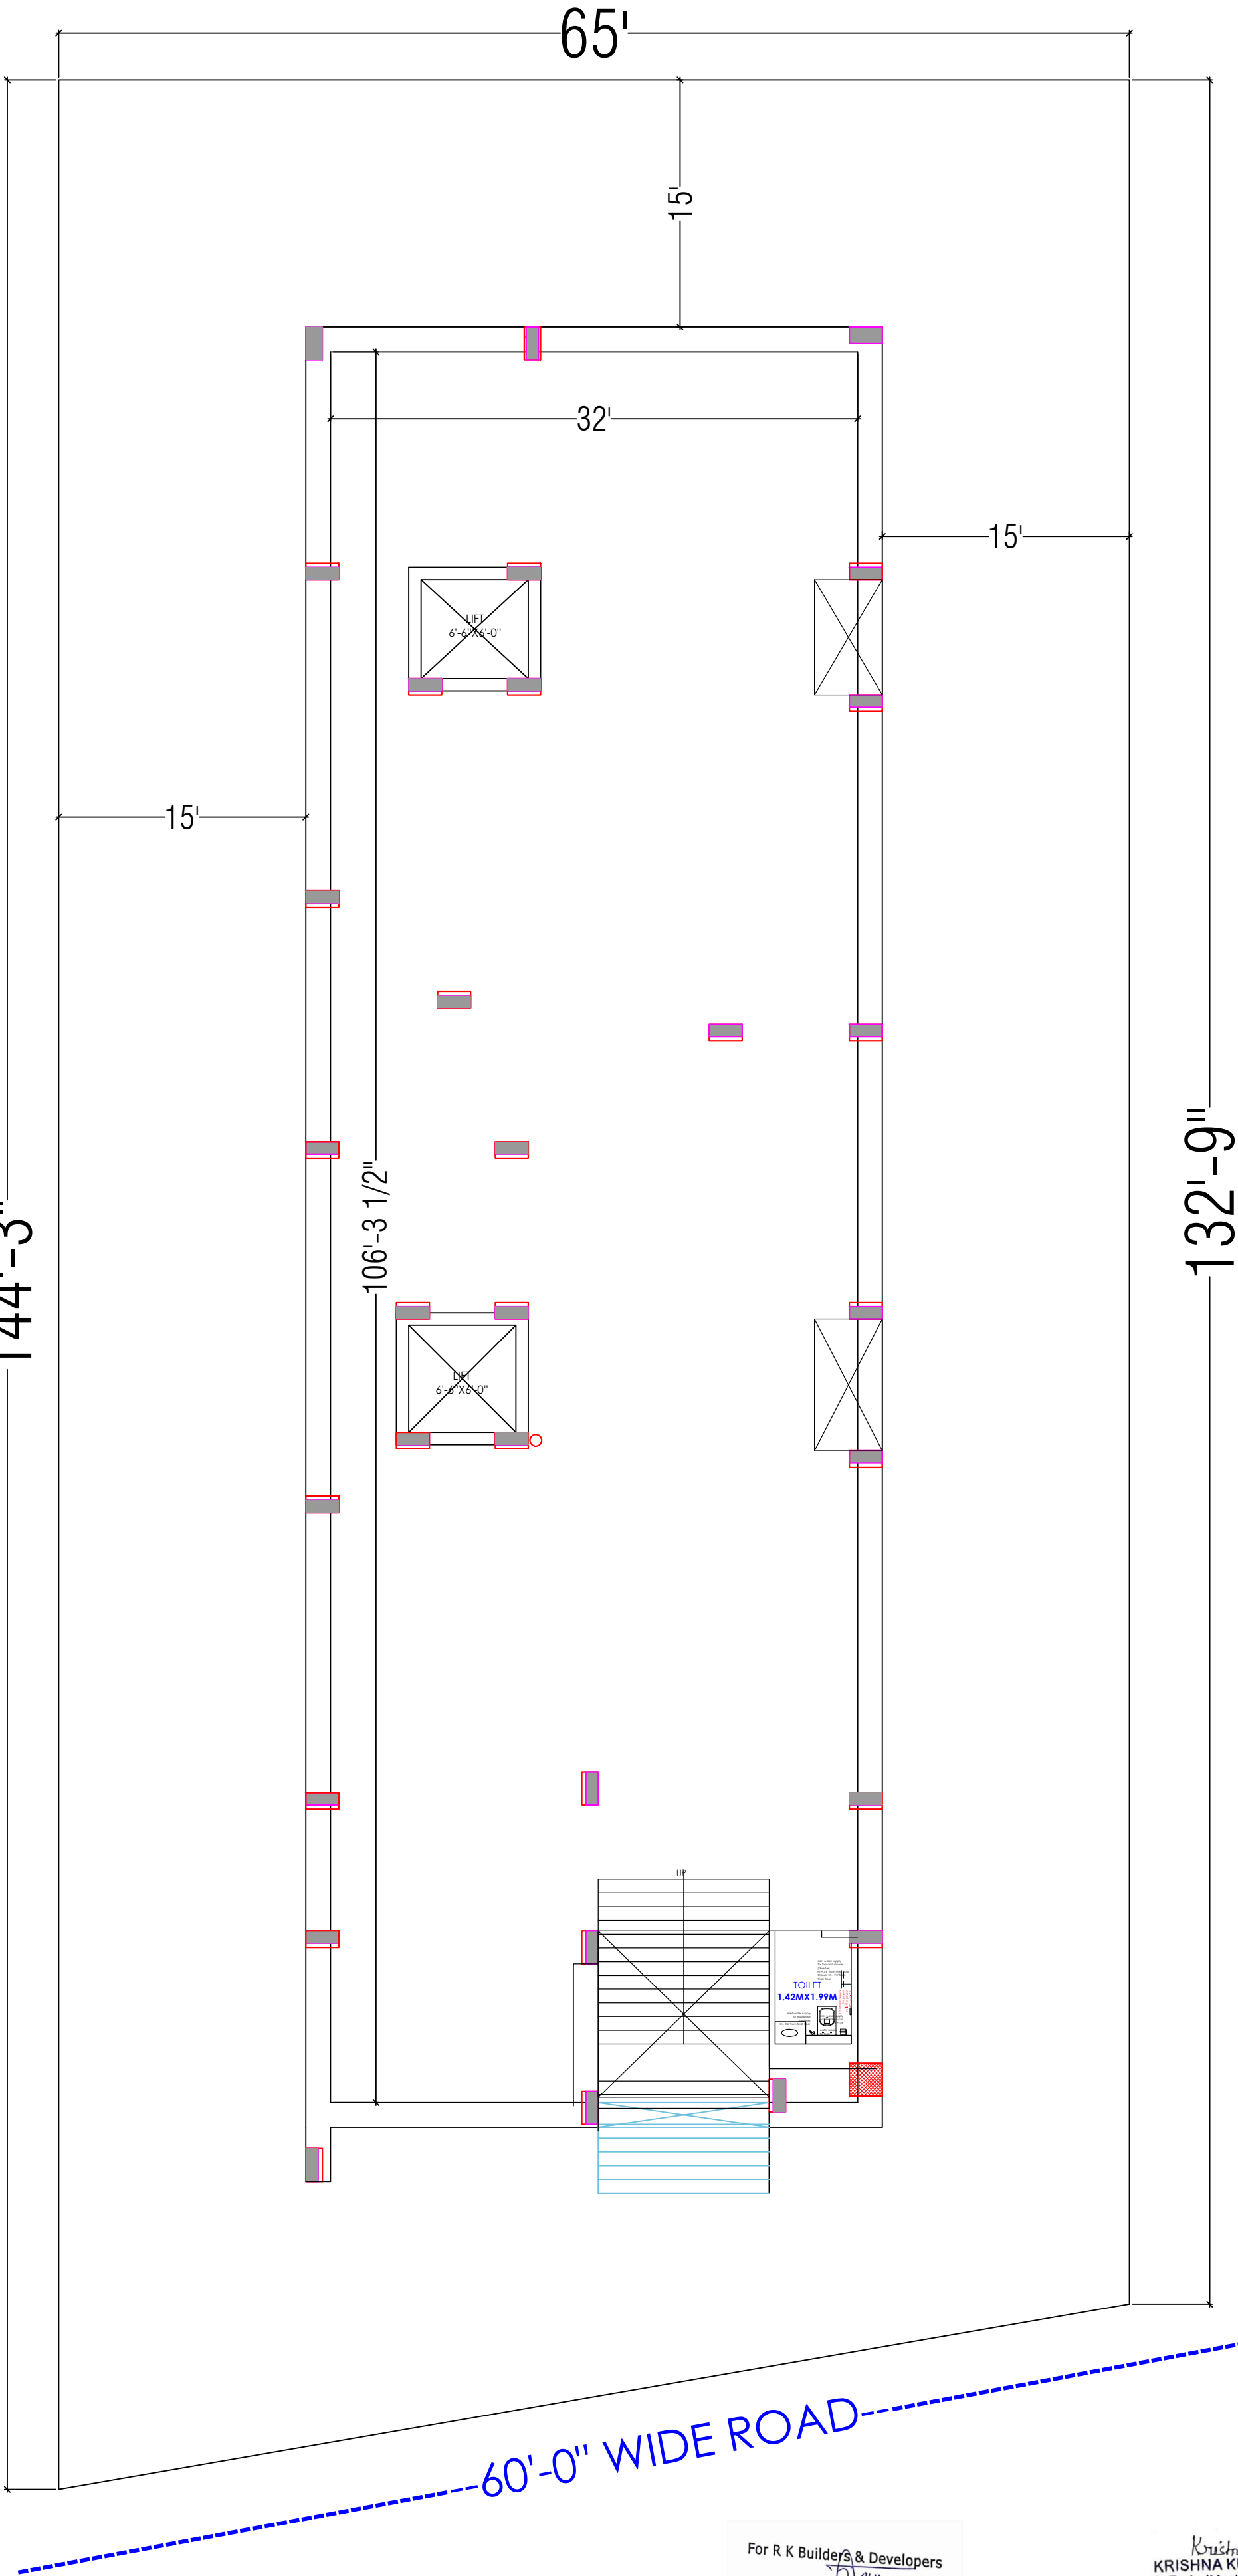

60'-0" WIDE ROAD

For R K Builders & Developers
B. Tech. (Mechanical)
M.E.P Consultant
Proprietor

Krishna
KRISHNA KUMAR
B. Tech. (Mechanical)
M.E.P Consultant

WARNING

1. This drawing is the sole copyright of Architects **VISTAAR** and should be used for the purpose expressly issued.

GENERAL NOTES

- 1. All dimensions are in feet and inches.
- 2. Do not scale this drawing follow written dimensions only.
- 3. This drawing should be read in conjunction with other architectural and structural drawings.
- 4. Any discrepancy in the drawing should be immediately brought to the notice of architect.

PROJECT TITLE


CITY PALM
BUILDING AT PLOT-E-84,JAGDAMBA
NAGAR-E,JAIPUR

DRAWING TITLE

BASEMENT FLOOR PLUMBING PLAN

ARCHITECTS :

VISTAAR ARCHITECTS & PLANNERS
Architects :: Interior Designers
B-2/12, Chitrkoot scheme,
main Gandhi Path,Opp mall of jaipur,Jaipur
PH. - 0141-4116461,09001010366

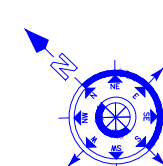PATH :-			
DRN.	DATE	REV.	NORTH
MANOJ KUMAWAT	23-06-2023		
SCALE	JOB NO.		
N.T.S			


40'-0" WIDE ROAD

144'-3"

65'

132'-9"

60'-0" WIDE ROAD

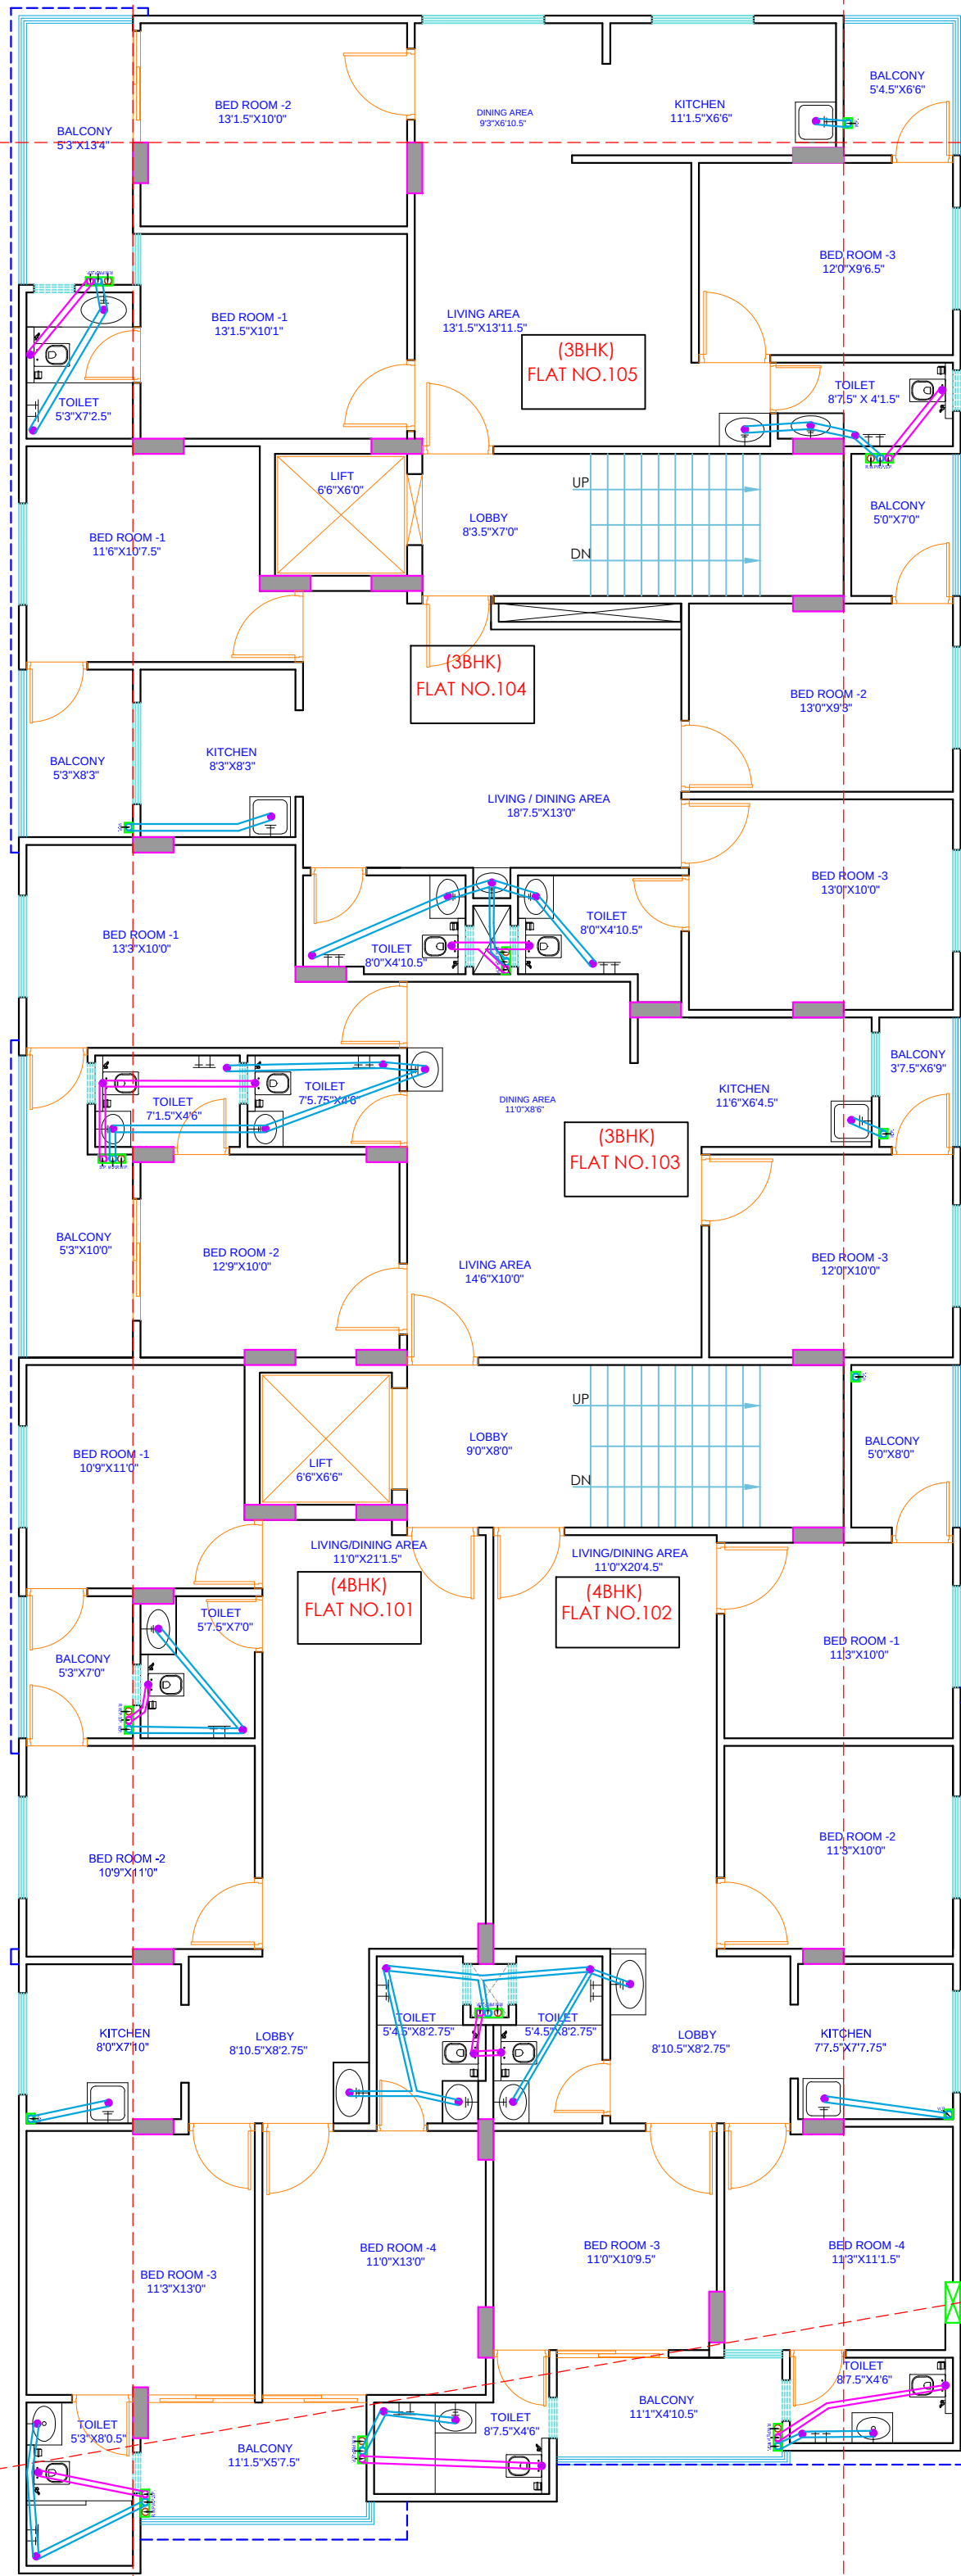

For R K Builders & Developers
Proprietor

Krishna
KRISHNA KUMAR
B. Tech. (Mechanical)
M.E.P Consultant

LEGENDS		
S.NO.	SYMBOL	DESCRIPTION
1.		SDR-11 Fresh Water Pipe
2.		SDR-11 Solar Water Pipe
3.		Waste Water Pipe (W.P.)
4.		Soil Pipe (S.P.)
5.		Rain Water Pipe (R.W.P.)
6.		Butter Fly Valve (B.F.V.)
7.		Geyser
8.		RO
9.		Single Lever Diverter
10.		Concealed Valve
11.		Angle Valve
12.		Nahani Trap
13.		P-Trap
14.		Tap
15.		Floor Drain (F.D.)
16.		Plain Tee (P-tee)
17.		Gully Trap (G.T.)
18.		

WARNING

1. This drawing is the sole copyright of Architects **VISTAAR** and should be used for the purpose expressly issued.

GENERAL NOTES

- All dimensions are in feet and inches.
- Do not scale this drawing follow written dimensions only.
- This drawing should be read in conjunction with other architectural and structural drawings.
- Any discrepancy in the drawing should be immediately brought to the notice of architect.

PROJECT TITLE

CITY PALM
BUILDING AT PLOT-E-84,JAGDAMBA
NAGAR-E,JAIPUR

DRAWING TITLE

GROUND TO 4TH FLOOR DRAINAGE PLAN

ARCHITECTS :

VISTAAR ARCHITECTS & PLANNERS

Architects :: Interior Designers
B-2/12, Chitrkoot scheme,
main Gandhi Path, Opp mall of jaipur,Jaipur
PH. - 0141-4116461,09001010366

PATH :-

DRN.

DATE


REV.

NORTH


SCALE

JOB NO.

N.T.S

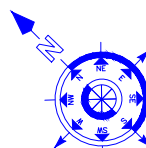

40'-0" WIDE ROAD

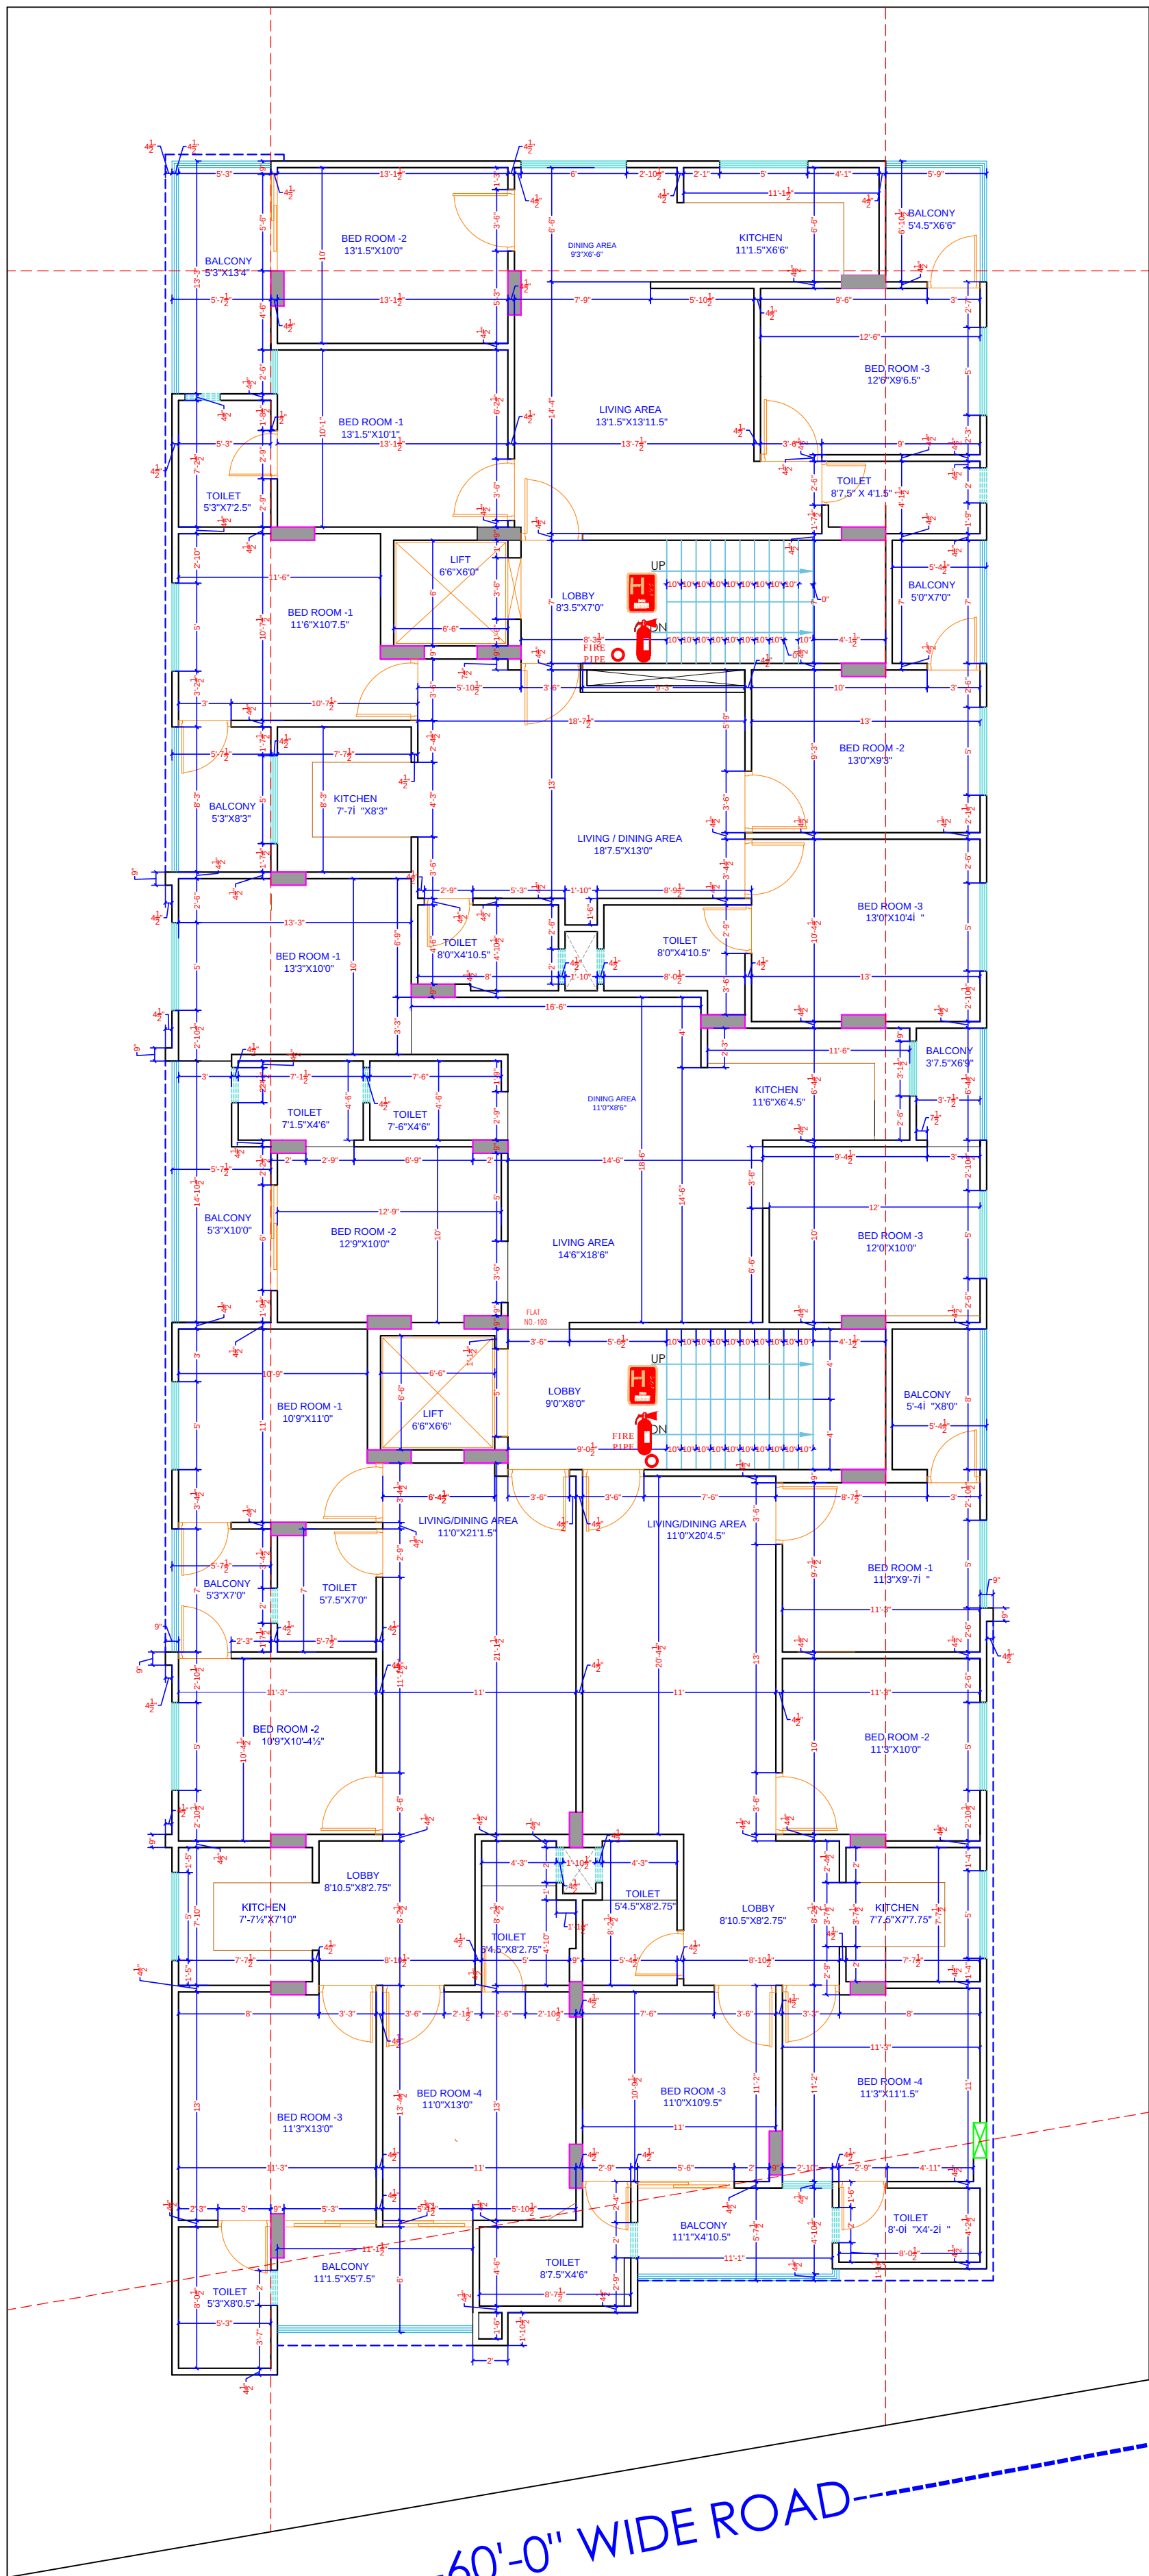

60'-0" WIDE ROAD

For R K Builders & Developers
Proprietor

Krishna
KRISHNA KUMAR
B. Tech. (Mechanical)
M.E.P Consultant

LEGEND



EMERGENCY ASSEMBLY POINT



FIRE POINT



FIRE HYDRANT



EMERGENCY CONTROL ROOM



HOSE REEL

WARNING

1. This drawing is the sole copyright of Architects **VISTAAR** and should be used for the purpose expressly issued.

GENERAL NOTES

1. All dimensions are in feet and inches.
2. Do not scale this drawing follow written dimensions only.
3. This drawing should be read in conjunction with other architectural and structural drawings.
4. Any discrepancy in the drawing should be immediately brought to the notice of architect.

PROJECT TITLE

CITY PALM
BUILDING AT PLOT-E-84,JAGDAMBA
NAGAR-E,JAIPUR

DRAWING TITLE

GROUND TO 4TH FLOOR FIRE FIGHTER PLAN

ARCHITECTS :

VISTAAR ARCHITECTS & PLANNERS

Architects :: Interior Designers
B-2/12, Chitrkoot scheme,
main Gandhi Path,Opp mall of jaipur,Jaipur
PH.- 0141-4116461,09001010366

PATH :-

DRN.

DATE


REV.

NORTH

SCALE

JOB NO.

N.T.S

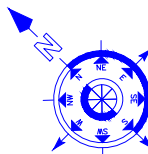


40'-0" WIDE ROAD

144'-3"

65'

132'-9"

60'-0" WIDE ROAD

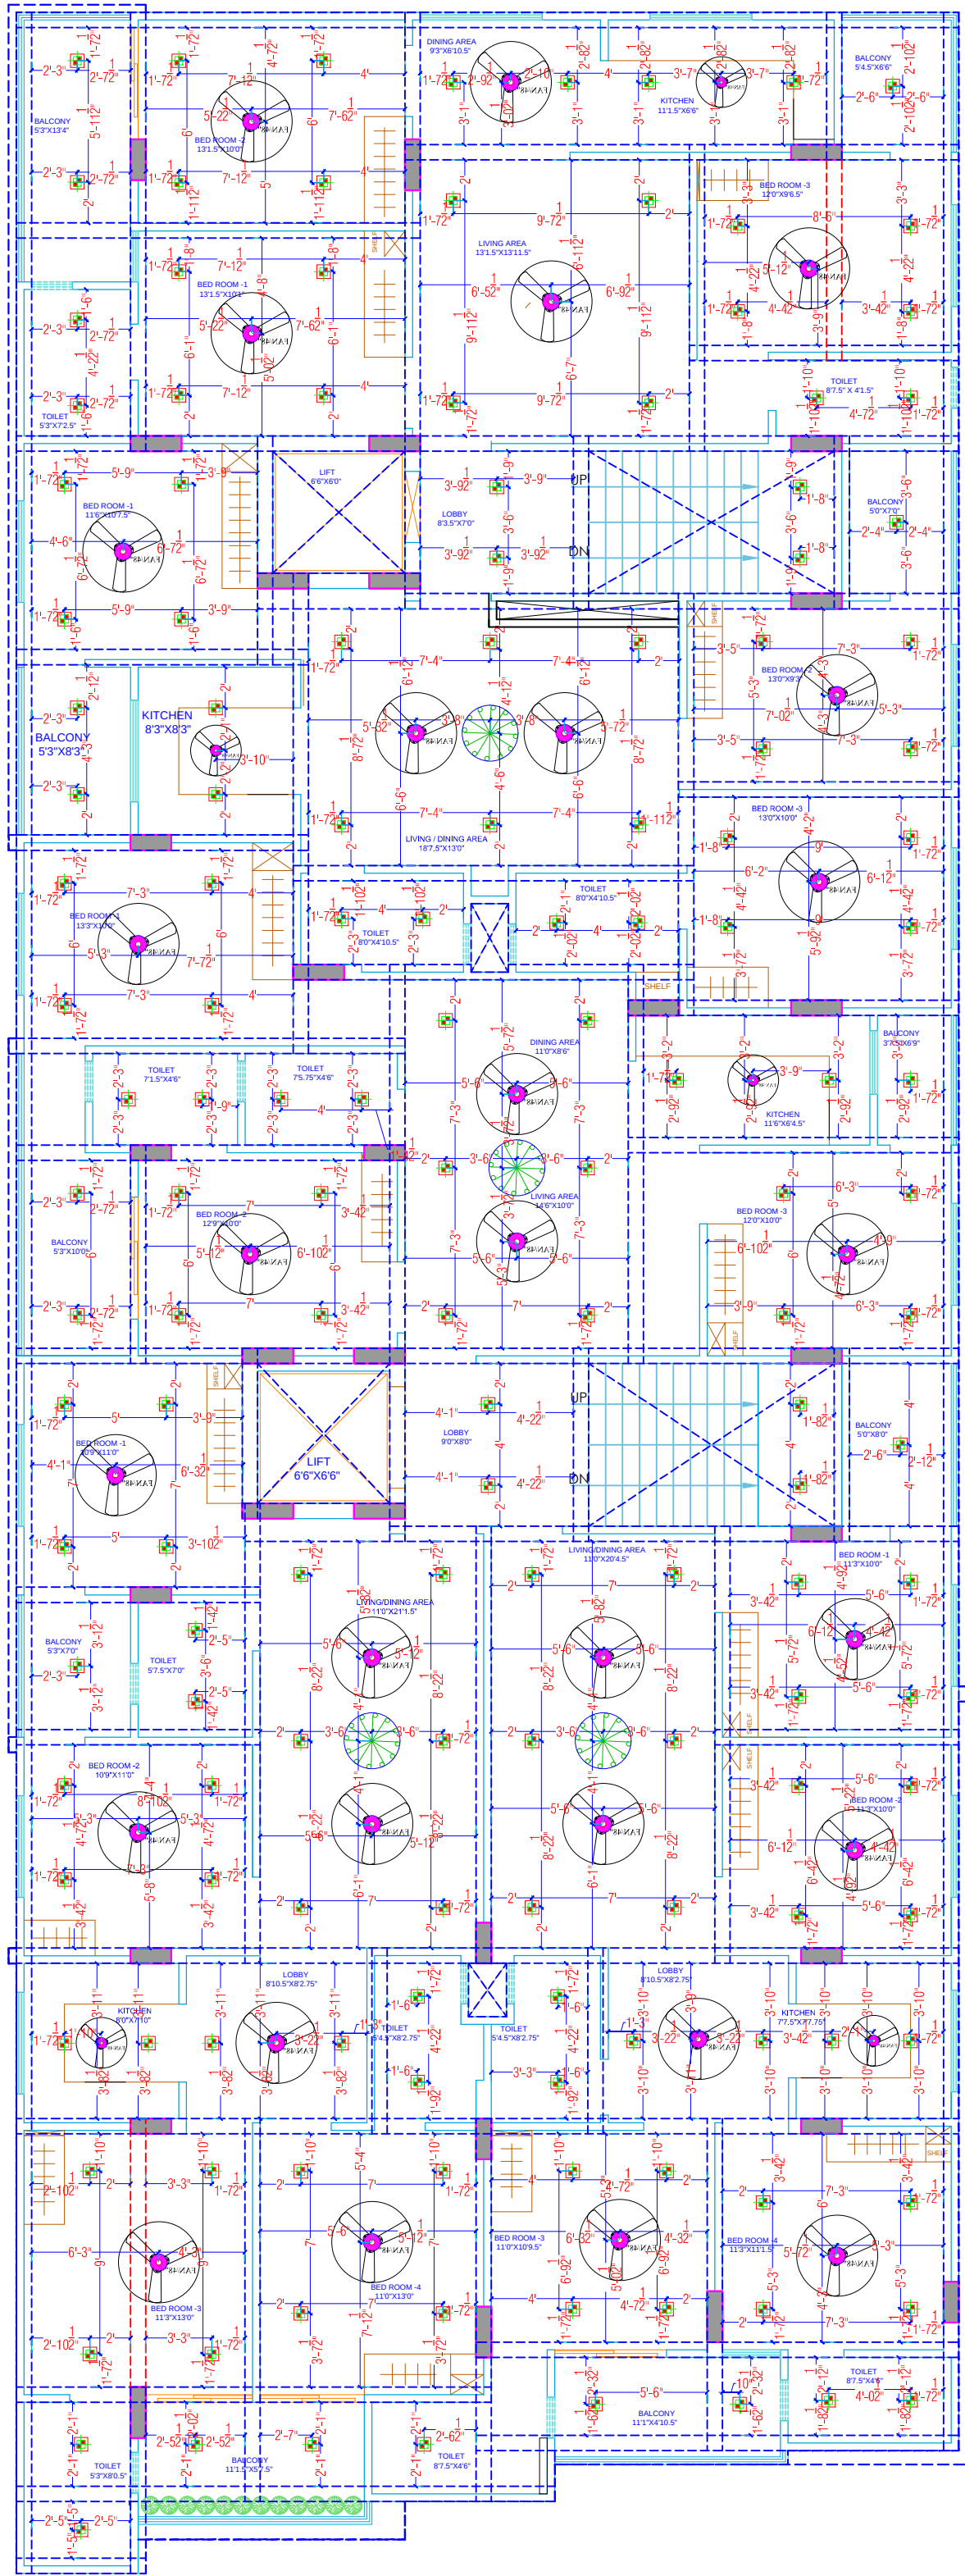

LEGENDS:				
Mounting Height	No.	ID	Symbol	Description
IN FLOOR				CONTROL WIRING
IN CONDUIT				CONTROL WIRING
IN CONDUIT				AC CONTROL WIRING
IN CONDUIT				GYSER CONTROL WIRING
IN CONDUIT				BUZZER CONTROL WIRING
CEILING	06	FAN/48"		CEILING FAN 48"
CEILING	02	FAN/30"		CEILING FAN 30"
+90"	04	TL		1X40W WALL TUBELIGHT
+90"	04	BULB		WALL BRACKETS AS DESIGN LIGHT
+90"	01	GL		WALL BRACKETS AS DESIGN FOR GANESH LIGHT
	02	GL		WALL BRACKETS AS DESIGN FOR GATE LIGHT
CEILING	21	CFL		CFL CEILING LIGHT
+21"	02	FL		FOOT LIGHT
+48"	14	SB		SWITCH BOARD
+75"	03	ML		1 X 11" W CFL MIRROR LIGHT
VENTILATOR HT.	03	CR		CEILING ROSE
VENTILATOR HT.	03	EXP		9" DIA FRESH AIR FAN
+24"	02	TEL		TELEPHONE POINT
+27"	03	TV		TV COAXIAL POINT
+24"	02	LP TEL		6 A PLUG POINT FOR TELEPHONE
+27"	03	LP TV		6 A PLUG POINT FOR TV
+24"	02	LP		6 A PLUG POINT
+72"	01	LP-CH		6 A PLUG POINT FOR CHIMNEY
+102"	03	SAC		SPLIT AC
+102"	03	PP-SAC		25 A POWER POINT FOR SPLIT AC
+42"	01	PP-MIX		15 A POWER POINT FOR MIXER
+78"	02	PP-G		15 A POWER POINT FOR GEYSER
+54"	01	PP-F		15 A POWER POINT FOR FRIDGE
+78"	01	PP-WP		15 A POWER POINT FOR WATER PURIFIER
+48"	01	PP-WM		15 A POWER POINT FOR WASHING MACHINE
+42"	02	BP		BELL PUSH SWITCH
+90"	01	BZ		BUZZER POINT
+24"	03	AC		AC STARTER
+60"	01	MCB DB		MCB DISTRIBUTION BOARD
	05		SBL/L	SWITCH BOARD NO./ LIGHT CIRCUIT NO.
	03		ACI	AC CIRCUIT NO.
	05		PI	POWER CIRCUIT NO.

WARNING

1. This drawing is the sole copyright of Architects VISTAAR and should be used for the purpose expressly issued.

GENERAL NOTES

1. All dimensions are in feet and inches.
2. Do not scale this drawing follow written dimensions only.
3. This drawing should be read in conjunction with other architectural and structural drawings.
4. Any discrepancy in the drawing should be immediately brought to the notice of architect.

PROJECT TITLE

CITY PALM
BUILDING AT PLOT-E-84,JAGDAMBA
NAGAR-E,JAIPUR

DRAWING TITLE

GROUND TO 4TH FLOOR ELECTRICAL PLAN

ARCHITECTS :

VISTAAR ARCHITECTS &
PLANNERS
Architects :: Interior Designers
B-2/12, Chitrkoot scheme,
main Gandhi Path, Opp mall of jaipur,Jaipur
PH. - 0141-4116461,09001010366

PATH :-

DRN.

DATE

REV.

NORTH


SCALE

JOB NO.


N.T.S

For R K Builders & Developers
21/9/21
Proprietor

Krishna
KRISHNA KUMAR
B. Tech. (Mechanical)
M.E.P Consultant

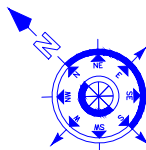

40'-0" WIDE ROAD

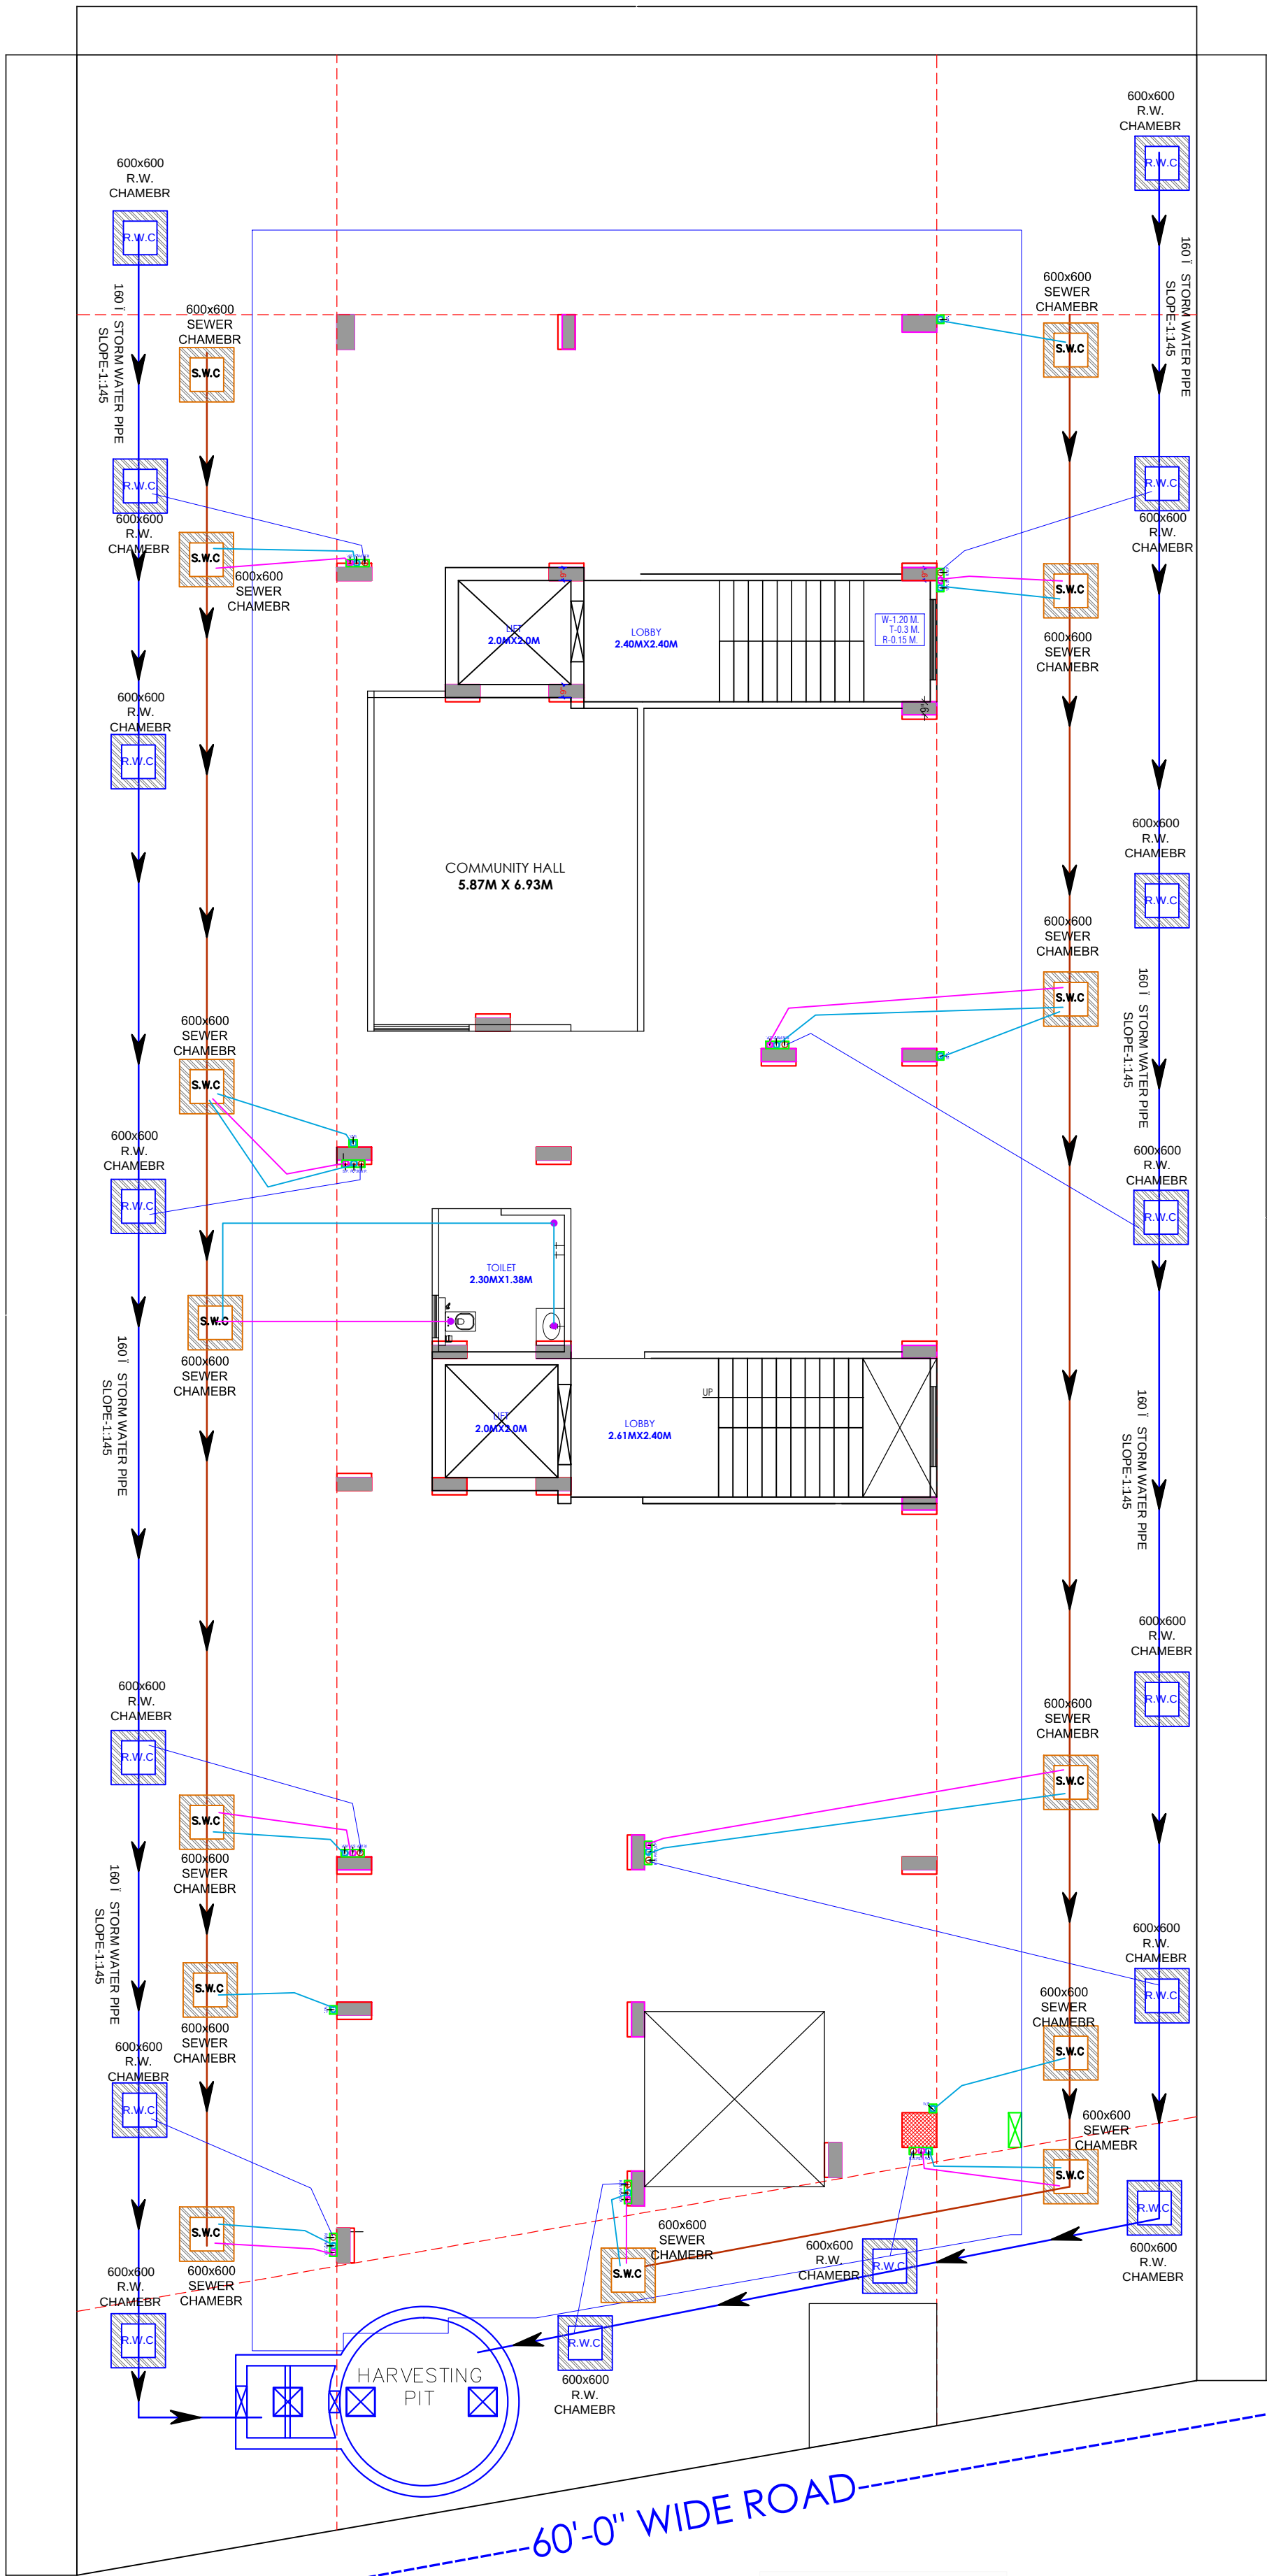

①	RAIN WATER PIPE		
②	WEST WATER PIPE		
③	SOIL WATER PIPE		
④		INSPECTION CHAMBER / GULLY TRAP	2'6" DEPTH
⑤		MAN HOLE	2'6" DEPTH
⑥		ELECTRICAL PIPELINE	

LEGENDS		
S.NO.	SYMBOL	DESCRIPTION
1.		SDR-11 Fresh Water Pipe
2.		SDR-11 Solar Water Pipe
3.		Waste Water Pipe (W.P.)
4.		Soil Pipe (S.P.)
5.		Rain Water Pipe (R.W.P.)
6.		Butter Fly Valve (B.F.V.)
7.		Geyser
8.		RO
9.		Single Lever Diverter
10.		Concealed Valve
11.		Angle Valve
12.		Nahani Trap
13.		P-Trap
14.		Tap
15.		Floor Drain (F.D.)
16.		Plain Tee (P-tee)
17.		Gully Trap (G.T.)
18.		

WARNING

1. This drawing is the sole copyright of Architects **VISTAAR** and should be used for the purpose expressly issued.

GENERAL NOTES

1. All dimensions are in feet and inches.
2. Do not scale this drawing follow written dimensions only.
3. This drawing should be read in conjunction with other architectural and structural drawings.
4. Any discrepancy in the drawing should be immediately brought to the notice of architect.

PROJECT TITLE

CITY PALM
BUILDING AT PLOT-E-84,JAGDAMBA
NAGAR-E,JAIPUR

DRAWING TITLE

STILT FLOOR DRAINAGE PLAN

ARCHITECTS :

VISTAAR ARCHITECTS & PLANNERS

Architects :: Interior Designers
B-2/12, Chitrkoot scheme,
main Gandhi Path, Opp mall of jaipur,Jaipur
PH. - 0141-4116461,09001010366

PATH :-

DRN.

DATE


REV.

NORTH

SCALE


JOB NO.

N.T.S

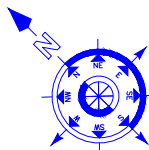

For R K Builders & Developers
B. Tech. (Mechanical)
M.E.P Consultant
Proprietor

Krishna
KRISHNA KUMAR
B. Tech. (Mechanical)
M.E.P Consultant

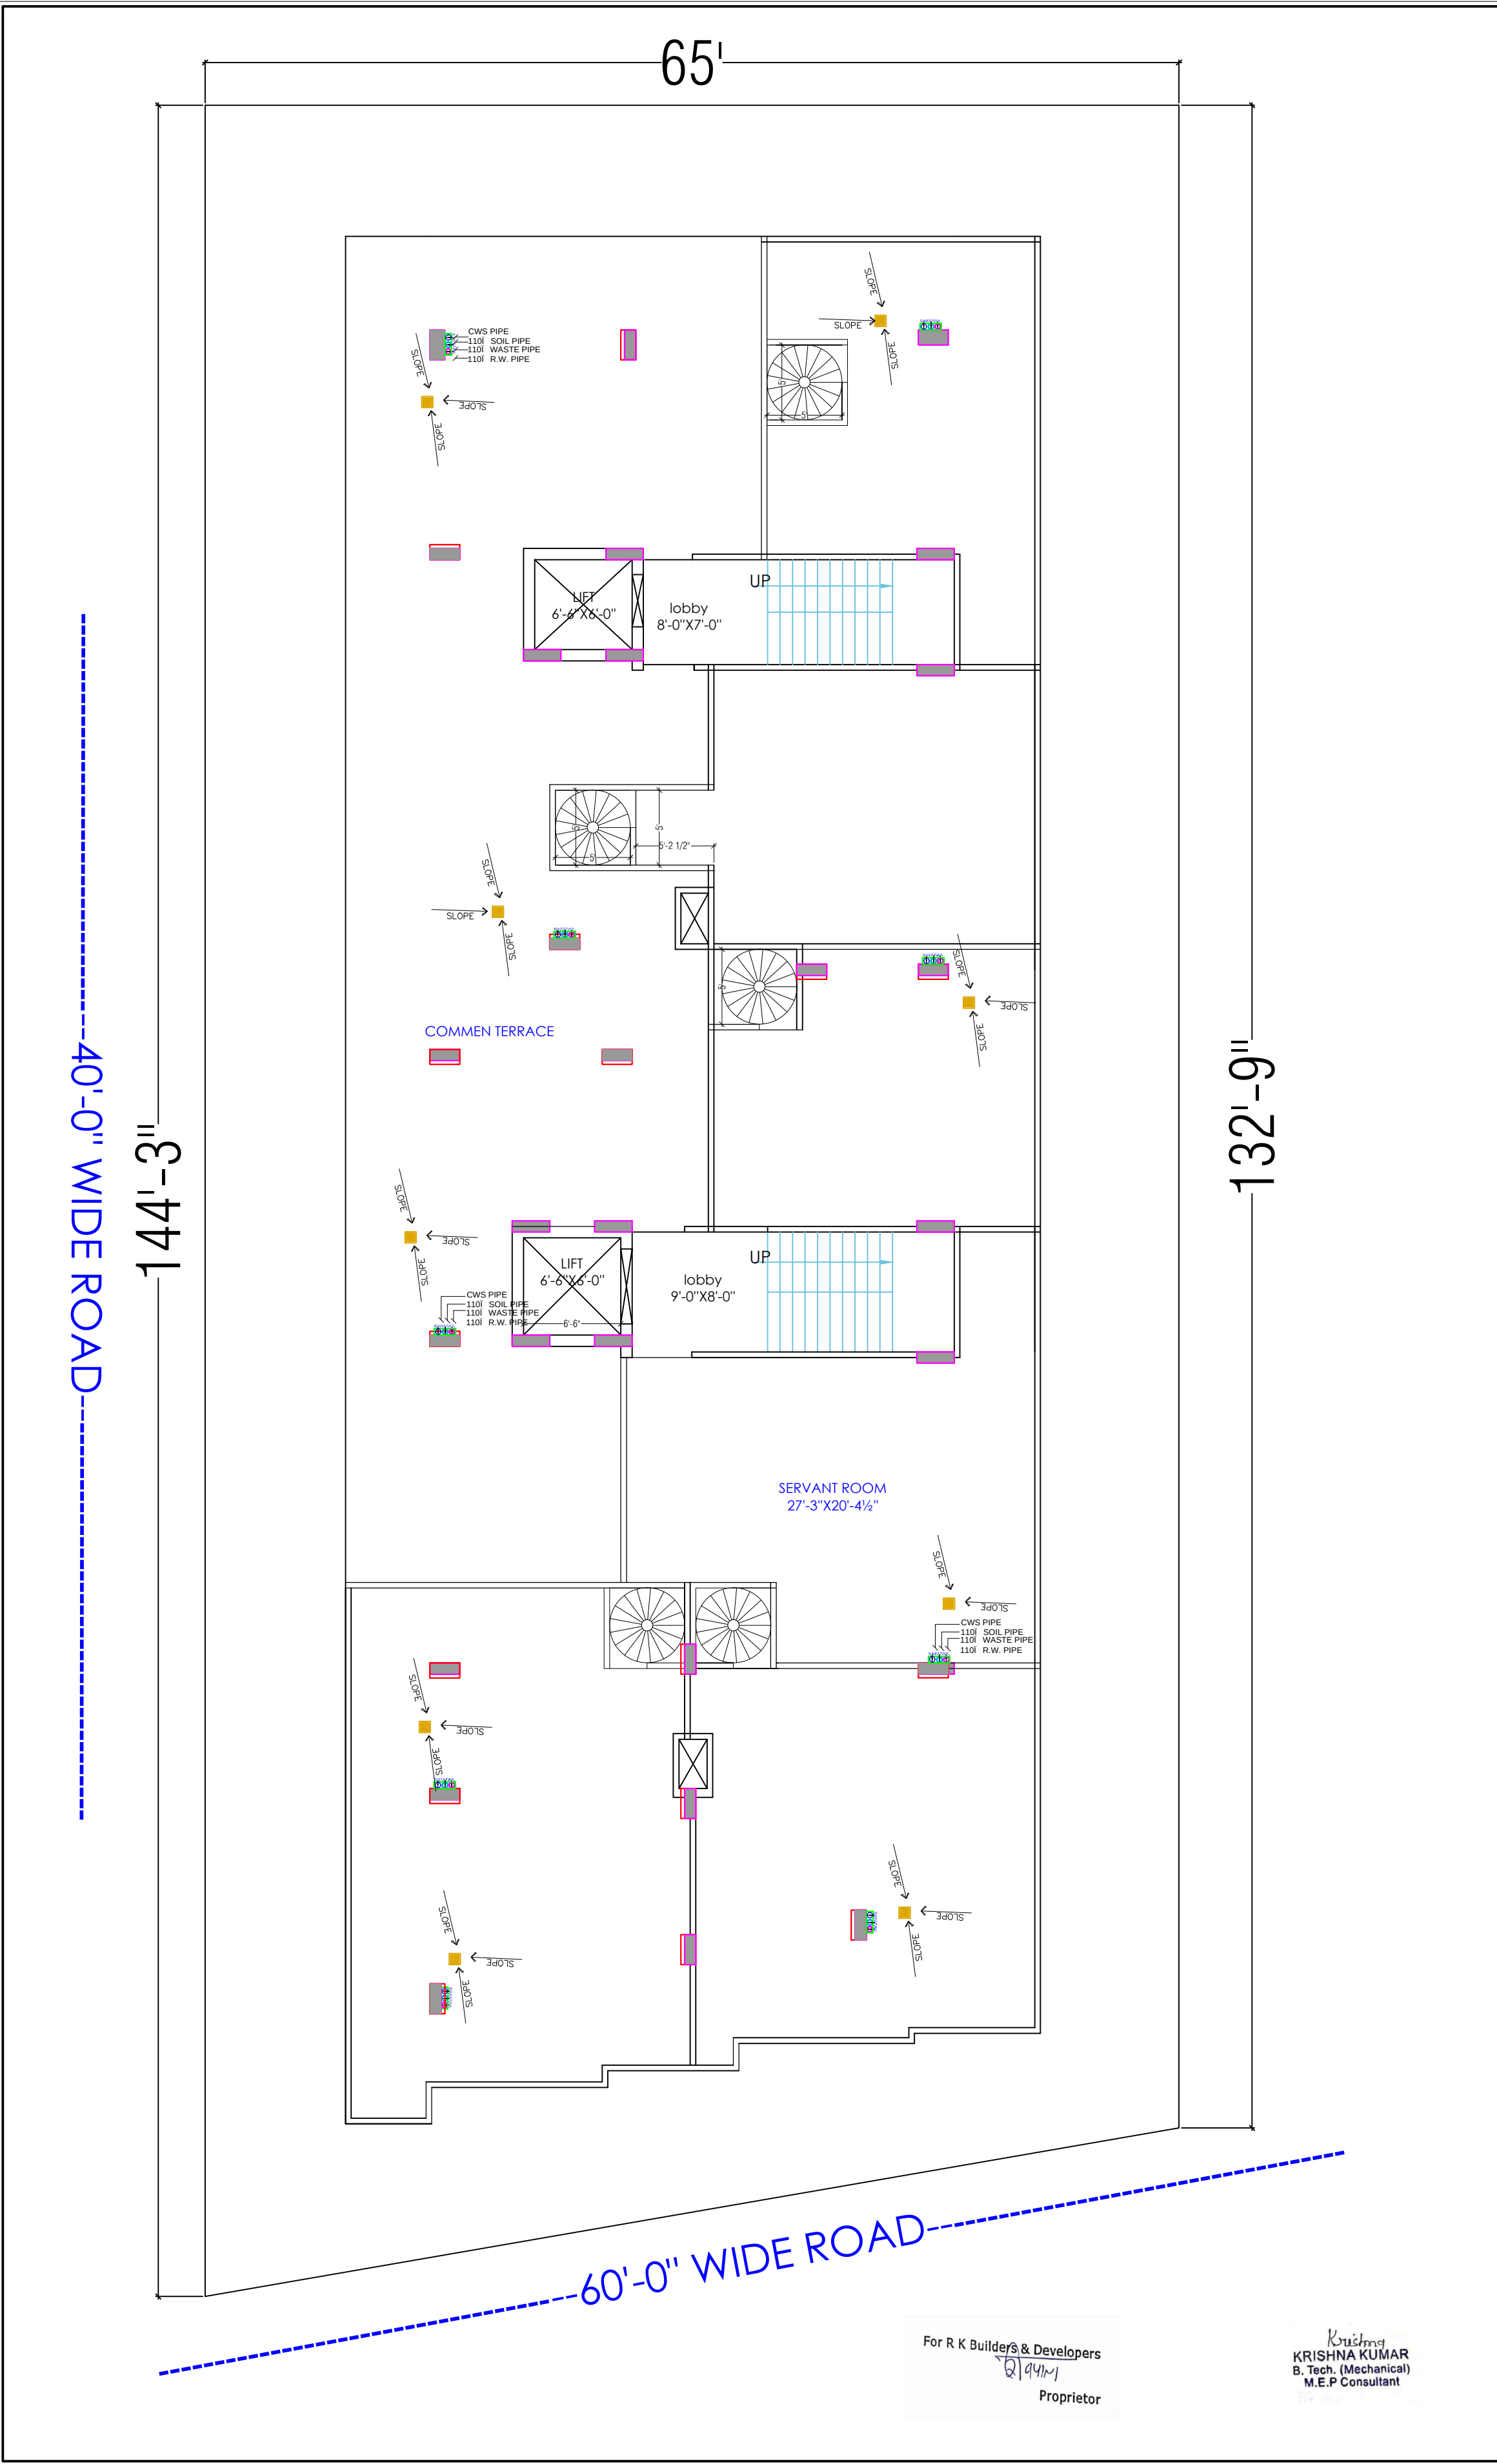

</

For R K Builders & Developers
B. Tech. (Mechanical)
Proprietor

Krishna
KRISHNA KUMAR
B. Tech. (Mechanical)
M.E.P Consultant