

*Dharmesh*  
DHARMESH SHARMA  
B. TECH. (CIVIL)


### WARNING

1. This drawing is the sole copyright of Architects **VISTAAR** and should be used for the purpose expressly issued.


### GENERAL NOTES

1. All dimensions are in feet and inches.
2. Do not scale this drawing follow written dimensions only.
3. This drawing should be read in conjunction with other architectural and structural drawings.
4. Any discrepancy in the drawing should be immediately brought to the notice of architect.

PROJECT TITLE			
Shree Krishna Residency Plot No. 82,83,84 E.P, 93 E.P-A-W.P,99 W.P,99 E.P-A , Village - Manpur Devri Urf Golyawas , Scheme - Vrindavan Vihar , Jaipur - 302020 (Rajasthan)			
DRAWING TITLE			
BASEMENT FLOOR PLUMBING PLAN			
ARCHITECTS :			
<b>VISTAAR ARCHITECTS &amp; PLANNERS</b> Architects :: Interior Designers B-2/12, Chitrkoot scheme, main Gandhi Path,Opp mall of jaipur,Jaipur PH.- 0141-4116461,09001010366			
PATH :-			
DRN.	DATE	REV.	NORTH
MANOJ KUMAWAT	09-09-2022		
SCALE	JOB NO.		
N.T.S			

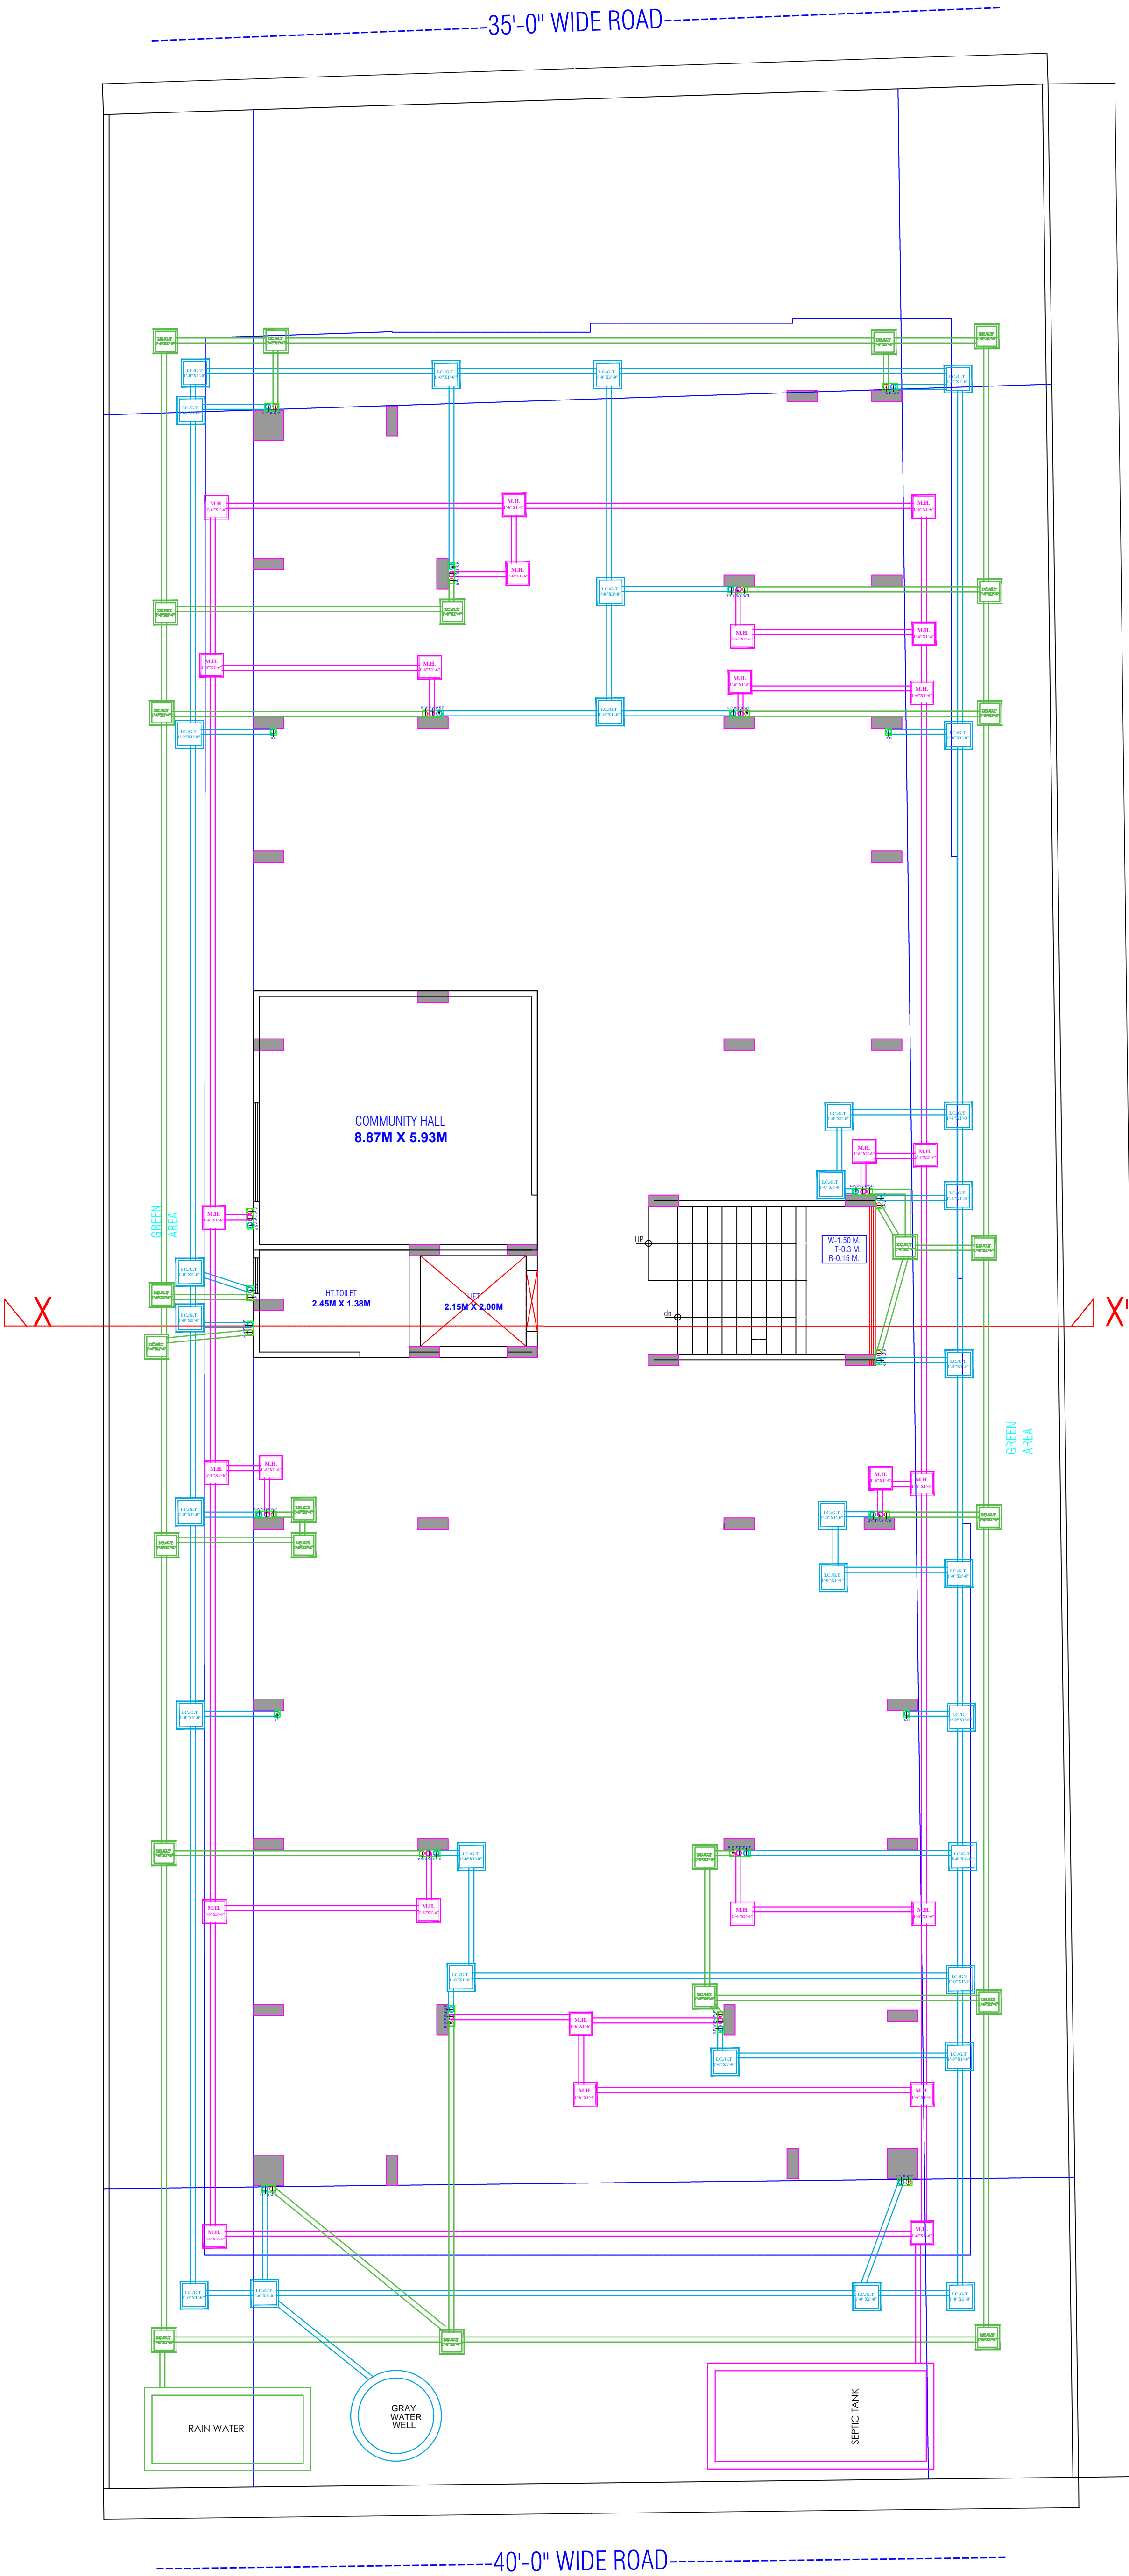

①	RAIN WATER PIPE		
②	WEST WATER PIPE		
③	SOIL WATER PIPE		
④	INSPECTION CHAMBER / GULLY TRAP		2'6" DEPTH
⑤	MAN HOLE		2'6" DEPTH
⑥	ELECTRICAL PIPELINE		

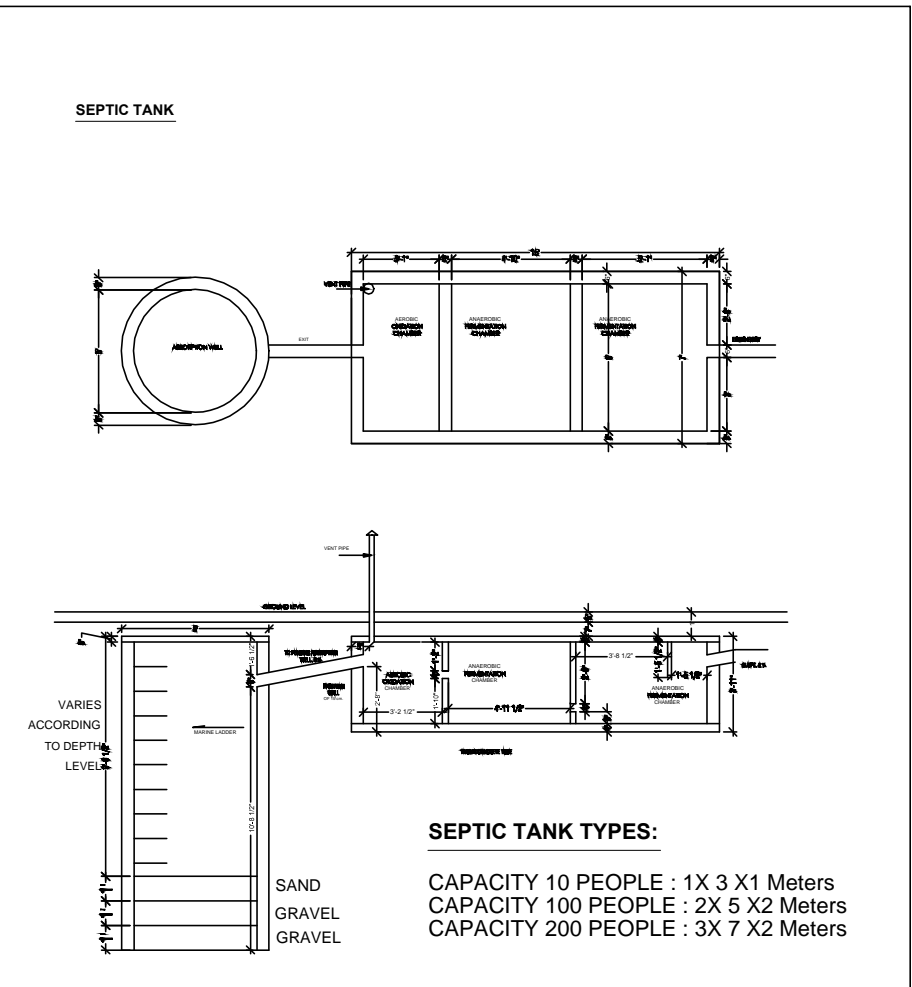

*Dharmesh*  
DHARMESH SHARMA  
B. TECH. (CIVIL)

## WARNING

1. This drawing is the sole copyright of Architects **VISTAAR** and should be used for the purpose expressly issued.

## GENERAL NOTES

1. All dimensions are in feets and inches.
2. Do not scale this drawing follow written dimensions only.
3. This drawing should be read in conjunction with other architectural and structural drawings.
4. Any discrepancy in the drawing should be immediately brought to the notice of architect.

### PROJECT TITLE

Shree Krishna Residency  
Plot No. 82,83,84 E.P. 93 E.P-A-W.P.99 W.P.99  
E.P-A , Village - Manpur Devri Urf Golyawas ,  
Scheme - Vrindavan Vihar , Jaipur - 302020  
(Rajasthan)

### DRAWING TITLE

COMMON AREA WATER SUPPLY  
,SANITATION(STORM WATER DRAINAGE,  
SEWERAGE,STP,SOLID WATER DISPOSAL) AND  
RAIN WATER HARVESTING PLAN


### ARCHITECTS :

### VISTAAR ARCHITECTS & PLANNERS

Architects :: Interior Designers  
B-2/12, Chitrkoot scheme,  
main Gandhi Path,Opp mall of jaipur,Jaipur  
PH.- 0141-4116461,09001010366

### PATH :-

DRN.	DATE	REV.	NORTH
MANOJ KUMAWAT	09-09-2022		
SCALE	JOB NO.		
N.T.S			

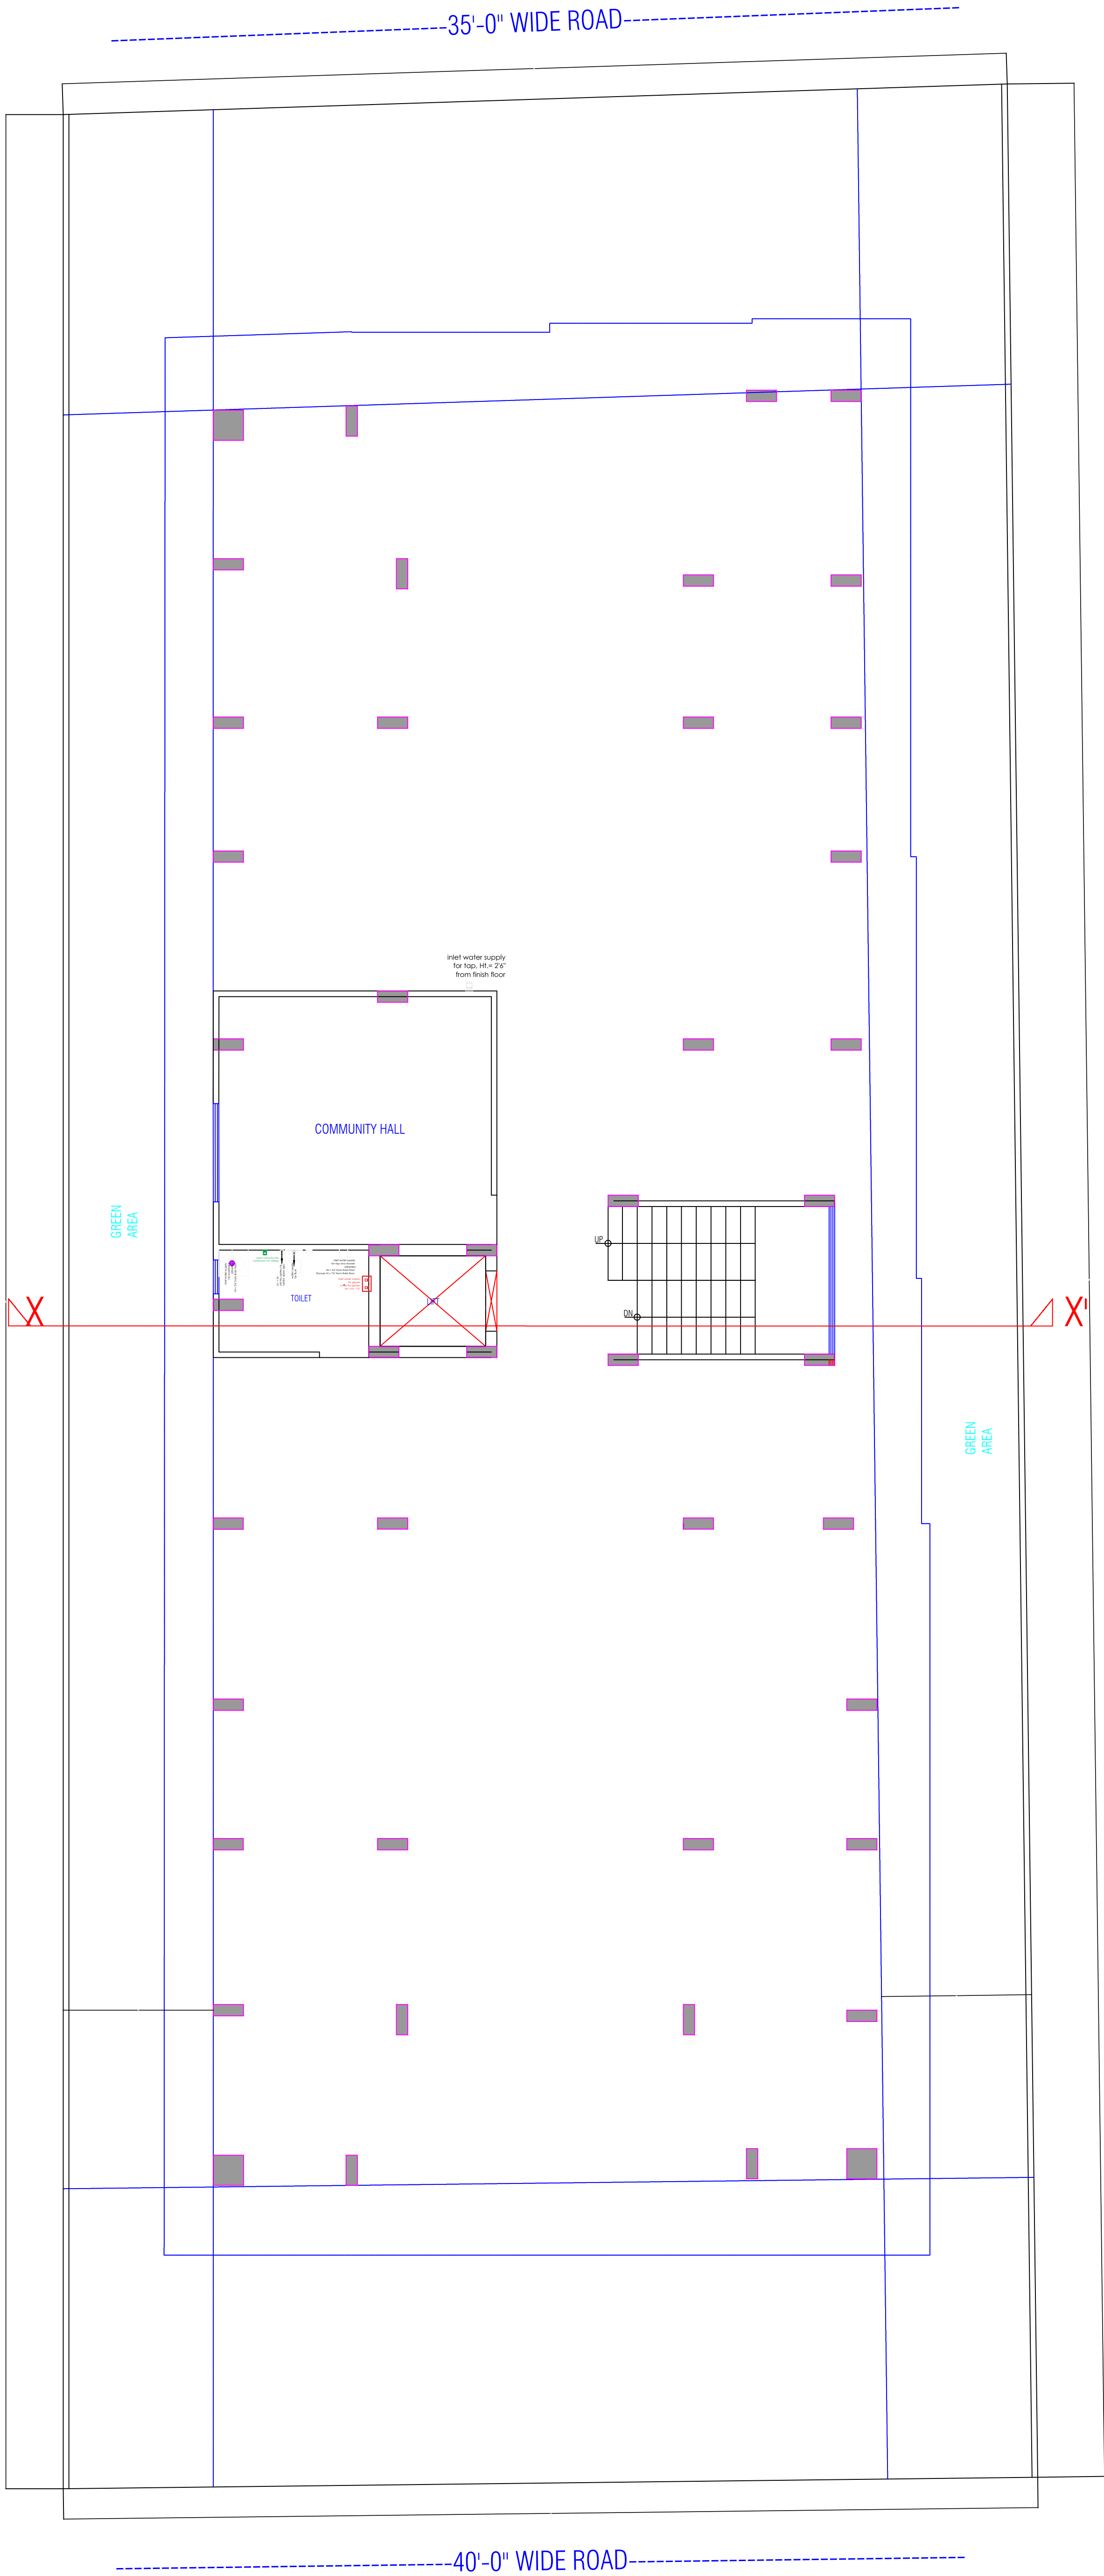

STILT(PARKING)FLOOR PLAN

*Dharmesh*  
DHARMESH SHARMA  
B. TECH. (CIVIL)

WARNING

1. This drawing is the sole copyright of Architects **VISTAAR** and should be used for the purpose expressly issued.

GENERAL NOTES

1. All dimensions are in feet and inches.
2. Do not scale this drawing follow written dimensions only.
3. This drawing should be read in conjunction with other architectural and structural drawings.
4. Any discrepancy in the drawing should be immediately brought to the notice of architect.

PROJECT TITLE

Shree Krishna Residency  
Plot No. 82,83,84 E.P, 93 E.P-A-W.P,99 W.P,99  
E.P-A , Village - Manpur Devri Urf Golyawas ,  
Scheme - Vrindavan Vihar , Jaipur - 302020  
(Rajasthan)

DRAWING TITLE

STILT FLOOR  
PLUMBING PLAN

ARCHITECTS :


**VISTAAR ARCHITECTS & PLANNERS**

Architects :: Interior Designers  
B-2/12, Chitrkoot scheme,  
main Gandhi Path,Opp mall of jaipur,Jaipur  
PH.- 0141-4116461,09001010366

PATH :-

DRN.	DATE	REV.	NORTH
MANOJ KUMAWAT	09-09-2022		
SCALE	JOB NO.		
N.T.S			



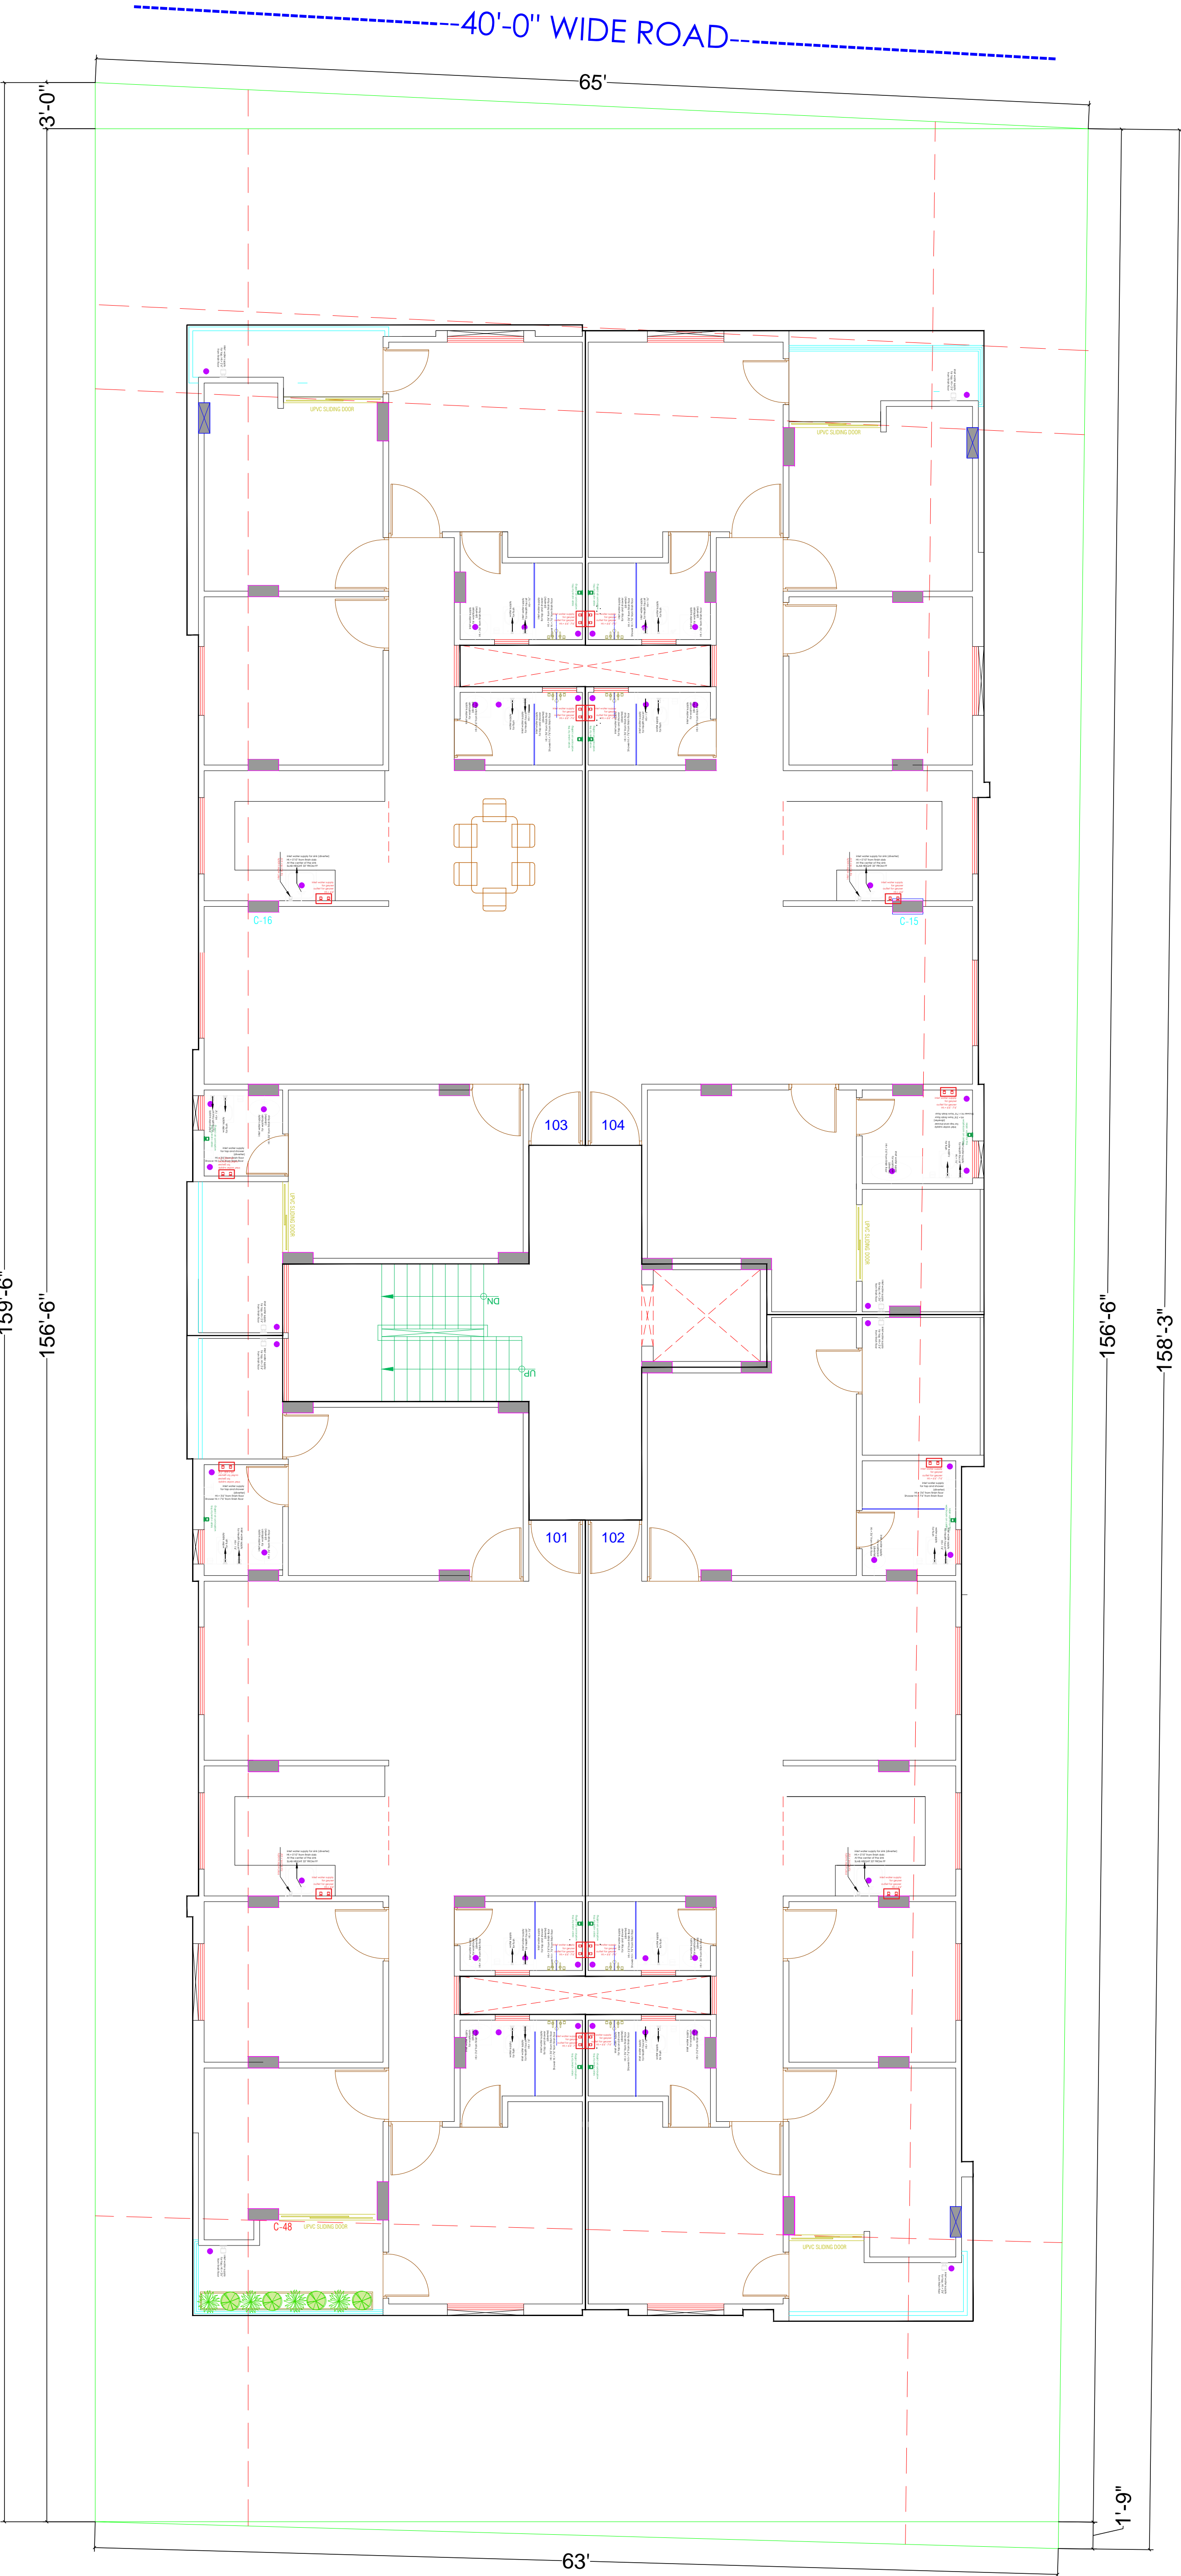

*Dharmesh*  
DHARMESH SHARMA  
B. TECH. (CIVIL)

## WARNING

1. This drawing is the sole copyright of Architects **VISTAAR** and should be used for the purpose expressly issued.

## GENERAL NOTES

1. All dimensions are in feets and inches.
2. Do not scale this drawing follow written dimensions only.
3. This drawing should be read in conjunction with other architectural and structural drawings.
4. Any discrepancy in the drawing should be immediately brought to the notice of architect.

### PROJECT TITLE

Shree Krishna Residency  
Plot No. 82,83,84 E.P, 93 E.P-A-W.P,99 W.P,99  
E.P-A , Village - Manpur Devri Urf Golyawas ,  
Scheme - Vrindavan Vihar , Jaipur - 302020  
(Rajasthan)

### DRAWING TITLE

TYPICAL FLOOR  
PLUMBING PLAN

### ARCHITECTS :

### VISTAAR ARCHITECTS & PLANNERS

Architects :: Interior Designers  
B-2/12, Chitrkoot scheme,  
main Gandhi Path,Opp mall of jaipur,Jaipur  
PH.- 0141-4116461,09001010366

### PATH :-

### DRN.

### DATE

### REV.

### NORTH

### MANOJ KUMAWAT

09-09-2022

### SCALE

### JOB NO.

### N.T.S

