


NOTE:-
1. ALL ROAD CROSSING ARE RCC HUME PIPE(NP3) UMO.

PLUMBING DWG.

S.NO.	SYMBOL	LEGEND FOR SWD	DESCRIPTION
1.		450x500mm	CATCH BASIN
2.		800x900mm	MANHOLE
3.		300mm RCC PIPE	(slope 1:12/5)
4.		250/300mm OVER FLOW PIPE	
5.		300mm WIDE DRAIN WITH SPPC GRATING	(slope 1:125/200/750)
6.		300mm WIDE DRAIN WITH MS GRATING	(slope 1:750)
7.		TUBE WELL	
8.		3.0x3.0x3.0 m ³ RAIN WATER HARVESTING PIT WITH DE - SILTING CHAMBER	
9.		1200X1200X1200mm	DRAINAGE SUMP

V Srinivasan
Srian Engineering Consultants
Signature

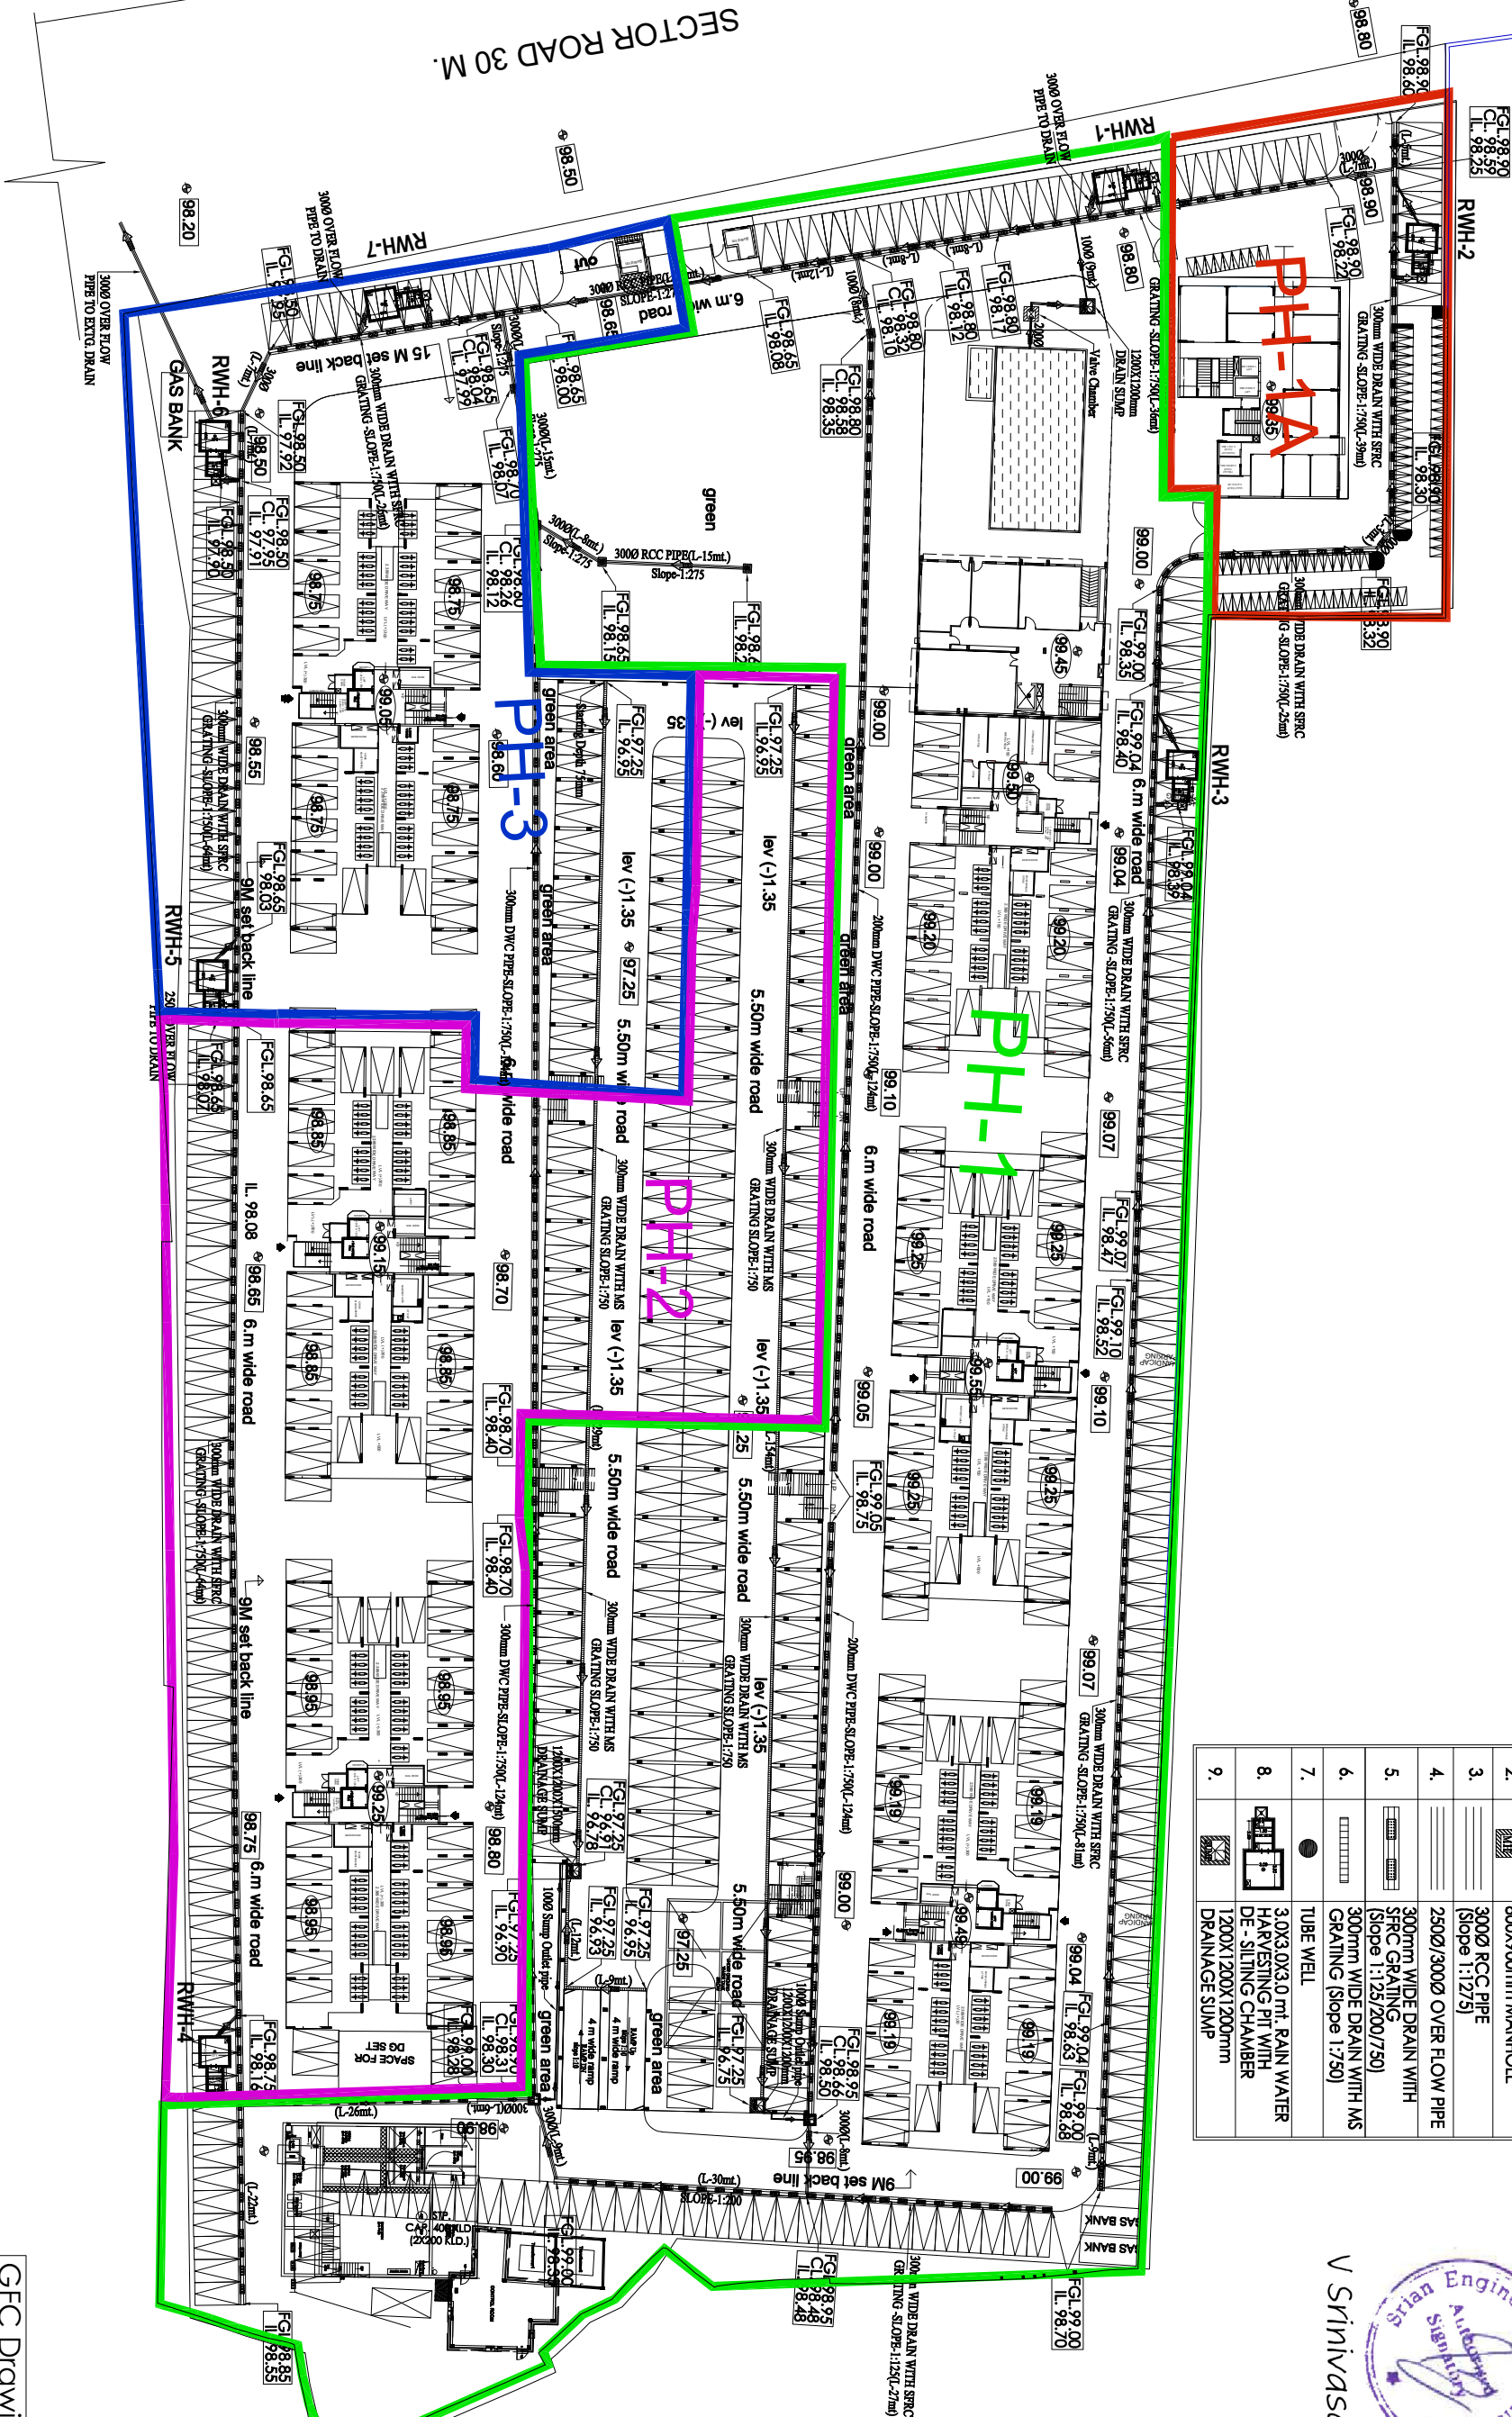

PROJECT :

ASHIANA DAKSH

OWNERS NAME
Ashiana Housing Ltd.

304, Southern park, saket District Centre,
Saket New Delhi - 110017
Phone no. 011- 42 65 42 65

Services consultants:-

SRIAN ENGINEERING CONSULTANTS
(Building Engineering Services)
C2/357, 1st Floor, JNAAPIRA, NEW DELHI - 110088
Tel: 011-40532854
Email: srianpe@gmail.com

DRG. TITLE:

Site plan
SVD. system
Plumbing dwg.

SCALE: DATE:

Drawn By

Checked By

Approved By

Rev.No.

Rev.Date

Remarks

GFC Drawing