





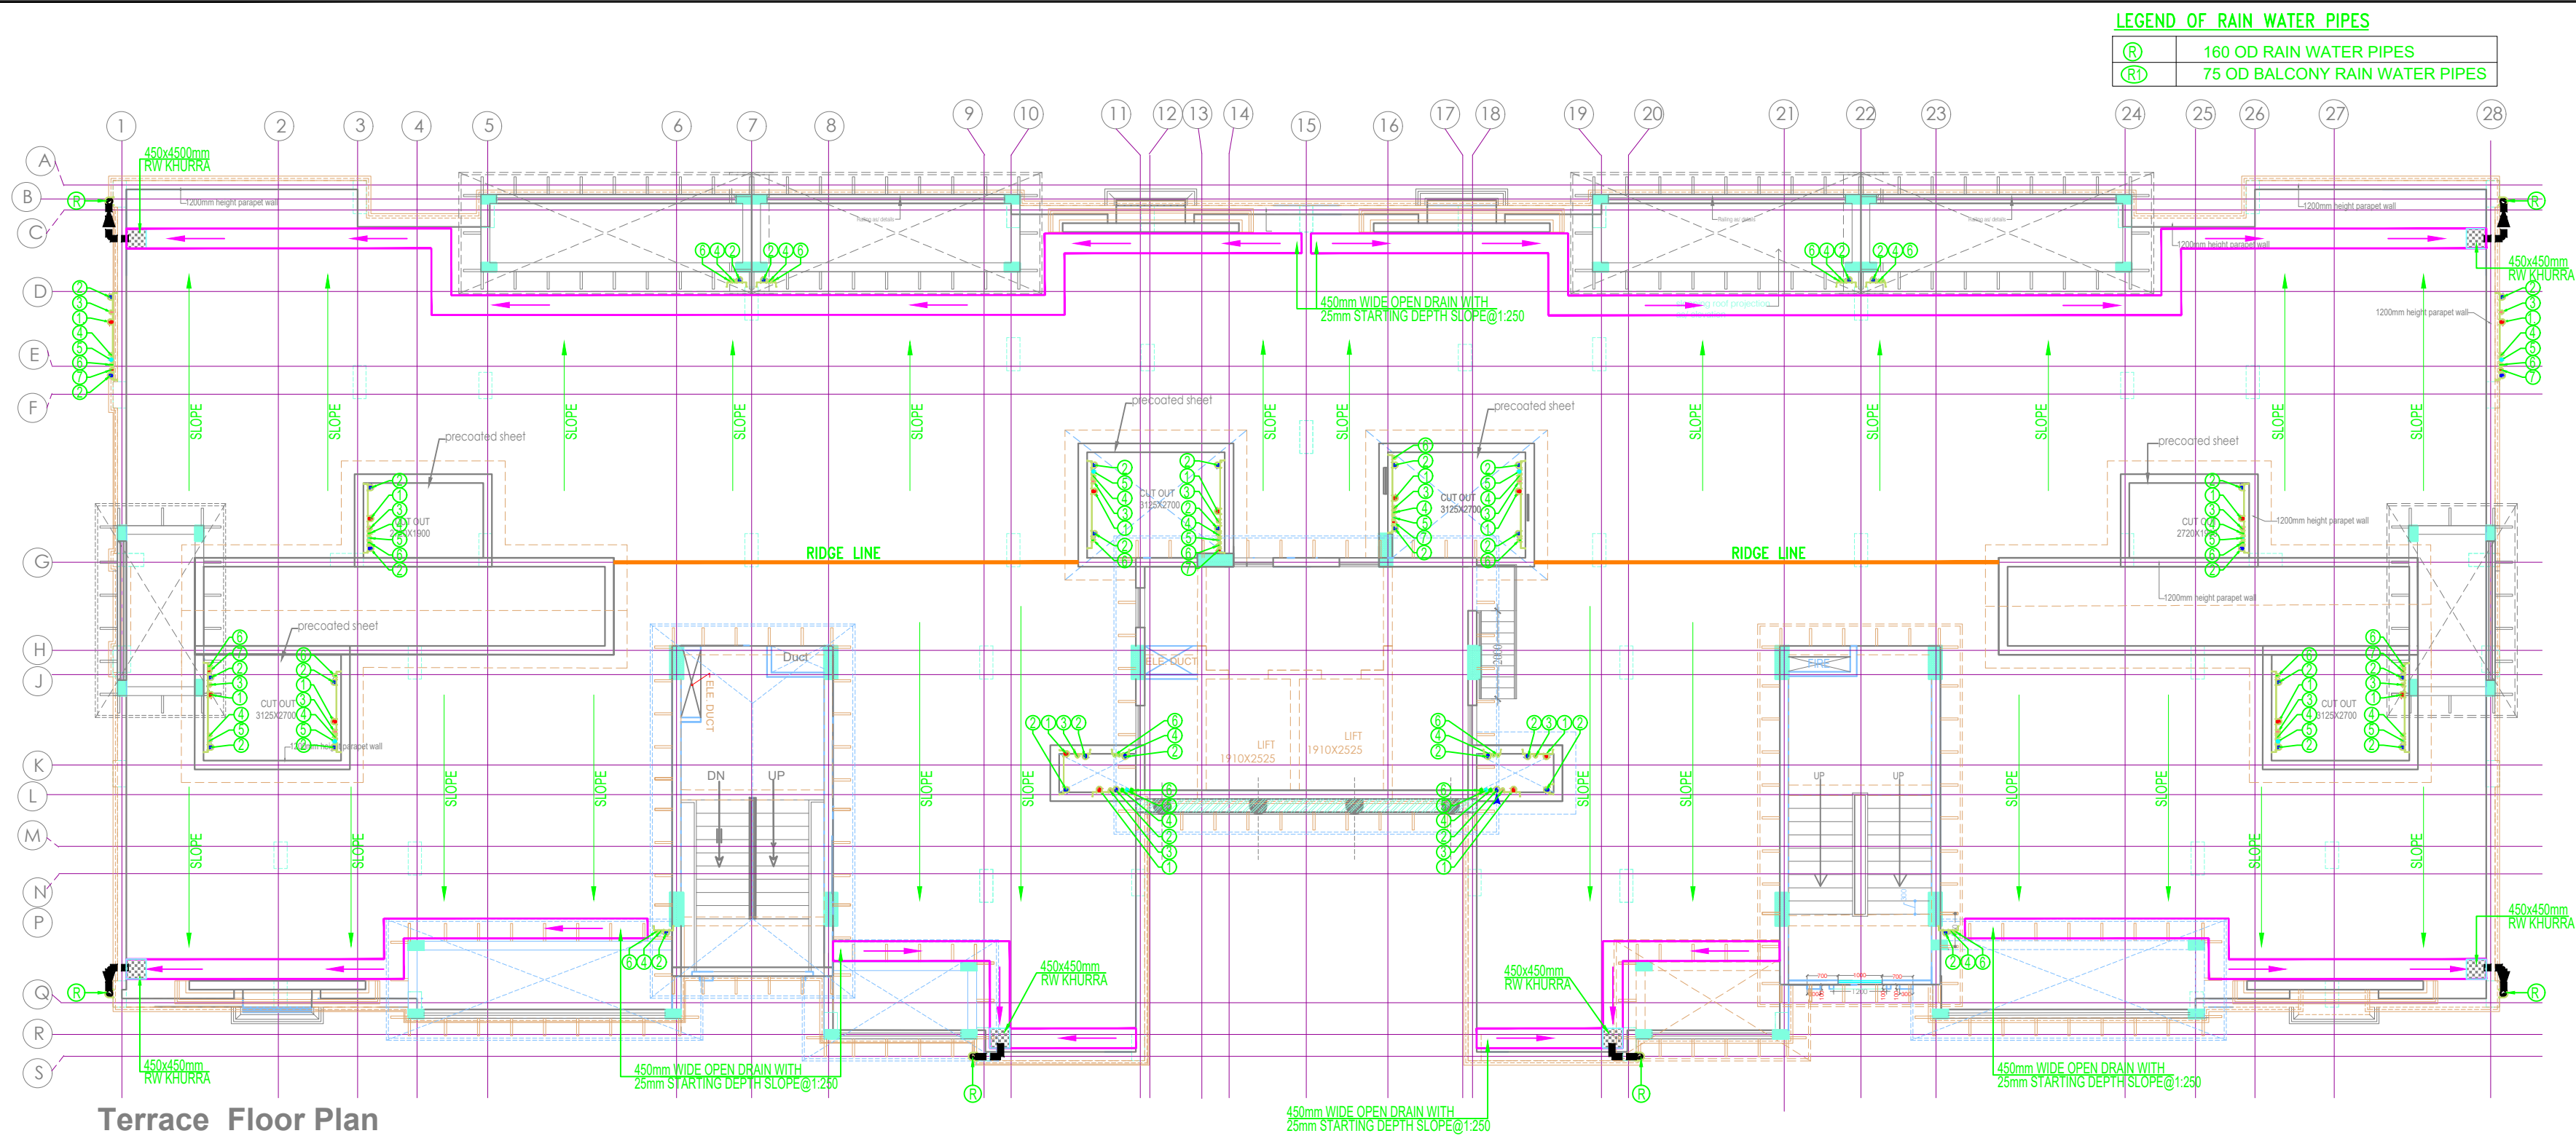

Terrace Floor Plan

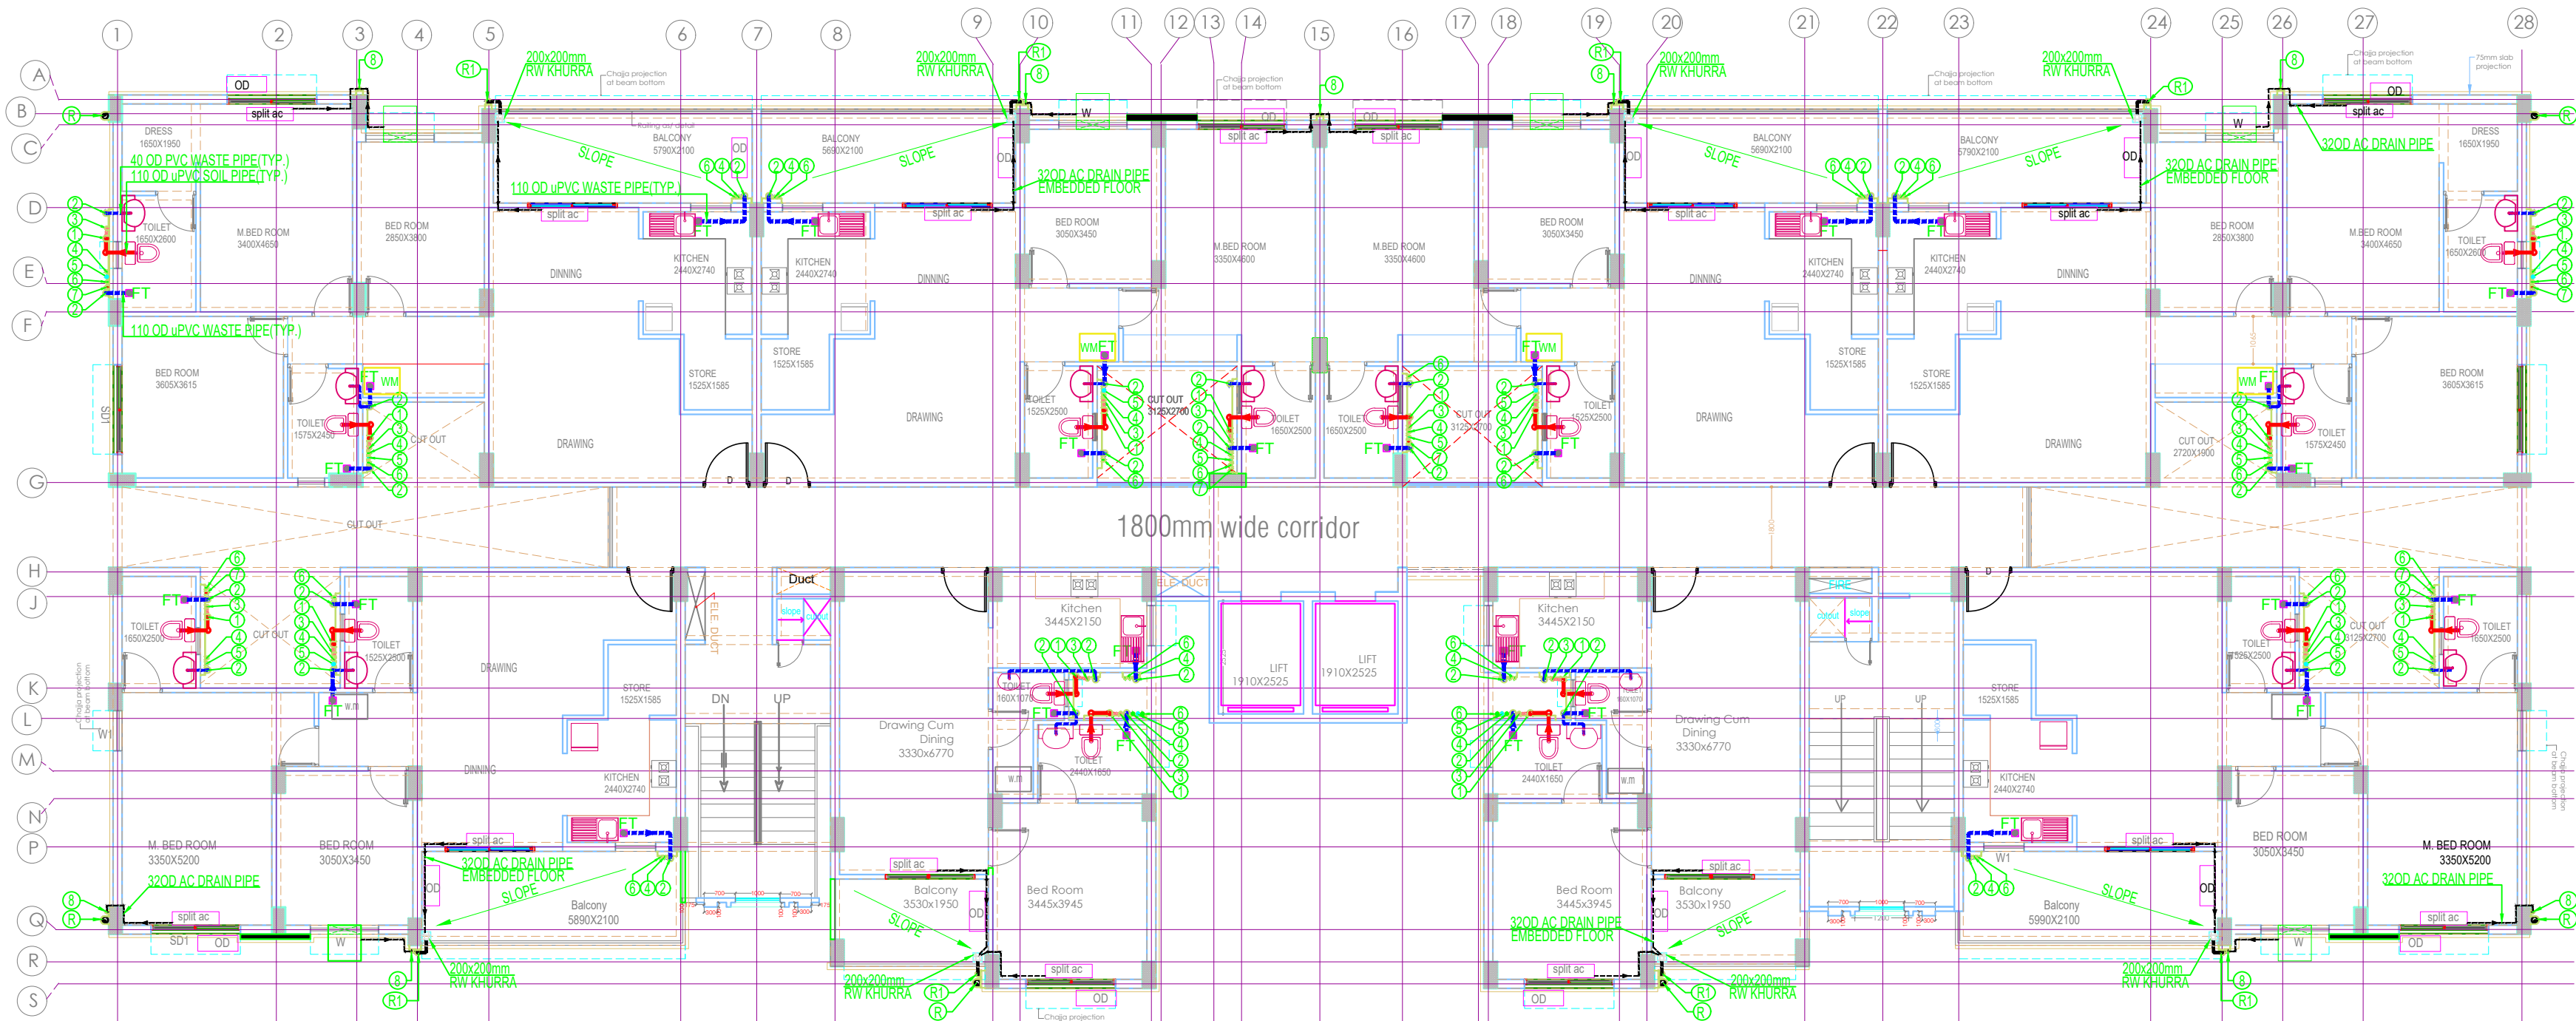

TYPICAL FLOOR PLAN

| LEGEND OF RAIN WATER PIPES |                                |
|----------------------------|--------------------------------|
| (R)                        | 160 OD RAIN WATER PIPES        |
| (RD)                       | 75 OD BALCONY RAIN WATER PIPES |

| LEGEND FOR VERTICAL PIPES |                                                                           |
|---------------------------|---------------------------------------------------------------------------|
| ①                         | 110 OD UPVC SOIL & VENT PIPE                                              |
| ②                         | 110 OD UPVC WASTE & VENT PIPE                                             |
| ③                         | 75 OD UPVC ANTI-SYPHONAGE PIPE                                            |
| ④                         | DOMESTIC WATER SUPPLY PIPE DNTAKE PIPE                                    |
| ⑤                         | FLUSHING WATER SUPPLY PIPE DNTAKE PIPE                                    |
| ⑥                         | DOMESTIC WATER SUPPLY FROM HYDRO-PNEUMATIC SYSTEM FOR UPPER THREE FLOORS. |
| ⑦                         | HOT WATER PIPE FROM SOLAR TO M.BED ROOM                                   |
| ⑧                         | 63 OD UPVC AC DRAIN PIPE                                                  |
| FT                        | FLOOR TRAP (110x110 mm)                                                   |

FOR SUBMISSION  
ABL Hospitech Pvt. Ltd.  
New Delhi

| No. | Date | By | Description |
|-----|------|----|-------------|
|     |      |    |             |

ISSUES

| No. | Date | By | Description |
|-----|------|----|-------------|
|     |      |    |             |

OWNERS NAME  
**Ashiana Housing Ltd.**  
Unit no.4 & 5,Plot No.D-2,3rd Floor,  
Southern park, saket District Centre,  
Saket New Delhi - 110017  
Phone no. 011-42 65 42 65

ARCHITECT:  
**b.sengupta architect**  
A-305,RANGOLI, ASHIANA VILLAGE BHIWADI.  
PH . 09887488263

Electro - Mechanical Consultants  
**ABL**  
ASHIANTECH (P) LTD  
Electro-Mechanical Consulting Engineer  
B-137, Basement, Kalkaji, New Delhi-110019  
P: +91-11-41623566, 46524180, 81,82,83,84  
F: +91-11-46524182  
E-mail: ahl@ashiantech.com  
ashihospitech@gmail.com

PROJECT:-  
**Ashiana Nirmay**  
AT BHIWADI

Drawing Title  
**TERRACE PLAN &  
TYPICAL FLOOR PLAN  
DRAINAGE LAYOUT  
( BLOCK -B5 )**

| Job No.            | Drawing No.        |
|--------------------|--------------------|
| Drawn<br>S.J.      | Checked<br>N.V.    |
| Date<br>18/01/2018 | Scale<br>1:125     |
|                    | Revisions<br>DR-02 |