


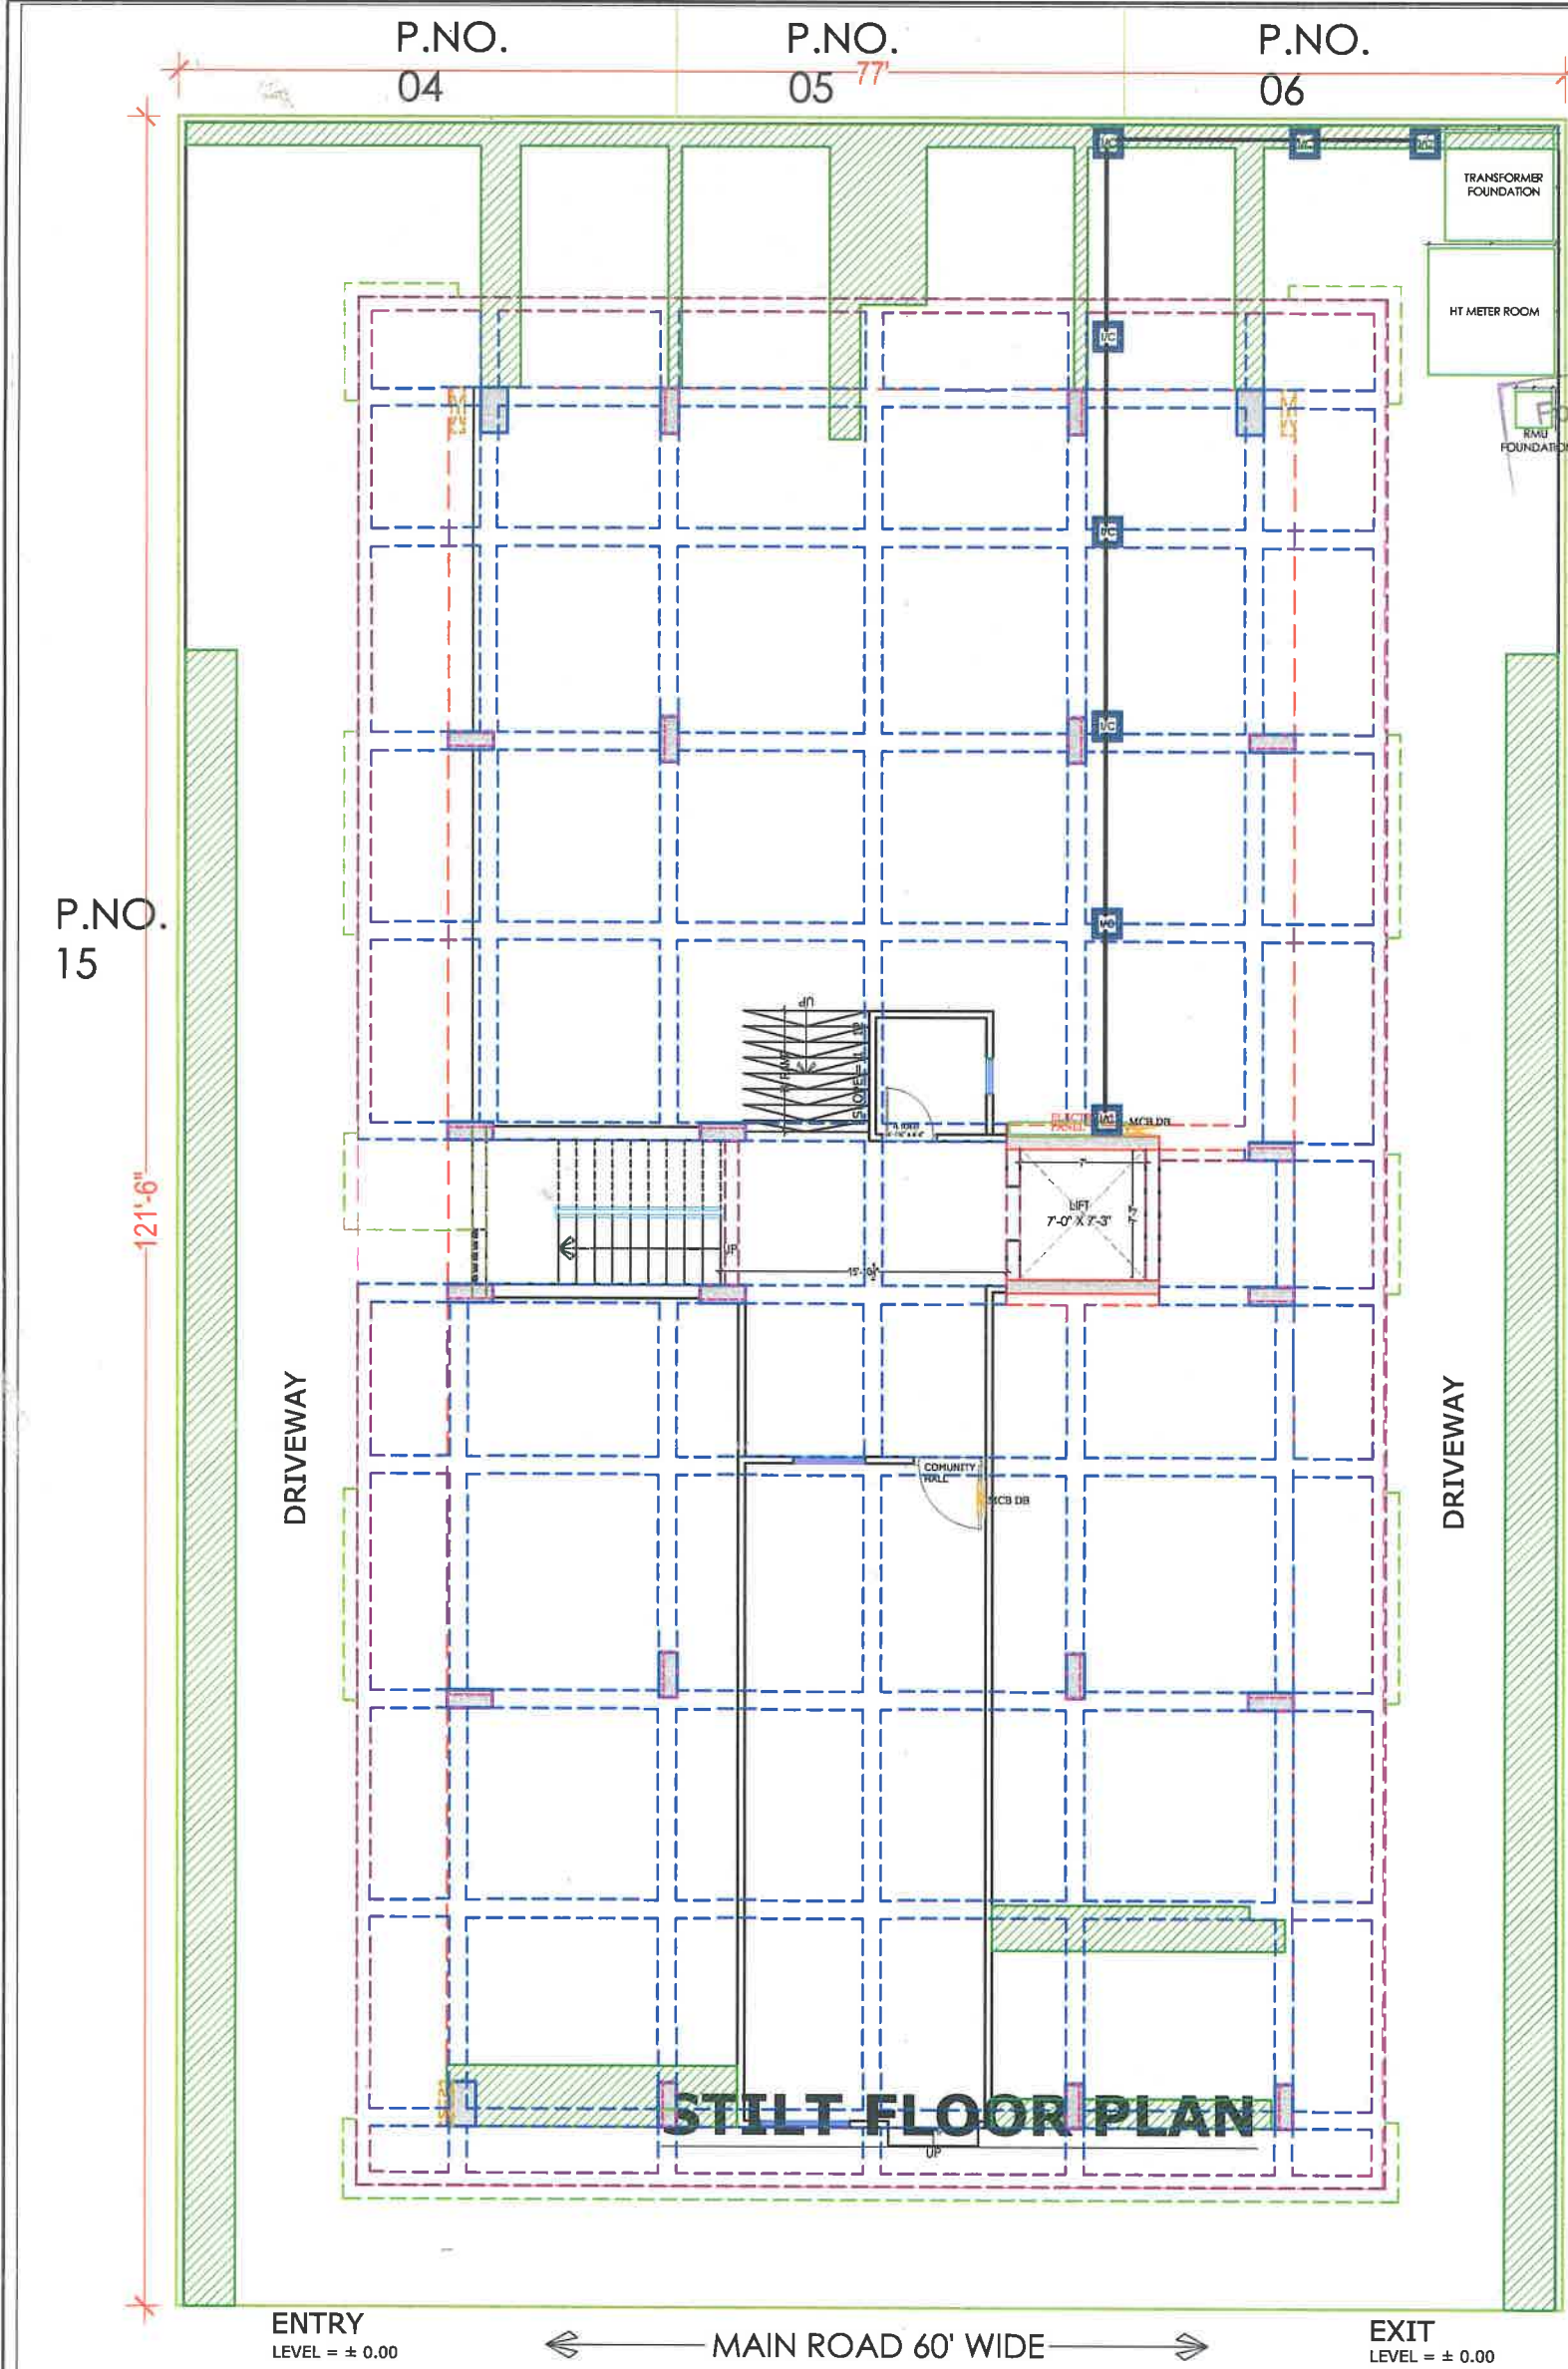

PROJECT NAME :
"UTSAV"

DEVELOPER
NAME :
M/S VINAYAK REAL ESTATE

ARCHITECTS :
INSIDE
ARCHITECTURE N INTERIORS
Plot no. 72, S.P. Marg, C- Scheme
Jaipur, Rajasthan, India
Cont: 91 9950595991, 91 9982812777
e.mail: 4insideofficial@gmail.com

Partner

Sanjeev SHARMA
B.E (Electrical)

LEGENDS:

Mounting Height	TD	Symbol	Description
CEILING	FAN48"		CEILING FAN 48"
CEILING	FAN30"		CEILING FAN 30"
CEILING	CH		CHANDIELIER
+93"	TL/W		LED Wall Light Make:- Syntex Ltd Cat no:- SDC-15-30W
+93"	BULB		LED Bulb 20W Make:- Syntex Ltd Cat no:- SDC-20W-57K/3K
+93"	OL		12x2 LED Mirror Light Make:- Syntex Ltd Cat no:- SDC-15W-57K/3K
+78"	ML		LED 6 inch Down Light 20W (Surface Mounted) Make:- Syntex Ltd Cat no:- SDC-15W-57K/3K
CEILING	DL		LED 6 inch Down Light 20W (Surface Mounted) Make:- Syntex Ltd Cat no:- SDC-15W-57K/3K
VENTILATOR	RT		CEILING ROSE
VENTILATOR	HT		9" DIA FRESH AIR FAN
+24"	2xSB		2x SWITCH BOARD
+42"	SB		SWITCH BOARD (BA SOCKET & SWITCH)
+24"	TEL		TELEPHONE POINT
+24"	LP TEL		6 A PLUG POINT FOR TELEPHONE
+48"	TV		TV COAXIAL POINT
+48"	LP TV		8 A PLUG POINT FOR TV
+24"	LP		6 A PLUG POINT FOR SIDE TABLE
+72"	LP CH		6 A PLUG POINT FOR CHIMNEY
+12"	LP PC		6 A PLUG POINT FOR COMPUTER
+93"	SAC		SPLIT AC INDOOR UNIT
+42"	PP-MIX		16 A POWER POINT FOR MIXER
+42"	PP-MC		16 A POWER POINT FOR MICROWAVE
+78"	PP-G		16 A POWER POINT FOR GEYSER
+54"	PP-F		16 A POWER POINT FOR FRIDGE
+78"	PP-WP		16 A POWER POINT FOR WATER PURIFIER
+48"	PP-WM		16 A POWER POINT FOR WASHING MACHINE
+12"	PP-INV		16 A POWER POINT FOR INVERTOR
+93"	PP-AC		25A SWITCH/MSB FOR AC
			CHAMBER (2' X 2')
+18"			BA 2 NOS. SOCKET +1 NOS. 16A SWITCH, TELEPHONE LAN
+60"	MCB DB		MCB DISTRIBUTION BOARD
			CAMERA
			WALL FAN

PROJECT:
PROPOSED RESIDENTIAL FLATS ON PLOT NO.-13A & 14 SCHEME - SUMER NAGR VISTAR 'N' BLOCK, JAIPUR

NAME OF DRAWING: STILT FLOOR ELECTRICAL ROUTE LAYOUT (TRANSFORMER, RMU, METER PANEL, ELECTRICAL CABLE)


DRAWING: WORKING DRAWING

PROJECT NO. : DATE : 19, Feb. -2024

SCALE : NTS

REV NO. : R-0

DRAWING NO. : A-01

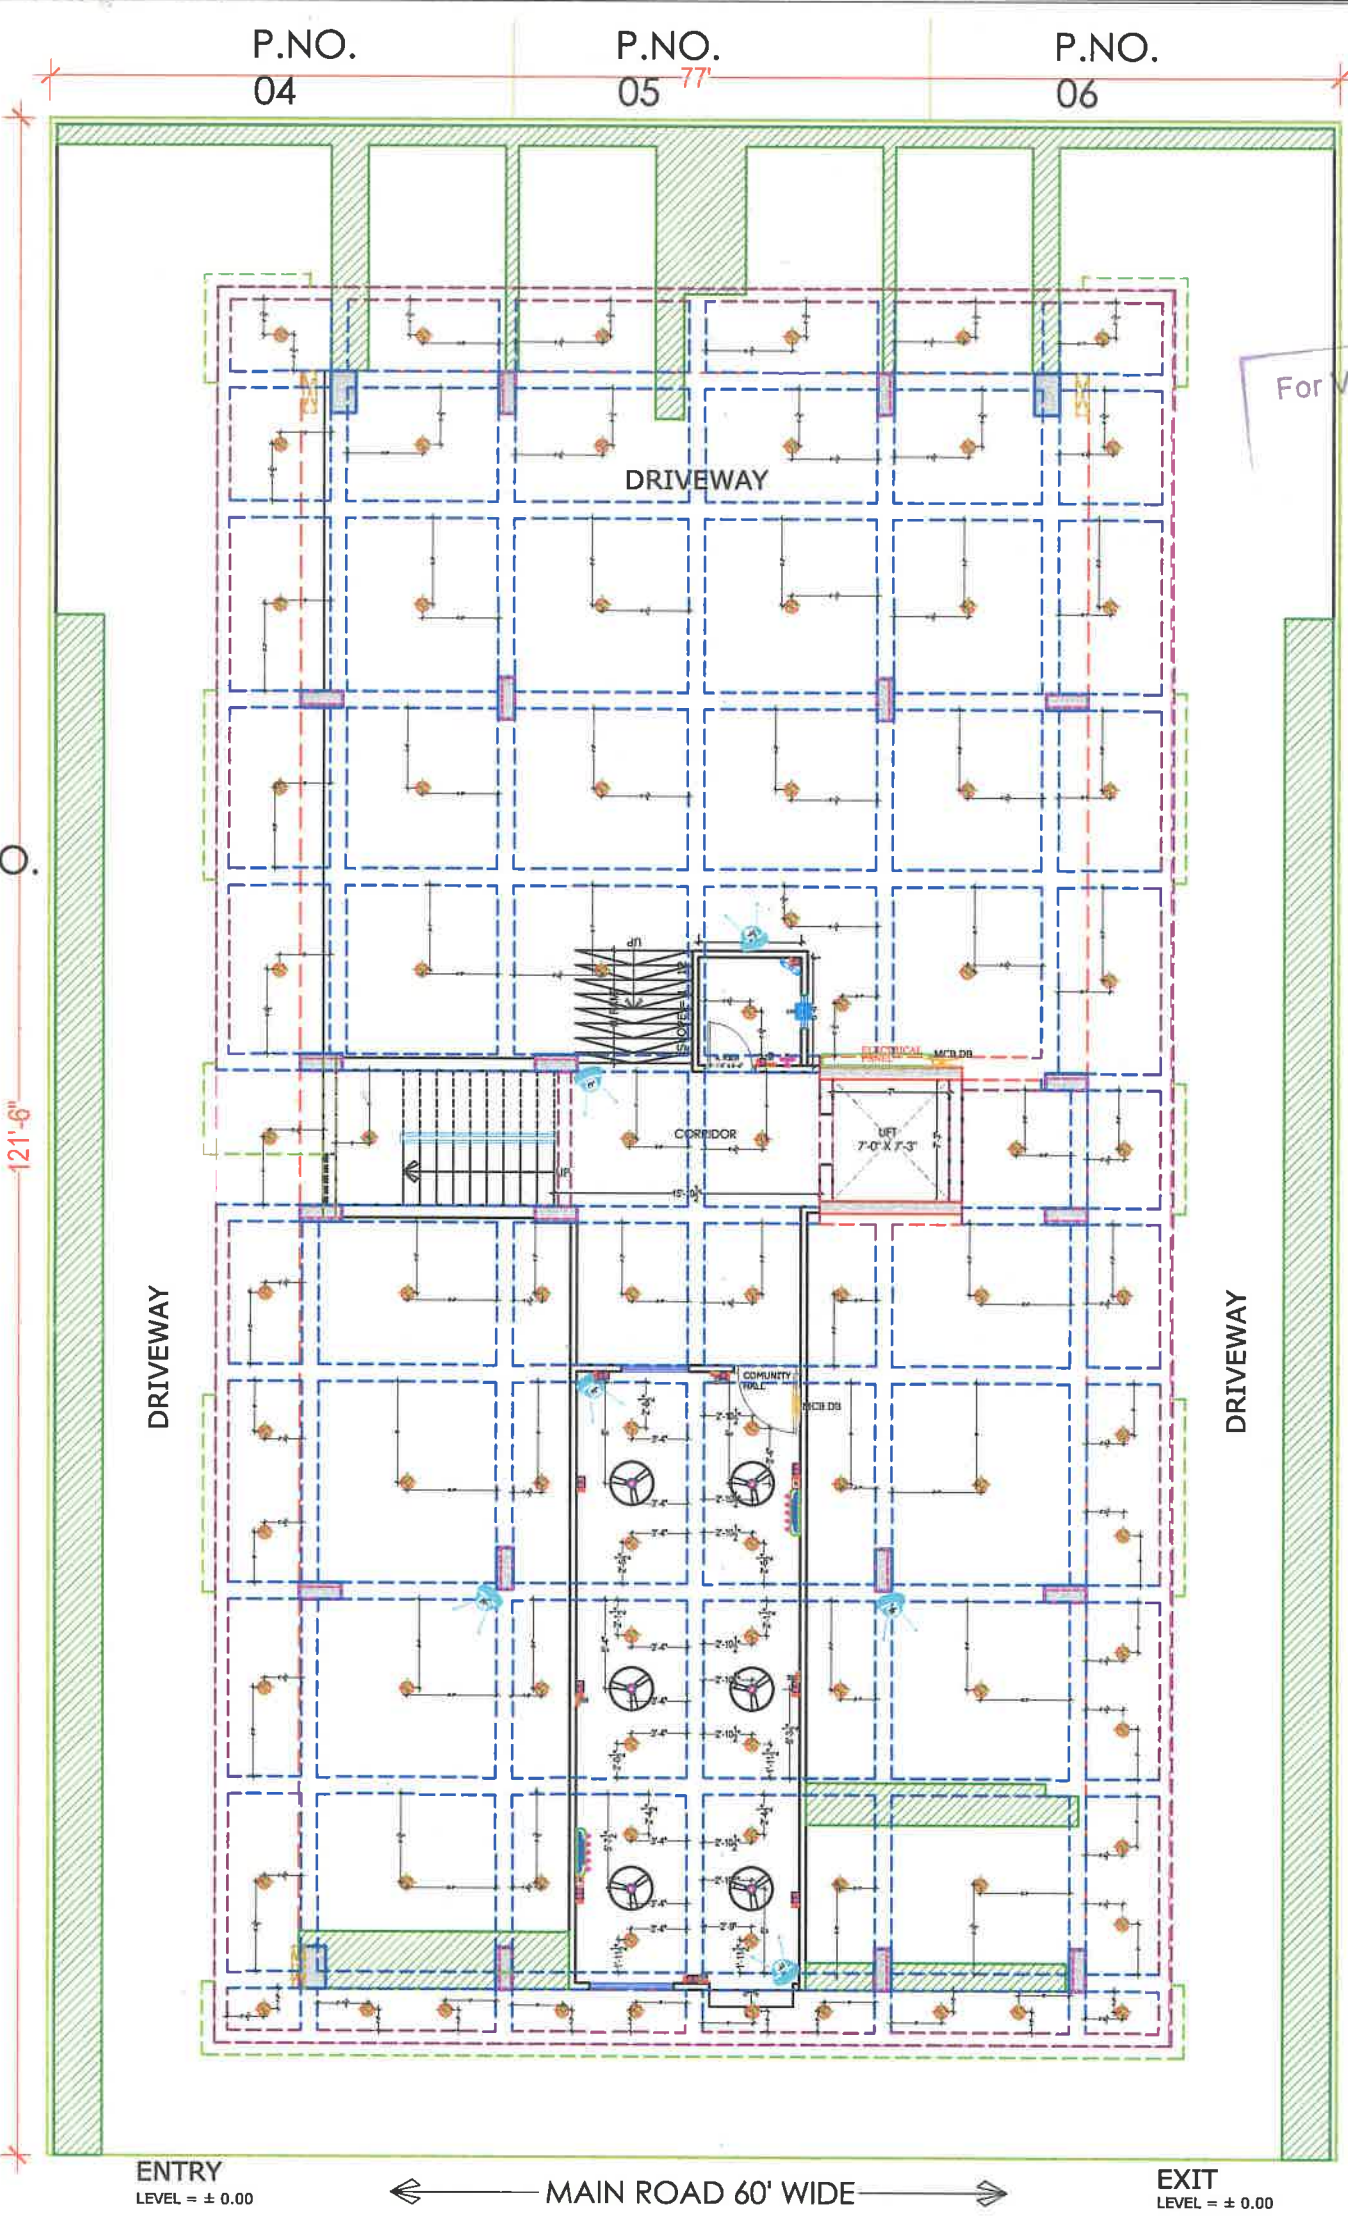

For VINAYAK REAL ESTATE
214
Partner

Er. SANJEEV SHARMA
B.E. (Electrical)

PROJECT NAME :
"UTSAV"
DEVELOPER
NAME :
M/S VINAYAK REAL ESTATE
ARCHITECTS :
INSIDE
ARCHITECTURE N INTERIORS
Plot no. 72, S.P. Marg, C-Scheme
Jaipur, Rajasthan, India
cont: +91 9950595991, 91 9982812777
e-mail: 4insideofficial@gmail.com


Measuring Height	I D	Symbol	Description
CEILING	FAN 4F		CEILING FAN 4F
CEILING	FAN 3F		CEILING FAN 3F
CEILING	CH		CHANDIELIER
+91"	TLW		LED WAS Tube Light Make:- Syde Led Cat no:- SLD-15-20W
+93"	TLB		LED Bulb 20W Make:- Syde Led Cat no:- SLD-20W 3.7U/IC
+93"	OL		WALL BRACKET AS DESIGN FOR CHANDIER LIGHT
+78"	ML		12x2 Led Mirror Light Make:- Syde Led Cat no:- PFL-12x2
CEILING	DL		LED 4" Down Lighter 20W (Surface Mount) Make:- Syde Led Cat no:- SLD-4" 15W 4.0U/IC
VENTILATOR	CR		CEILING ROSE
VENTILATOR	EXP		8" DIA FRESH AIR FAN
+24"	2xSB		2xSWITCH BOARD
+42"	SH		SWITCH BOARD (5A SOCKET & SWITCH)
+24"	TEL		TELEPHONE POINT
+24"	LP TEL		5 A PLUG POINT FOR TELEPHONE
+48"	TV		TV COAXIAL POINT
+48"	LP TV		5 A PLUG POINT FOR TV
+24"	LP		5 A PLUG POINT FOR SIDE TABLE
+72"	LP CH		5 A PLUG POINT FOR CHIMNEY
+12"	LP FC		5 A PLUG FOR COMPUTER POINT
+93"	SAC		SPLIT AC INDOOR UNIT
+42"	PP-MIX		15 A POWER POINT FOR MIXER
+42"	PP-MC		15 A POWER POINT FOR MICROWAVE
+78"	PP-G		15 A POWER POINT FOR GEYSER
+54"	PP-F		15 A POWER POINT FOR FRIDGE
+78"	PP-WP		15 A POWER POINT FOR WATER PUMP
+48"	PP-WM		15 A POWER POINT FOR WASHING MACHINE
+12"	PP-DV		15 A POWER POINT FOR DIVERTOR
+93"	PP-AC		25A SWITCH/MCB FOR AC
	CH		CHAMBER (2' X 2')
+18"	SW		5A 2 HBS. SOCKET +1 NOS. 10A SWITCH, TELEPHONE/LAN
+60"	MCB DB		MCB DISTRIBUTION BOARD
	CA		CAMERA
	WF		WALL FAN

PROJECT:
PROPOSED RESIDENTIAL FLATS ON PLOT
NO.-13A & 14 SCHEME - SUMER NAGR
VISTAR 'N' BLOCK, JAIPUR

NAME OF DRAWING: **STILT FLOOR
CEILING ELECTRICAL LAYOUT,
ELECTRICAL POINT DRAWING,
CAMERA POINT DRAWING**

DRAWING: WORKING DRAWING	NORTH:
PROJECT NO. :	DATE : 19, Feb.- 2024
SCALE : NTS	REV NO. : R-0
DRAWING NO. : 	A-01

STILT FLOOR CEILING ELECTRICAL LAYOUT, ELECTRICAL POINT DRAWING, CAMERA POINT DRAWING

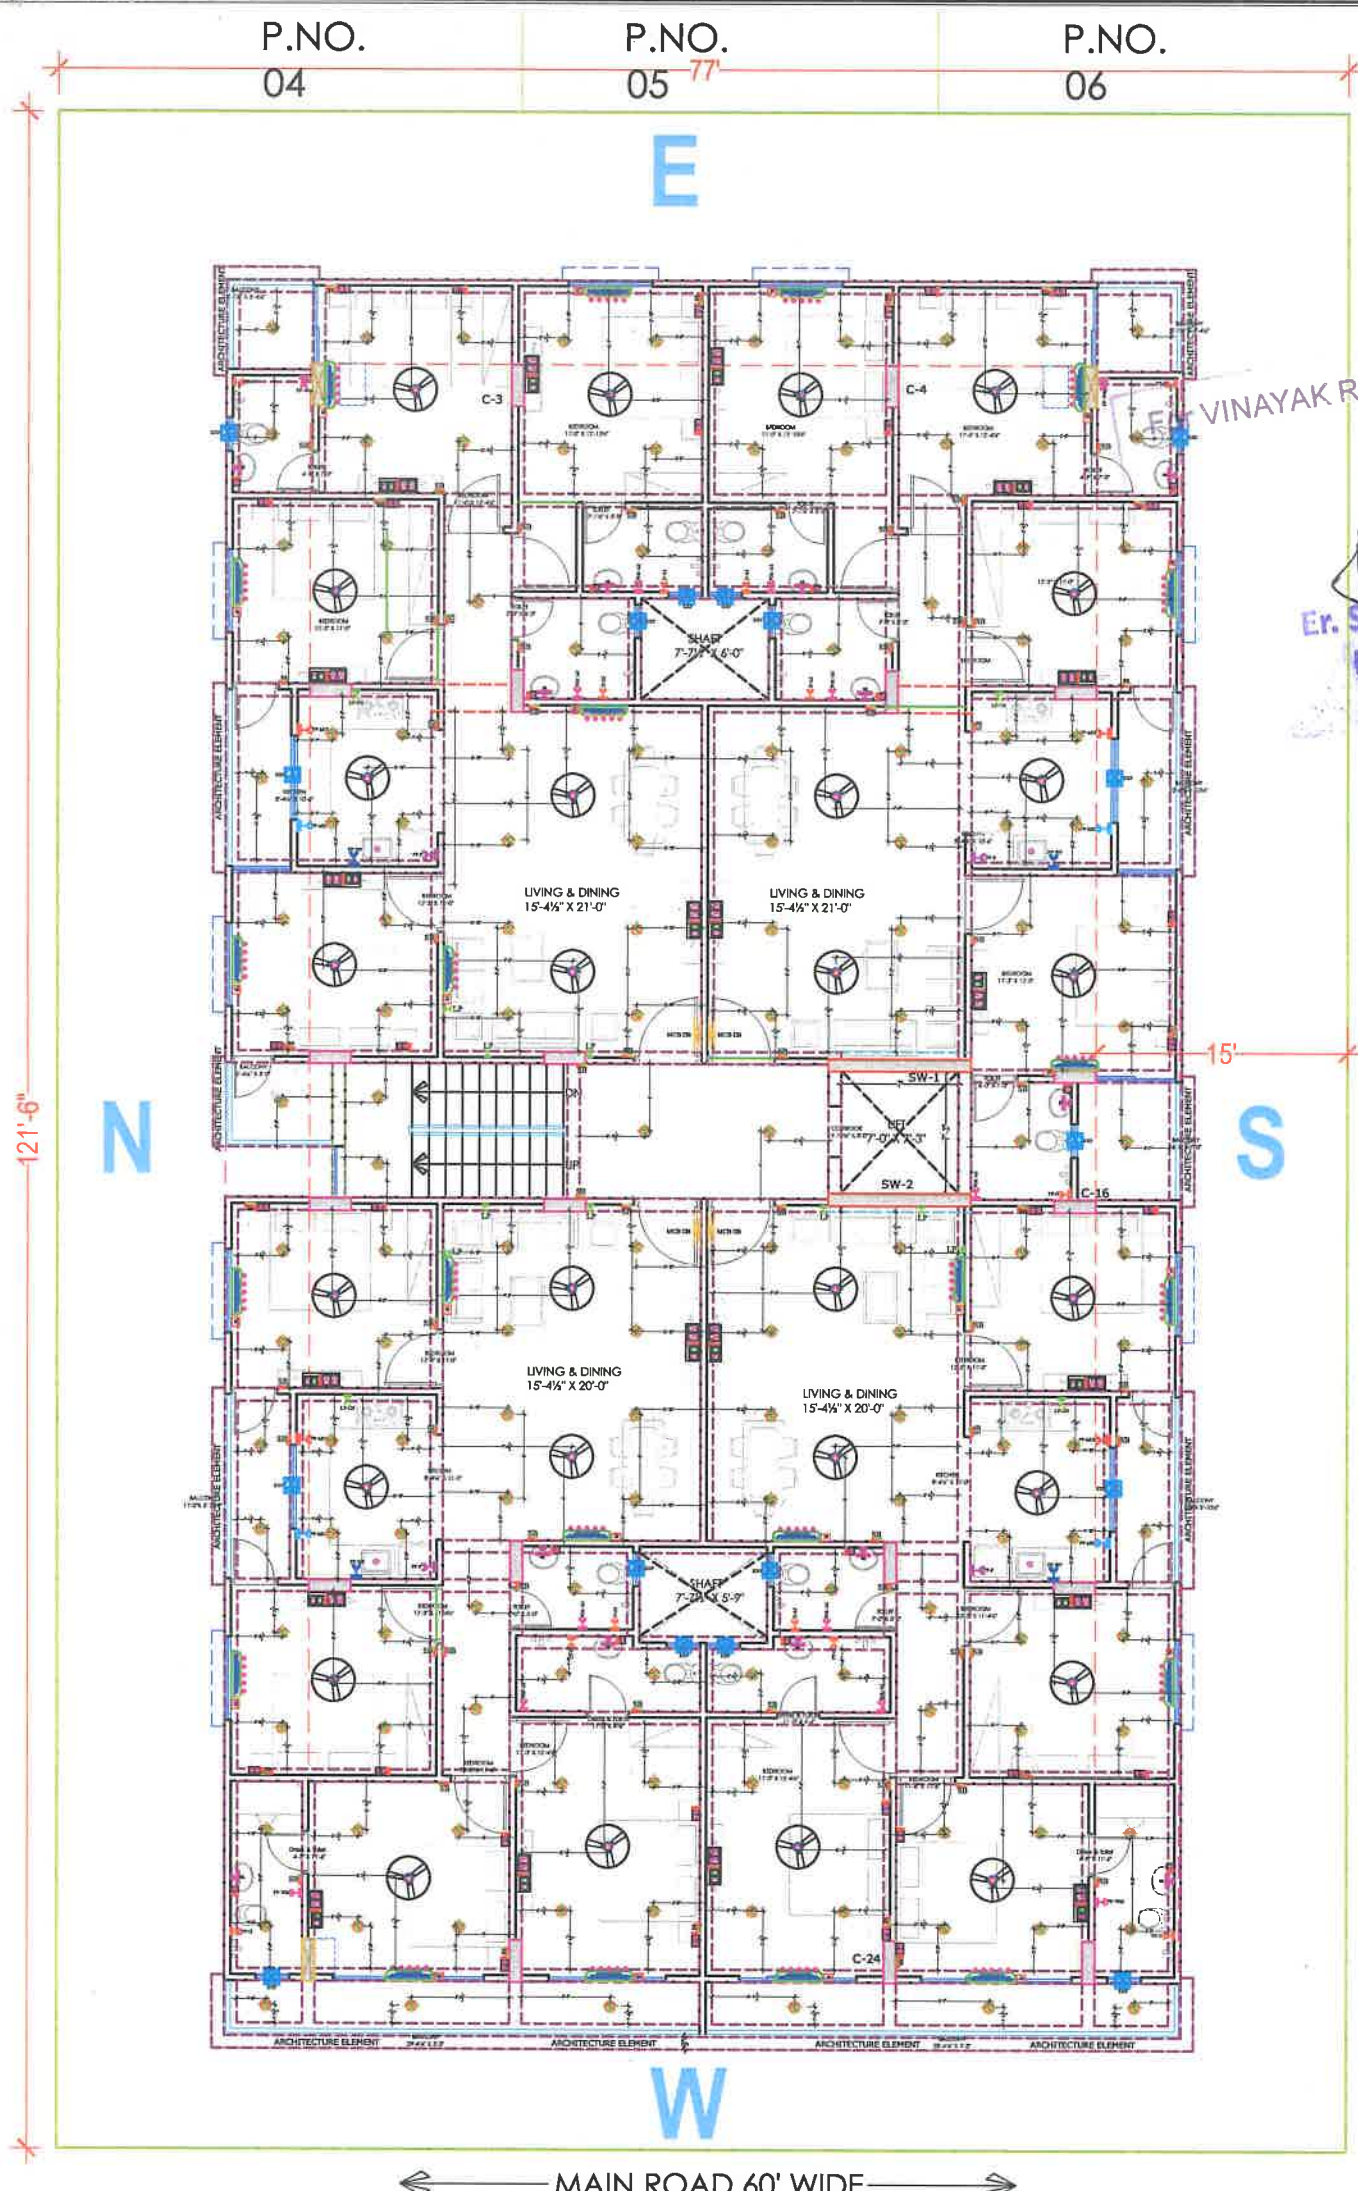

**TYPICAL FLOOR ELECTRICAL LAYOUT G+5
(ELECTRICAL POINT, CEILING POINT, TV)**

PROJECT NAME :
"UTSAV"

DEVELOPER
NAME :
M/S VINAYAK REAL ESTATE

ARCHITECTS :
INSIDE
ARCHITECTURE N INTERIORS
Plot no. 72, S.P. Marg, C- Scheme
jaipur, rajasthan, India
cont: +91 9950595991, 91 9982812777
e-mail: 4insideofficial@gmail.com

VINAYAK REAL ESTATE
Partner

Er. SANJEEV SHARMA
B.E (Electrical)

Measuring Height	I.D	Symbol	Description
CEILING	FAN4F		CEILING FAN 4F
CEILING	FAN30F		CEILING FAN 30F
CEILING	CHI		CHANDLIER
+9'3"	TLW		LED W40 Tube Light Make - SYLVANIA Cat no - SYLV-15-30W
+9'3"	BULB		LED Bulb 30W Make - SYLVANIA Cat no - SYLV-15-30W
+9'3"	OL		WALL BRACKETED ARDENSON FOR GANESH LIGHT
+7'8"	ML		LED Bulb 30W Make - SYLVANIA Cat no - SYLV-15-30W
CEILING	DL		LED 12" Down Lighter 30W (Nuclear Magnetic) Make - SYLVANIA Cat no - SYLV-15-30W
VENTILATOR	IT		CEILING ROOF
VENTILATOR	IT		9" DIA FRESH AIR FAN
+2'4"	2WB		2W SWITCH BOARD
+4'2"	SB		SWITCH BOARD (5A SOCKET & SWITCH)
+2'4"	TEL		TELEPHONE POINT
+2'4"	LP TEL		8 A PLUG POINT FOR TELEPHONE
+4'8"	TV		TV COAXIAL POINT
+4'8"	LP TV		8 A PLUG POINT FOR TV
+2'4"	LP		8 A PLUG POINT FOR SIDE TABLE
+7'2"	LP CH		8 A PLUG POINT FOR CHAIR
+1'2"	LP IC		6 A PLUG FOR COMPUTER POINT
+9'3"	SAC		SPLIT AC INDOOR UNIT
+4'2"	PP-MIX		16 A POWER POINT FOR MIXER
+4'2"	PP-MIC		16 A POWER POINT FOR MICROWAVE
+7'8"	PP-G		16 A POWER POINT FOR GEYSER
+5'4"	PP-F		16 A POWER POINT FOR FRIDGE
+7'8"	PP-WP		16 A POWER POINT FOR WATER PUMP
+4'8"	PP-WM		16 A POWER POINT FOR WASHING MACHINE
+1'2"	PP-INV		16 A POWER POINT FOR INVERTER
+9'3"	PP-AC		25A SWITCH/ACB FOR AC
			CHAMBER (2' X 2')
+1'8"			8A 2 NOS. SOCKET + 1 NOS. 16A SWITCH TELEPHONE LANE
+6'0"	MCB DB		MCB DISTRIBUTION BOARD
			CAMERA
			WALL FAN

PROJECT:
PROPOSED RESIDENTIAL FLATS ON PLOT
NO.-13A & 14 SCHEME - SUMER NAGR
VISTAR 'N' BLOCK, JAIPUR

NAME OF DRAWING: **TYPICAL FLOOR
ELECTRICAL LAYOUT G+5
(ELECTRICAL POINT,
CEILING POINT, TV)**

DRAWING
WORKING DRAWING


PROJECT NO. :
DATE :
19, Feb.- 2024

SCALE :
NTS

REV NO. :
R-0

DRAWING NO. :

A-01

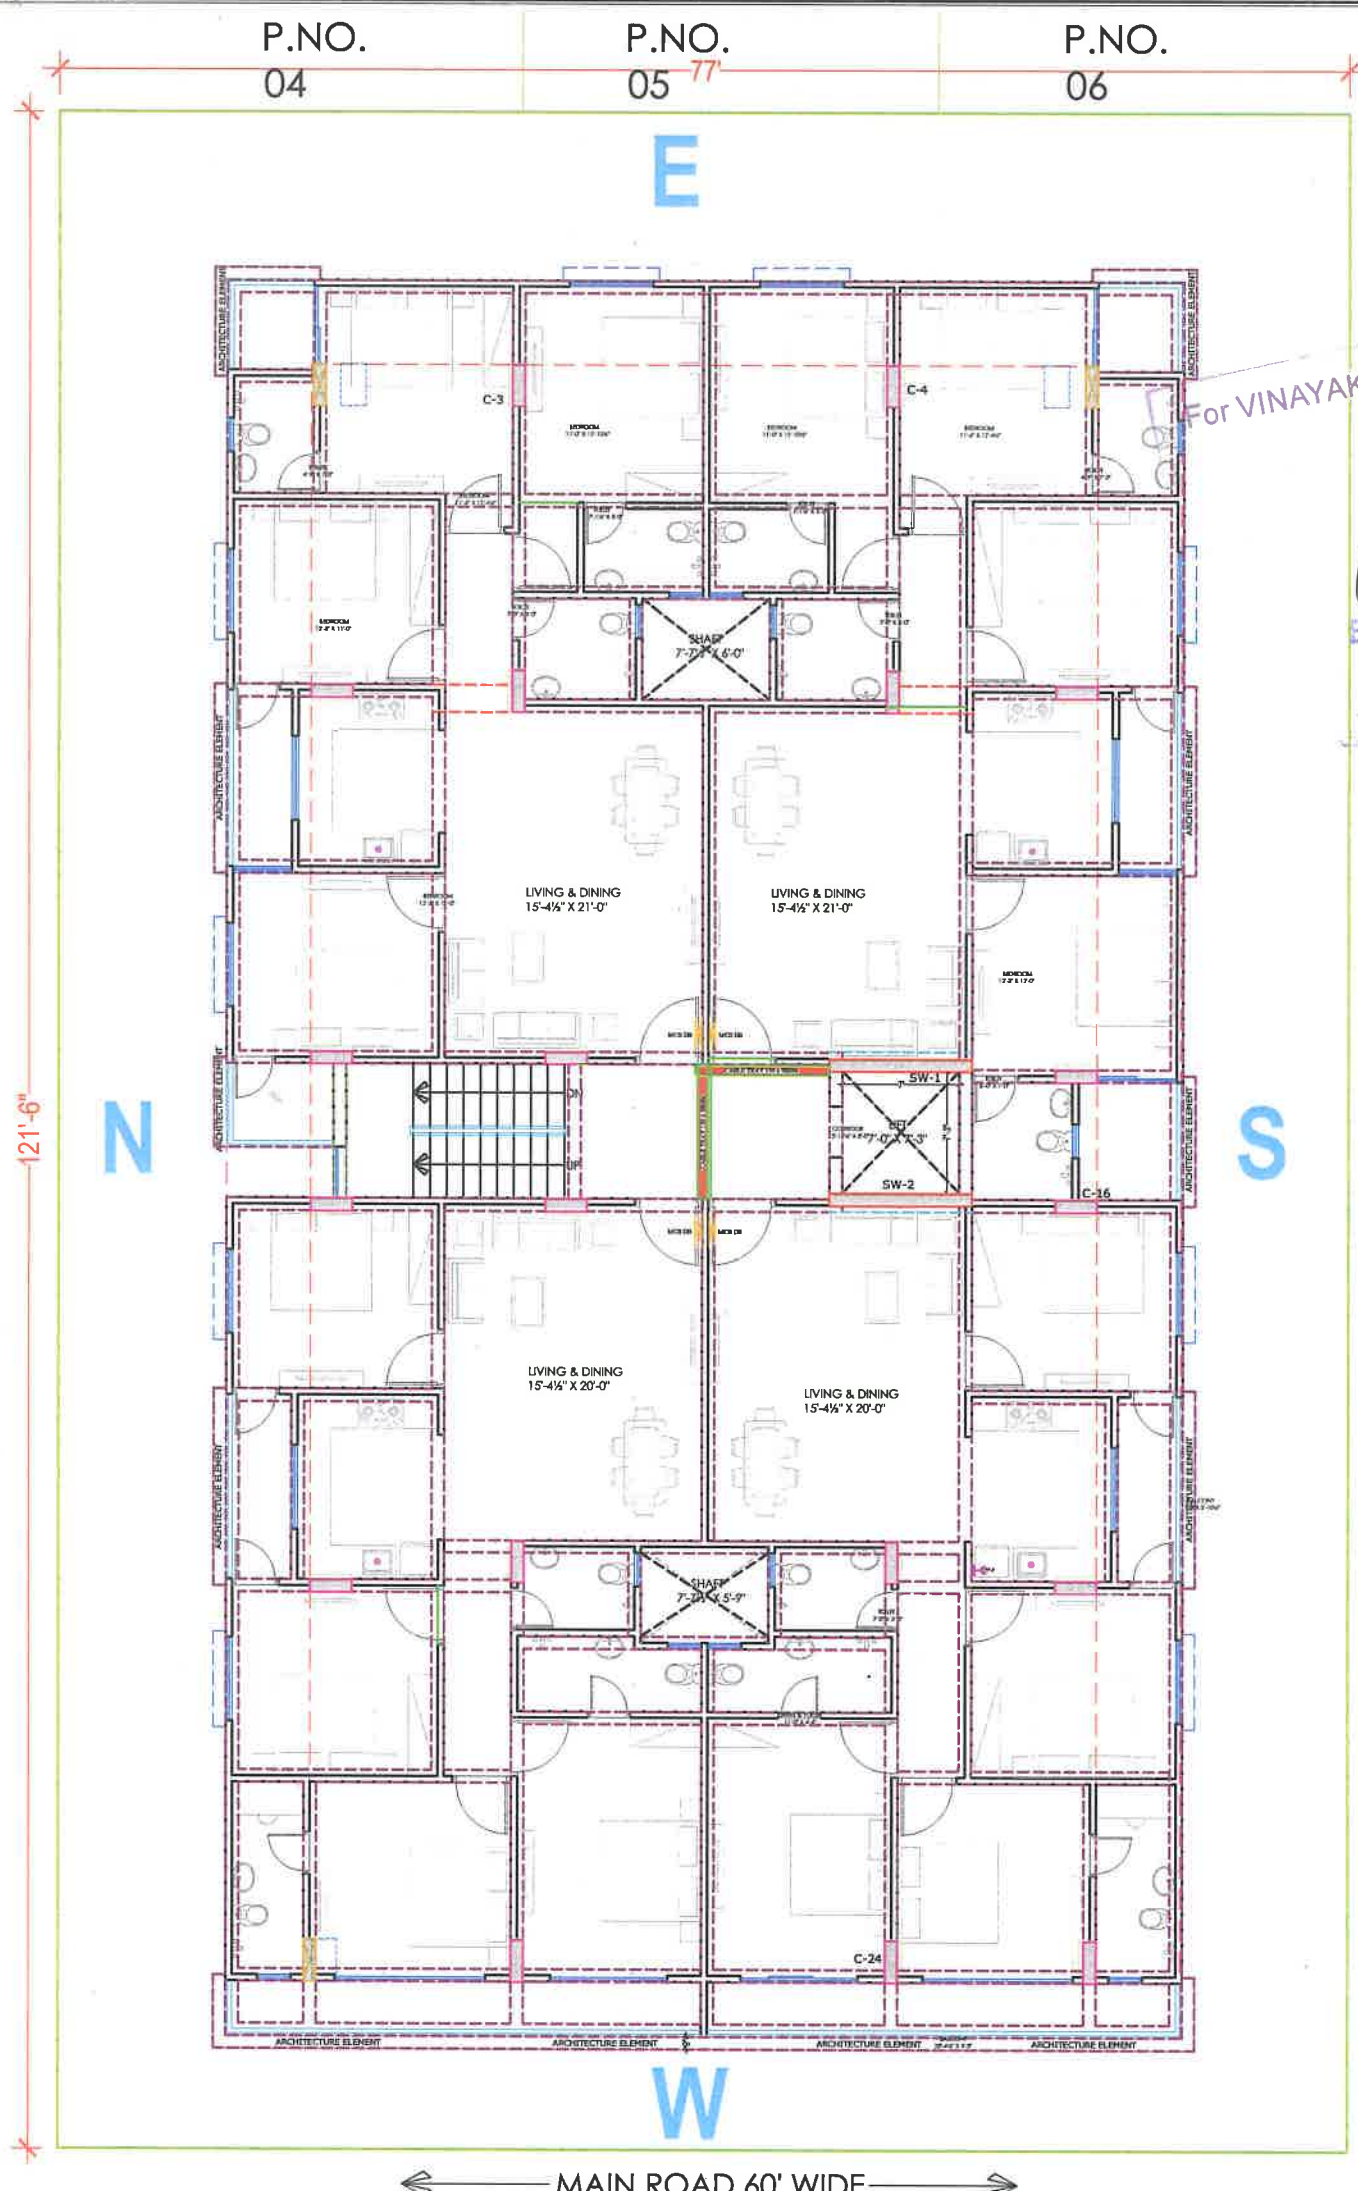

TYPICAL FLOOR G+5
ELECTRICAL CABLES, ELECTRICAL DB, ELECTRICAL SHAFT, CABLE TRAY

PROJECT NAME :
"UTSAV"

DEVELOPER
NAME :
M/S VINAYAK REAL ESTATE

ARCHITECTS :
INSIDE
ARCHITECTURE N INTERIORS
Plot no. 72, S.P. Marg, C- Scheme
Jaipur, Rajasthan, India
cont: +91 9950595991, 91 9982812777
e mail: 4insideofficial@gmail.com

For VINAYAK REAL ESTATE

Partner

Mr. SANJEEV SHARMA
B.E (Electrical)

Measuring Height	I.D	Symbol	Description
CEILING	FAN 4P		CEILING FAN 4P
CEILING	FAN 3P		CEILING FAN 3P
CEILING	CH 1		CHANDLIER
+93"	TLW		LED Wall Tube Light Make:- Syba Led Cat no:- SLC-TS-20W
+93"	BULB		LED Bulb 20W Make:- Syba Led Cat no:- SLC-20W 5.7K/7K
+93"	GL		WALL BRACKETS AS DESIGN FOR GUANSHI LIGHT
+78"	ML		12x12 Led Mirror Light Make:- Syba Led Cat no:- PPL-12x12
CEILING	DL		LED 6" Down Lighter 20W (Surface Mounted) Make:- Syba Led Cat no:- SFL-6" 15W OLD & NEW
VENTILATOR	RT		CEILING ROSE
VENTILATOR	HT		8" DIA FRESH AIR FAN
+24"	2WB		2W SWITCH BOARD
+42"	SB		SWITCH BOARD (A SOCKET & SWITCH)
+24"	TEL		TELEPHONE POINT
+24"	LP TEL		8 A PLUG POINT FOR TELEPHONE
+48"	TV		TV COAXIAL POINT
+48"	LP TV		8 A PLUG POINT FOR TV
+24"	LP		8 A PLUG POINT FOR SIDE TABLE
+72"	LP CH		8 A PLUG POINT FOR CHAIR
+12"	LP PC		8 A PLUG POINT FOR COMPUTER POINT
+93"	SAC		SPLIT AC INDOOR UNIT
+42"	PP-MIX		16 A POWER POINT FOR MIXER
+42"	PP-MIC		16 A POWER POINT FOR MICROWAVE
+78"	PP-O		16 A POWER POINT FOR OVEN
+54"	PP-F		16 A POWER POINT FOR FRIDGE
+78"	PP-WP		16 A POWER POINT FOR WATER PURIFIER
+48"	PP-WM		16 A POWER POINT FOR WASHING MACHINE
+12"	PP-INV		16 A POWER POINT FOR INVERTER
+93"	PP-AC		25A SWITCH/ACB FOR AC
			CHAMBER (2' X 2')
+18"			8x 2 NOS. SOCKET + 1 NOS. 16A SWITCH TELEPHONE/LAN
+60"	MCB DB		MCB DISTRIBUTION BOARD
			CAMERA
			WALL FAN

PROJECT:
PROPOSED RESIDENTIAL FLATS ON PLOT NO.-13A & 14 SCHEME - SUMER NAGR VISTAR 'N' BLOCK, JAIPUR

NAME OF DRAWING:
TYPICAL FLOOR G+5
ELECTRICAL CABLES, ELECTRICAL DB, ELECTRICAL SHAFT, CABLE TRAY

DRAWING:
WORKING DRAWING

NORTH:

PROJECT NO. :

DATE :
19, Feb.- 2024


SCALE :
NTS

REV NO. :
R-0

DRAWING NO. :

A-01

MAIN PANEL

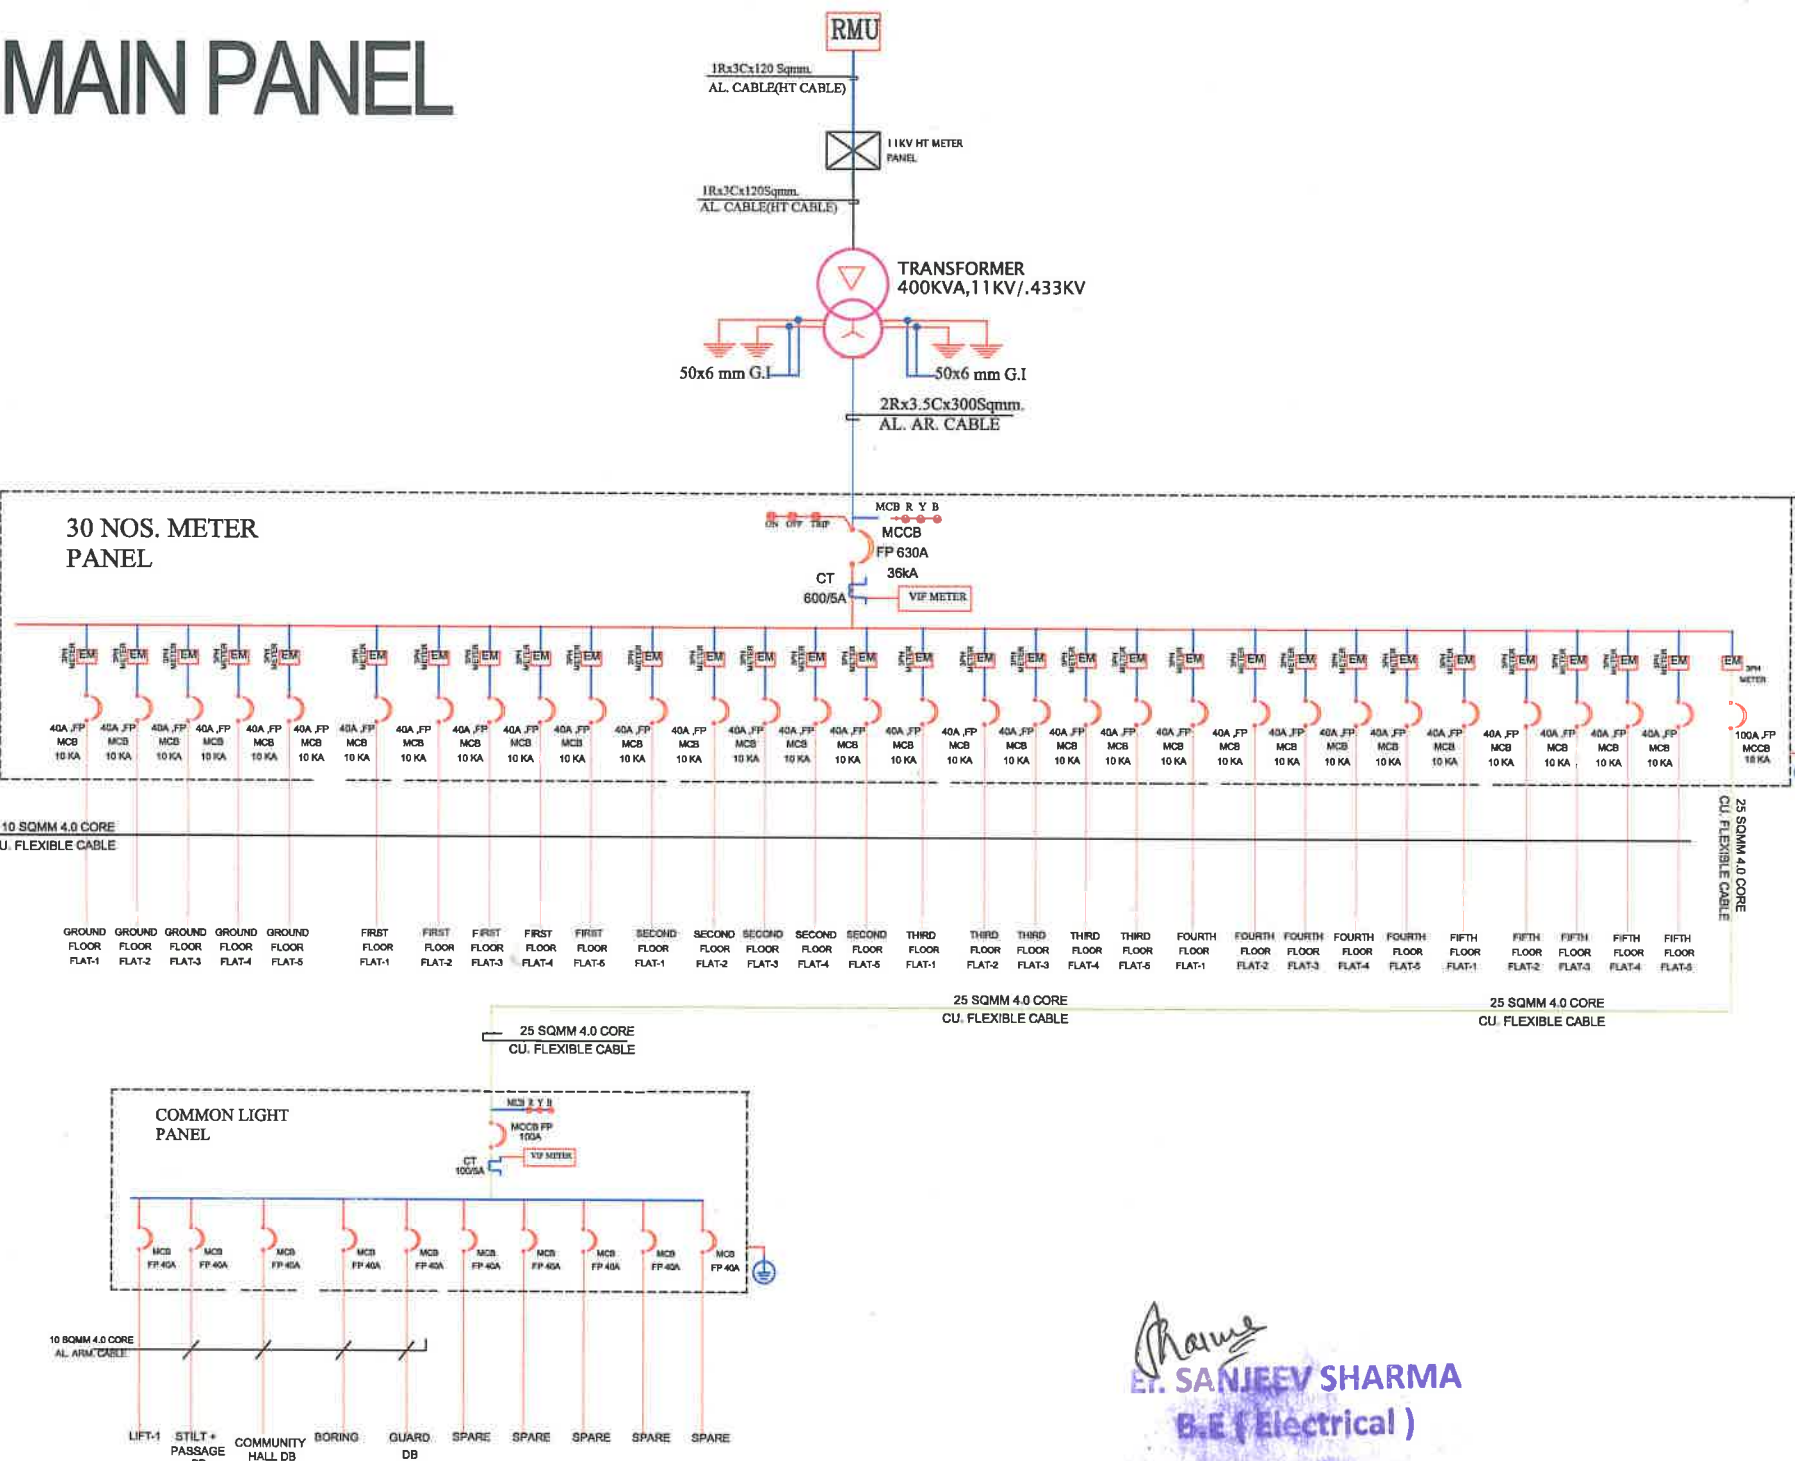

PROJECT NAME :
"UTSAV"
DEVELOPER
NAME :
M/S VINAYAK REAL ESTATE
ARCHITECTS :
INSIDE
ARCHITECTURE N INTERIORS
Plot no. 72, S.P. Marg, C-Scheme
jaipur, rajasthan, India
cont: +91 9950595991, 91 9982812777
e-mail: 4insideofficial@gmail.com

Measuring Height	I D	Symbol	Description
CEILING	FAN 4"		CEILING FAN 4"
CEILING	FAN 36"		CEILING FAN 36"
CEILING	CHI		CHANDLIER
+93"	TLW		LED Tube Light (Make: Syde Ltd Cat no. SDC-TS-3PW)
+93"	BULB		LED Bulb 25W (Make: Syde Ltd Cat no. SDC-25W-17C-3K)
+93"	GL		WALL BRACKET & 8.5 INCH BULB (Make: Syde Ltd Cat no. SDC-8.5-17W-17C-3K-4K)
+78"	ML		12x2 Led Mirror Light (Make: Syde Ltd Cat no. SDC-12x2-17W-17C-3K-4K)
CEILING	DL		LED 6" Down Light 20W (Make: Syde Ltd Cat no. SDC-6-17W-17C-3K-4K)
VENTILATOR HT.	CH		CEILING ROSE
VENTILATOR HT.	EXP		6" DIA FRESH AIR FAN
+24"	2WB		2 SWITCH BOARD
+42"	SB		SWITCH BOARD (5A SOCKET & SWITCH)
+24"	TBL		TELEPHONE POINT
+24"	LP TEL		6 A PLUG POINT FOR TELEPHONE
+48"	TV		6 A PLUG POINT FOR TV
+48"	LP TV		6 A PLUG POINT FOR TV
+24"	LP		6 A PLUG POINT FOR SIDE TABLE
+72"	LP-CH		6 A PLUG POINT FOR CHIMNEY
+12"	LP-PC		6 A PLUG POINT FOR COMPUTER
+93"	SAC		SPLIT AC INDOOR UNIT
+42"	PP-MIX		15 A POWER POINT FOR MIXER
+42"	PP-MC		15 A POWER POINT FOR MICROWAVE
+78"	PP-G		15 A POWER POINT FOR GEYSER
+54"	PP-F		15 A POWER POINT FOR FRIDGE
+78"	PP-WP		15 A POWER POINT FOR WATER PUMP
+48"	PP-WM		15 A POWER POINT FOR WASHING MACHINE
+12"	PP-INV		15 A POWER POINT FOR INVERTER
+93"	PP-AC		25A SWITCH/MCB FOR AC
			CHAMBER (2' x 2')
+18"			IN 2 NOS. SOCKET + 1 MCB 10A SWITCH, TELEPHONE, LAN
+60"	MCB DB		MCB DISTRIBUTION BOARD
			CAMERA
			WALL FAN

PROJECT:
PROPOSED RESIDENTIAL FLATS ON PLOT NO.-13A & 14 SCHEME - SUMER NAGR VISTAR 'N' BLOCK, JAIPUR

NAME OF DRAWING:
MAIN PANEL(SLD/DISTRIBUTION DETAILS AFTER LT PANEL

DRAWING WORKING DRAWING	NORTH:
PROJECT NO. :	DATE : 19, Feb.- 2024
SCALE : NTS	REV NO. : R-0
DRAWING NO. : PROJECT CATEGORY BLOCK FLOOR TYPE WARD	
A-01	

SINGLE LINE DIAGRAM
MAIN PANEL(SLD/DISTRIBUTION DETAILS AFTER LT PANEL

For VINAYAK REAL ESTATE
Partner