

9.14m wide side road



Vipul
VIPUL AGARWAL
M.E.P. CONSULTANT
B.E. ELECTRICAL

SYMBOL	DESCRIPTION
	110 mm Soil Waste Water Pipe
	110 mm Waste Water Pipe
	110 mm Rain Water Pipe
	160 mm Soil Waste Water Pipe
	160 mm Waste Water Pipe
	160 mm Rain Water Pipe
	110 mm Rain Water Pipe

PROJECT ADD. :-
Khasra no/ plot no A-6,7,8,9,10,&11/547,
550,to 555, 557,and 558, Pragti Nagar, Kotra
Scheam , Ajmer-305004 (Rajasthan)

PROJECT NAME:-

SKY TOWER

DRAWING

BASEMENT FLOOR
DRAINAGE PIPE
ROUTE PLAN

DRAWN:-
RAAJ
APPD:-
SANJAY
VIPUL AGARWAL

SERVICES CONSULTANT:
VIPUL CONSULTING,
F 9 / 440 , Keshav Marg Chitrakut
Scheme,Jaipur
PH:91-0-93146-10438 ,0141-2440946
Mail:vipul8599@yahoo.com
REV. NO. 00,DATE:-18-02-2019


ARCHITECT:
studio RKR architecture
plot no. G-14, jan path, near dana pani restaurant
shyam nagar, jaipur, rajasthan, India
cont: 098286 00550
e.mail: rajoriyarajesh@yahoo.co.in

NORTH

NO. OF CARS = 25
NO. OF SCOOTERS = 30


9.14m wide back road

9.14m wide side road

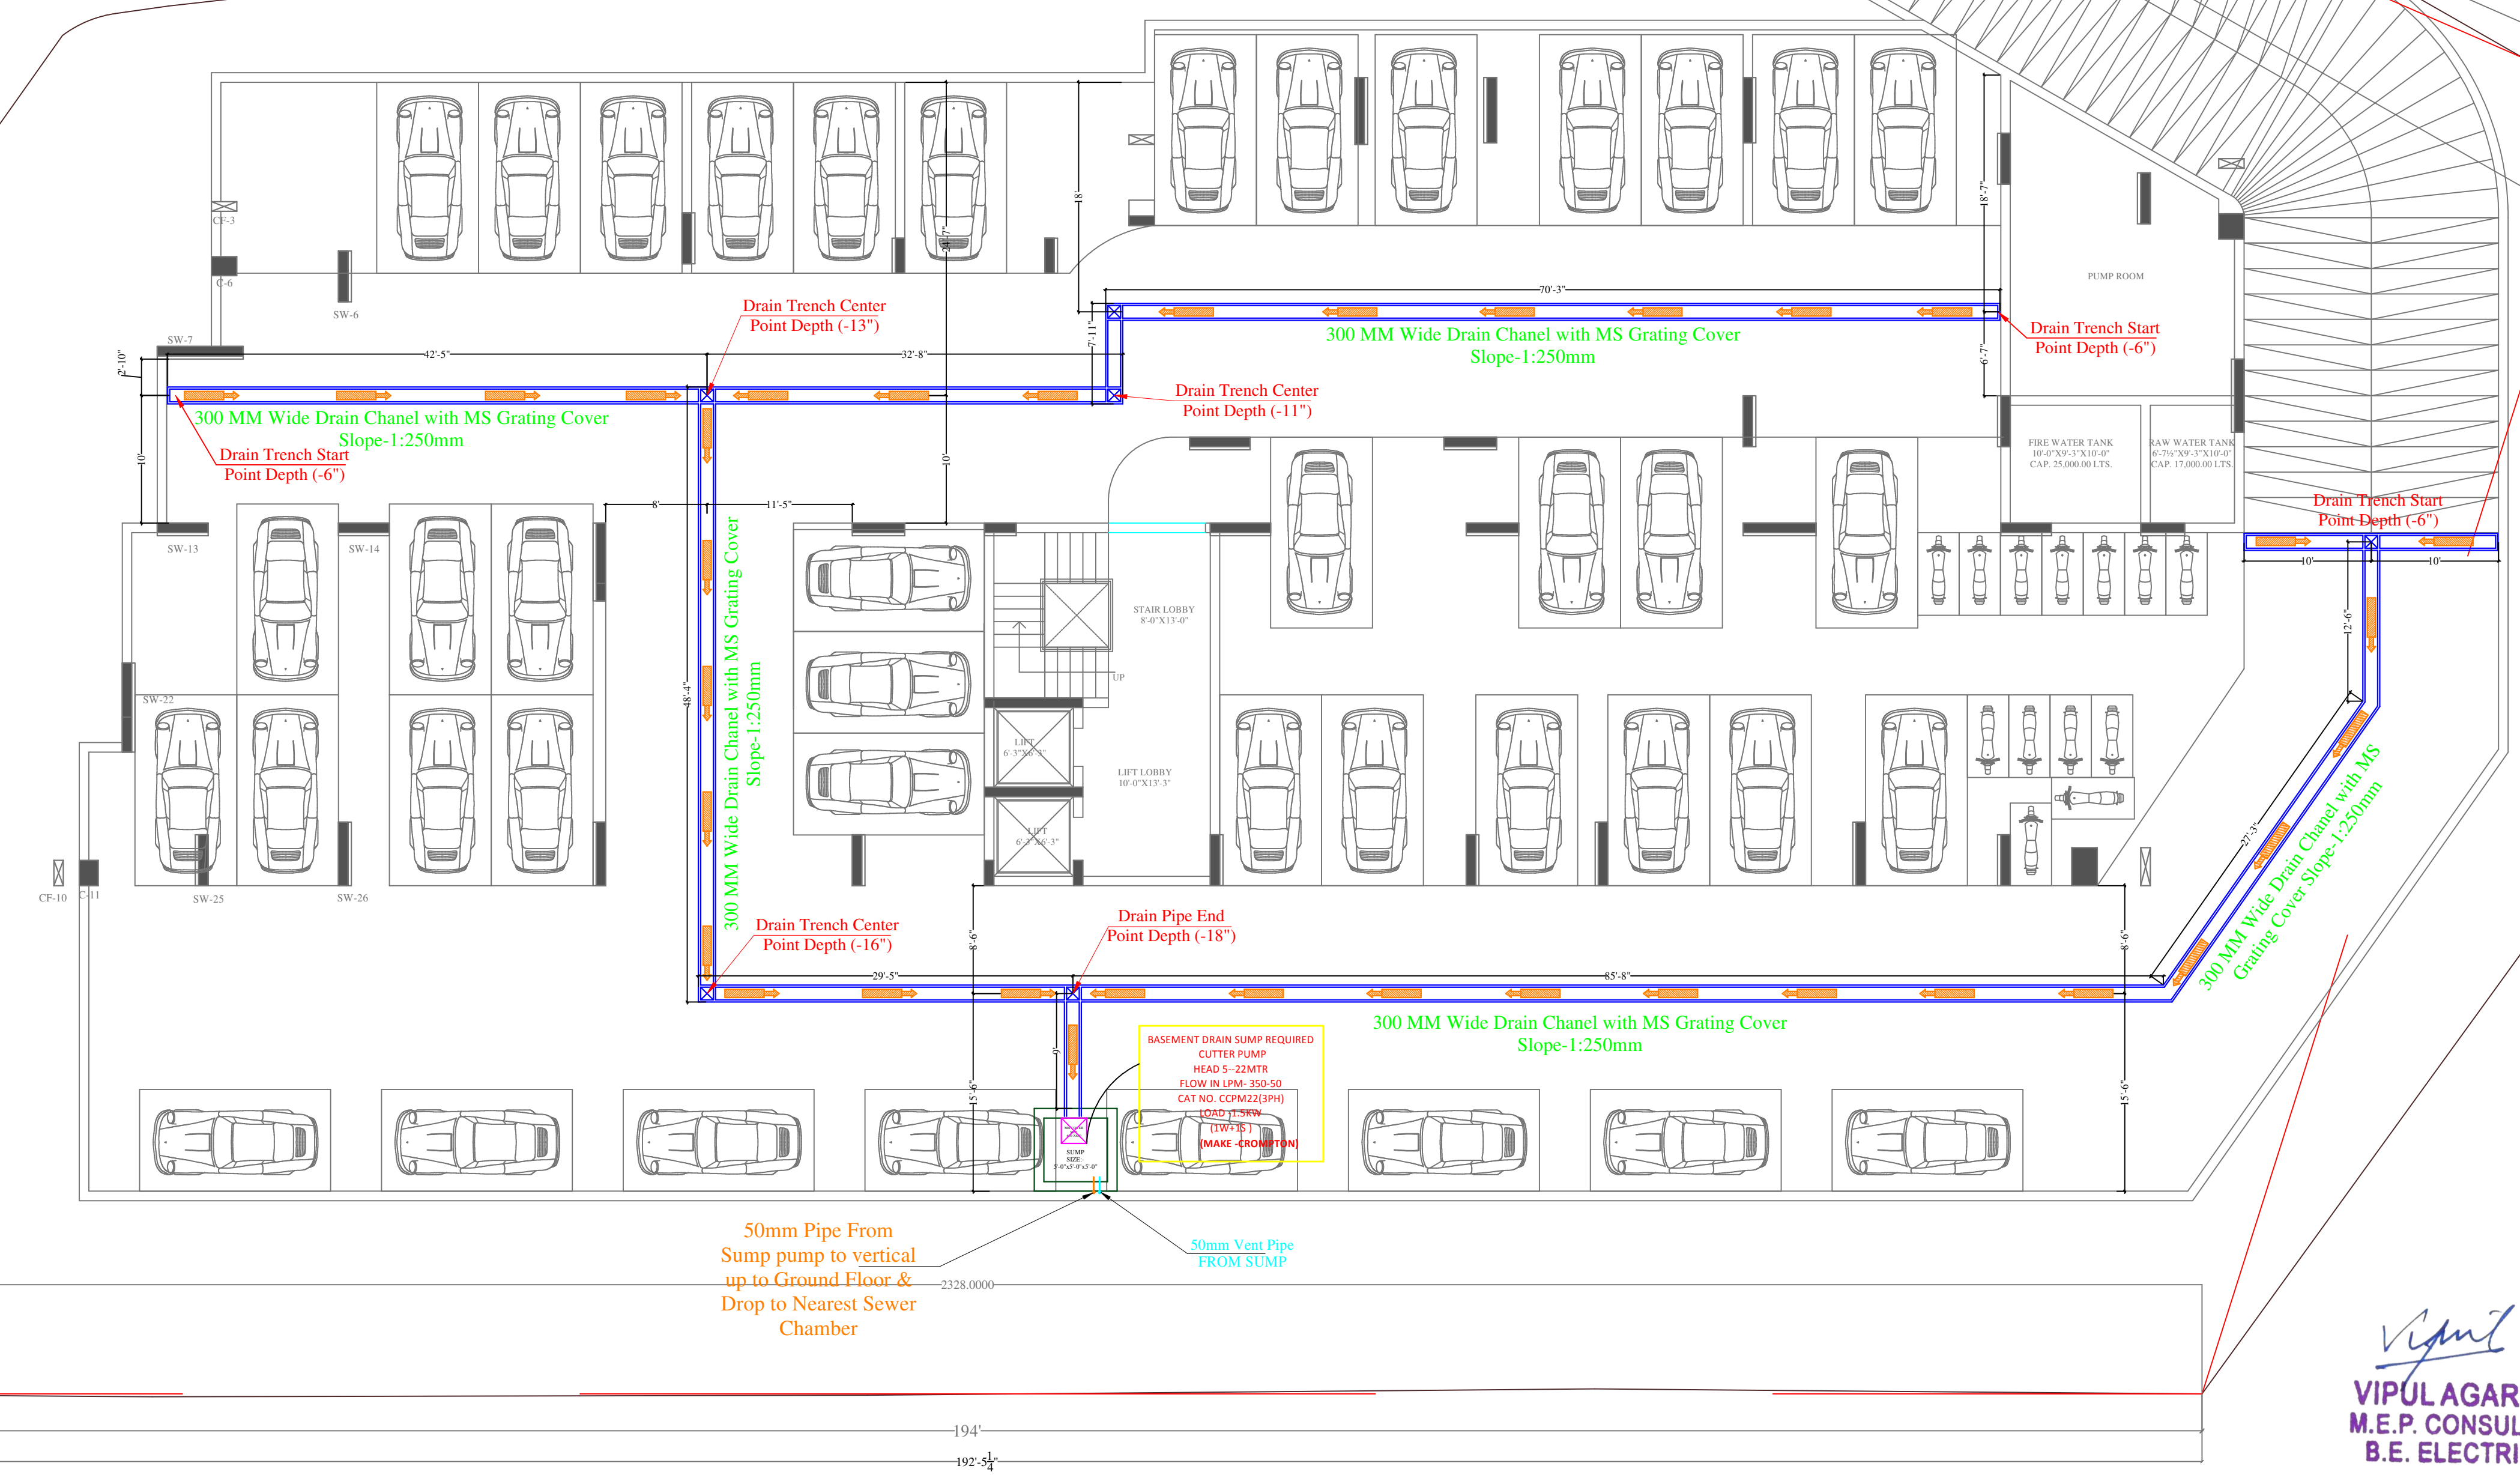

Vipul
VIPUL AGARWAL
M.E.P. CONSULTANT
B.E. ELECTRICAL

18.28m wide side road

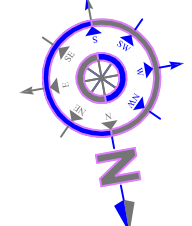PROJECT ADD. :- Khasra no/ plot no A-6,7,8,9,10,&11/547, 550,to 555, 557,and 558, Pragti Nagar, Kotra Scheam , Ajmer-305004 (Rajasthan)	PROJECT NAME:- SKY TOWER DRAWING BASEMENT FLOOR DRAIN TRENCH PLAN	DATE: 06-08-2021 SERVICES CONSULTANT: VIPUL CONSULTING, F 9 / 440 , Keshav Marg Chitrakut Scheme,Jaipur PH:91-0-93146-10438 ,0141-2440946 Mail:vipul8599@yahoo.com REV. NO. 00,DATE:-06-08-2021	ARCHITECT: studio RKR architecture plot no. G-14, jan path, near dana pani restaurant shyam nagar, jaipur, rajasthan, India cont: 098286 00550 e.mail: rajoriyarajesh@yahoo.co.in	NORTH 
--	---	---	--	--



Vipul
VIPUL AGARWAL
M.E.P. CONSULTANT
B.E. ELECTRICAL

STANDARDS SANITARY APPLIANCES HEIGHTS AS PER AR DETAILS		
S.NO	SYMBOL	DESCRIPTION
1		WASH BASIN MIXER
2		WASH BASIN ANGLE VALVE
3		BOTTLE TRAP
4		MIRROR (45X45mm BOTTOM)
5		OVER HEAD SHOWER
6		WALL MIXER DIVERTOR
7		TAP FOR BATH AREA
8		SOAP DISH
9		TOWEL RAIL
10		Health Facet Hand Shower
11		PAPER HOLDER
12		ANGLE VALVE FOR GEYSER
13		CANCELLED STOP COCK
14		CISTERN ANGLE VALVE
15		KITCHEN SINK MIXER
16		ANGLE VALVE FOR WATER PURIFIER
17		TAP FOR BALCONY WASHING
Floor Trap		
Cold Water Supply		
Hot Water Line - Internal		
Cold Water Line - Internal		
SERVICES CONSULTANT: VIPUL CONSULTING, F 9 / 440 , Keshav Marg Chitrakut Scheme,Jaipur PH-91-0-93146-10438 ,0141-2440946 Multi:ipul5599@yahoo.com REV. NO. 00 DATE: 24-12-2019		

PROJECT NAME:-

SKY TOWER

PROJECT ADD. :-

Khasra no/ plot no A-6,7,8,9,10,&11/547, 550,to 555, 557, and 558, Pragti Nagar, Kotra Scheam , Ajmer-305004 (Rajasthan)

TYPICAL FLOOR INTERNAL PLUMBING PLAN			
NAME OF DRAWING:	PROJ. NO.- PA-06_17	DRAWING NO.	NORTH
SCALE 1" : 8'-0"	DEALT BY.- RAAJ	CEN-02	
DATE 24-12-2019	CHKD BY.- SANJAY APPD BY.- VIPUL AGARWAL		

GENERAL NOTES

1. ALL DIMENSION ON THIS DRAWING ARE IN FEET AND INCHES
2. ONLY WRITTEN DIMENSIONS ARE TO BE FOLLOWED. DRAWINGS SHOULD NOT BE SCALED UNDER ANY CIRCUMSTANCES.
3. ALL MEASUREMENTS MUST BE CHECKED AND VERIFIED BY THE CONTRACTORS PRIOR TO EXECUTION OF WORK AT THE SITE.
4. THIS DRAWING IS TO BE READ IN CONJUNCTION WITH ALL RELEVANT STRUCTURAL, SERVICES & FACILITY PLANNING DRAWINGS.
5. ARCHITECTURAL DRAWINGS ARE TO BE FOLLOWED FOR THE LOCATION OF ALL STRUCTURAL MEMBERS & MASONRY WALLS, FOR SIZES & REINFORCEMENT DETAILS OF STRUCTURAL MEMBERS. RELEVANT STRUCTURAL DRAWINGS ARE TO BE REFERRED.
6. ANY DISCREPANCIES BETWEEN ARCHITECTURAL, STRUCTURAL AND SERVICES DRAWINGS MUST BE BROUGHT TO THE NOTICE OF THE ARCHITECTS IMMEDIATELY & PRIOR TO EXECUTION AT SITE.
7. CO-ORDINATIO WITH SERVICES SUCH AS HVAC, PLUMBING & ELECTRICAL, ETC. IS THE RESPONSIBILITY OF THE CONTRACTORS.
8. ALL MASONRY WALLS SHOULD BE ALIGNED WITH THE COLUMNS AS INDICATED ON THE PLAN, IRRESPECTIVE OF THE POSITION AS CALCULATED WITH THE DIMENSIONING.
9. FURNITURE/FIXTURES SHOWN ARE INDICATIVE ONLY PLEASE REFER RESPECTIVE SCHEDULES
10. THIS DRAWING IS THE PROPERTY OF **IMAGINE ARCHITECTURE**.AND NOT TO BE COPIED OR USED WITHOUT THEIR PERMISSION

REVISION LEGEND


S.NO.	DATE	DESCRIPTION
01		
02		

ARCHITECT:

STUDIO rkr architecture

plot no. G-14,Siddharth Apartment,
opp. Dana Pani Restaurant, Jan Path
Shyam Nagar, jaipur , rajasthan, India
cont: 0141-2297446

R. - 098286 00550 H. - 9636020090
e.mail: info@imaginearchitecture.co.in;
rajoriyarajesh@yahoo.co.in

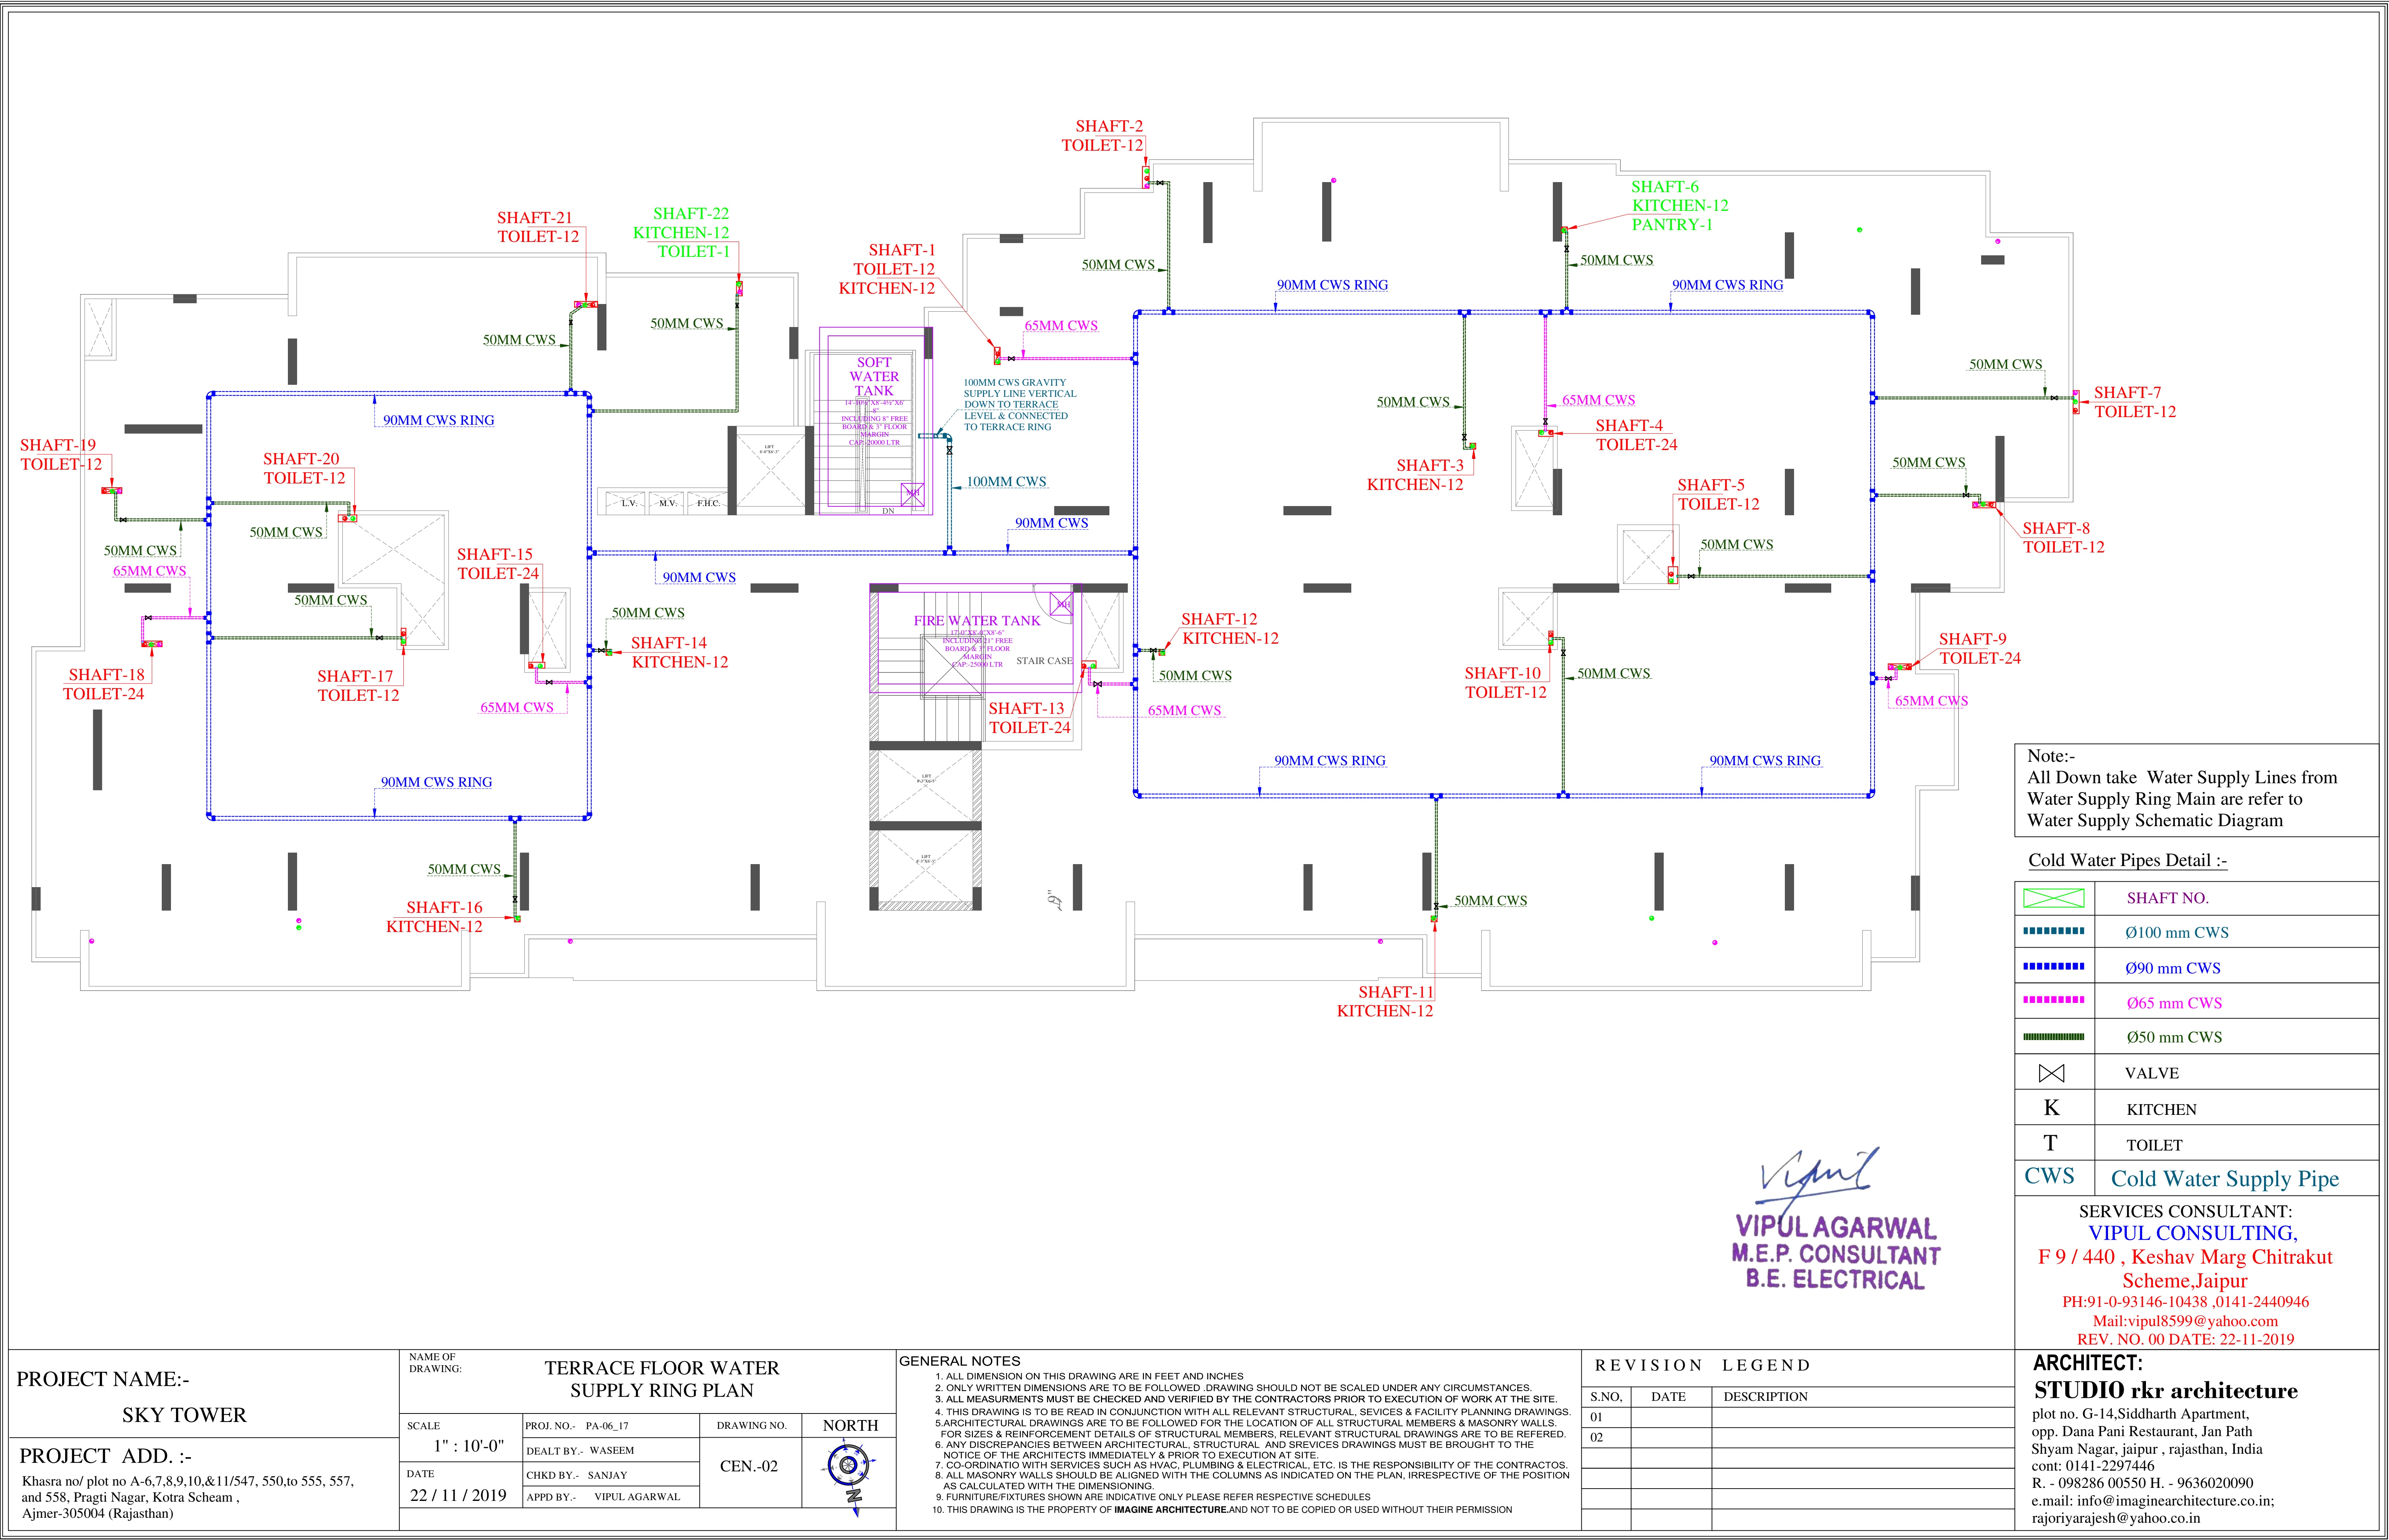



Vipul
VIPUL AGARWAL
M.E.P. CONSULTANT
B.E. ELECTRICAL

SYMBOL	DESCRIPTION
	110 mm Soil Waste Water Pipe
	110 mm Waste Water Pipe
	110 mm Rain Water Pipe
	110 mm Soil Waste Water Pipe
	110 mm Waste Water Pipe
	110 mm Rain Water Pipe
	75 mm Waste Water Pipe Internal Toilet
	75 mm Rain Water Pipe
	50mm Waste Water Pipe Bottle Trap
	Floor Trap
	Flow Direction
	6" Platform Raise
SERVICES CONSULTANT: VIPUL CONSULTING, F 9 / 440 , Keshav Marg Chitrakut Scheme Jaipur PH-91-0-93146-10438 ,0141-2440946 Mail: vipul8599@yahoo.co.in REV. NO. 00 DATE: 24-12-2019	

PROJECT NAME:-
SKY TOWER

PROJECT ADD. :-
Khasra no/ plot no A-6,7,8,9,10,&11/547, 550,to 555, 557,
and 558, Pragti Nagar, Kotra Scheam ,
Ajmer-305004 (Rajasthan)


NAME OF DRAWING: TYPICAL FLOOR INTERNAL DRAINAGE PLAN			
SCALE 1" : 8'-0"	PROJ. NO.- PA-06_17	DRAWING NO.	 NORTH
	DEALT BY.- RAAJ	CEN-02	
DATE	CHKD BY.- SANJAY		
24-12-2019	APPD BY.- VIPUL AGARWAL		

GENERAL NOTES

1. ALL DIMENSION ON THIS DRAWING ARE IN FEET AND INCHES
2. ONLY WRITTEN DIMENSIONS ARE TO BE FOLLOWED. DRAWING SHOULD NOT BE SCALED UNDER ANY CIRCUMSTANCES.
3. ALL MEASUREMENTS MUST BE CHECKED AND VERIFIED BY THE CONTRACTORS PRIOR TO EXECUTION OF WORK AT THE SITE.
4. THIS DRAWING IS TO BE READ IN CONJUNCTION WITH ALL RELEVANT STRUCTURAL, SERVICES & FACILITY PLANNING DRAWINGS.
5. ARCHITECTURAL DRAWINGS ARE TO BE FOLLOWED FOR THE LOCATION OF ALL STRUCTURAL MEMBERS & MASONRY WALLS. FOR SIZES & REINFORCEMENT DETAILS OF STRUCTURAL MEMBERS, RELEVANT STRUCTURAL DRAWINGS ARE TO BE REFERRED.
6. ANY DISCREPANCIES BETWEEN ARCHITECTURAL, STRUCTURAL, AND SERVICES DRAWINGS MUST BE BROUGHT TO THE NOTICE OF THE ARCHITECT'S IMMEDIATELY & PRIOR TO EXECUTION AT SITE.
7. CO-ORDINATION WITH SERVICES SUCH AS HVAC, PLUMBING & ELECTRICAL, ETC. IS THE RESPONSIBILITY OF THE CONTRACTORS.
8. ALL MASONRY WALLS SHOULD BE ALIGNED WITH THE COLUMNS AS INDICATED ON THE PLAN, IRRESPECTIVE OF THE POSITION AS CALCULATED WITH THE DIMENSIONING.
9. FURNITURE/FIXTURES SHOWN ARE INDICATIVE ONLY PLEASE REFER RESPECTIVE SCHEDULES
10. THIS DRAWING IS THE PROPERTY OF **IMAGINE ARCHITECTURE**.AND NOT TO BE COPIED OR USED WITHOUT THEIR PERMISSION

REVISION LEGEND		
S.NO.	DATE	DESCRIPTION
01		
02		


ARCHITECT:
STUDIO rkr architecture
plot no. G-14,Siddharth Apartment,
opp. Dana Pani Restaurant, Jan Path
Shyam Nagar, jaipur , rajasthan, India
cont: 0141-2297446
R. - 098286 00550 H. - 9636020090
e.mail: info@imaginearchitecture.co.in;
rajoriyarajesh@yahoo.co.in

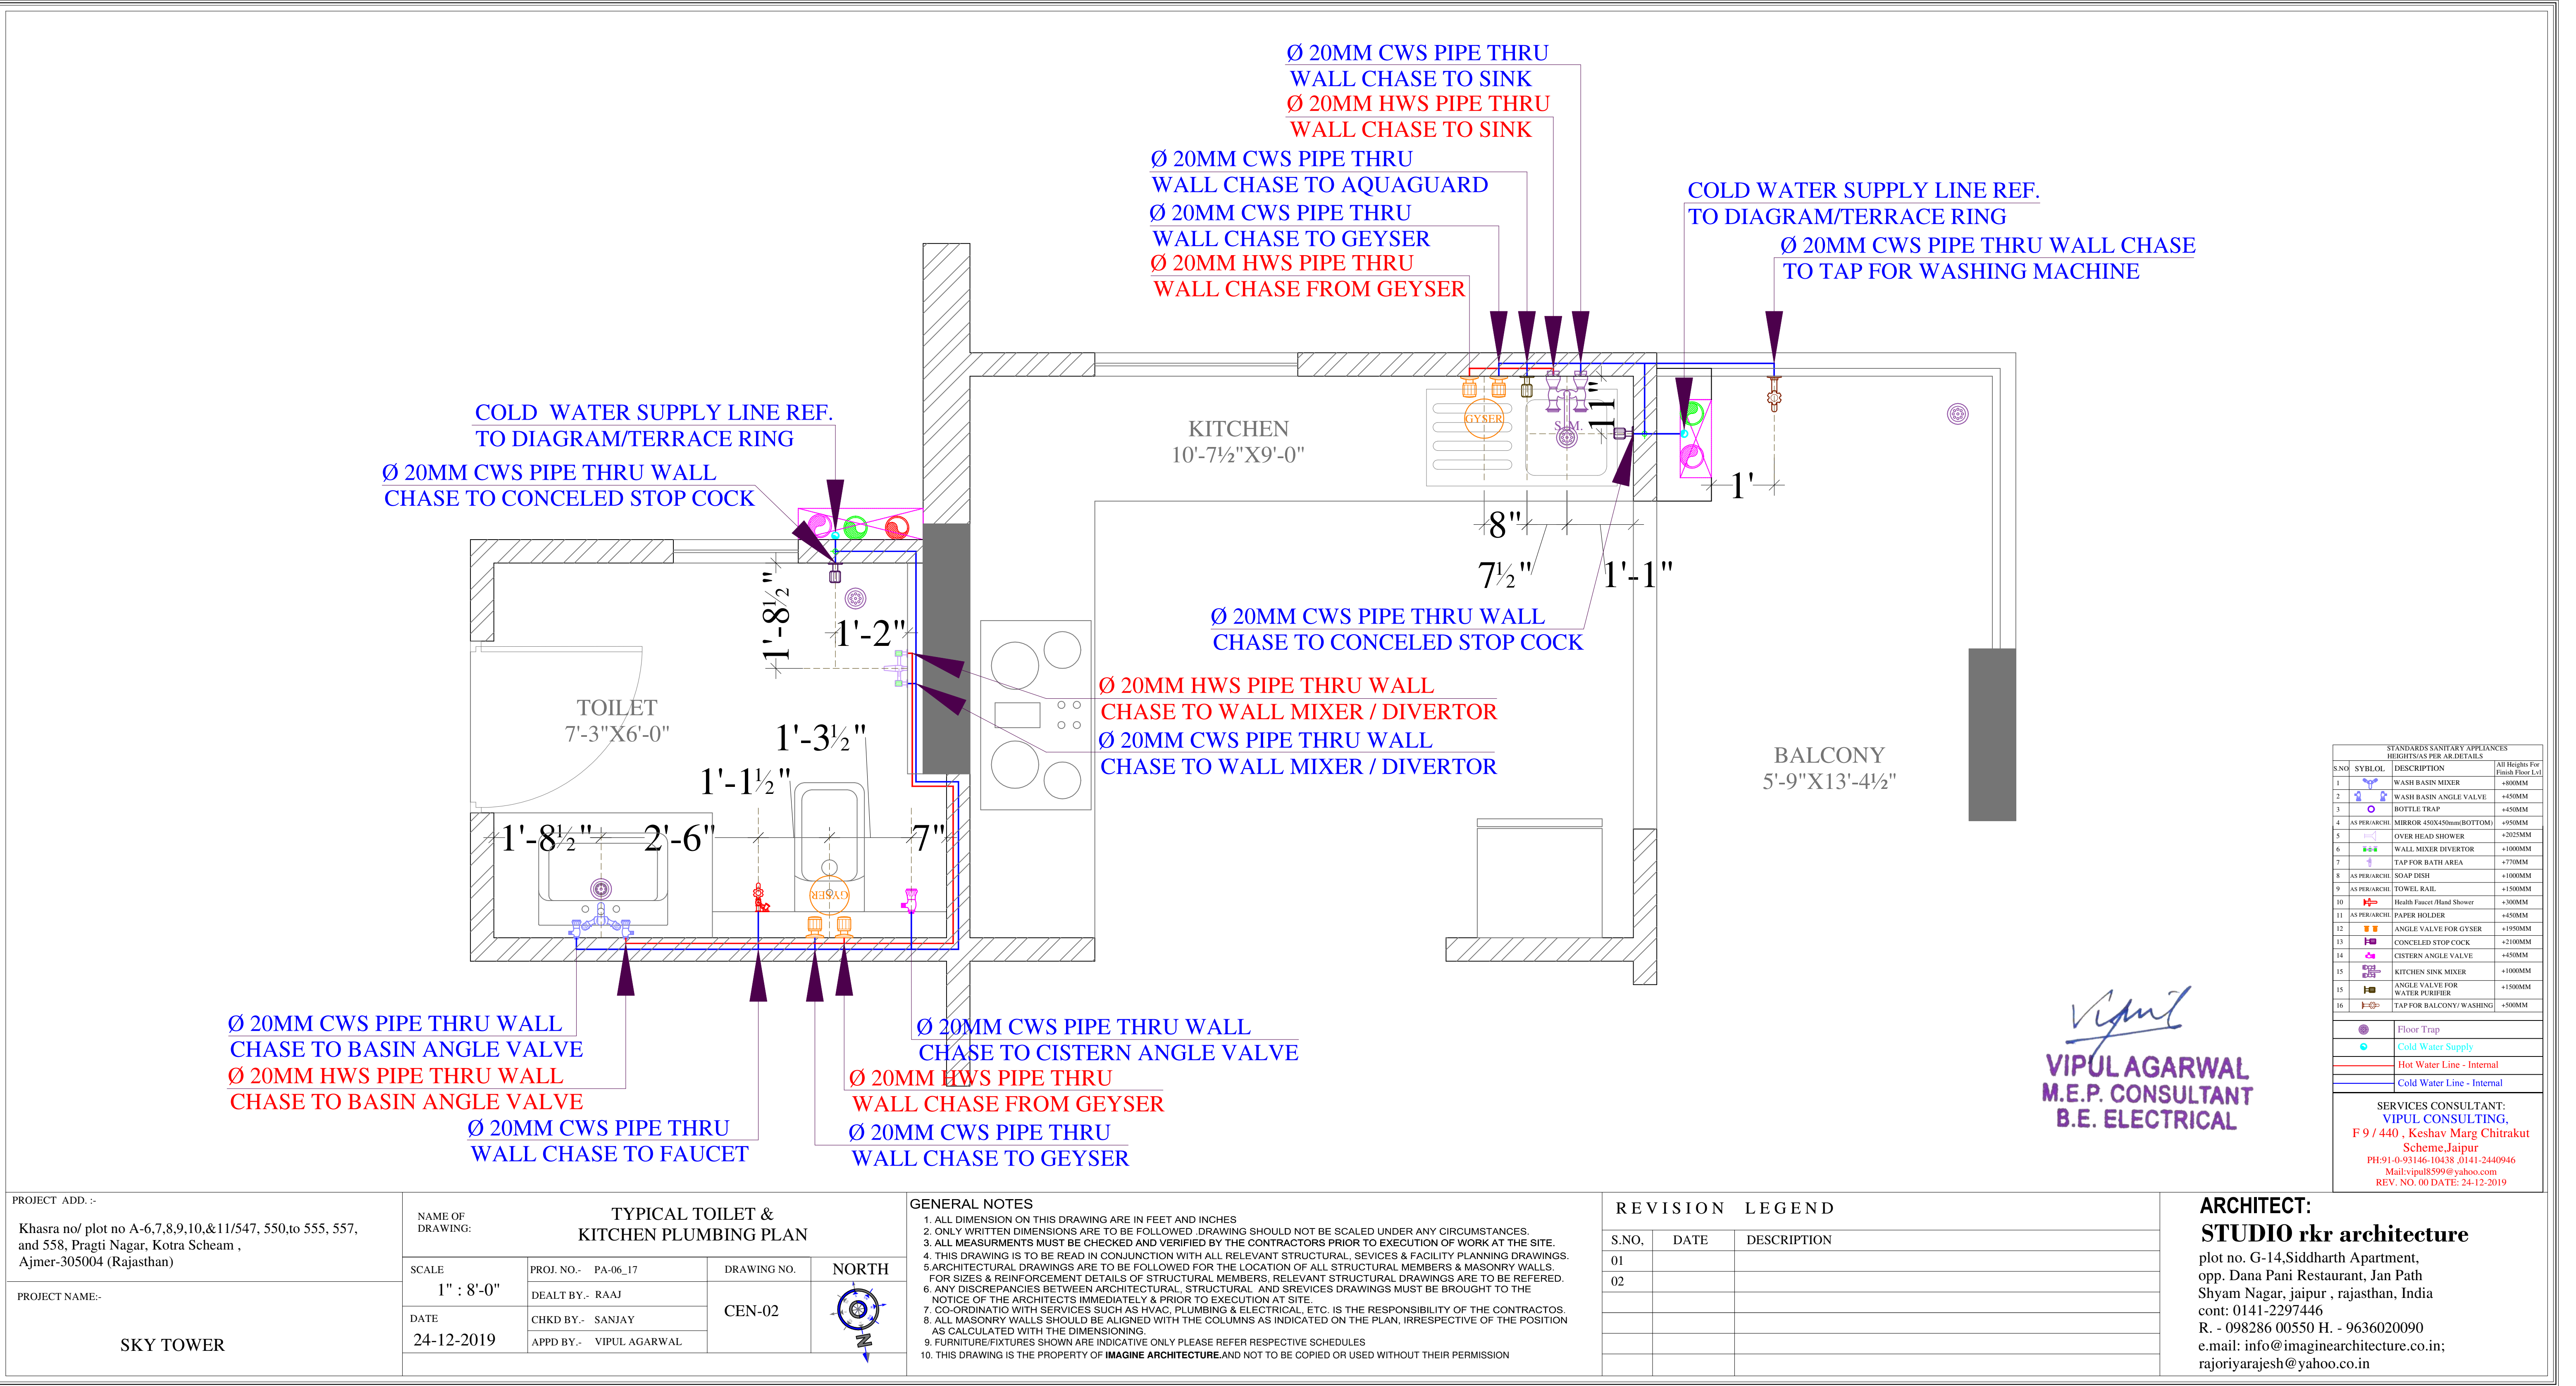

PROJECT ADD. :-
Khasra no/ plot no A-6,7,8,9,10.&11/547, 550,to 555, 557,
and 558, Pragti Nagar, Kotra Scheam ,
Ajmer-305004 (Rajasthan)

PROJECT NAME:-

SKY TOWER

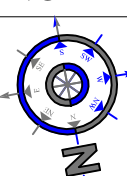TYPICAL TOILET & KITCHEN PLUMBING PLAN				
NAME OF DRAWING:				
SCALE	PROJ. NO.-	PA-06_17	DRAWING NO.	NORTH 
1" : 8'-0"	DEALT BY.-	RAAJ	CEN-02	
DATE	CHKD BY.-	SANJAY		
24-12-2019	APPD BY.-	VIPUL AGARWAL		

- GENERAL NOTES
1. ALL DIMENSION ON THIS DRAWING ARE IN FEET AND INCHES
 2. ONLY WRITTEN DIMENSIONS ARE TO BE FOLLOWED. DRAWING SHOULD NOT BE SCALED UNDER ANY CIRCUMSTANCES.
 3. ALL MEASUREMENTS MUST BE CHECKED AND VERIFIED BY THE CONTRACTORS PRIOR TO EXECUTION OF WORK AT THE SITE.
 4. THIS DRAWING IS TO BE READ IN CONJUNCTION WITH ALL RELEVANT STRUCTURAL, SERVICES & FACILITY PLANNING DRAWINGS.
 5. ARCHITECTURAL DRAWINGS ARE TO BE FOLLOWED FOR THE LOCATION OF ALL STRUCTURAL MEMBERS & MASONRY WALLS.
 6. ANY DISCREPANCIES BETWEEN ARCHITECTURAL, STRUCTURAL, AND SERVICES DRAWINGS MUST BE BROUGHT TO THE NOTICE OF THE ARCHITECTS IMMEDIATELY & PRIOR TO EXECUTION AT SITE.
 7. CO-ORDINATIO WITH SERVICES SUCH AS HVAC, PLUMBING & ELECTRICAL, ETC. IS THE RESPONSIBILITY OF THE CONTRACTOS.
 8. ALL MASONRY WALLS SHOULD BE ALIGNED WITH THE COLUMNS AS INDICATED ON THE PLAN, IRRESPECTIVE OF THE POSITION AS CALCULATED WITH THE DIMENSIONING.
 9. FURNITURE/FIXTURES SHOWN ARE INDICATIVE ONLY PLEASE REFER RESPECTIVE SCHEDULES
 10. THIS DRAWING IS THE PROPERTY OF **IMAGINE ARCHITECTURE** AND NOT TO BE COPIED OR USED WITHOUT THEIR PERMISSION

REVISION LEGEND		
S.NO.	DATE	DESCRIPTION
01		
02		

ARCHITECT:
STUDIO rkr architecture
plot no. G-14,Siddharth Apartment,
opp. Dana Pani Restaurant, Jan Path
Shyam Nagar, jaipur , rajasthan, India
cont: 0141-2297446
R. - 098286 00550 H. - 9636020090
e.mail: info@imaginearchitecture.co.in;
rajoriyarajesh@yahoo.co.in