

PLUMBING DRAWING

NOTE

- 1) All toilet,kitchen & balcony floor
15mm drop in floor finished
- 2) All grooves in plaster 40mm
wide & 15mm deep

Rev	Date	Description
-----	------	-------------

OWNERS NAME

ashiana housing ltd.

Unit no.4 & 5,Plot No.D-2,3rd Floor,
Southern park, saket District Centre,
Saket New Delhi - 110017
Phone no. 011- 42 65 42 65

PROJECT :

ASHIANA DAKSH AT
Jaipur

ARCHITECT

b.sengupta architect

A305,RANCOLI,ASHIANAVILLAGEBHIWADI.
PH . 09887488263

SERVICES CONSULTANTS:-



SRIAN ENGINEERING CONSULTANTS
(Building Engineering Services)
C2/357 1st Floor, JANAKPURI, NEW DELHI - 110058
Tel: 011-40532854, 25611240
Email: srianphe@gmail.com

BUILDING TYPE	BLOCK-B2, B3,B4 & B5 3bhk + 2bhk	SHEET. NO.:	A-02
---------------	-------------------------------------	-------------	------

DRG. TITLE:	TYPICAL FLOOR PLAN PLUMBING DRAWING. (TOWER-B2,B3,B4&B5)	
-------------	---	---


SCALE: ----- KEY IN:

DATE.: 27.01-2020 PLOTTED ON:

DRAWN BY	CHECKED BY	APPROVED BY
----------	------------	-------------

RAKESH	SANTOSH	SRINIVASAN
--------	---------	------------

ISSUED FOR: For GFC Drawing.

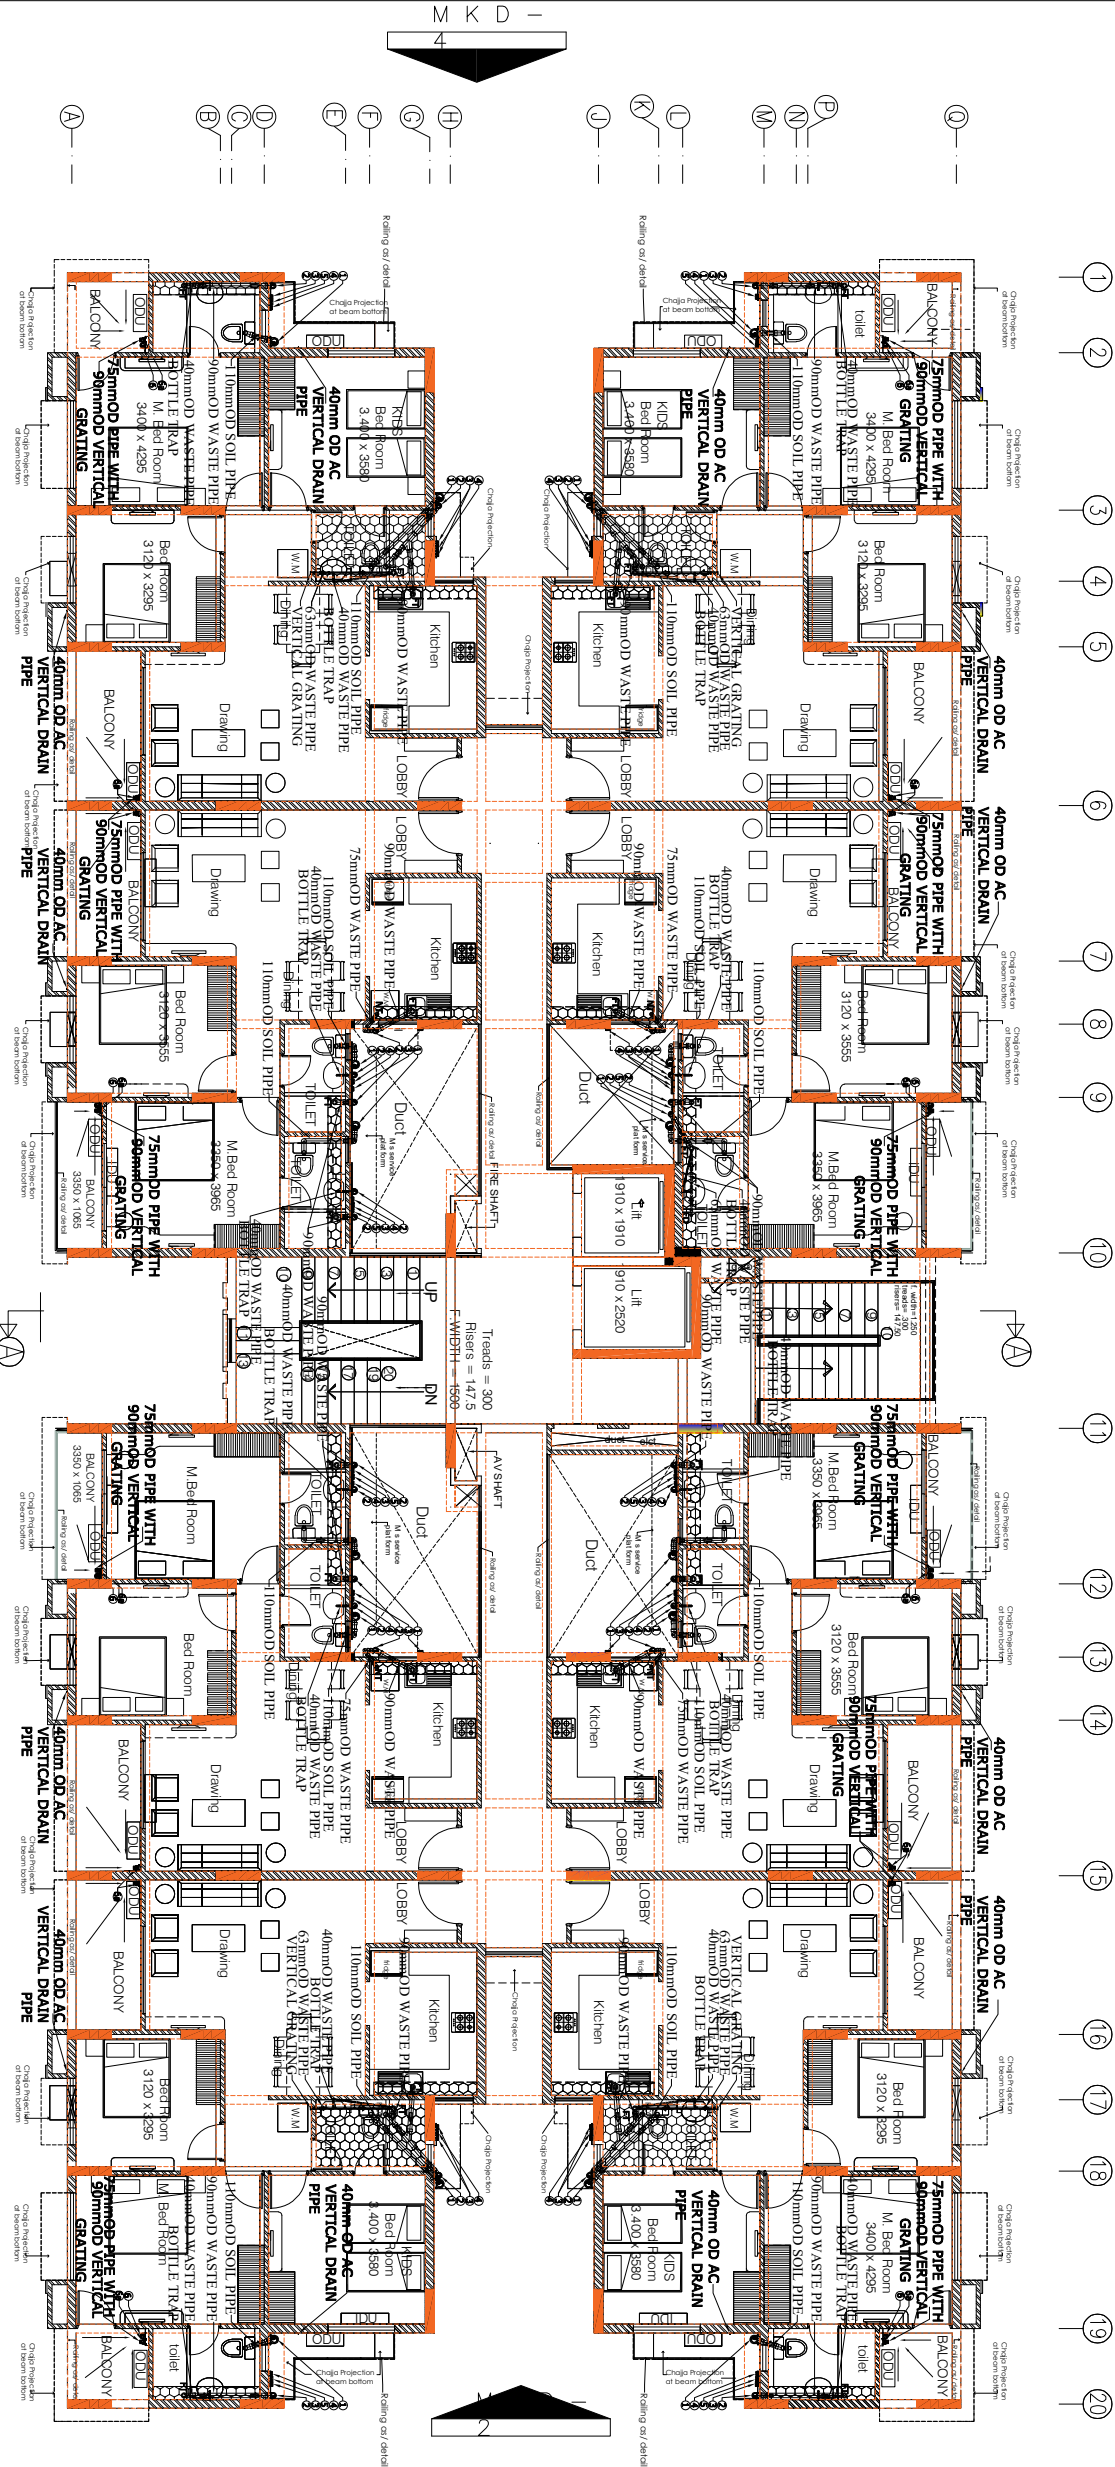

TYPICAL FLOOR PLAN

3RD,4TH,5TH,6TH,7TH,8TH.9TH,10TH,11TH&12TH

PIPE SCHEDULE:-	
S.NO.	DESCRIPTION
1.	PPE DIA FROM WC TO VERTICAL STACK
2.	PPE DIA FROM FT TO VERTICAL STACK
3.	PPE DIA FROM FD TO FT
4.	PPE DIA FROM SINK TO FT
5.	PPE DIA FROM WASH BASIN TO FT
PIPE DIA FROM GT. TO MH. = 1000 S.W PIPE	
GT SIZE = 300 X 300 X 675MM	
ALL FIRST MH. SIZE = 900 X 600 X 600MM D.M.O.	
FOR SIZING OF VERTICAL WATER SUPPLY LINE,	
PLEASE REFER WATER SUPPLY SCHEMATIC DIAGRAM DWG.	

LEGEND			
S.NO.	SYMBOL	DESCRIPTION	P.NO.
1.		160mm OD uPVC VERTICAL SOIL PIPE	①
2.		110mm OD uPVC VERTICAL WASTE PIPE	②
3.		DOM. WATER SUPPLY D/N TAKE FROM OHT	③
4.		FLU. WATER SUPPLY D/N TAKE FROM OHT	④
5.		HOT WATER SUPPLY D/N TAKE FROM SOLOR	⑤
6.		110mm OD uPVC RAIN WATER PIPE	⑥
7.		90mm OD uPVC RAIN WATER PIPE	⑦
8.		110X90mm FLOOR TRAP (FT)	⑧
9.		75X65mm FLOOR DRAIN (FD)	⑨
10.		NAHANI TRAP (75X75mm OD) (NT)	⑩
11.		FLOOR CLEAN OUT WITH PLUG (100X100mm)	⑪



V Srinivasan