
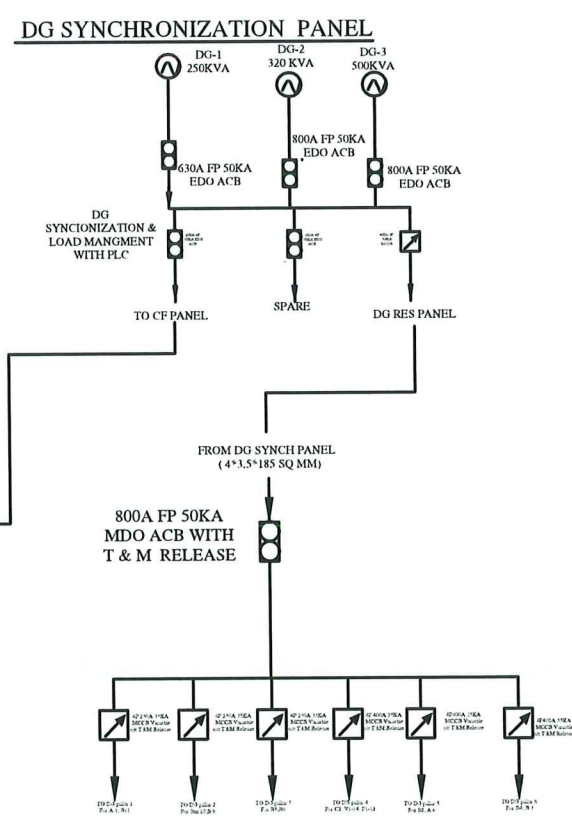


Handwritten signature: Roshni Bhatnagar
Electro Mech.

NOMENCLATURE	
VCB	Vaccum Circuit Breaker
RMU	Ring main unit
MLTP	Mains LT Pillar
MP	Meter Panel
CP	Common Facility Pillar
DGP	Rse. DG Pillar

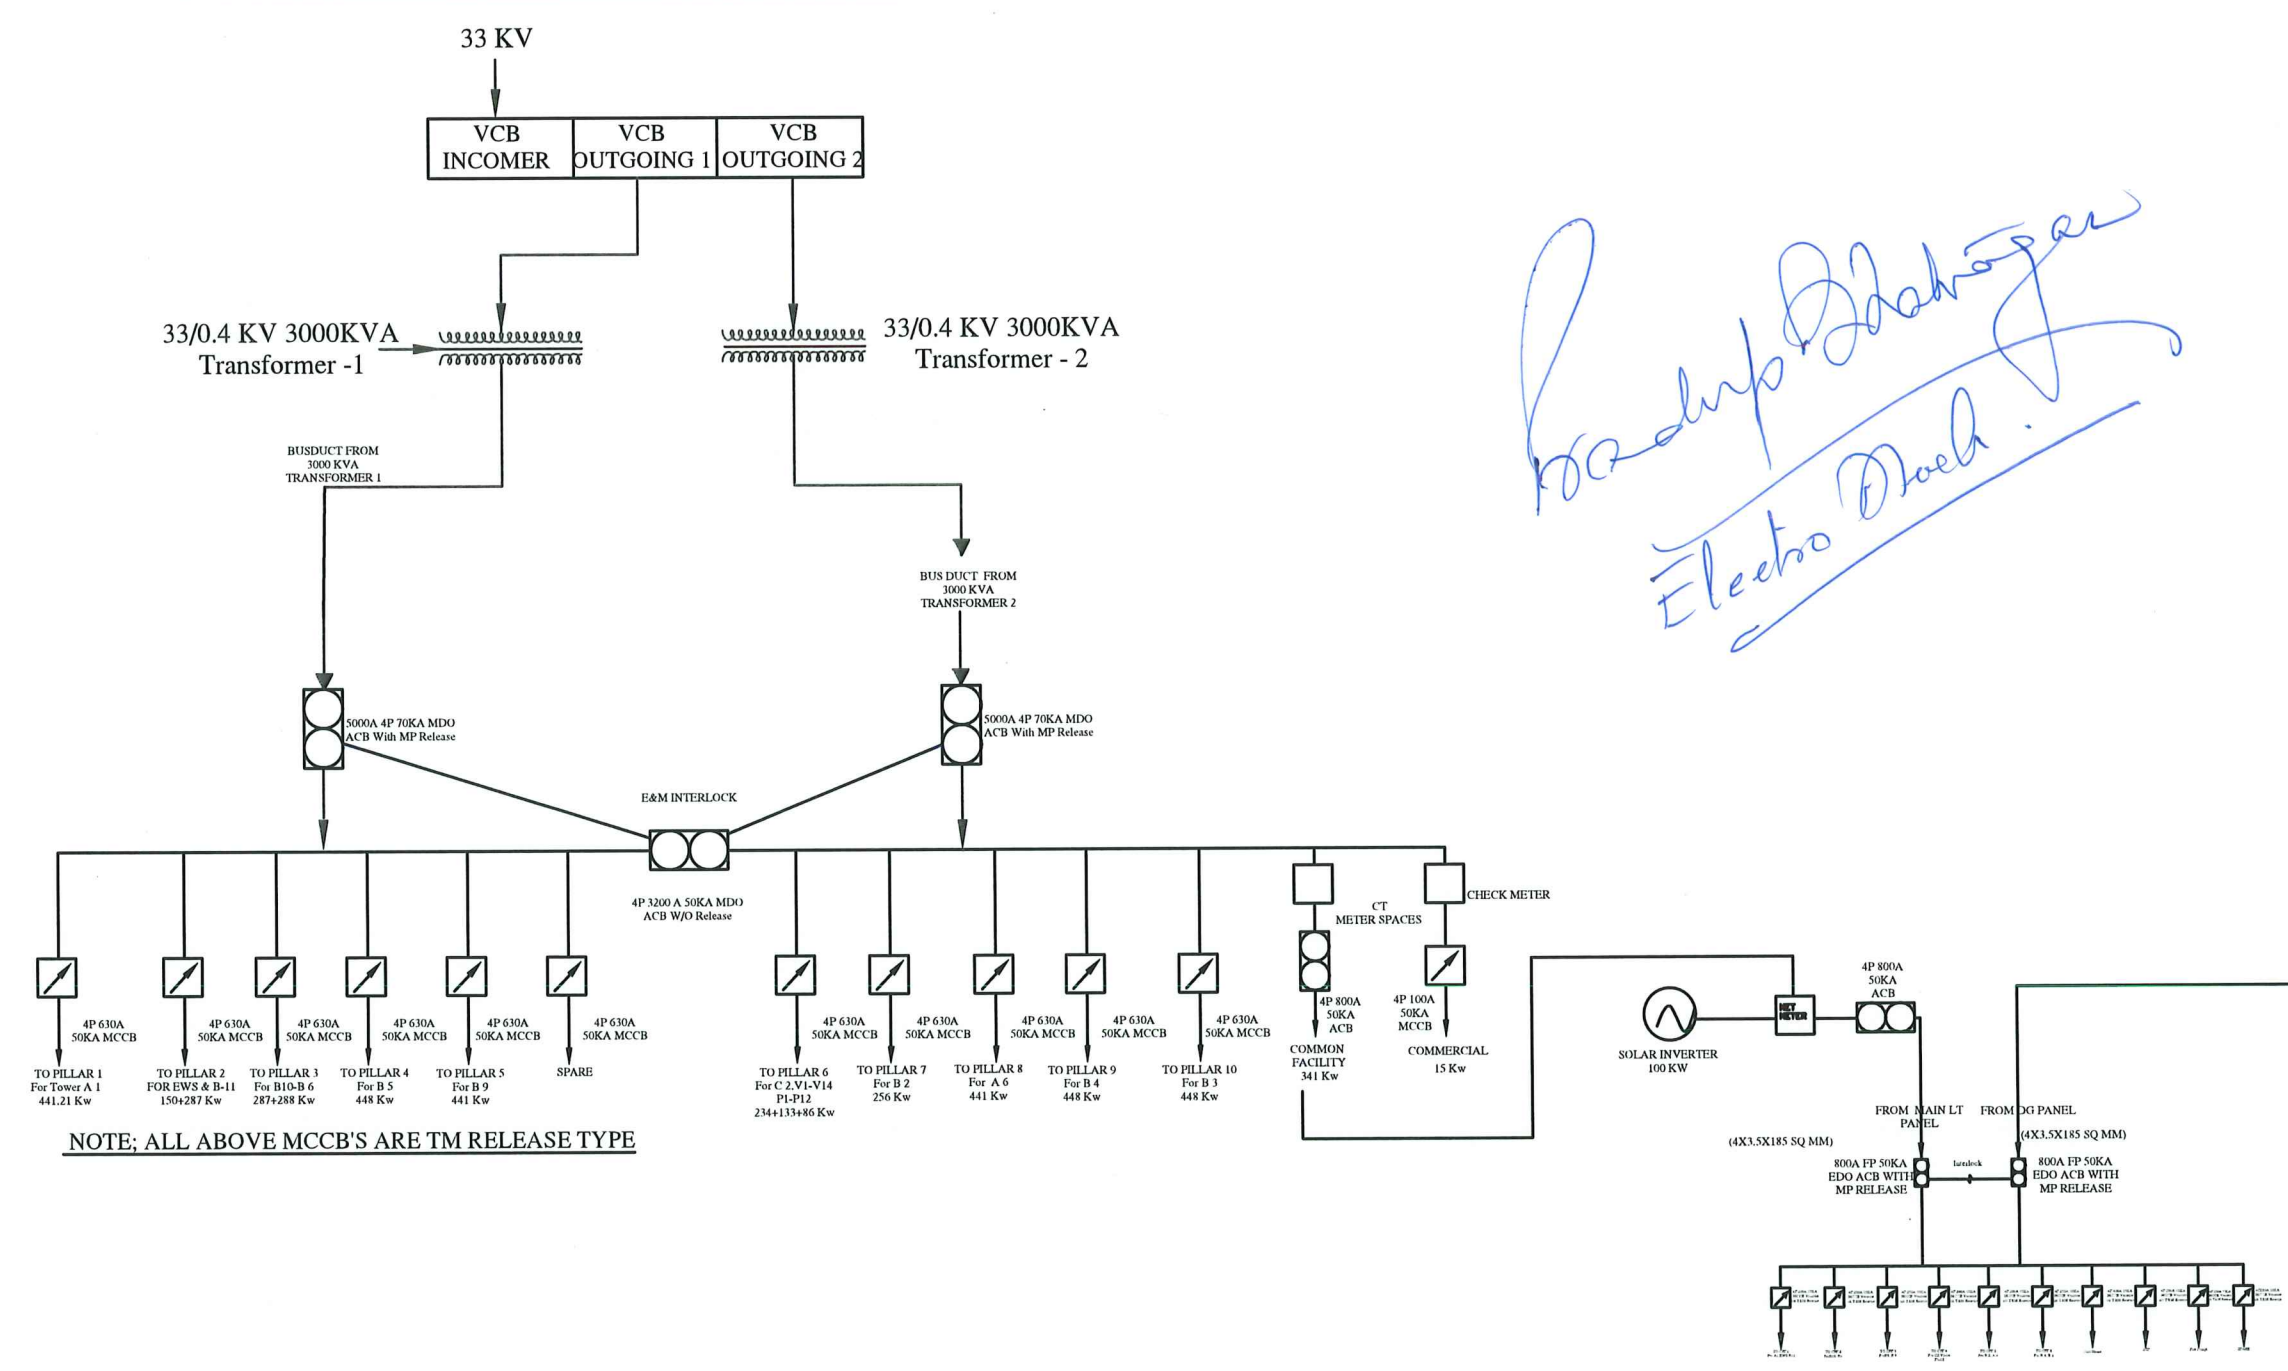

NOTE; ALL ABOVE MCCB'S ARE TM RELEASE TYPE

PROJECT:-
**ASHIANA TARANG
BHIWADI**

DRAWING TITLE:-
TOTAL POWER FLOW SHEET

DATE:- 13-08-2022


REV /DATE:-

ELECTRO-MECH ENGINEES & CONSULTANTS
KABRI DOOGRI, SHERAWATPURA, MUNDOTA, KALWAD
JAIPUR-303706 (RAJ.)
TEL:- 91 7851054954, 91 7976268514

DRAWN BY:- RICHHA BHATNAGAR

APPD. BY:- Er. P. P.BHATNAGAR

KEY PLAN

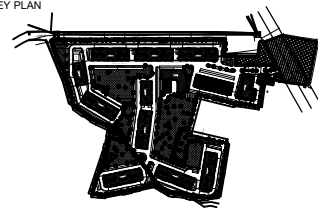

NOTES:-

1. ALL DIMENSIONS ARE IN MM.
2. FOR LEGENDS, REFER TYPICAL APARTMENT DRAWINGS NO. 15280-E-A1-0300, 15280-E-A1-0301 & 15280-E-A1-0302.
3. FOR COMMON AREA ELECTRICAL SERVICES, REFER DRAWING NO. 15280-E-A1-1001 & 15280-E-A1-1001A.
4. THIS DRAWING SHOULD BE READ IN CONJUNCTION WITH ARCHITECTURE, STRUCTURE AND OTHER SERVICES.

Rev	Date	Issued to	Description	By	Chk
R1	13.12.16	ARCH.	ISSUED FOR APPROVAL	SKT	ANS
R0	07.12.16	ARCH.	ISSUED FOR APPROVAL	SKT	ANS

The concepts and information contained in this document are the copyright of think BM Technical Services Pvt. Ltd. Use or copying of the document in whole or in part without the written permission of think BM Technical Services Pvt. Ltd. constitutes an infringement of copyright. Do not scale drawings. If in doubt, ask!

ARCHITECTS:

b.sengupta architect

A305,RANGOLI,ASHIANA VILLAGE,BHIWADI,
PH. 0988748263

MEP CONSULTANT:



STRUCTURAL CONSULTANT:

Developer:-

ASHIANA HOUSING LTD
Unit no.4 & 5,Plot No.D-2,3rd Floor,
Southern park, saket District Centre,
Saket New Delhi - 110017
Phone no. 011- 42 65 42 65


Project Name


ASHIANA TARANG AT BHIWADI

Title

**TOWER BLOCK-A
TYPICAL FLOOR
APARTMENT LAYOUT**

Discipline ELECTRICAL SERVICE		Status GFC
Designed By SKT	Checked By ANS	Approved By SOL/AKT
Project No. 15280	Date 07.12.2016	Scale 1 : 100 (at A1)
Drawing No. 15280-E-A1-1001B		Revision R1

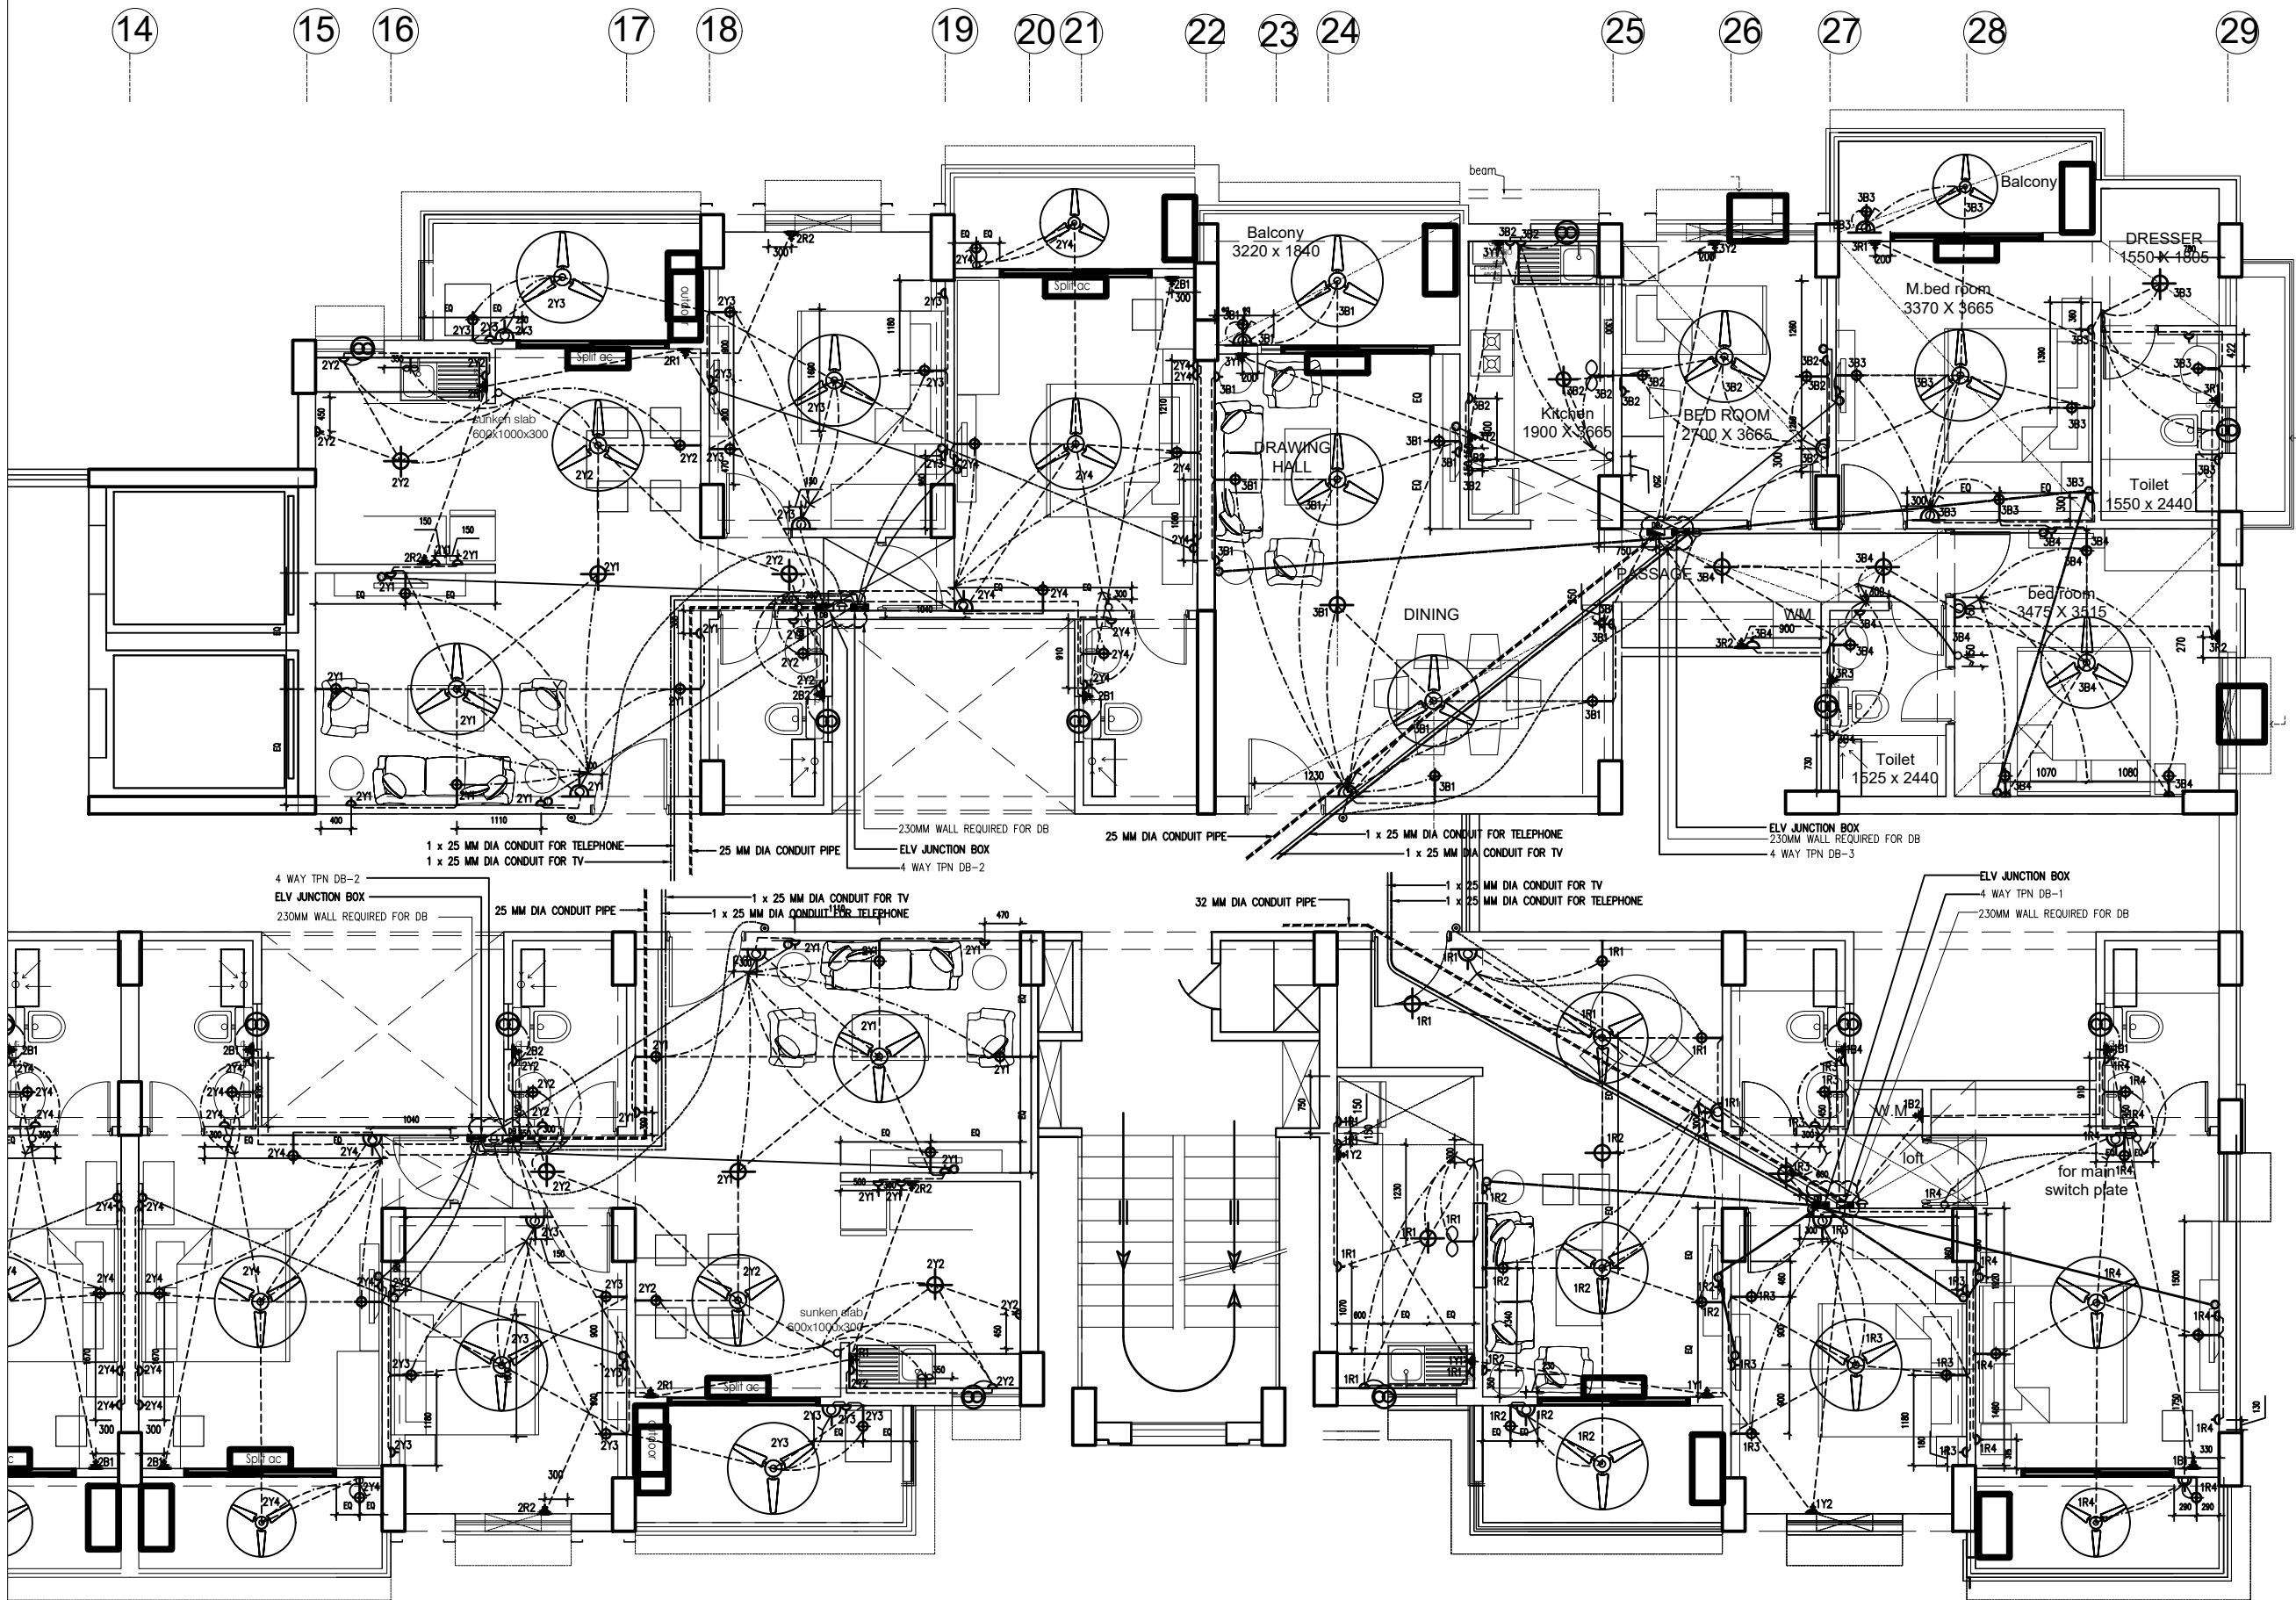

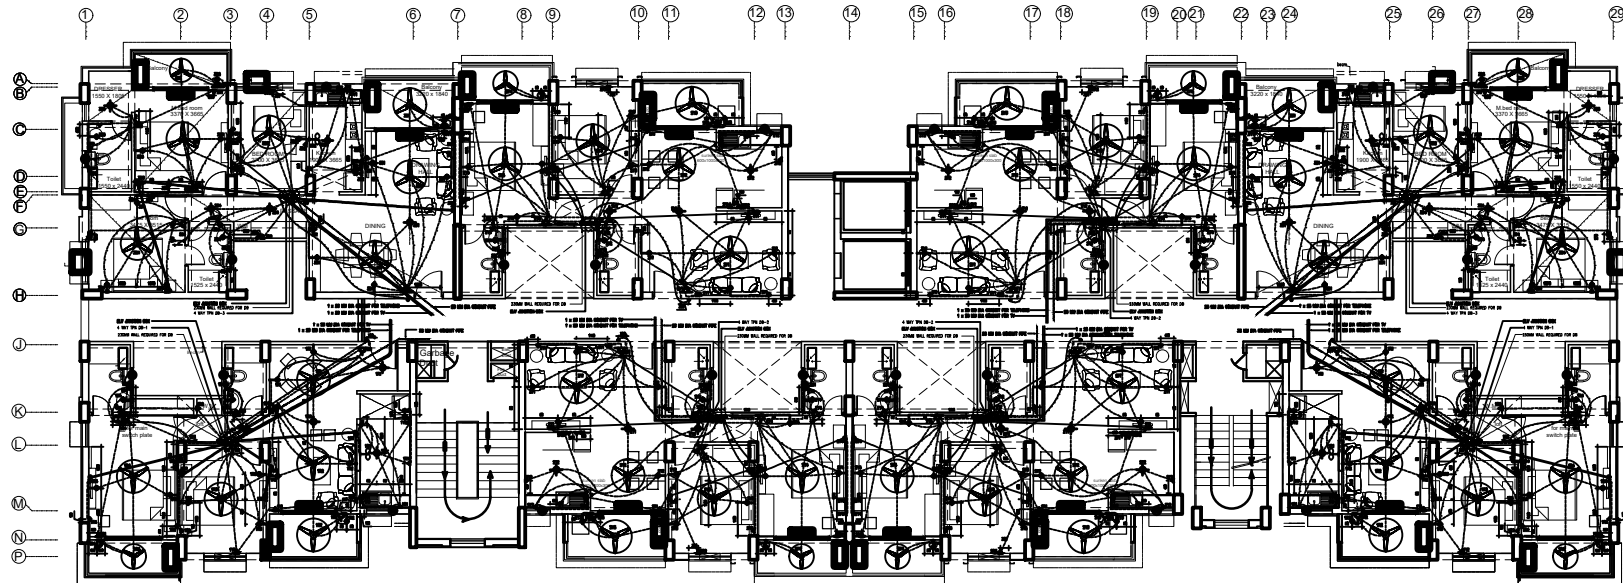

Tarang Electrical Layout Plan

GOOD FOR CONSTRUCTION

KEY PLAN



NOTES:-

1. ALL DIMENSIONS ARE IN MM.
2. FOR LEGENDS, REFER TYPICAL APARTMENT DRAWINGS NO. 15280-E-A1-020A, 15280-E-A1-0201 & 15280-E-A1-0302.
3. FOR COMMON AREA ELECTRICAL SERVICES, REFER DRAWING NO. 15280-E-A1-1001 & 15280-E-A1-1001A.
4. THIS DRAWING SHOULD BE READ IN CONJUNCTION WITH ARCHITECTURE, STRUCTURE AND OTHER SERVICES.

Rev	Date	Issued to	Description	By	Chk
01	13.12.18	ARCH	ISSUED FOR APPROVAL	SKT	ANS
02	07.12.18	ARCH	ISSUED FOR APPROVAL	SKT	ANS

The concepts and information contained in this document are the copyright of b.sengupta architect. No part of this document may be reproduced or transmitted in any form or by any means, electronic or mechanical, including photocopying, recording, or by any information storage and retrieval system, without the prior written permission of b.sengupta architect.

ARCHITECTS:

b.sengupta architect
 405, ANSOL, ASHIANA, WILFAC, BHIWADI.
 PH. 68874803

MEP CONSULTANT:



STRUCTURAL CONSULTANT:

Developer:-

ASHIANA HOUSING LTD
 Unit no.4 & 5, Plot No. D-2, 3rd Floor,
 Southern park, Saket District Centre,
 Saket New Delhi - 110017
 Phone no. 011-42654265

Project Name:

ASHIANA TARANG AT BHIWADI

Title:

**TOWER BLOCK-A
 TYPICAL FLOOR
 APARTMENT LAYOUT**

Discipline	Electrical Service	Status	GFC
Designed By	SKT	Checked By	SOL/AKT
Project No.	15280	Date	07.12.2018
Scale	1 : 100	Sheet	(of A1)
Drawing No.	15280-E-A1-1001B	Revision	R1