


MAIN PANEL

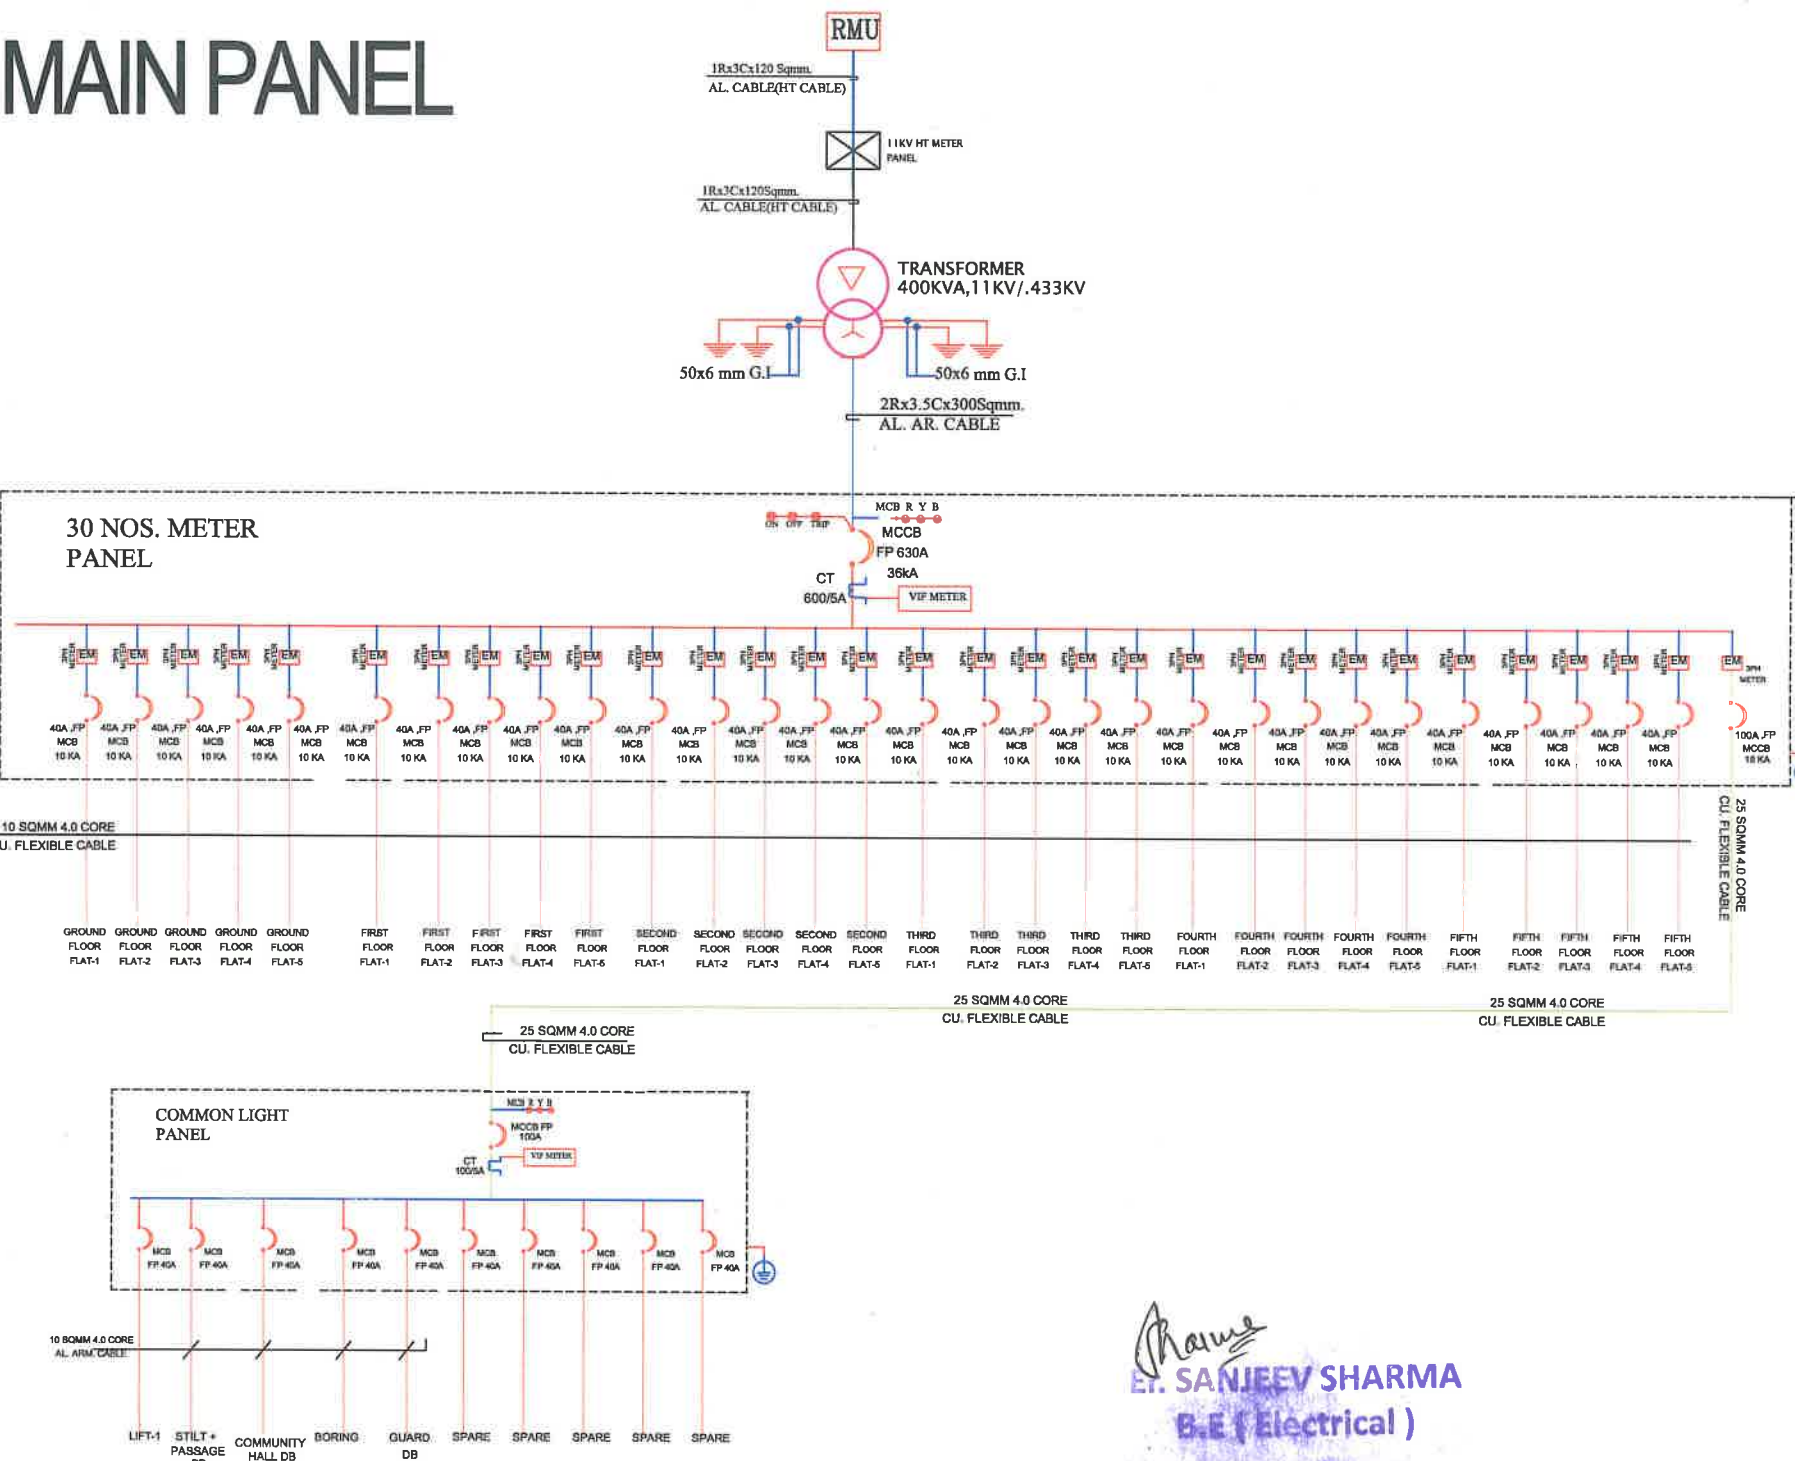

PROJECT NAME :
"UTSAV"
DEVELOPER
NAME :
M/S VINAYAK REAL ESTATE
ARCHITECTS :
INSIDE
ARCHITECTURE N INTERIORS
Plot no. 72, S.P. Marg, C- Scheme
jaipur, rajasthan, India
cont: +91 9950595991, 91 9982812777
e-mail: 4insideofficial@gmail.com


Measuring Height	I D	Symbol	Description
CEILING	FAN 4"		CEILING FAN 4"
CEILING	FAN 36"		CEILING FAN 36"
CEILING	CHI		CHANDIELIER
+93"	TL/W		LED WALL Tube Light Make: Tuba Led Cat no. SDC-75-30W
+93"	BULB		LED Bulb 20W Make: Tuba Led Cat no. SDC-20W-17C/3K
+93"	GL		WALL BRACKETE A8 DESIGN BYR GANDESH LACHT
+78"	ML		12x2 Led Mirror Light Make: Tuba Led Cat no. ZFL-12x2
CEILING	DL		LED 6" Down Light 20W (Double Mount) Make: Tuba Led Cat no. SDC-12W-CLD-6-50-40C
VENTILATOR HT.	CH		CEILING ROSE
VENTILATOR HT.	EXP		6" DIA FRESH AIR FAN
+24"	2WB		2 SWITCH BOARD
+42"	SB		SWITCH BOARD (SA SOCKET & SWITCH)
+24"	TBL		TELEPHONE POINT
+24"	LP TEL		6 A PLUG POINT FOR TELEPHONE
+48"	TV		8 A PLUG POINT FOR TV
+48"	LP TV		8 A PLUG POINT FOR TV
+24"	LP		6 A PLUG POINT FOR SIDE TABL
+72"	LP-CH		6 A PLUG POINT FOR CHIMNEY
+12"	LP-PC		6 A PLUG FOR COMPUTER POINT
+93"	SAC		SPLIT AC INDOOR UNIT
+42"	PP-MIX		16 A POWER POINT FOR MIXER
+42"	PP-MC		16 A POWER POINT FOR MICROWAVE
+78"	PP-Q		16 A POWER POINT FOR GEYSER
+54"	PP-F		16 A POWER POINT FOR FRIDGE
+78"	PP-WP		16 A POWER POINT FOR WATER PUMP
+48"	PP-WM		16 A POWER POINT FOR WASHING MACHINE
+12"	PP-INV		16 A POWER POINT FOR INVERTER
+93"	PP-AC		25A SWITCH/MCB FOR AC
			CHAMBER (2' x 2')
+18"			IN 2 NOS. SOCKET +1 NOS. 16A SWITCH, TELEPHONE/LAN
+60"	MCB DB		MCB DISTRIBUTION BOARD
			CAMERA
			WALL FAN

PROJECT:
PROPOSED RESIDENTIAL FLATS ON PLOT NO.-13A & 14 SCHEME - SUMER NAGR VISTAR 'N' BLOCK, JAIPUR

NAME OF DRAWING:
MAIN PANEL(SLD/DISTRIBUTION DETAILS AFTER LT PANEL

DRAWING WORKING DRAWING	NORTH: 												
PROJECT NO. :	DATE : 19, Feb.- 2024												
SCALE : NTS	REV NO. : R-0												
DRAWING NO. : <table border="1" data-bbox="1782 2525 2058 2555"><tr><td>PROJECT</td><td>CATEGORY</td><td>SHEET</td><td>FLOOR</td><td>TYPE</td><td>NUMBER</td></tr><tr><td></td><td></td><td></td><td></td><td></td><td></td></tr></table>		PROJECT	CATEGORY	SHEET	FLOOR	TYPE	NUMBER						
PROJECT	CATEGORY	SHEET	FLOOR	TYPE	NUMBER								
A-01													

SINGLE LINE DIAGRAM
MAIN PANEL(SLD/DISTRIBUTION DETAILS AFTER LT PANEL

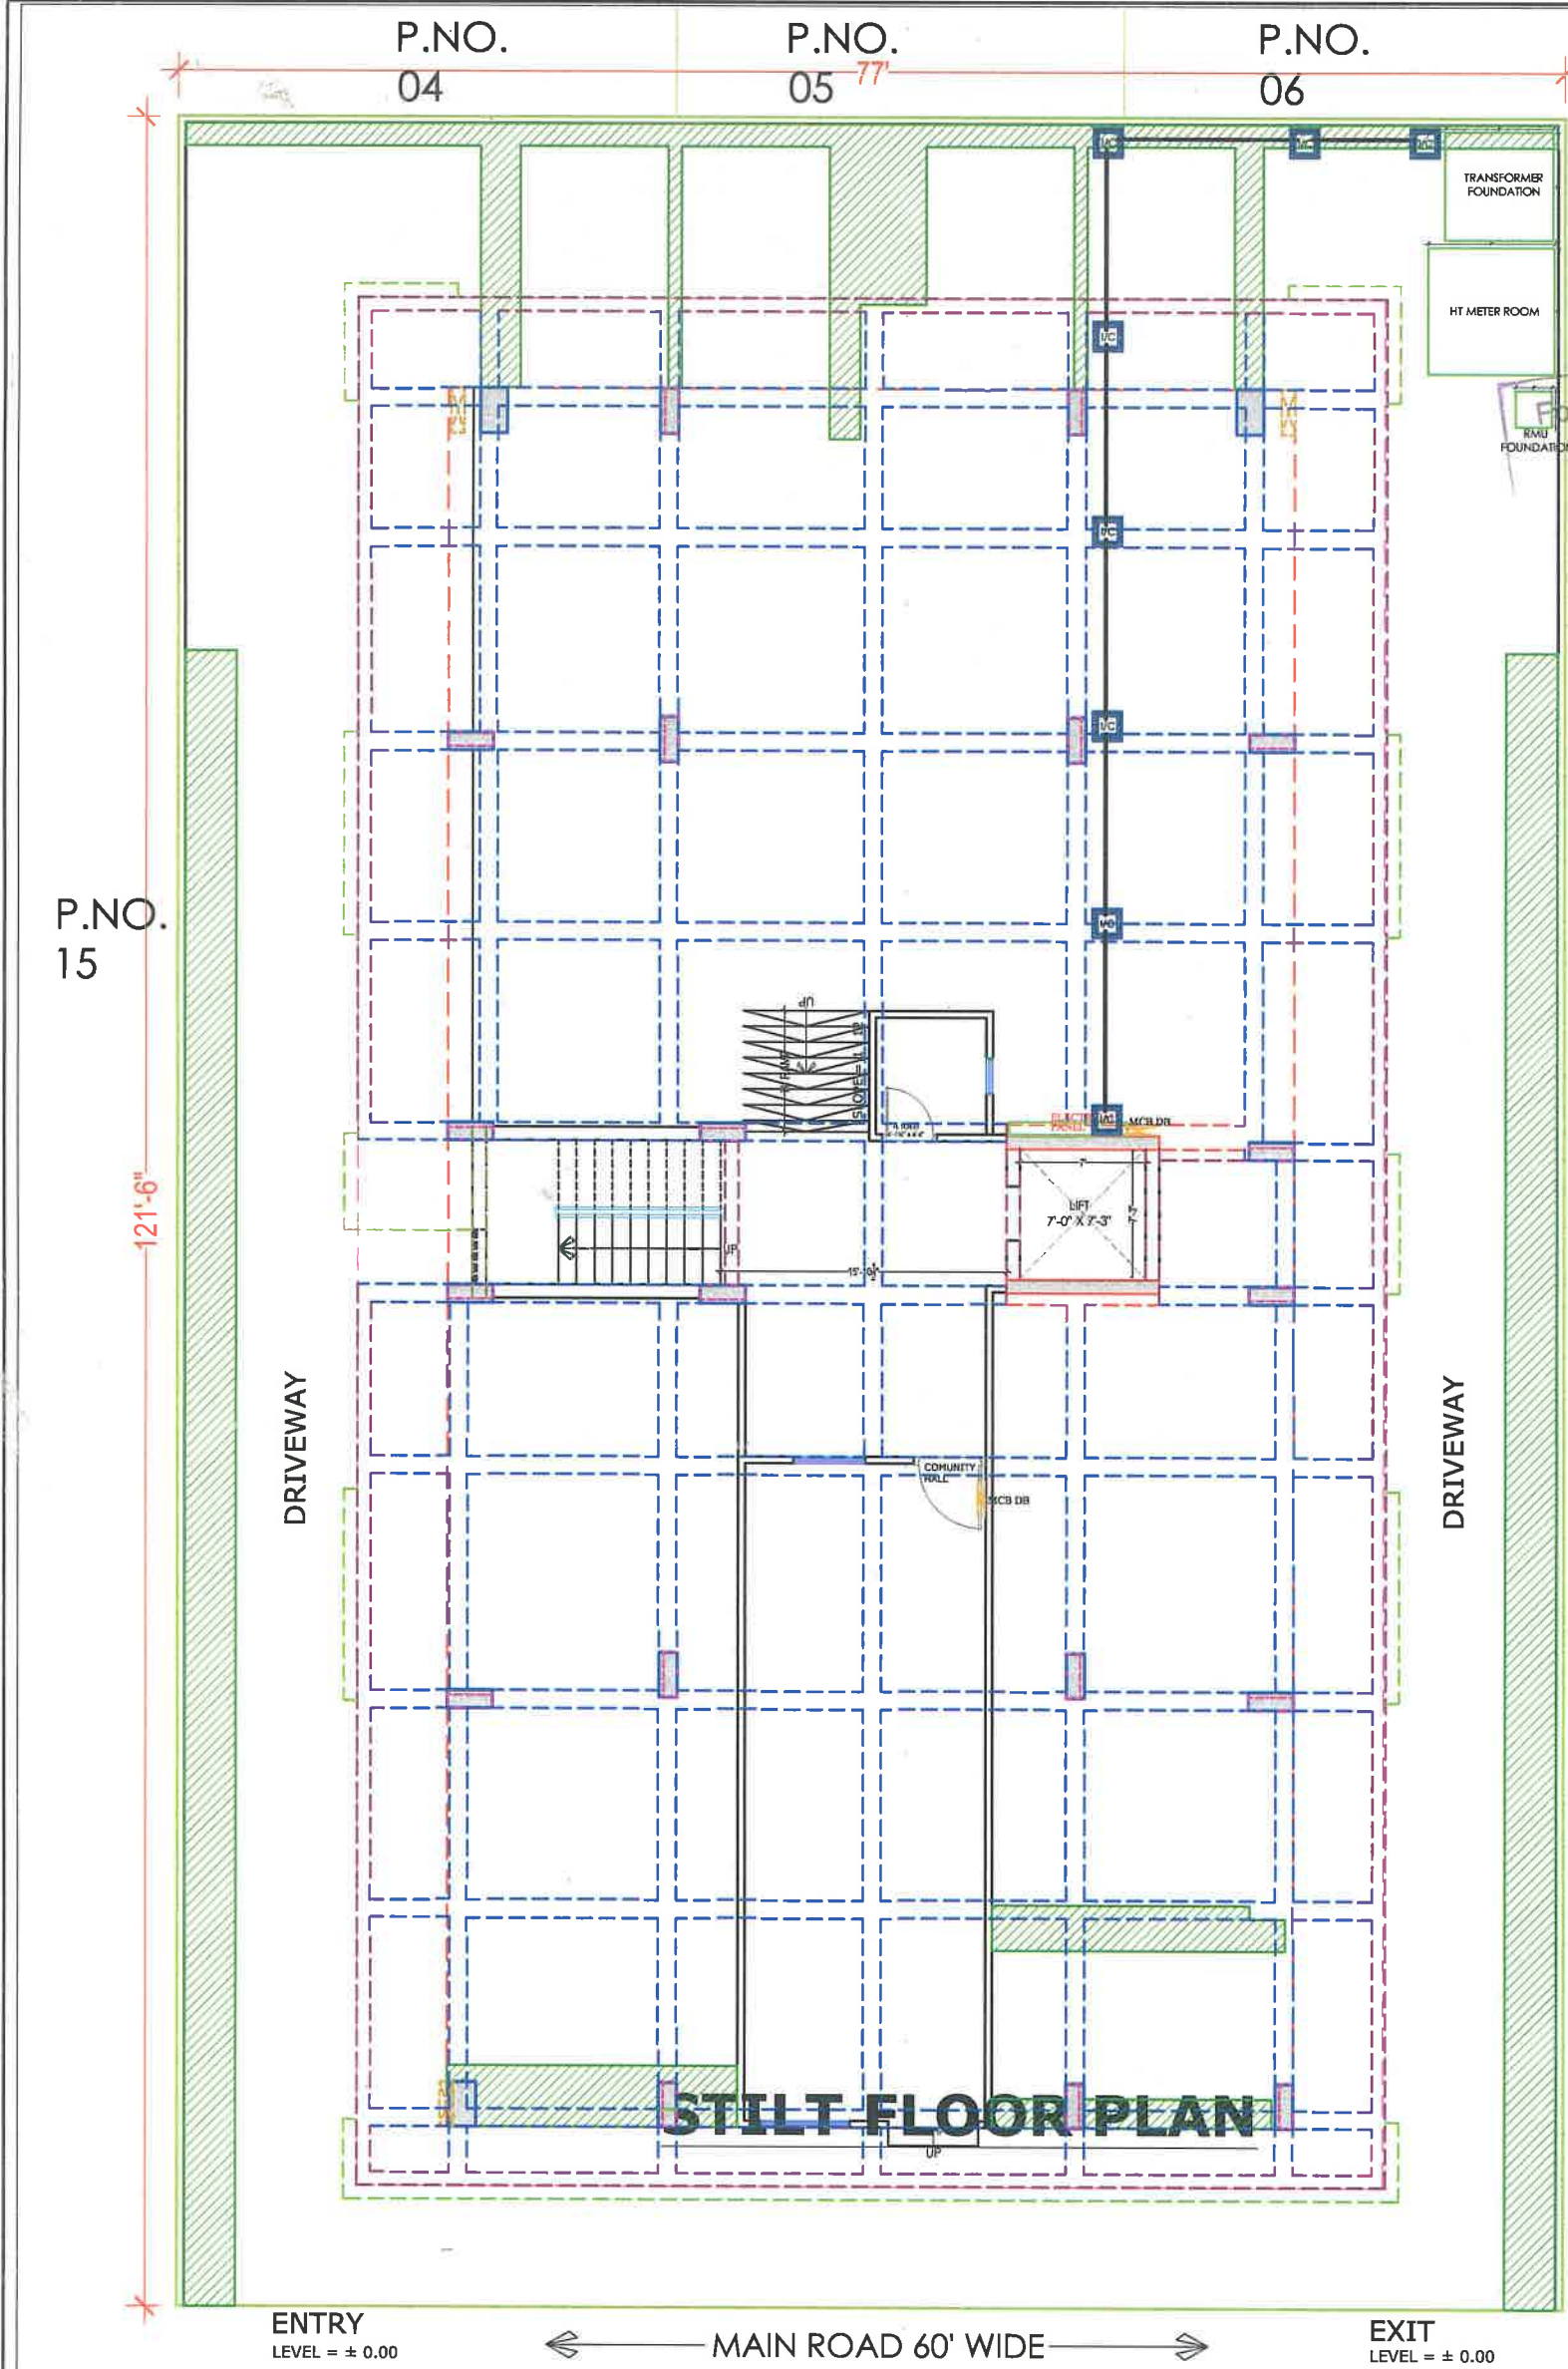

PROJECT NAME :
"UTSAV"

DEVELOPER
NAME :
M/S VINAYAK REAL ESTATE

ARCHITECTS :
INSIDE
ARCHITECTURE N INTERIORS
Plot no. 72, S.P. Marg, C- Scheme
Jaipur, Rajasthan, India
Cont: 91 9950595991, 91 9982812777
e.mail: 4insideofficial@gmail.com

Partner

Sanjeev SHARMA
B.E (Electrical)

LEGENDS:

Mounting Height	TD	Symbol	Description
CEILING	FAN48"		CEILING FAN 48"
CEILING	FAN30"		CEILING FAN 30"
CEILING	CH		CHANDELIER
+93"	TL/W		Led Wall Tube Light Make:- Syntex Led Cat no:- SDC-15-30W
+93"	BULB		Led Bulb 20W Make:- Syntex Led Cat no:- SDC-20W-57K/3K
+93"	OL		12x2 Led Mirror Light Make:- Syntex Led Cat no:- SDC-15W-57K/3K
+78"	ML		Led 6" Down Lighter 20W (Surface Mounted) Make:- Syntex Led Cat no:- SDC-15W-57K/3K
CEILING	DL		Led 6" Down Lighter 20W (Surface Mounted) Make:- Syntex Led Cat no:- SDC-15W-57K/3K
VENTILATOR RT.	CR		CEILING ROSE
VENTILATOR HT	EXP		9" DIA FRESH AIR FAN
+24"	2xSB		2xSWITCH BOARD
+42"	SB		SWITCH BOARD(8A SOCKET & SWITCH)
+24"	TEL		TELEPHONE POINT
+24"	LP TEL		6 A PLUG POINT FOR TELEPHONE
+48"	TV		TV COAXIAL POINT
+48"	LP TV		8 A PLUG POINT FOR TV
+24"	LP		6 A PLUG POINT FOR SIDE TABL
+72"	LP-CH		6 A PLUG POINT FOR CHIMNEY
+12"	LP PC		6 A PLUG FOR COMPUTER POINT
+93"	SAC		SPLIT AC INDOOR UNIT
+42"	PP-MIX		16 A POWER POINT FOR MIXER
+42"	PP-MC		16 A POWER POINT FOR MICROWAVE
+78"	PP-G		16 A POWER POINT FOR GEYSER
+54"	PP-F		16 A POWER POINT FOR FRIDGE
+78"	PP-WP		16 A POWER POINT FOR WATER PURIFIER
+48"	PP-WM		16 A POWER POINT FOR WASHING MACHINE
+12"	PP-INV		16 A POWER POINT FOR INVERTOR
+93"	PP-AC		25A SWITCH/MCB FOR AC
	CH		CHAMBER(2' X 2')
+18"			8A 2 NOS. SOCKET +1 NOS. 16A SWITCH TELEPHONE/LAN
+60"	MCB DB		MCB DISTRIBUTION BOARD
			CAMERA
			WALL FAN

PROJECT:
PROPOSED RESIDENTIAL FLATS ON PLOT NO.-13A & 14 SCHEME - SUMER NAGR VISTAR 'N' BLOCK, JAIPUR

NAME OF DRAWING: STILT FLOOR ELECTRICAL ROUTE LAYOUT (TRANSFORMER, RMU, METER PANEL ELECTRICAL CABLE)

DRAWING: WORKING DRAWING

PROJECT NO. : DATE : 19, Feb. -2024

SCALE : NTS

REV NO. : R-0

DRAWING NO. : A-01

P.NO.
04

P.NO.
05

P.NO.
06

PROJECT NAME :
"UTSAV"
DEVELOPER NAME :
M/S VINAYAK REAL ESTATE
ARCHITECTS :
INSIDE
ARCHITECTURE N INTERIORS
Plot no. 72, S.P. Marg, C- Scheme
jaipur, rajasthan, India
cont: +91 9950595991, 91 9982812777
e.mail: 4insideofficial@gmail.com


P.NO.
15

100 MM HYDRANT PIPE

N

S

P.NO.13 B

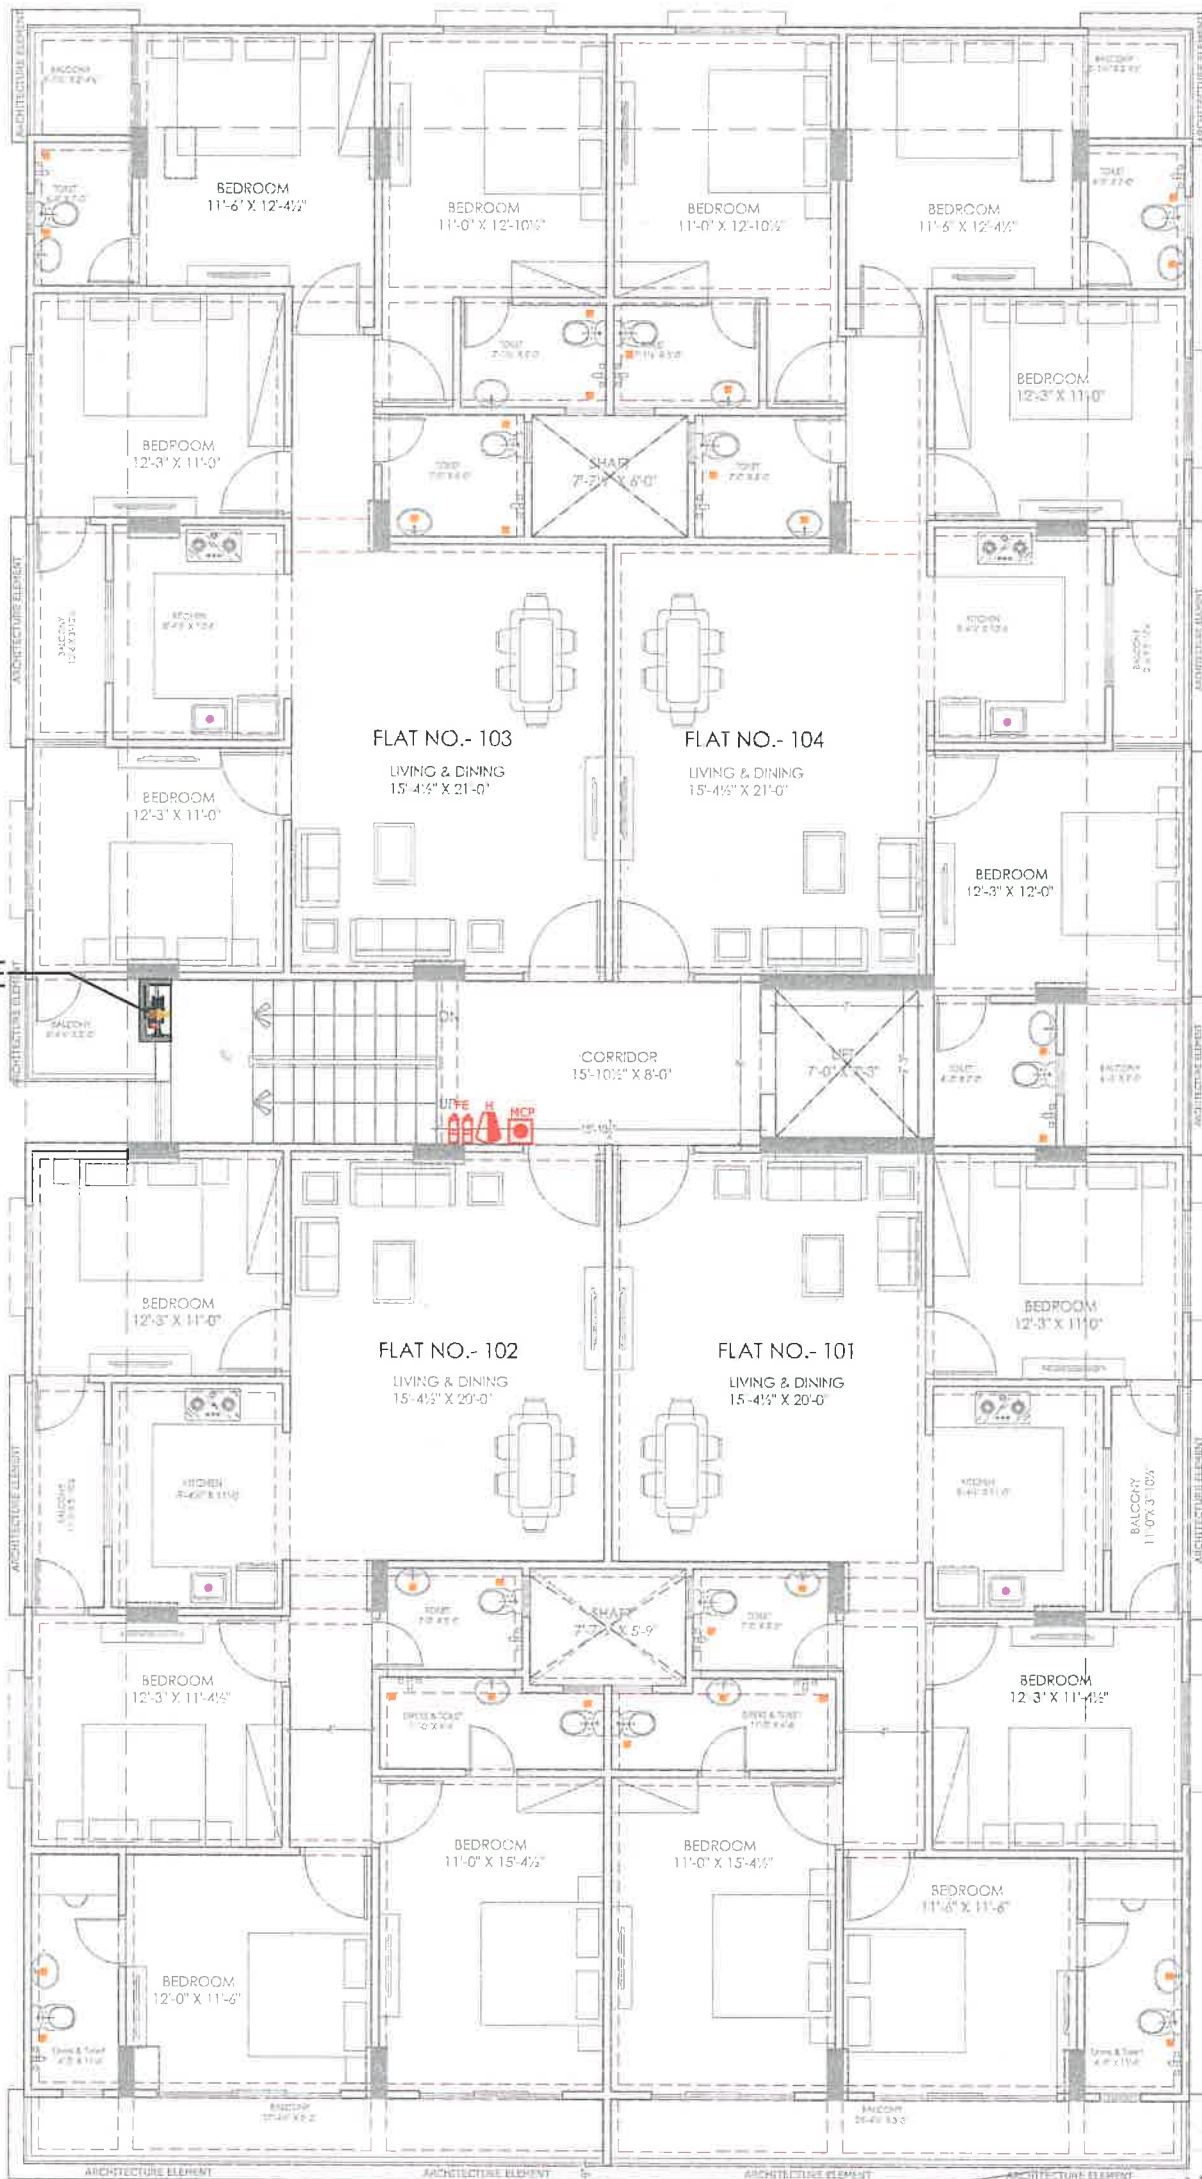

W

MAIN ROAD 60' WIDE

For VINAYAK REAL ESTATE
214
Partner

Er. SANJEEV SHARMA
B.E (Electrical)

TYPICAL FLOOR FIRE FIGHTING LAYOUT (G+5)

PROJECT NAME :
"UTSAV"
DEVELOPER NAME :
M/S VINAYAK REAL ESTATE
ARCHITECTS :
INSIDE
ARCHITECTURE N INTERIORS
Plot no. 72, S.P. Marg, C- Scheme
jaipur, rajasthan, India
cont: +91 9950595991, 91 9982812777
e.mail: 4insideofficial@gmail.com

100 MM HYDRANT PIPE

PLAN OF FIRE HOSE CABINET

LEGEND:-

FIRE HYDRANT MS PIPE	---
BALL VALVE	⋈
EXTERNAL FIRE HYDRANT	⚡
EXTERNAL FIRE HOSE CABINET	EFHC
FIRE HOSE CABINET	FHC
UPRIGHT SPRINKLER HEAD	⚙
PENDENT SPRINKLER HEAD	⚙
SIDE WALL SPRINKLER HEAD	⚙
FIRE EXTINGUISHER	⚡
FLOW SWITCH	FS
ISOLATION VALVE	IV
2 WAY FIRE BRIGADE INLET	⚡

PROJECT:
PROPOSED RESIDENTIAL FLATS
ON PLOT NO.-13A & 14
SCHEME - SUMER NAGR VISTAR
'N' BLOCK, JAIPUR. RAJASTHAN.

NAME OF DRAWING:
TYPICAL FLOOR FIRE FIGHTING
LAYOUT (G+5)

DRAWING
WORKING DRAWING

PROJECT NO. :
DATE :
06, Feb. - 2024

SCALE :
NTS

REV NO. :
R-0

DRAWING NO. :
A-01