


NOTE:-
1. ALL ROAD CROSSING ARE RCC HUMEP(NP3) UMO.

S.NO.	SYMBOL	LEGEND FOR SWD.	DESCRIPTION
1.		450X500mm	CATCH BASIN
2.		800X900mm	MANHOLE
3.		300Ø RCC PIPE (Slope 1:12/5)	
4.		250Ø/300Ø OVER FLOW PIPE	
5.		300mm WIDE DRAIN WITH SFRC GRATING (Slope 1:125/200/750)	
6.		300mm WIDE DRAIN WITH MS GRATING (Slope 1:750)	
7.		TUBE WELL	
8.		3.0X3.0X3.0 mt. RAIN WATER HARVESTING PIT WITH DE - SILLING CHAMBER	
9.		1200X1200X1200mm DRAINAGE SUMP	



V Srinivasan

PLUMBING DWG.

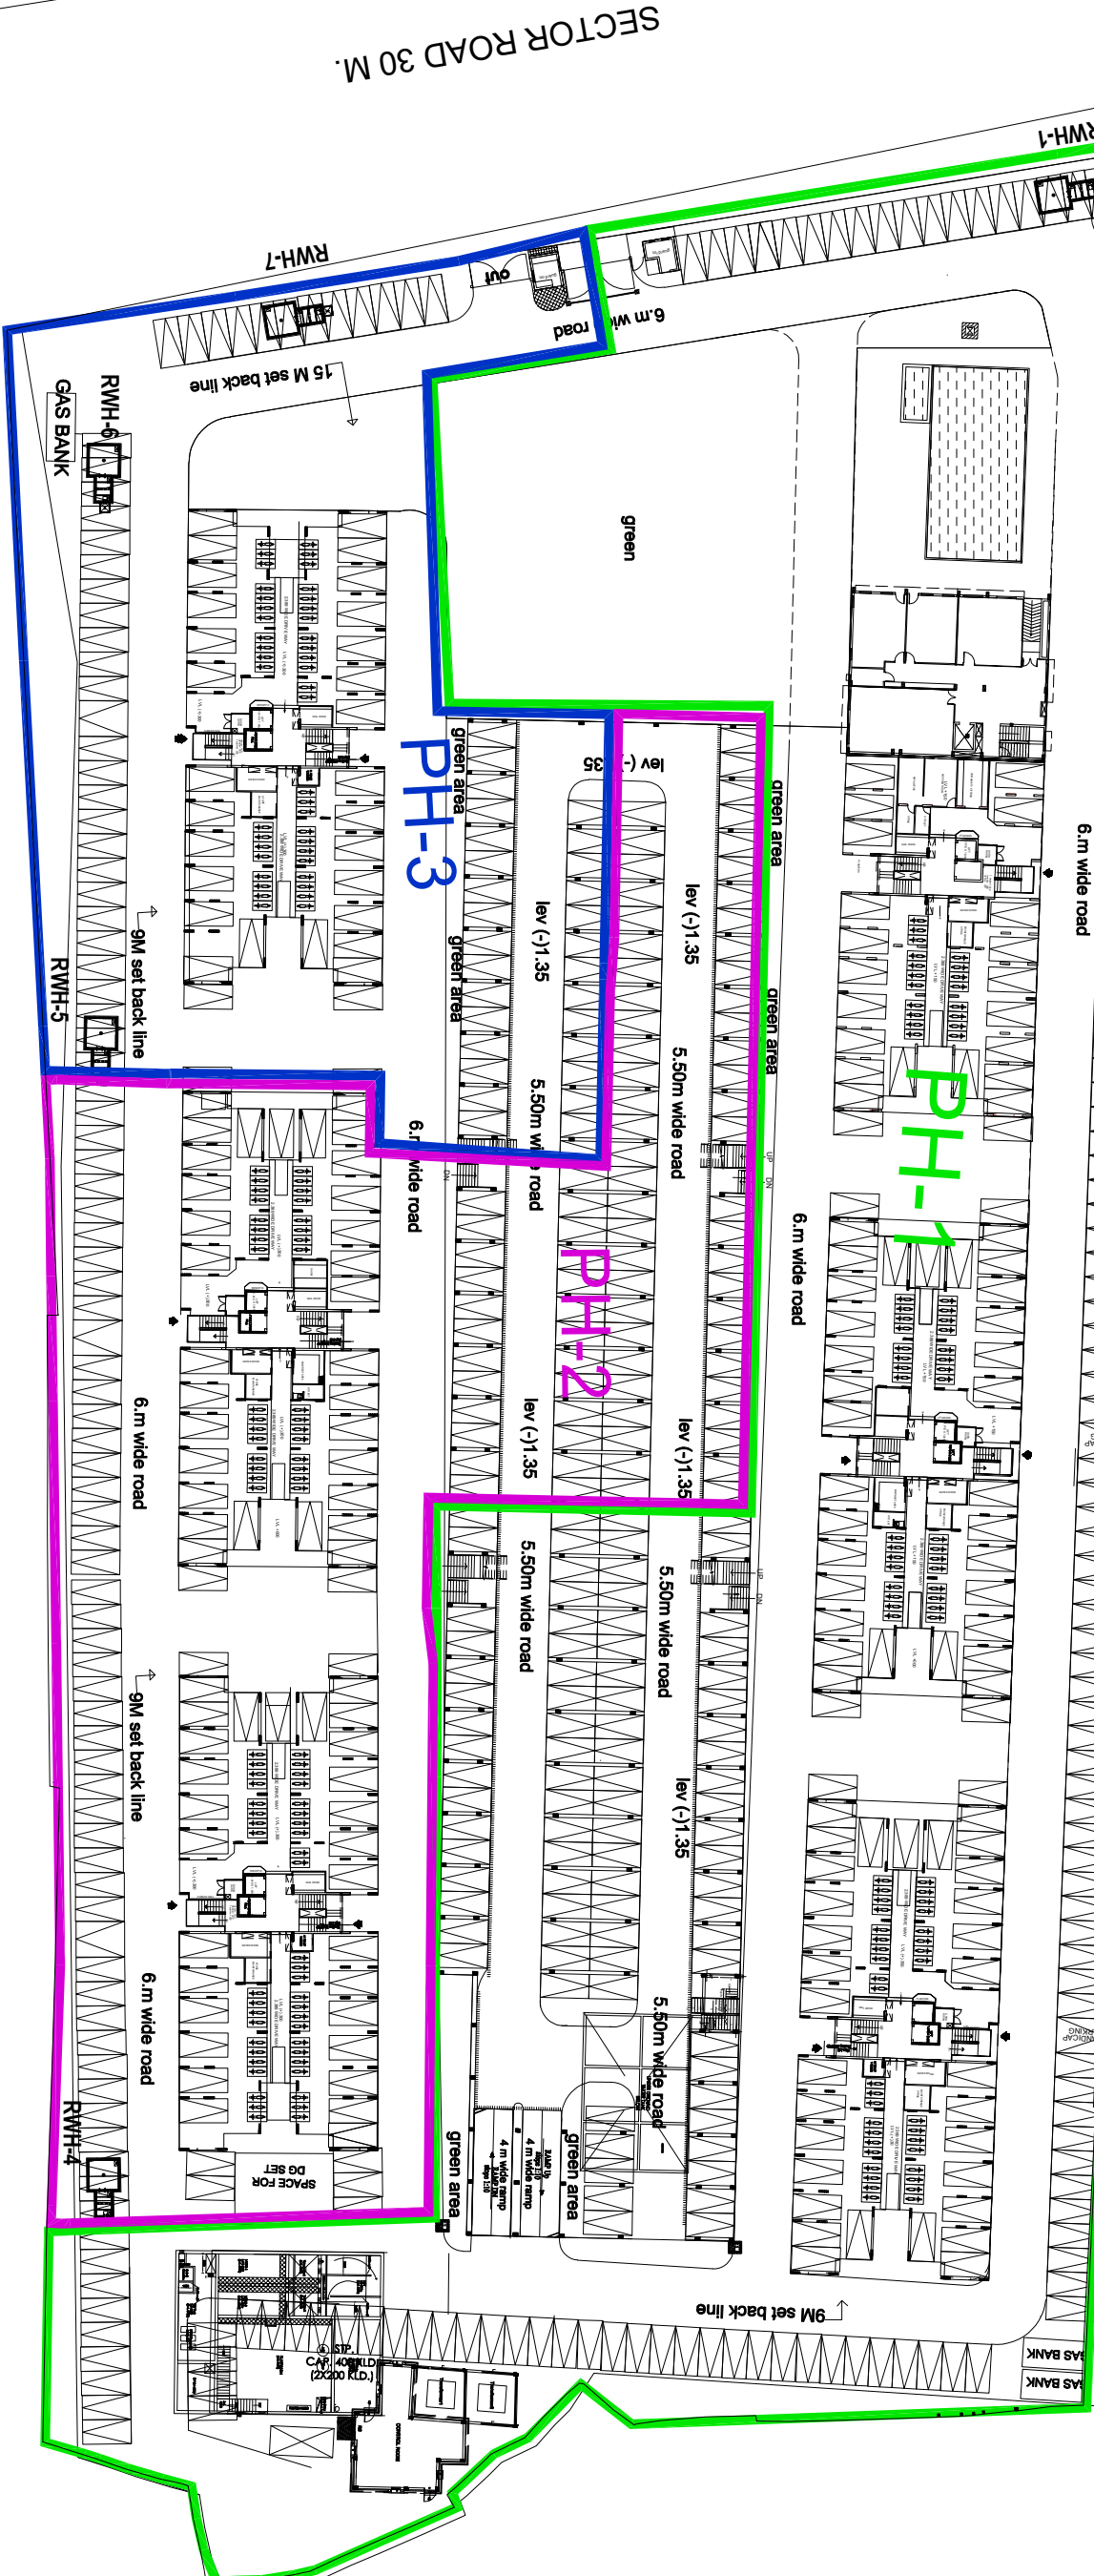

SECTOR ROAD 30 M.

PROJECT :

ASHIANA DAKSH

OWNERS NAME

Ashiana Housing Ltd.

304, Southern park, saket District Centre,
Saket New Delhi - 110017
Phone no. 011- 42 65 42 65

Services consultants:-

SRIAN ENGINEERING CONSULTANTS
(Building Engineering Services)
C2/357, 1st Floor, JANAKPURI, NEW DELHI - 110058
Tel: 011-40532854
Email: srianpie@gmail.com

DRG. TITLE:

Site plan
SVD. system
Plumbing dwg.

SCALE:

NTS

DATE:

10.02.20

Drawn By

Samtosh

Checked By

Srinivasan

Approved By

S.K.Palit

Rev.No.

Rev.Date

Remarks

GFC Drawing