


IN PROGRESS

NOT FOR CONSTRUCTION

KEY PLAN

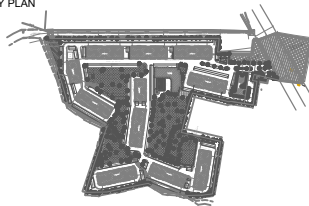

NOTES :-

1. ALL DIMENSION ARE IN MM.

R1	25.11.21	ARCH.	ISSUE FOR EIA SUBMISSION	ANK	DVA
R0	16.09.15	ARCH.	ISSUE FOR EIA SUBMISSION	ANS	SHS
Rev	Date	Issued to	Description	By	Chk

The concepts and information contained in this document are the copyright of Black & White Engineering Services Pvt. Ltd. Use or copying of the document in whole or in part without the written permission of Black & White Engineering Services Pvt. Ltd. constitutes an infringement of copyright. Do not scale drawings. If in doubt, ask!

ARCHITECTS :

b.sengupta architect

A305,RANGOLIA SHIANAVILLAGEBHIWADI.
PH. 0988748263

MEP CONSULTANT :



STRUCTURAL CONSULTANT :

Developer:-

ASHIANA HOUSING LTD
Unit no.4 & 5,Plot No.D-2,3rd Floor,
Southern park, saket District Centre,
Saket New Delhi - 110017
Phone no. 011- 42 65 42 65

Project Name

ASHIANA TARANG AT BHIWADI

Title


SITE PLAN
WATER SUPPLY LAYOUT


Discipline PLUMBING SERVICE Status EIA SUBMISSION

Designed By ANS Checked By SHS Approved By DKT

Project No. 15280 Date 15.09.2015 Scale 1:400 (at A0)


Drawing No. 15280-P-A0-0401 Revision R1

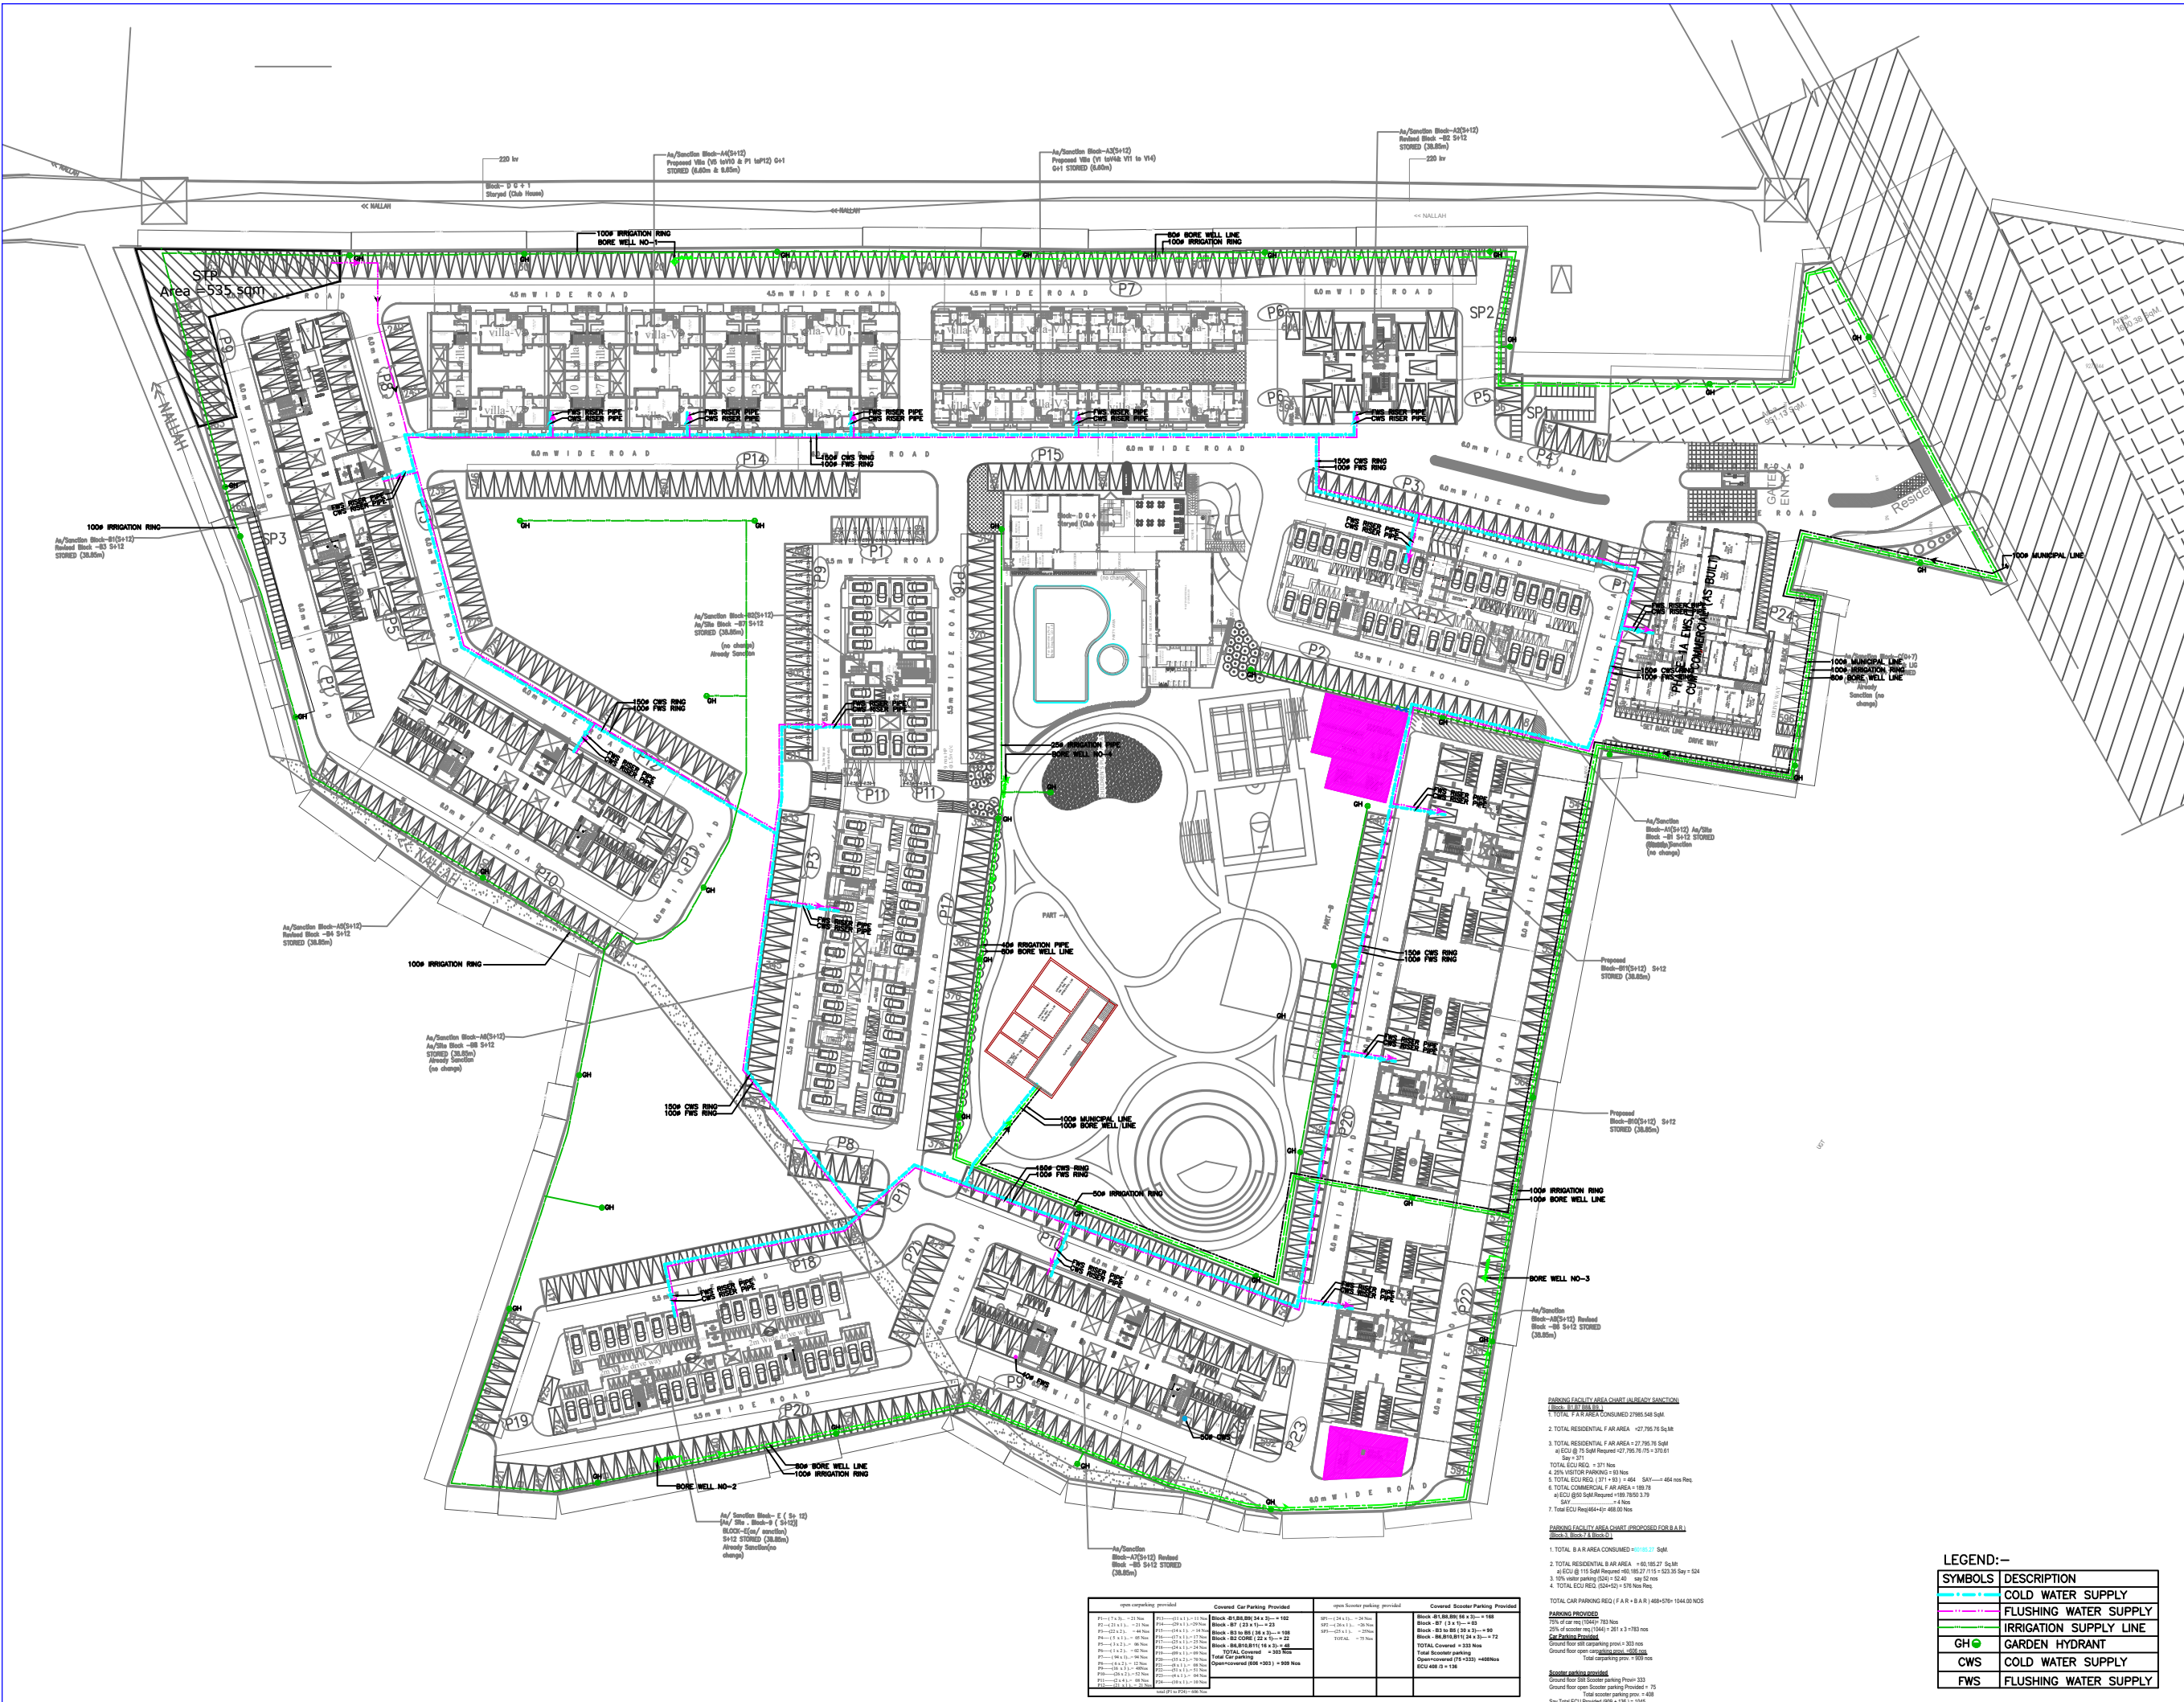

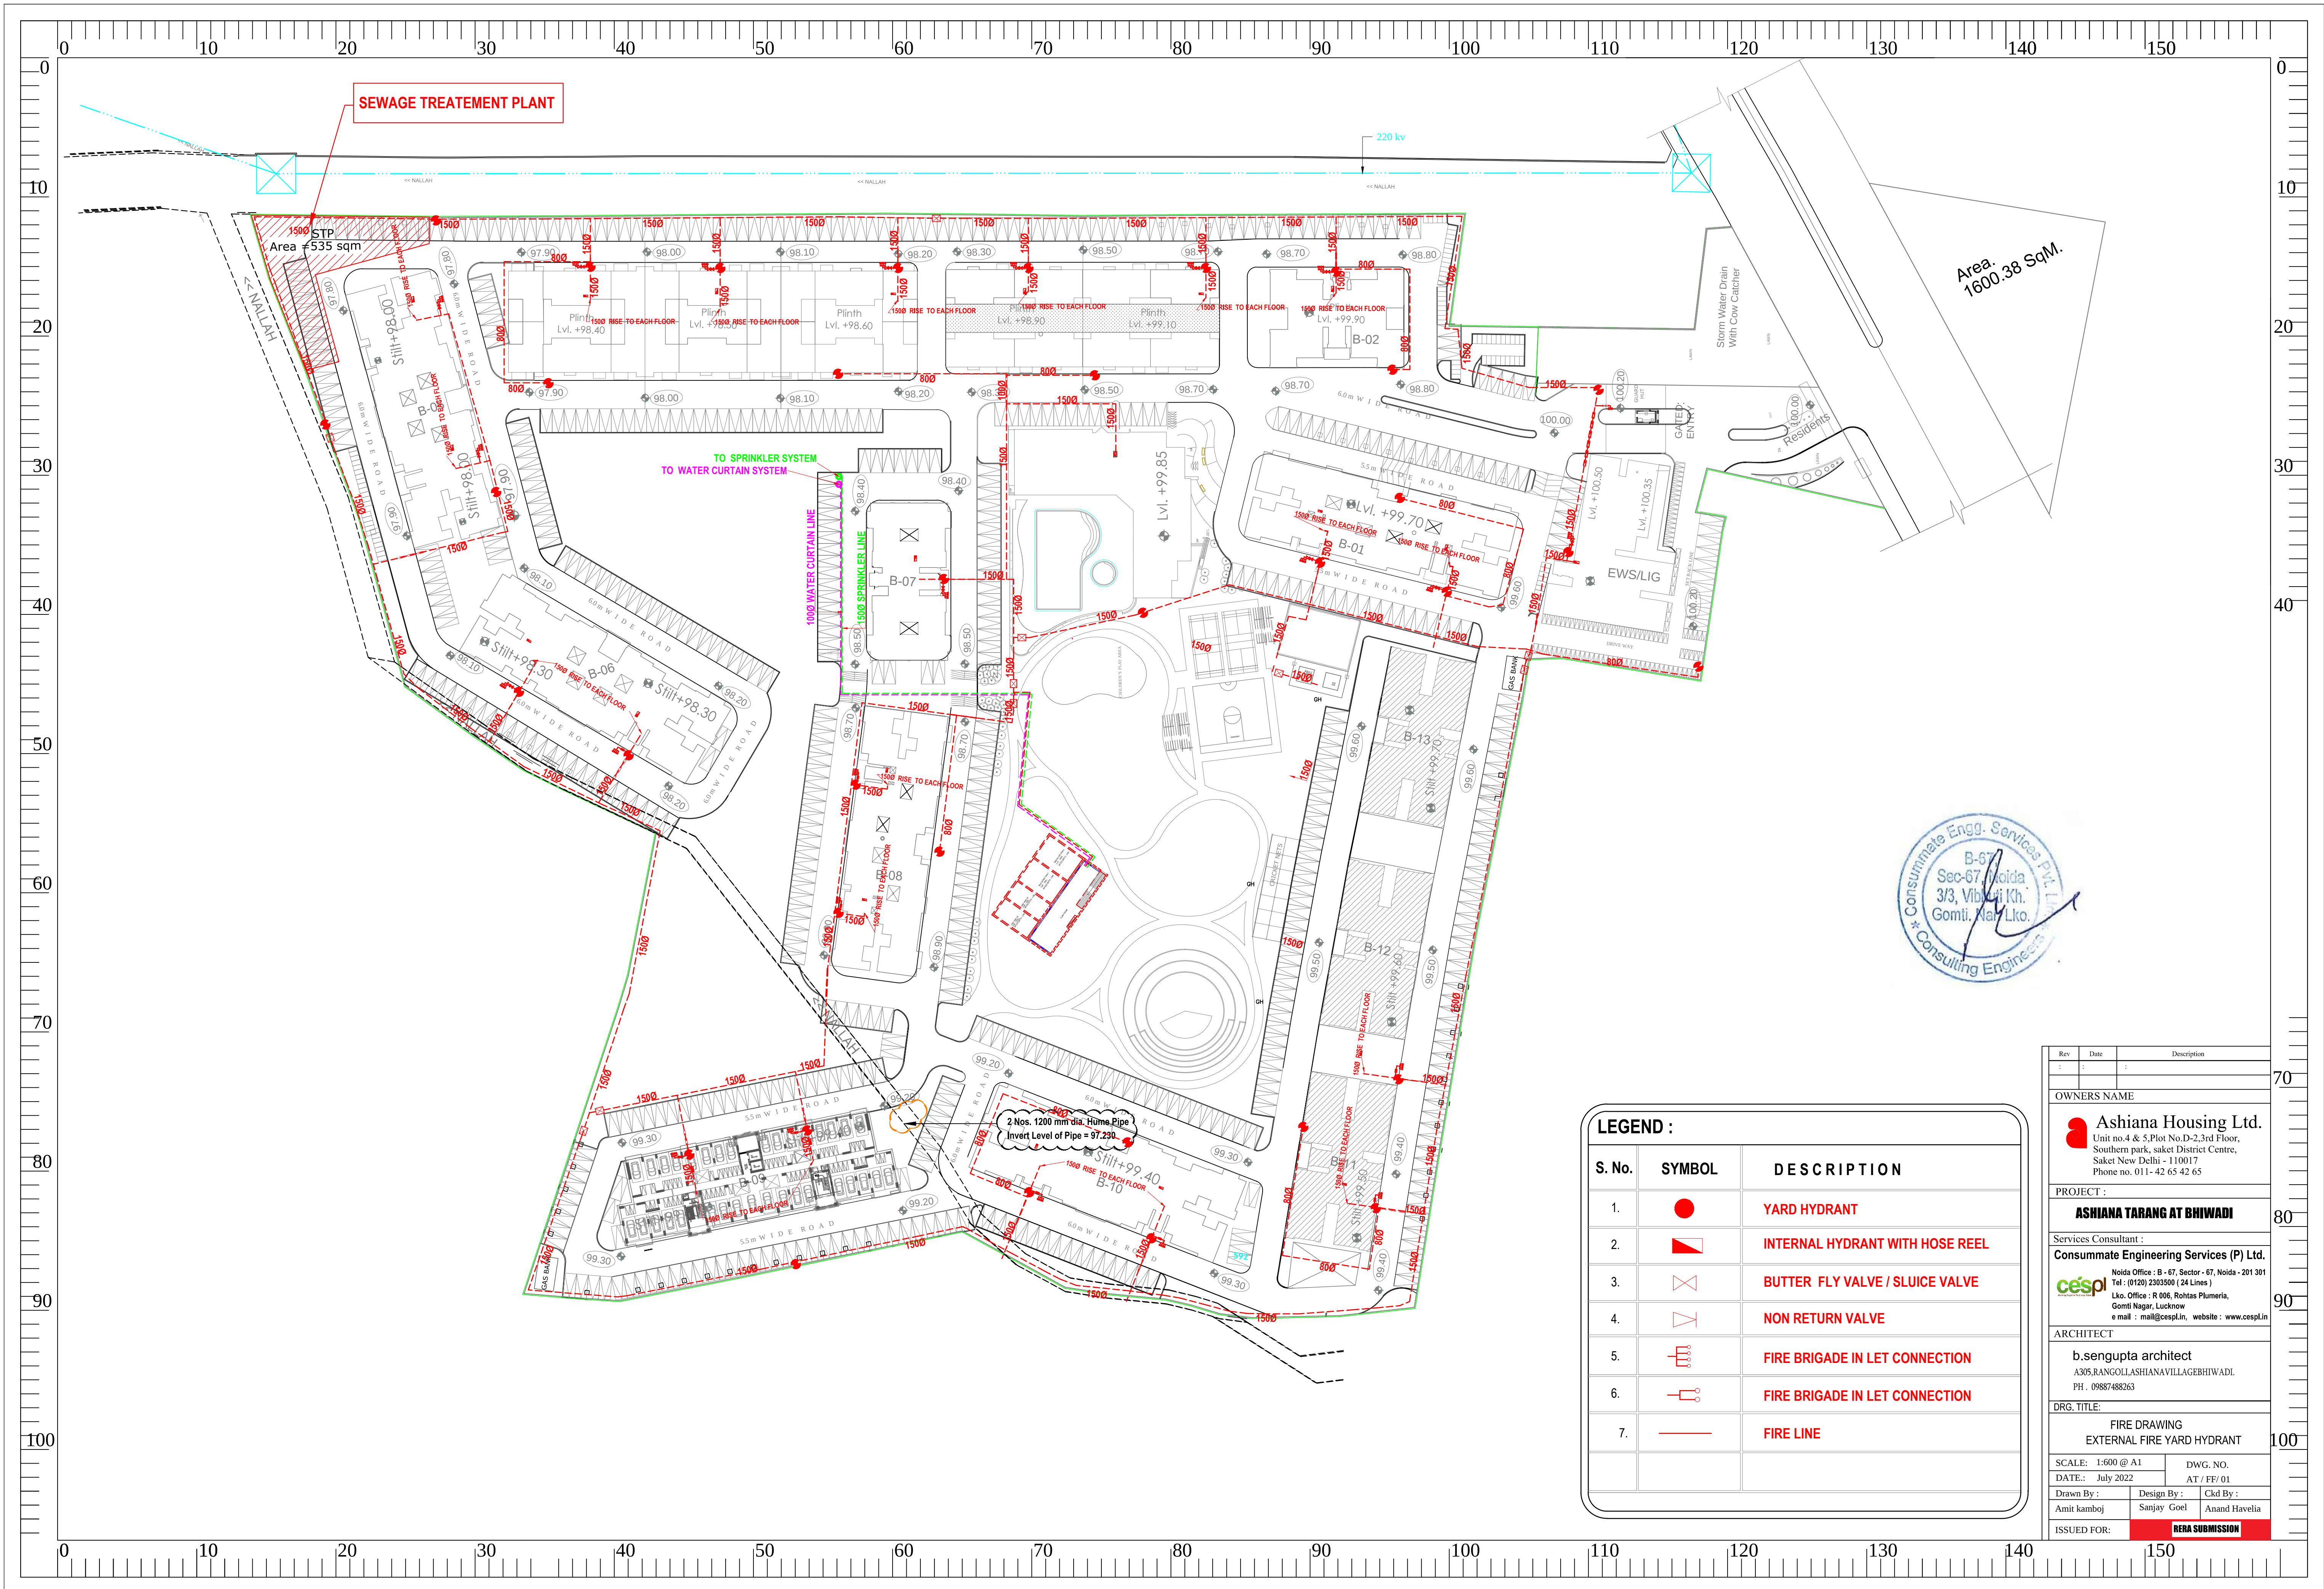

LEGEND :		
S. No.	SYMBOL	DESCRIPTION
1.	●	YARD HYDRANT
2.	▴	INTERNAL HYDRANT WITH HOSE REEL
3.	✕	BUTTER FLY VALVE / SLUICE VALVE
4.	▽	NON RETURN VALVE
5.	≡	FIRE BRIGADE IN LET CONNECTION
6.	≡	FIRE BRIGADE IN LET CONNECTION
7.	—	FIRE LINE


Rev	Date	Description
OWNERS NAME		
Ashiana Housing Ltd. Unit no.4 & 5, Plot No.D-2, 3rd Floor, Southern park, Saket District Centre, Saket New Delhi - 110017 Phone no. 011- 42 65 42 65		
PROJECT :		
ASHIANA TARANG AT BHIWADI		
Services Consultant :		
Consummate Engineering Services (P) Ltd. Noida Office : B - 67, Sector - 67, Noida - 201 301 Tel : (0120) 2303500 (24 Lines) Lko. Office : R 006, Rohas Plumeria, Gomti Nagar, Lucknow e mail : mail@cespln, website : www.cespln		
ARCHITECT		
b.sengupta architect A305,RANGOLLIASHIANAVILLAGEBHIWADI. PH. : 09887488263		
DRG. TITLE:		
FIRE DRAWING EXTERNAL FIRE YARD HYDRANT		
SCALE: 1:600 @ A1		DWG. NO.
DATE: July 2022		AT / FF/ 01
Drawn By : Amit kamboj	Design By : Sanjay Goel	Ckd By : Anand Havelia
ISSUED FOR:		REDA SUBMISSION

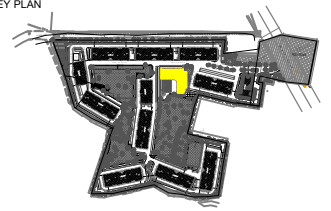

NOTES :-



1. ALL DIMENSION ARE IN MM.

RECHARGE PIT SIZE { L } = 3000 MM { W } = 3000 MM EFFECTIVE DEPTH = 3000 MM	DESILTING TANK SIZE { L } = 2500 MM { W } = 1500 MM EFFECTIVE DEPTH { D } = 1200 MM
--	--

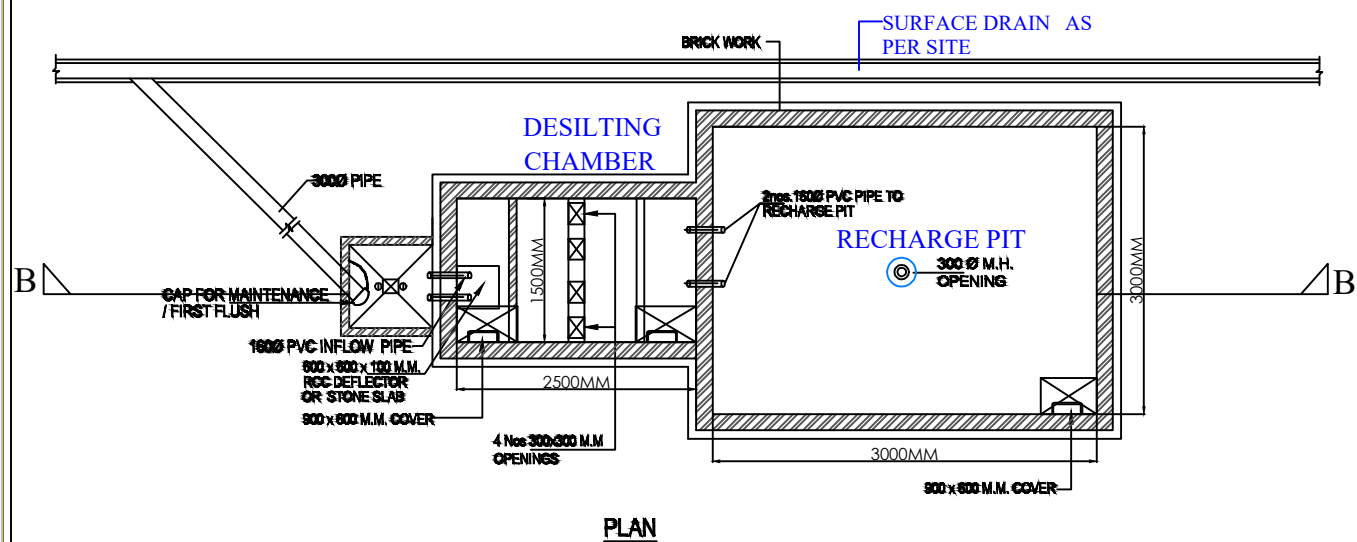

DESSILTING / SETTLING CHAMBER & RECHARGE PIT

- 1) ALL BRICK WORK / BAFFLE WALL IN RWH SHALL BE STRICTLY AS PER STRUCTURE CONSULTANTS DESIGN & DETAIL.**
- 2) THE BOREWELL PIPE OF RECHARGE PIT SHOULD BE LEFT ATLEAST 5 M ABOVE THE KNOWN HIGHEST WATER TABLE TO AVOID ANY POSSIBLE POLLUTION TO THE AQUIFER.**

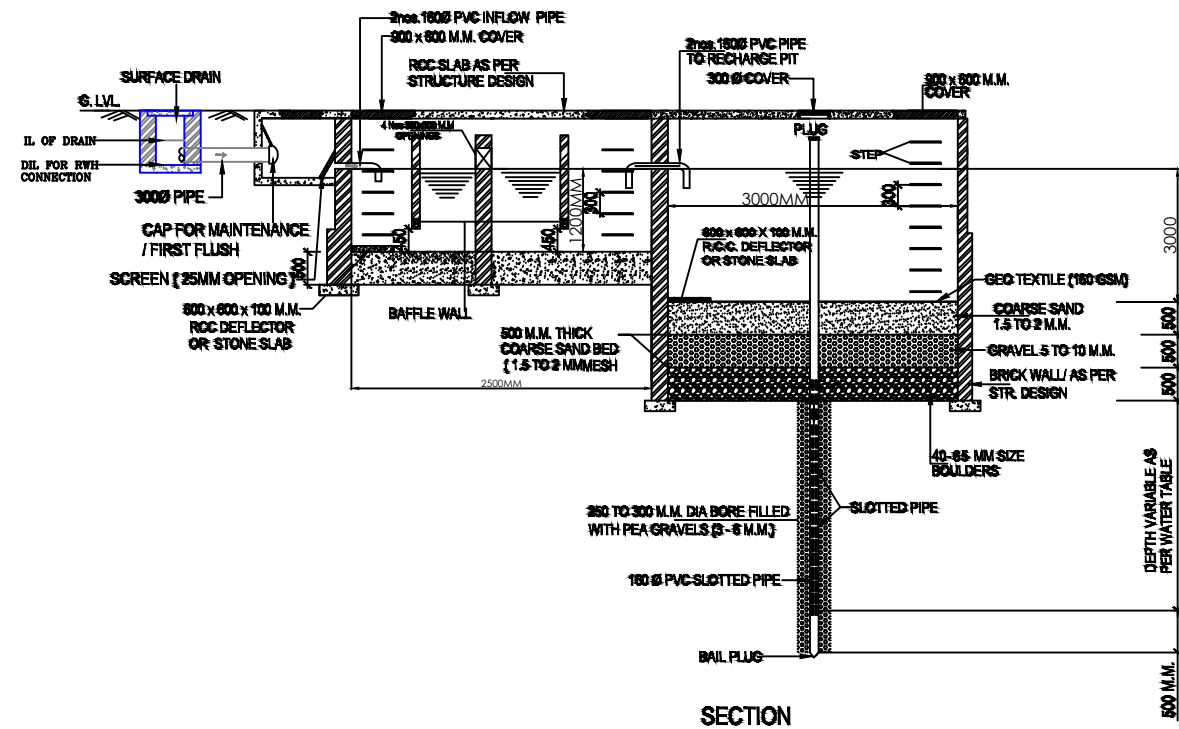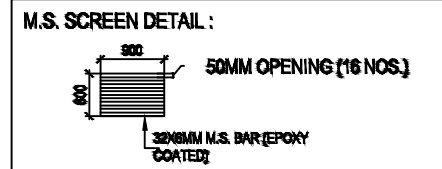

R0	12.10.17	ARCH.	ISSUED FOR GFC	DKK	MKS
Rev	Date	Issued to	Description	By	Chk

The concepts and information contained in this document are the copyright of think BIM Technical Services Pvt. Ltd. Use or copying of the document in whole or in part without the written permission of think BIM Technical Services Pvt. Ltd. constitutes an infringement of copyright. Do not scale drawings. If in doubt, ask!

ARCHITECTS :

A305,RANGOLI,ASHIANAVILLAGEBHIWADI.
PH . 09887488263

MEP CONSULTANT : Unit No. 228-236, 2nd Floor
Tower A Spaze i-Tech Park,
Sohna Road, Sector-49,
Gurgaon- 122018 Haryana, India
PH-0124-4069379, 4145060-61

STRUCTURAL CONSULTANT :

Developer:-

ASHIANA HOUSING LTD
Unit no.4 & 5,Plot No.D-2,3rd Floor,
Southern park, saket District Centre,
Saket New Delhi - 110017
Phone no. 011- 42 65 42 65

Project Name

ASHIANA TARANG AT BHIWADI

Title	Author	Year	Journal	Volume	Issue	Page
1. The Effect of the 1997 Asian Financial Crisis on the U.S. Economy	John H. Coatsworth	1998	Journal of International Economics	50	1	1-15
2. The Impact of the 1997 Asian Financial Crisis on the U.S. Economy	John H. Coatsworth	1998	Journal of International Economics	50	1	16-30
3. The Effect of the 1997 Asian Financial Crisis on the U.S. Economy	John H. Coatsworth	1998	Journal of International Economics	50	1	31-45
4. The Impact of the 1997 Asian Financial Crisis on the U.S. Economy	John H. Coatsworth	1998	Journal of International Economics	50	1	46-60
5. The Effect of the 1997 Asian Financial Crisis on the U.S. Economy	John H. Coatsworth	1998	Journal of International Economics	50	1	61-75
6. The Impact of the 1997 Asian Financial Crisis on the U.S. Economy	John H. Coatsworth	1998	Journal of International Economics	50	1	76-90
7. The Effect of the 1997 Asian Financial Crisis on the U.S. Economy	John H. Coatsworth	1998	Journal of International Economics	50	1	91-105
8. The Impact of the 1997 Asian Financial Crisis on the U.S. Economy	John H. Coatsworth	1998	Journal of International Economics	50	1	106-120
9. The Effect of the 1997 Asian Financial Crisis on the U.S. Economy	John H. Coatsworth	1998	Journal of International Economics	50	1	121-135
10. The Impact of the 1997 Asian Financial Crisis on the U.S. Economy	John H. Coatsworth	1998	Journal of International Economics	50	1	136-150


RAIN WATER HARVESTING DETAIL

Discipline PLUMBING SERVICE		Status GFC
Designed By VIK	Checked By MKS	Approved By DKT
Project No. 15280	Date 21.09.17	Scale NTS (at A1)
Drawing No. 16280-P-A1-0102		Revision R0

IN PROGRESS


NOT FOR CONSTRUCTION

KEY PLAN

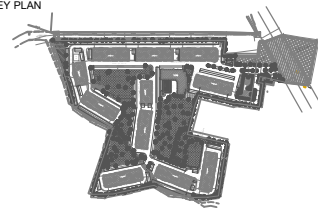


NOTES:-

1: ALL DIMENSION ARE IN MM.

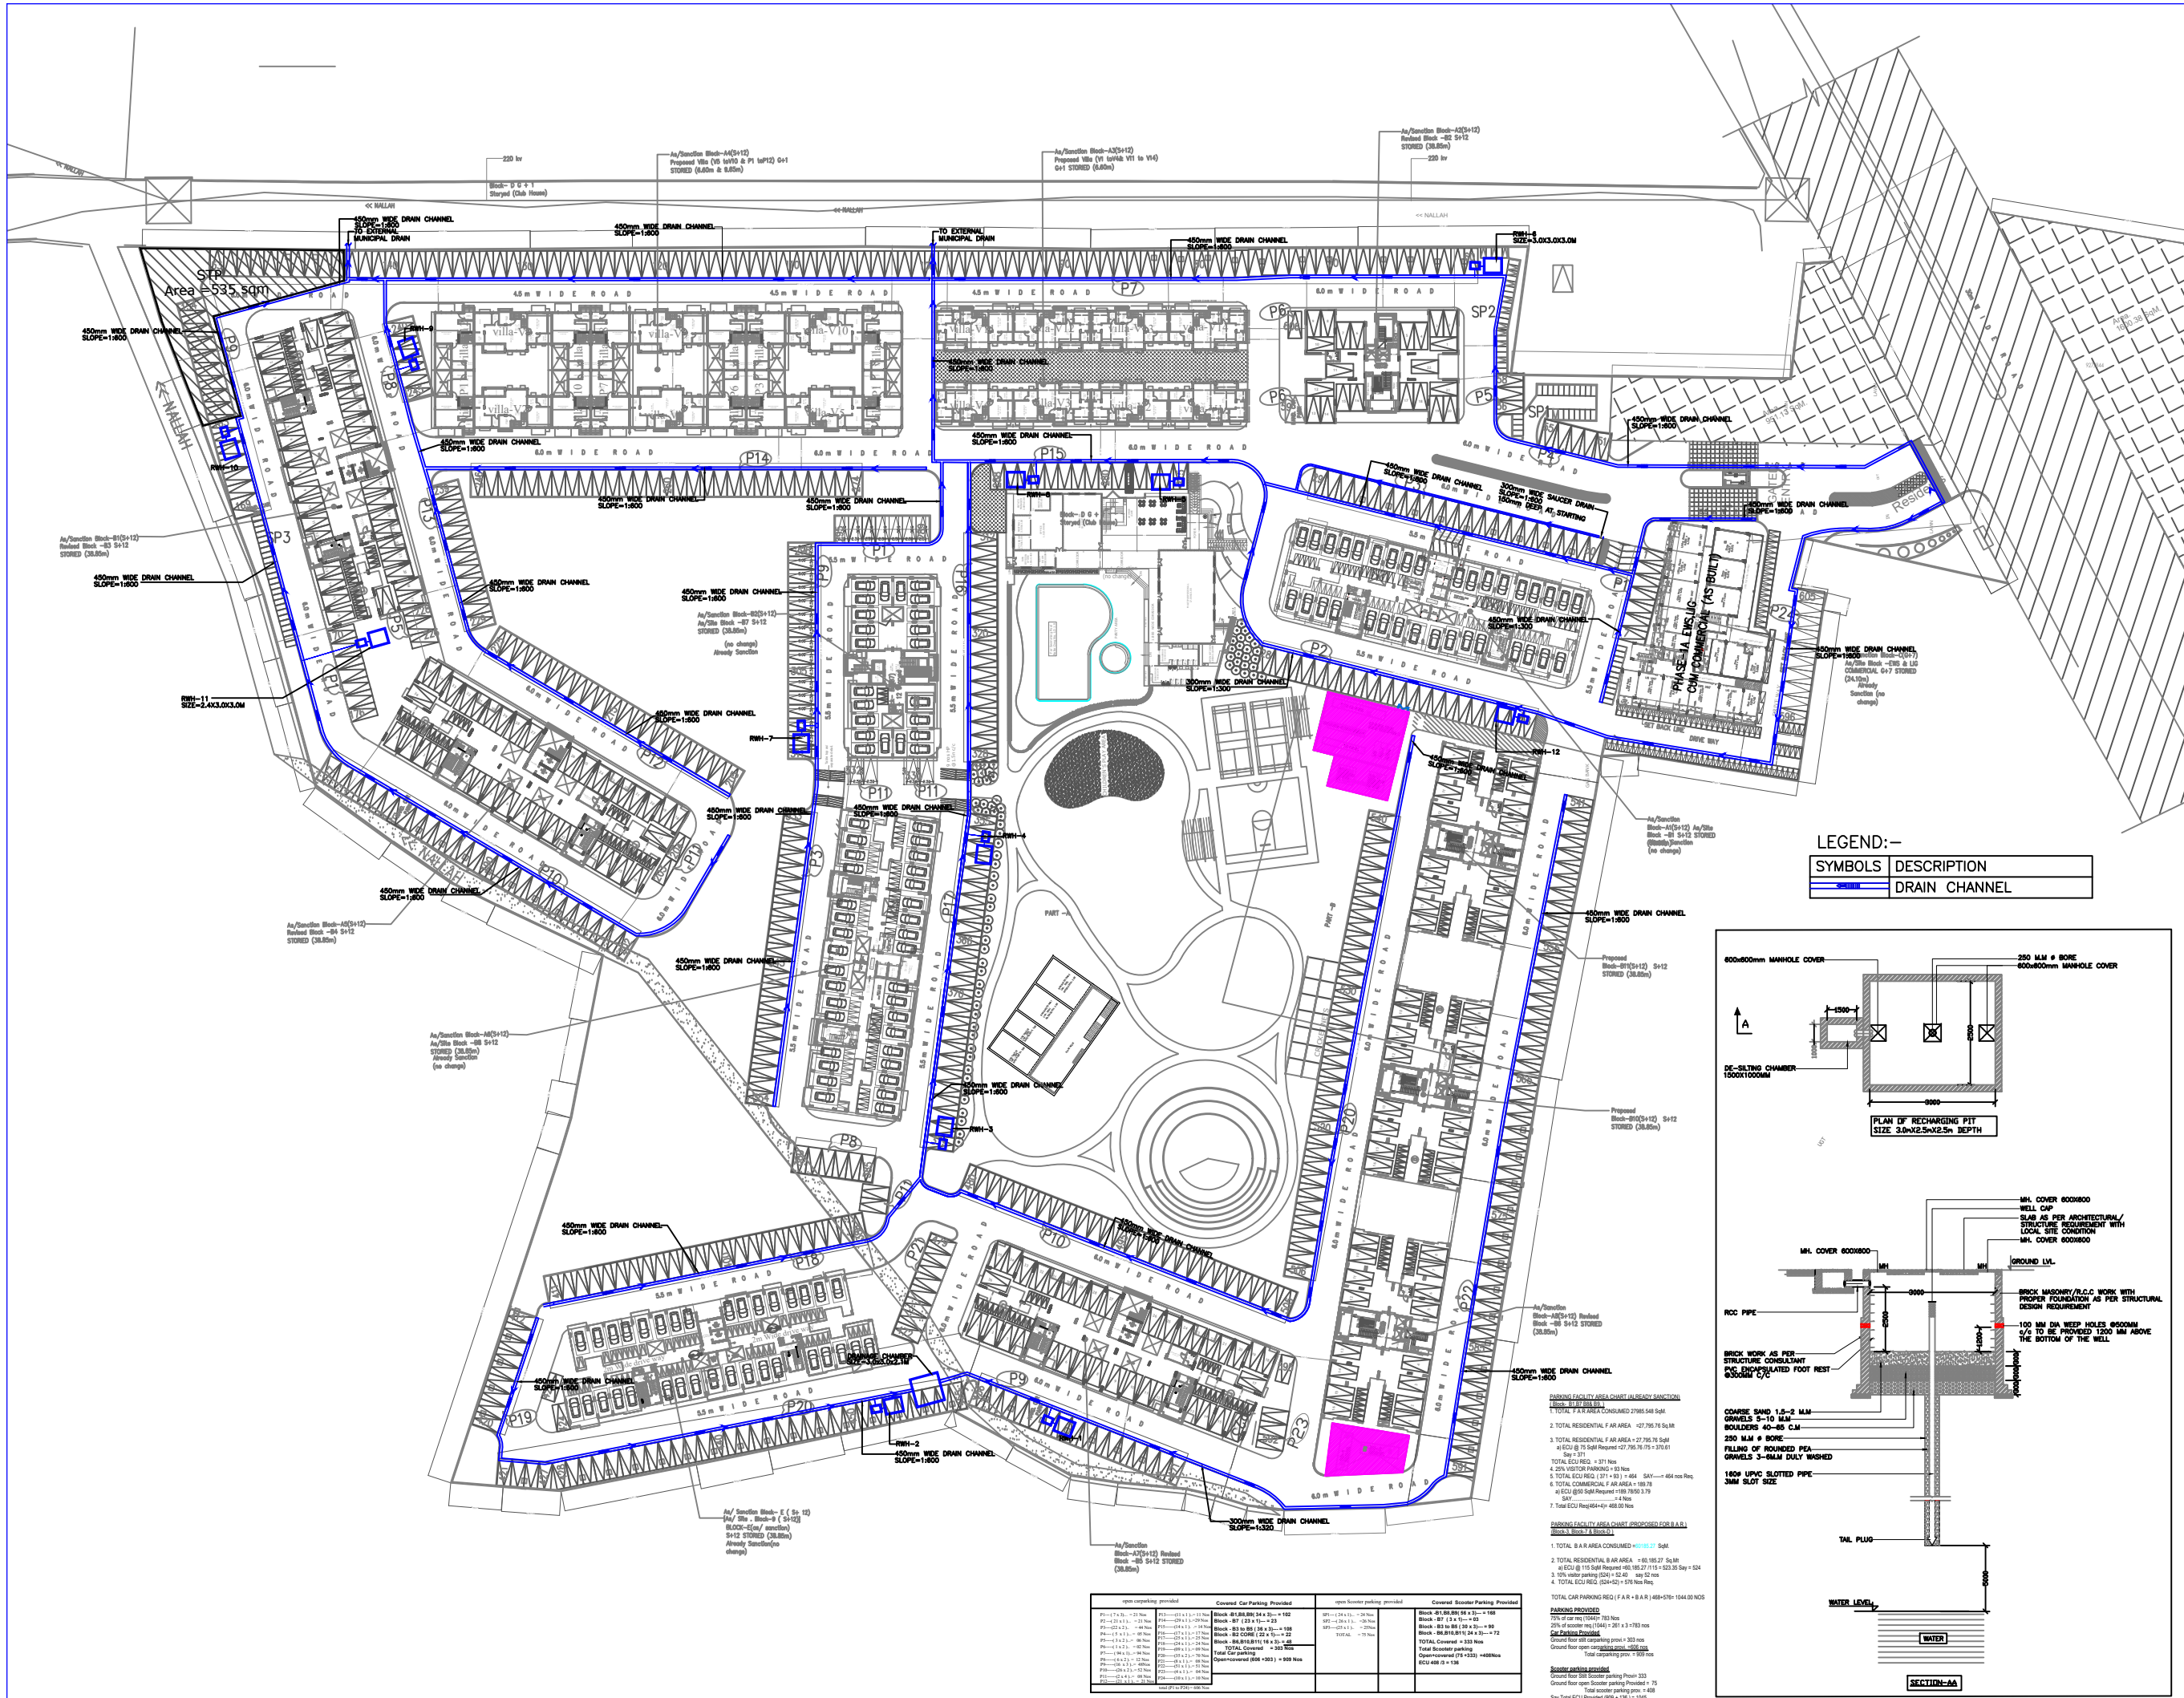

LEGEND:-

SYMBOLS	DESCRIPTION
	DRAIN CHANNEL

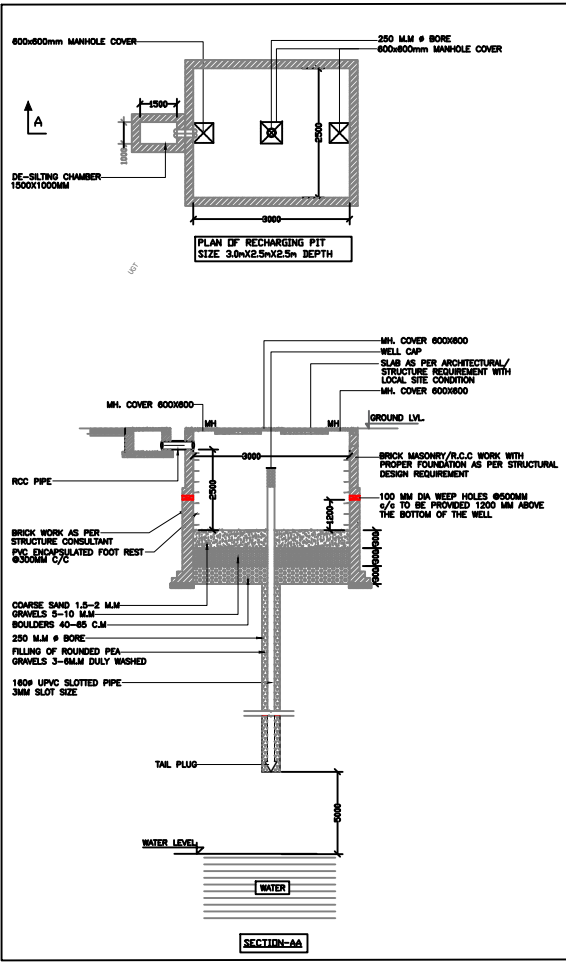

R1	25.11.21	ARCH.	ISSUE FOR EIA SUBMISSION	ANK	DVA
R0	16.09.15	ARCH.	ISSUE FOR EIA SUBMISSION	ANS	SHS
Rev	Date	Issued to	Description	By	Chk

The concepts and information contained in this document are the copyright of Black & White Engineering Services Pvt. Ltd. Use or copying of the document in whole or in part without the written permission of Black & White Engineering Services Pvt. Ltd. constitutes an infringement of copyright. Do not scale drawings. If in doubt, ask!

ARCHITECTS :-

b.sengupta architect
A305,RANGOLI,ASHIANA,VILLAGE,BHIWADI.
PH. 0988748263

MEP CONSULTANT :-



STRUCTURAL CONSULTANT :-

Developer:-

ASHIANA HOUSING LTD
Unit no.4 & 5,Plot No.D-2,3rd Floor,
Southern park, saket District Centre,
Saket New Delhi - 110017
Phone no. 011- 42 65 42 65

Project Name

ASHIANA TARANG AT BHIWADI


Title
**SITE PLAN
DRAINAGE LAYOUT**

Discipline PLUMBING SERVICE	Status EIA SUBMISSION
Designed By ANS	Checked By SHS
Project No. 15280	Date 15.09.2015
Drawing No. 15280-P-A0-0400	Scale 1:400
	Revision R1

IN PROGRESS


NOT FOR CONSTRUCTION

KEY PLAN

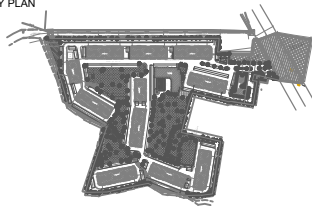



NOTES :-

1. ALL DIMENSION ARE IN MM.

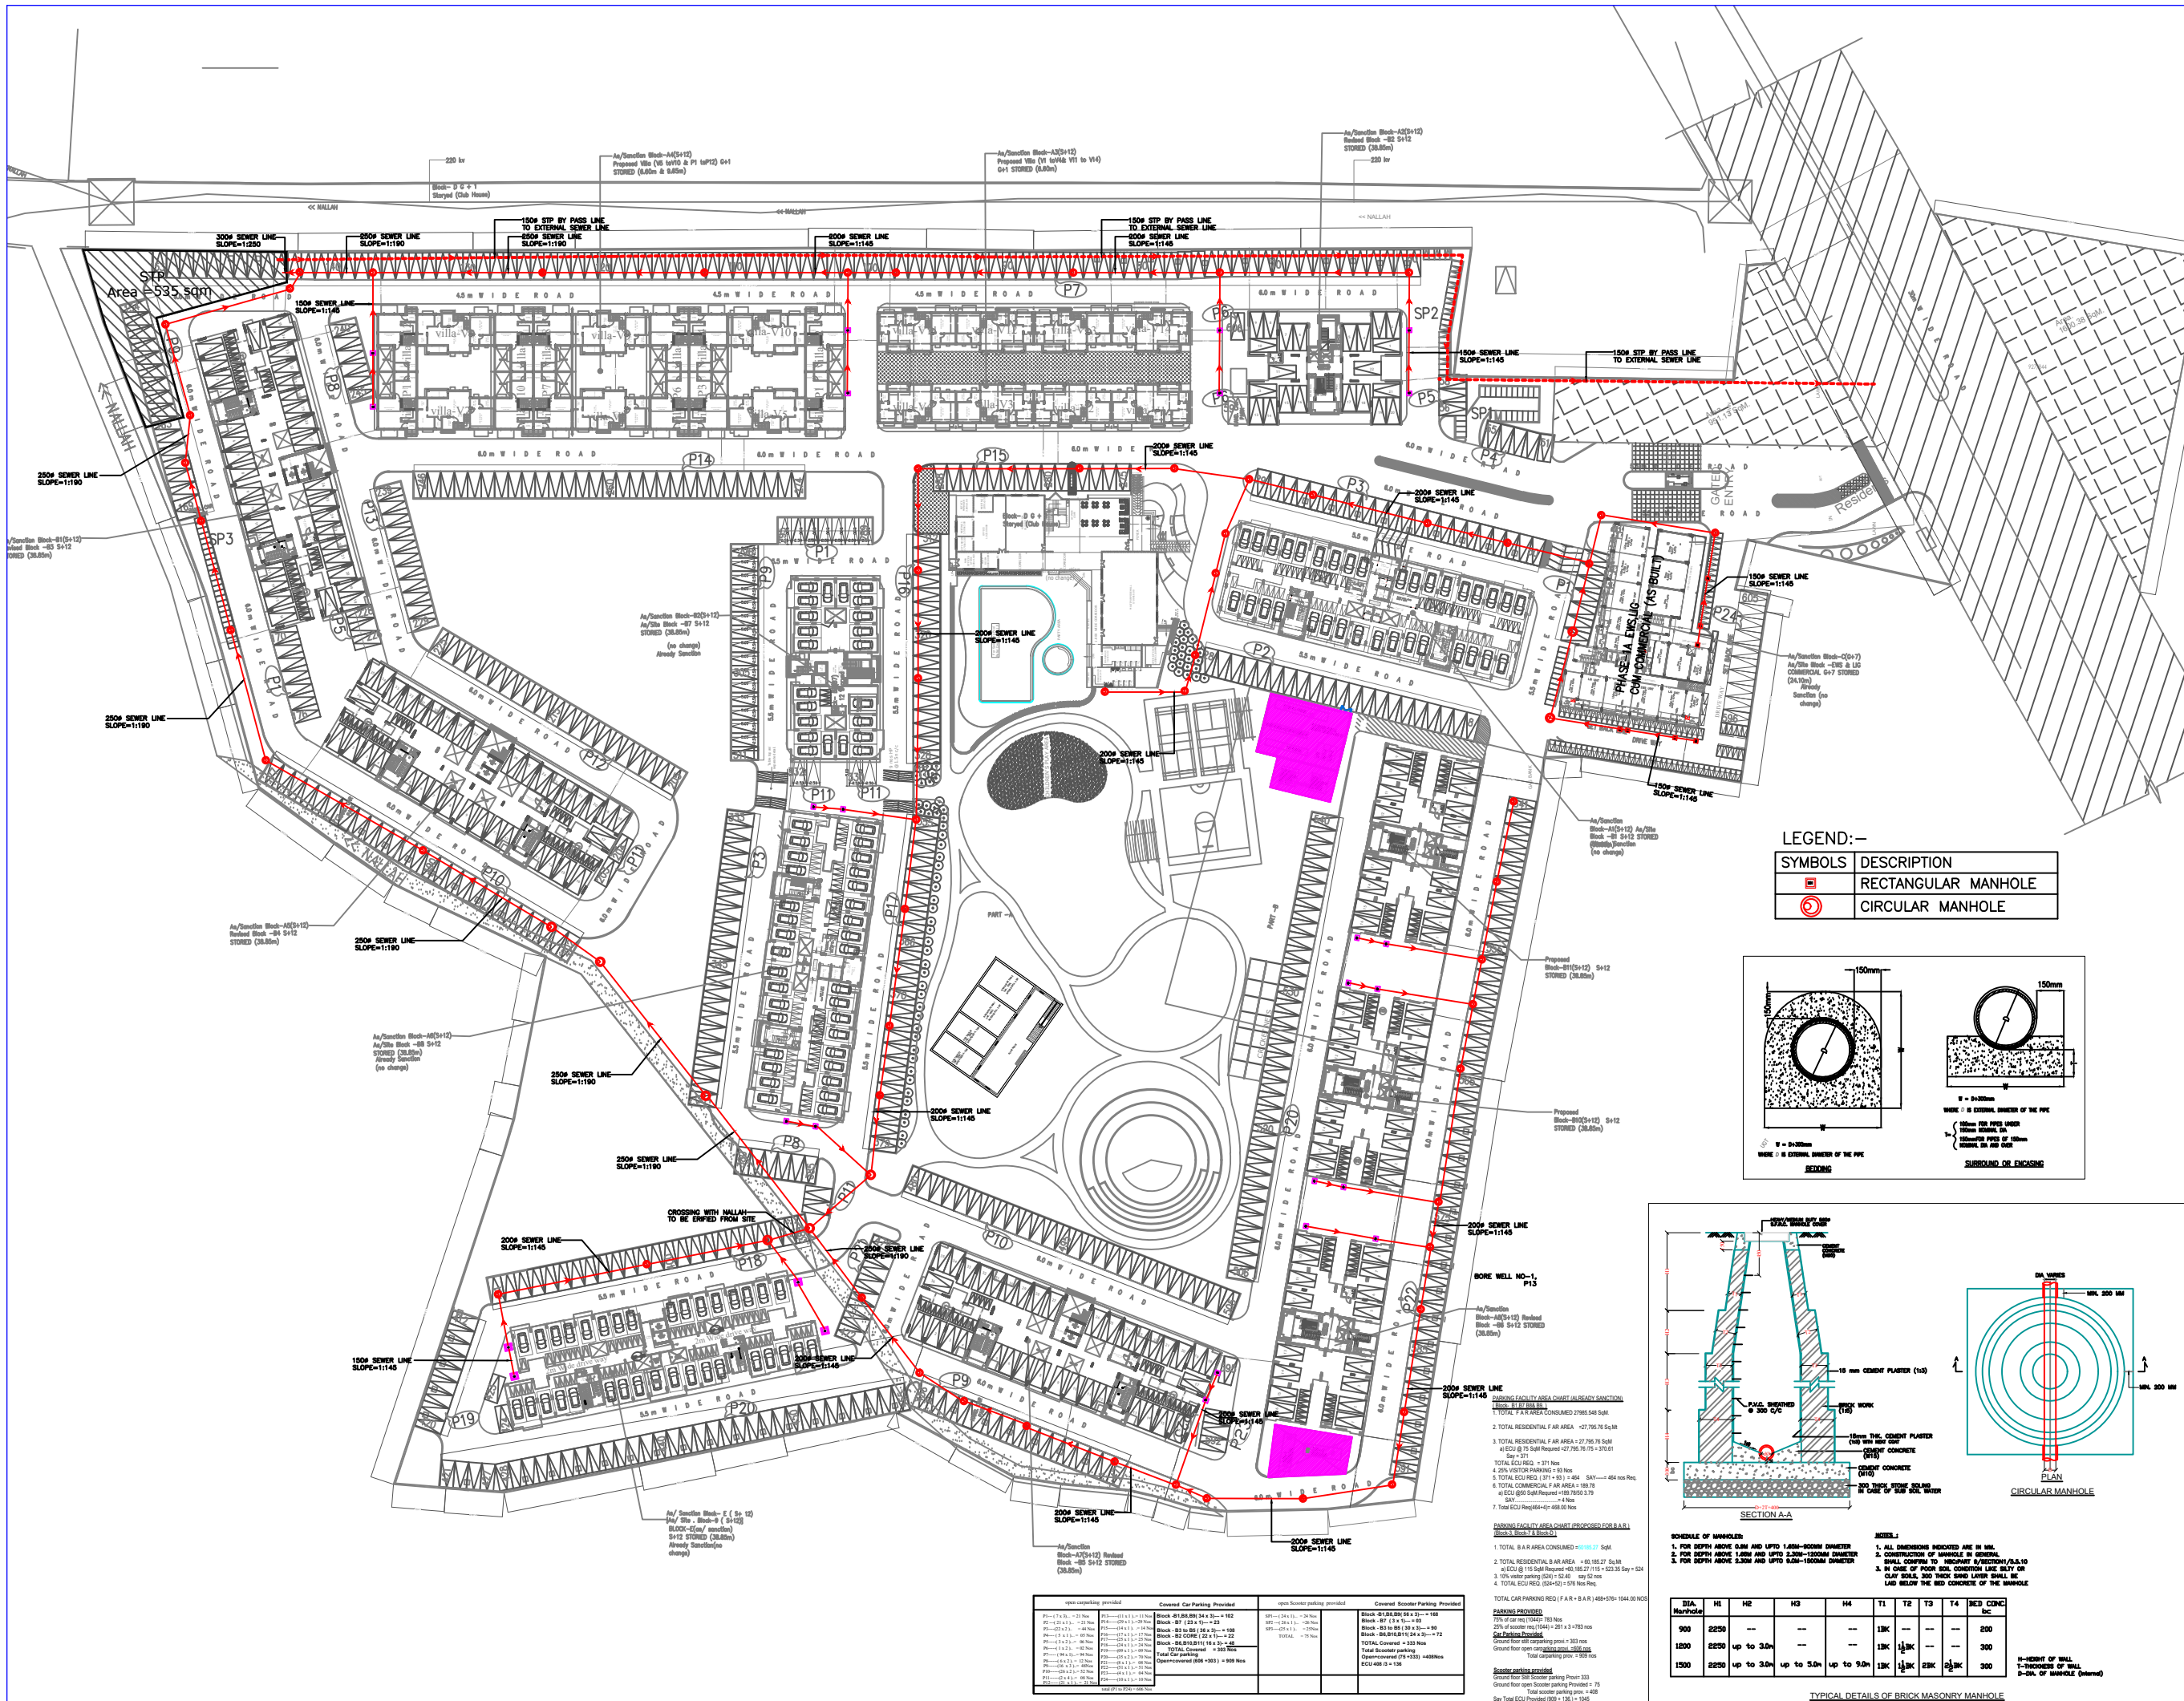

LEGEND:-

SYMBOLS	DESCRIPTION
	RECTANGULAR MANHOLE
	CIRCULAR MANHOLE

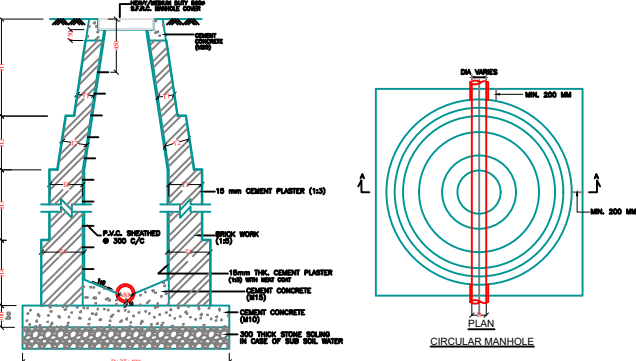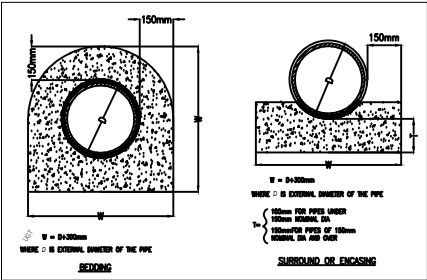

DATA	H1	H2	H3	H4	T1	T2	T3	T4	BD CONC
900	2250	--	--	--	18K	--	--	--	200
1200	2250	up to 3.0m	--	--	18K	1/2BK	--	--	300
1500	2250	up to 3.0m	up to 5.0m	up to 9.0m	18K	1/2BK	2BK	2/3BK	300

TYPICAL DETAILS OF BRICK MASONRY MANHOLE

Rev	Date	Issued to	Description	By	Chk
R1	25.11.21	ARCH.	ISSUE FOR EIA SUBMISSION	ANK	DVA
R0	16.09.15	ARCH.	ISSUE FOR EIA SUBMISSION	ANS	SHS

The concepts and information contained in this document are the copyright of Black & White Engineering Services Pvt. Ltd. Use or copying of the document in whole or in part without the written permission of Black & White Engineering Services Pvt. Ltd. constitutes an infringement of copyright. Do not scale drawings. If in doubt, ask!

ARCHITECTS :

b.sengupta architect
A305,RANGOLASHIANAVILLAGEBHIWADI.
PH. 09887488263

MEP CONSULTANT :



STRUCTURAL CONSULTANT :

Developer:-

ASHIANA HOUSING LTD
Unit no.4 & 5,Plot No.D-2,3rd Floor,
Southern park, saket District Centre,
Saket New Delhi - 110017
Phone no. 011- 42 65 42 65

Project Name

ASHIANA TARANG AT BHIWADI

Title
SITE PLAN
SEWERAGE LAYOUT

Discipline	Status
PLUMBING SERVICE	EIA SUBMISSION
Designed By ANS	Checked By SHS
Project No. 15280	Date 15.09.2015
Drawing No. 15280-P-A0-0402	Scale 1:400
	Revision R1