


LEGENDS	
TYPE OF FIXTURE	DESCRIPTION
PTZ	IP PTZ CAMERA
	IP FIXED DOME CAMERA

PARKING CALCULATION		
S.NO.	FLAT TYPE	PROVIDED PARKING
01.	5 BHK	3 CARS
02.	4 BHK	2 CARS
03.	3 BHK	2 CARS

PARKING PROVIDED	
• OPEN PARKING	=70 (1 to 64,73,74,109 to 111,124)
• COVERED PARKING	=54 (65 to 72,75 to 108, 112 to 123)
TOTAL PARKING = 124	

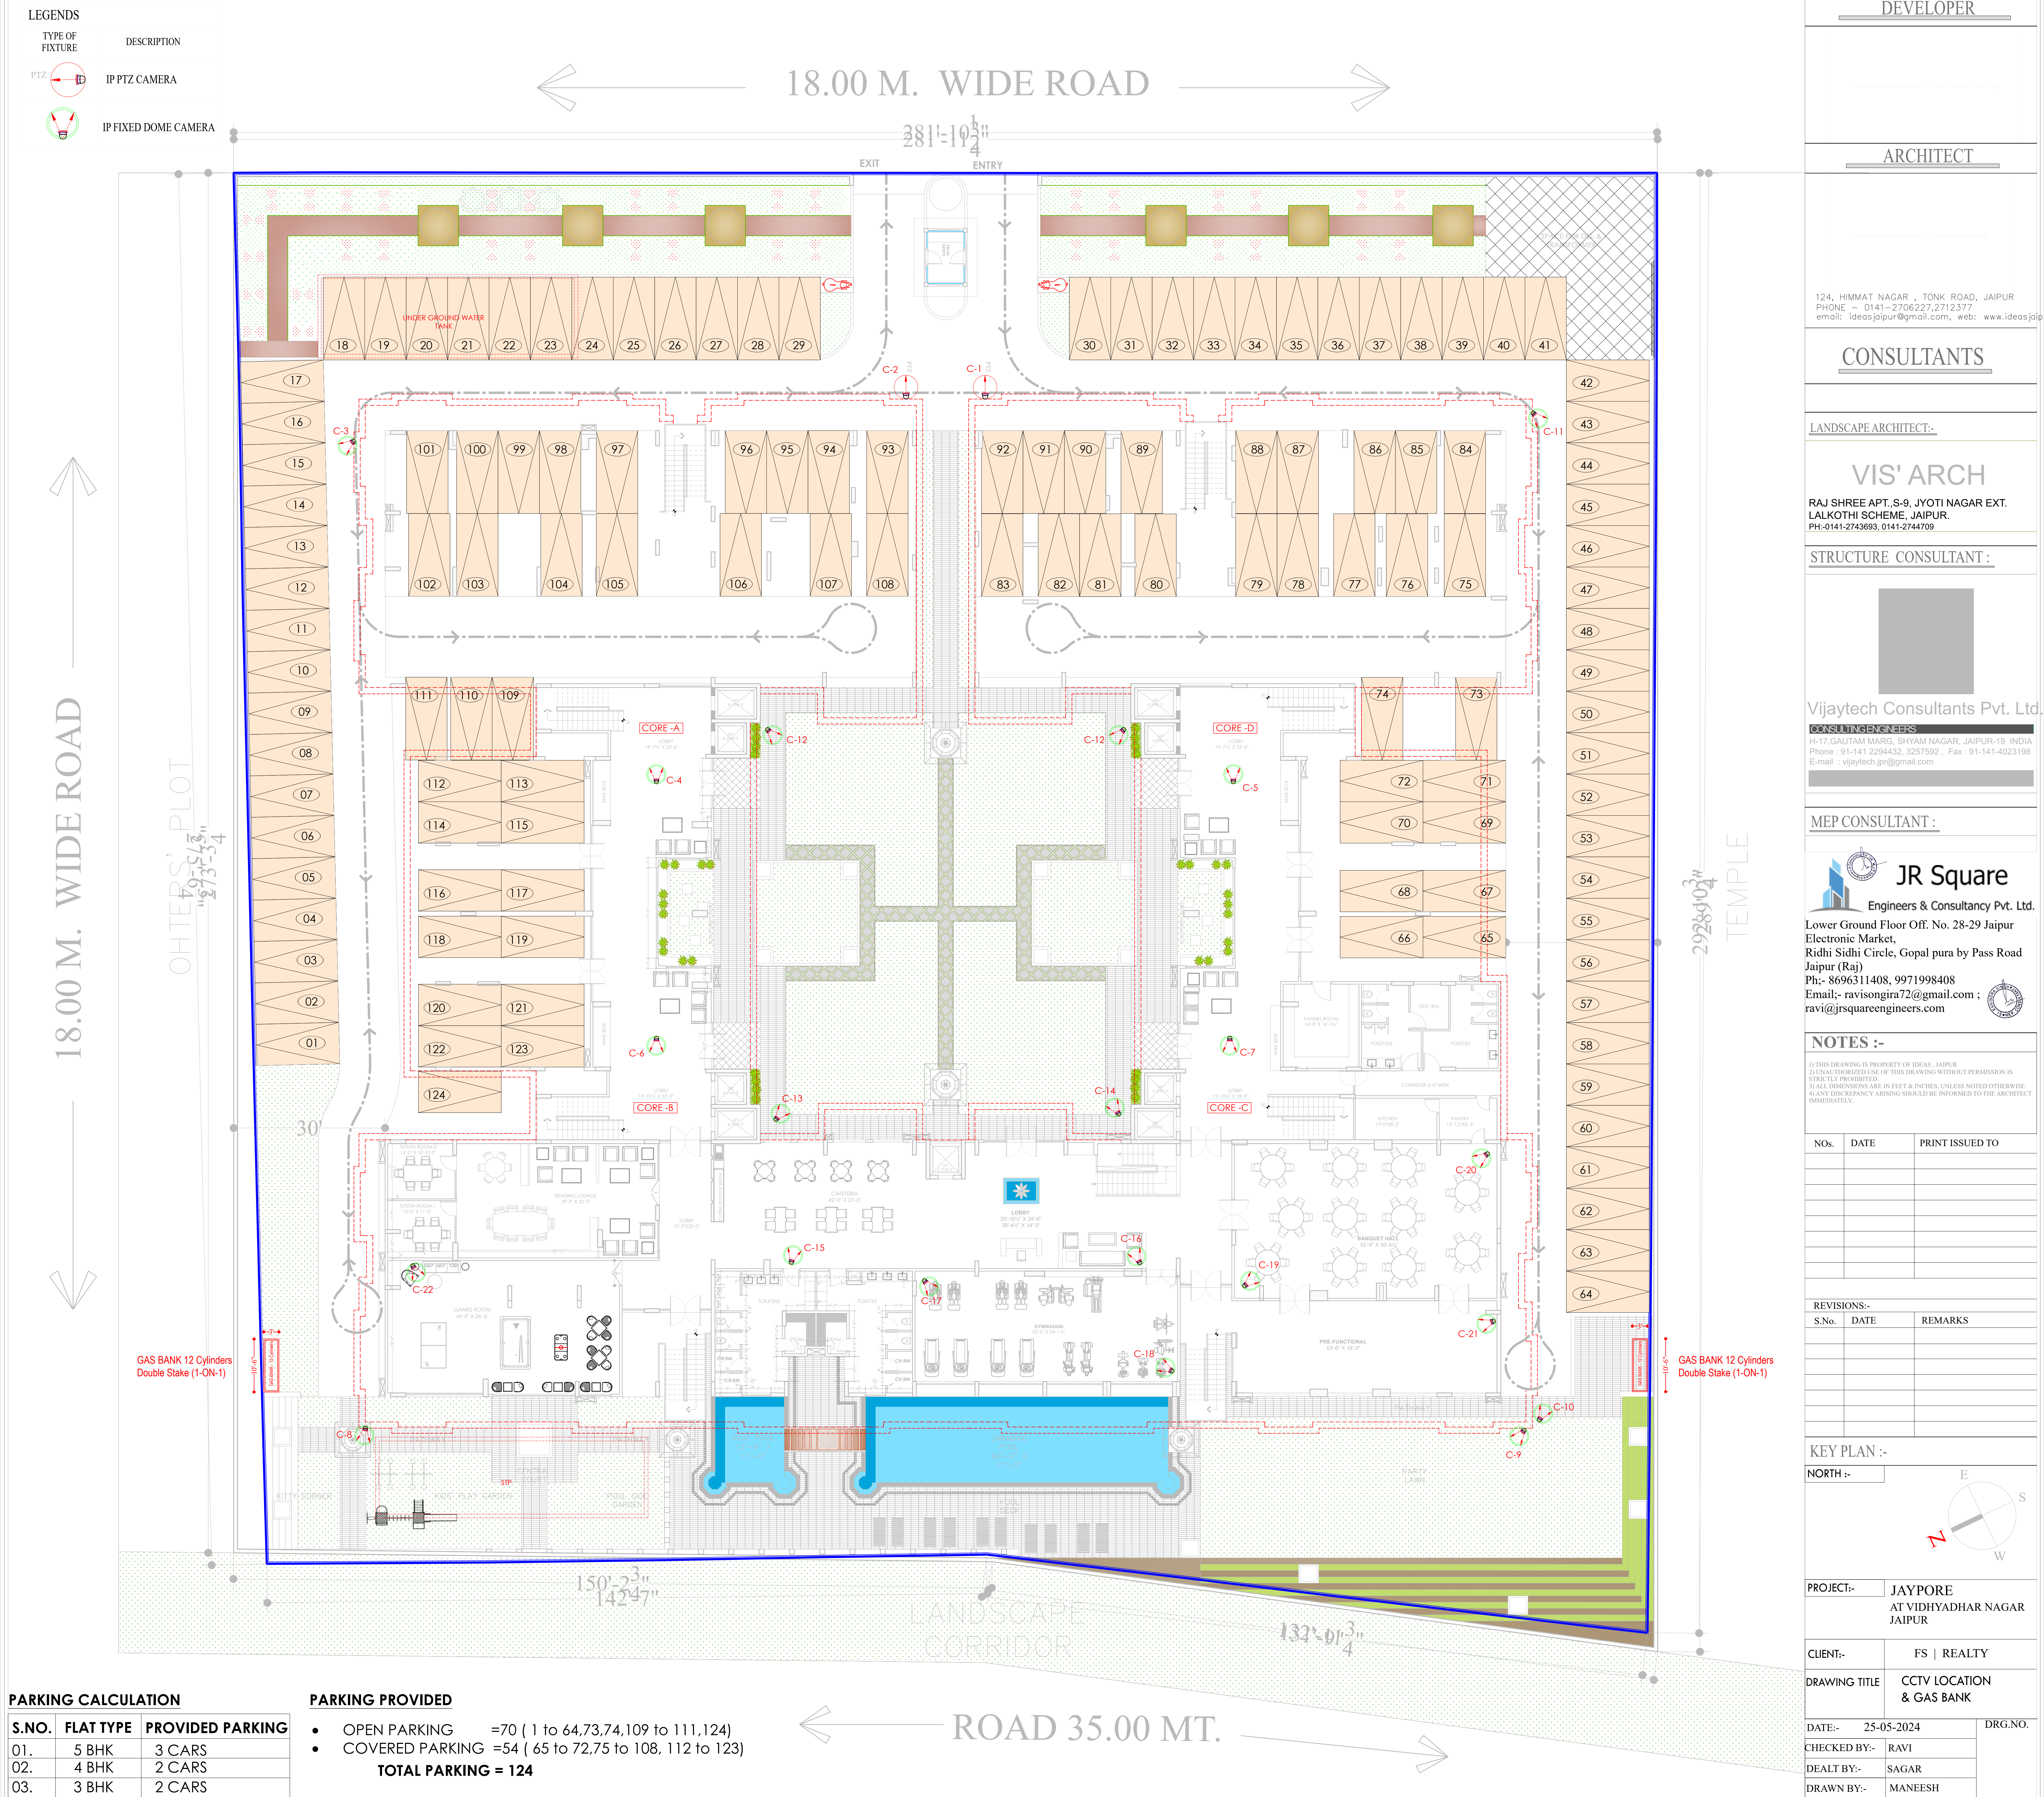

DEVELOPER

ARCHITECT

CONSULTANTS

LANDSCAPE ARCHITECT:-

VIS' ARCH

STRUCTURE CONSULTANT :

MEP CONSULTANT :

JR Square

NOTES :-

KEY PLAN :-

PROJECT:-

CLIENT:-

DRAWING TITLE

DATE:-

CHECKED BY:-

DEALT BY:-

DRAWN BY:-

124, HIMMAT NAGAR , TONK ROAD, JAIPUR
PHONE - 0141-2706227,2712377
email: ideasjaipur@gmail.com, web: www.ideasjaipur.com

RAJ SHREE APT.-S-9, JYOTI NAGAR EXT.
LALKOTHI SCHEME, JAIPUR.
PH-0141-2743693, 0141-2744709

Vijaytech Consultants Pvt. Ltd.

CONSULTING ENGINEERS

Phone: 91-141 2294432, 3257592 ; Fax: 91-141-4023198
E-mail : vijaytech.jpr@gmail.com

Lower Ground Floor Off. No. 28-29 Jaipur
Electronic Market,
Ridhi Sidhi Circle, Gopal pura by Pass Road
Jaipur (Raj)
Ph:- 8696311408, 9971998408
Email:- ravisongira72@gmail.com ;
ravi@jrsquareengineers.com

1) THIS DRAWING IS PROPERTY OF IDEAS, JAIPUR.
2) UNAUTHORIZED USE OF THIS DRAWING WITHOUT PERMISSION IS
STRICTLY PROHIBITED.
3) ALL DIMENSIONS ARE IN FEET & INCHES, UNLESS NOTED OTHERWISE.
4) ANY DISCREPANCY ARISING SHOULD BE INFORMED TO THE ARCHITECT
IMMEDIATELY.

REVISIONS:-

KEY PLAN :-

PROJECT:-

CLIENT:-

DRAWING TITLE

DATE:-





CHECKED BY:-

DEALT BY:-

DRAWN BY:-

DRG.NO.

SINGLE POINT METERING:

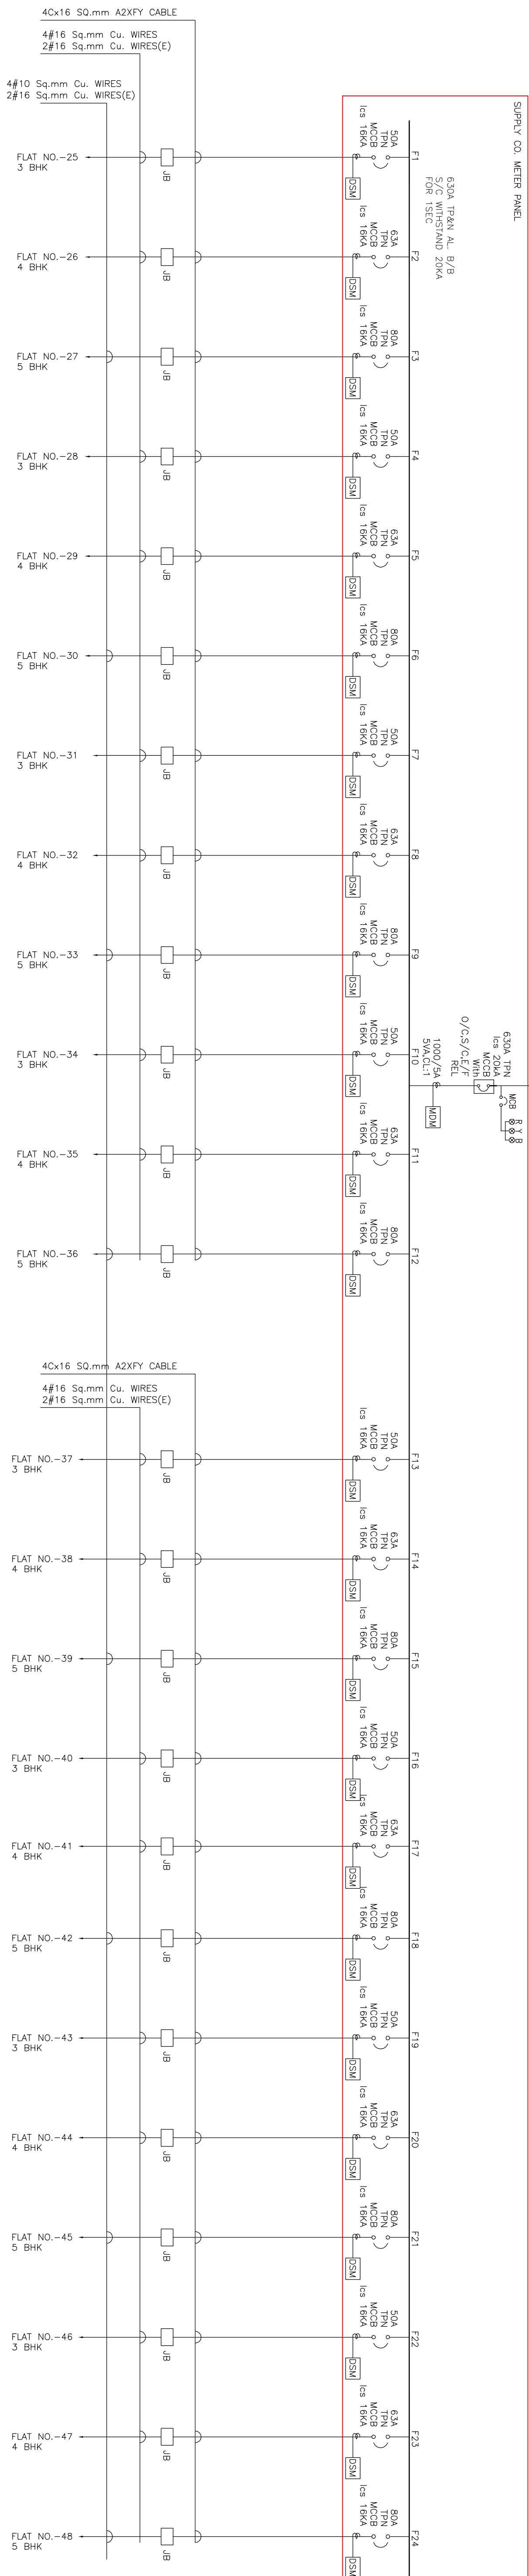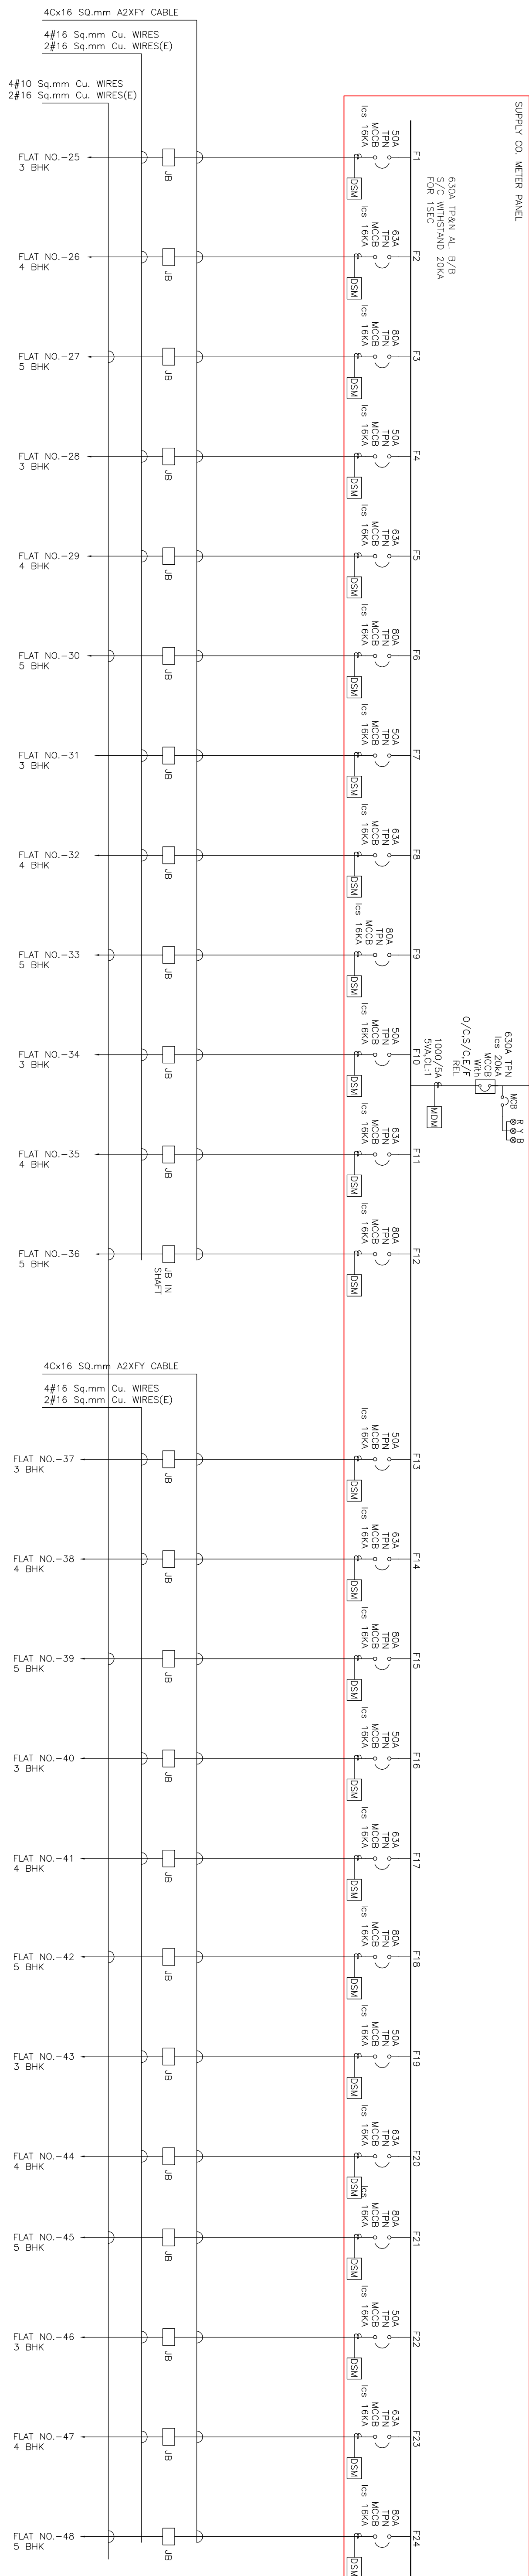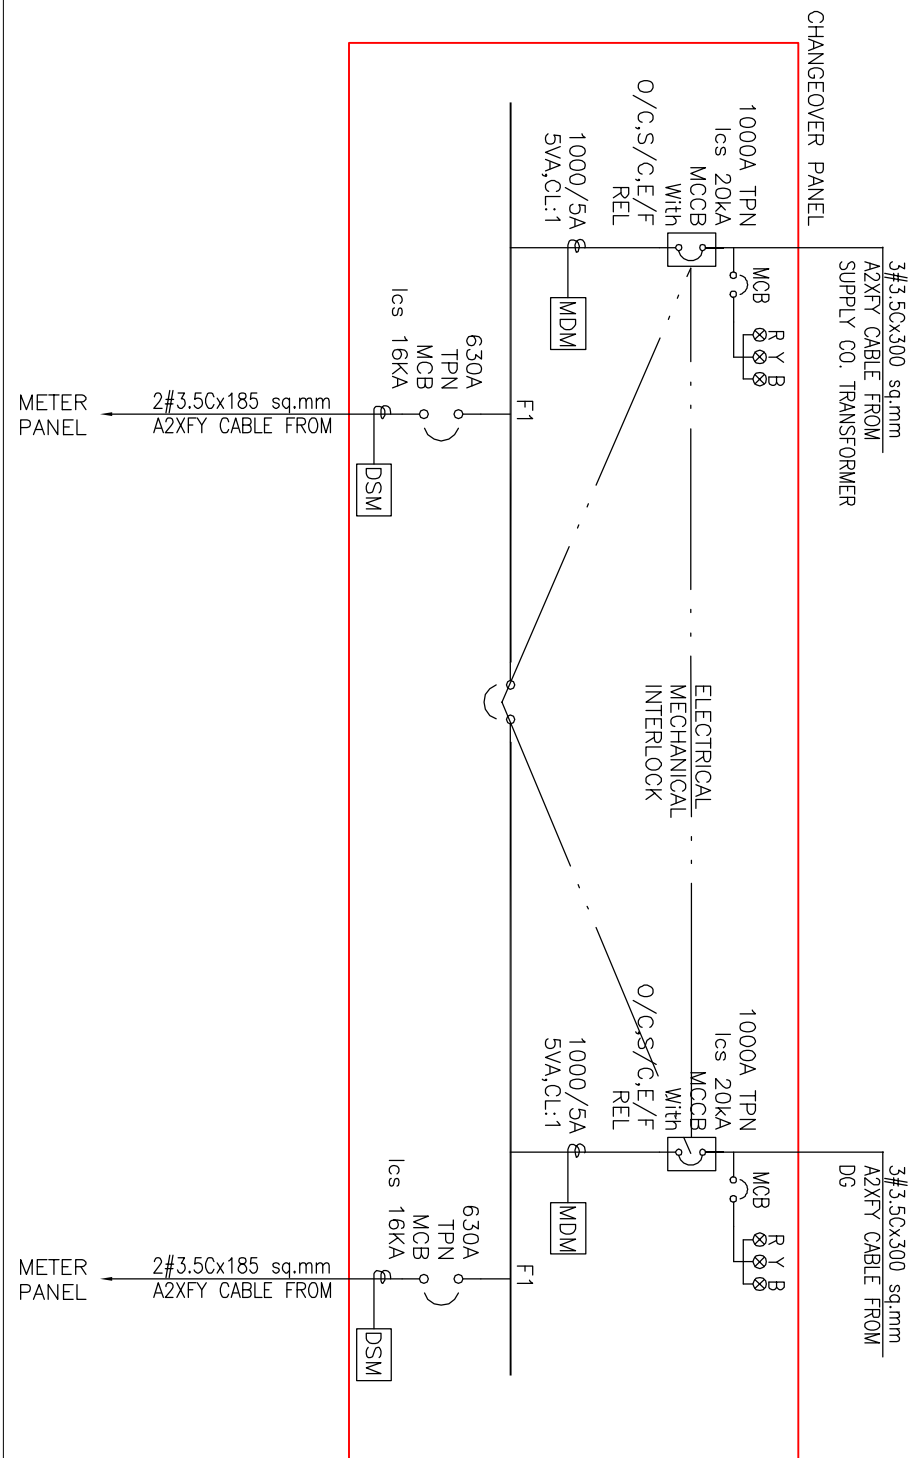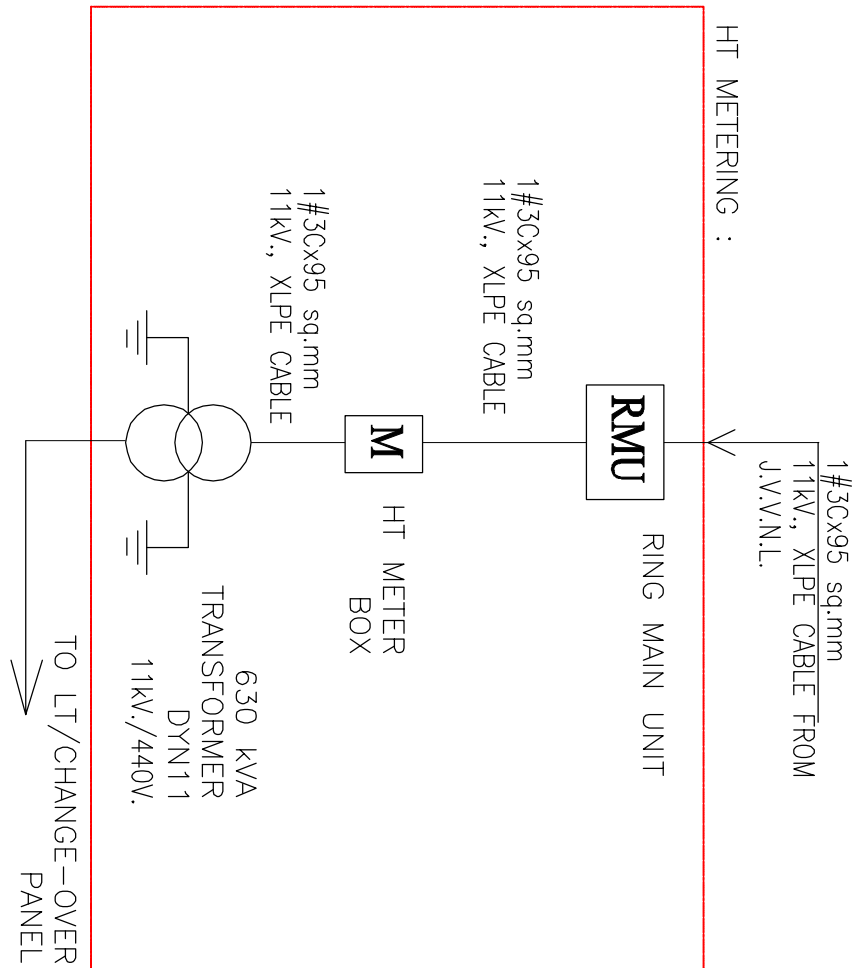

NOTES:

1. ALL DIMENSIONS GIVEN ON THIS DRAWING ARE IN MILLIMETERS. DO NOT SCALE THE DRAWINGS. ANY DISCREPANCIES FOUND SHOULD BE REPORTED TO THE RESPONSIBLE ARCHITECT OR ENGINEER IMMEDIATELY.
2. IT IS THE RESPONSIBILITY OF THE CONTRACTOR TO ASCERTAIN AND CONFIRM THAT ALL DIMENSIONS SHOWN IN THESE DRAWINGS SHALL COMPLY WITH THE SITE DIMENSIONS AND LEVELS PRIOR TO PREPARING DRAWINGS AND EXECUTING THE WORKS.

RELEASED FOR

☐ PRELIMINARY ☐ APPROVAL ☒ TENDER

PMC:

CLIENT:



MEP SERVICES CONSULTANT:

ELECTRO-MECH CONSULTANTS PVT. LTD.

106/151 Floor, Siddhant Vardaan, Dada Patil Road,
Thane(West) 400 602, Maharashtra, India.
Tel : +91-022 6510 3097/2538 / 9671
Email : emc.mumbai@gmail.com/www.electromech.co.in
BANDHOI (MUMBAI)
106/4-19, SHAKAR WARE, NEER - NEHU SHAKAR BHAVAN, JALPUR - 302001
(RAUSTHAN) PHONE : 0141-4026138 electromech@bandhoi@gmail.com


:3711

MAIN SCHEMATIC DISTRIBUTION


DRG NO.

EMC-01-EL-06A

J16	R0
-----	----

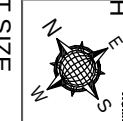NORTH

SHEET 217

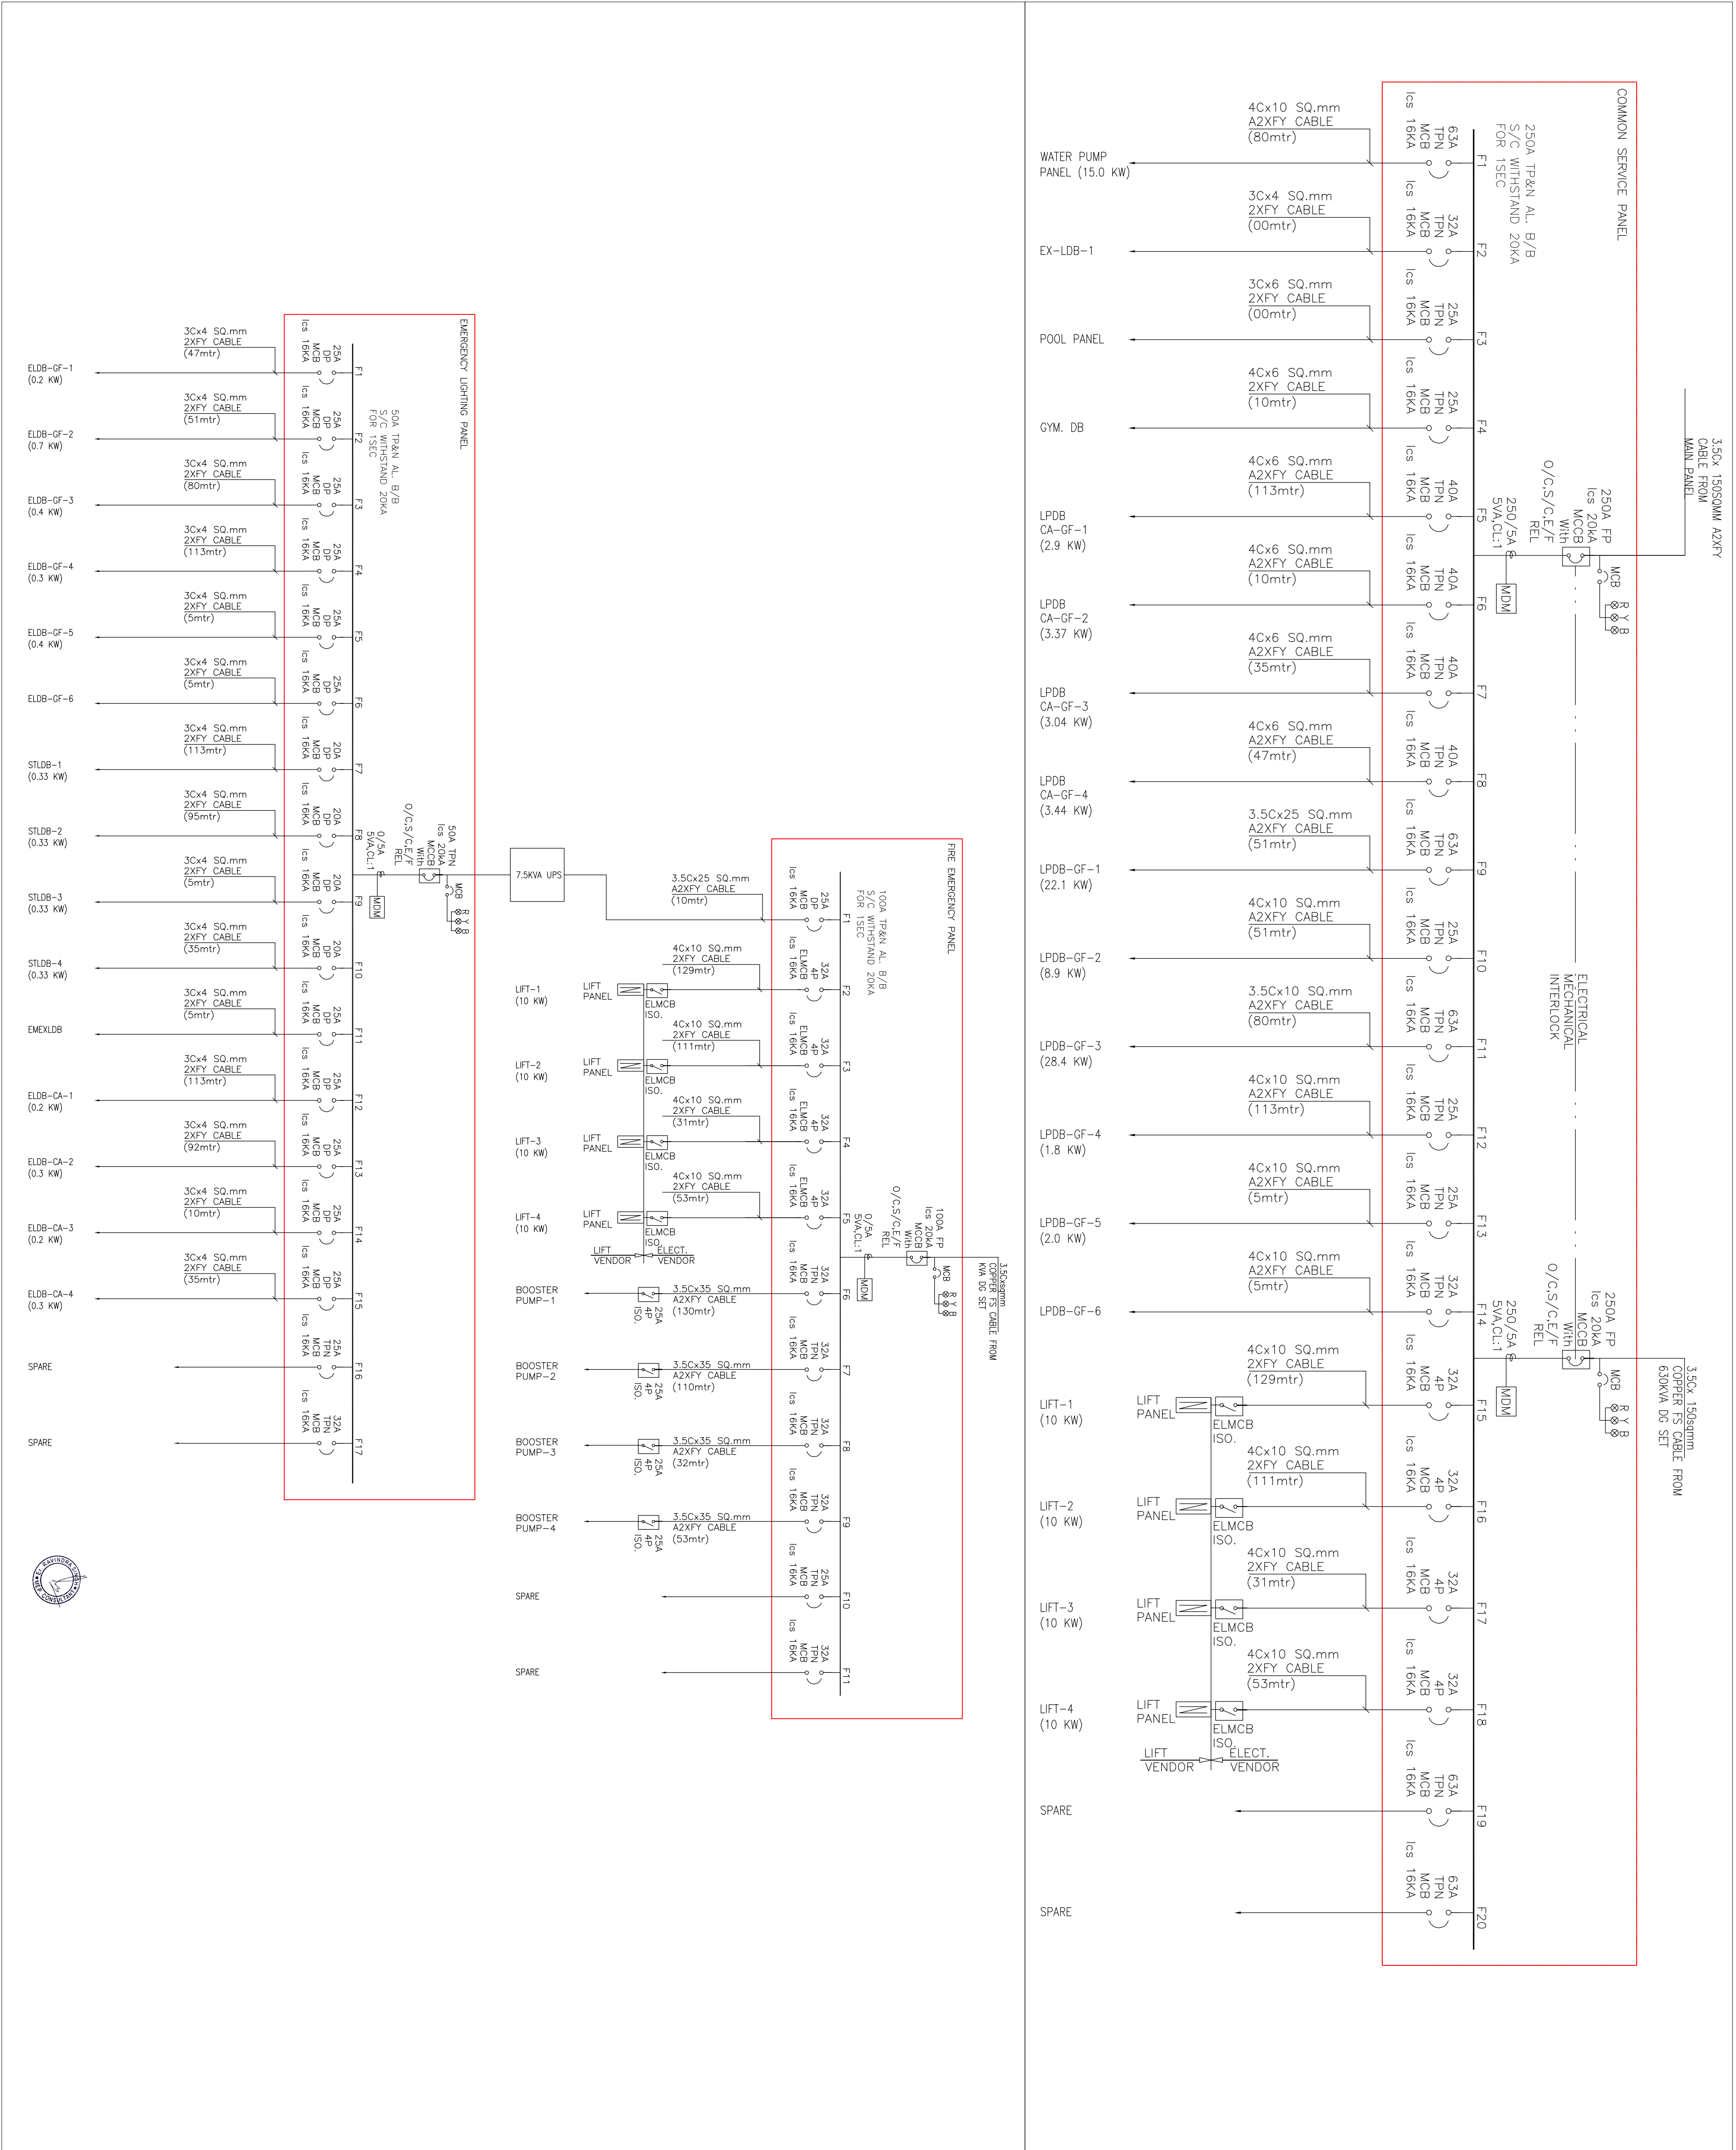

NOTES:

1. ALL DIMENSIONS GIVEN ON THIS DRAWING ARE IN MILLIMETERS. DO NOT SCALE THE DRAWINGS. ANY DISCREPANCIES FOUND SHOULD BE REPORTED TO THE RESPONSIBLE ARCHITECT OR ENGINEER IMMEDIATELY.

2. IT IS THE RESPONSIBILITY OF THE CONTRACTOR TO ASCERTAIN AND CONFIRM THAT ALL DIMENSIONS SHOWN IN THESE DRAWINGS SHALL COMPLY WITH THE SITE DIMENSIONS AND LEVELS PRIOR TO PREPARING DRAWINGS AND EXECUTING THE WORKS.

RELEASED FOR

PRELIMINARY

APPROVAL

TENDER

CONSTRUCTION

PROJECT:

JAYPORE THE PAUJALUJUNG
@ VIDHYADHAR NAGAR, JAIPUR

ARCHITECT:

MEP SERVICES CONSULTANT:

EMC

ELECTRO-MECH CONSULTANTS PVT. LTD.

106/1ST Floor, Siddharth Boudhan, Doda Patti wadi,
Thane(West) 400 602, Maharashtra, India.
Tel : +91-022 6510 3097/2538 /9671
Email : emc.mumbai@gmail.com/www.electromech.co.in
106/A-13, Sakur Nagar, Wadi, Chhatrapati Shivaji Maharaj Jaypr-202001
(Rajasthan) PHONE : 0141-4028138 electromech@gmail.com

REV	DATE	DESCRIPTION	DRN	CHKD	SJR

TITLE:

MAIN SCHEMATIC DISTRIBUTION

DWG NO.

EMC-01-EL-06

DATE

20.05.2017

SCALE

N.T.S

CHKD.

SHWETA

DRAWN

SR

JOB NO.

116

REVISION

R0


NORTH

SHEET SIZE

A1

APP.

RUPESH G.

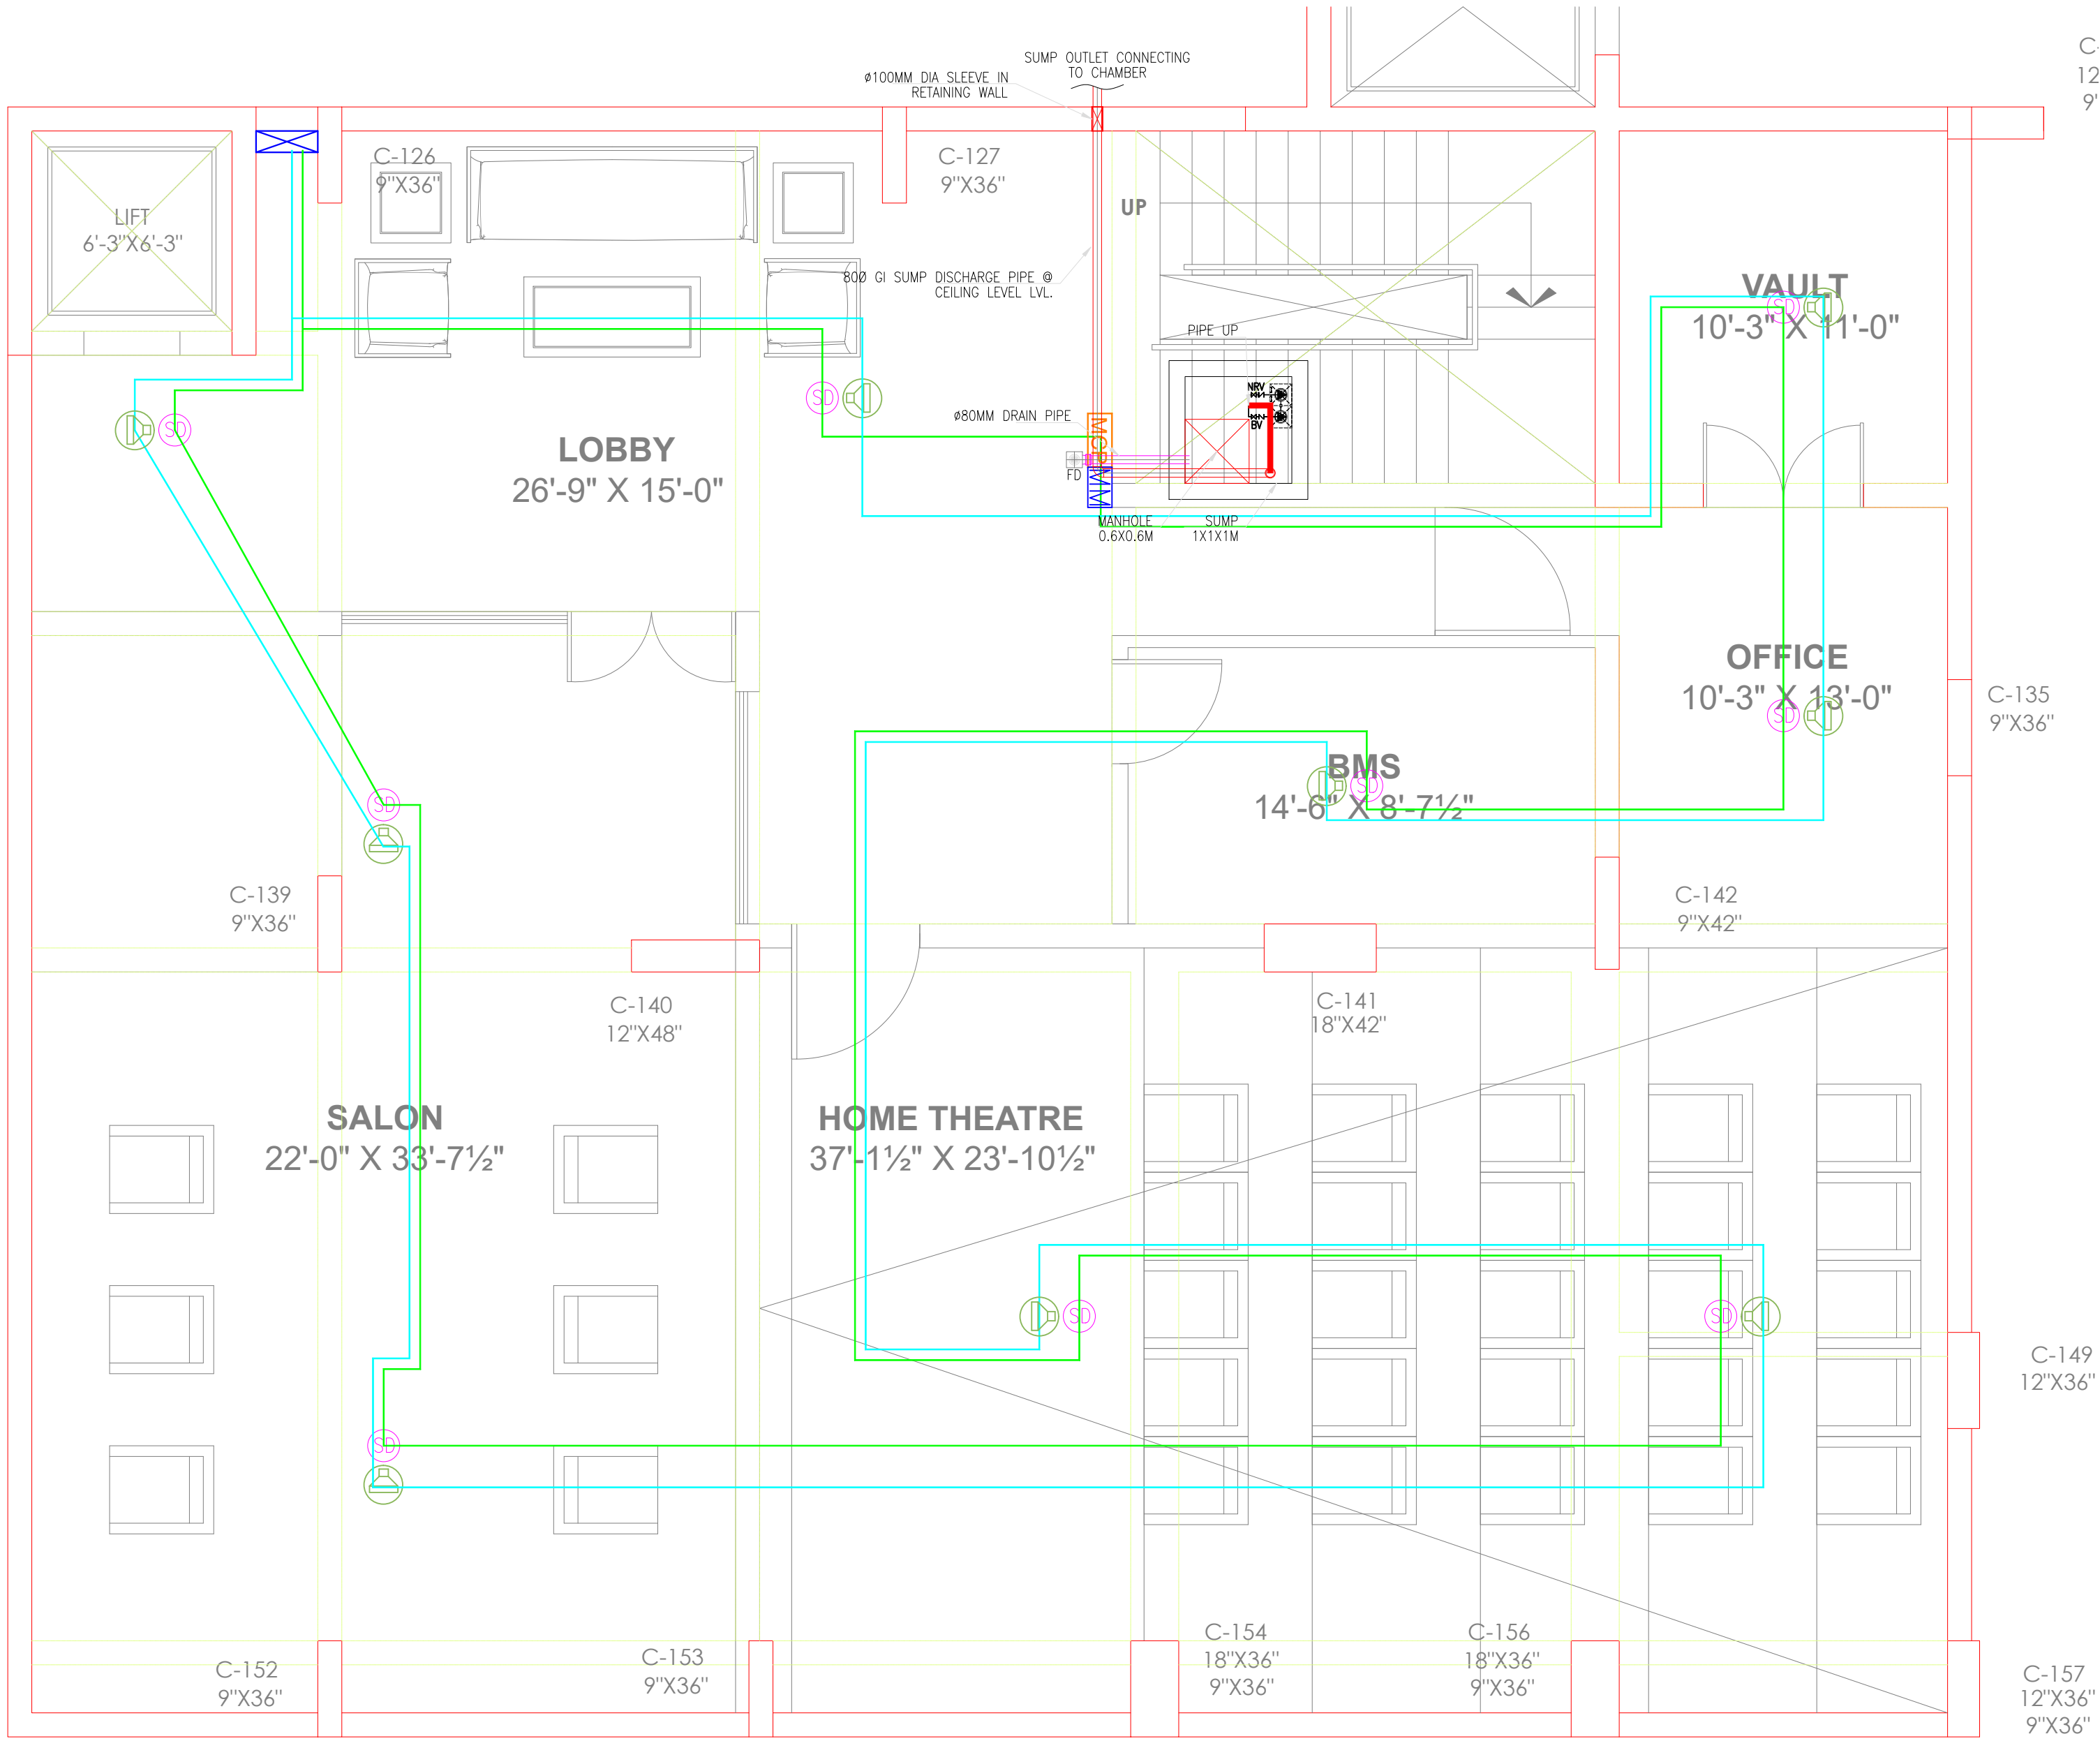

C 12 9'

C-135 9"X36"

C-149 12"X36"

C-157 12"X36" 9"X36"

NOTES:
1. ALL DIMENSIONS GIVEN ON THIS DRAWING ARE IN MILLIMETERS. DO NOT SCALE THE DRAWINGS, ANY DISCREPANCIES FOUND SHOULD BE REPORTED TO THE RESPONSIBLE ARCHITECT OR ENGINEER IMMEDIATELY.
2. IT IS THE RESPONSIBILITY OF THE CONTRACTOR TO ASCERTAIN AND CONFIRM THAT ALL DIMENSIONS SHOWN IN THESE DRAWINGS SHALL COMPLY WITH THE SITE DIMENSIONS AND LEVELS PRIOR TO PREPARING DRAWINGS AND EXECUTING THE WORKS.

RELEASED FOR
☒ PRELIMINARY ☐ APPROVAL ☐ TENDER ☐ CONSTRUCTION

PMC :
==

PROJECT :
JAYPORE THE PALATIAL LIVING
© VIDHYADHAR NAGAR, JAIPUR

CLIENT:

ARCHITECT:

MEP SERVICES CONSULTANT:

LQ-28 Floor Jaipur Electronic Market, Ridhi Sidhi Circle, Gopal pura by Pass Road , Jaipur (Raj)
Ph:- 8696311408, 9971998408
Email:- ravisongira72@gmail.com ; ravi@rsquareengineers.com

R0	07.07.2017	ISSUED FOR APPROVAL		R.P	SK
REV.	DATE	DESCRIPTION		DRN.	CHKD.

TITLE: FIRE ALARM LAYOUT FOR BASEMENT FLOOR				NORTH 	
DRG NO. JRS-EL-01				JOB NO.	REVISION R0
DRAWN SAGAR	DATE 21.06.2024	SCALE NTS	CHKD. MANISH	APP. SAGAR	



ELECTRICAL FIXTURE	
TYPE OF FIXTURE	DESCRIPTION
	28W SURFACE MOUNTED TUBE LIGHT (T5)(NORMAL)
	28W SURFACE MOUNTED TUBE LIGHT (T5)(EM'CY)
	18W CEILING MOUNTED LIGHT (CFL)(NORMAL)
	18W CEILING MOUNTED LIGHT (CFL)(EM'CY)
	E-2x36W CFL RECESS MOUNTED MIRROR OPTIC (NORMAL)
	E-2x36W CFL RECESS MOUNTED MIRROR OPTIC (EM'CY)
	E-1x28W SURFACE MOUNTED LUMINARIES (NORMAL)
	E-1x28W SURFACE MOUNTED LUMINARIES (EM'CY)
	250W CHANDELIER LIGHT
	11W MIRROR LIGHT
	40W BULKED LIGHT
	6A SWITCH SOCKET
	6/16A SWITCH SOCKET
	20A SWITCH SOCKET
	6A ONE WAY SWITCH
	600/900/1200B CEILING FAN POINT (60W)
	6A SWITCH & ELECTRONIC TYPE FAN REGULATOR
	ELECTRICAL JUNCTION BOX
	1X70W ADJUSTABLE WALL LIGHT AT 2800 MM FROM FFL
	BOLLARD LIGHT
	RJ 11-TELEPHONE SOCKET WITH SHUTTER
	INTERCOM PHONE
	RJ 45 SOCKET
	240V STEP LIGHT
	ELECTRICAL DISTRIBUTION BOARD
	LOW VOLTAGE JUNCTION BOX (LVJB)
	ELECTRICAL SWITCHING (NORMAL)
	ELECTRICAL EMERGENCY SWITCHING (EM'CY)
	EMERGENCY ELECTRICAL CONDUIT
	ELECTRICAL CONDUIT

FIRE ALARM & PUBLIC ADDRESS LEGEND	
SYMBOL	DESCRIPTION
	SMOKE DETECTOR (BELOW FALSE CEILING)
	MULTI SENSOR DETECTOR
	SOUNDER
	BREAK GLASS
	MANUAL CALL POINT
	MONITOR MODULE
	FIRE ALARM CONTROL PANEL
	CEILING MOUNTED SPEAKER
	PA CONTROL PANEL

NOTES:
1. ALL DIMENSIONS GIVEN ON THIS DRAWING ARE IN MILLIMETERS. DO NOT SCALE THE DRAWINGS, ANY DISCREPANCIES FOUND SHOULD BE REPORTED TO THE RESPONSIBLE ARCHITECT OR ENGINEER IMMEDIATELY.
2. IT IS THE RESPONSIBILITY OF THE CONTRACTOR TO ASCERTAIN AND CONFIRM THAT ALL DIMENSIONS SHOWN IN THESE DRAWINGS SHALL COMPLY WITH THE SITE DIMENSIONS AND LEVELS PRIOR TO PREPARING DRAWINGS AND EXECUTING THE WORKS.

RELEASED FOR
☒ PRELIMINARY ☐ APPROVAL ☐ TENDER ☐ CONSTRUCTION

PMC :

PROJECT :
JAYPORE THE PALATIAL LIVING
© VIDHYADHAR NAGAR, JAIPUR

CLIENT :

ARCHITECT :

MEP SERVICES CONSULTANT:

LG-28 Floor Jaipur Electronic Market, Rishi
Siddhi Circle, Gopal pura by Pass Road , Jaipur
(Rd.)
Ph: 8696311408, 9971998408
Email: ravisingh72@gmail.com ;
rav@rsquareengineers.com

R0	17.05.2017	ISSUED FOR APPROVAL	RM	SK
REV.	DATE	DESCRIPTION	DRN.	CHKD.

TITLE: DG SET, TR & EARTHING LAYOUT		DRG NO. JRS-01-EL-03		JOB NO.	REVISION R0
DRAWN MANISHI	DATE 21.6.2024	SCALE 1:150	CHKD. MANISH	APP. SAGAR	

