


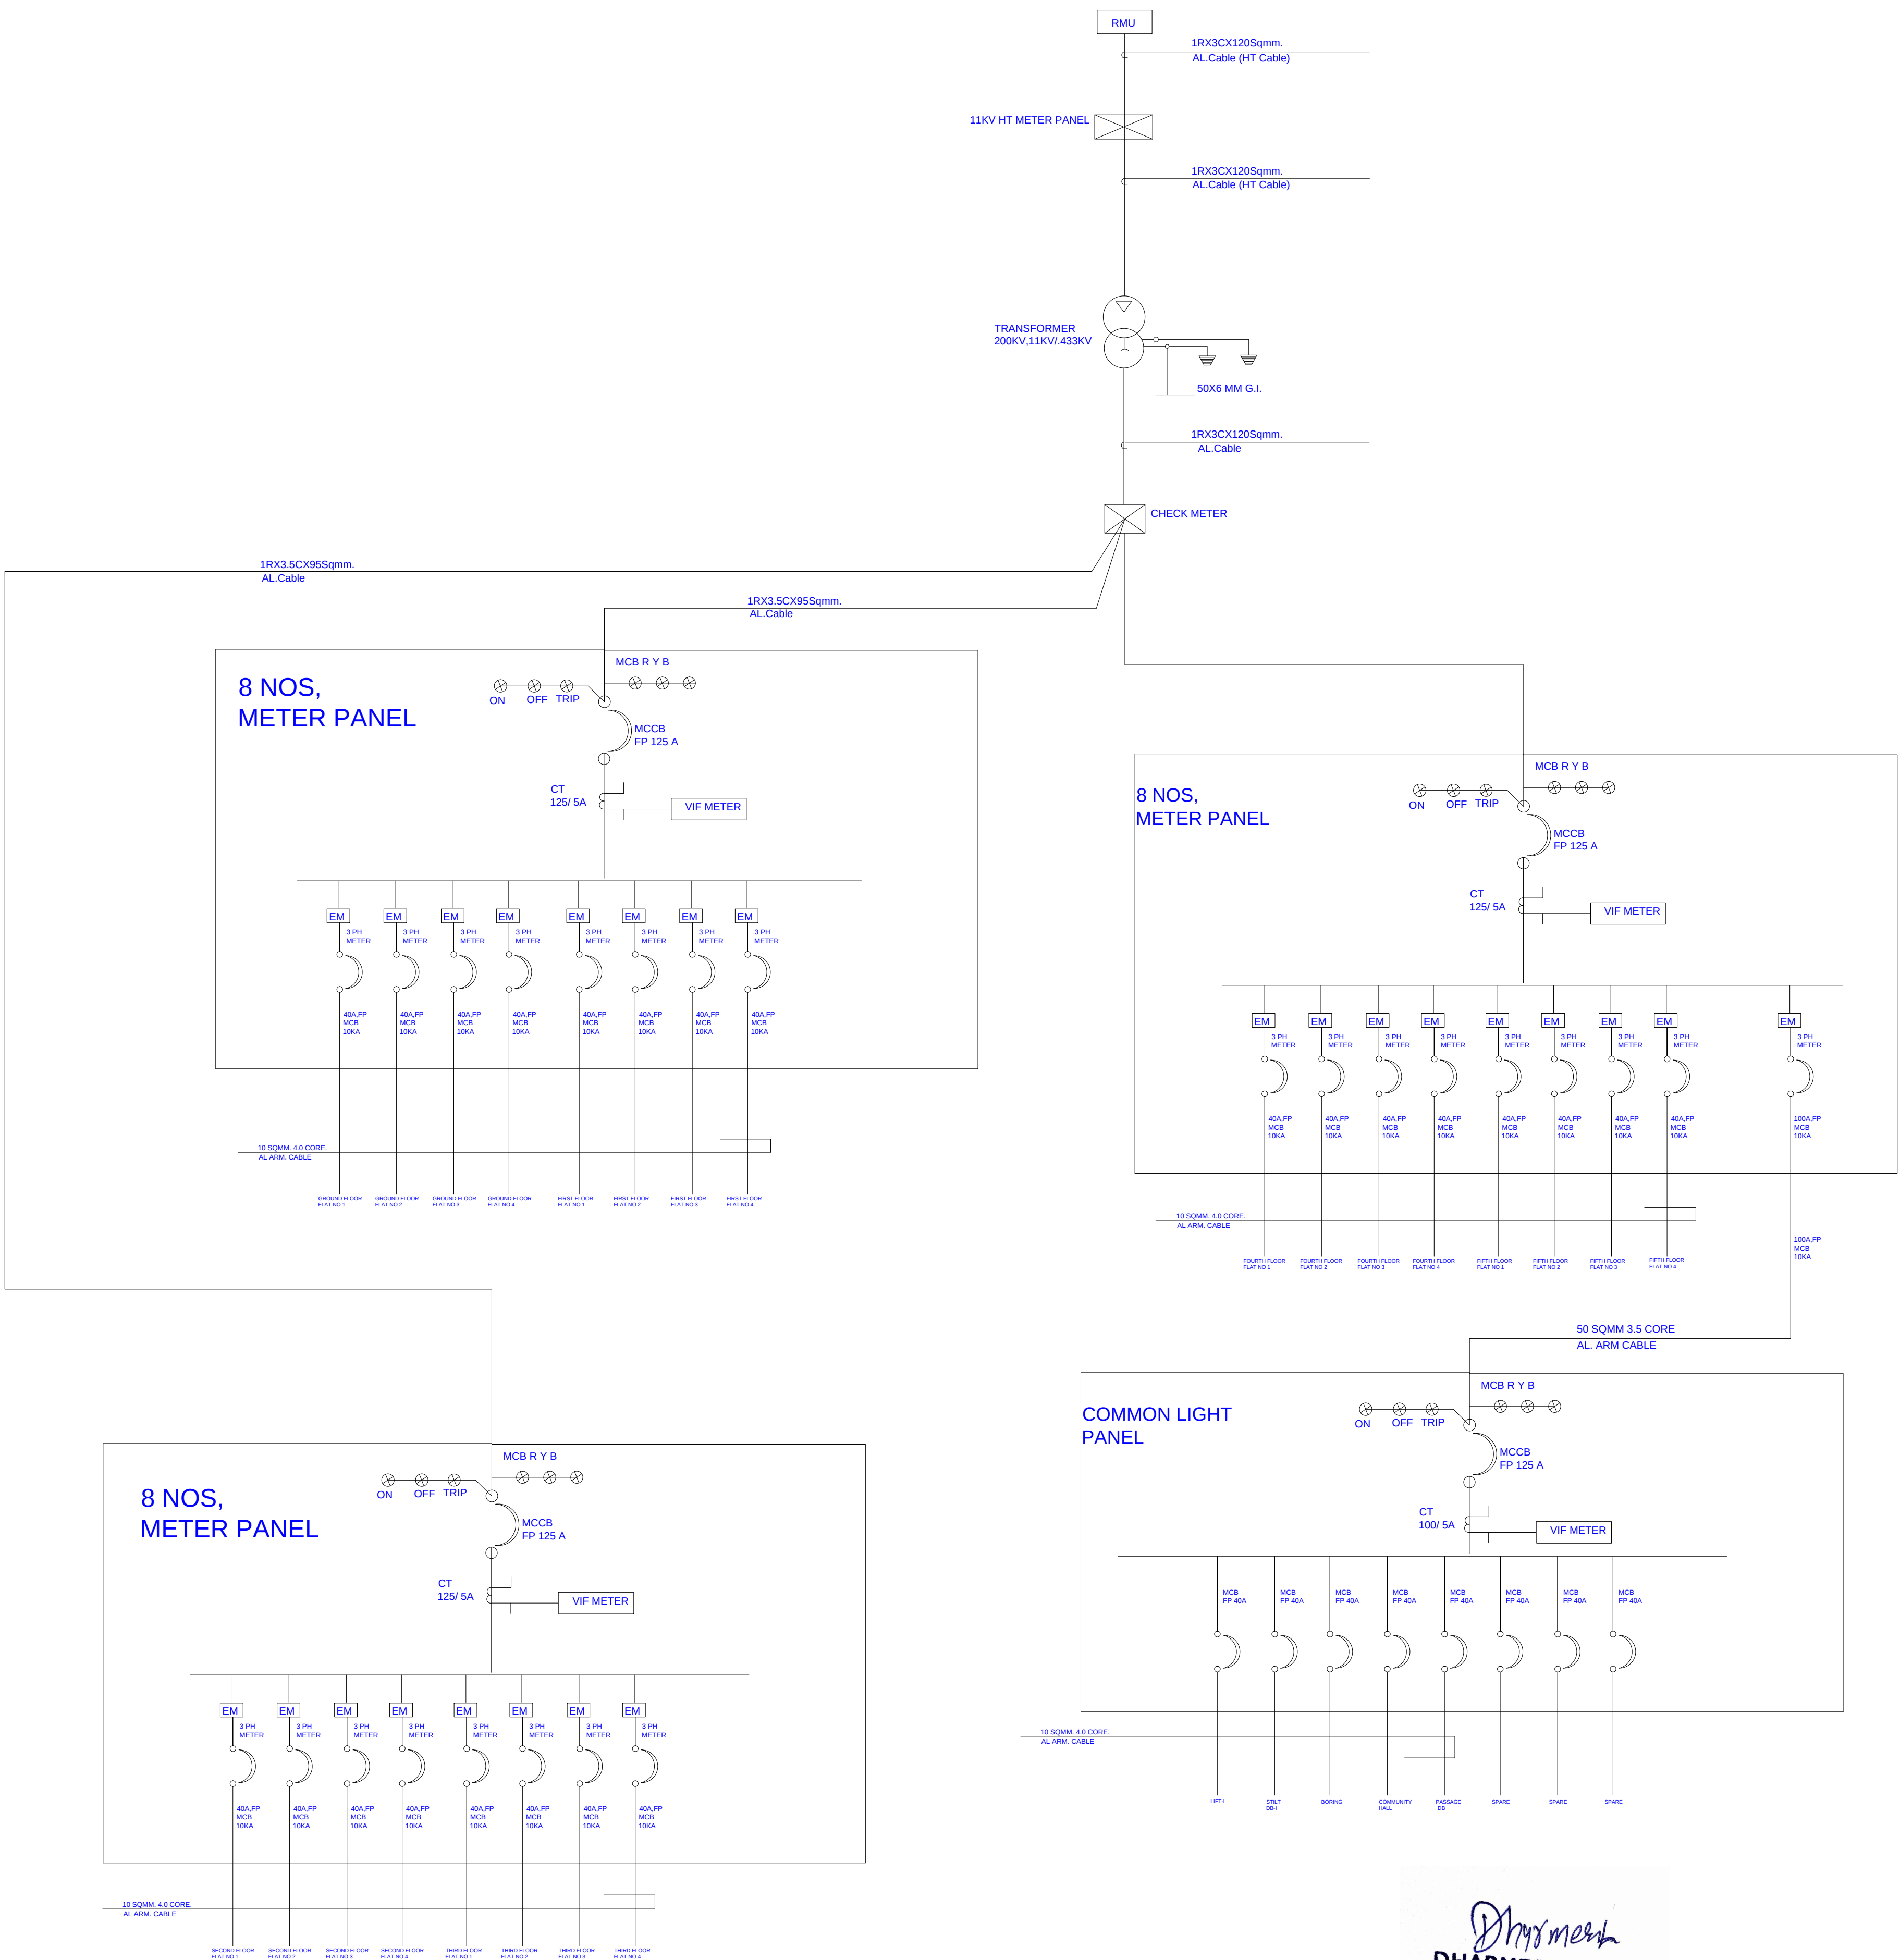

Dharmesh
DHARMESH SHARMA
B. TECH. (CIVIL)

WARNING

1. This drawing is the sole copyright of Architects **VISTAAR** and should be used for the purpose expressly issued.

GENERAL NOTES

1. All dimensions are in feets and inches.
2. Do not scale this drawing follow written dimensions only.
3. This drawing should be read in conjunction with other architectural and structural drawings.
4. Any discrepancy in the drawing should be immediately brought to the notice of architect.

PROJECT TITLE

Shree Krishna Residency
Plot No. 82,83,84 E.P, 93 E.P-A-W.P,99 W.P,99
E.P-A , Village - Manpur Devri Urf Golyawas ,
Scheme - Vrindavan Vihar , Jaipur - 302020 (Rajasthan)

DRAWING TITLE


ELECTRICAL SLD

ARCHITECTS :

VISTAAR ARCHITECTS & PLANNERS
Architects :: Interior Designers
B-2/12, Chitrkoot scheme,
main Gandhi Path,Opp mall of jaipur,Jaipur-21
Email-Vistaararchitects.web@gmail.com
PH.- 0141-4116461,09001010366

PATH :-

DRN.	DATE	REV.	NORTH
MANOJ KUMAWAT	05-08-2022		
SCALE	JOB NO.		
N.T.S			

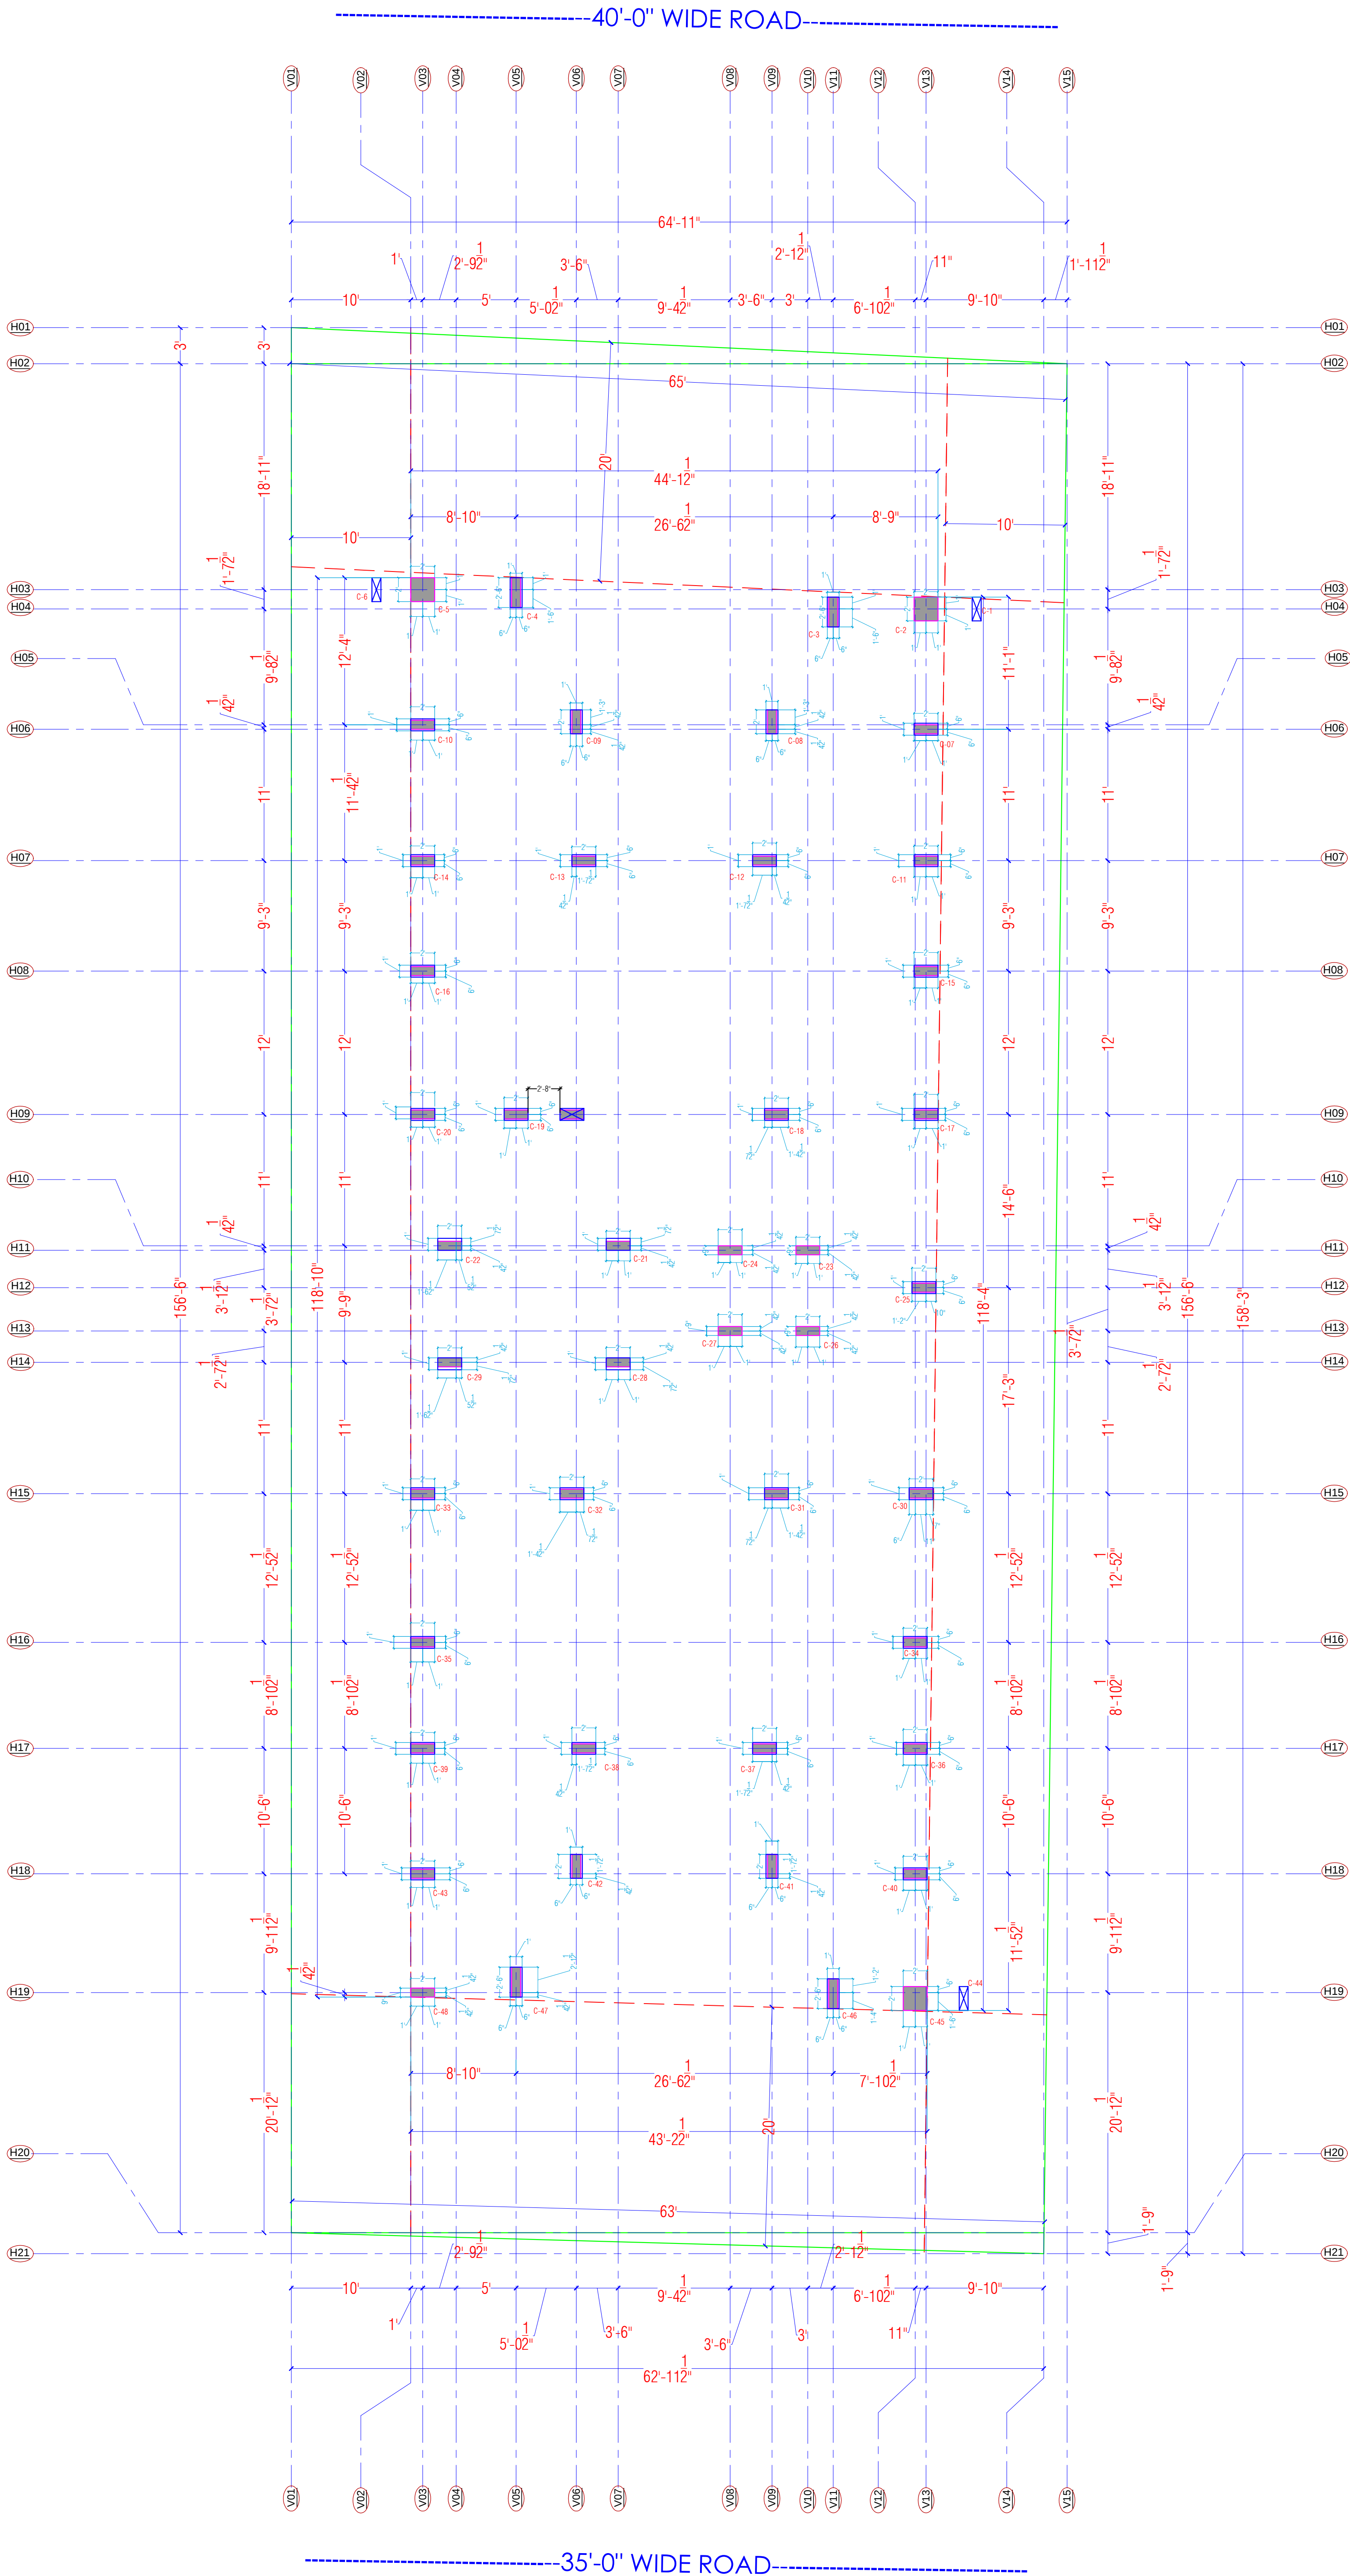

Vijay Sharma
VIJAY SHARMA
CA/2011/52069
CTP RAJ/Architect/2021/37

WARNING

1. This drawing is the sole copyright of Architects **VISTAAR** and should be used for the purpose expressly issued.

GENERAL NOTES

1. All dimensions are in feet and inches.
2. Do not scale this drawing follow written dimensions only.
3. This drawing should be read in conjunction with other architectural and structural drawings.
4. Any discrepancy in the drawing should be immediately brought to the notice of architect.

PROJECT TITLE

Shree Krishna Residency
Plot No. 82,83,84 E.P, 93 E.P-A-W.P,99 W.P,99
E.P-A , Village - Manpur Devri Urf Golyawas ,
Scheme - Vrindavan Vihar , Jaipur - 302020
(Rajasthan)

DRAWING TITLE


CENTER LINE PLAN

ARCHITECTS :

VISTAAR ARCHITECTS & PLANNERS

Architects :: Interior Designers
B-2/12, Chitrkoot scheme,
main Gandhi Path,Opp mall of jaipur,Jaipur
PH. - 0141-4116461,09001010366

PATH :-			
DRN.	DATE	REV.	NORTH
MANOJ KUMAWAT	26-05-2022		
SCALE	JOB NO.		
N.T.S			

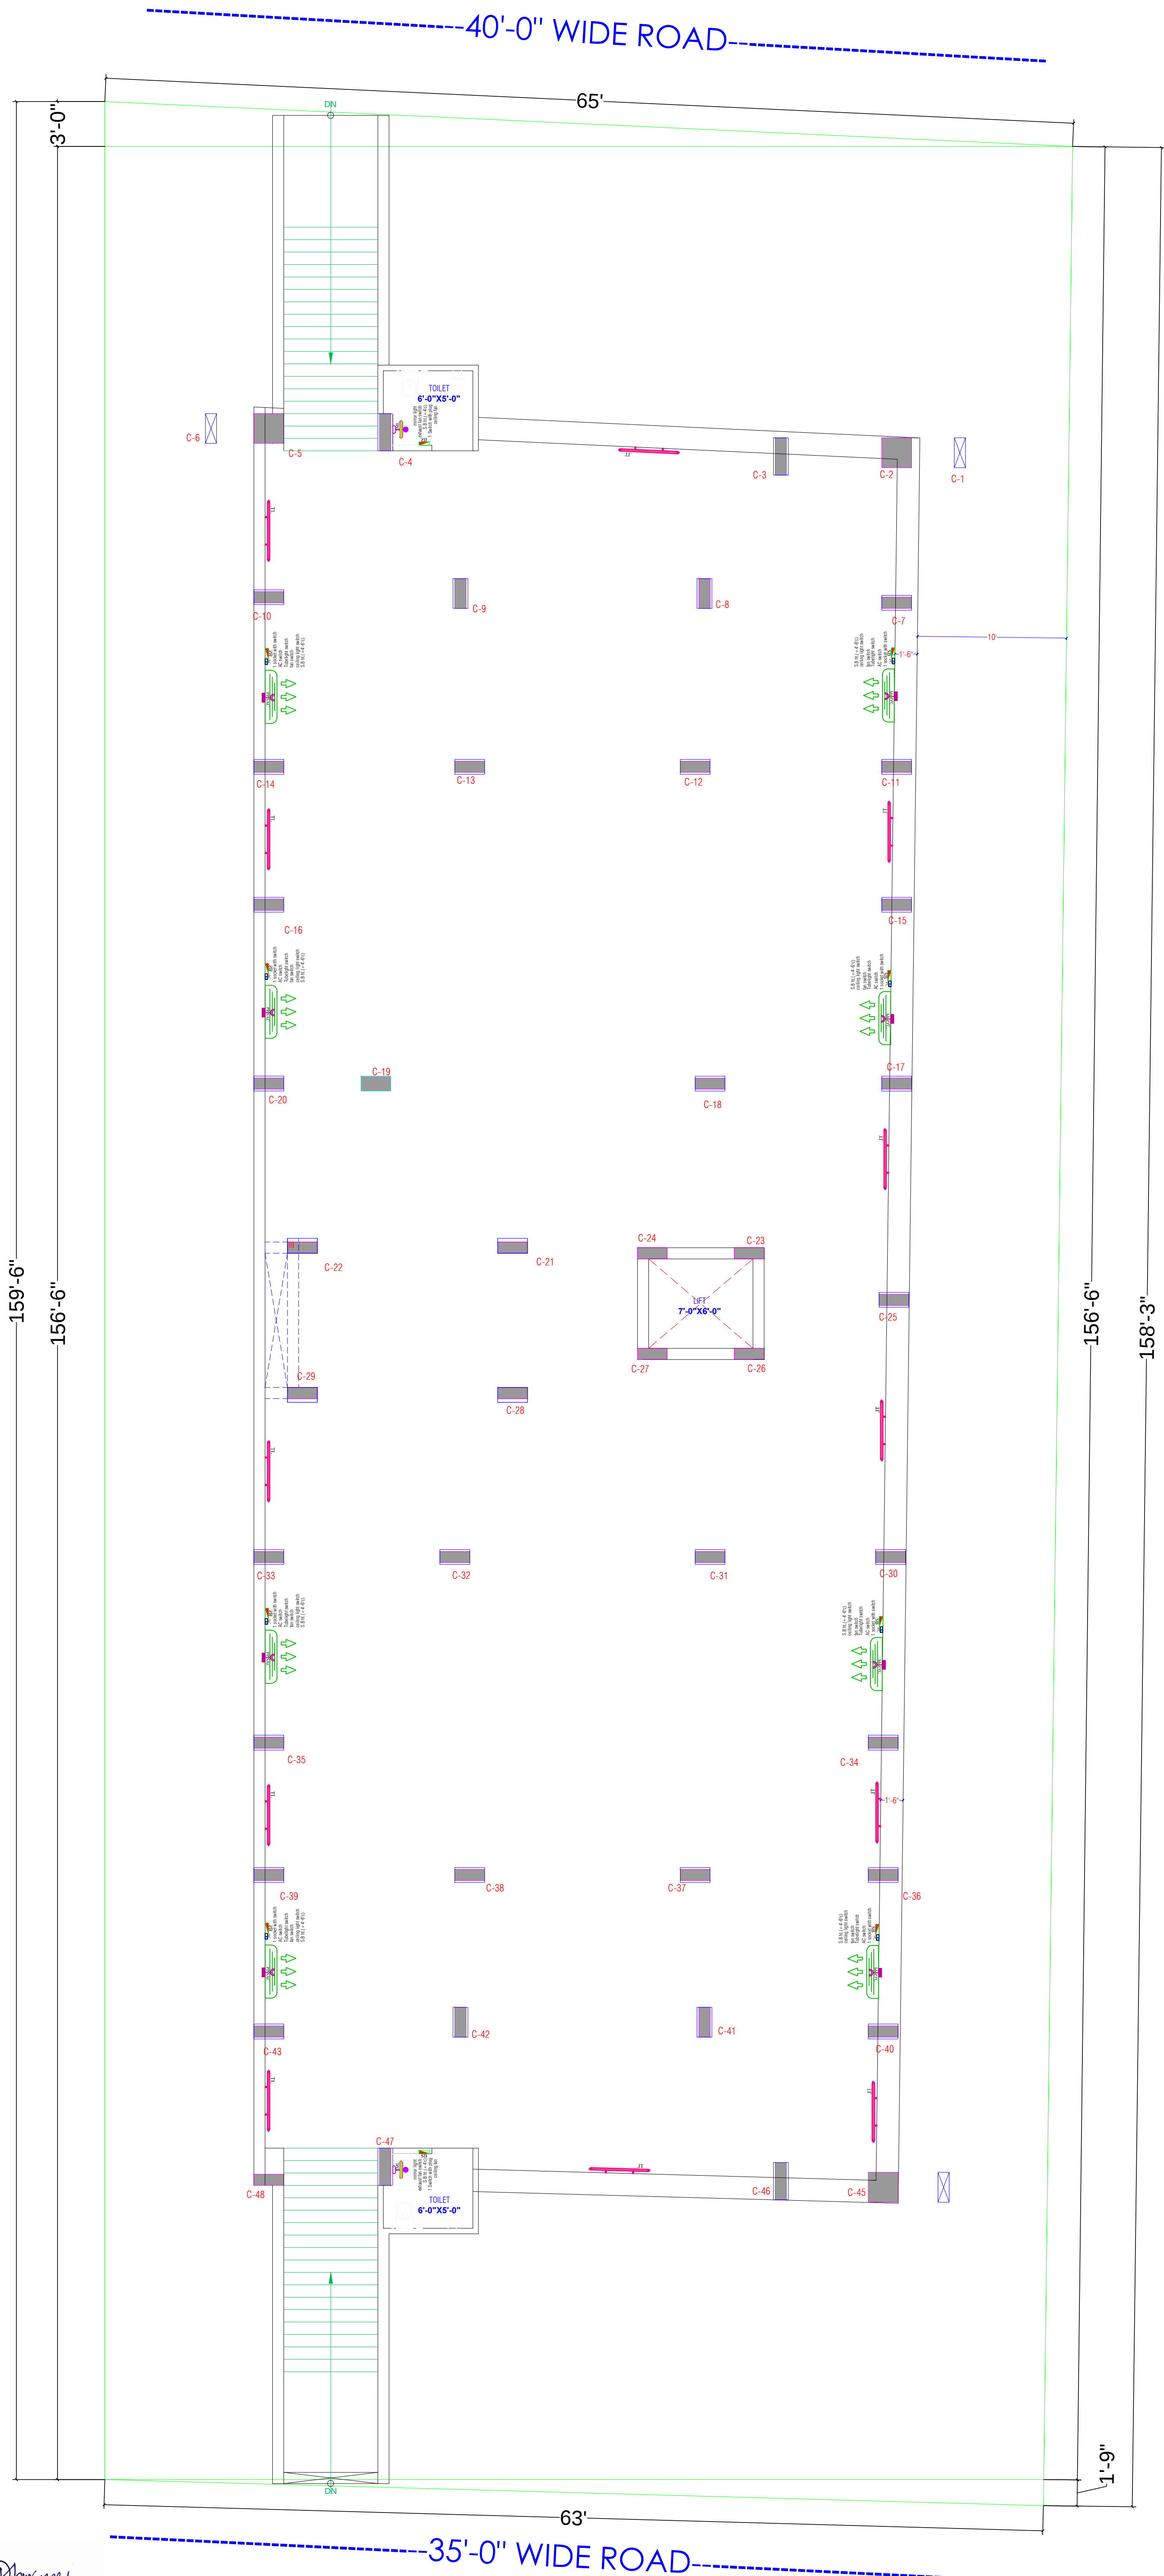

LEGENDS:				
Mounting Height	No.	I D	Symbol	Description
IN FLOOR				CONTROL WIRING
IN CONDUIT				CONTROL WIRING
IN CONDUIT				AC CONTROL WIRING
IN CONDUIT				GEYSER CONTROL WIRING
IN CONDUIT				BUZZER CONTROL WIRING
CEILING	06	FAN/48"		CEILING FAN 48"
CEILING	02	FAN/30"		CEILING FAN 30"
+90"	04	TL		1X40W WALL TUBELIGHT
+90"	04	BULB		WALL BRACKETS AS DESIGN LIGHT
+90"	01	GL		WALL BRACKETS AS DESIGN FOR GANESH LIGHT
	02	GL		WALL BRACKETS AS DESIGN FOR GATE LIGHT
CEILING	21	CFL		CFL CEILING LIGHT
+21"	02	FL		FOOT LIGHT
+48"	14	SB		SWITCH BOARD
+75"	03	ML		1 X 11 W CFL MIRROR LIGHT
VENTILATOR HT.	03	CR		CEILING ROSE
VENTILATOR HT.	03	EXF		9" DIA FRESH AIR FAN
+24"	02	TEL		TELEPHONE POINT
+27"	03	TV		TV COAXIAL POINT.
+24"	02	LP TEL		6 A PLUG POINT FOR TELEPHONE
+27"	03	LP TV		6 A PLUG POINT FOR TV
+24"	02	LP		6 A PLUG POINT
+72"	01	LP-CH		6 A PLUG POINT FOR CHIMNEY
+102"	03	SAC		5PLUT AC
+102"	03	PP- SAC		25 A POWER POINT FOR 5PLUT AC
+42"	01	PP-MIX		15 A POWER POINT FOR MIXER
+78"	02	PP-G		15 A POWER POINT FOR GEYSER
+54"	01	PP-F		15 A POWER POINT FOR FRIDGE
+78"	01	PP-WP		15 A POWER POINT FOR WATER PURIFIER
+48"	01	PP-WM		15 A POWER POINT FOR WASHING MACHINE
+42"	02	BP		BELL PUSH SWITCH
+90"	01	BZ		BUZZER POINT
+24"	03	AC		AC STARTER
+60"	01	MCB DB		MCB DISTRIBUTION BOARD
	05		SBI/LI	SWITCH BOARD NO./ LIGHT CIRCUIT NO.
	03		ACI	AC CIRCUIT NO.
	05		PI	POWER CIRCUIT NO.

WARNING


1. This drawing is the sole copyright of Architects **VISTAAR** and should be used for the purpose expressly issued.

GENERAL NOTES

1. All dimensions are in feet and inches.
2. Do not scale this drawing follow written dimensions only.
3. This drawing should be read in conjunction with other architectural and structural drawings.
4. Any discrepancy in the drawing should be immediately brought to the notice of architect.

PROJECT TITLE			
Shree Krishna Residency Plot No. 82,83,84 E.P, 93 E.P-A-W.P,99 W.P,99 E.P-A , Village - Manpur Devri Urf Golyawas , Scheme - Vrindavan Vihar , Jaipur - 302020 (Rajasthan)			
DRAWING TITLE			
BASEMENT FLOOR WALL ELECTRICAL PLAN			
ARCHITECTS :			
VISTAAR ARCHITECTS & PLANNERS Architects :: Interior Designers B-2/12, Chitrkoot scheme, main Gandhi Path,Opp mall of jaipur,Jaipur PH.- 0141-4116461,09001010366			
PATH :-			
DRN.	DATE	REV.	NORTH
MANOJ KUMAWAT	09-09-2022		
SCALE	JOB NO.		
N.T.S			

Dharmesh
DHARMESH SHARMA
B. TECH. (CIVIL)

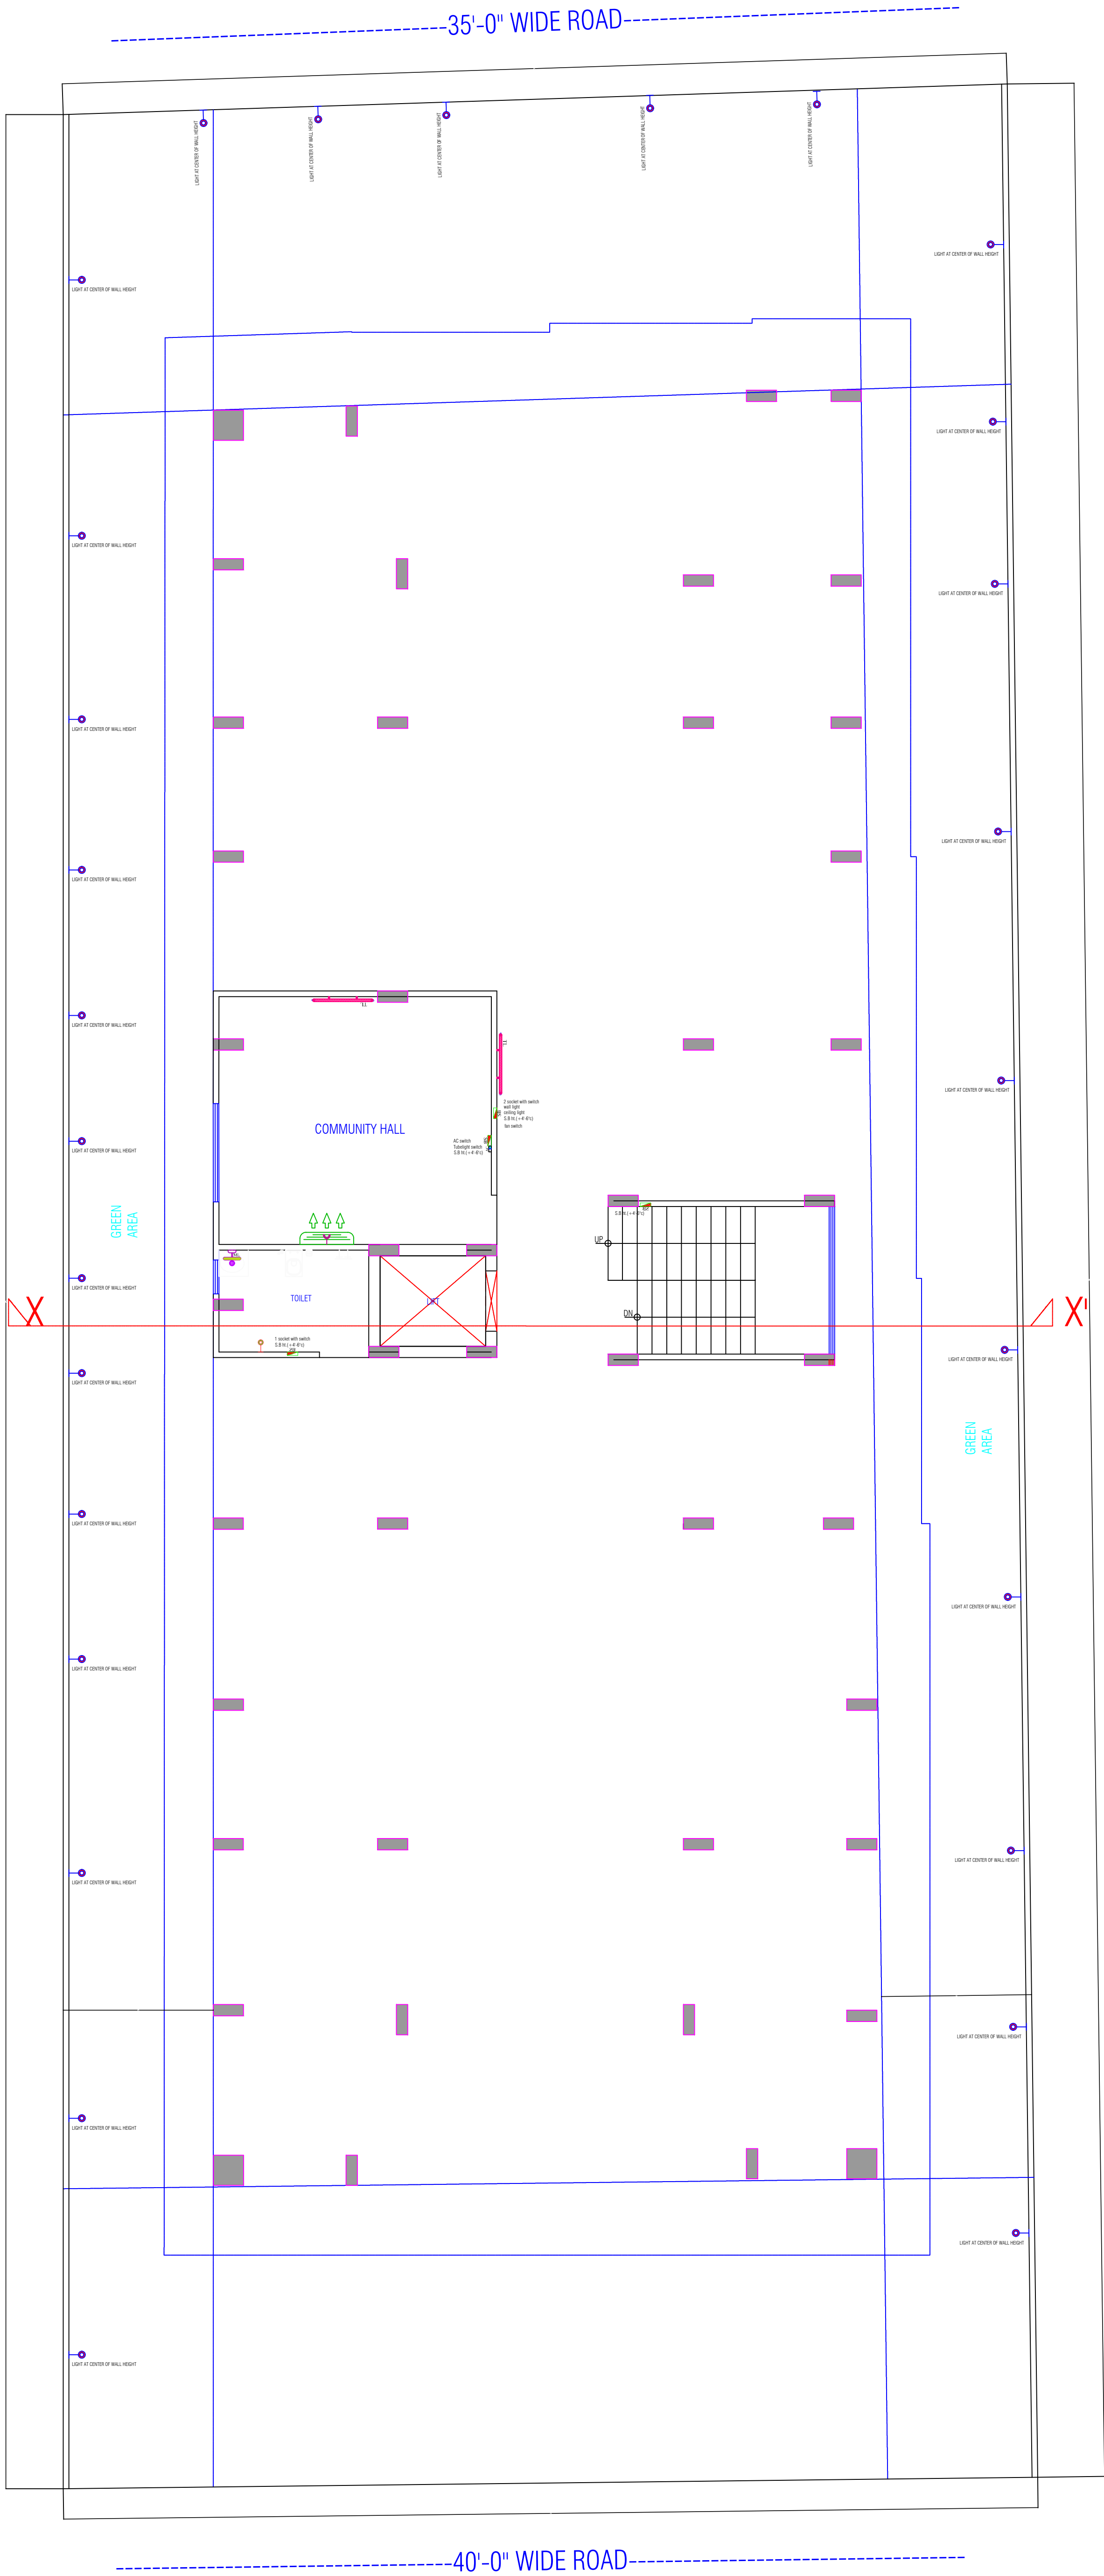

STILT(PARKING)FLOOR PLAN

Dharmesh
DHARMESH SHARMA
B. TECH. (CIVIL)

LEGENDS:				
Mounting Height	No.	I D	Symbol	Description
IN FLOOR				CONTROL WIRING
IN CONDUIT				CONTROL WIRING
IN CONDUIT				AC CONTROL WIRING
IN CONDUIT				GYSER CONTROL WIRING
IN CONDUIT				BUZZER CONTROL WIRING
CEILING	06	FAN/48"		CEILING FAN 48"
CEILING	02	FAN/30"		CEILING FAN 30"
+90"	04	TL		1X40W WALL TUBELIGHT
+90"	04	BULB		WALL BRACKETS AS DESIGN LIGHT
+90"	01	GL		WALL BRACKETS AS DESIGN FOR GANESH LIGHT
	02	GL		WALL BRACKETS AS DESIGN FOR GATE LIGHT
CEILING	21	CFL		CFL CEILING LIGHT
+21"	02	FL		FOOT LIGHT
+48"	14	SB		SWITCH BOARD
+78"	03	ML		1 X 11 W CFL MIRROR LIGHT
VENTILATOR HT.	03	CR		CEILING ROSE
VENTILATOR HT.	03	EXF		9" DIA FRESH AIR FAN
+24"	02	TEL		TELEPHONE POINT
+27"	03	TV		TV COAXIAL POINT.
+24"	02	LP TEL		G A PLUG POINT FOR TELEPHONE
+27"	03	LP TV		G A PLUG POINT FOR TV
+24"	02	LP		G A PLUG POINT
+72"	01	LP-CH		G A PLUG POINT FOR CHIMNEY
+102"	03	SAC		SPLIT AC
+102"	03	PP-SAC		25 A POWER POINT FOR SPLIT AC
+42"	01	PP-MIX		15 A POWER POINT FOR MIXER
+78"	02	PP-G		15 A POWER POINT FOR GEYSER
+54"	01	PP-F		15 A POWER POINT FOR FRIDGE
+78"	01	PP-WP		15 A POWER POINT FOR WATER PURIFIER
+48"	01	PP-WM		15 A POWER POINT FOR WASHING MACHINE
+42"	02	BP		BELL PUSH SWITCH
+90"	01	BZ		BUZZER POINT
+24"	03	AC		AC STARTER
+60"	01	MCB DB		MCB DISTRIBUTION BOARD
	05		SBI/L	SWITCH BOARD NO./ LIGHT CIRCUIT NO.
	03		ACI	AC CIRCUIT NO.
	05		PI	POWER CIRCUIT NO.

WARNING

1. This drawing is the sole copyright of Architects **VISTAAR** and should be used for the purpose expressly issued.

GENERAL NOTES

1. All dimensions are in feet and inches.
2. Do not scale this drawing follow written dimensions only.
3. This drawing should be read in conjunction with other architectural and structural drawings.
4. Any discrepancy in the drawing should be immediately brought to the notice of architect.

PROJECT TITLE

Shree Krishna Residency
Plot No. 82.83.84 E.P, 93 E.P-A-W.P,99 W.P,99
E.P-A , Village - Manpur Devri Urf Golyawas ,
Scheme - Vrindavan Vihar , Jaipur - 302020
(Rajasthan)

DRAWING TITLE

STILT FLOOR
WALL ELECTRICAL PLAN

ARCHITECTS :

VISTAAR ARCHITECTS & PLANNERS

Architects :: Interior Designers
B-2/12, Chitrkoot scheme,
main Gandhi Path,Opp mall of jaipur,Jaipur
PH.- 0141-4116461,09001010366


PATH :-


DRN.	DATE	REV.	NORTH
------	------	------	-------

MANOJ KUMAWAT	09-09-2022		
---------------	------------	--	--

SCALE	JOB NO.		
-------	---------	--	--

N.T.S			
-------	--	--	--

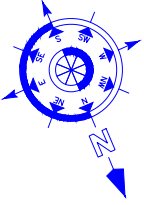

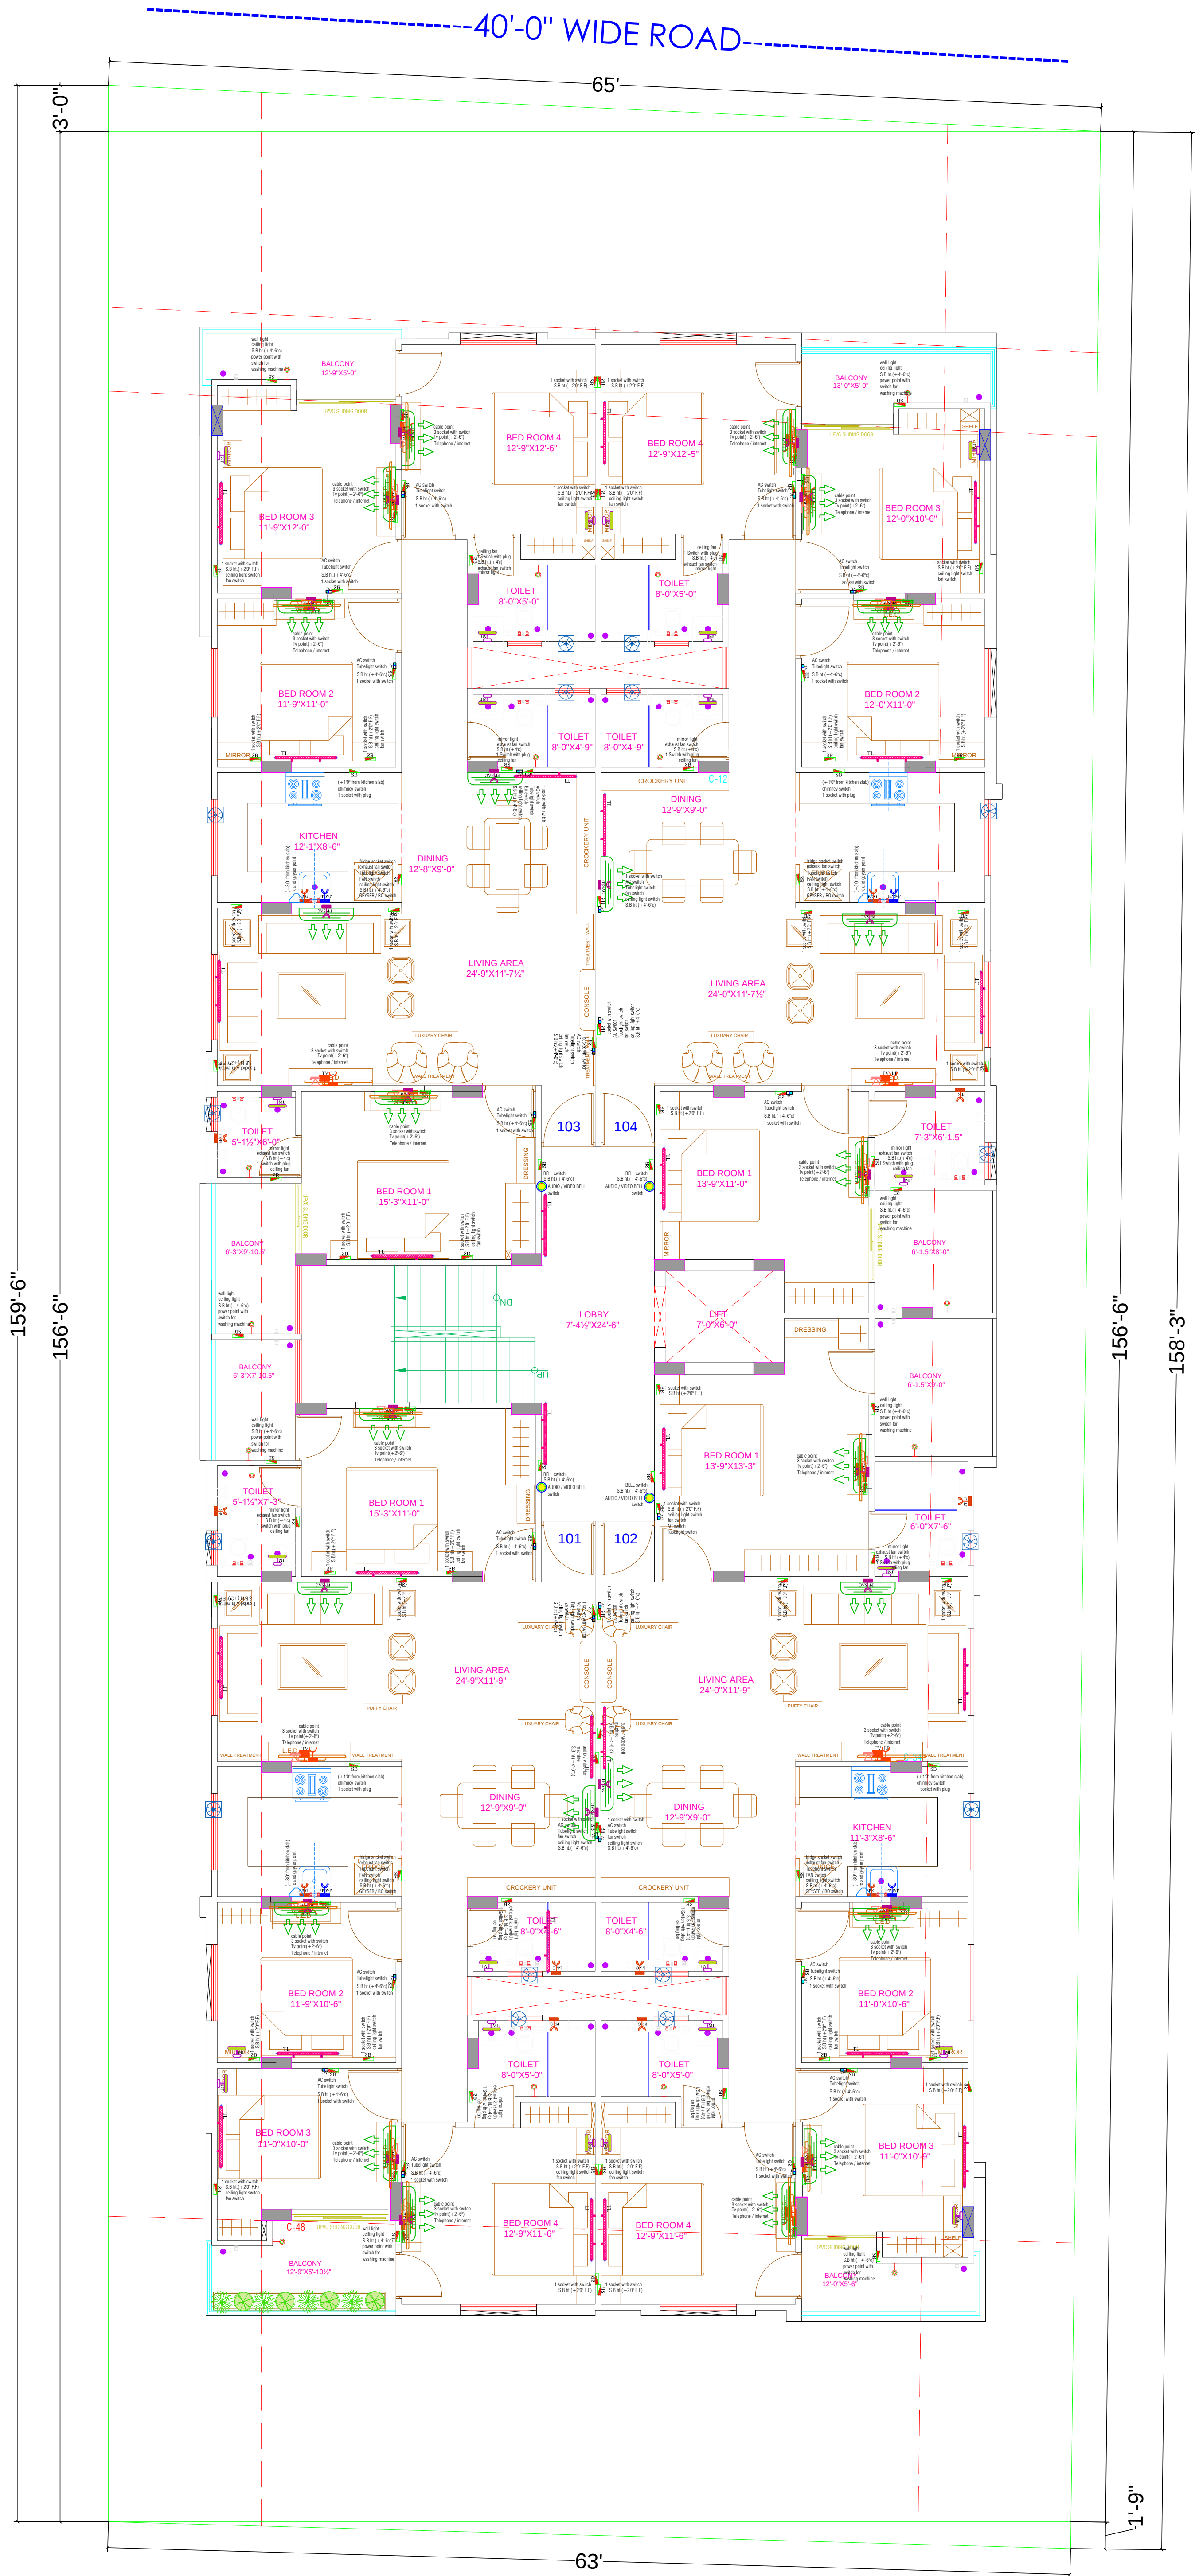

LEGENDS:				
Mounting Height	No.	I D	Symbol	Description
IN FLOOR				CONTROL WIRING
IN CONDUIT				CONTROL WIRING
IN CONDUIT				AC CONTROL WIRING
IN CONDUIT				GYSER CONTROL WIRING
IN CONDUIT				BUZZER CONTROL WIRING
CEILING	FAN/48"			CEILING FAN 48"
CEILING	FAN/30"			CEILING FAN 30"
+90"	TL			1X40W WALL TUBELIGHT
+90"	BULB			WALL BRACKETS AS DESIGN LIGHT
+90"	GL			WALL BRACKETS AS DESIGN FOR GANESH LIGHT
	GL			WALL BRACKETS AS DESIGN FOR GATE LIGHT
CEILING	CFL			CFL CEILING LIGHT
+21"	FL			FOOT LIGHT
+48"	SB			SWITCH BOARD
+78"	ML			1 X 11 W CFL MIRROR LIGHT
VENTILATOR HT.	CR			CEILING ROSE
VENTILATOR HT.	EXF			9" DIA FRESH AIR FAN
+24"	TEL			TELEPHONE POINT
+27"	TV			TV COAXIAL POINT.
+27"	LP TV			6 A PLUG POINT FOR TV
+72"	LP-CH			6 A PLUG POINT FOR CHIMNEY
+102"	SAC			SPLIT AC
+102"	PP-SAC			25 A POWER POINT FOR SPLIT AC
+42"	PP-MIX			15 A POWER POINT FOR MIXER
+78"	PP-G			15 A POWER POINT FOR GEYSER
+54"	PP-F			15 A POWER POINT FOR FRIDGE
+78"	PP-WP			15 A POWER POINT FOR WATER PURIFIER
+48"	PP-WM			15 A POWER POINT FOR WASHING MACHINE
+42"	BP			BELL PUSH SWITCH
+90"	BZ			BUZZER POINT
+48"	AC			AC STARTER
+60"	MCB DB			MCB DISTRIBUTION BOARD

WARNING

1. This drawing is the sole copyright of Architects **VISTAAR** and should be used for the purpose expressly issued.

GENERAL NOTES

1. All dimensions are in feet and inches.
2. Do not scale this drawing follow written dimensions only.
3. This drawing should be read in conjunction with other architectural and structural drawings.
4. Any discrepancy in the drawing should be immediately brought to the notice of architect.

PROJECT TITLE

Shree Krishna Residency
Plot No. 82,83,84 E.P, 93 E.P-A-W.P,99 W.P.99
E.P-A , Village - Manpur Devri Urf Golyawas ,
Scheme - Vrindavan Vihar , Jaipur - 302020
(Rajasthan)

DRAWING TITLE

TYPICAL FLOOR
WALL ELECTRICAL PLAN


ARCHITECTS :

VISTAAR ARCHITECTS & PLANNERS


Architects :: Interior Designers
B-2/12, Chitrkoot scheme,
main Gandhi Path,Opp mall of jaipur,Jaipur
PH.- 0141-4116461,09001010366

PATH :-

DRN.	DATE	REV.	NORTH
MANOJ KUMAWAT	09-09-2022		
SCALE	JOB NO.		
N.T.S			

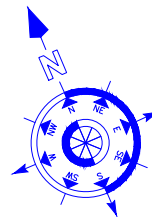

Dharmesh
DHARMESH SHARMA
B. TECH. (CIVIL)

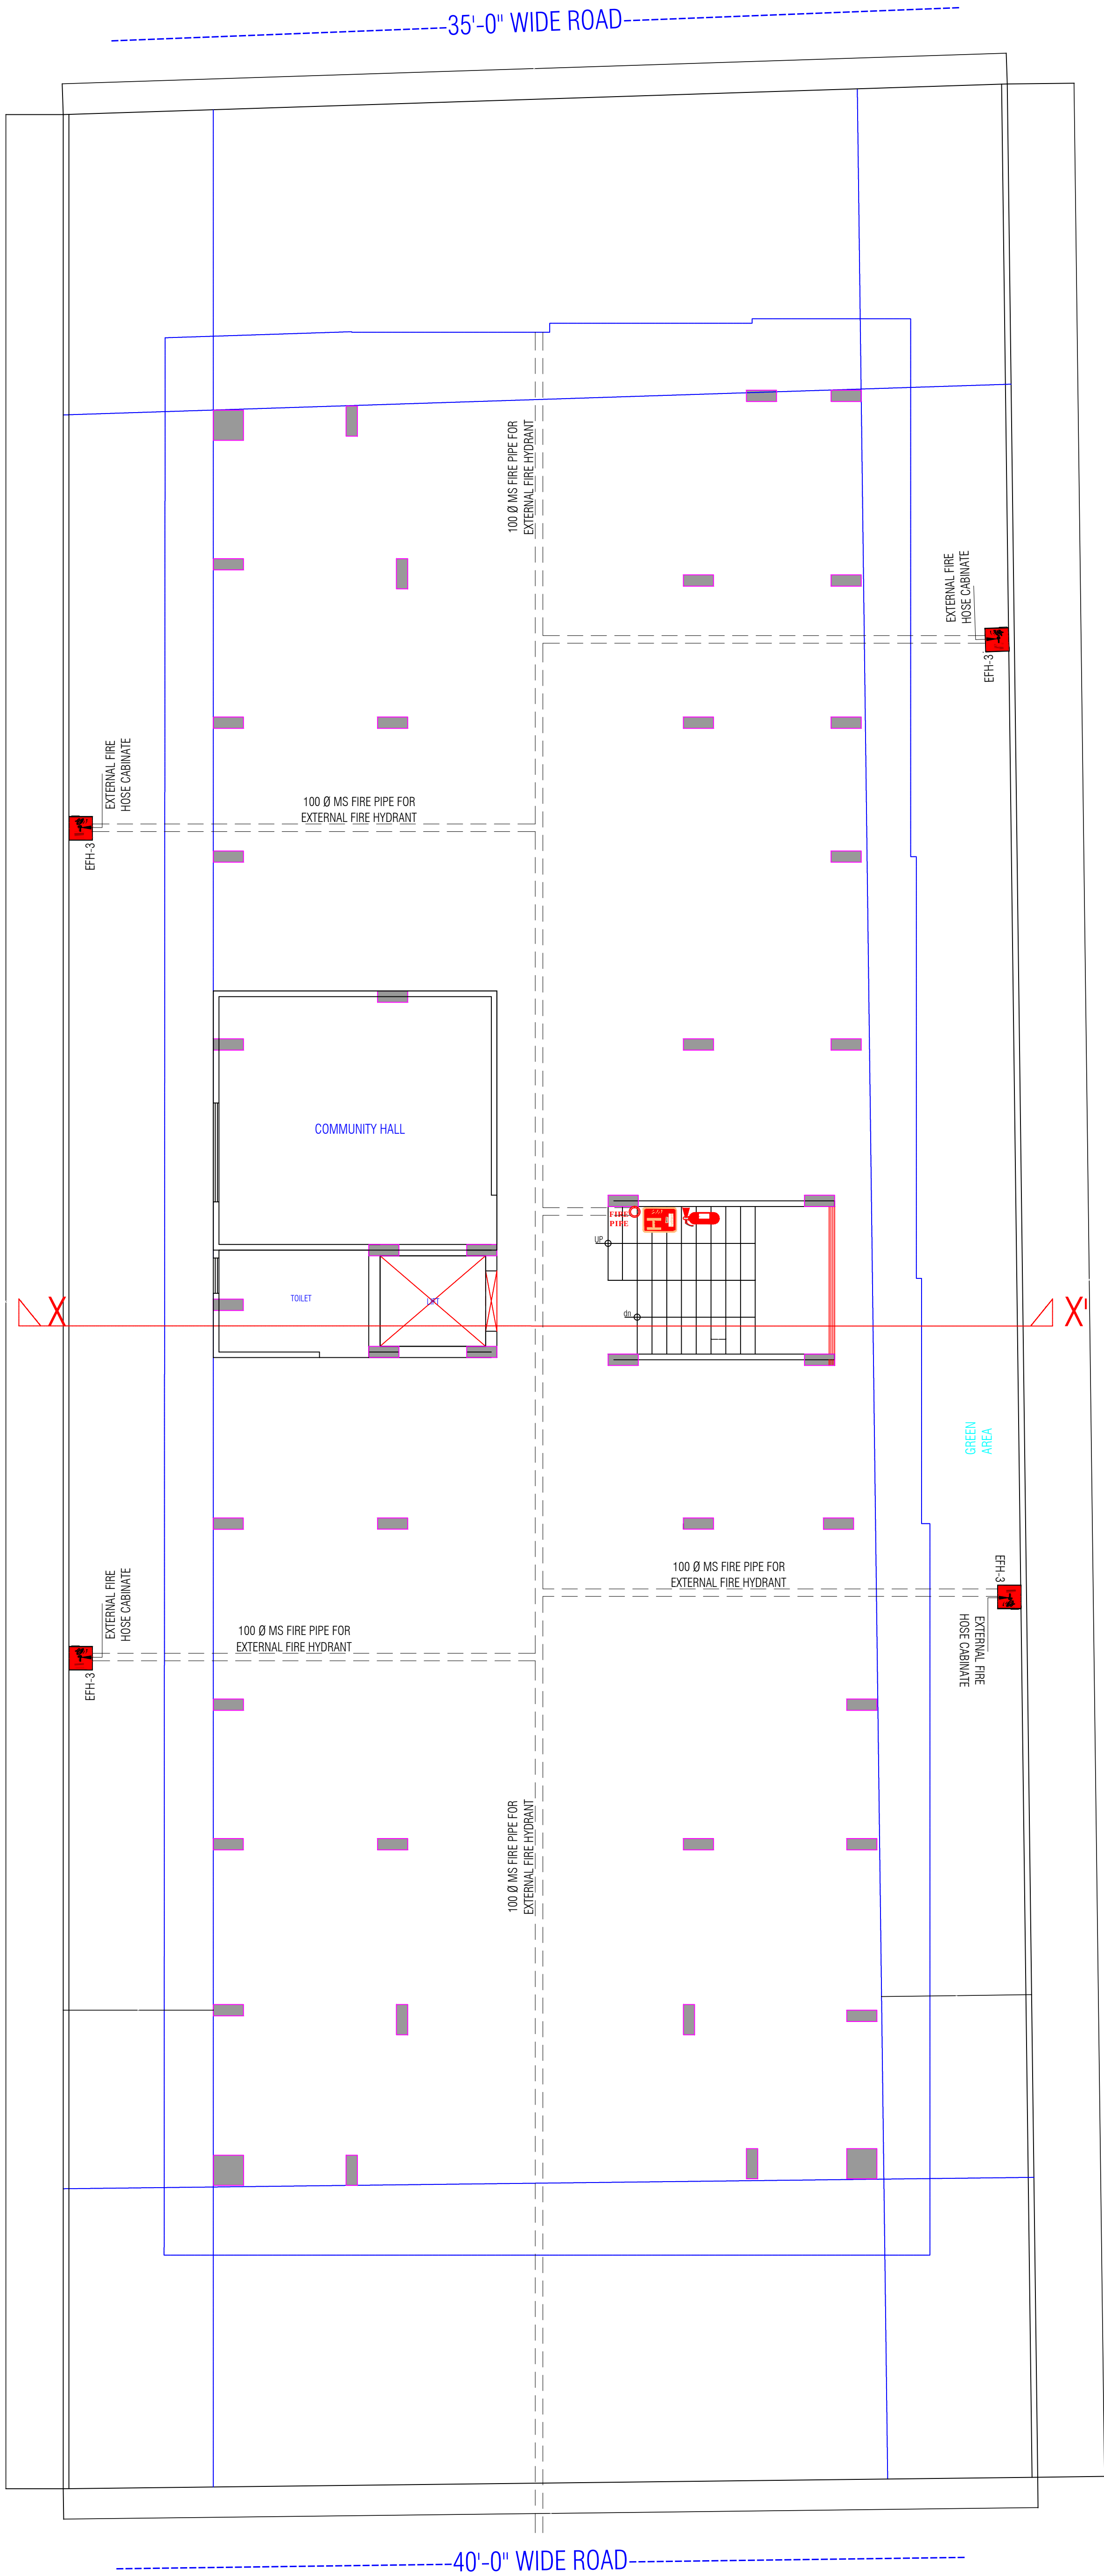

STILT(PARKING)FLOOR PLAN

LEGEND



EMERGENCY
ASSEMBLY POINT



FIRE POINT



FIRE HYDRANT



EMERGENCY
CONTROL ROOM



HOSE REEL

DHARMESH SHARMA
B. TECH. (CIVIL)

WARNING

1. This drawing is the sole copyright of Architects **VISTAAR** and should be used for the purpose expressly issued.

GENERAL NOTES

1. All dimensions are in feet and inches.
2. Do not scale this drawing follow written dimensions only.
3. This drawing should be read in conjunction with other architectural and structural drawings.
4. Any discrepancy in the drawing should be immediately brought to the notice of architect.

PROJECT TITLE

Shree Krishna Residency
Plot No. 82,83,84 E.P, 93 E.P-A-W.P,99 W.P,99
E.P-A , Village - Manpur Devri Urf Golyawas ,
Scheme - Vrindavan Vihar , Jaipur - 302020
(Rajasthan)

DRAWING TITLE

STILT FLOOR FIRE FIGHTER


ARCHITECTS :

VISTAAR ARCHITECTS & PLANNERS

Architects :: Interior Designers
B-2/12, Chitrkoot scheme,
main Gandhi Path,Opp mall of jaipur,Jaipur
PH.- 0141-4116461,09001010366

PATH :-

DRN.	DATE	REV.	NORTH
MANOJ KUMAWAT	09-09-2022		
SCALE	JOB NO.		
N.T.S			

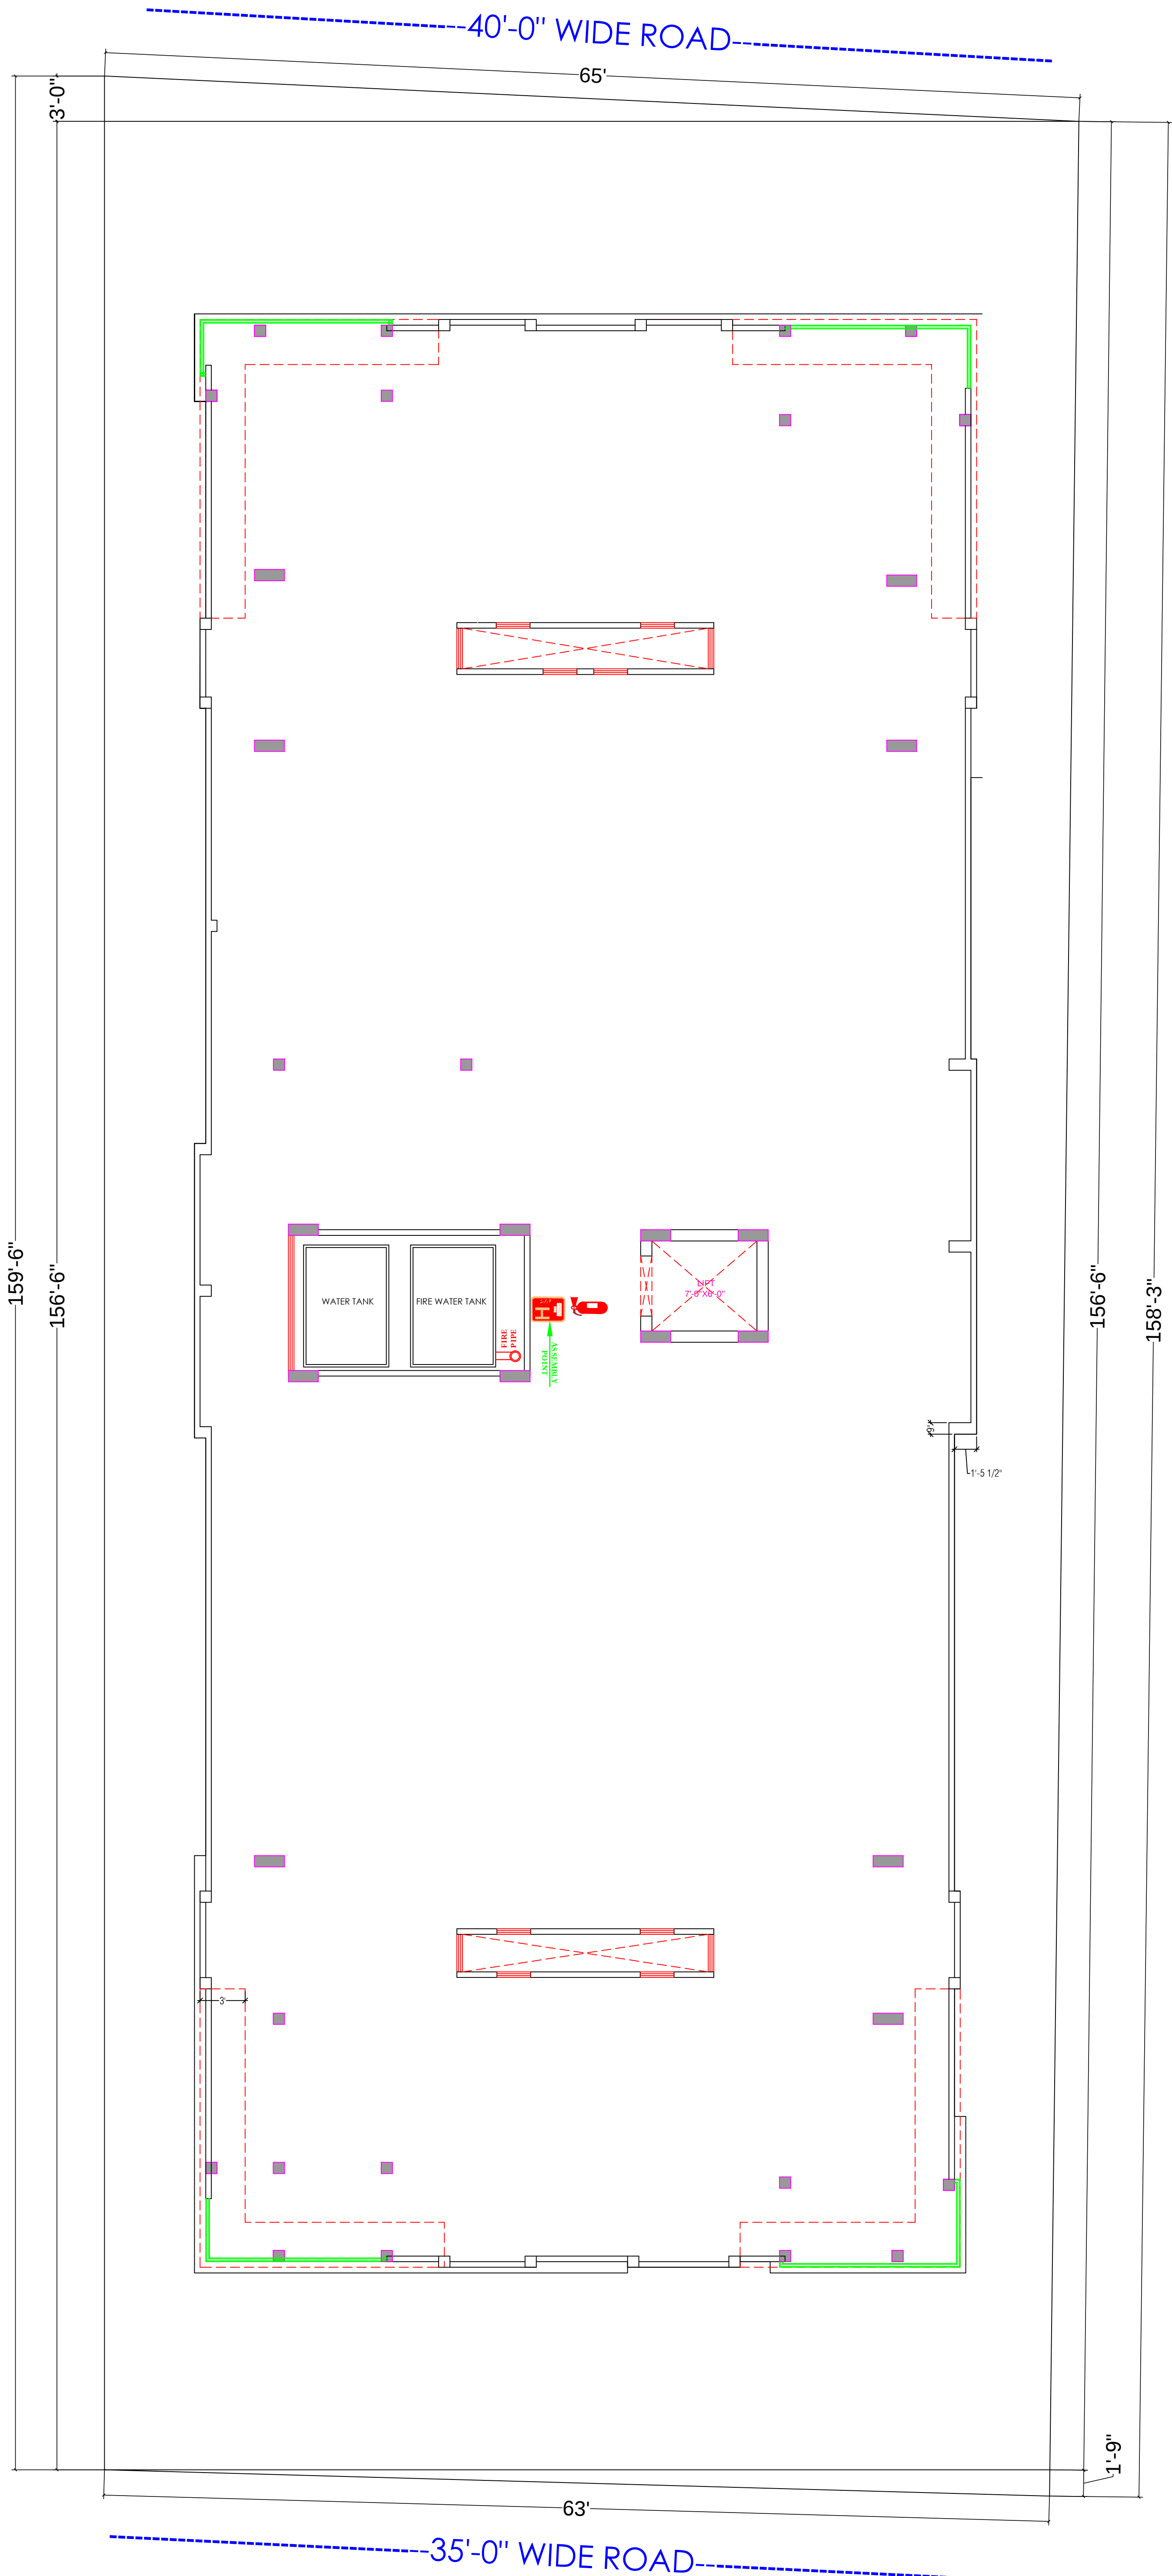

LEGEND



EMERGENCY
ASSEMBLY POINT



FIRE POINT



FIRE HYDRANT



EMERGENCY
CONTROL ROOM



HOSE REEL

Dharmesh Sharma
DHARMESH SHARMA
B. TECH. (CIVIL)

WARNING

1. This drawing is the sole copyright of Architects **VISTAAR** and should be used for the purpose expressly issued.

GENERAL NOTES

1. All dimensions are in feet and inches.
2. Do not scale this drawing follow written dimensions only.
3. This drawing should be read in conjunction with other architectural and structural drawings.
4. Any discrepancy in the drawing should be immediately brought to the notice of architect.

PROJECT TITLE

Shree Krishna Residency
Plot No. 82,83,84 E.P, 93 E.P-A-W.P,99 W.P,99
E.P-A , Village - Manpur Devri Urf Golyawas ,
Scheme - Vrindavan Vihar , Jaipur - 302020
(Rajasthan)

DRAWING TITLE

TERRACE FIRE FIGHTER


ARCHITECTS :

VISTAAR ARCHITECTS & PLANNERS

Architects :: Interior Designers
B-2/12, Chitrkoot scheme,
main Gandhi Path,Opp mall of jaipur,Jaipur
PH.- 0141-4116461,09001010366

PATH :-

DRN.	DATE	REV.	NORTH
MANOJ KUMAWAT	21-10-2022		
SCALE	JOB NO.		
N.T.S			

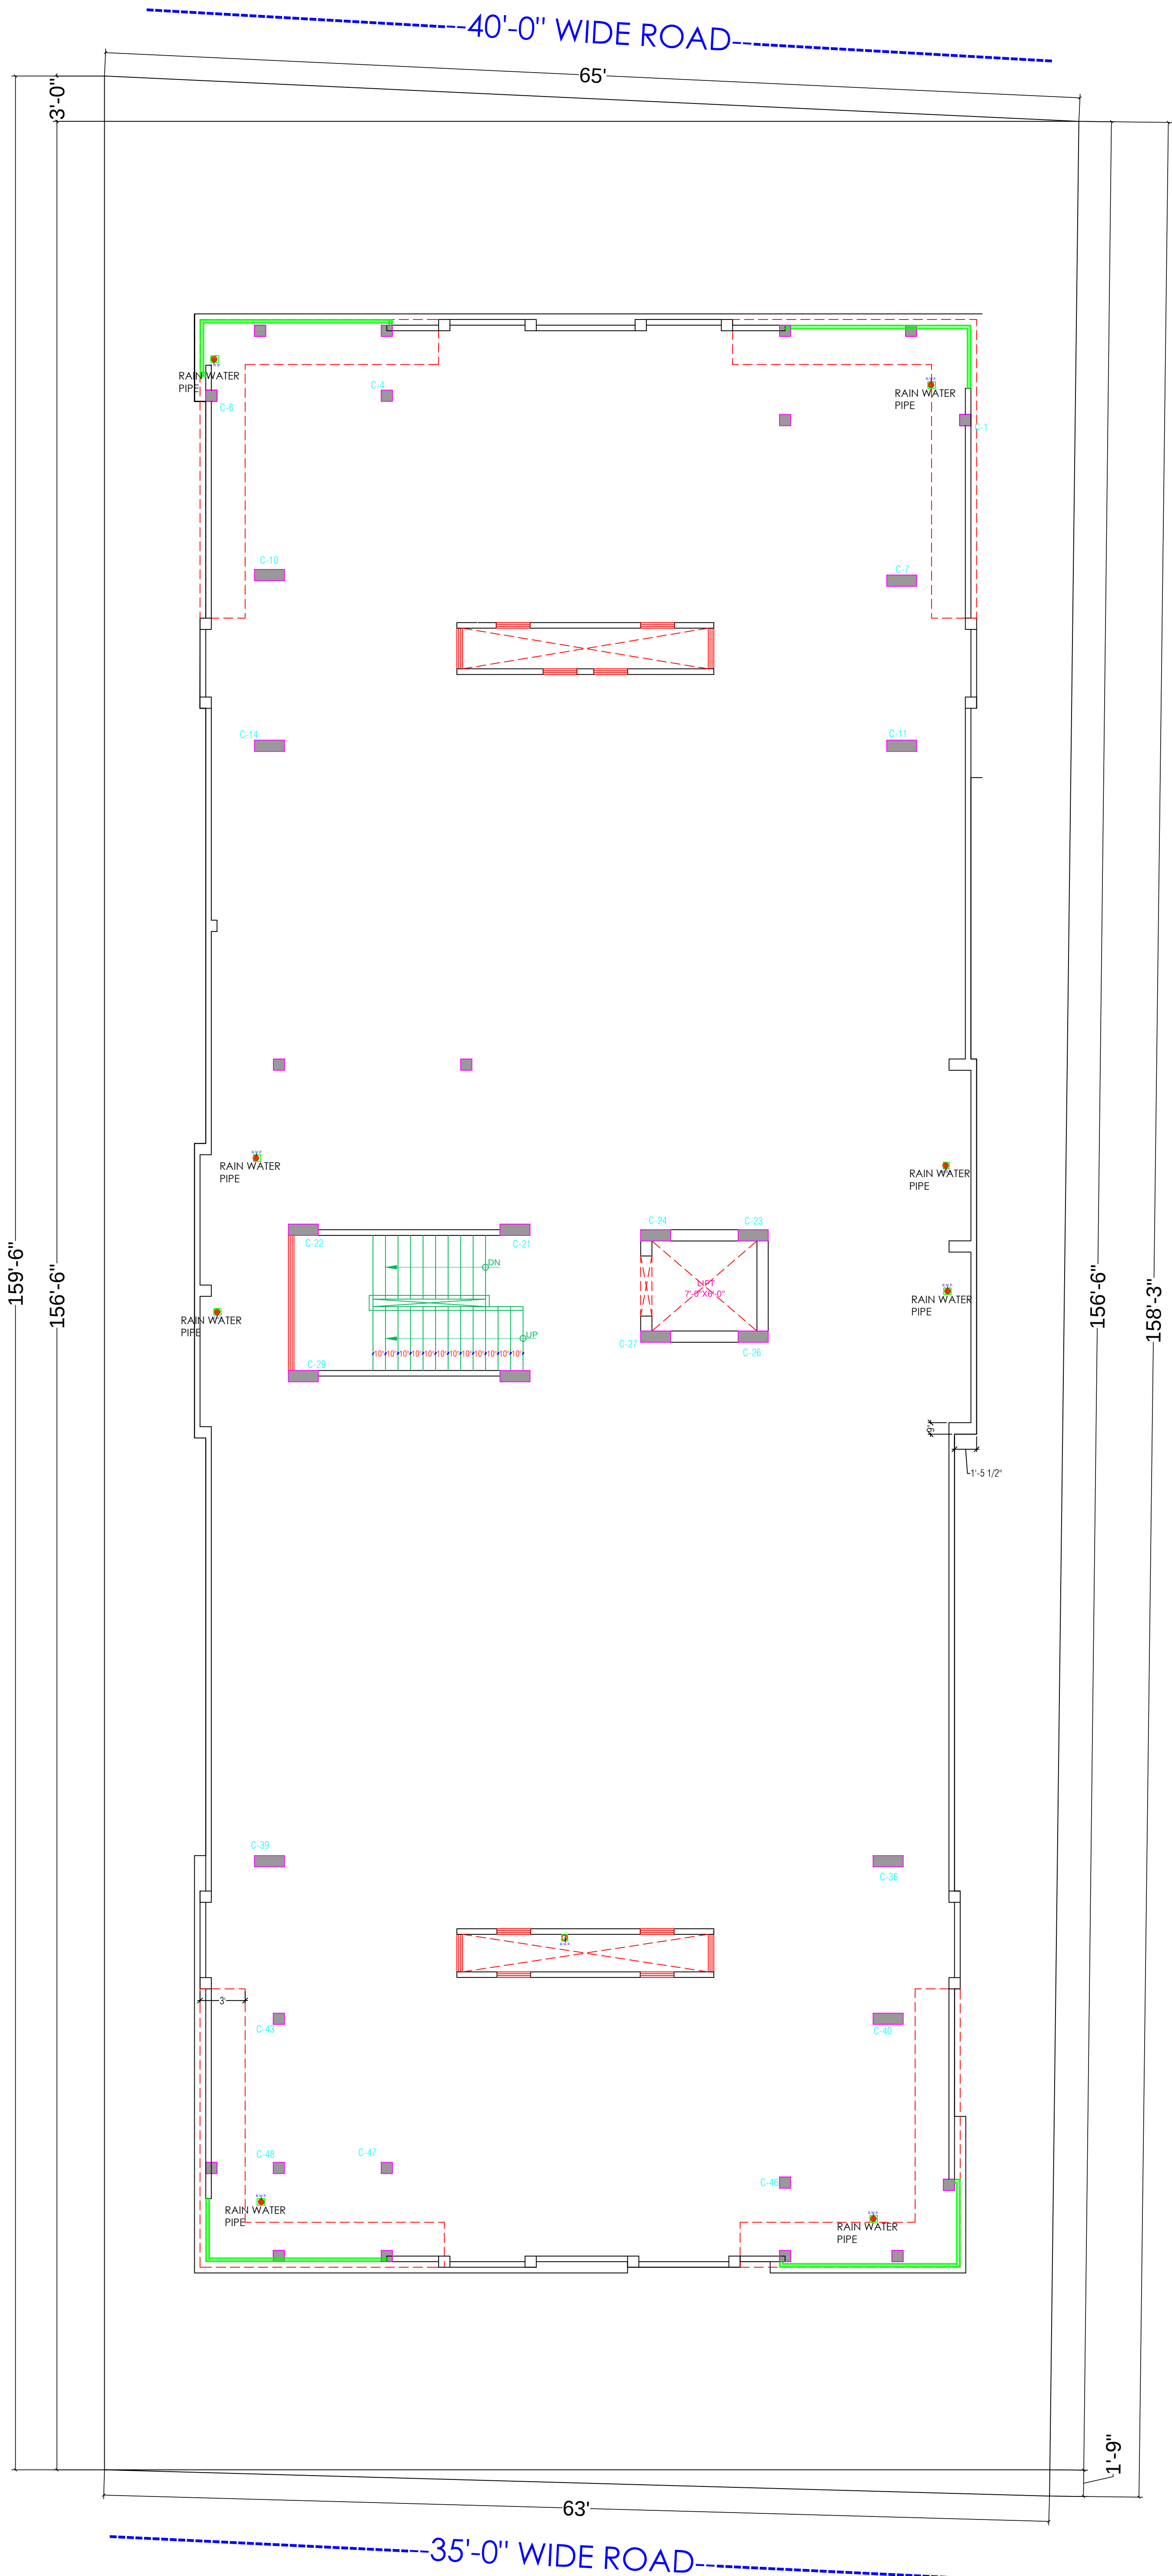

○	RAIN WATER PIPE	⊙	=====
②	WEST WATER PIPE	⊙	=====
③	SOIL WATER PIPE	⊙	=====
④			
⑤			

Dharmesh Sharma
DHARMESH SHARMA
B. TECH. (CIVIL)

WARNING

1. This drawing is the sole copyright of Architects **VISTAAR** and should be used for the purpose expressly issued.

GENERAL NOTES

1. All dimensions are in feet and inches.
2. Do not scale this drawing follow written dimensions only.
3. This drawing should be read in conjunction with other architectural and structural drawings.
4. Any discrepancy in the drawing should be immediately brought to the notice of architect.

PROJECT TITLE

Shree Krishna Residency
Plot No. 82,83,84 E.P. 93 E.P-A-W.P.99 W.P.99
E.P-A , Village - Manpur Devri Urf Golyawas ,
Scheme - Vrindavan Vihar , Jaipur - 302020
(Rajasthan)

DRAWING TITLE

TERRACE FLOOR
RAIN WATER PLAN

ARCHITECTS :

VISTAAR ARCHITECTS & PLANNERS

Architects :: Interior Designers
B-2/12, Chitrkoot scheme,
main Gandhi Path,Opp mall of jaipur,Jaipur
PH.- 0141-4116461,09001010366

PATH :-			
DRN.	DATE	REV.	NORTH
MANOJ KUMAWAT	21-10-2022		
SCALE	JOB NO.		
N.T.S			