


40'-0" WIDE ROAD

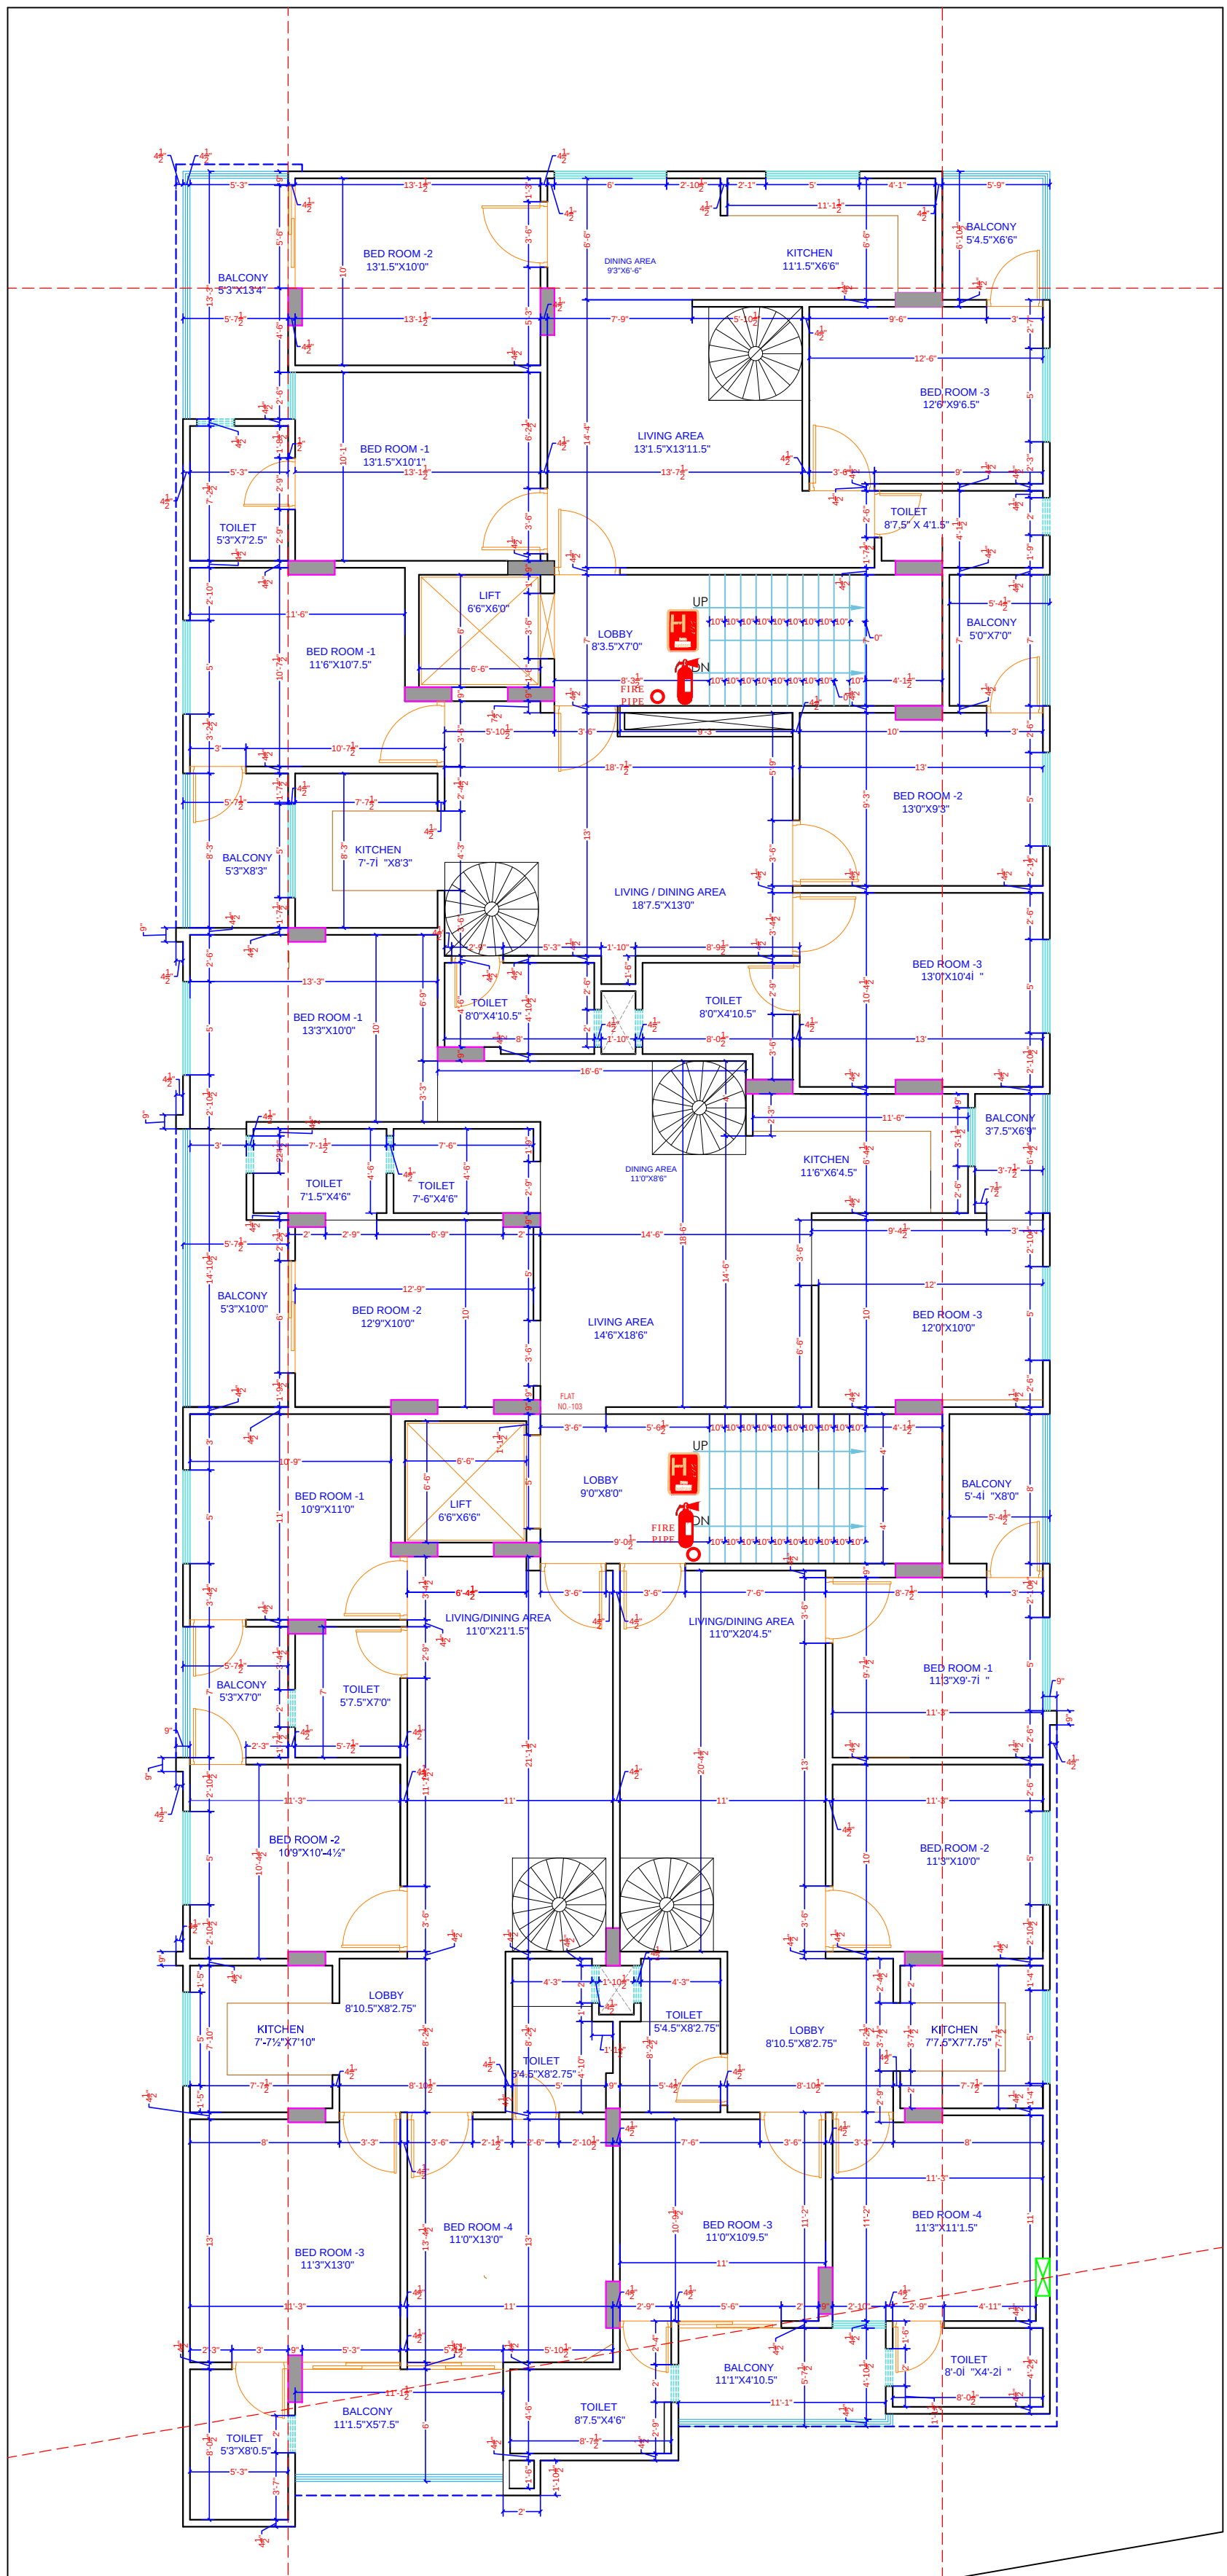

60'-0" WIDE ROAD

For R K Builders & Developers  
Q. 94111  
Proprietor

Krishna  
KRISHNA KUMAR  
B. Tech. (Mechanical)  
M.E.P Consultant

## LEGEND

-  EMERGENCY ASSEMBLY POINT
-  FIRE POINT
-  FIRE HYDRANT
-  EMERGENCY CONTROL ROOM
-  HOSE REEL

## WARNING

1. This drawing is the sole copyright of Architects **VISTAAR** and should be used for the purpose expressly issued.

## GENERAL NOTES

1. All dimensions are in feet and inches.
2. Do not scale this drawing follow written dimensions only.
3. This drawing should be read in conjunction with other architectural and structural drawings.
4. Any discrepancy in the drawing should be immediately brought to the notice of architect.

## PROJECT TITLE

CITY PALM  
BUILDING AT PLOT-E-84,JAGDAMBA  
NAGAR-E,JAIPUR

## DRAWING TITLE


5TH FLOOR FIRE FIGHTER PLAN

## ARCHITECTS :

**VISTAAR ARCHITECTS & PLANNERS**


Architects :: Interior Designers  
B-2/12, Chitrkoot scheme,  
main Gandhi Path,Opp mall of jaipur,Jaipur  
PH.- 0141-4116461,09001010366

| PATH :-       |  | DATE       |  | REV. |  | NORTH |  |
|---------------|--|------------|--|------|--|-------|--|
| DRN.          |  |            |  |      |  |       |  |
| MANOJ KUMAWAT |  | 05-08-2023 |  |      |  |       |  |
| SCALE         |  | JOB NO.    |  |      |  |       |  |
| N.T.S         |  |            |  |      |  |       |  |

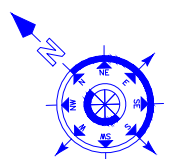

40'-0" WIDE ROAD

144'-3"

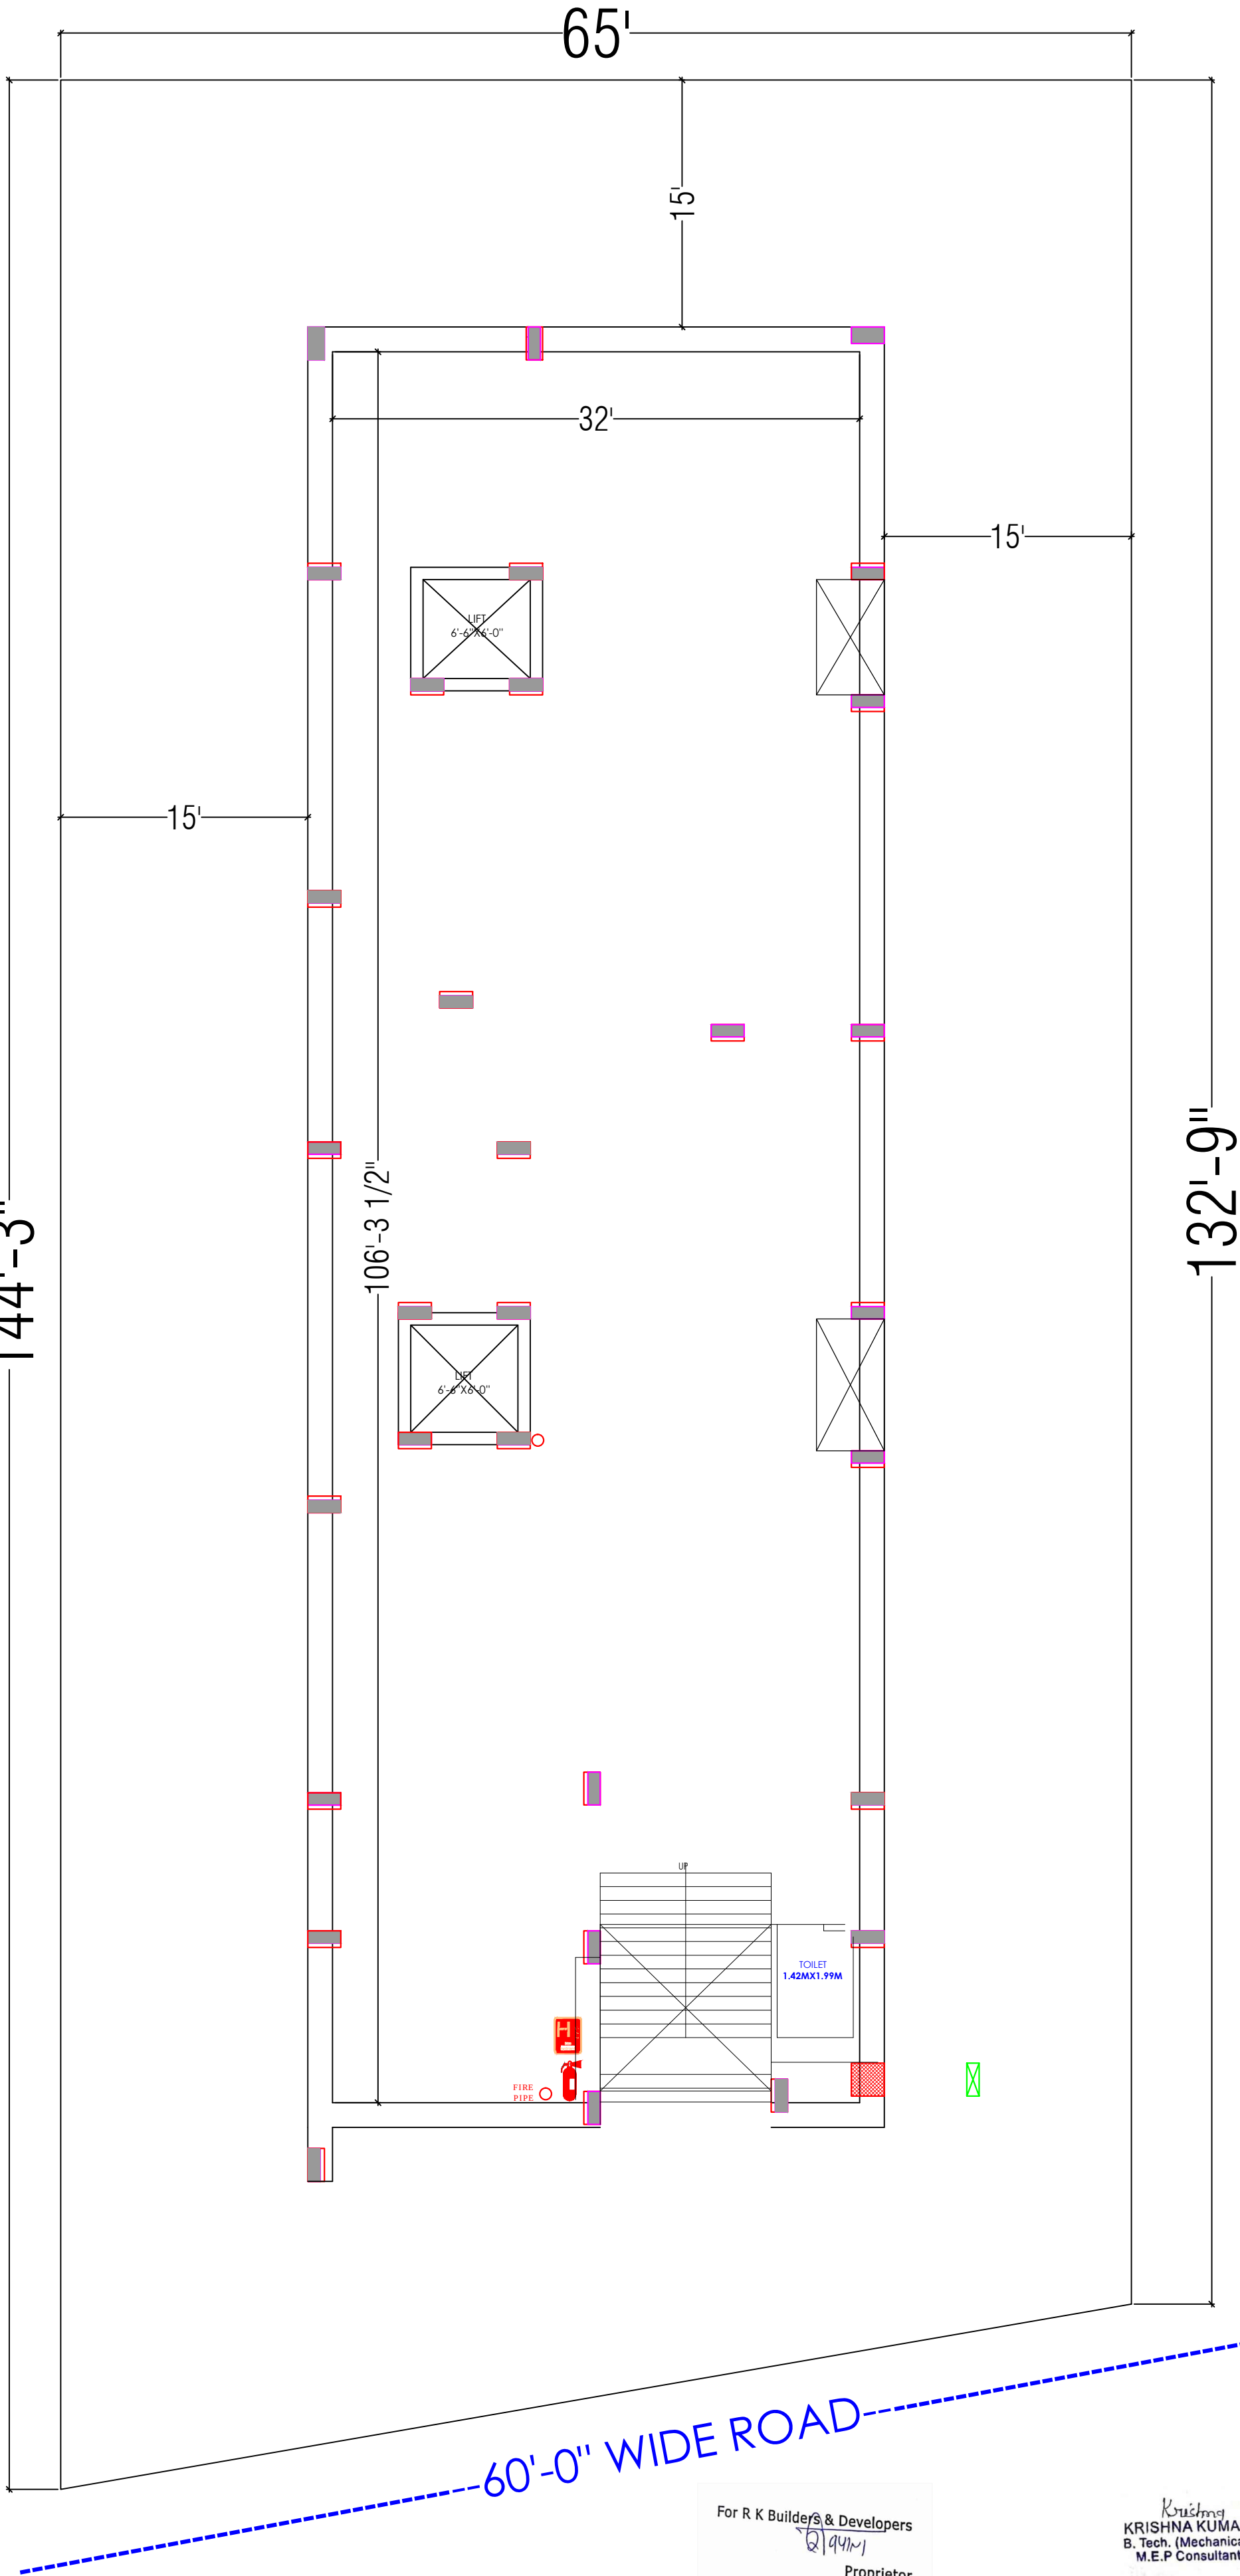

60'-0" WIDE ROAD

For R K Builders & Developers  
Proprietor

Krishna  
KRISHNA KUMAR  
B. Tech. (Mechanical)  
M.E.P Consultant

LEGEND



EMERGENCY ASSEMBLY POINT



FIRE POINT



FIRE HYDRANT



EMERGENCY CONTROL ROOM



HOSE REEL

WARNING

1. This drawing is the sole copyright of Architects **VISTAAR** and should be used for the purpose expressly issued.

GENERAL NOTES

1. All dimensions are in feet and inches.
2. Do not scale this drawing follow written dimensions only.
3. This drawing should be read in conjunction with other architectural and structural drawings.
4. Any discrepancy in the drawing should be immediately brought to the notice of architect.

PROJECT TITLE

CITY PALM  
BUILDING AT PLOT-E-84,JAGDAMBA  
NAGAR-E,JAIPUR

DRAWING TITLE

BASEMENT FLOOR FIRE FIGHTER PLAN

ARCHITECTS :

VISTAAR ARCHITECTS & PLANNERS

Architects :: Interior Designers  
B-2/12, Chitrkoot scheme,  
main Gandhi Path,Opp mall of jaipur,Jaipur  
PH. - 0141-4116461,09001010366

PATH :-

DRN.

DATE

REV.

NORTH


MANOJ  
KUMAWAT





23-06-2023

SCALE

JOB NO.

N.T.S

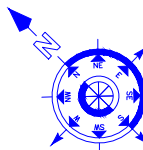

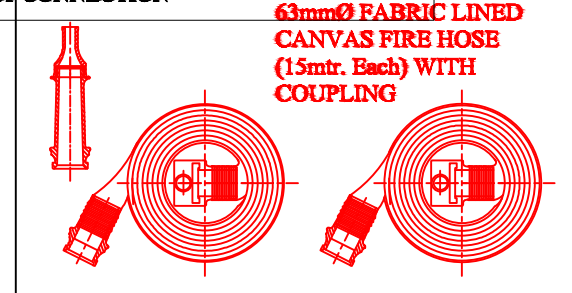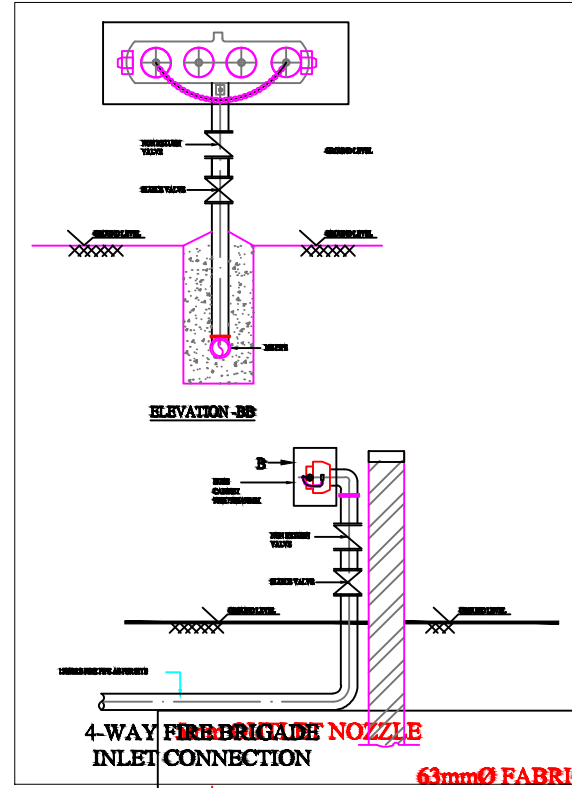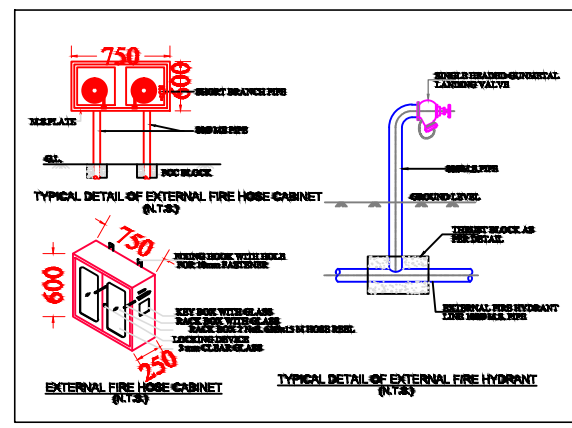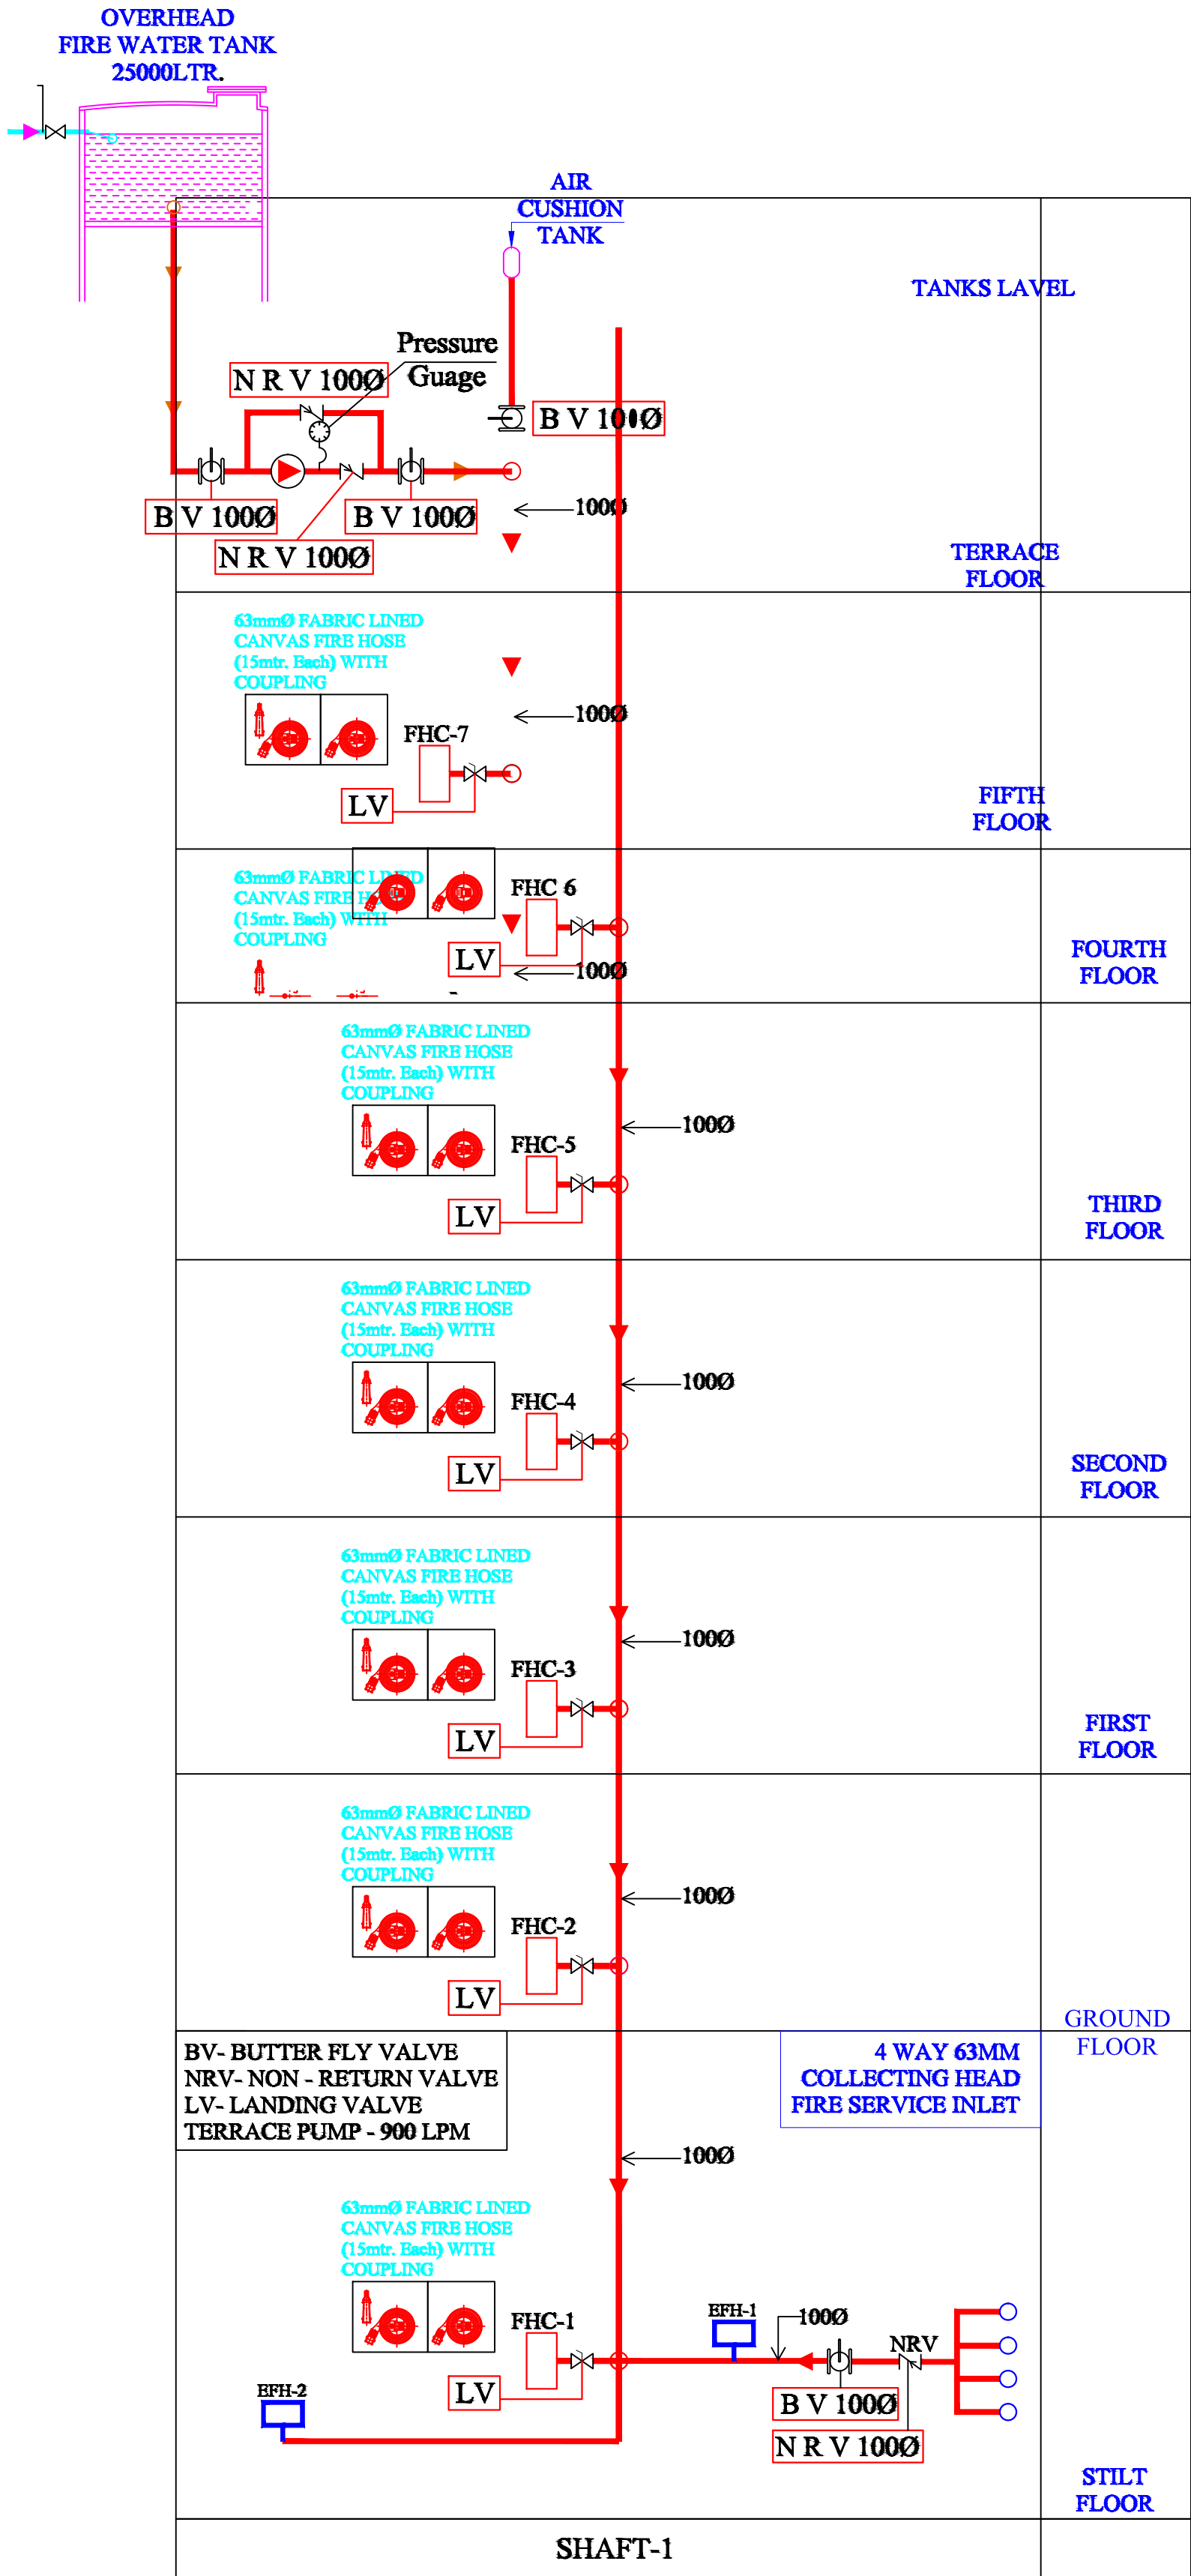


For R K Builders & Developers  
Proprietor

Krishna  
KRISHNA KUMAR  
B. Tech. (Mechanical)  
M.E.P Consultant

|                                                                                                                                                                                                                                                                                                                                     |            |      |       |
|-------------------------------------------------------------------------------------------------------------------------------------------------------------------------------------------------------------------------------------------------------------------------------------------------------------------------------------|------------|------|-------|
| <b>WARNING</b><br>1. This drawing is the sole copyright of Architects VISTAAR and should be used for the purpose expressly issued.                                                                                                                                                                                                  |            |      |       |
| <b>GENERAL NOTES</b><br>1. All dimensions are in feet and inches.<br>2. Do not scale this drawing follow written dimensions only.<br>3. This drawing should be read in conjunction with other architectural and structural drawings.<br>4. Any discrepancy in the drawing should be immediately brought to the notice of architect. |            |      |       |
| PROJECT TITLE                                                                                                                                                                                                                                                                                                                       |            |      |       |
| CITY PALM BUILDING AT PLOT-E-84, JAGDAMBA NAGAR-E, JAIPUR                                                                                                                                                                                                                                                                           |            |      |       |
| DRAWING TITLE                                                                                                                                                                                                                                                                                                                       |            |      |       |
| FIRE SCHEMATIC LAYOUT PLAN                                                                                                                                                                                                                                                                                                          |            |      |       |
| ARCHITECTS :                                                                                                                                                                                                                                                                                                                        |            |      |       |
| VISTAAR ARCHITECTS & PLANNERS<br>Architects :: Interior Designers<br>B-2/12, Chitrkoot scheme, main Gandhi Path, Opp mall of Jaipur, Jaipur<br>PH- 0141-4116461, 09001010366                                                                                                                                                        |            |      |       |
| DESIGNED BY                                                                                                                                                                                                                                                                                                                         | CHECKED BY | DATE | SCALE |
| 23-06-2023                                                                                                                                                                                                                                                                                                                          |            |      |       |
| N/A                                                                                                                                                                                                                                                                                                                                 |            |      |       |



40'-0" WIDE ROAD

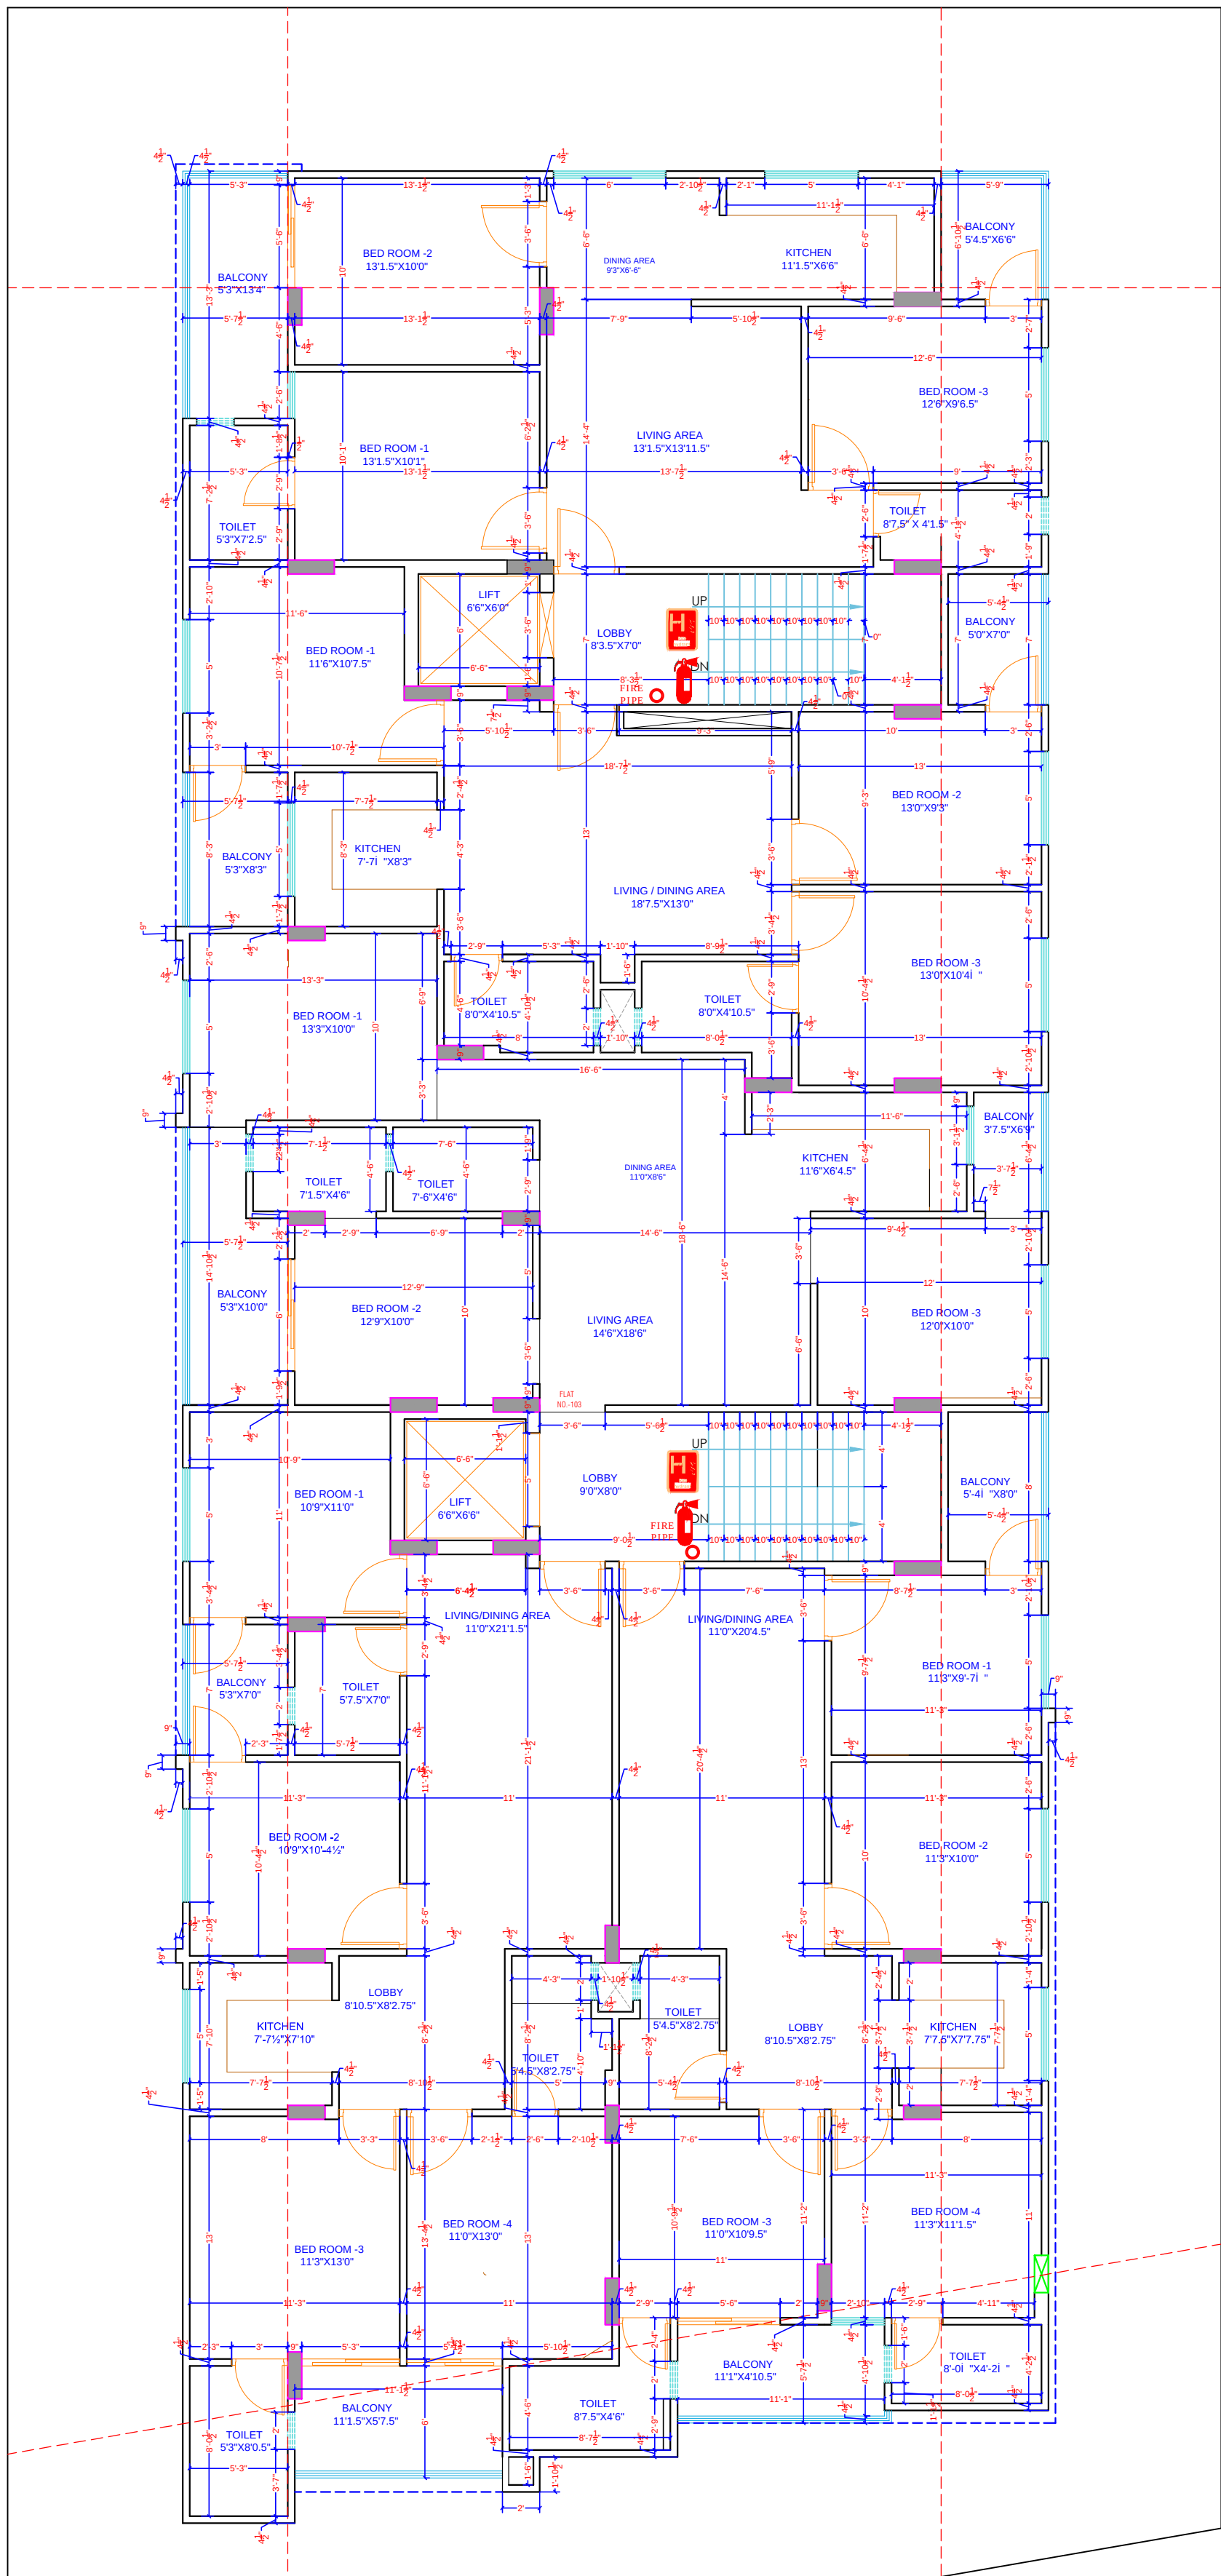

60'-0" WIDE ROAD

For R K Builders & Developers  
Proprietor

Krishna  
KRISHNA KUMAR  
B. Tech. (Mechanical)  
M.E.P Consultant

## LEGEND



EMERGENCY ASSEMBLY POINT



FIRE POINT



FIRE HYDRANT



EMERGENCY CONTROL ROOM



HOSE REEL

## WARNING

1. This drawing is the sole copyright of Architects **VISTAAR** and should be used for the purpose expressly issued.

## GENERAL NOTES

1. All dimensions are in feet and inches.
2. Do not scale this drawing follow written dimensions only.
3. This drawing should be read in conjunction with other architectural and structural drawings.
4. Any discrepancy in the drawing should be immediately brought to the notice of architect.

PROJECT TITLE

CITY PALM  
BUILDING AT PLOT-E-84,JAGDAMBA  
NAGAR-E,JAIPUR

DRAWING TITLE

GROUND TO 4TH FLOOR FIRE FIGHTER PLAN

ARCHITECTS :

**VISTAAR ARCHITECTS & PLANNERS**

Architects :: Interior Designers  
B-2/12, Chitrkoot scheme,  
main Gandhi Path,Opp mall of jaipur,Jaipur  
PH.- 0141-4116461,09001010366

PATH :-

DRN.

DATE


REV.

NORTH


SCALE

JOB NO.

N.T.S

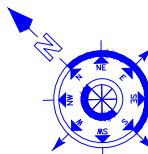



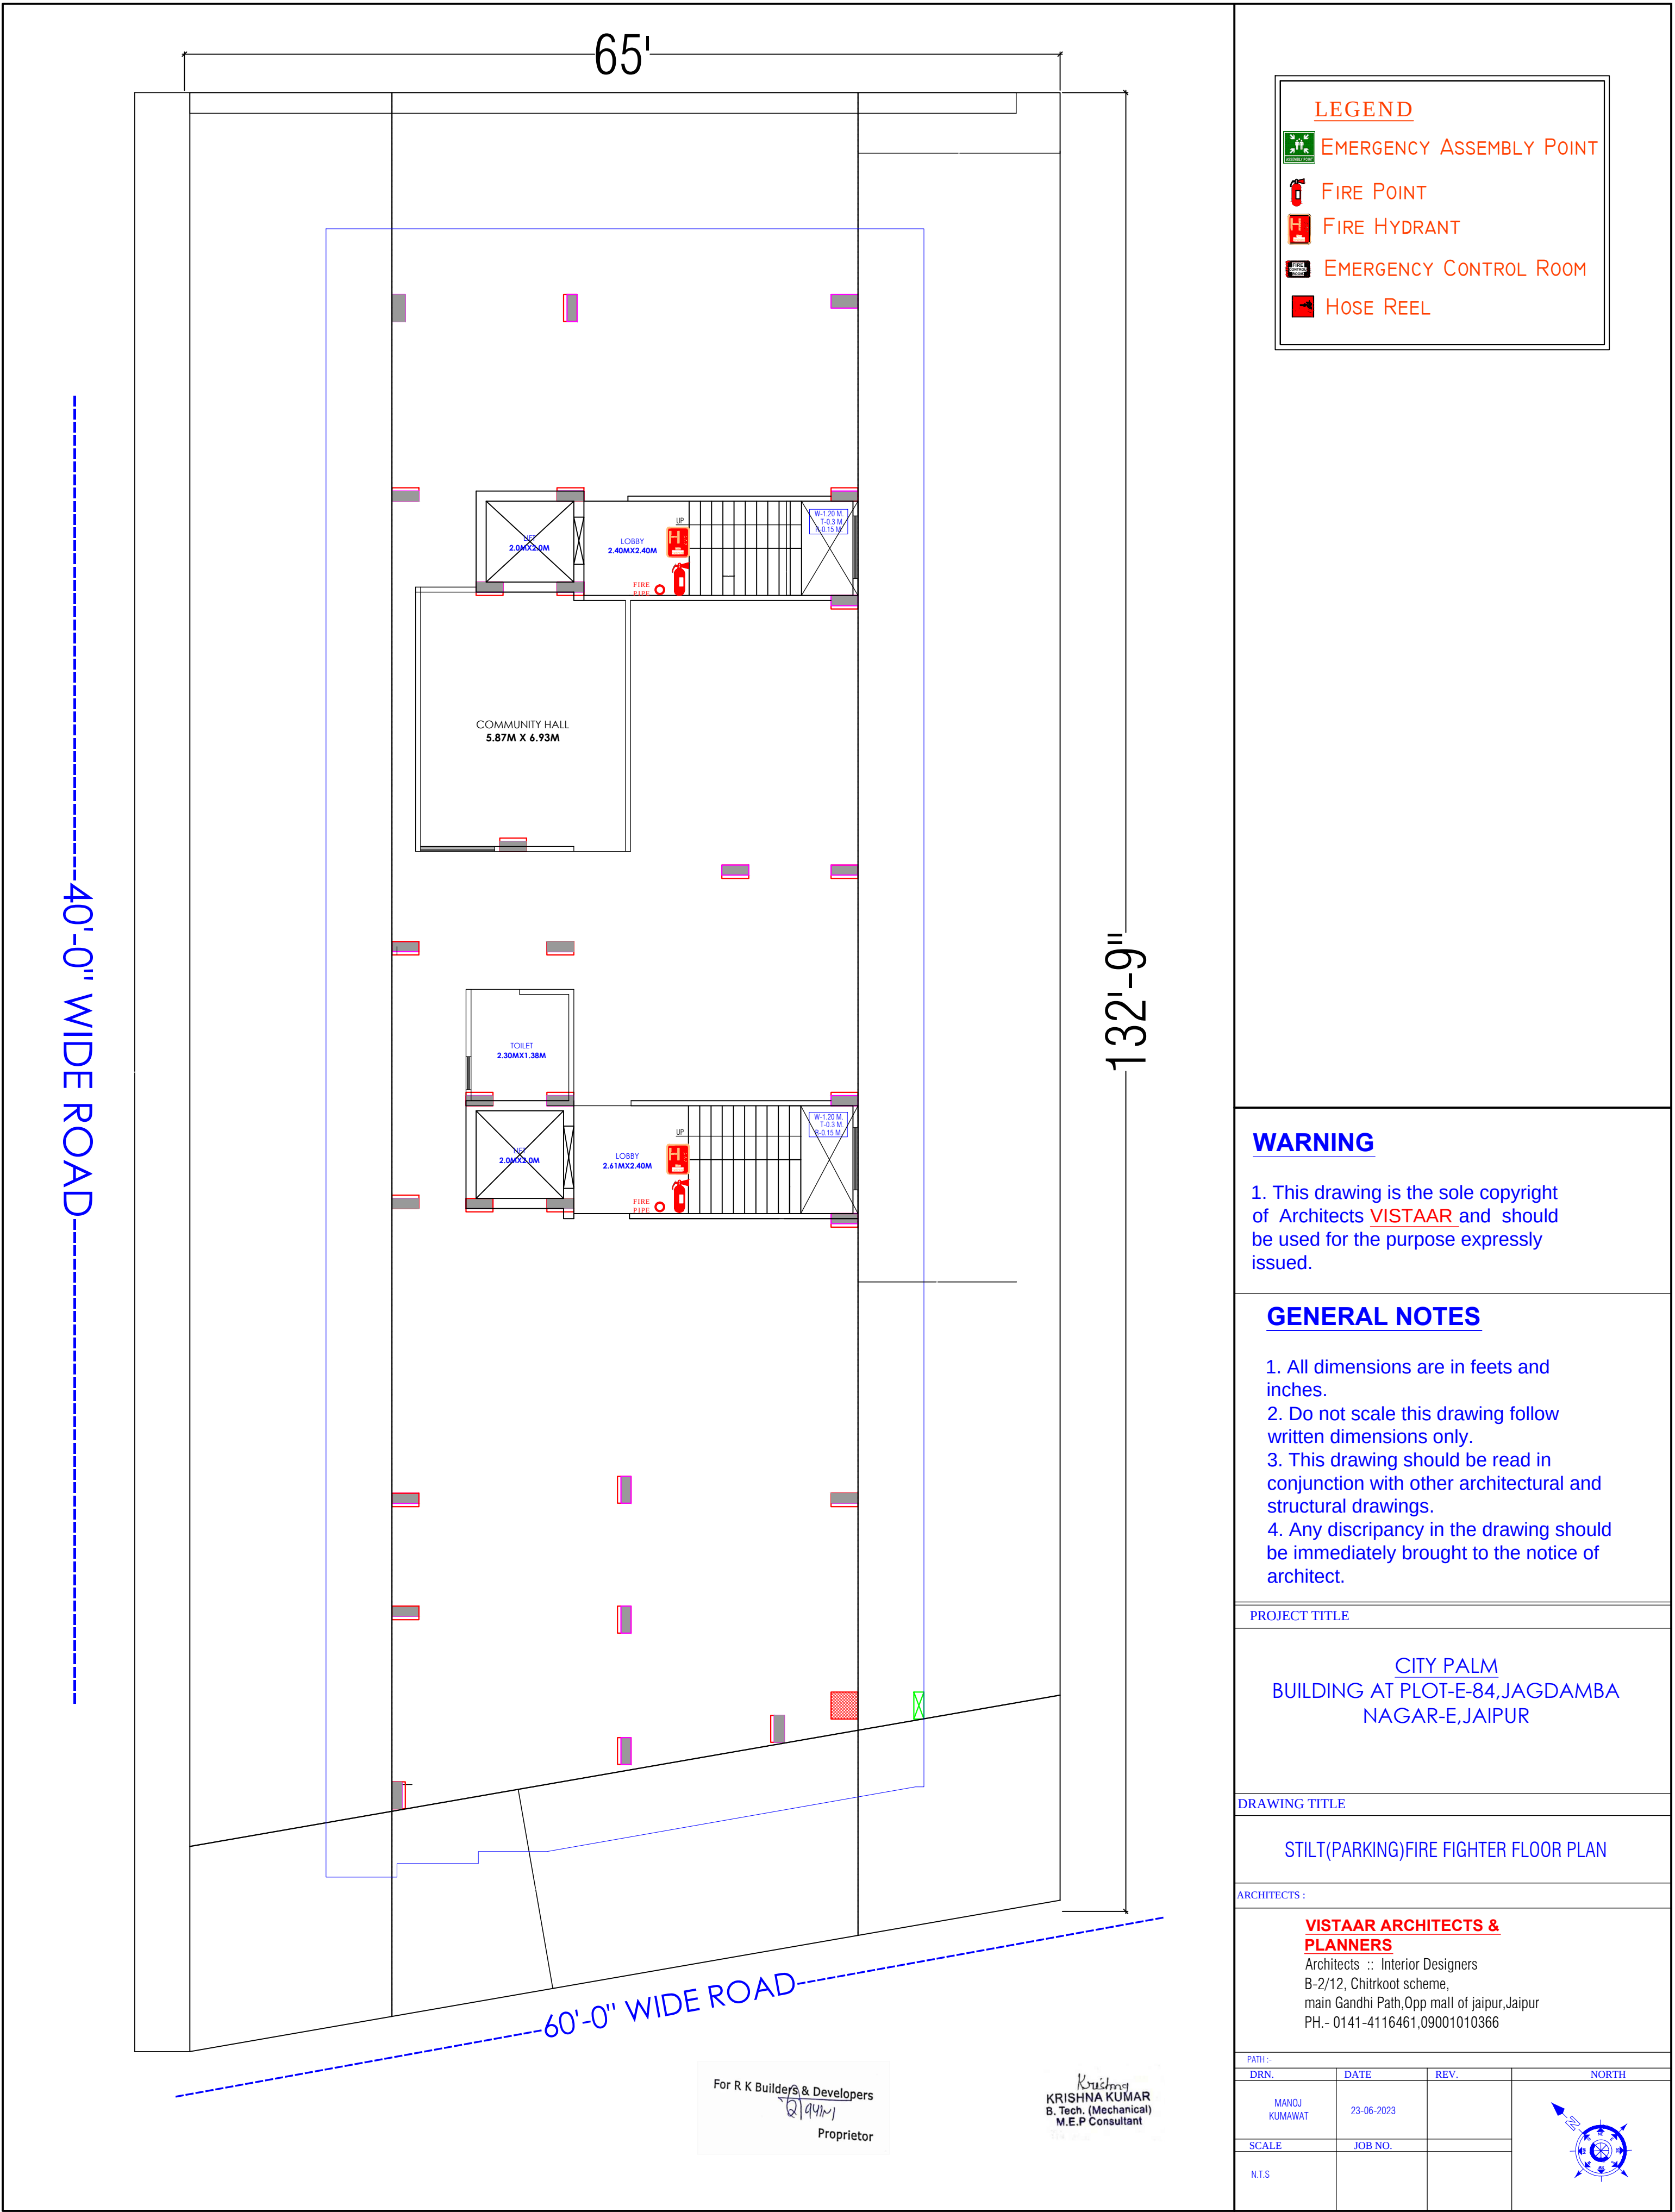

LEGEND

EMERGENCY ASSEMBLY POINT

FIRE POINT

FIRE HYDRANT

EMERGENCY CONTROL ROOM

HOSE REEL

**WARNING**

1. This drawing is the sole copyright of Architects **VISTAAR** and should be used for the purpose expressly issued.

- GENERAL NOTES**
1. All dimensions are in feet and inches.
  2. Do not scale this drawing follow written dimensions only.
  3. This drawing should be read in conjunction with other architectural and structural drawings.
  4. Any discrepancy in the drawing should be immediately brought to the notice of architect.

PROJECT TITLE

CITY PALM  
BUILDING AT PLOT-E-84,JAGDAMBA  
NAGAR-E,JAIPUR

DRAWING TITLE

STILT(PARKING)FIRE FIGHTER FLOOR PLAN


ARCHITECTS :

**VISTAAR ARCHITECTS & PLANNERS**  
Architects :: Interior Designers  
B-2/12, Chitrkoot scheme,  
main Gandhi Path,Opp mall of jaipur,Jaipur  
PH. - 0141-4116461,09001010366

| PATH :-       |            |      |       |
|---------------|------------|------|-------|
| DRN.          | DATE       | REV. | NORTH |
| MANOJ KUMAWAT | 23-06-2023 |      |       |
| SCALE         | JOB NO.    |      |       |
| N.T.S         |            |      |       |

For R K Builders & Developers  
21/9/23  
Proprietor

Krishna  
KRISHNA KUMAR  
B. Tech. (Mechanical)  
M.E.P Consultant

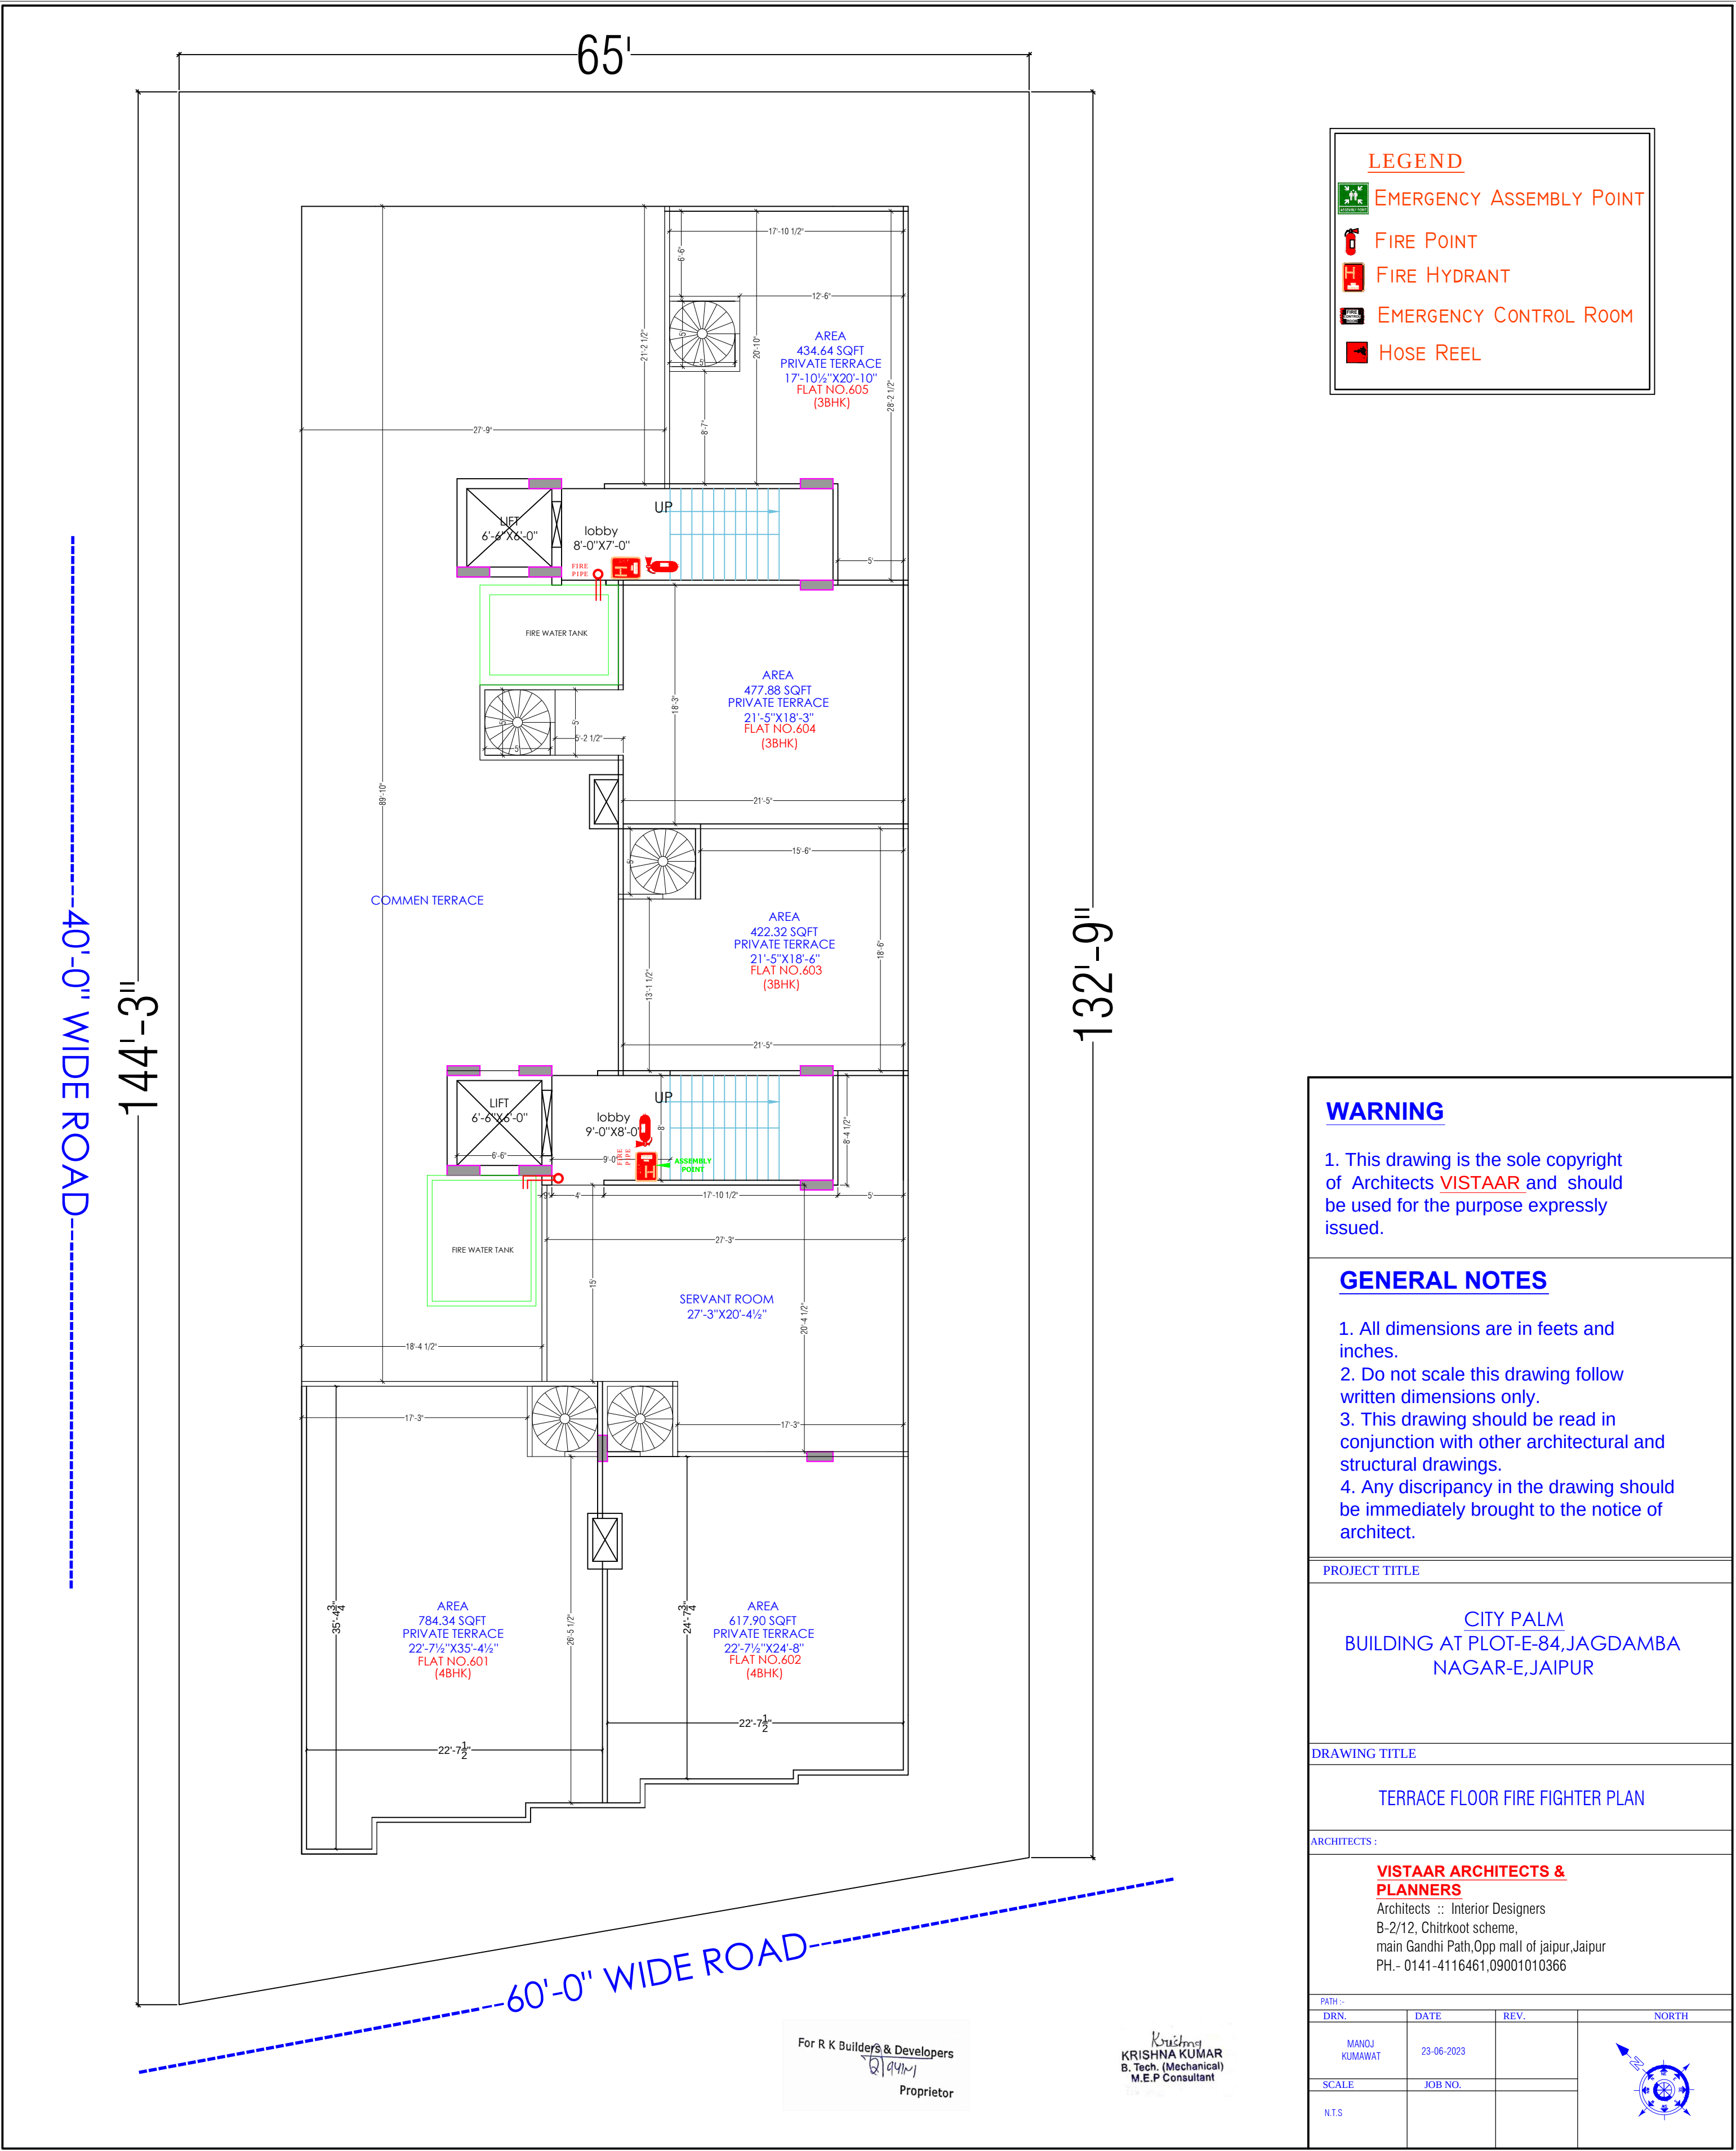

LEGEND

EMERGENCY ASSEMBLY POINT

FIRE POINT

FIRE HYDRANT

EMERGENCY CONTROL ROOM

HOSE REEL

WARNING

1. This drawing is the sole copyright of Architects **VISTAAR** and should be used for the purpose expressly issued.

GENERAL NOTES

1. All dimensions are in feet and inches.  
2. Do not scale this drawing follow written dimensions only.  
3. This drawing should be read in conjunction with other architectural and structural drawings.  
4. Any discrepancy in the drawing should be immediately brought to the notice of architect.

PROJECT TITLE

CITY PALM  
BUILDING AT PLOT-E-84,JAGDAMBA  
NAGAR-E,JAIPUR

DRAWING TITLE

TERRACE FLOOR FIRE FIGHTER PLAN

ARCHITECTS :

VISTAAR ARCHITECTS & PLANNERS  
Architects :: Interior Designers  
B-2/12, Chitrkoot scheme,  
main Gandhi Path,Opp mall of jaipur,Jaipur  
PH.- 0141-4116461,09001010366

PATH ::

DRN.

MANOJ KUMAWAT

SCALE

N.T.S

DATE

23-06-2023

JOB NO.

REV.

NORTH