



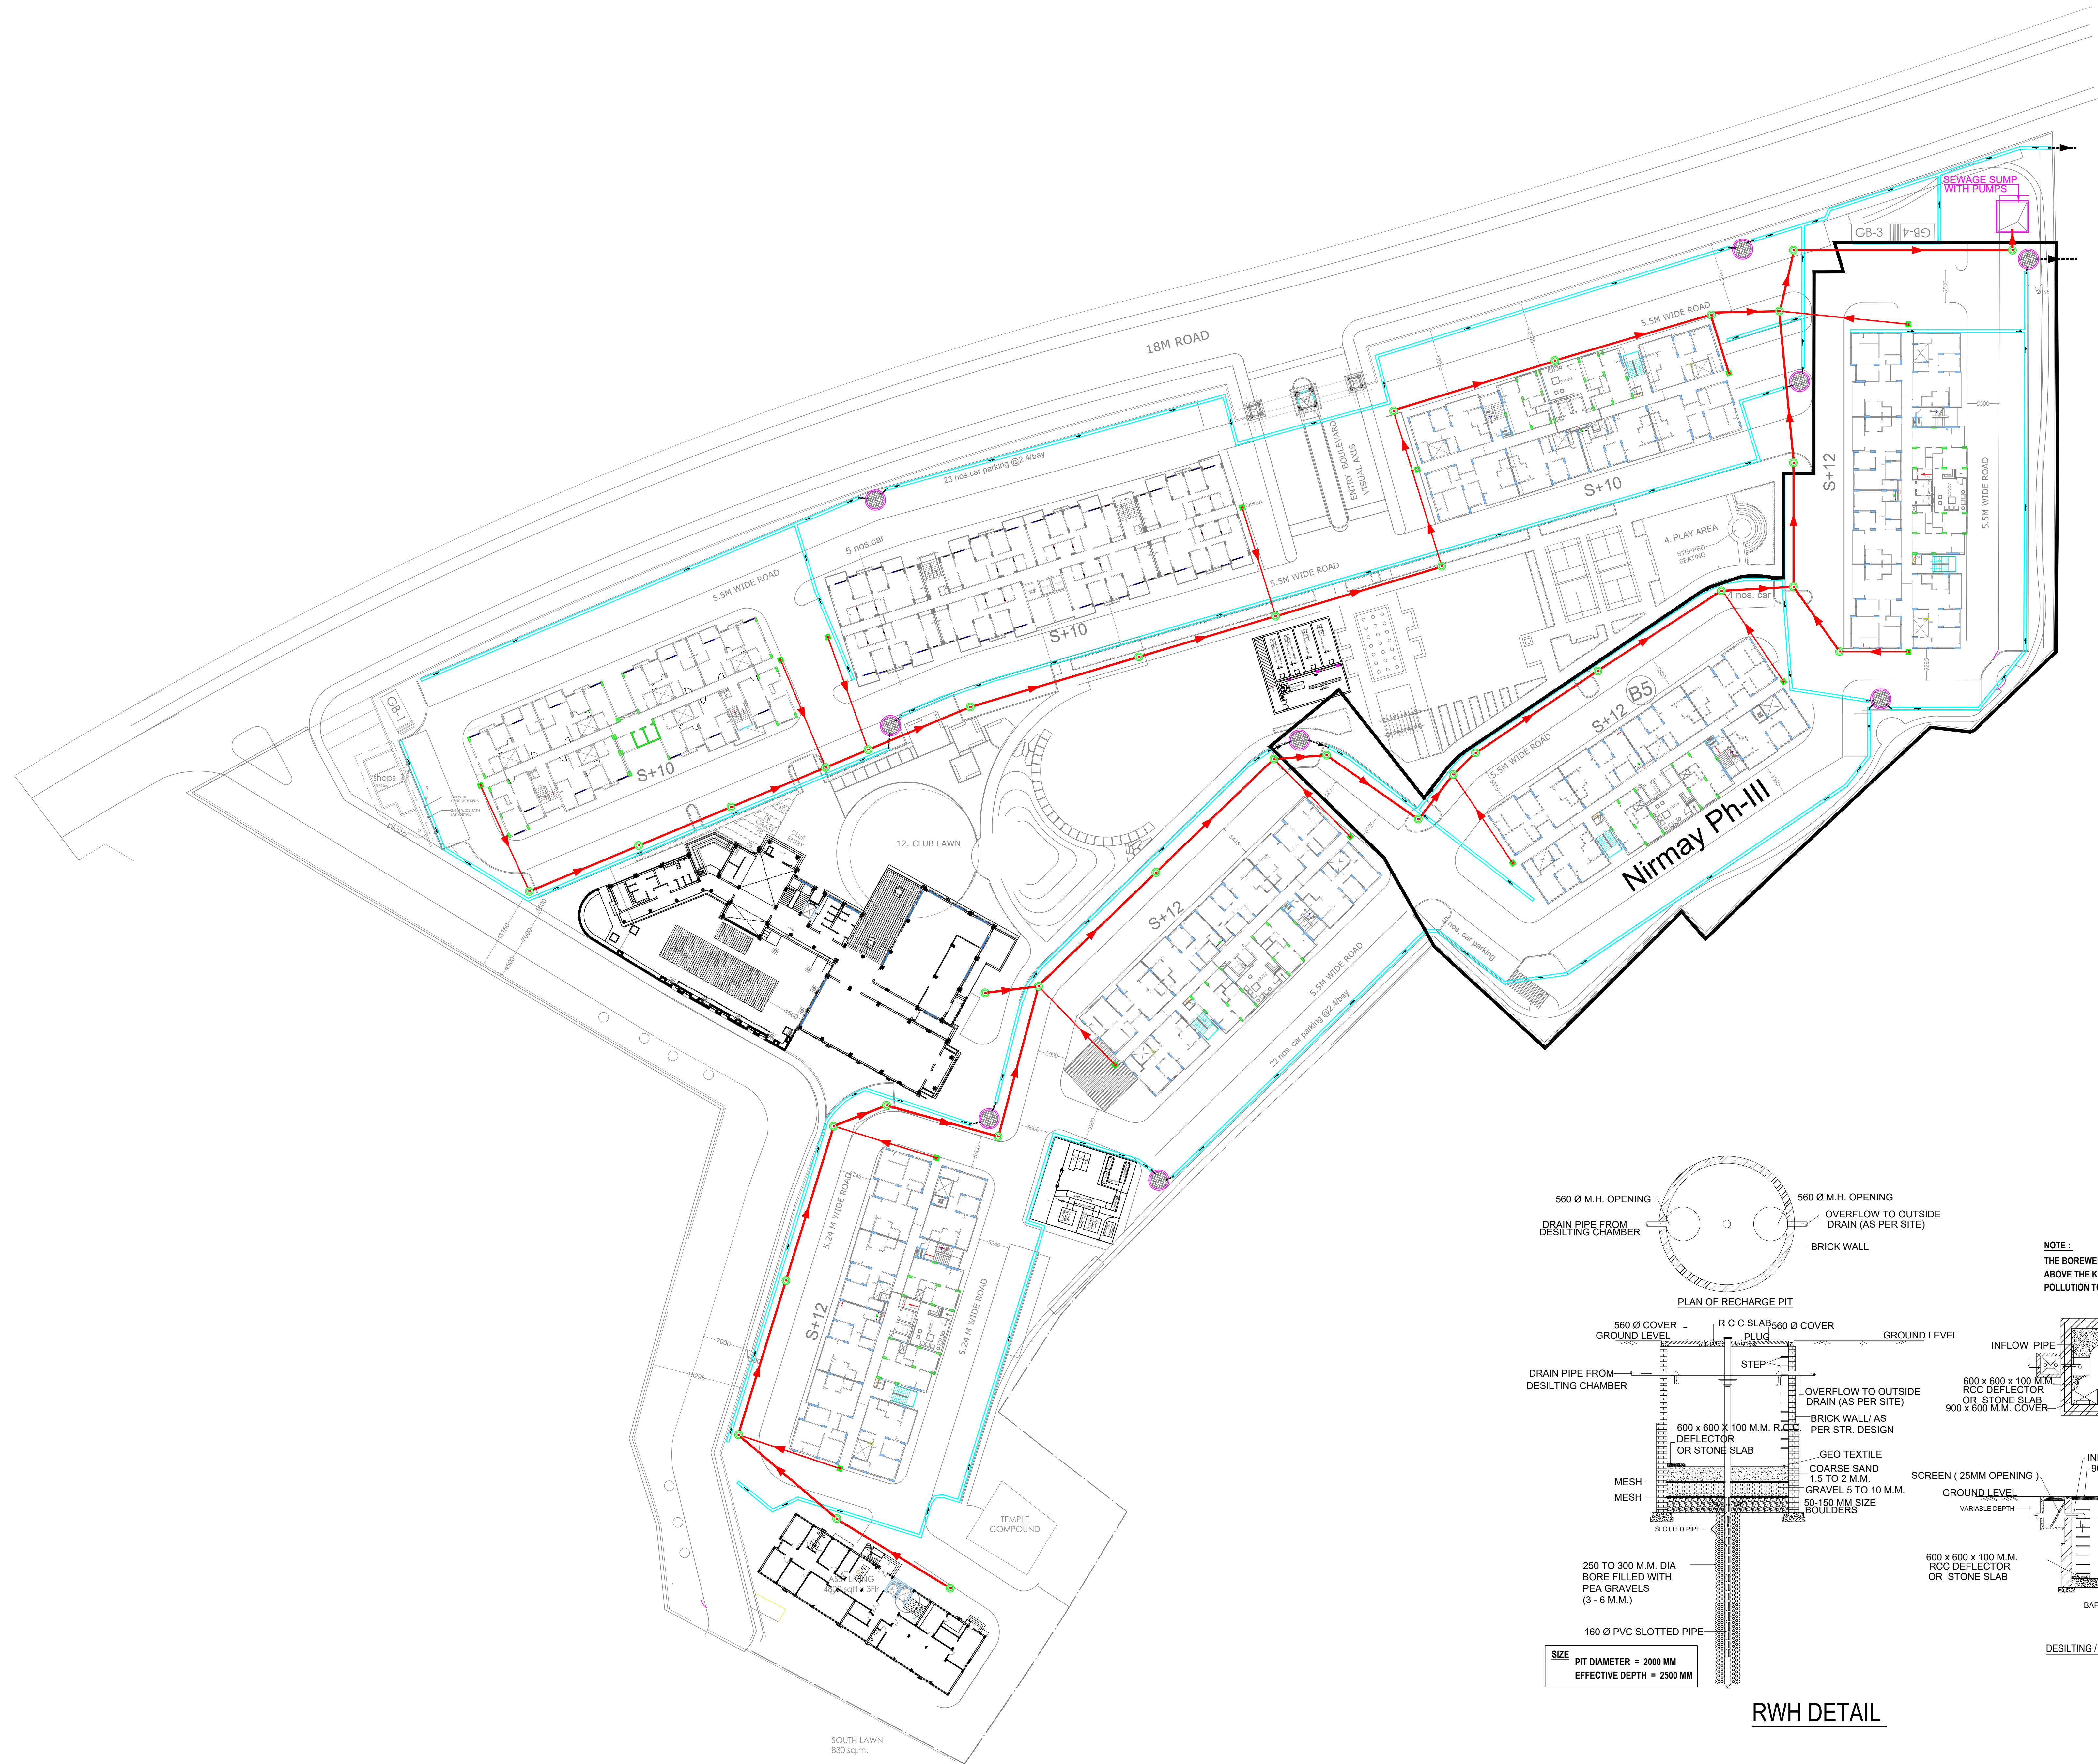

- LEGEND
- RAIN WATER HARVESTING
 - MEN HOLE
 - DRAIN LINE
 - SEWER LINE

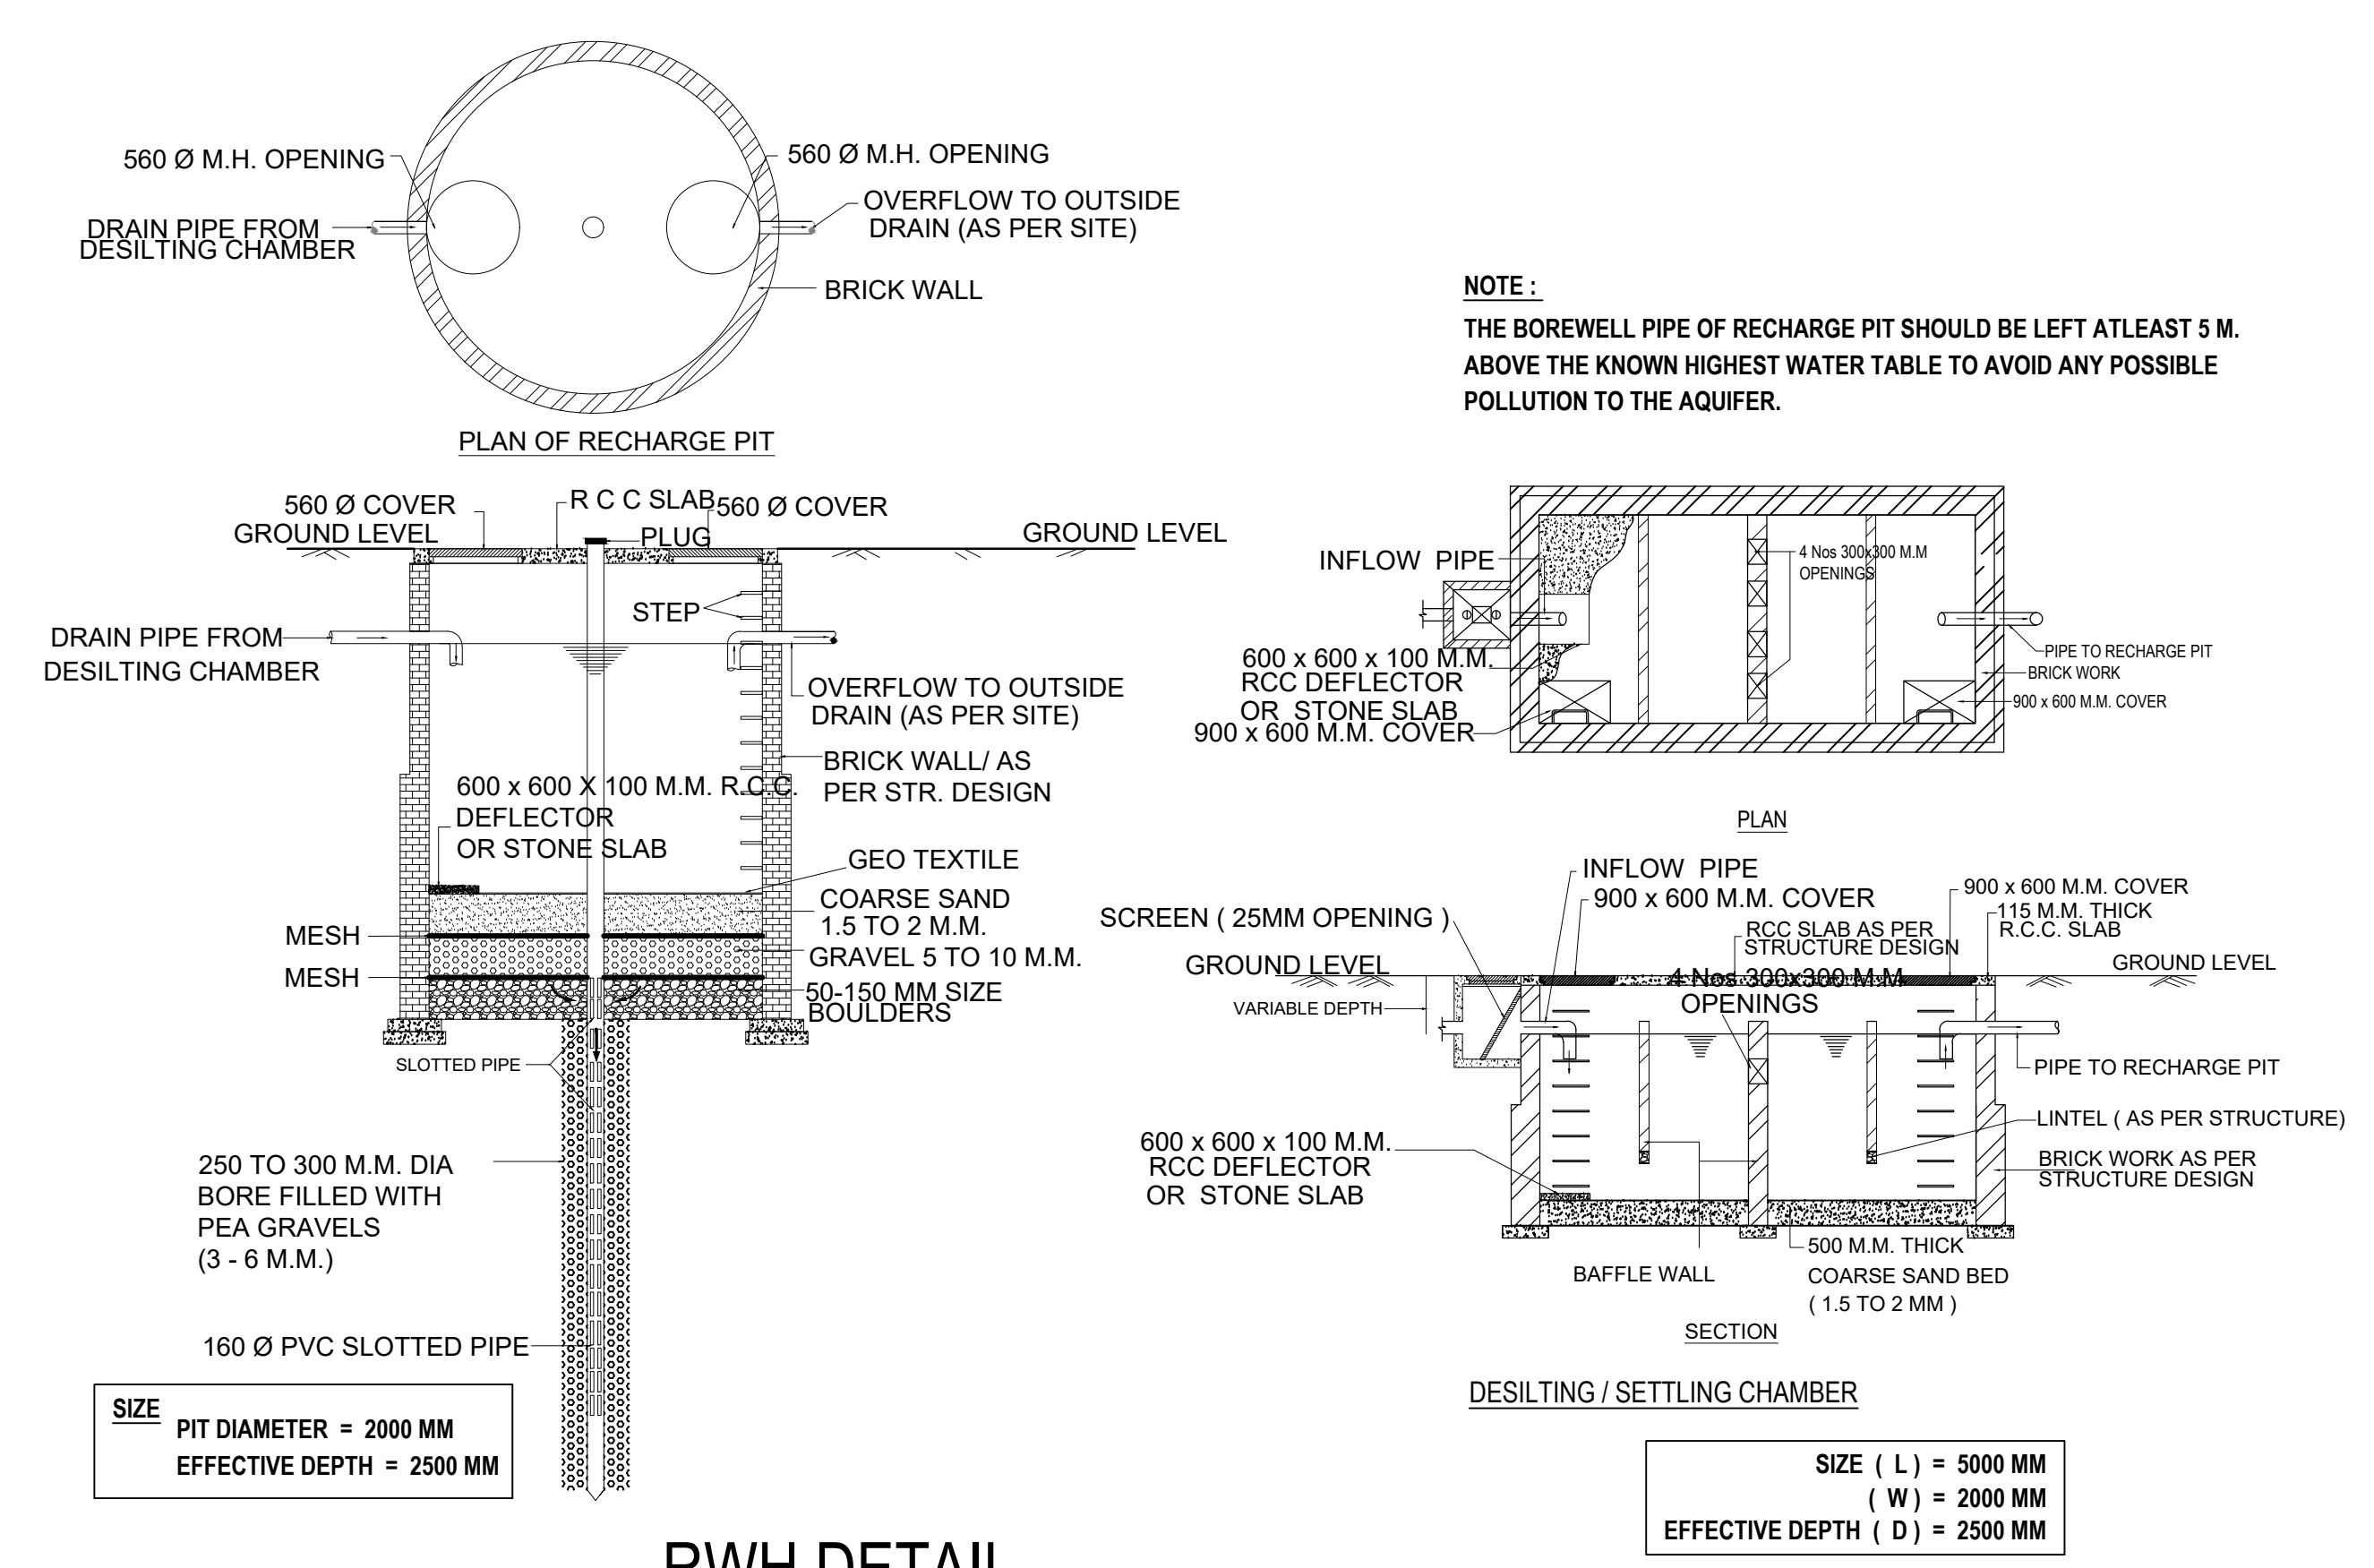

RWH DETAIL

FOR SUBMISSION
ABL Hospitech Pvt. Ltd.
New Delhi

CLIENT
ASHIANA HOUSING LTD.


PROJECT
Ashiana Nirmay

Drawing Title
RAIN WATER HARVESTING



LEGEND :-

	INTERNAL HYDRANT WITH HOSE REEL
	YARD HYDRANT
	SLUICE VALVE
	NON RETURN VALVE
	FIRE BRIGADE CONNECTION (INLET)
	FIRE BRIGADE DRAW-OUT CONNECTION
	MAIN PIPE
	HOSE REEL

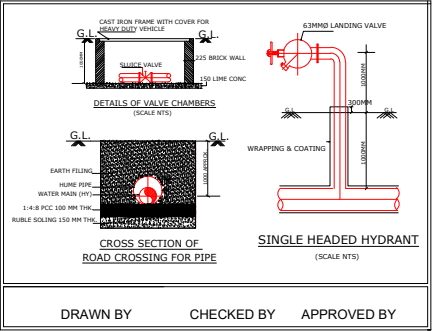


FOR SUBMISSION
Ashiana
ABL Hospitech Pvt. Ltd.
New Delhi.


CLIENT
ASHIANA HOUSING LTD.

PROJECT
Ashiana Nirmay

Drawing Title
SITE PLAN
FIRE FIGHTING LAYOUT

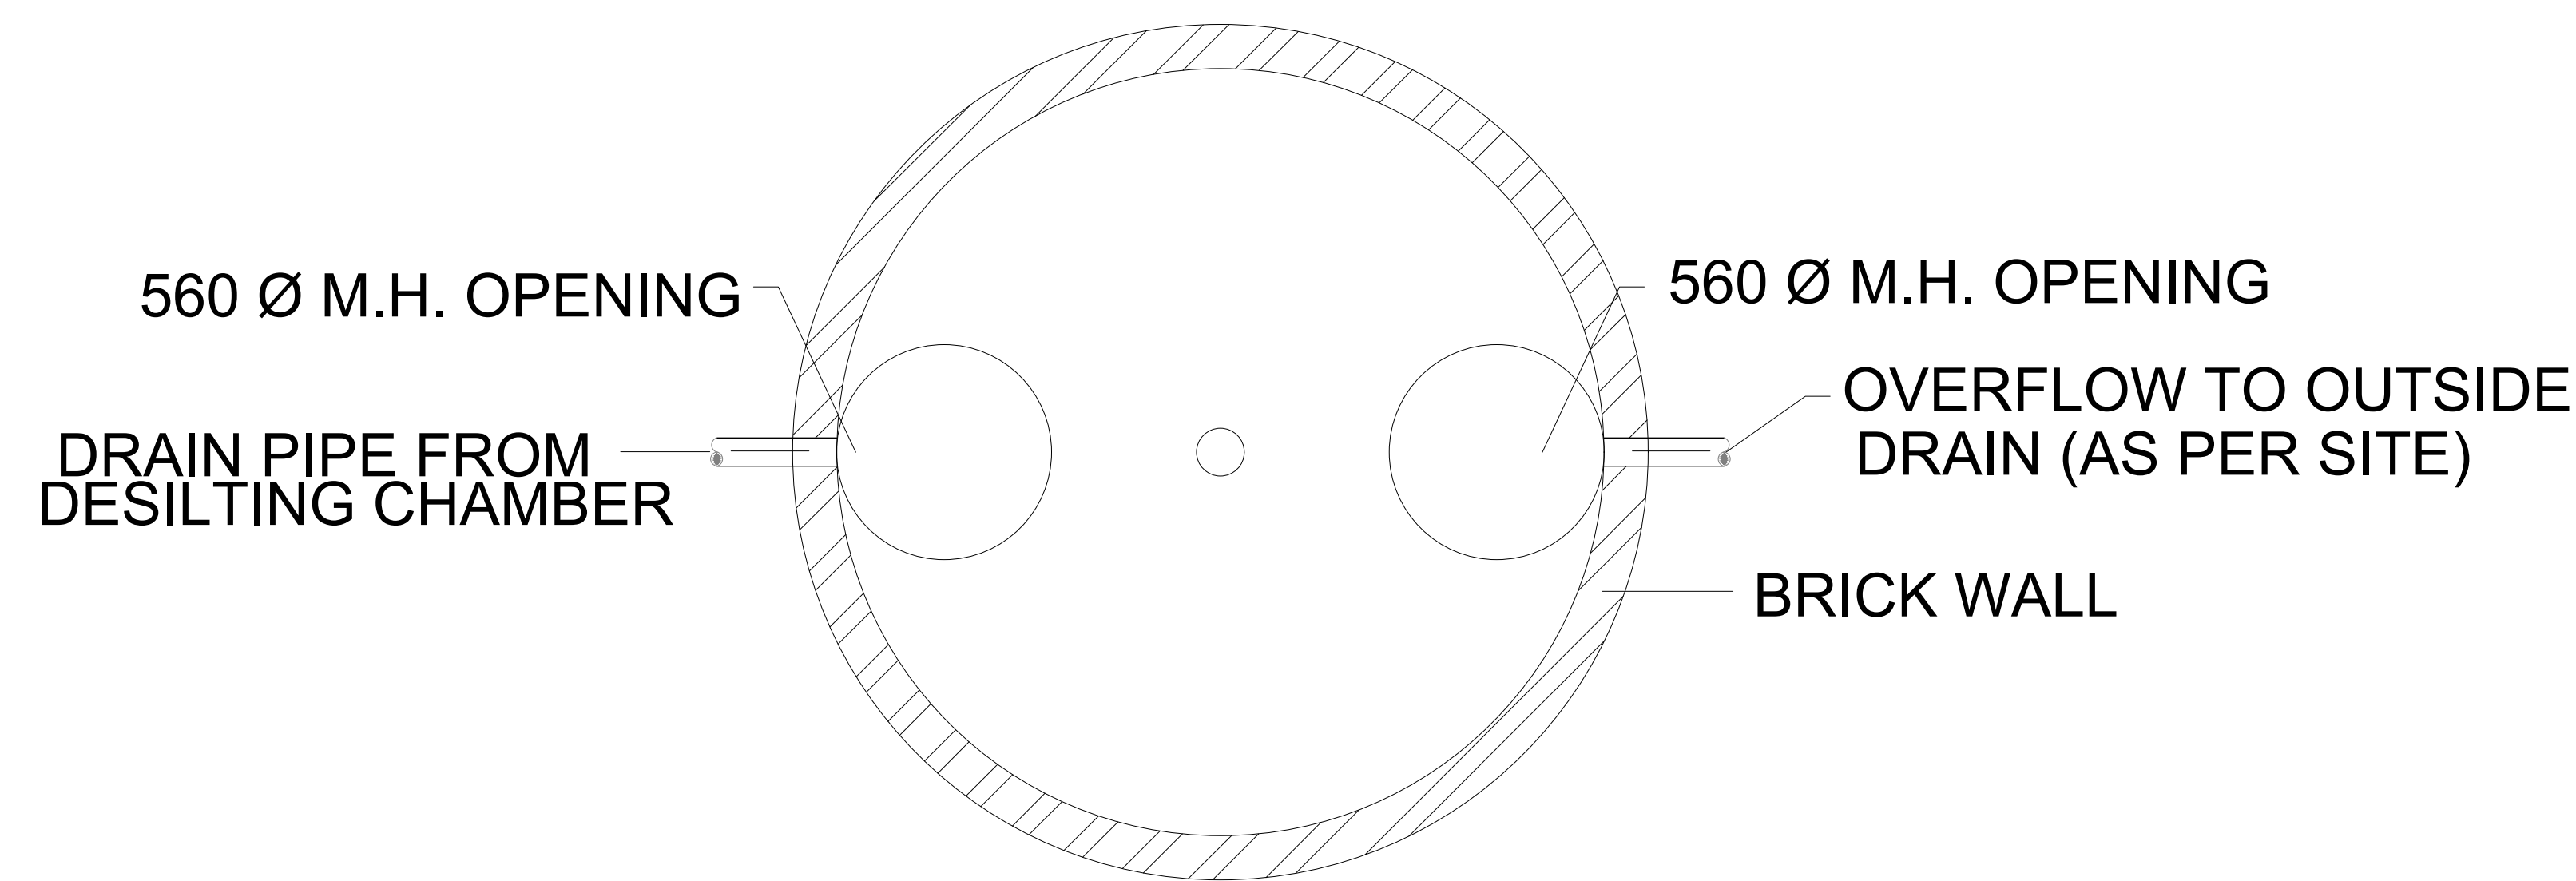


PLAN OF RECHARGE PIT

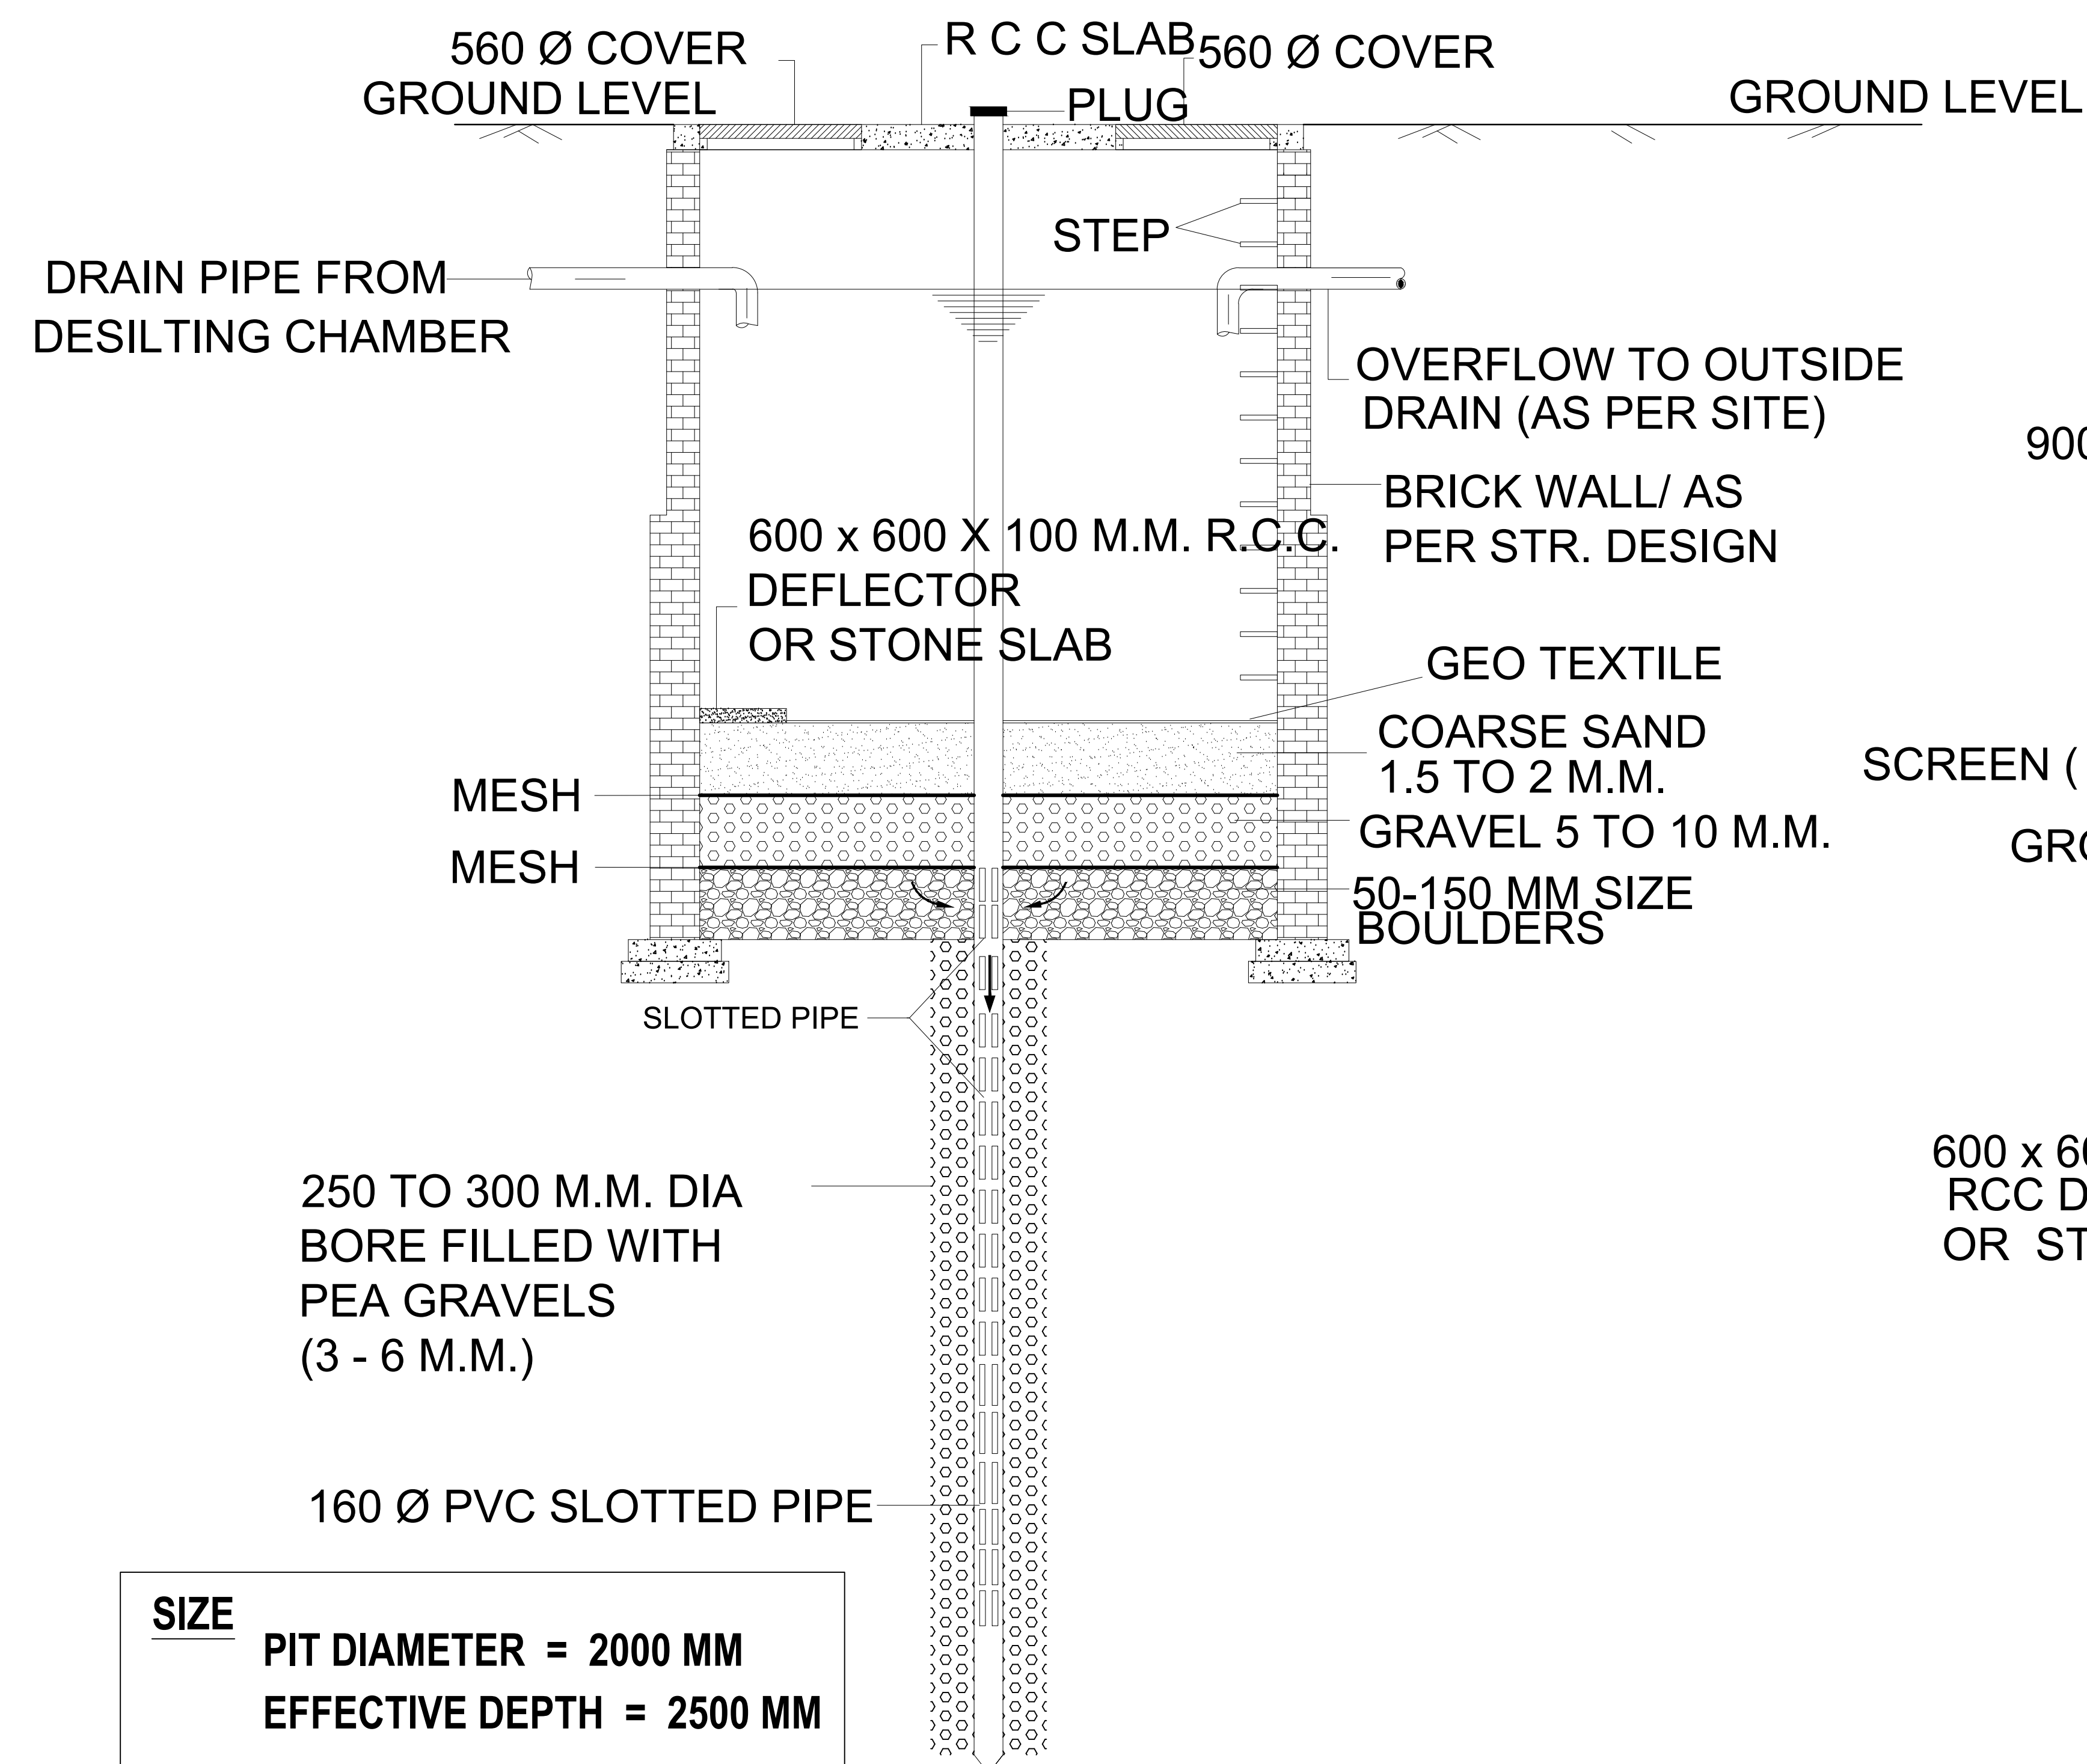


RWH DETAIL

NOTE :

THE BOREWELL PIPE OF RECHARGE PIT SHOULD BE LEFT ATLEAST 5 M. ABOVE THE KNOWN HIGHEST WATER TABLE TO AVOID ANY POSSIBLE POLLUTION TO THE AQUIFER.

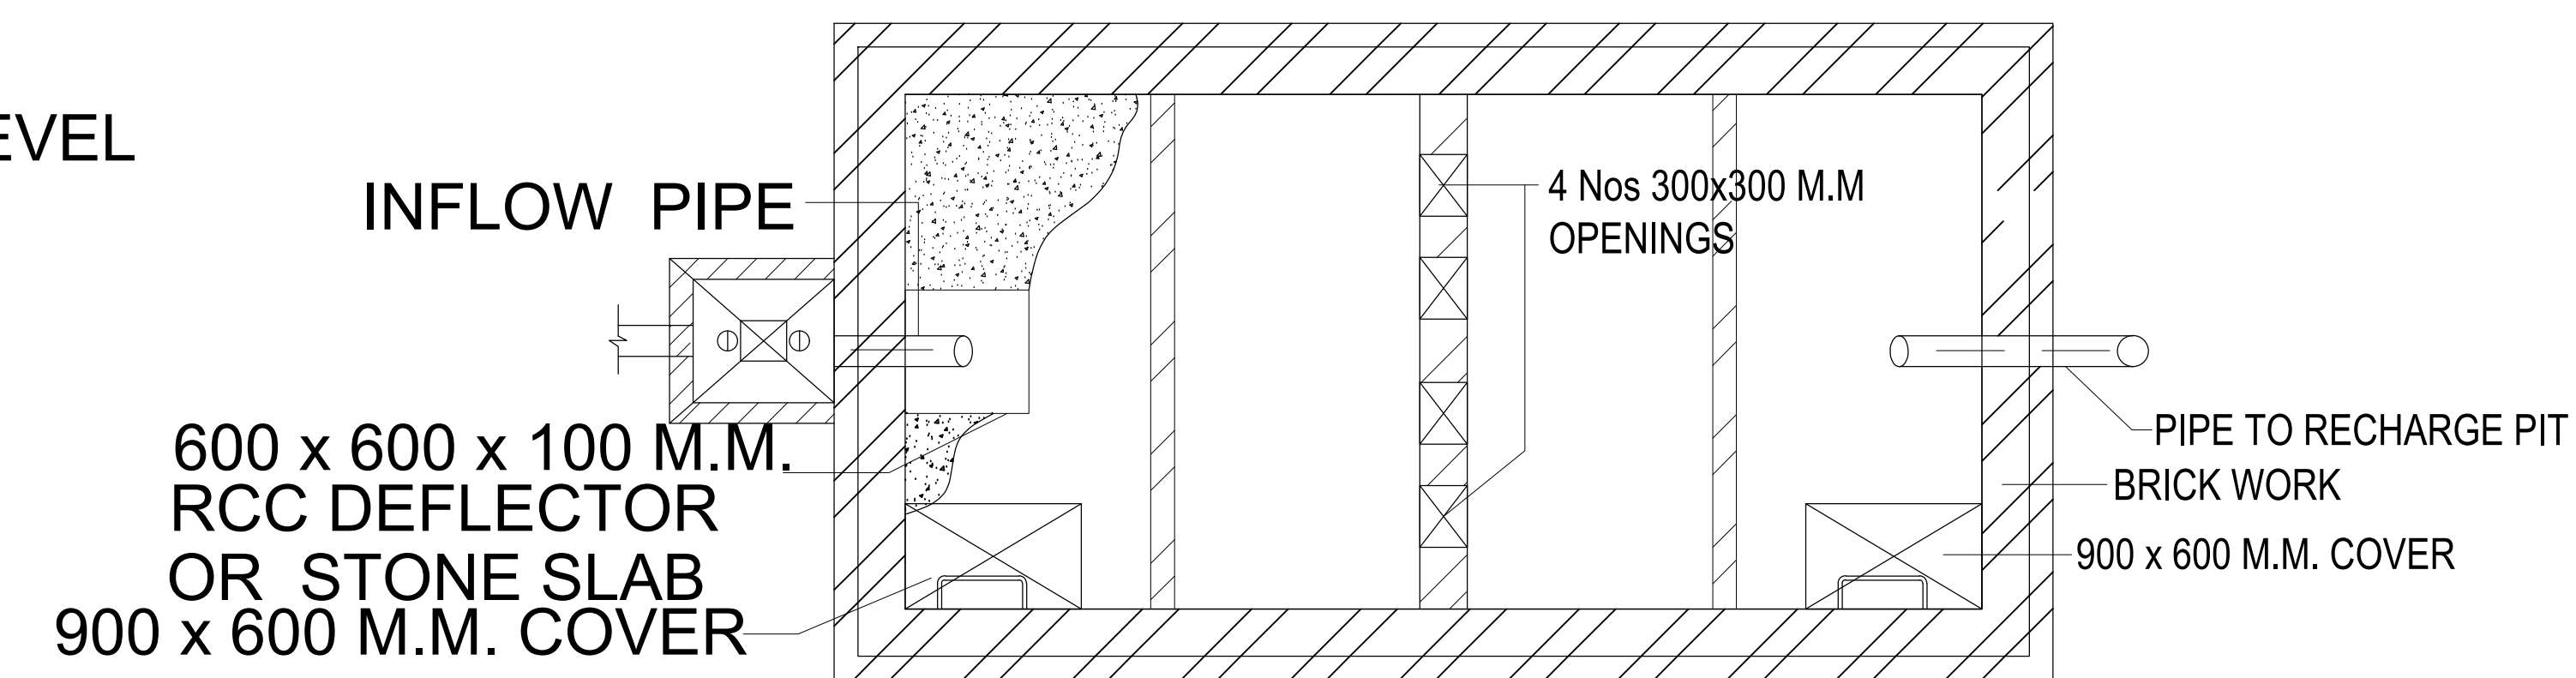

PLAN

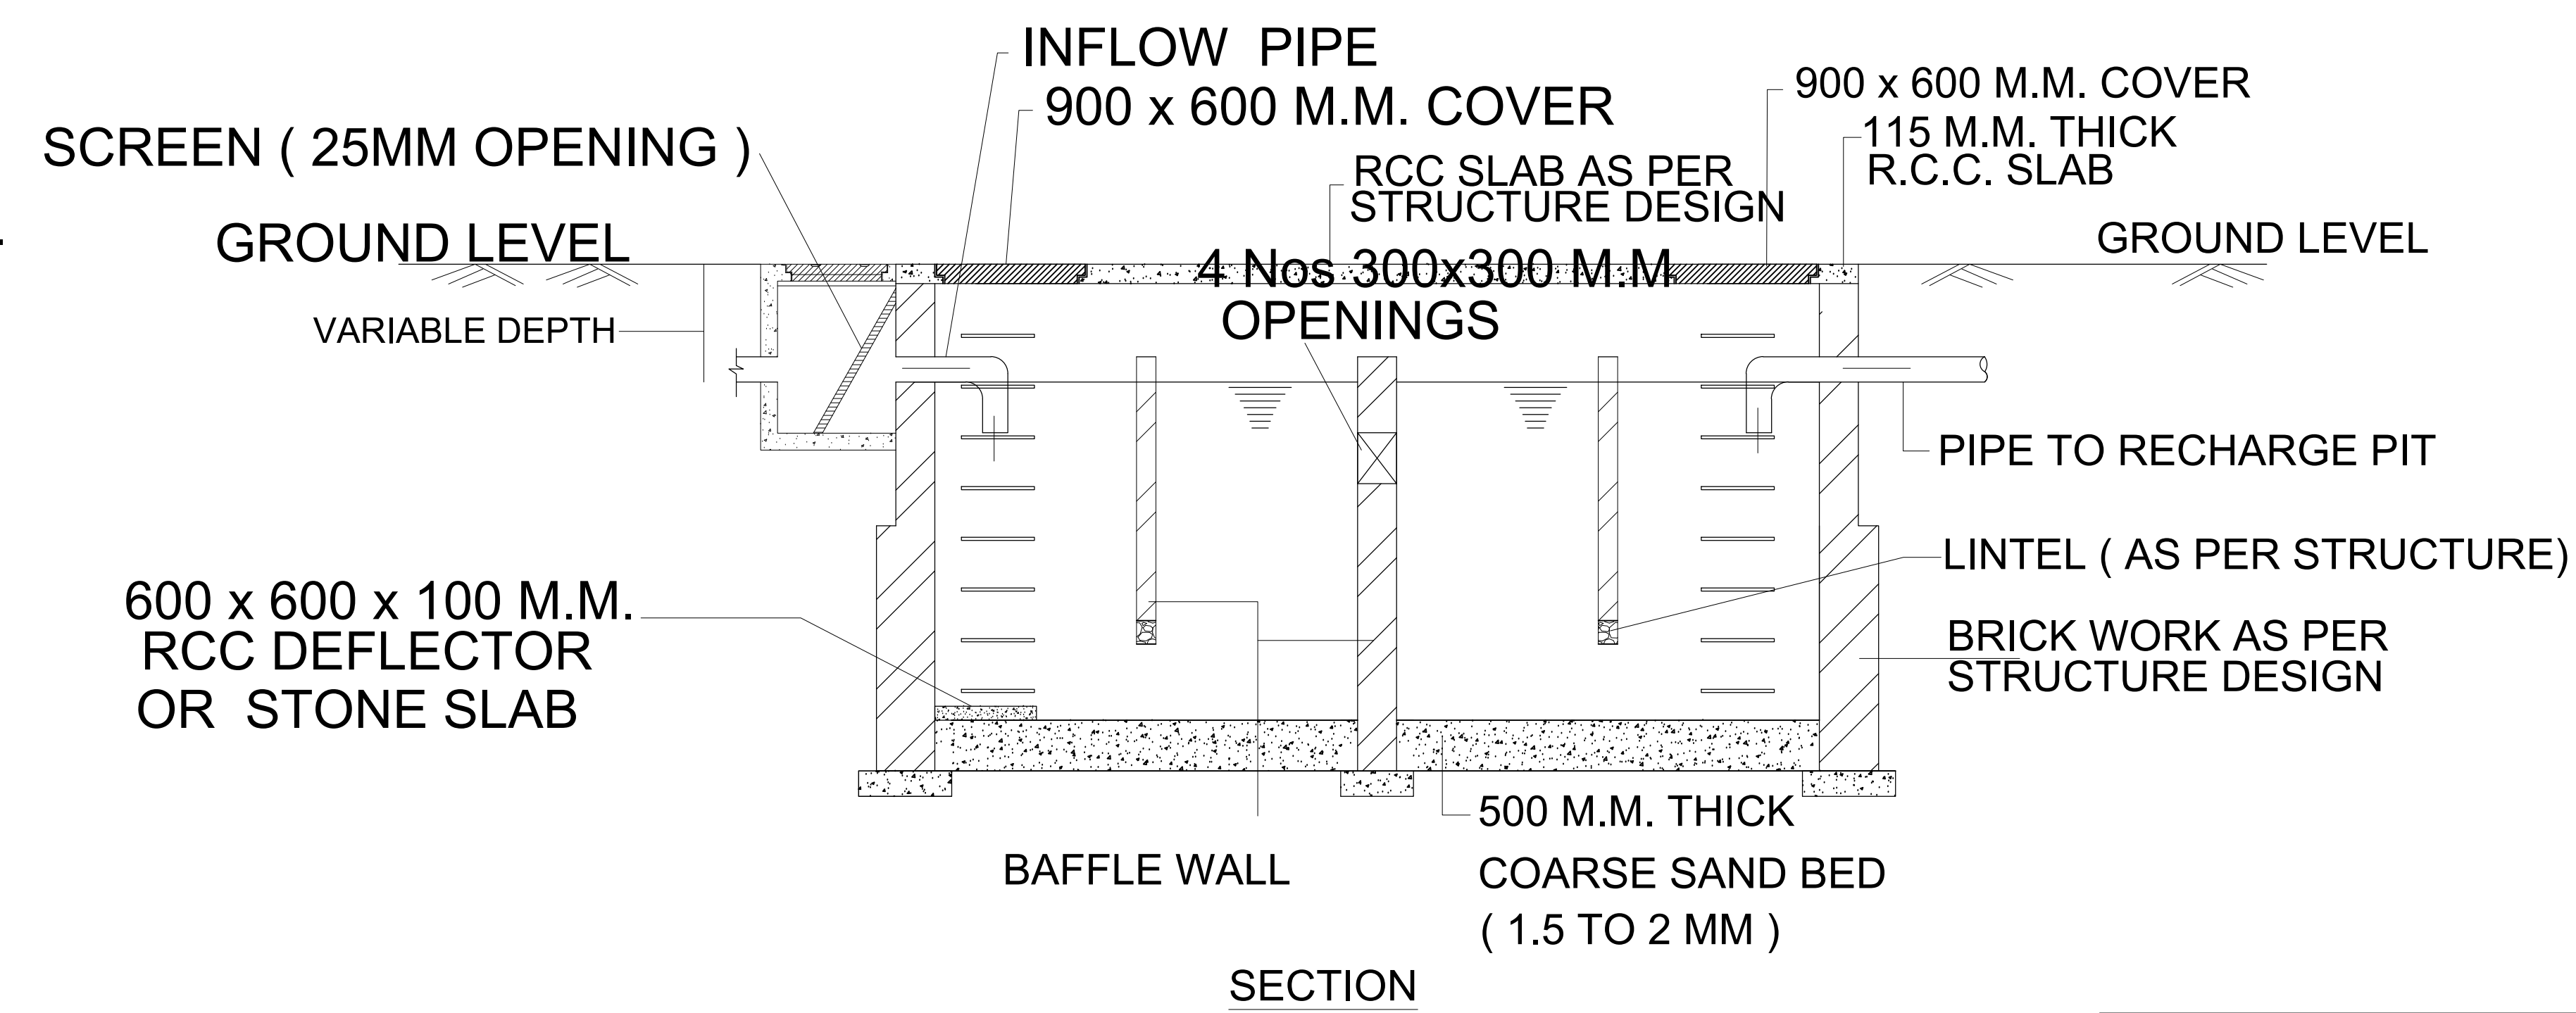

SECTION

DESILTING / SETTLING CHAMBER

SIZE (L) = 5000 MM

(W) = 2000 MM

EFFECTIVE DEPTH (D) = 2500 MM

FOR SUBMISSION

Singh

ABL Hospitech Pvt. Ltd.

New Delhi

PROJECT :

Ashiana Nirmay

OWNERS NAME

Ashiana Housing Ltd.

Unit no.4 & 5, Plot No.D-2, 3rd Floor,
Southern park, Saket District Centre,
Saket New Delhi - 110017
Phone no. 011- 42 65 42 65

ARCHITECT

B.sengupta architect

A305, RANGOLI, ASHIANA VILLAGE BHIWADI.

PH . 09887488263

MEP Consultants

ABL HOSPITECH (P) LTD

F-55 East of Kallash New Delhi-110065-India
Ph.: 91-11-41625566, 46524180, 81, 83, 84
Fax : 91-11-46524182
email : abldel@rediffmail.com, abldel@yahoo.co.in

DRG. TITLE:

RAIN WATER HARVESTING PIT



LEGEND

-  MAN HOLE
-  SEWER LINE

FOR SUBMISSION
ABL Hospitech Pvt. Ltd.
New Delhi

CLIENT
ASHIANA HOUSING LTD.

PROJECT
Ashiana Nirmay

Drawing Title
SITE PLAN
SEWERAGE LAYOUT

