


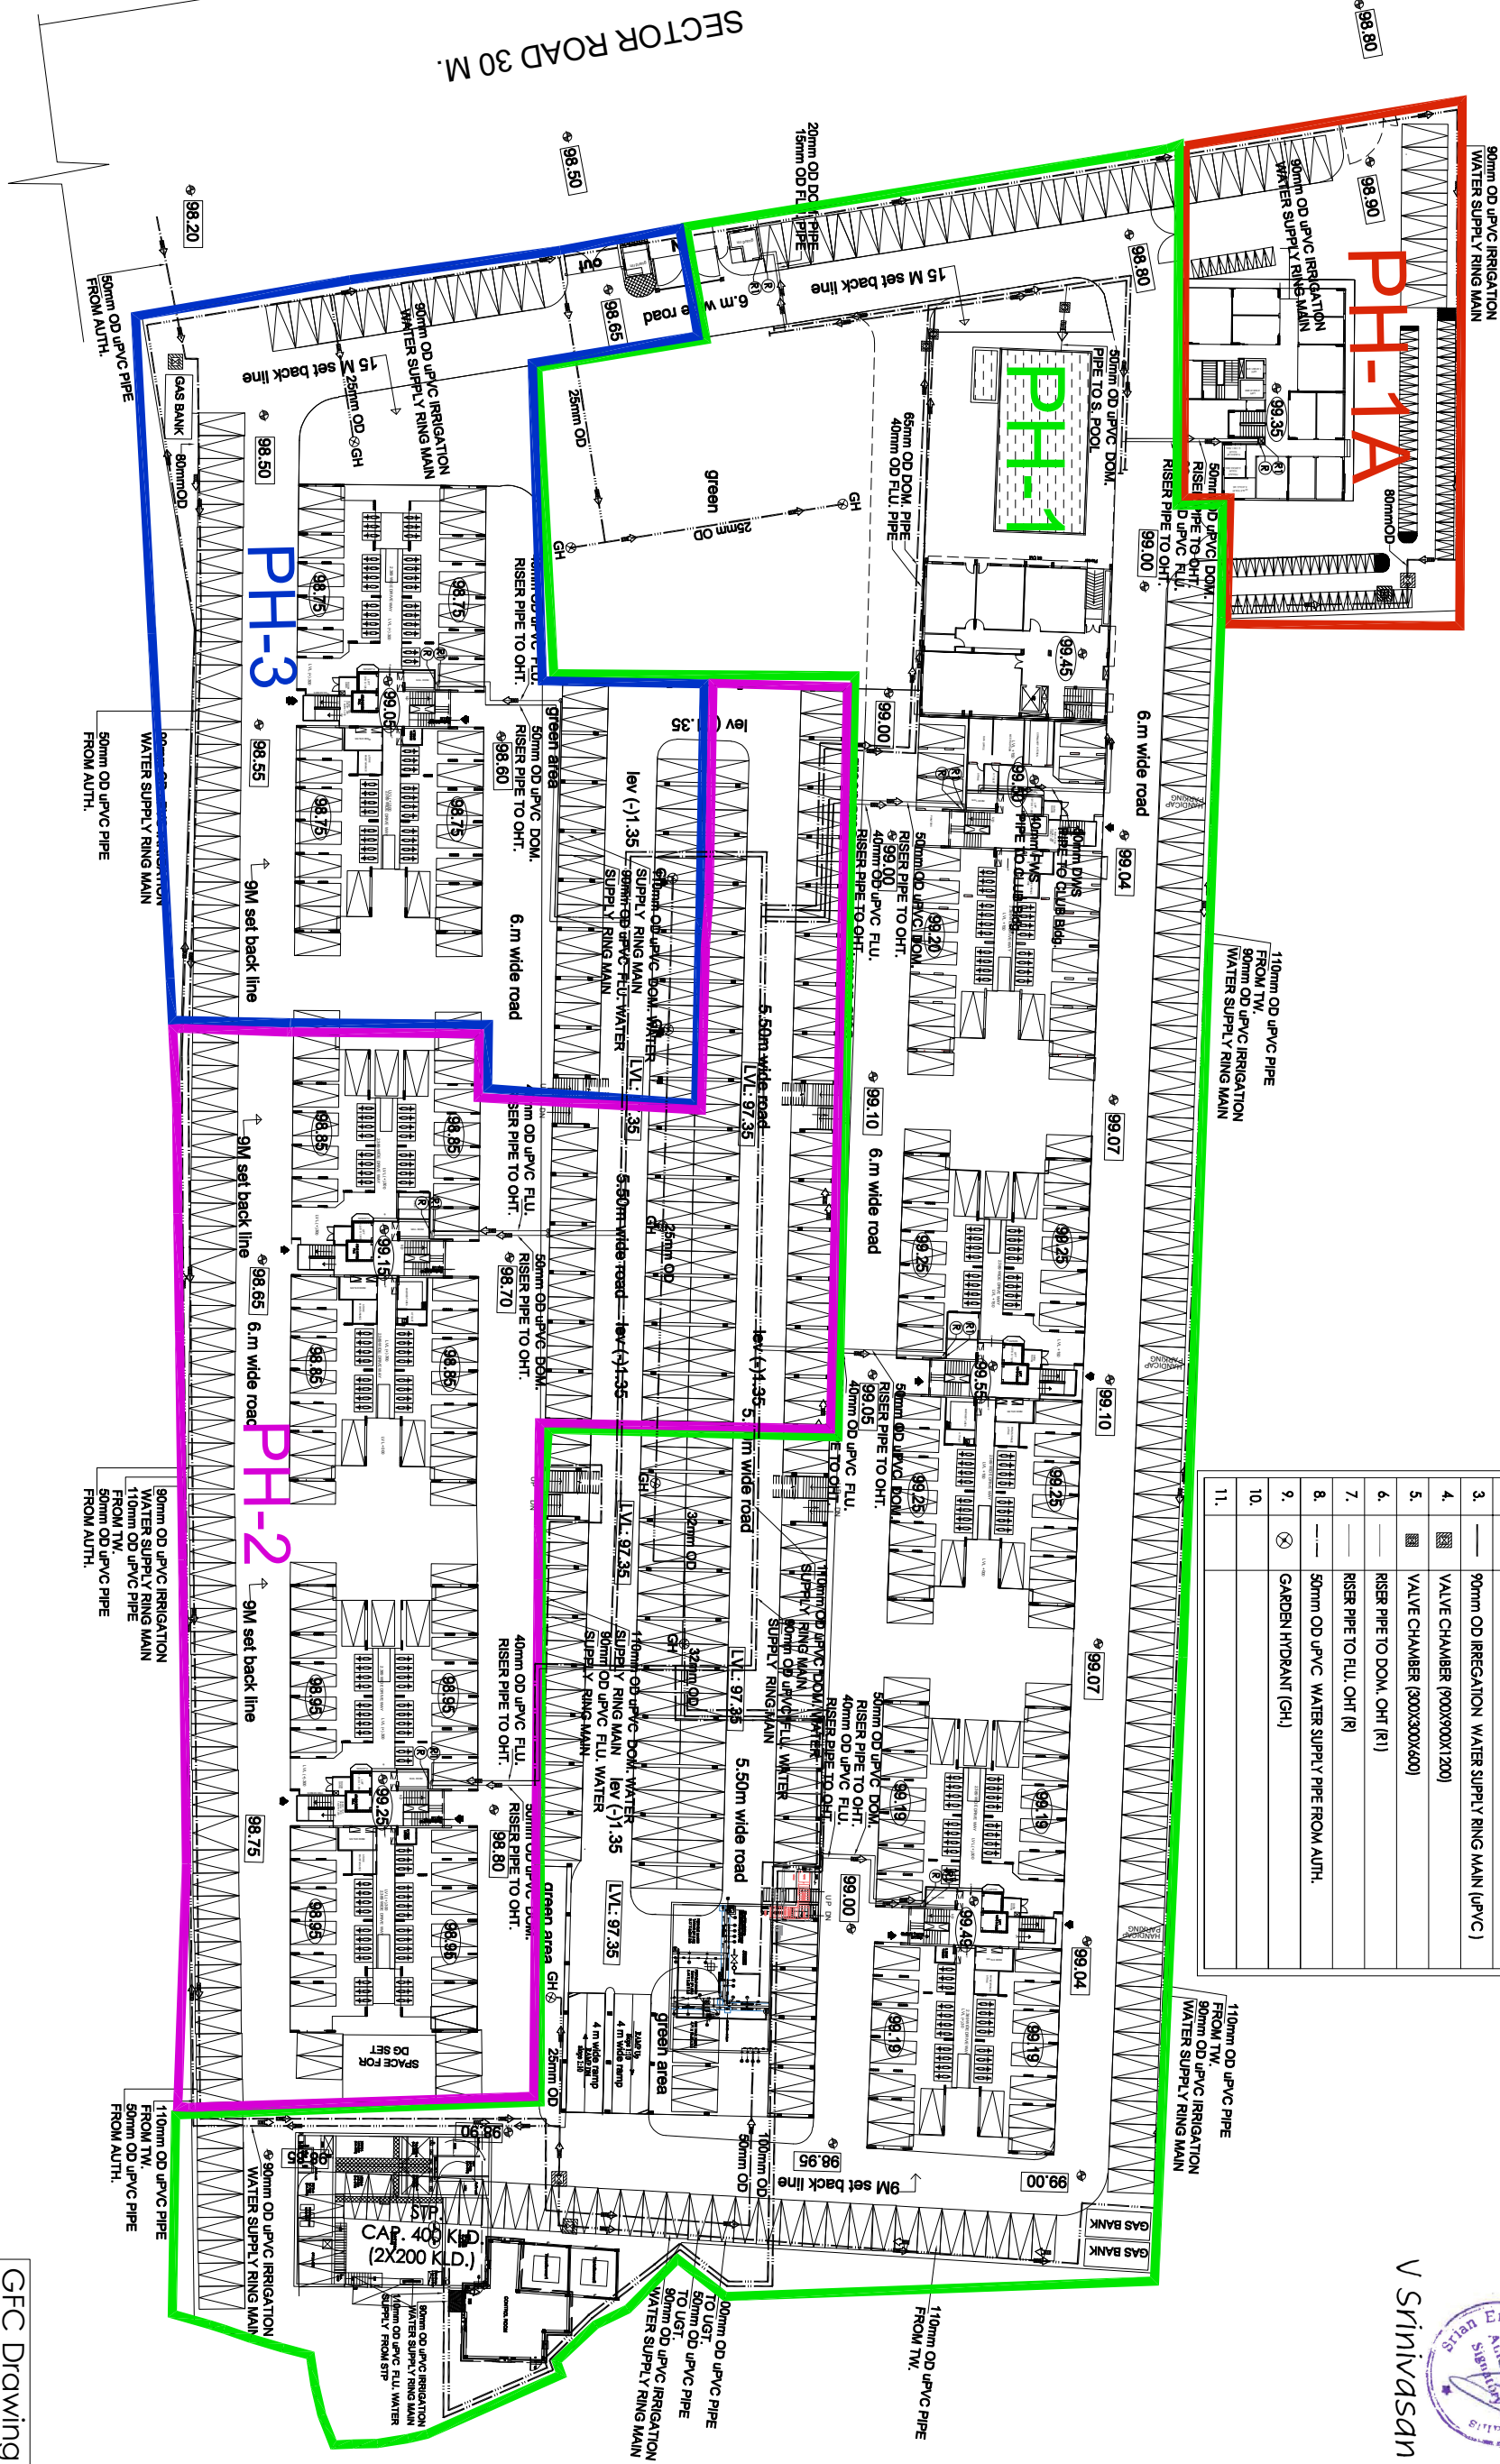

V Srinivasan

LEGEND FOR WATER SUPPLY	
S.NO.SYMBOL	DESCRIPTION
1. —	110mm OD DOM. WATER SUPPLY RING MAIN (UPVC /CPVC)
2. —	90mm OD FLUSHING WATER SUPPLY RING MAIN (UPVC/CPVC)
3. —	90mm OD IREGATION WATER SUPPLY RING MAIN (UPVC)
4. [Symbol]	VALVE CHAMBER (900X900X1200)
5. [Symbol]	VALVE CHAMBER (300X300X600)
6. —	RISER PIPE TO DOM. OHT (R)
7. —	RISER PIPE TO FLU. OHT (R)
8. —	50mm OD UPVC WATER SUPPLY PIPE FROM AUTH.
9. [Symbol]	GARDEN HYDRANT (GH.)
10. —	
11. —	



GFC Drawing

PROJECT :

ASHIANA DAKSH

OWNERS NAME

Ashiana Housing Ltd.

304, Southern park, saket District Centre,
Saket New Delhi - 110017
Phone no. 011- 42 65 42 65

Services consultants:-

SRIAN ENGINEERING CONSULTANTS
(Building Engineering Services)
C2/13 2nd Floor, JYAPAR, NEW DELHI - 110086
Tel: 011-40532854, 25611240
Email: srianpie@gmail.com

DRG. TITLE:

**Site plan
Water supply
system
Plumbing dwg**

SCALE:

NTS

DATE:

15.06.21

Drawn By

Santosh

Checked By

Srinivasan

Approved By

S.K.Palit

Rev.No.

01

Rev.Date

18-05-21

Remarks

DWS/FWS to Club Bldg. Shown