


"RAVI KIRAN VIHAR"

AT VILLAGE-MOHANPURA ,TEH.- SANGANER, JAIPUR
UNDER KHASRA NO - 202, 203/577
UNDER CMJAY PROVISIONAL -3C

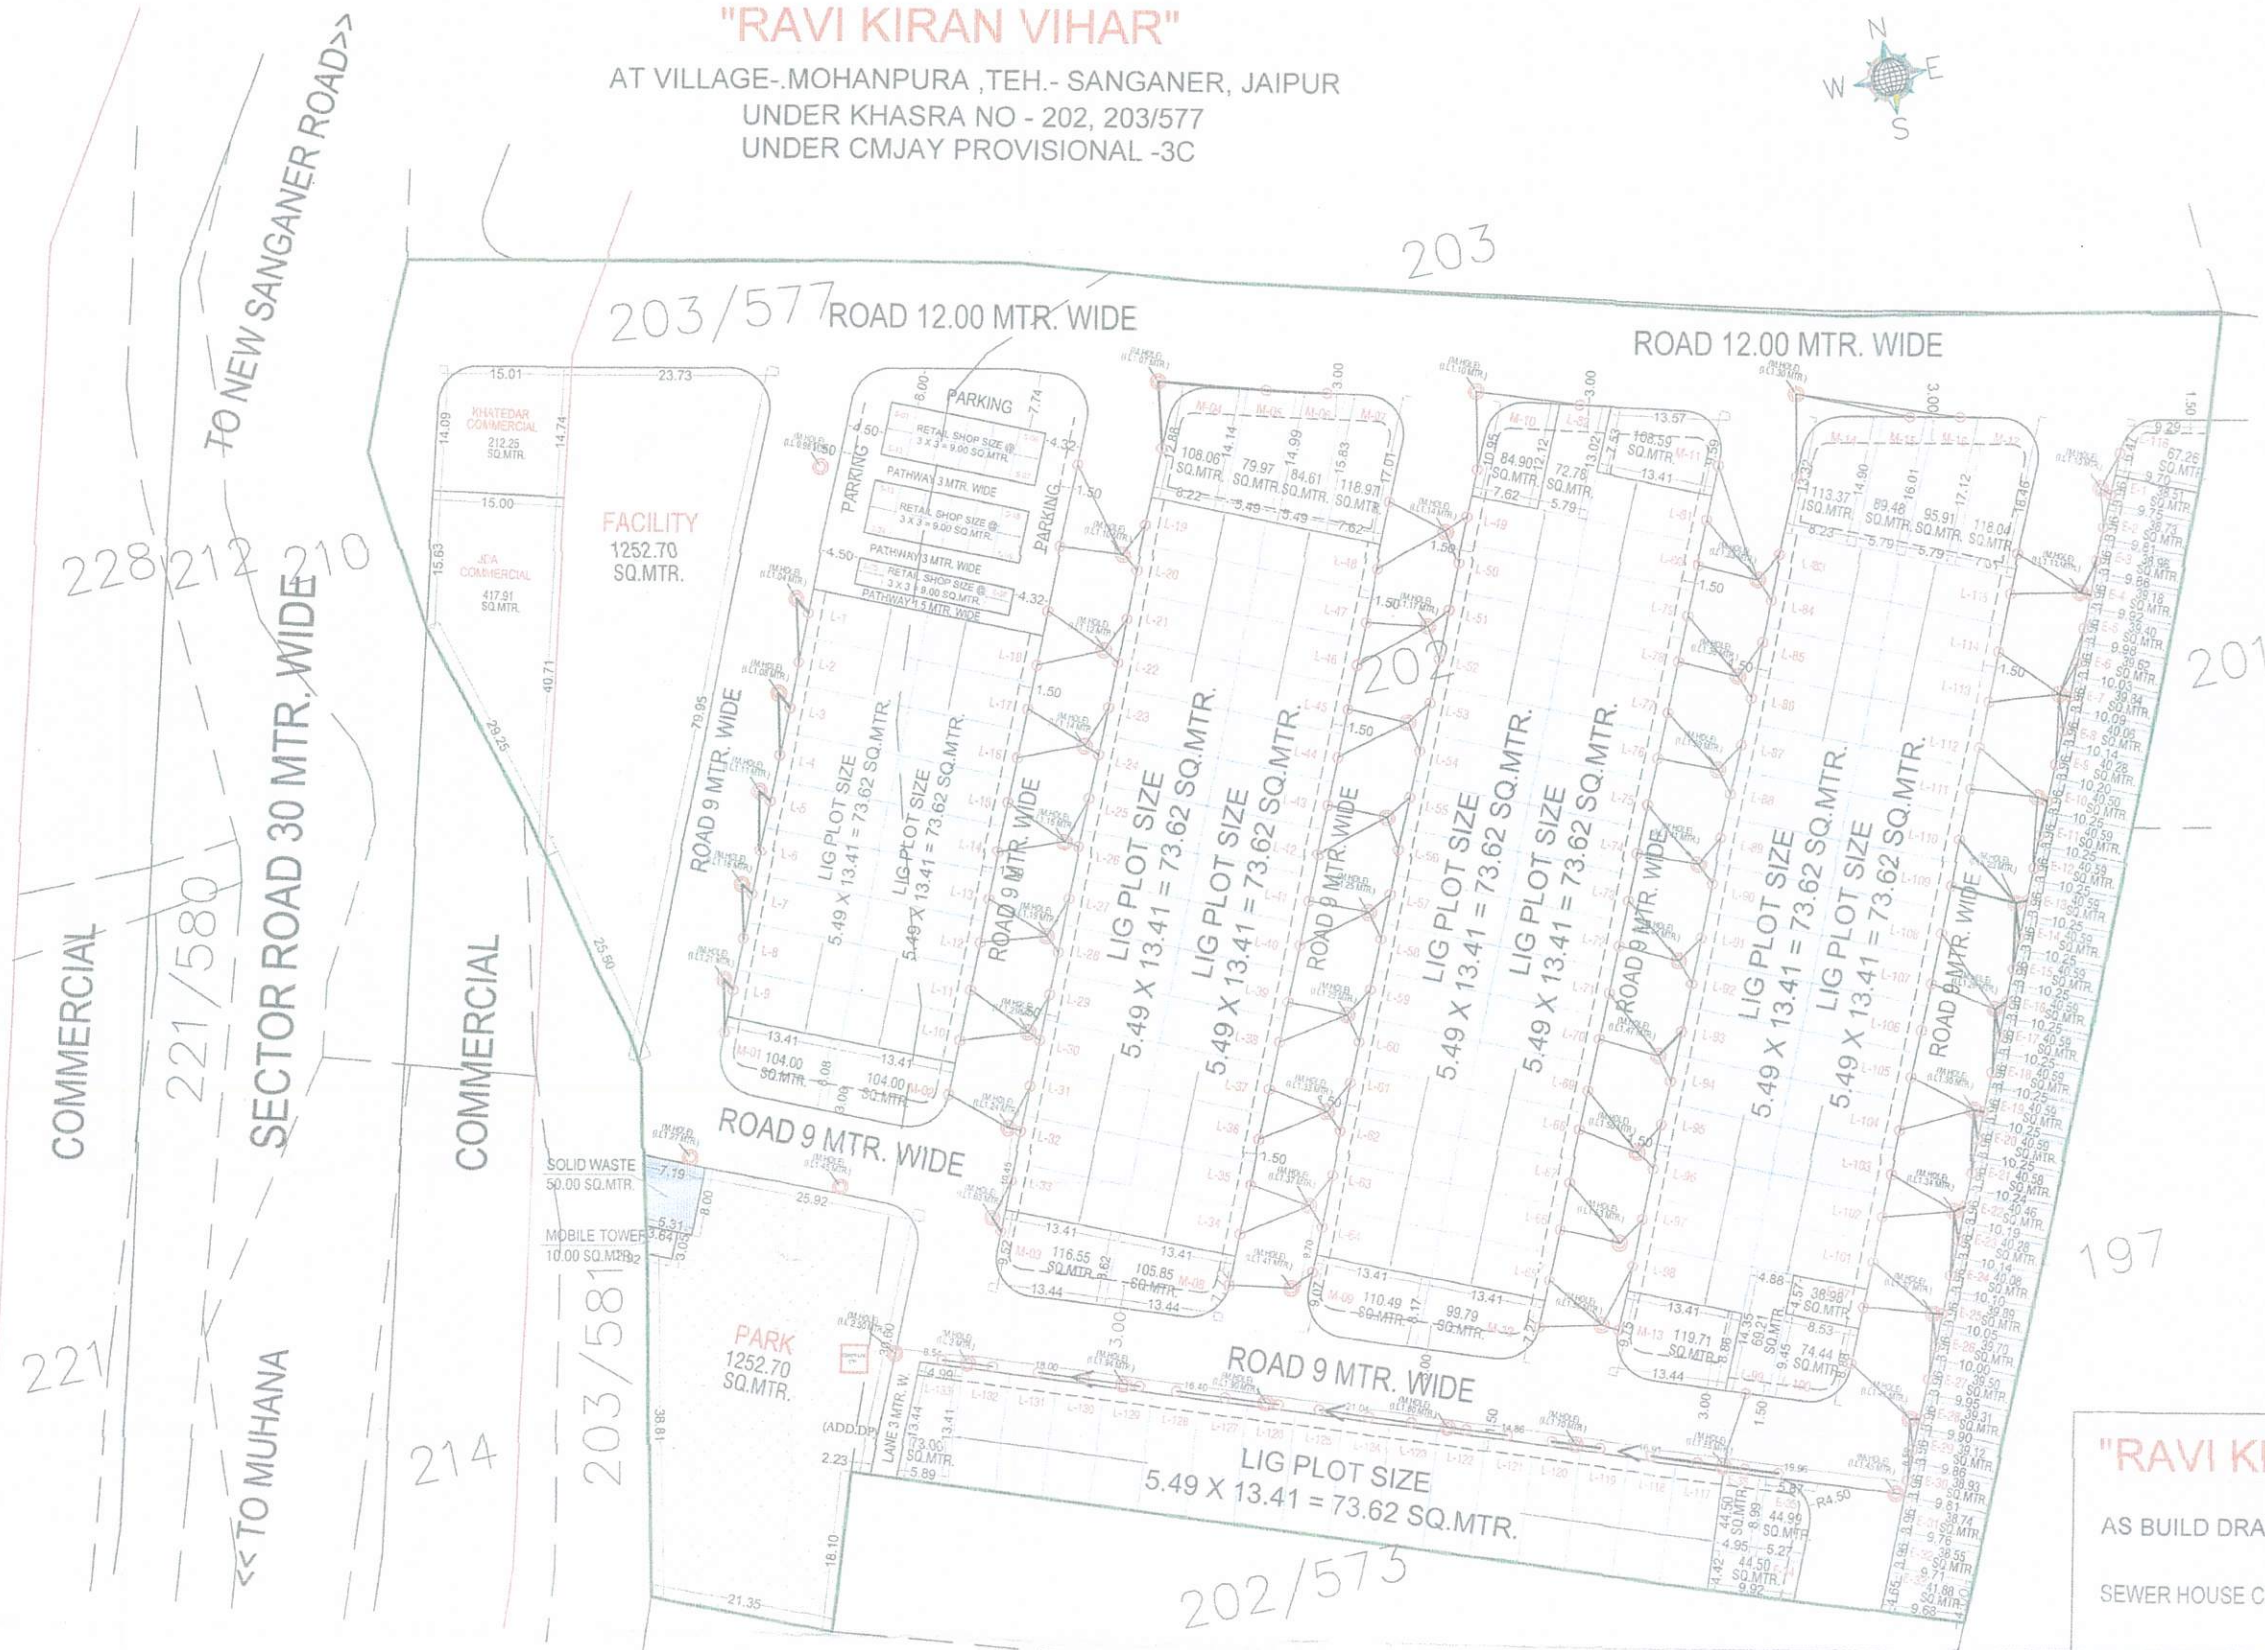

"RAVI KIRAN VIHAR"

AS BUILD DRAWING OF:-
SEWER HOUSE CONNECTION

DOVELOPED BY :-

RADHIKA ENGINEERS


For RADHIKA ENGINEERS
PARTNER

Dr. Ravi Kant Pareek
M. Tech (Civil)
Ph.d (Environment)

- DWC 110 MM PIPE
- IC RCC M. HOLE
- RCC 1MTR. DIA M.HOLE

"RAVI KIRAN VIHAR"

AT VILLAGE-.MOHANPURA ,TEH.- SANGANER, JAIPUR
UNDER KHASRA NO - 202, 203/577
UNDER CMJAY PROVISIONAL -3C

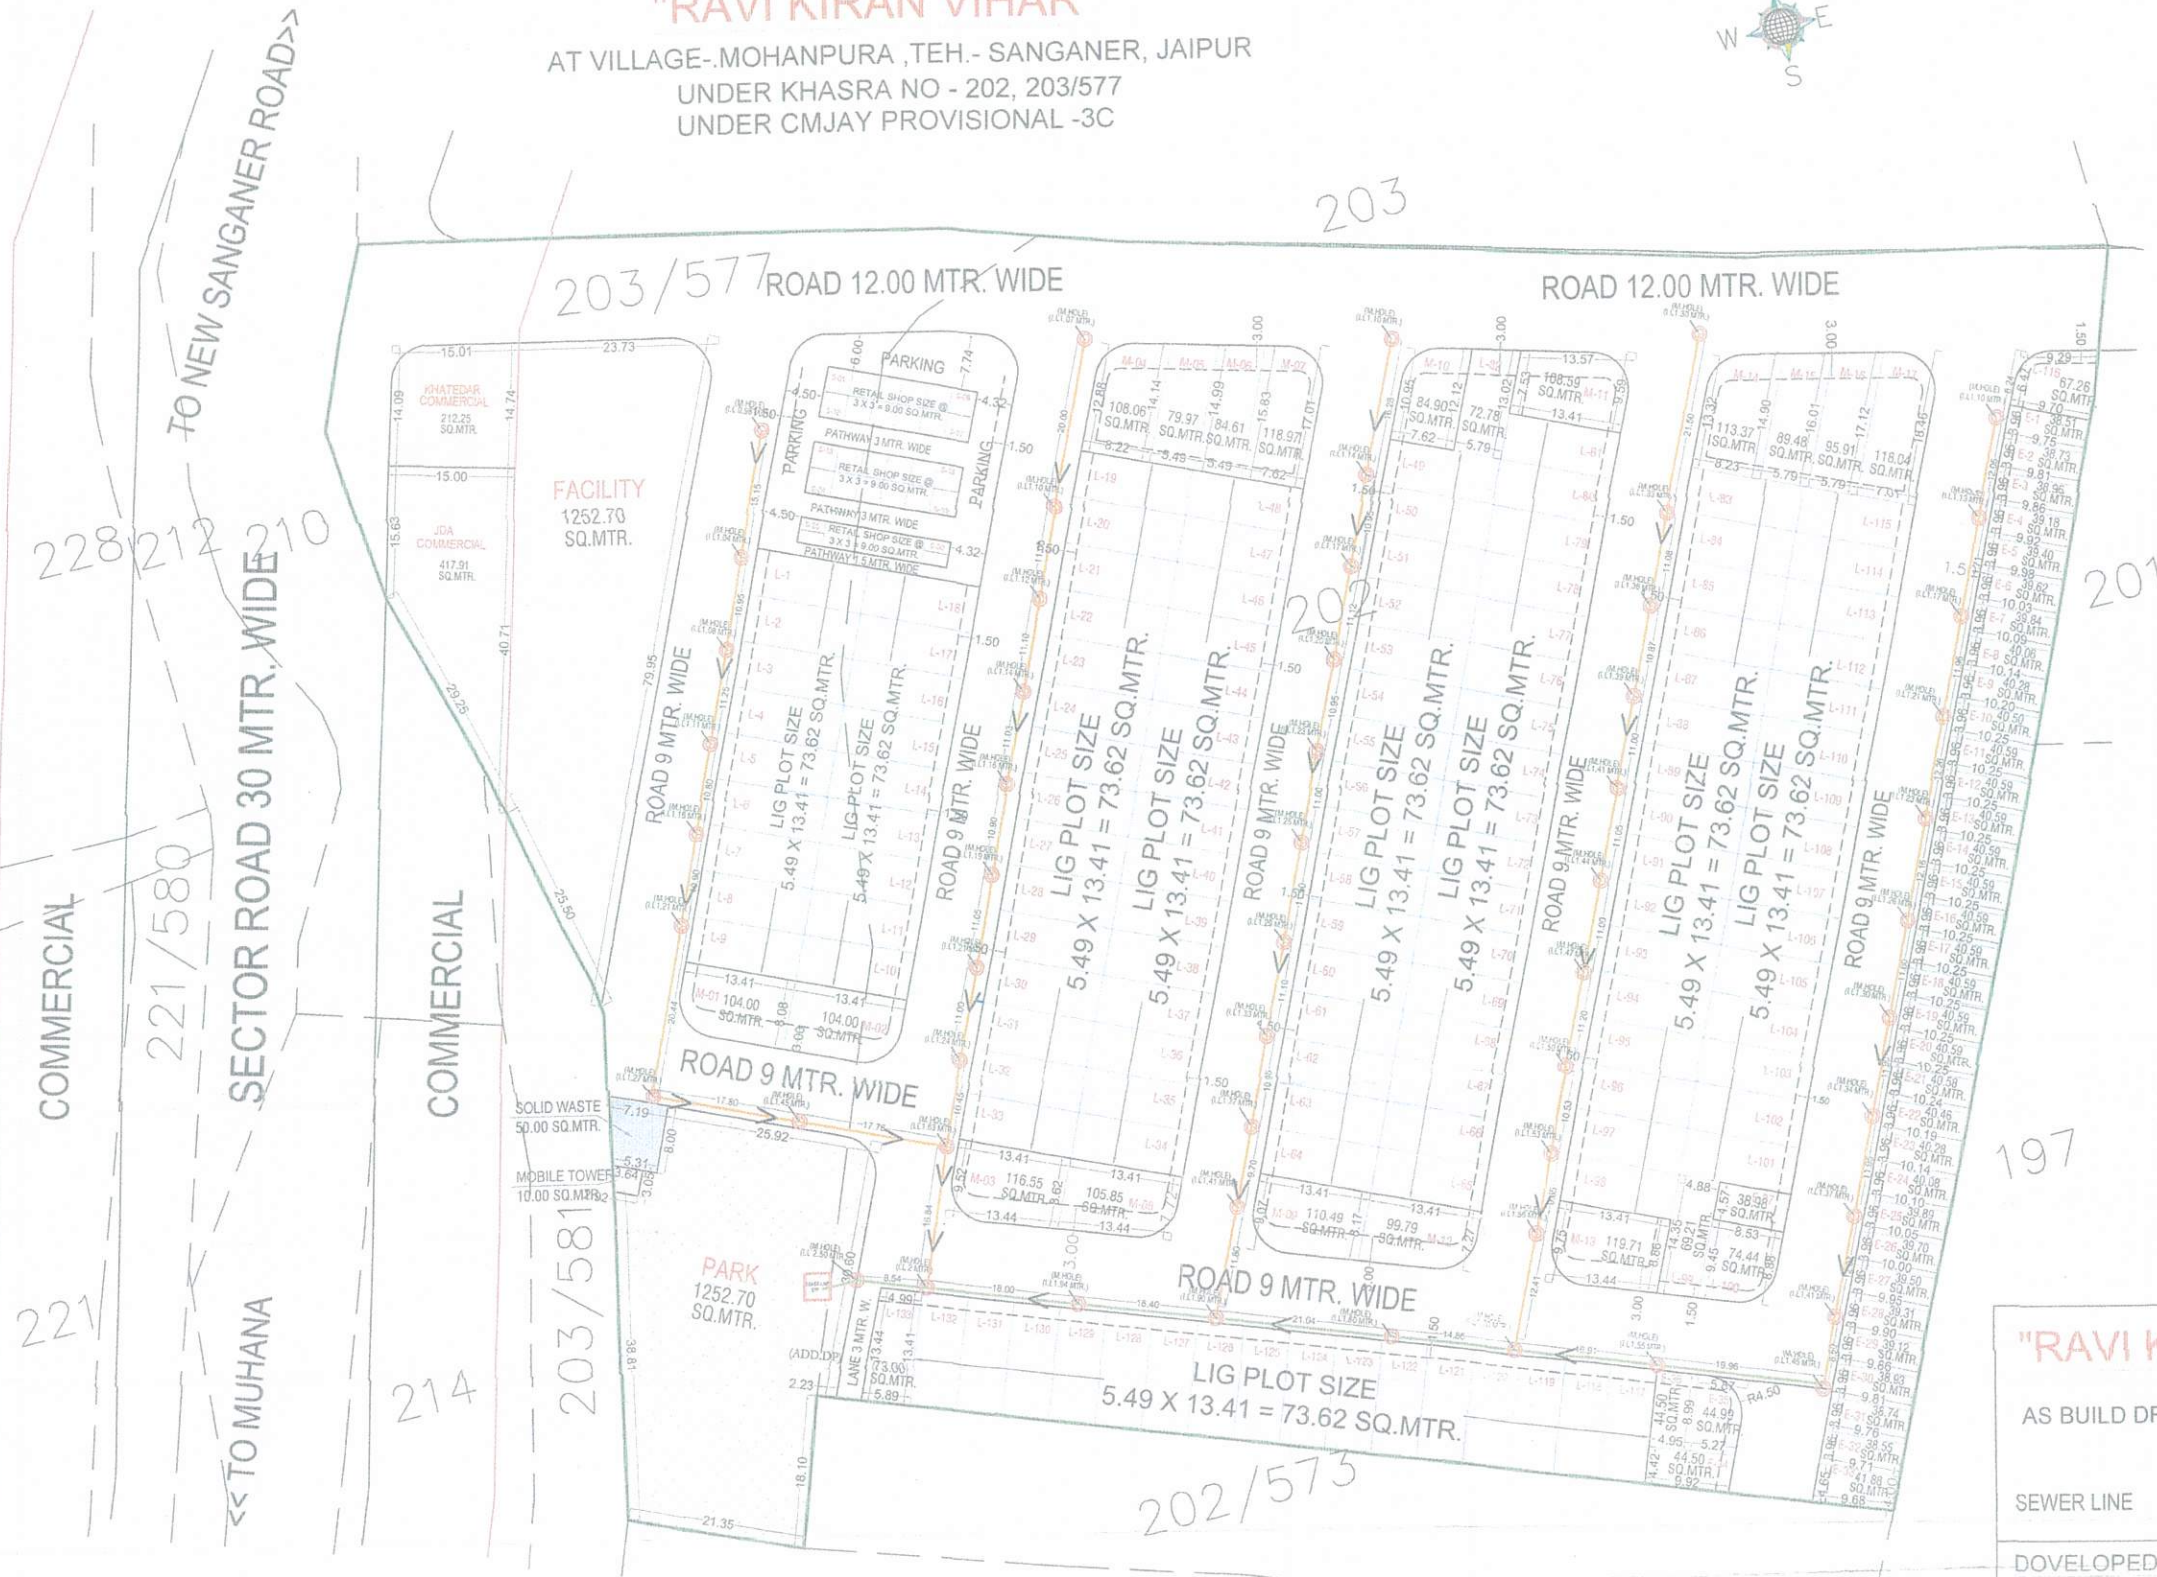

Dr. Ravikant Pareek
M. Tech (Civil)
Ph.d (Environment)

For RADHIKA ENGINEERS
PARTNER:

"RAVI KIRAN VIHAR"


AS BUILD DRAWING OF:-

SEWER LINE

DEVELOPED BY:-

RADHIKA ENGINEERS

- RCC 200 MM PIPE
- RCC 150 MM PIPE
- RCC 1 MTR. DIA M.HOLL

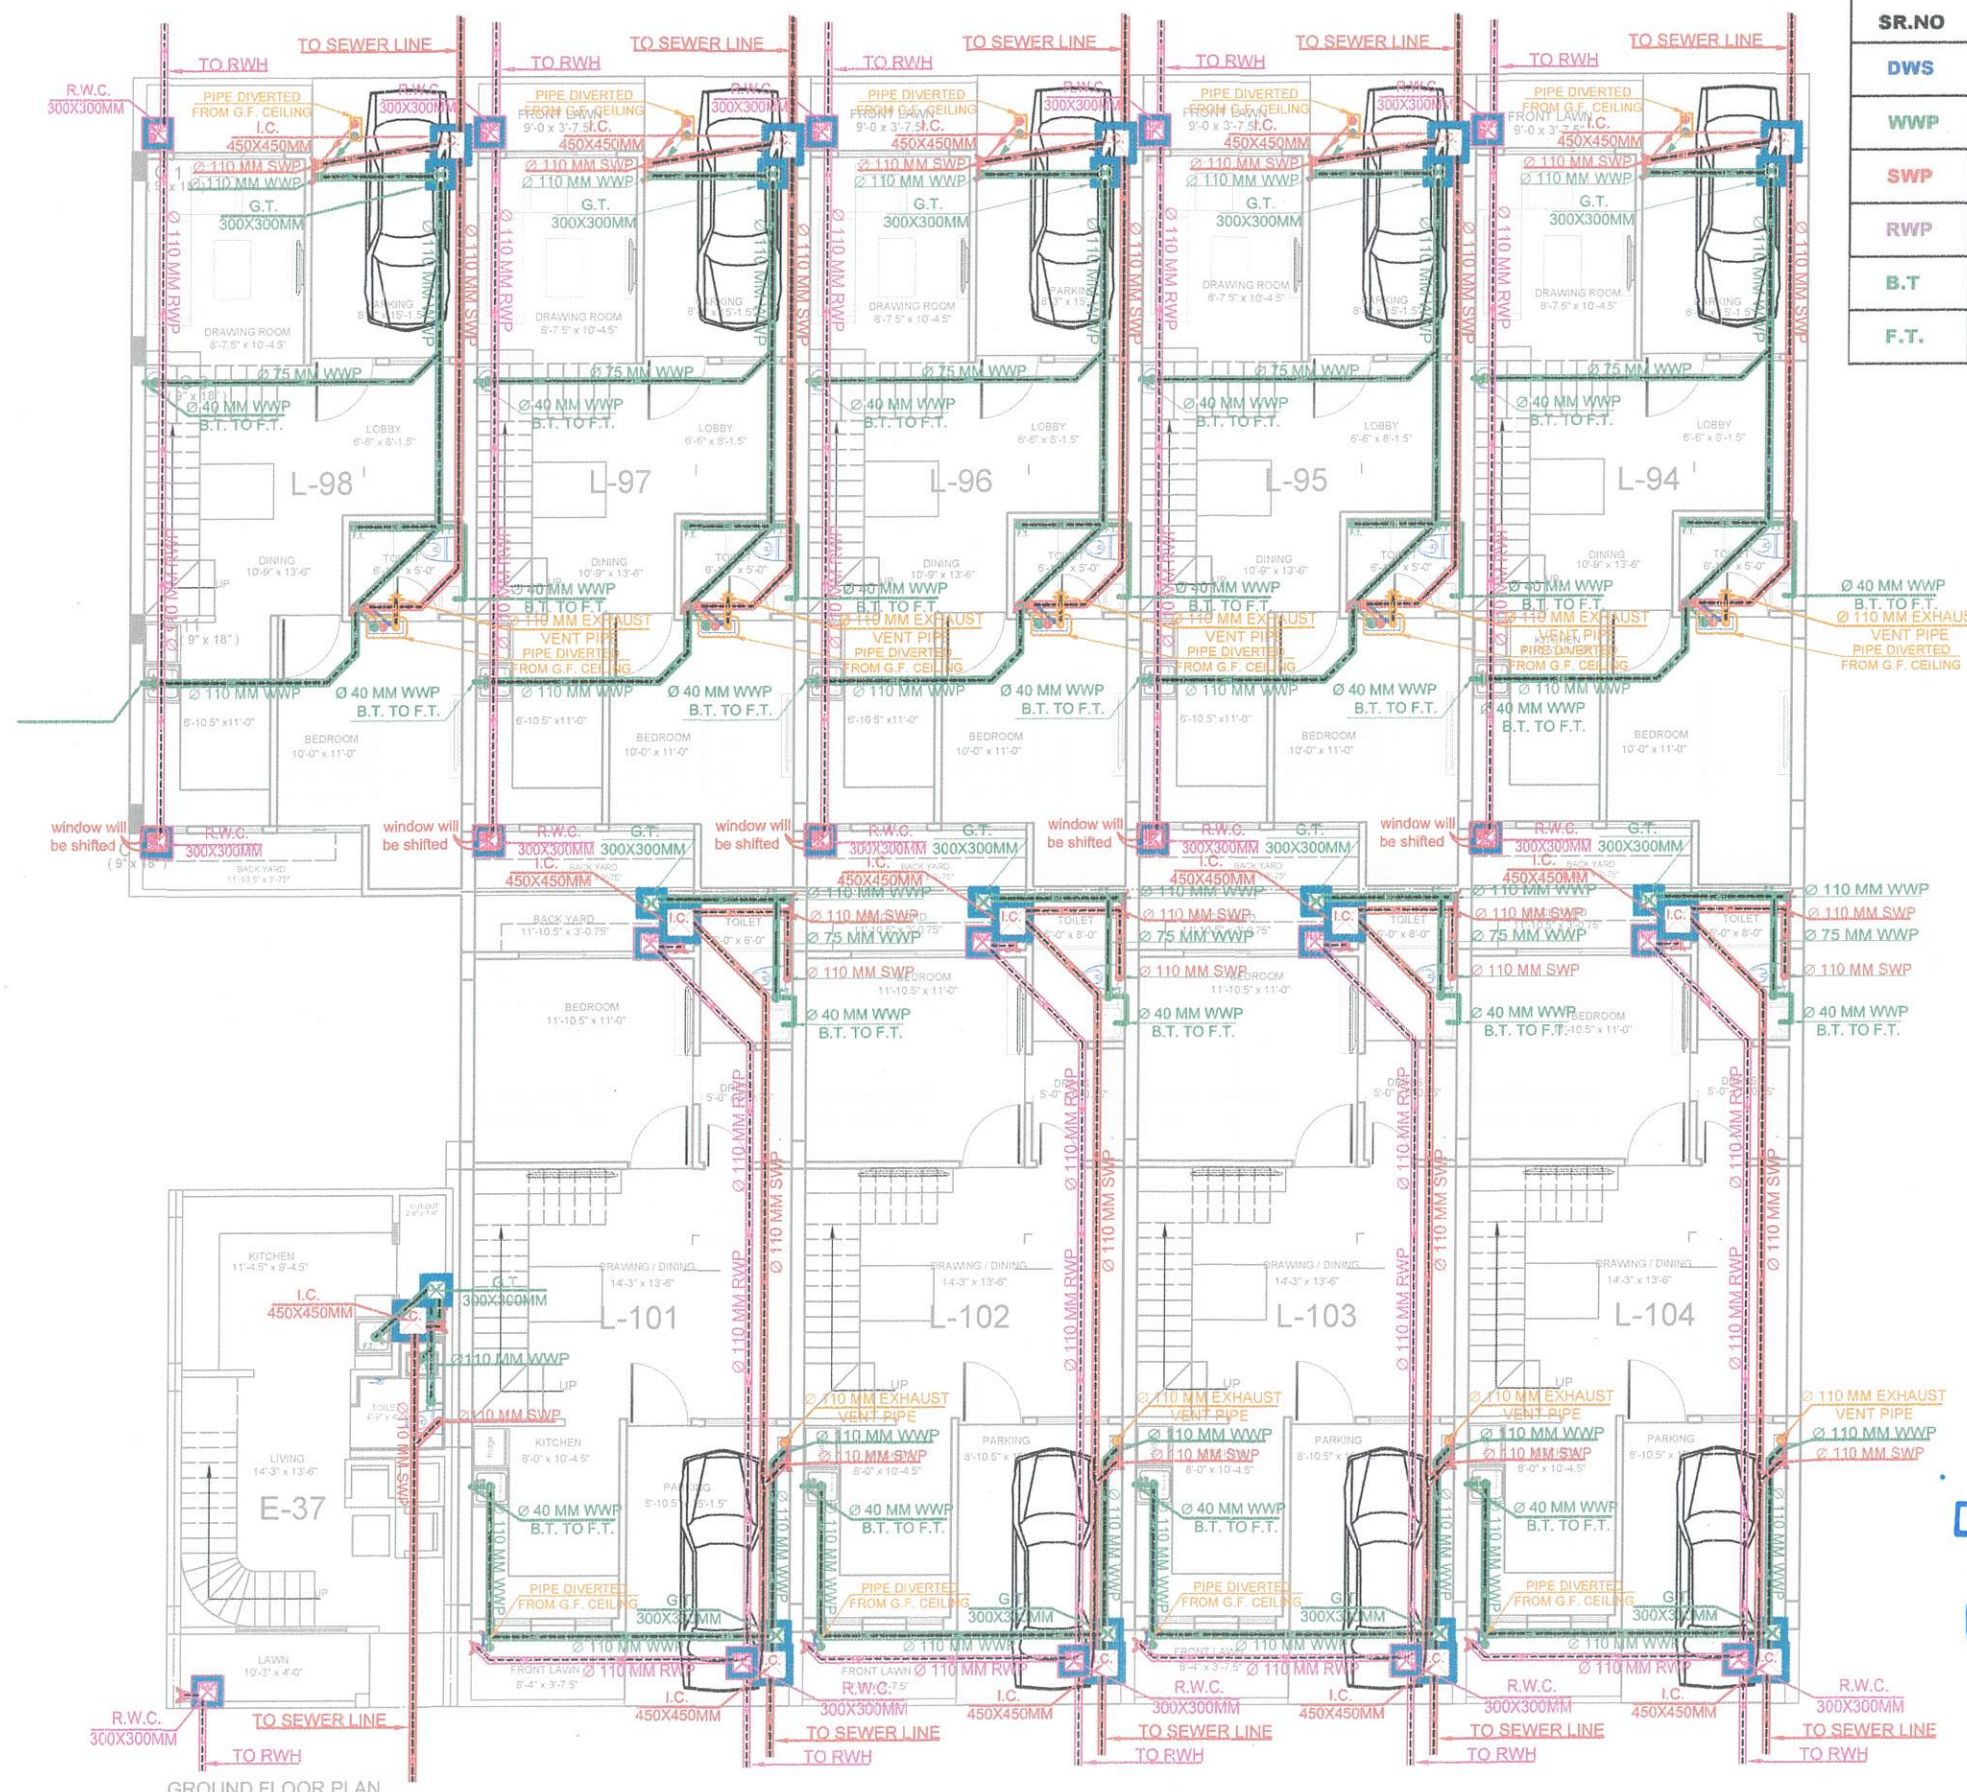

LEGEND	
SR.NO	DESCRIPTION
DWS	DOMESTIC WATER SUPPLY
WWP	WASTE WATER PIPE
SWP	SOIL WATER PIPE
RWP	RAIN WATER PIPE
B.T.	BOTTLE TRAP
F.T.	FLOOR TRAP

Dr. Ravi Kant Pareek
M. Tech (Civil)
Ph.d (Environment)

PROJECT TITLE	CONSULTANT	DRAWING TITTLE	CHECKED BY:	DRAWN BY:	NORTH :-	ARCHITECT
PROPOSED RESIDENTIAL SCHEME "RAVI KIRAN VIHAR" AT VILLAGE-MOHANPURA, TEH.- SANGANER, JAIPUR UNDER KHASRA NO - 202, 203/577	AMP INFRA SERVICES VILLA NO 16, SHUBHASIS GEETA JAISINGHPURA, BHANKROTA & CHIMANPURA, JAIPUR 302026 EMAIL ID- ampinfrajpr@gmail.com	GROUND FLOOR DRAINAGE LAYOUT	NARESH	SUFIAN KHAN		AIM ENGINEERS & ARCHITECTS #105 FI. FL., SHIV GYAN AVENUE PLOT NO. -2 YUDHISHTER MARG, OPP. YOJNA BHAWAN, C- SCHEME JAIPUR.
			DATE 19/10/2023	DWG. NO.		