



VIDEO DOOR PHONE SYSTEM


9TH FLOOR
08 NOS. VDP
CAMERA

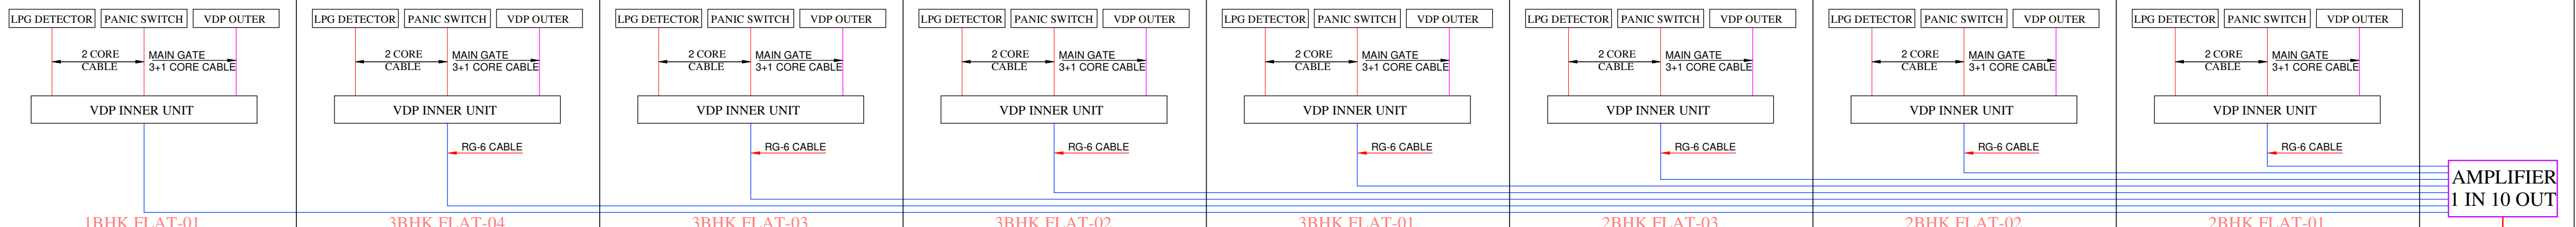


8TH FLOOR
08 NOS. VDP
CAMERA

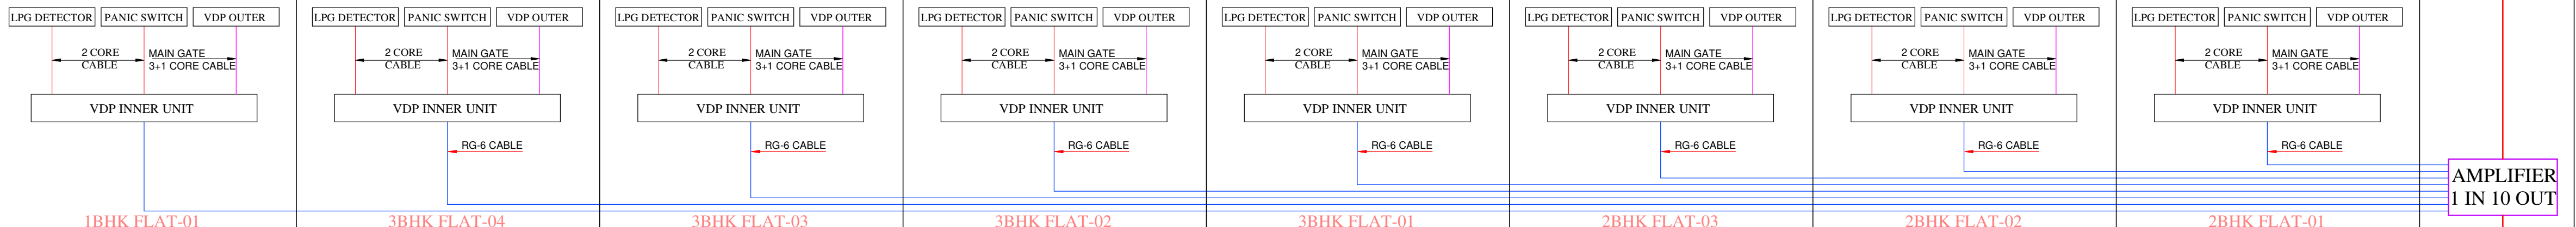


7TH FLOOR
08 NOS. VDP
CAMERA

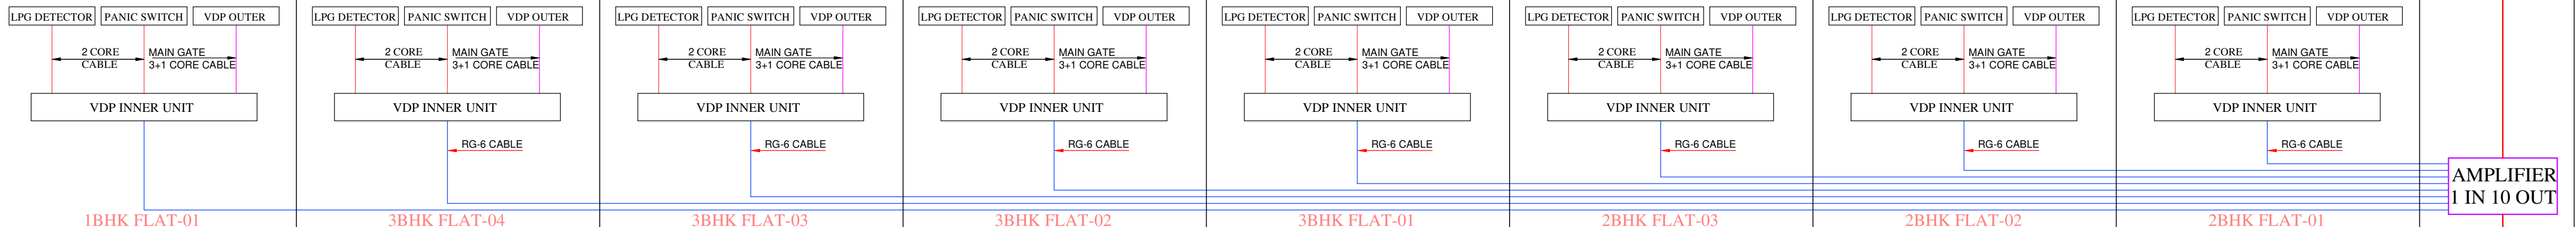


6TH FLOOR
08 NOS. VDP
CAMERA

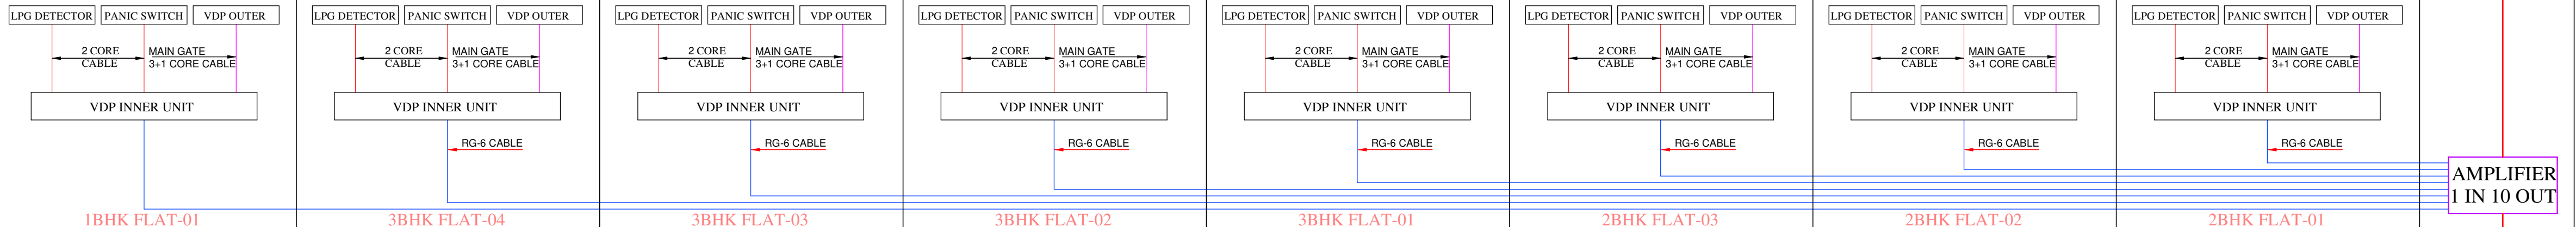


5TH FLOOR
08 NOS. VDP
CAMERA

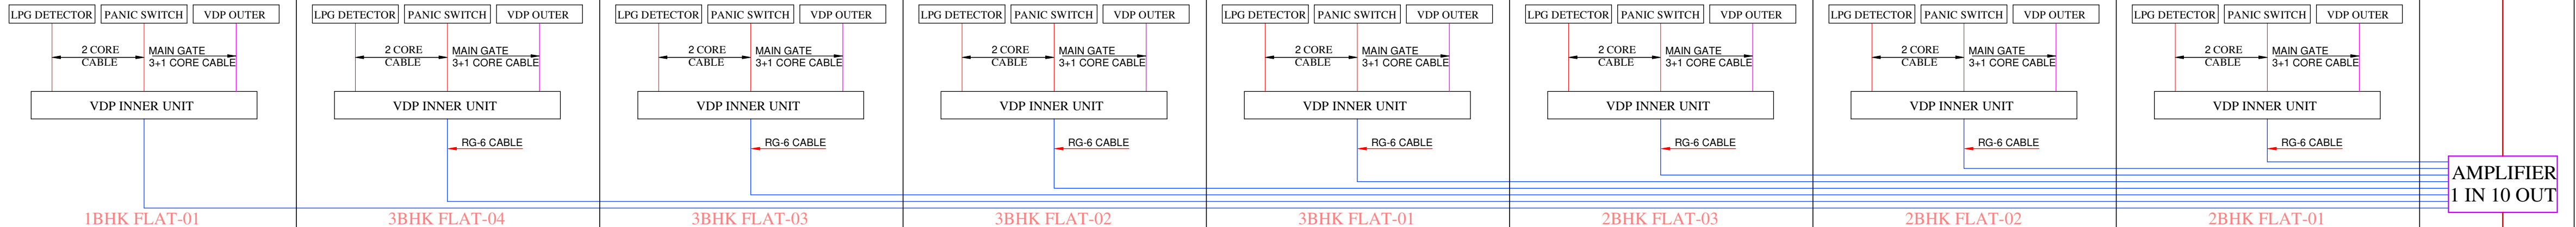


4TH FLOOR
08 NOS. VDP
CAMERA

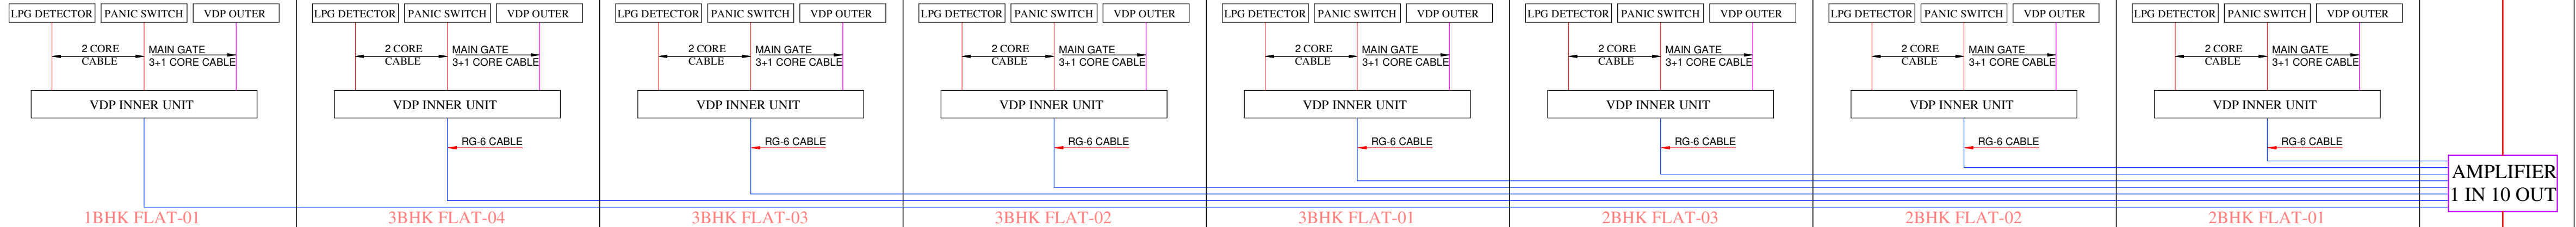


3RD FLOOR
08 NOS. VDP
CAMERA

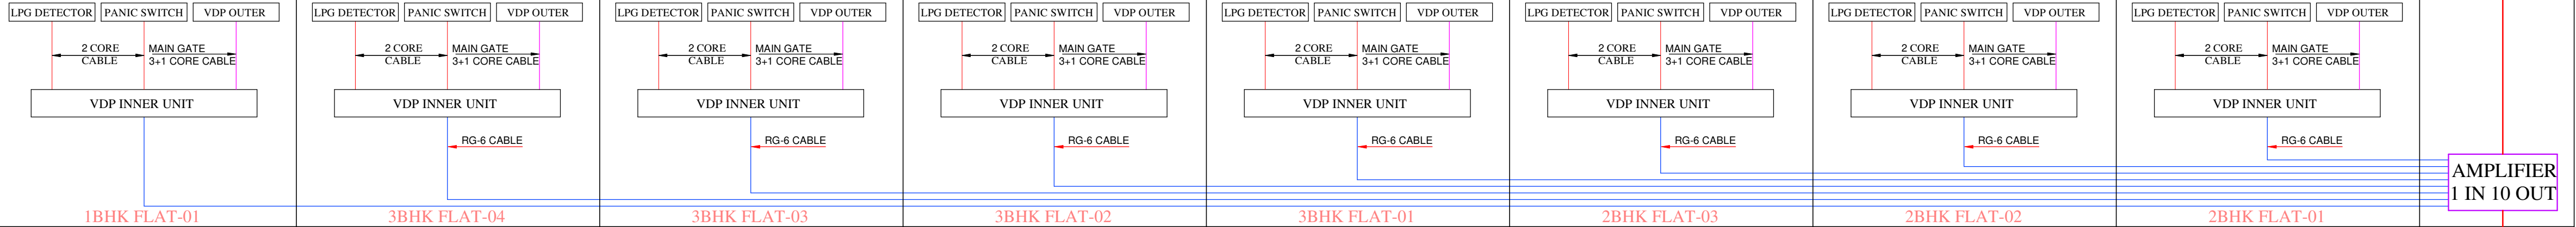

2ND FLOOR
08 NOS. VDP
CAMERA

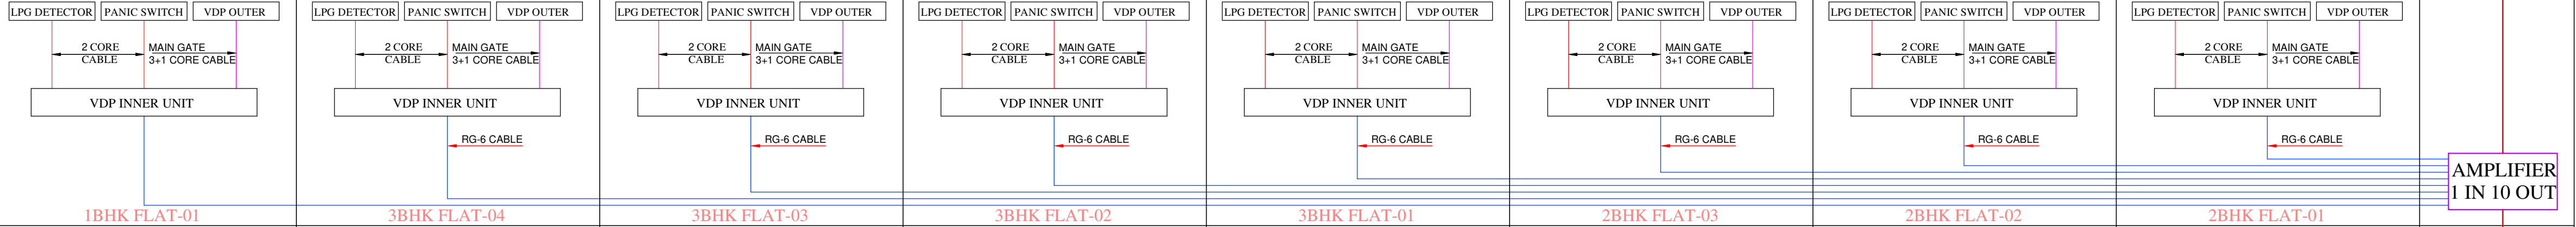

1ST FLOOR
08 NOS. VDP
CAMERA

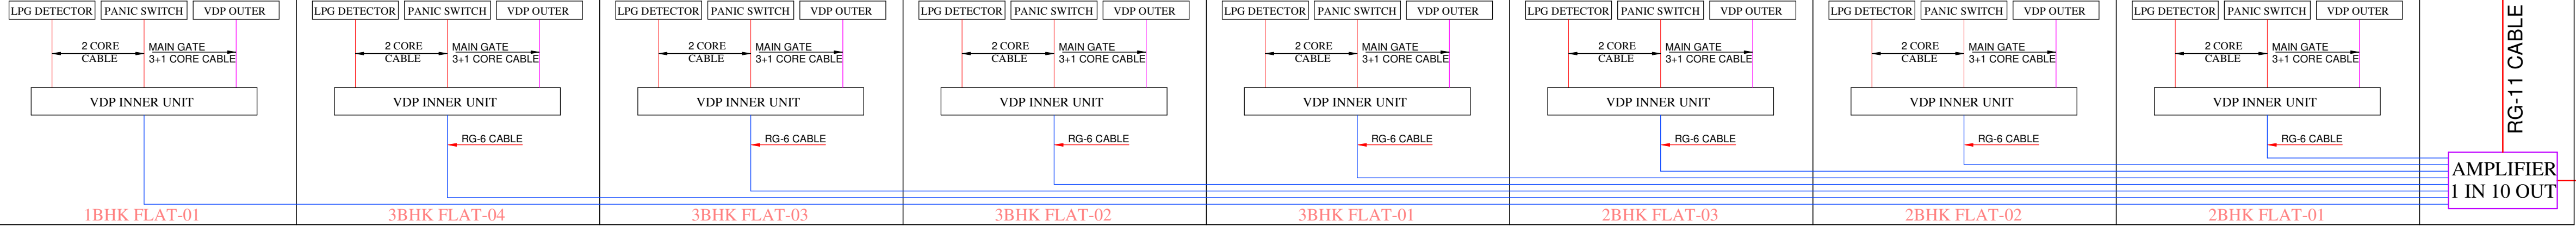

SERVICES CONSULTANT:
VIPUL CONSULTING,
F 9 / 440 ,Chitrakut
Scheme,Jaipur
PH:91-0-93146-10438,0141-2440946
Mail:vipul8599@yahoo.com

PROJECT ADD. :-
Khasra no/ plot no A-6,7,8,9,10,&11/547, 550,to
555, 557,and 558, Pragti Nagar, Kotra Scheme ,
Ajmer-305004 (Rajasthan)


PROJECT NAME:-
SKY TOWER

TITLE -
**VIDEO DOOR PHONE
SINGLE LINE DIAGRAM**


RIV. -
00
DATE -
19-03-2021

DRAWN BY:-
VICKY YADAV
APPROVED BY:-
VIPUL AGARWAL

Vipul
VIPUL AGARWAL
M.E.P. CONSULTANT
B.E. ELECTRICAL

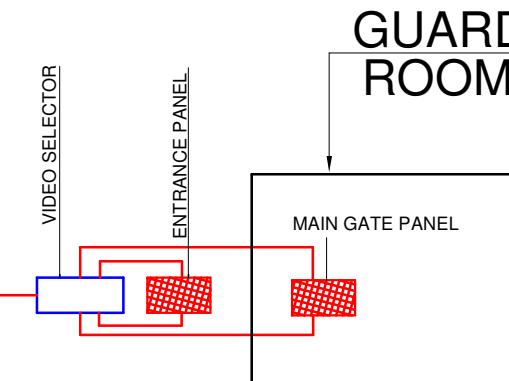

TELEPHONE

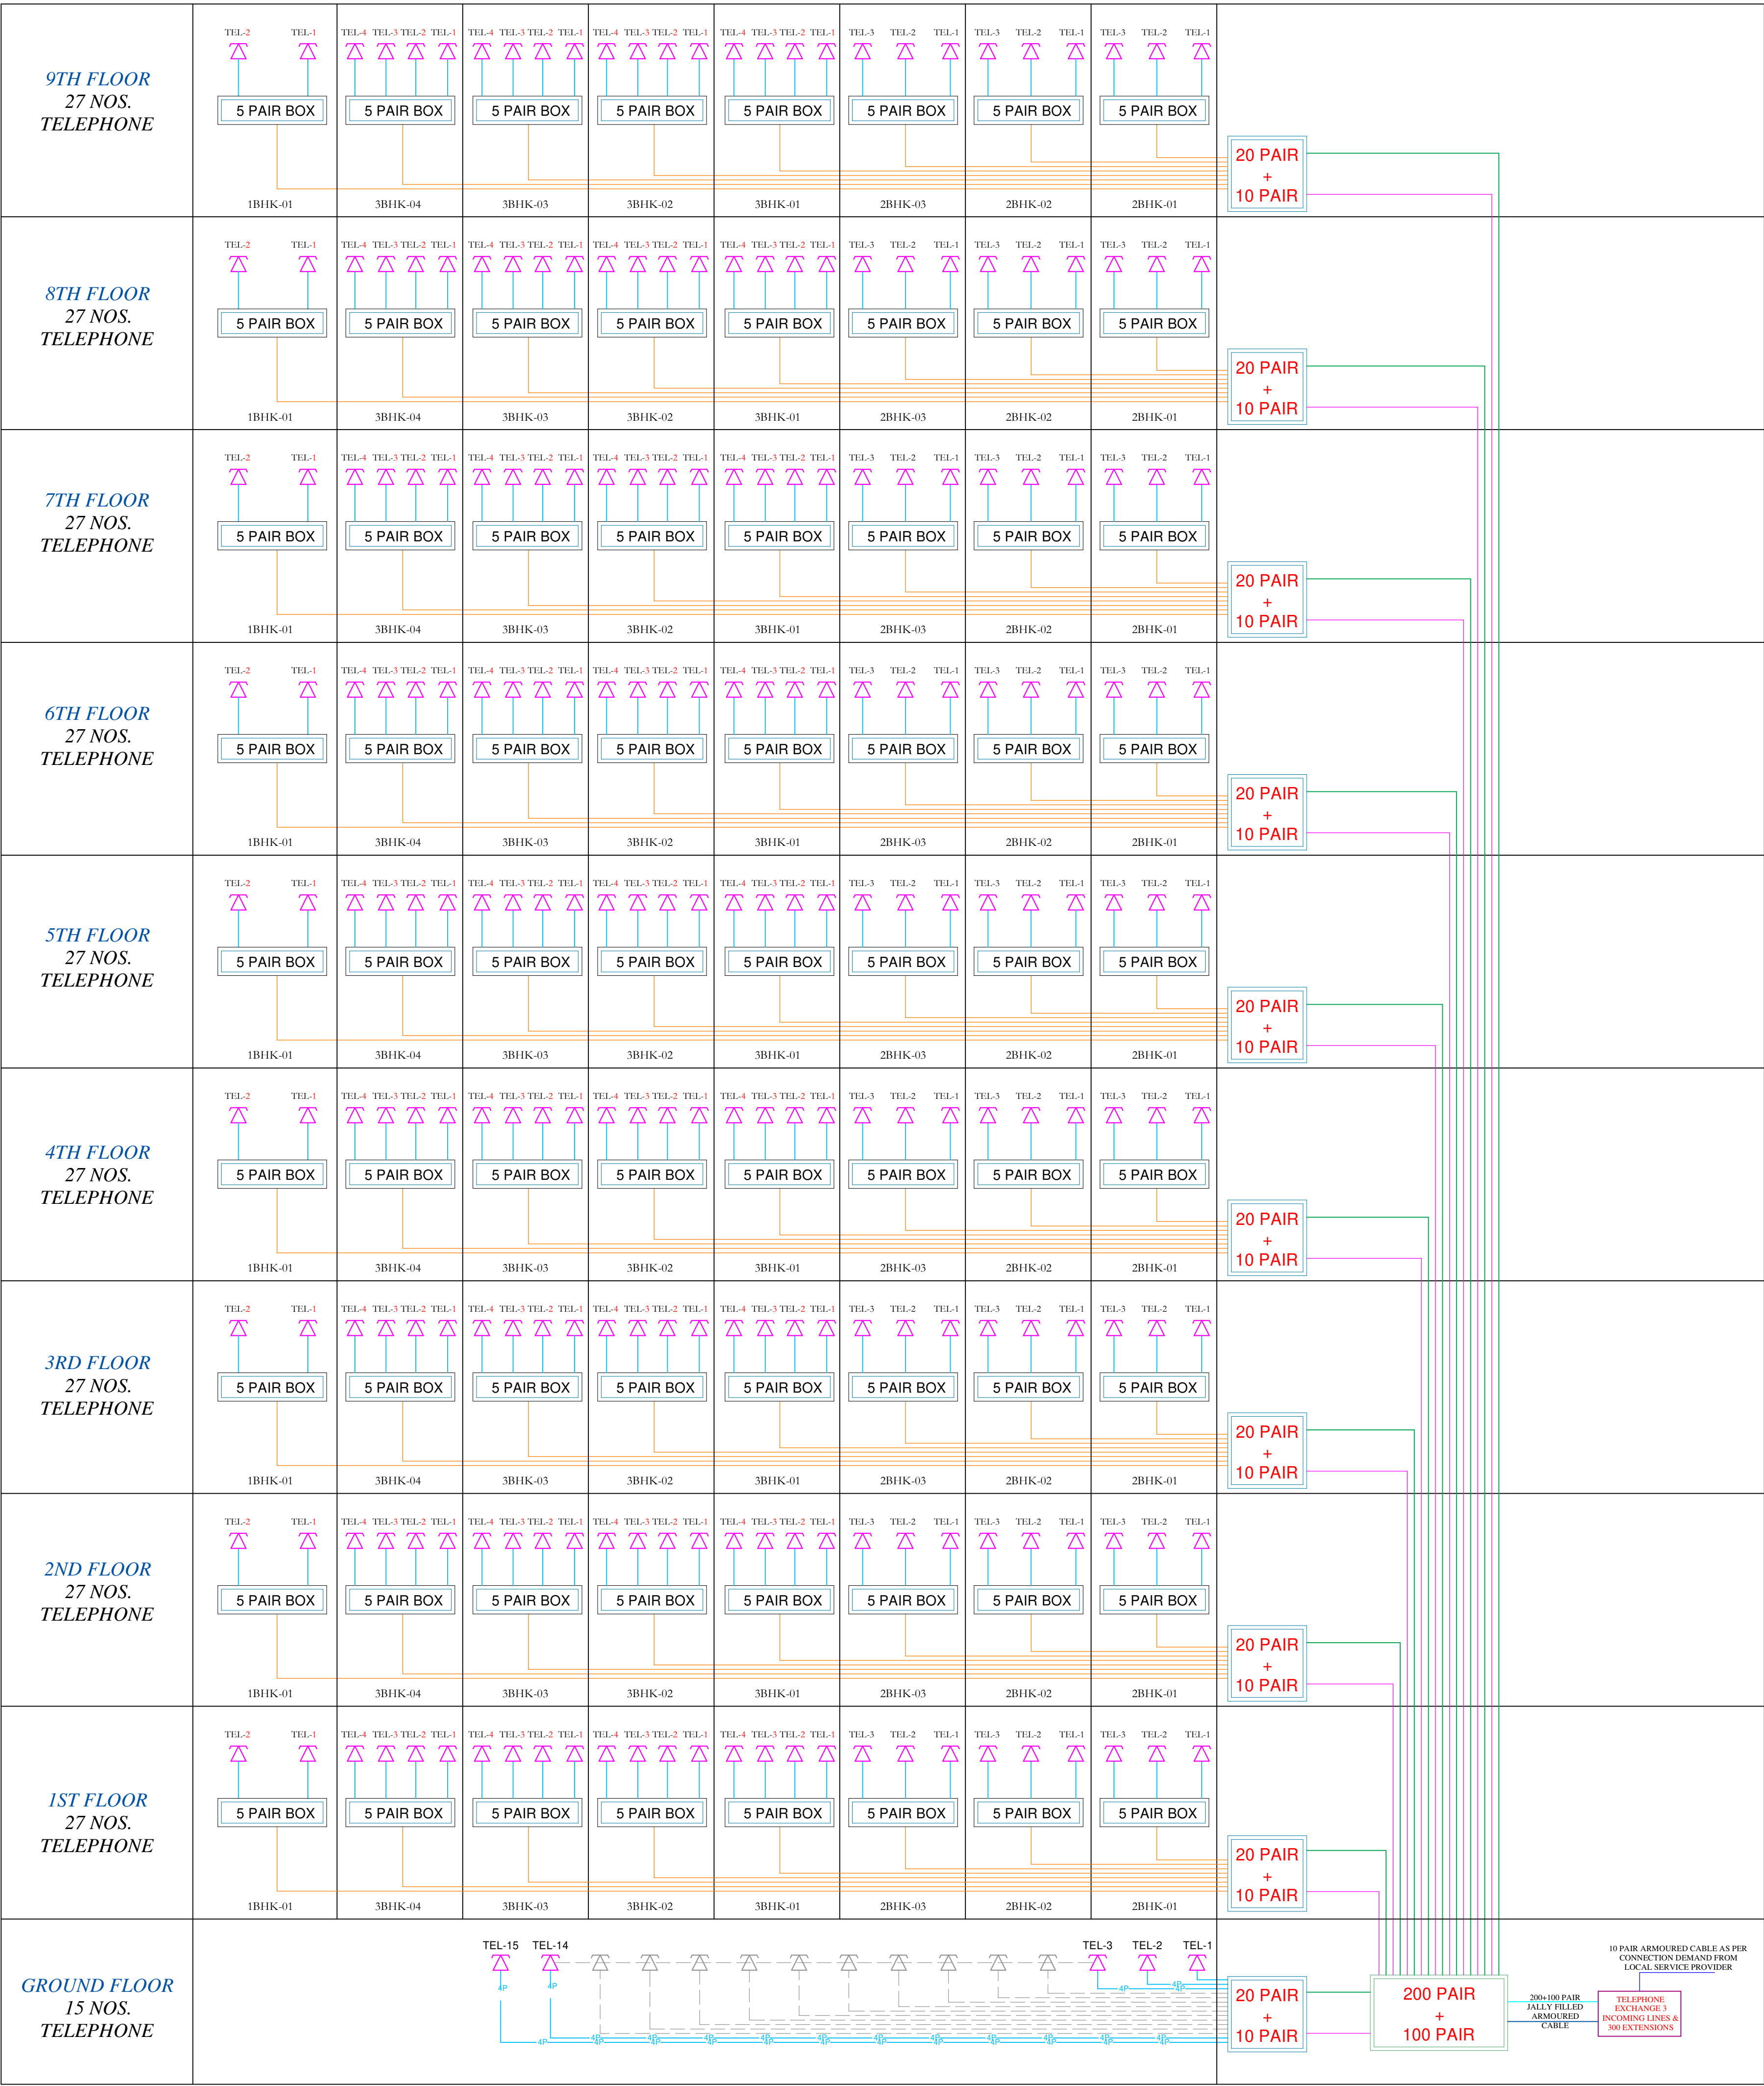

SR.N		DESCRIPTION
01	4-pair	4 PAIR UNARMoured CABLE
02	5-pair	5 PAIR UNARMoured CABLE
03	10-pair	10 PAIR UNARMoured CABLE
04	20-pair	20 PAIR UNARMoured CABLE
05	100-pair	100 PAIR ARMoured CABLE
06	200-pair	200 PAIR ARMoured CABLE

SERVICES CONSULTANT:
VIPUL CONSULTING,
F 9 / 440 ,Chitrakut Scheme,Jaipur
PH:91-0-93146-10438,0141-2440946
Mail:vipul8599@yahoo.com

PROJECT ADD. :-
Khasra no/ plot no A-6,7,8,9,10,&11/547, 550,10
553, 557 and 558, Pongli Nagar, Kotra Scheme ,
Ajmer-305004 (Rajasthan)

PROJECT NAME:-
SKY TOWER

TITLE -
TELEPHONE
SINGLE LINE DIAGRAM

RIV. -
00


DATE -
19-03-2021

DRAWN BY:-
VICKY YADAV

APPROVED BY:-
VIPUL AGARWAL

Vipul
VIPUL AGARWAL
M.E.P. CONSULTANT
B.E. ELECTRICAL


TV SYSTEM

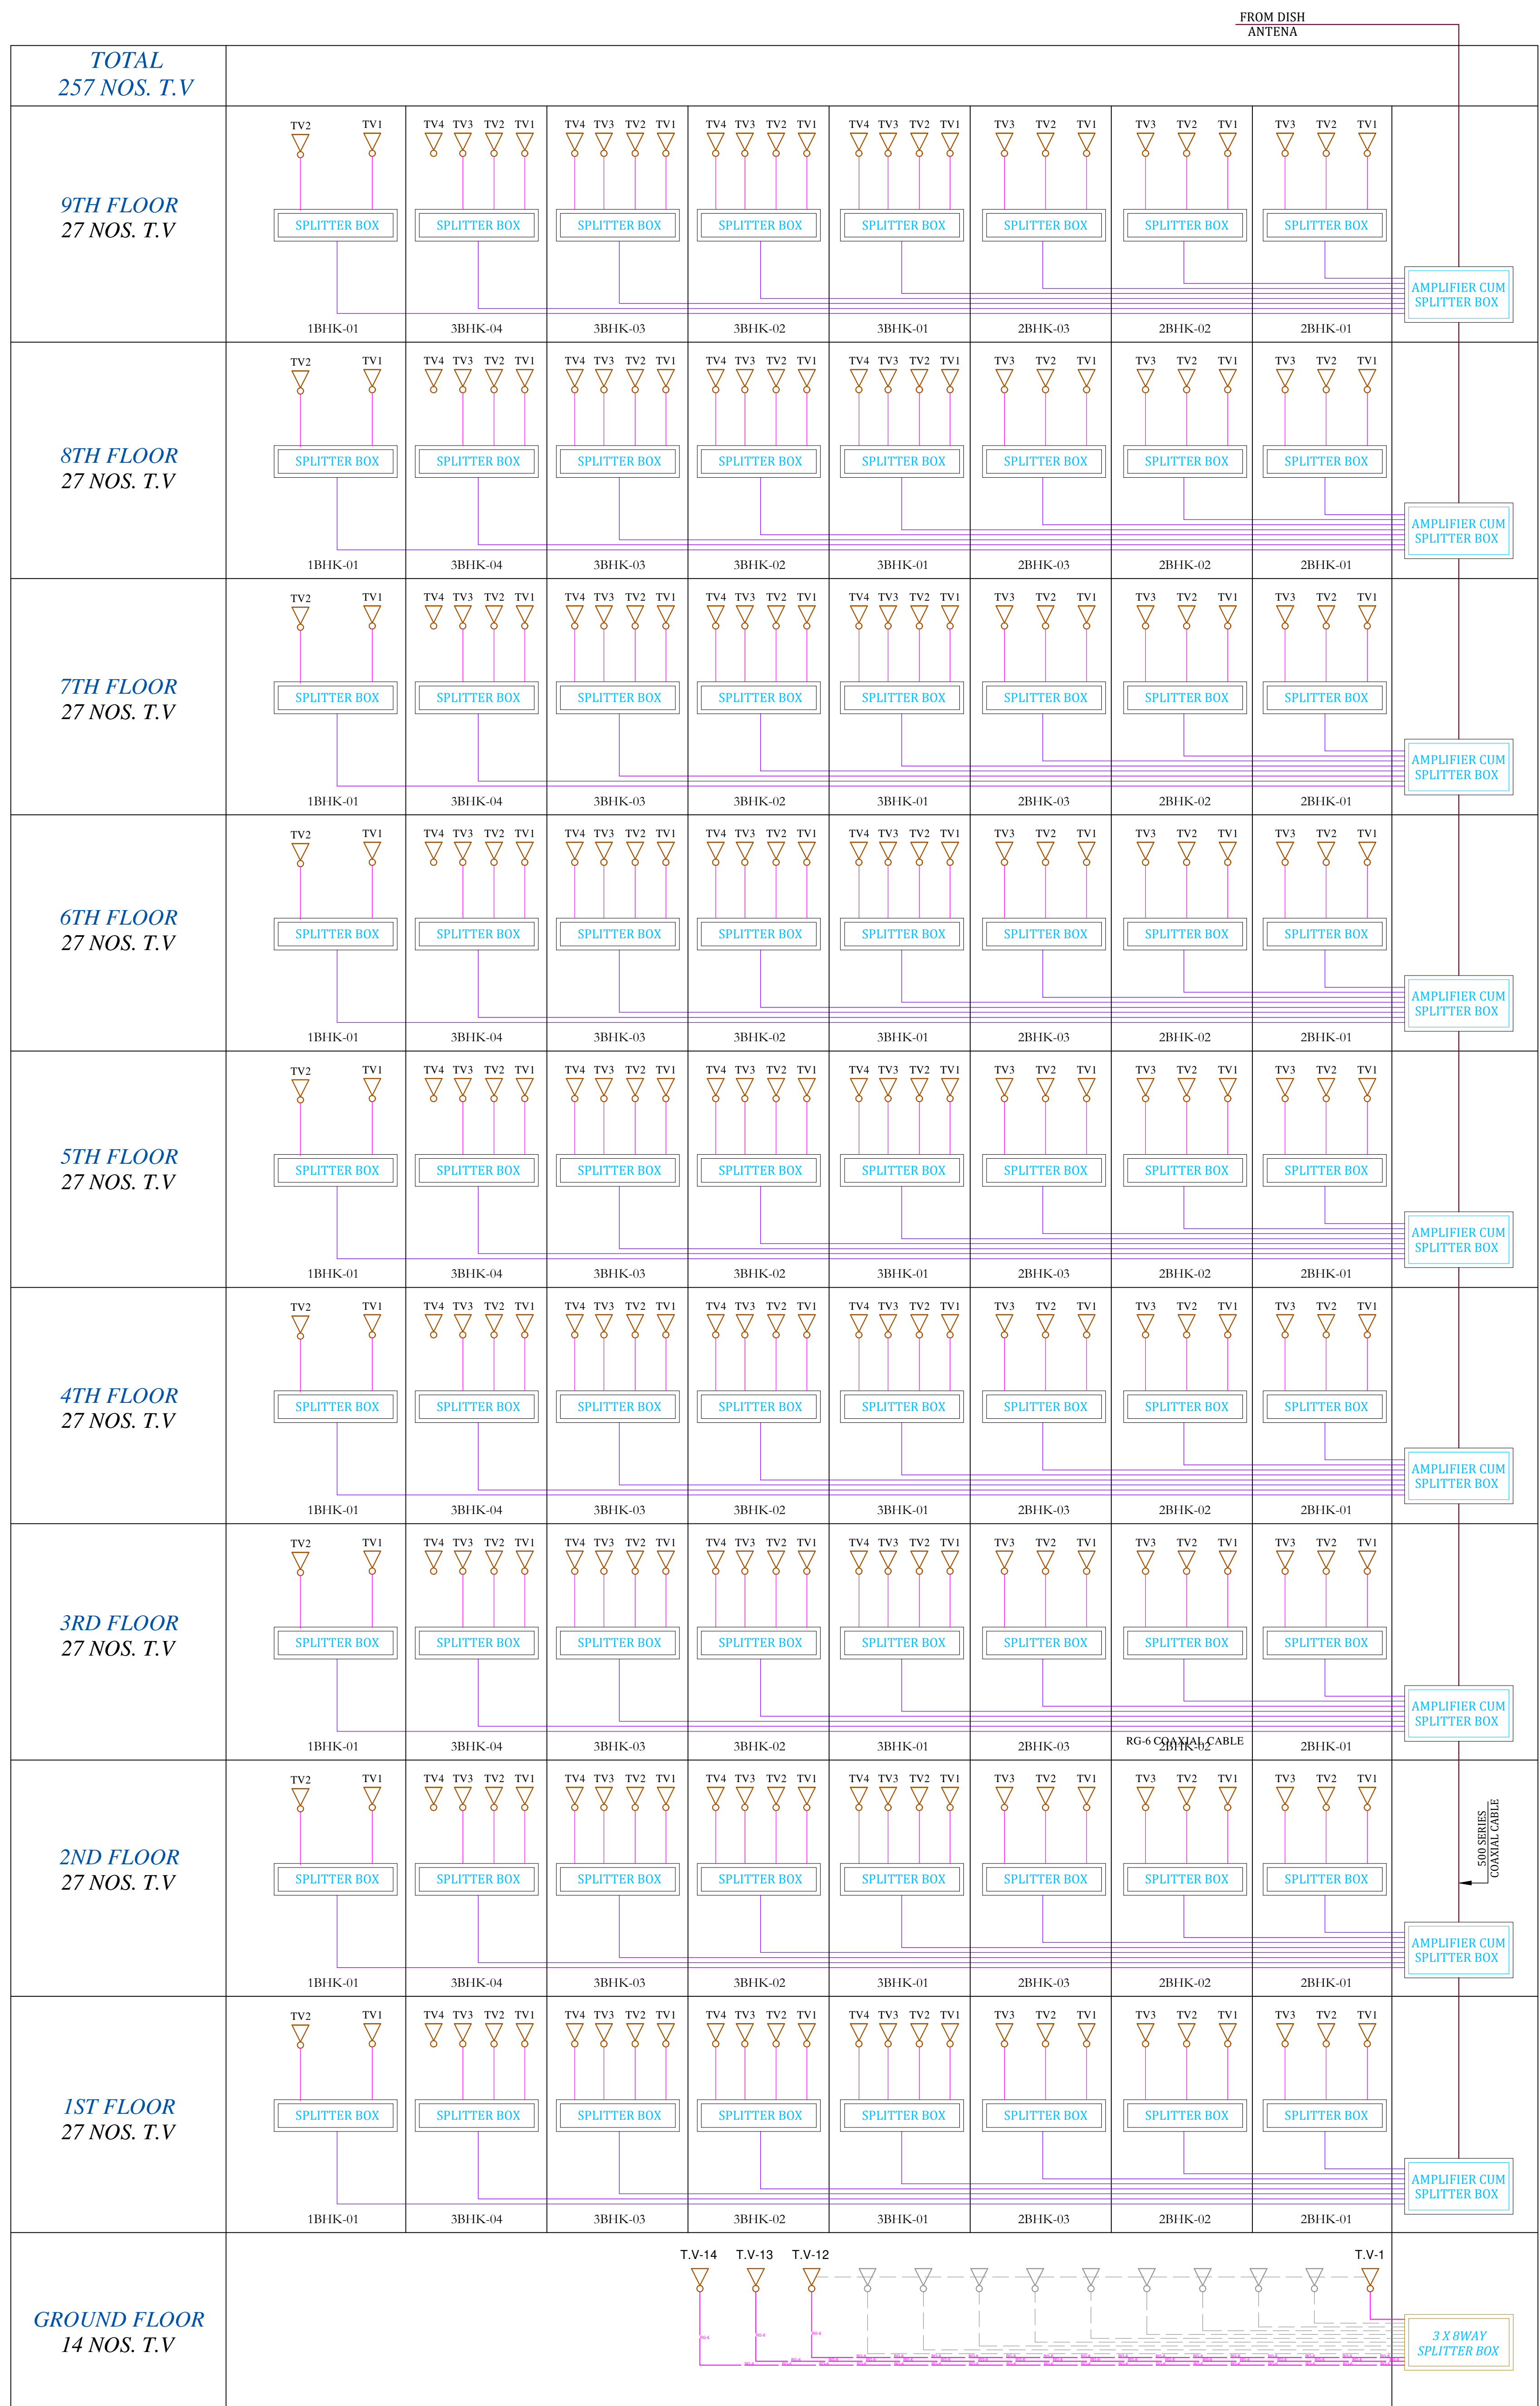



S.R.N.	CODE	DESCRIPTION
1		RG-6 COAXIAL CABLE
2		AMPLIFIER BOX
SERVICES CONSULTANT: VIPUL CONSULTING, F 9 / 440 ,Chitrakut Scheme,Jaipur PH:91-0-93146-10438,0141-2440946 Mail:vipul8599@yahoo.com		
PROJECT ADD. :-		
Khasra no/ plot no A-6,7,8,9,10,&11/547, 550,to 555, 557, and 558, Ragti Nagar, Kotra Schem , Ajmer-305004 (Rajasthan)		
PROJECT NAME:-		
SKY TOWER		
TITLE:-		
TELEVISION LV		
DRAWING TITLE:-		
SINGLE LINE DIAGRAM		
REV :-		DATE :-
00		19-03-2021
DRAWN BY:-		APPROVED BY:-
VICKY YADAV		VIPUL AGARWAL

VIPUL AGARWAL
M.E.P. CONSULTANT
B.E. ELECTRICAL

 
CCTV SYSTEM

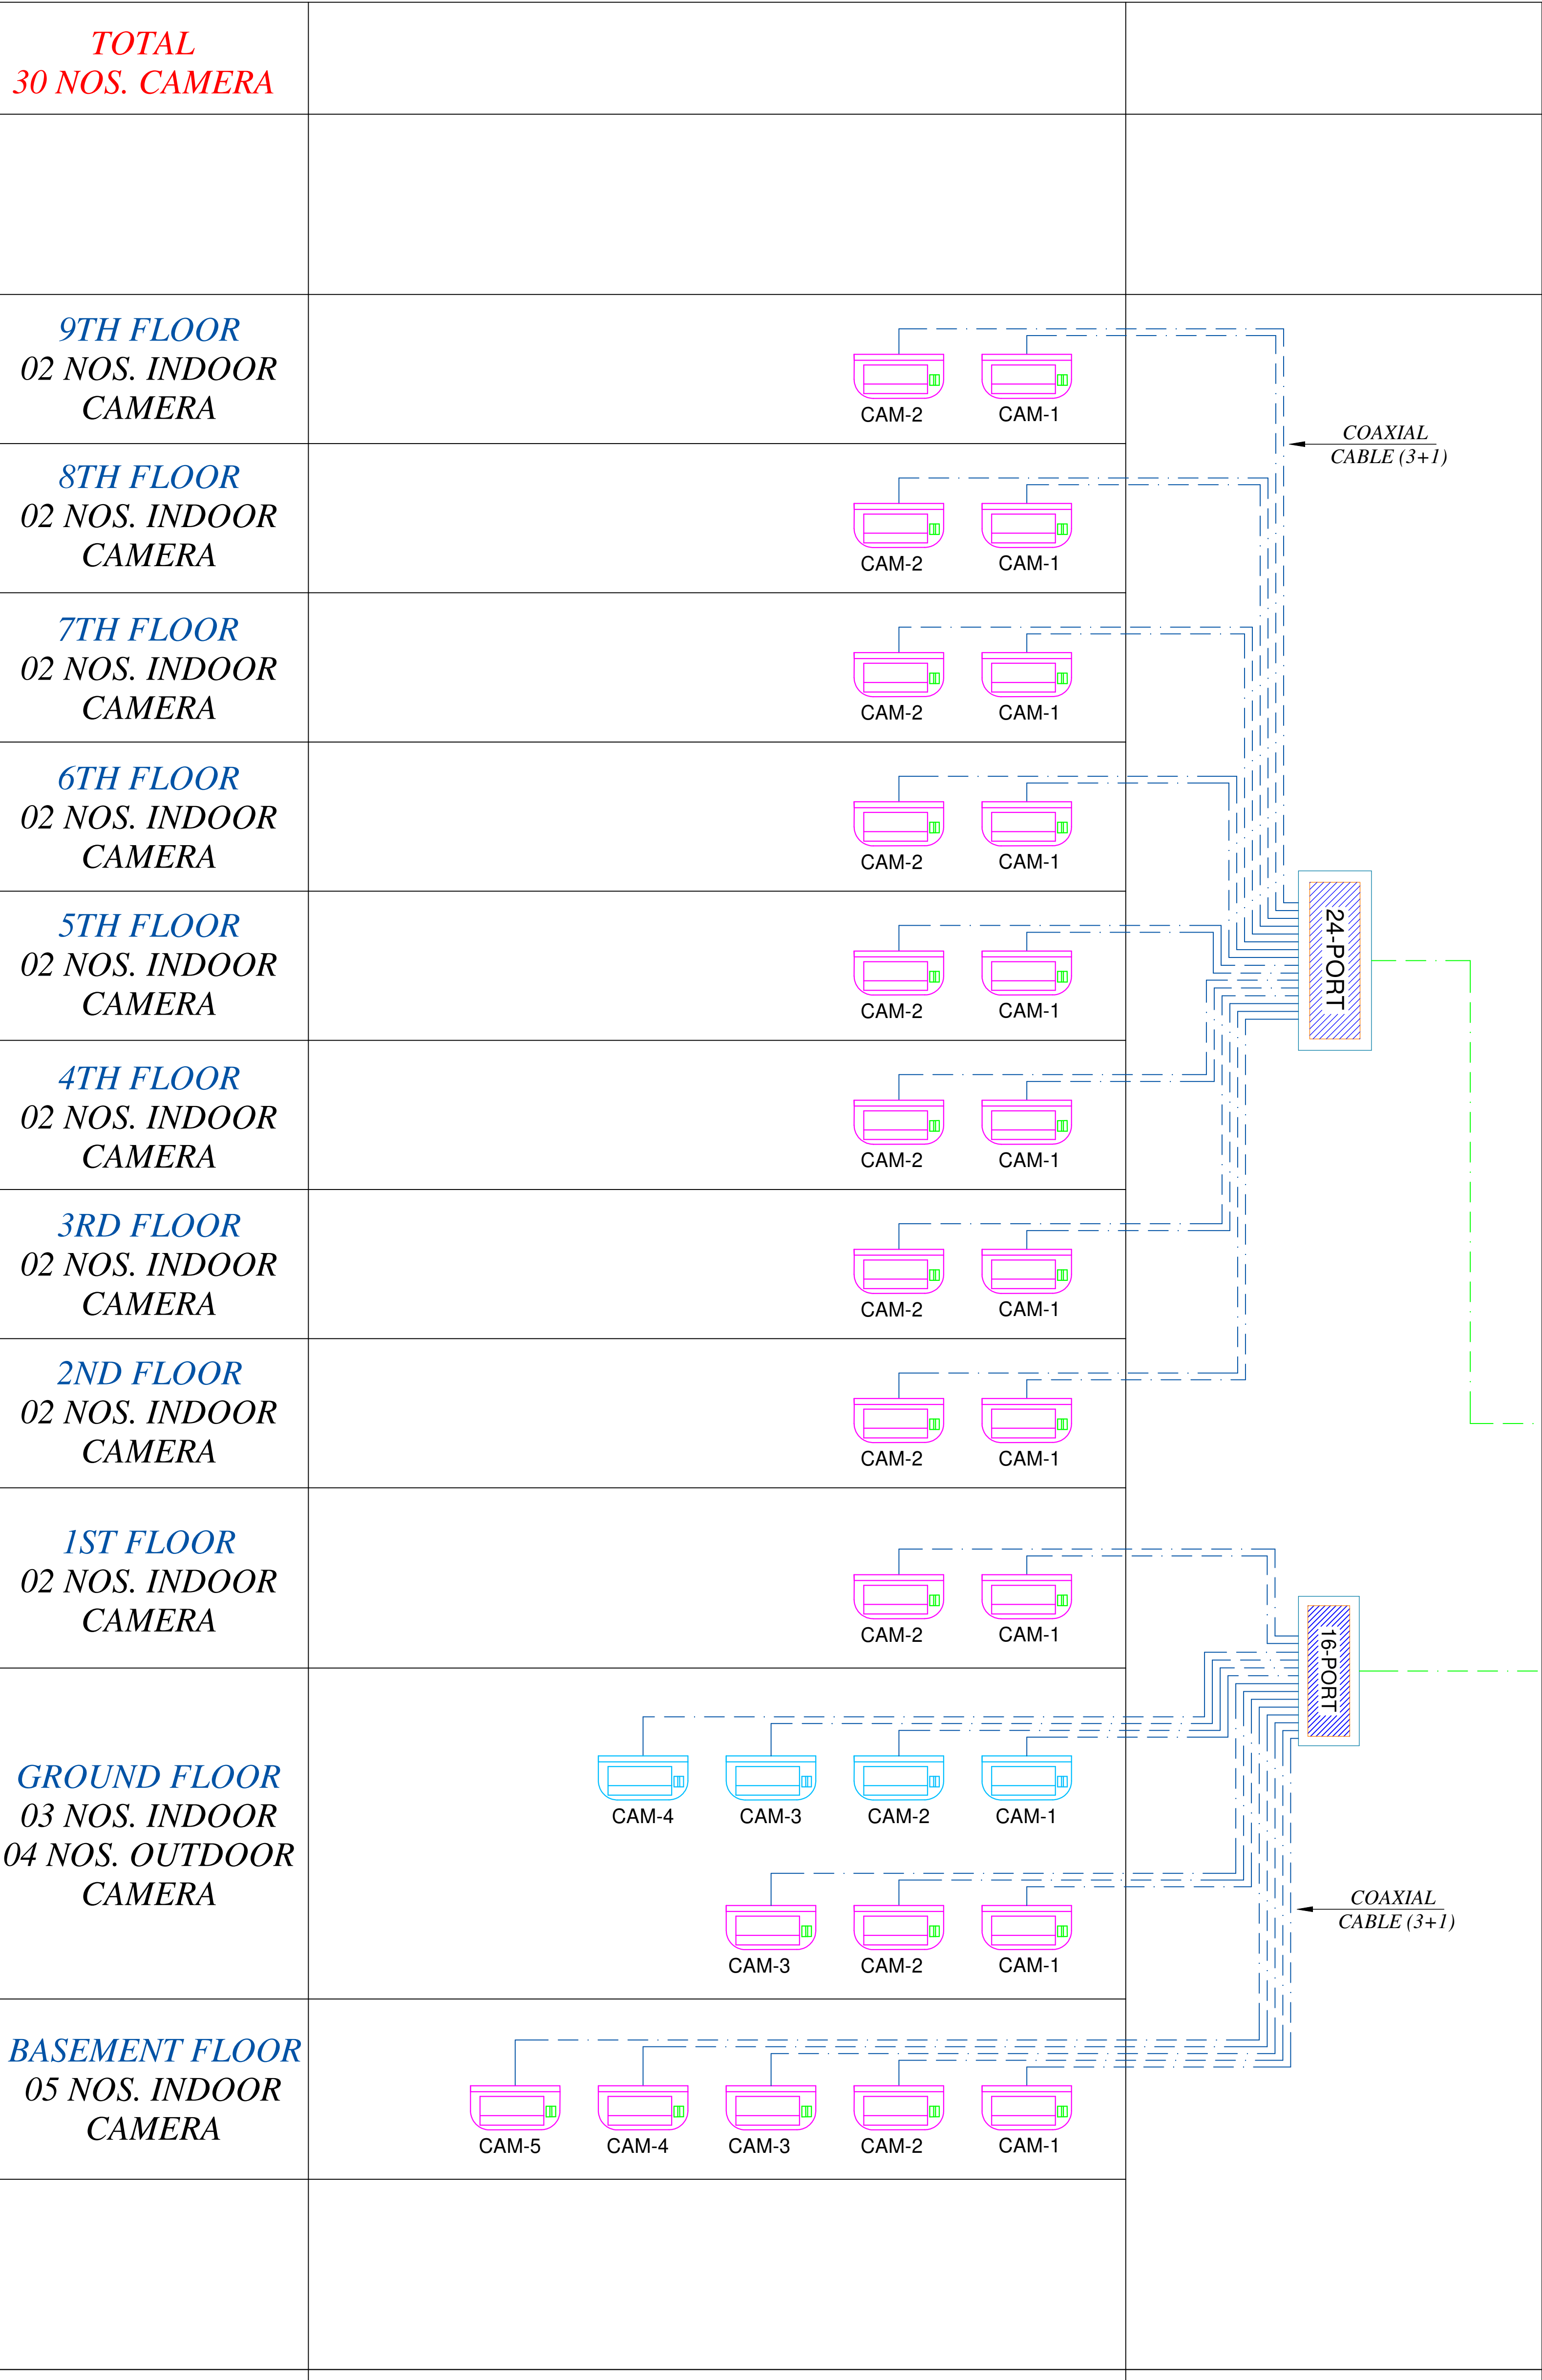

TOTAL CAMERA -60 NOS.				
LEGENDS:				
Mounting Height	No.	I D	Symbol	Description
	26	CCTV		WALL MOUNTED CCTV CAMERA FOR INDOOR AREA
	04	CCTV		WALL MOUNTED CCTV CAMERA FOR OUTDOOR AREA
	N/A	CABLE		CAT-6 LAN CABLE
	N/A	CABLE		COAXIAL CABLE
	N/A	CABLE		HDMI CABLE
SERVICES CONSULTANT: VIPUL CONSULTING, F 9 / 440 , Keshav Marg Chitrakut Scheme,Jaipur PH:91-0-93146-10438 ,0141-2440946 Mail:vipul8599@yahoo.com REV. NO. 00,DATE:-11-09-2020				
PROJECT ADD. :- Khasra no/ plot no A-6,7,8,9,10,&11/547, 550,to 555, 557,and 558, Pragti Nagar, Kotra Scheam , Ajmer-305004 (Rajasthan)				
PROJECT NAME:- SKY TOWER				
TITLE : CCTV CONTROL SLD				
DRAWING SINGLE LINE DIAGRAM				
DATE:- 19-03-2021			SCALE:- N.T.S	
DRAWN BY:- VICKY YADAV			APPROVED BY:- VIPUL AGARWAL	
 VIPUL AGARWAL M.E.P. CONSULTANT B.E. ELECTRICAL				

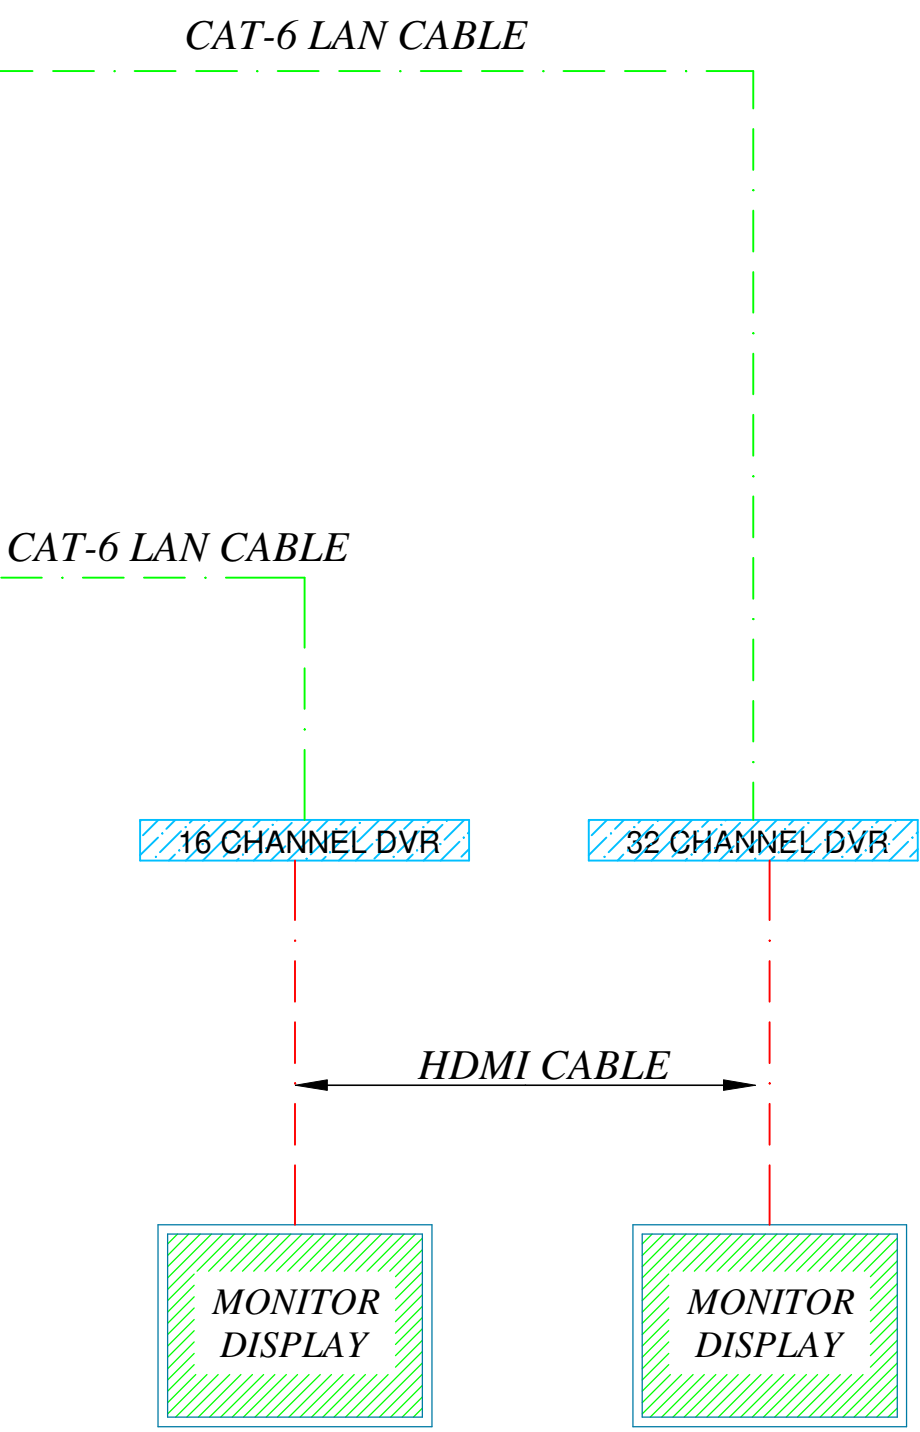

FIRE ALARM

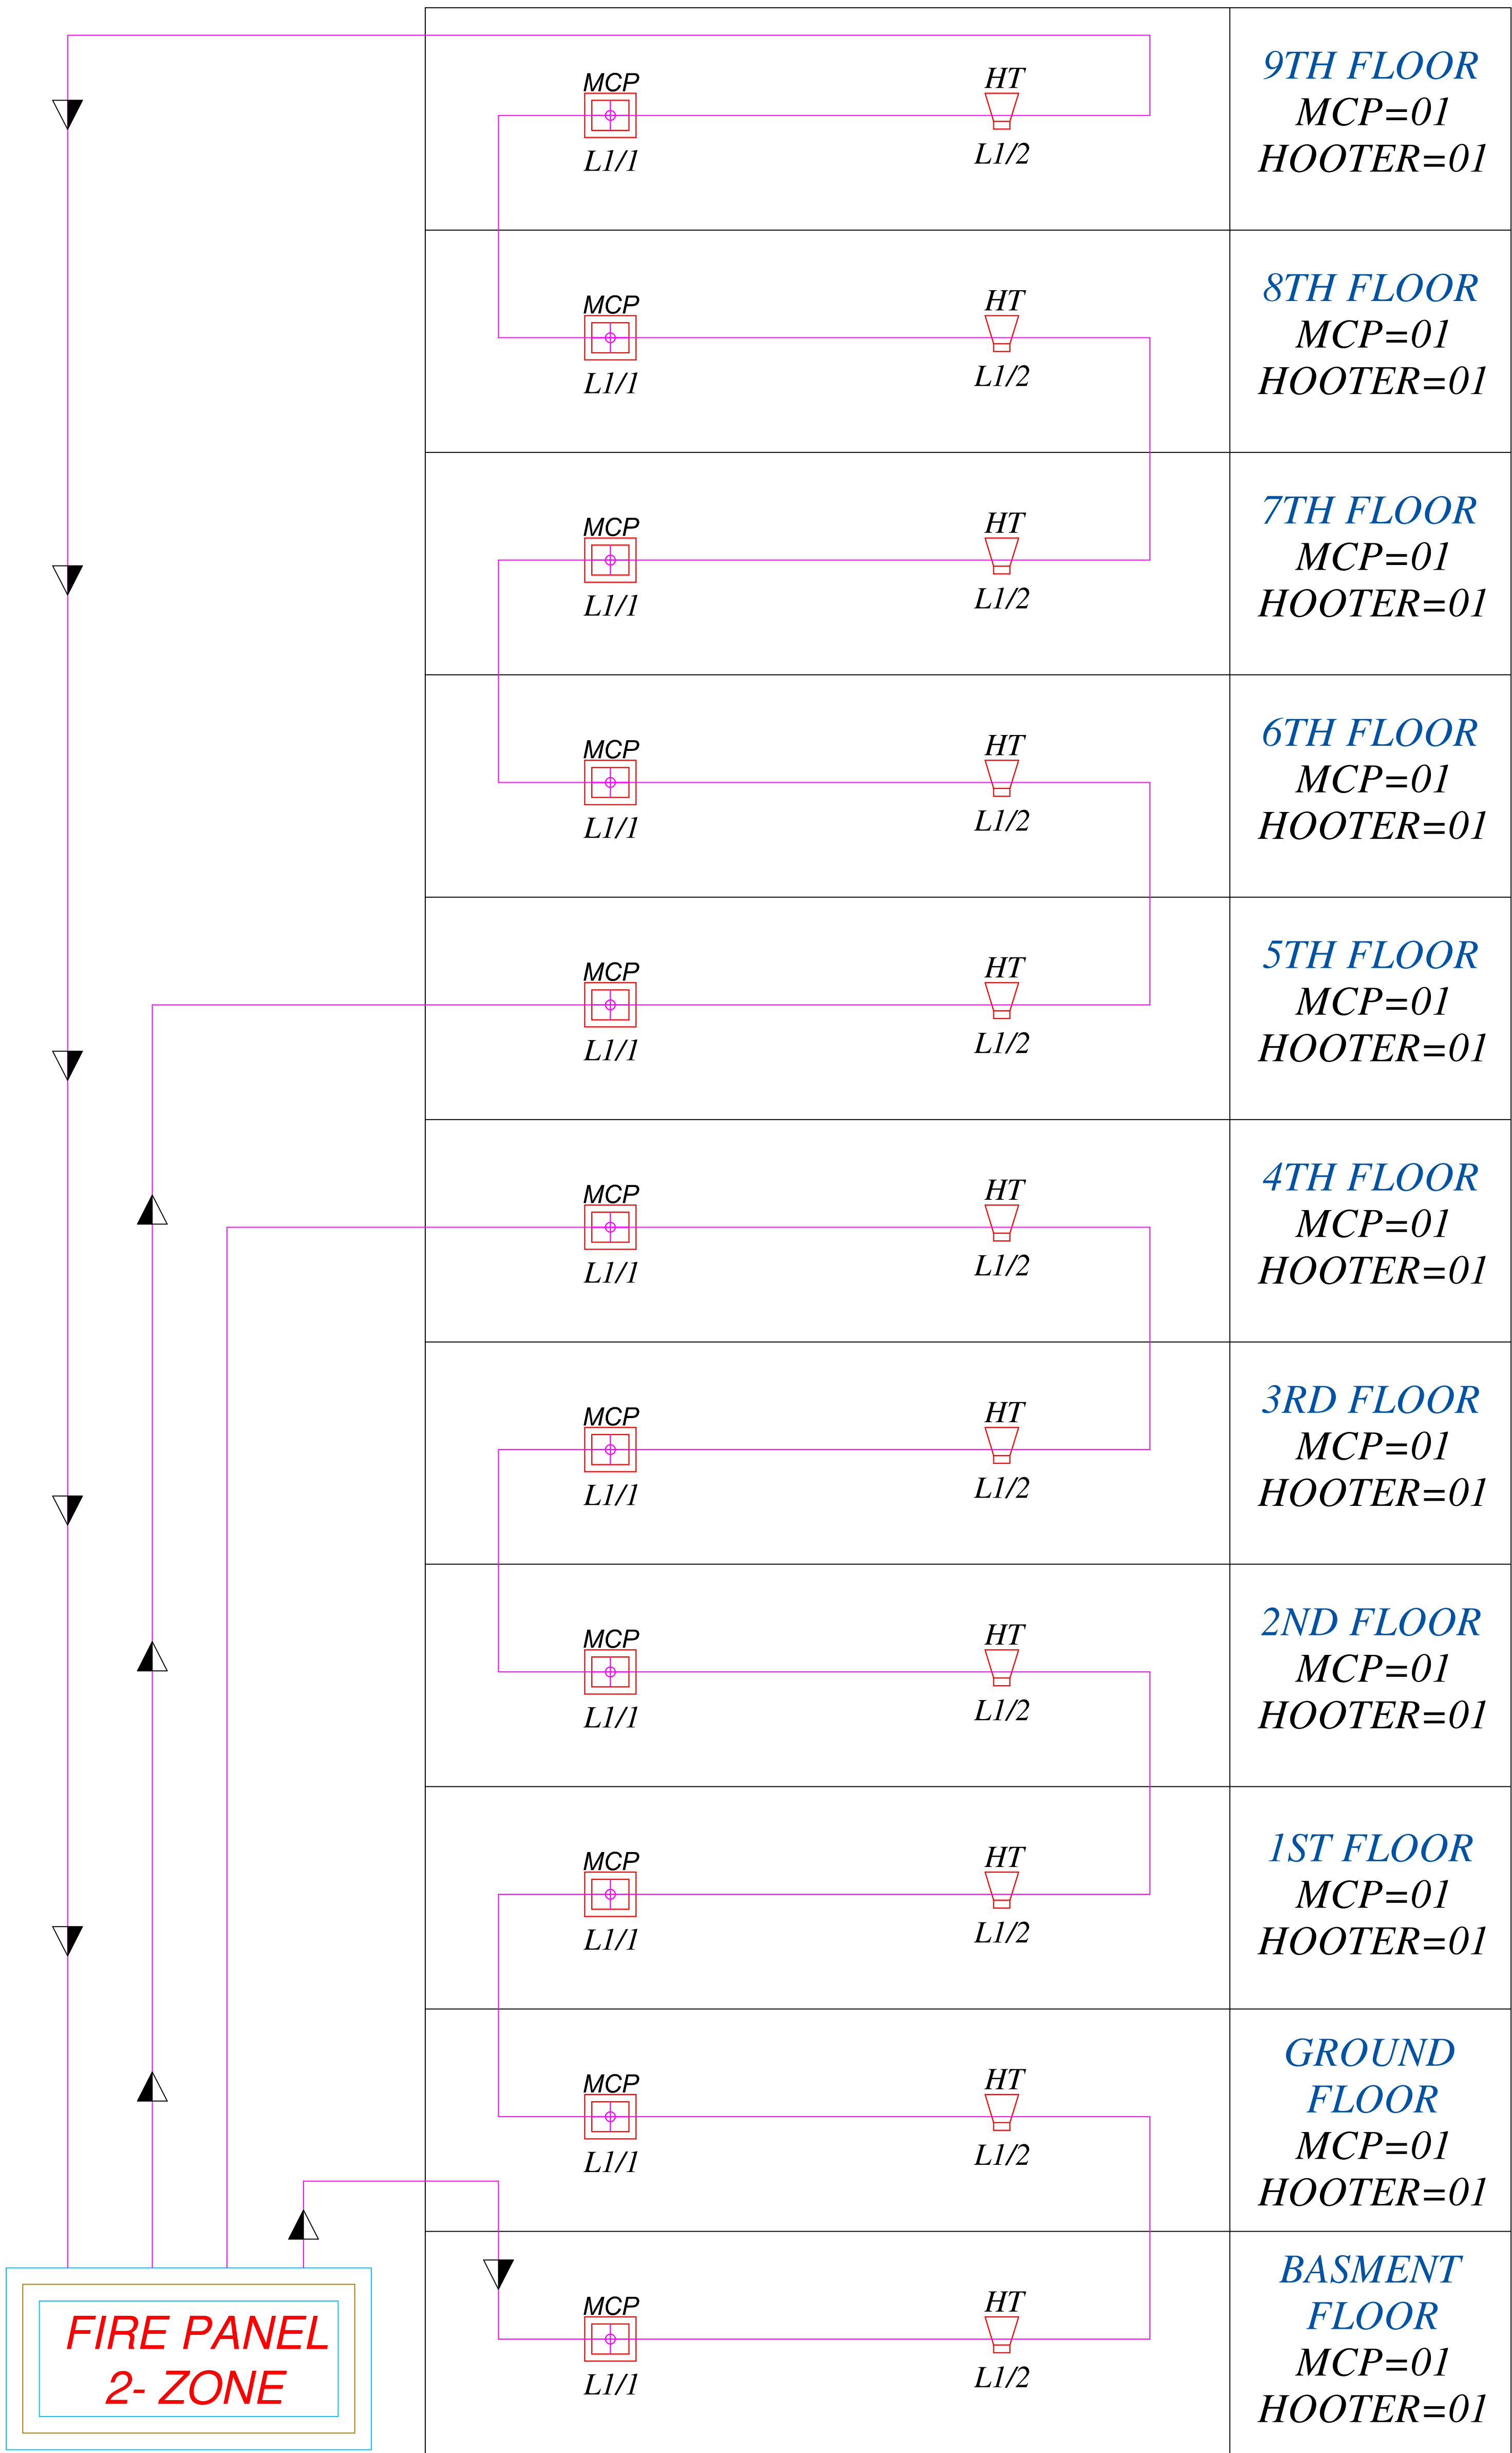

Vipul
VIPUL AGARWAL
M.E.P. CONSULTANT
B.E. ELECTRICAL

IMPORTANT NOTES

2. 2 X 1.5 sq mm ALUMIUM
ARMOURED CABLE CLIPPED
DIRECTLY TO SLAB

QTY

LEGENDS:

	ID	SYMBOL	DESCRIPTION
11	MCP		MANUAL CALL POINT
11	HT		HOOTER POINT

SERVICES CONSULTANT:
VIPUL CONSULTING,
F 9 / 440 , Keshav Marg Chitrakut Scheme,Jaipur
PH:91-0-93146-10438 ,0141-2440946
Mail:vipul8599@yahoo.com
REV. NO. 00,DATE:-09-12-2019

PROJECT ADD. :-

Khasra no/ plot no A-6,7,8,9,10,&11/547, 550,to
555, 557,and 558, Pragti Nagar, Kotra Scheme ,
Ajmer-305004 (Rajasthan)

PROJECT NAME:-

SKY TOWER

TITLE :

FIRE ALARM SYSTEM
SINGLE LINE DIAGRAM

DRAWING

SINGLE LINE DIAGRAM

DATE:-

19-03-2021

SCALE:-

N.T.S

DRAWN BY:-

VICKY YADAV

APPROVED BY:-

VIPUL AGARWAL