



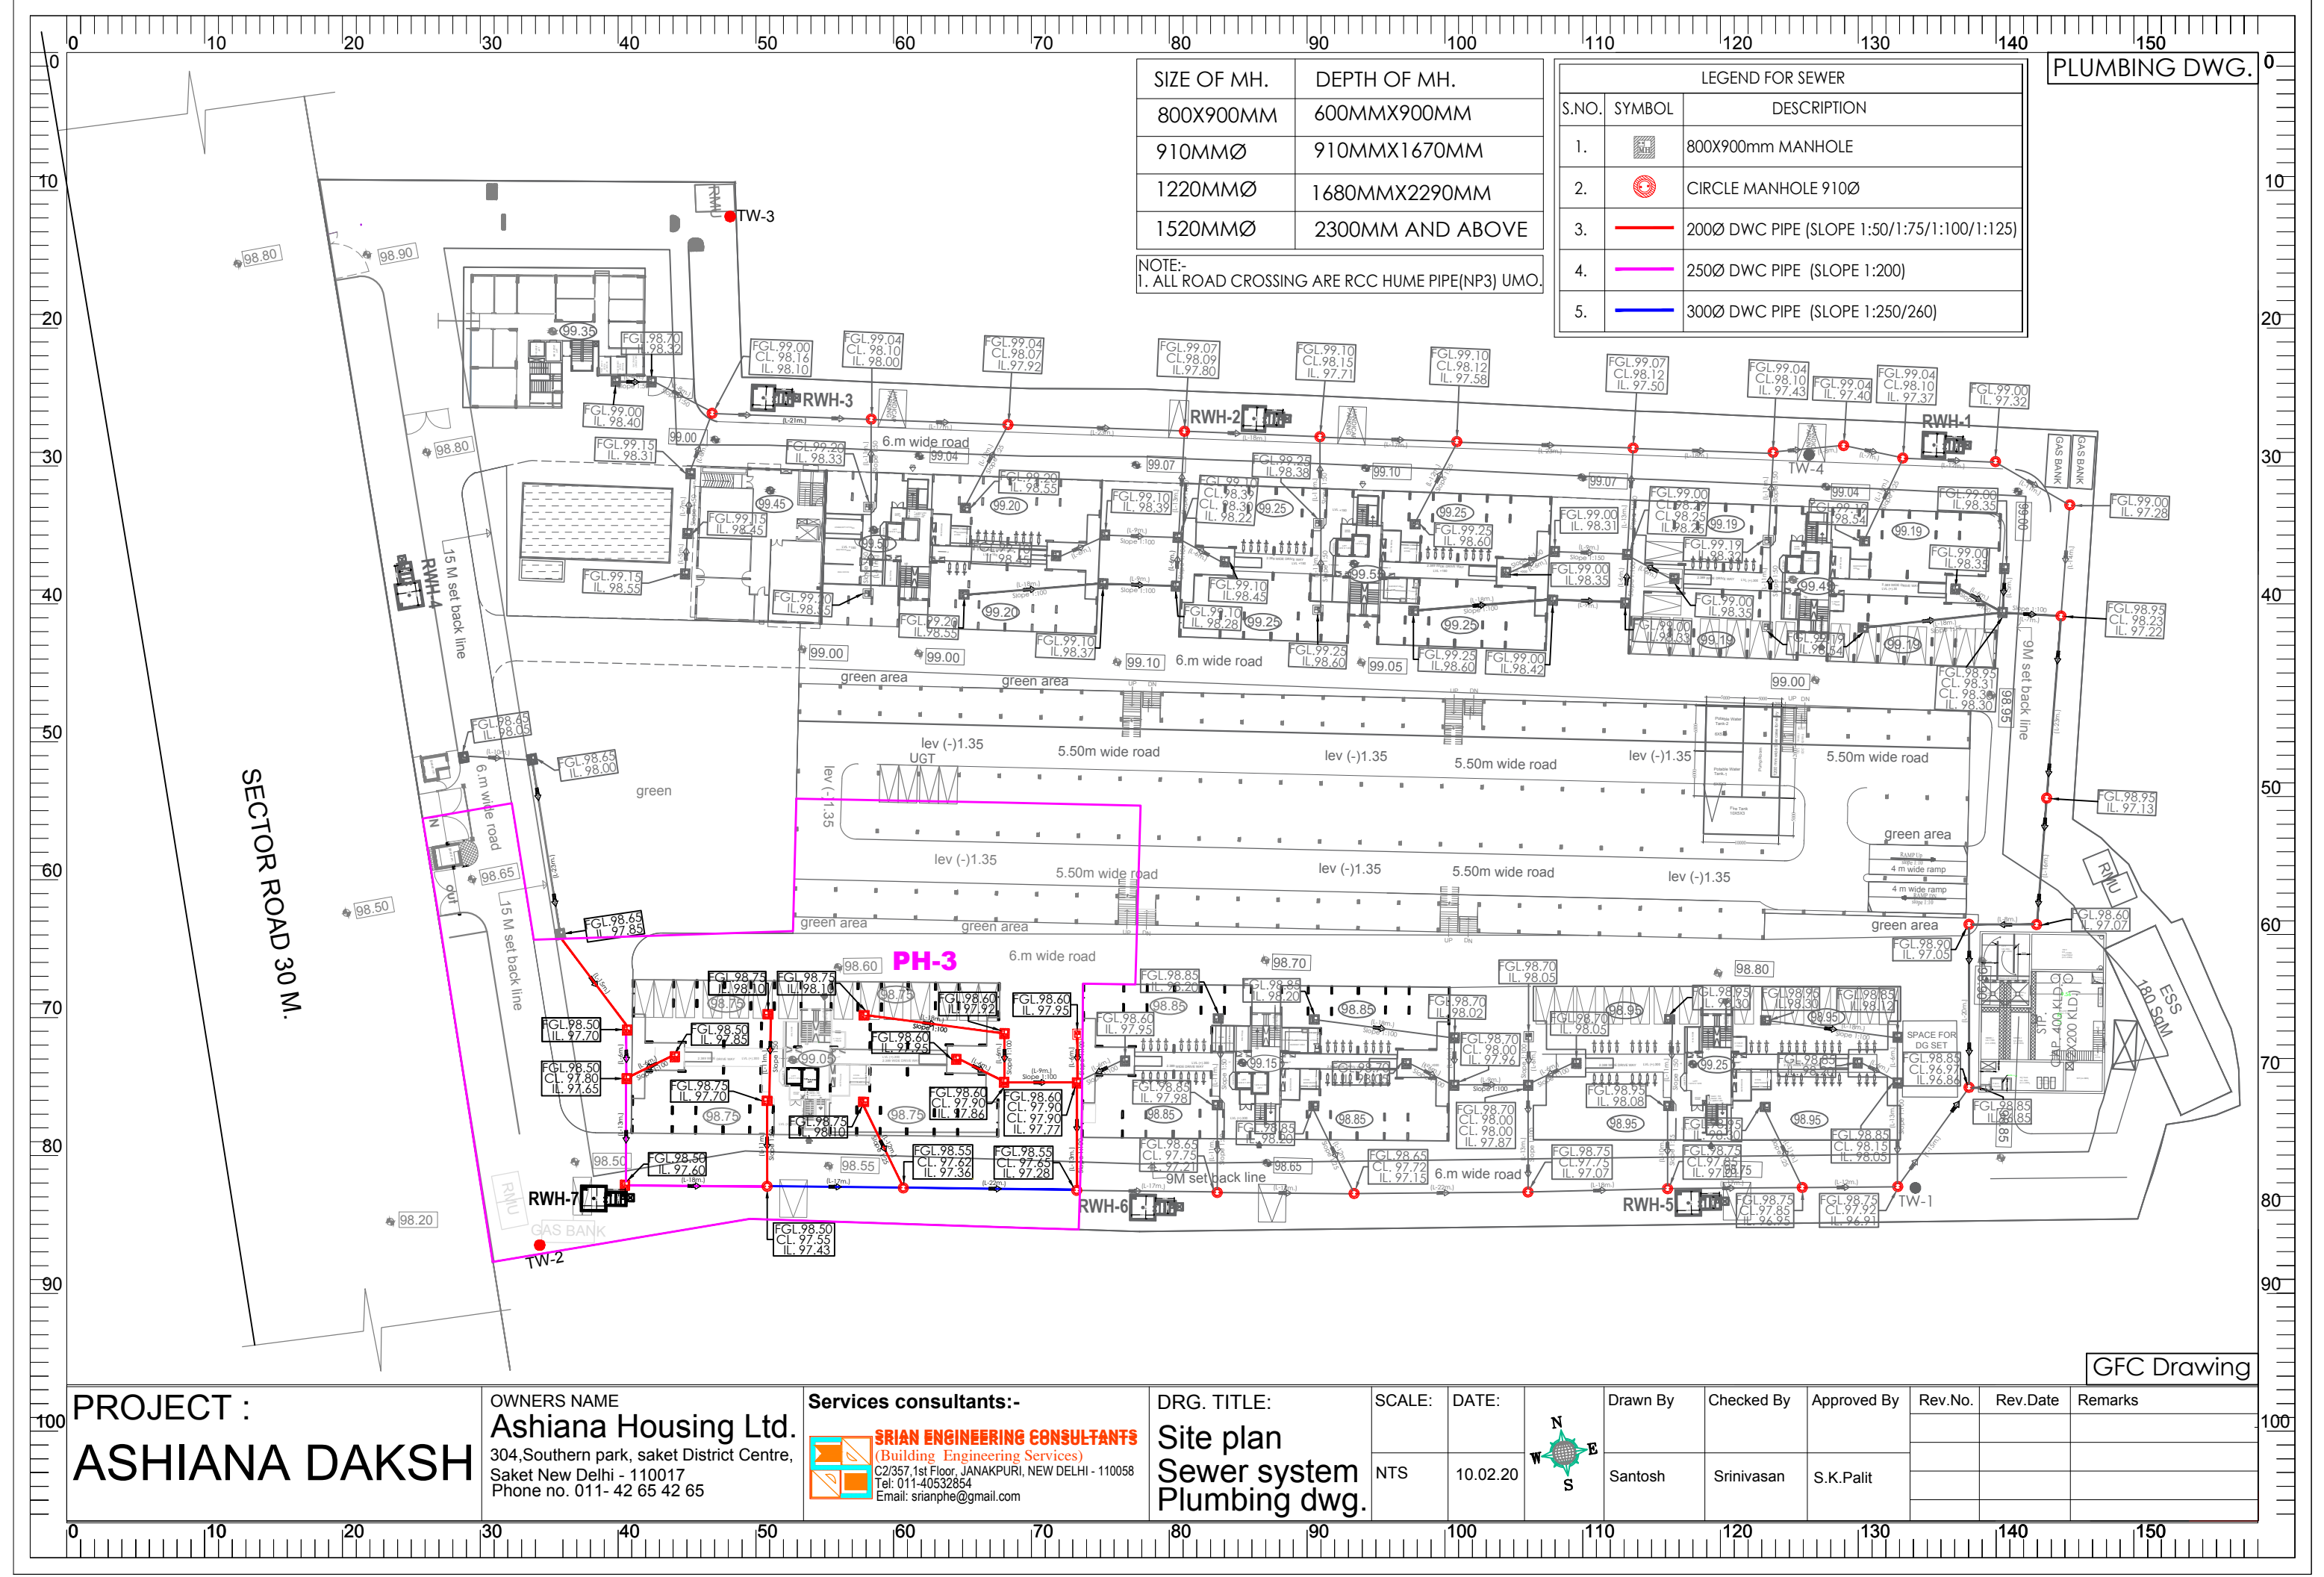

LEGEND FOR SEWER		
S.NO.	SYMBOL	DESCRIPTION
1.		800X900mm MANHOLE
2.		CIRCLE MANHOLE 910Ø
3.		200Ø DWC PIPE (SLOPE 1:50/1:75/1:100/1:125)
4.		250Ø DWC PIPE (SLOPE 1:200)
5.		300Ø DWC PIPE (SLOPE 1:250/260)

PLUMBING DWG.

Drawn By	Checked By	Approved By	Rev.No.	Rev.Date	Remarks
Santosh	Srinivasan	S.K.Palit			

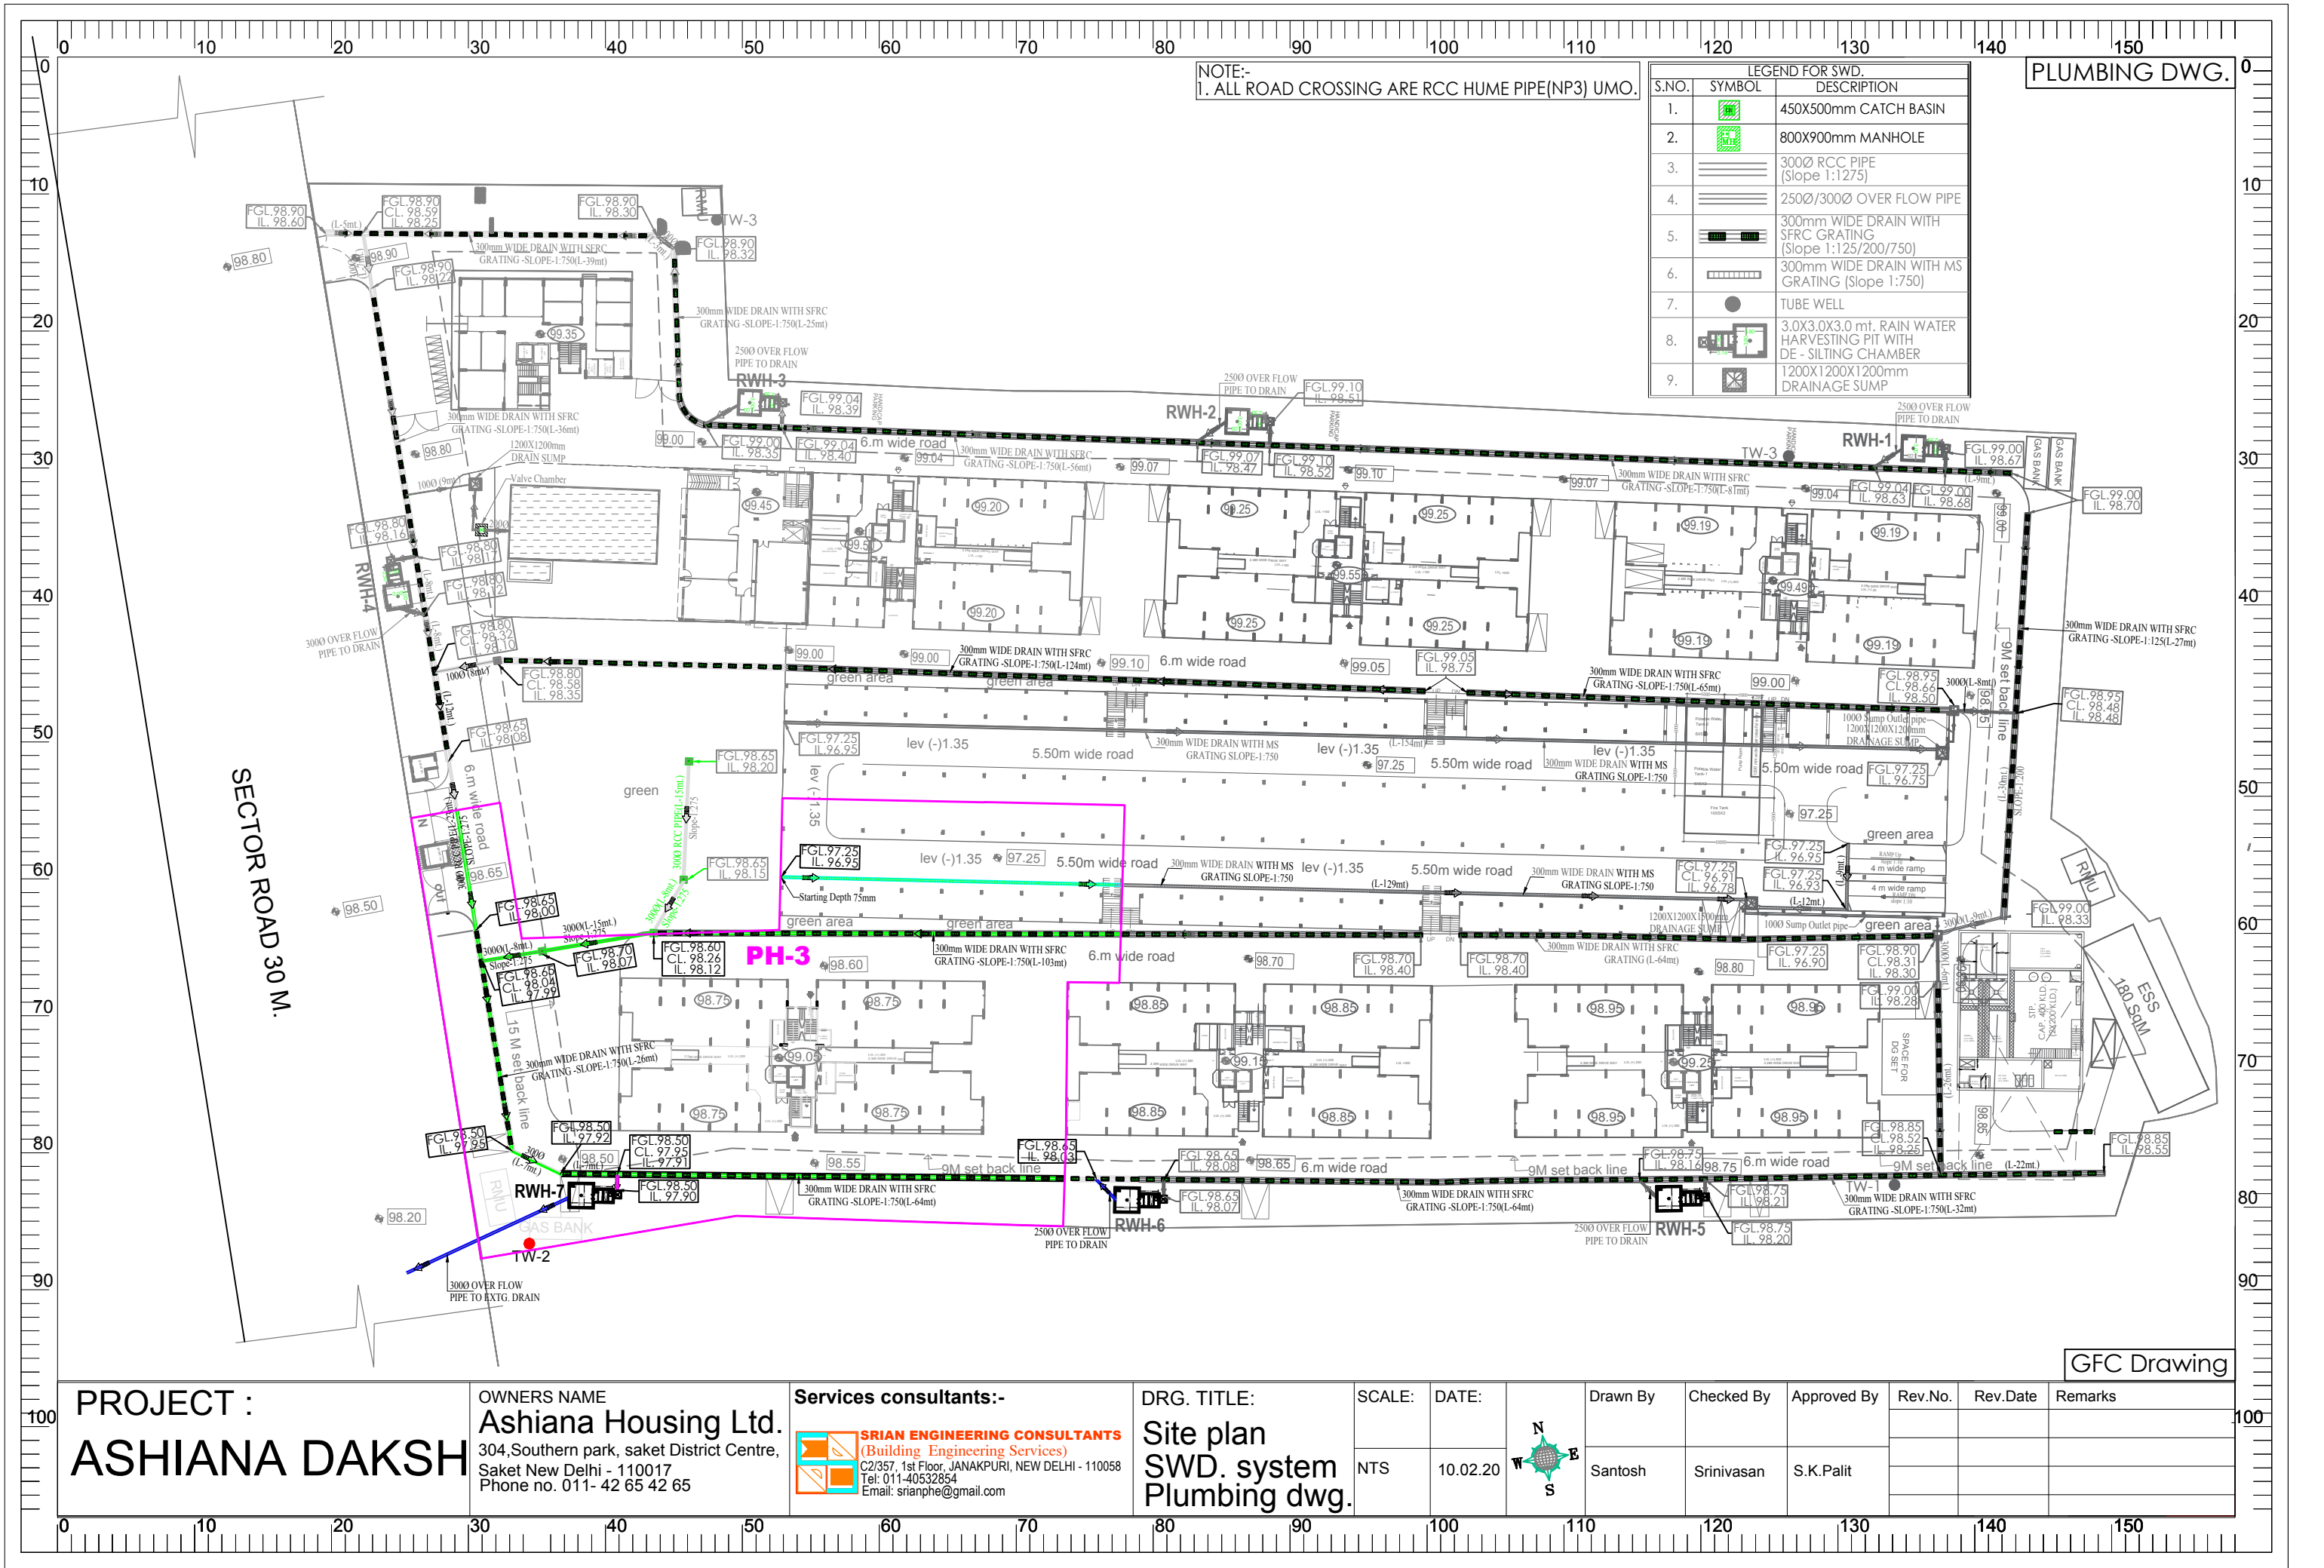

NOTE:-
1. ALL ROAD CROSSING ARE RCC HUME PIPE(NP3) UMO.

LEGEND FOR SWD.		
S.NO.	SYMBOL	DESCRIPTION
1.		450X500mm CATCH BASIN
2.		800X900mm MANHOLE
3.		300Ø RCC PIPE (Slope 1:1275)
4.		250Ø/300Ø OVER FLOW PIPE
5.		300mm WIDE DRAIN WITH SFRC GRATING (Slope 1:125/200/750)
6.		300mm WIDE DRAIN WITH MS GRATING (Slope 1:750)
7.		TUBE WELL
8.		3.0X3.0X3.0 mt. RAIN WATER HARVESTING PIT WITH DE - SILTING CHAMBER
9.		1200X1200X1200mm DRAINAGE SUMP

PLUMBING DWG.

GFC Drawing

PROJECT :
ASHIANA DAKSH

OWNERS NAME
Ashiana Housing Ltd.
304,Southern park, saket District Centre,
Saket New Delhi - 110017
Phone no. 011- 42 65 42 65

Services consultants:-

SRIAN ENGINEERING CONSULTANTS
(Building Engineering Services)
C2/357, 1st Floor, JANAKPURI, NEW DELHI - 110058
Tel: 011-40532854
Email: srianphe@gmail.com

DRG. TITLE:
**Site plan
SWD. system
Plumbing dwg.**

SCALE:

NTS

DATE:

10.02.20



Drawn By

Santosh

Checked By

Srinivasan

Approved By

S.K.Palit

Rev.No.

Rev.Date

Remarks