

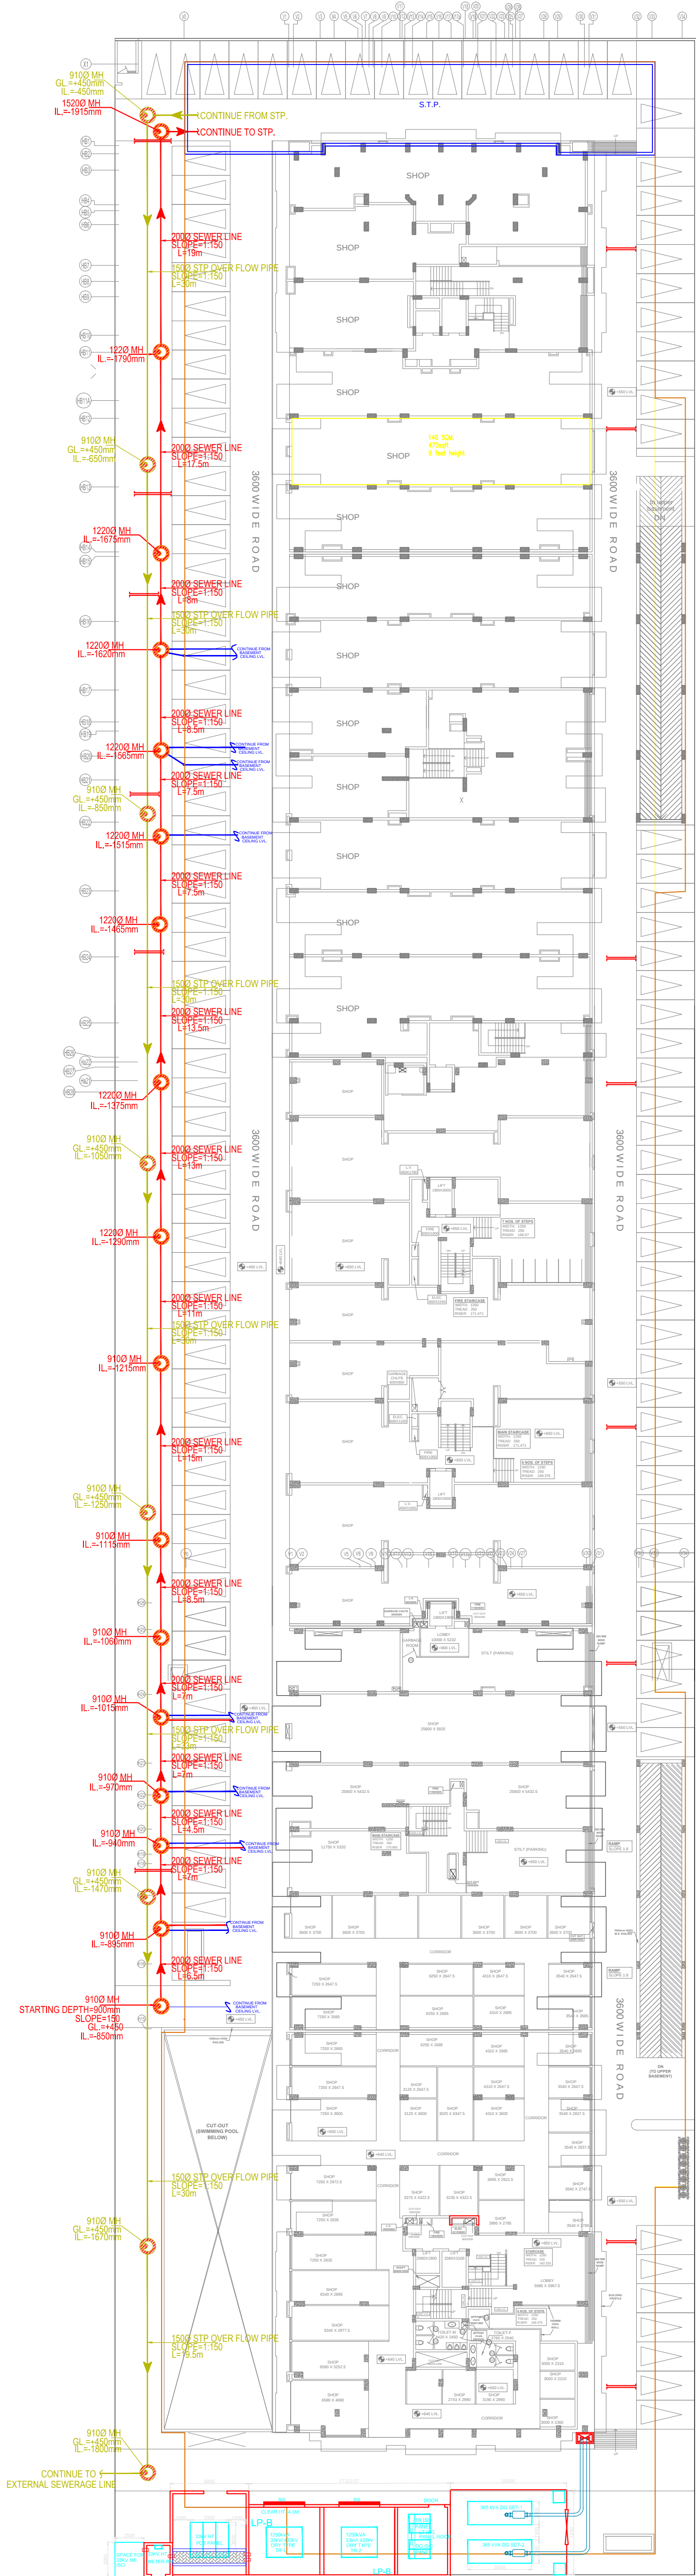
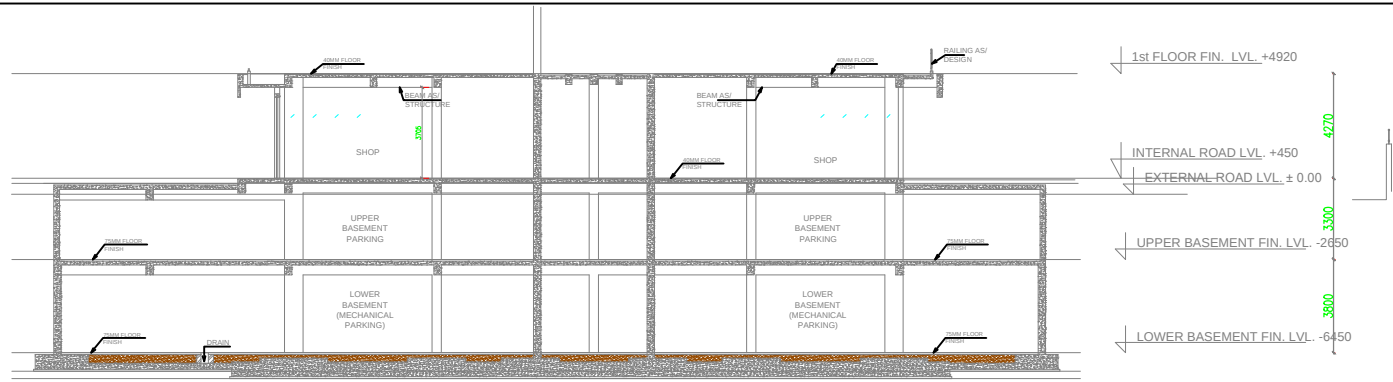


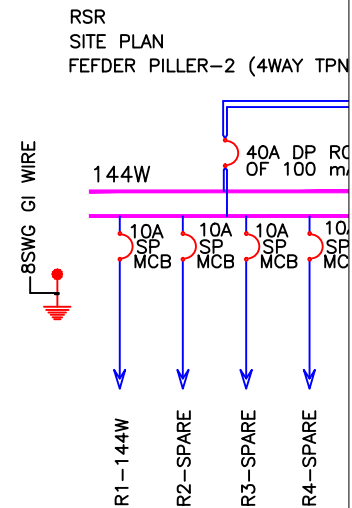

SYMBOL	
	36
	15
	4
	E
	15

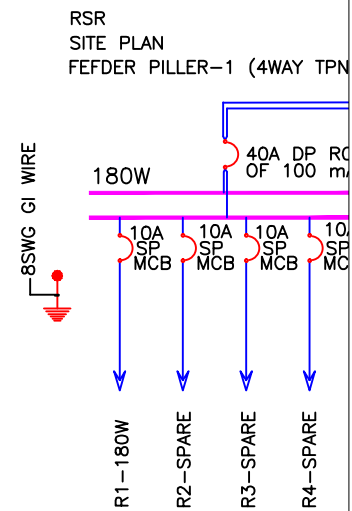

SEWERAGE LEGEND:-	
	EXTERNAL SEWER LINE
	SEWERAGE MANHOLE
MH	MANHOLE
	WATER FLOW

NOTE
ALL MH LOCATION WILL BE
CHANGE AS PER FINAL BASEMENT
PLUMBING CEILING LAYOUT

CLIENT :-	
PROJECT :-	
PROPOSED BUILDING AT PLOT NO.1,2,3,4 AT DAKANYA RAILWAY STATION ROAD, RAJEEV GANDHI NAGAR EXT.,KOTA	
ARCHITECTS :-	
 R.K. & ASSOCIATES Architects, Engineers & Planners E-31, GREEN PARK MAIN, NEW DELHI - 110038, INDIA Tel. : 2616-2154, 2651-0751, 2656-7357 Fax: (011) 2686-2540 E-mail : rka.architects@gmail.com	
CONSULTANTS :-	
ACROBAT ENGINEERS PVT.LTD.	
 H.No. 19/18, Basement Lvl. Spring Field Colony Faridabad (Haryana) Tel. : 0129-4056009 customerservice@acrobategngineers.com	
SHEET TITLE	
EXTERNAL SITE PLAN SEWERAGE LAYOUT PLUMBING DRAWING	
DRG. NO.	
AEA/RSR/ESP/SL/PL-01	
DATE	03-06-2016
SCALE	AS PER 300
DETAIL BY	VIRENDRA KANDARI
CHECK CELL	VIRENDRA
REV. NO	NORTH